
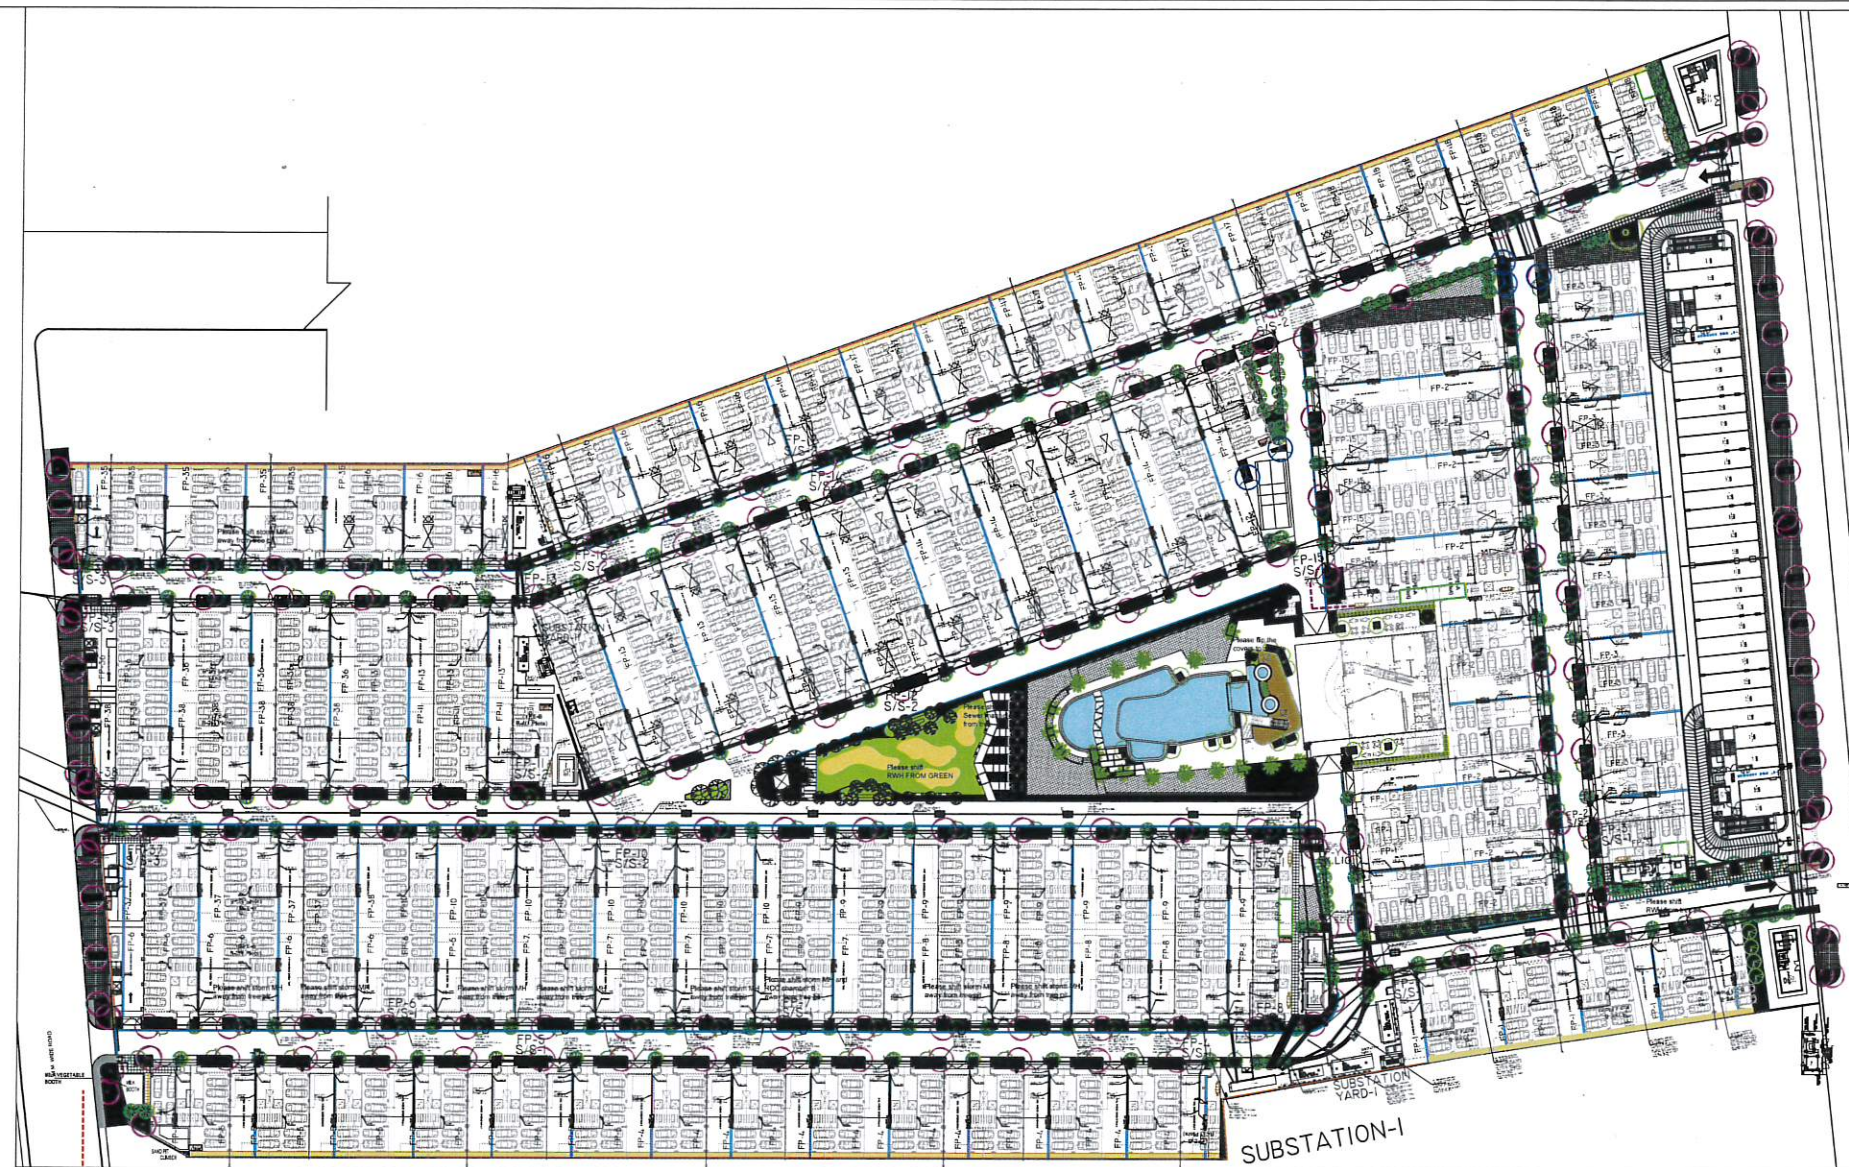
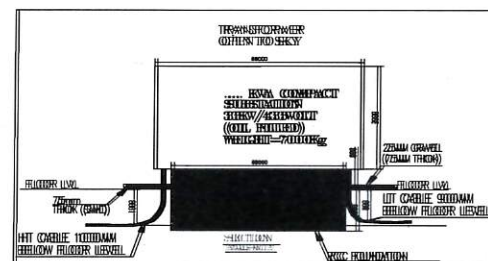
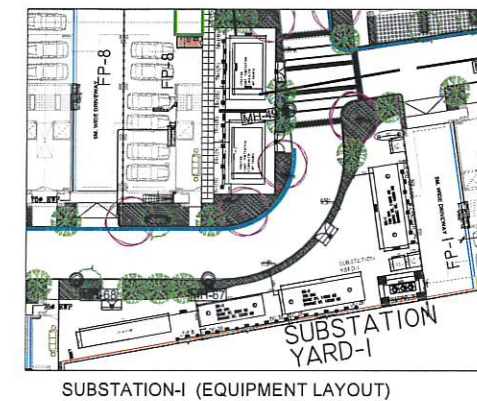


LEGEND			
S.NO	DESCRIPTION		SYMBOL
1.	125 MM OD HOPE PMS PE 80 PIPE FOR POWER CABLE TOP OF PIPE 750 MM BELOW GROUND LEVEL		
2.	160 MM OD HOPE PMS PE 80 PIPE FOR POWER CABLE TOP OF PIPE 750 MM BELOW GROUND LEVEL		
3.	200 MM OD HOPE PMS PE 80 PIPE FOR POWER CABLE TOP OF PIPE 750 MM BELOW GROUND LEVEL		
4.	125 MM OD HOPE PMS PE 80 PIPE FOR LV CABLE TOP OF PIPE 450 MM BELOW GROUND LEVEL		
5.	200 MM OD HOPE PMS PE 80 PIPE FOR HT CABLE TOP OF PIPE 900 MM BELOW GROUND LEVEL		
6.	300X300X10 MM MANHOLE FOR LV WITH ISI MARK HEAVY DUTY DI COVER OF SUITABLE SIZE WITH RCC WALL		
7.	80X80X1000 MM MANHOLE FOR LV WITH RCC FRAMING OF MAN HOLE & HEAVY DUTY DI COVER WITH RCC WALL		
8.	80X80X1000 MM MANHOLE FOR HT WITH RCC FRAMING OF MAN HOLE & HEAVY DUTY DI COVER WITH RCC WALL		
9.	FEDDER PILLAR		
10.	FEDDER PILLAR EXTERNAL LIGHTING		
11.			

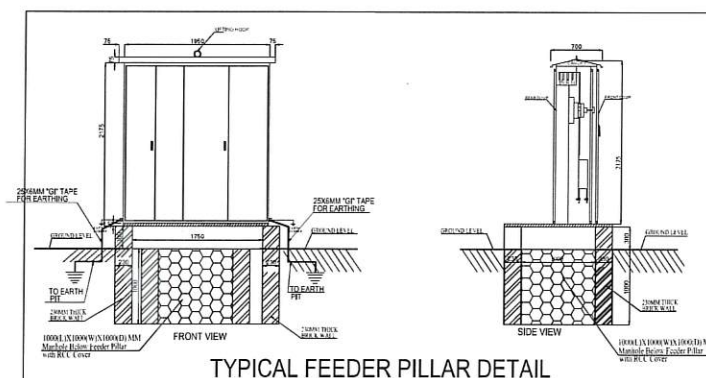

Suposhaa Realcon Private Limited

Authorized Signatory

NOTE :-

1. FOR FEEDER PILLAR ,SUBSTATION & DG SETS EARTHING PITS 2 METER DISTANCE CONSIDERED BETWEEN EARTHING PITS.
2. THESE EARTH PITS TO BE EXECUTED BEFORE FOOTING OF BOUNDARY WALL

NOTES:

NO	REVISION	DATE	ISSUED TO
----	----------	------	-----------

STRUCTURE CONSULTANT
BMSF Design Consultants(P).ltd
5-13/25,Ground Floor,DLF Phase-III, Gurgaon, Haryana-122002
Email: bmsfashd@gmail.com
PH: 0124-4113252; 9810053542.

PLUMBING & FIRE FIGHTING CONSULTANT >
SAVIRAM
ENGINEERING CONSULTANTS PRIVATE LIMITED
 Regd. off.: 22, Gopalnagar Road Vihar, Sector-62, Noida-201301
 Telephone: +91-122-2434877, 4261877, 4241878 Fax: +91-122-2434877
 E-mail: saviramside@gmail.com

ELECTRICAL CONSULTANT
AMPOWER CONSULTANCY SERVICES
B-222 SECOND FLOOR,
NARAINA INDUSTRIAL AREA PHASE-I,
NEW DELHI-28. PH. - 45054718, 41414735

PROJECT
SMART WORLD BOUTIQUE FLOORS,
SECTOR-61,GURUGRAM

DRAWING TITLE

SITE PLAN-PART-II
(FEEDER PILLAR, UNIT SUBSTATION,
DG SETS & HUME PIPE ROUTING LAYOUT)

SCALE 1:350	DATE 31-01-2022	DRG. NO. SW/DDJAY/SITE/EL-D/C	
DRAWN BY Dinesh	CHECKED BY Vivek Jain	NORTH N 	REVISION R-0

DESIGN FORUM
OF ARCHITECTS

Advant IT Park Tower-B, Unit-602
Sector-142 Expressway Noida-201301.
E-MAIL: dfaconsultants@gmail.com