
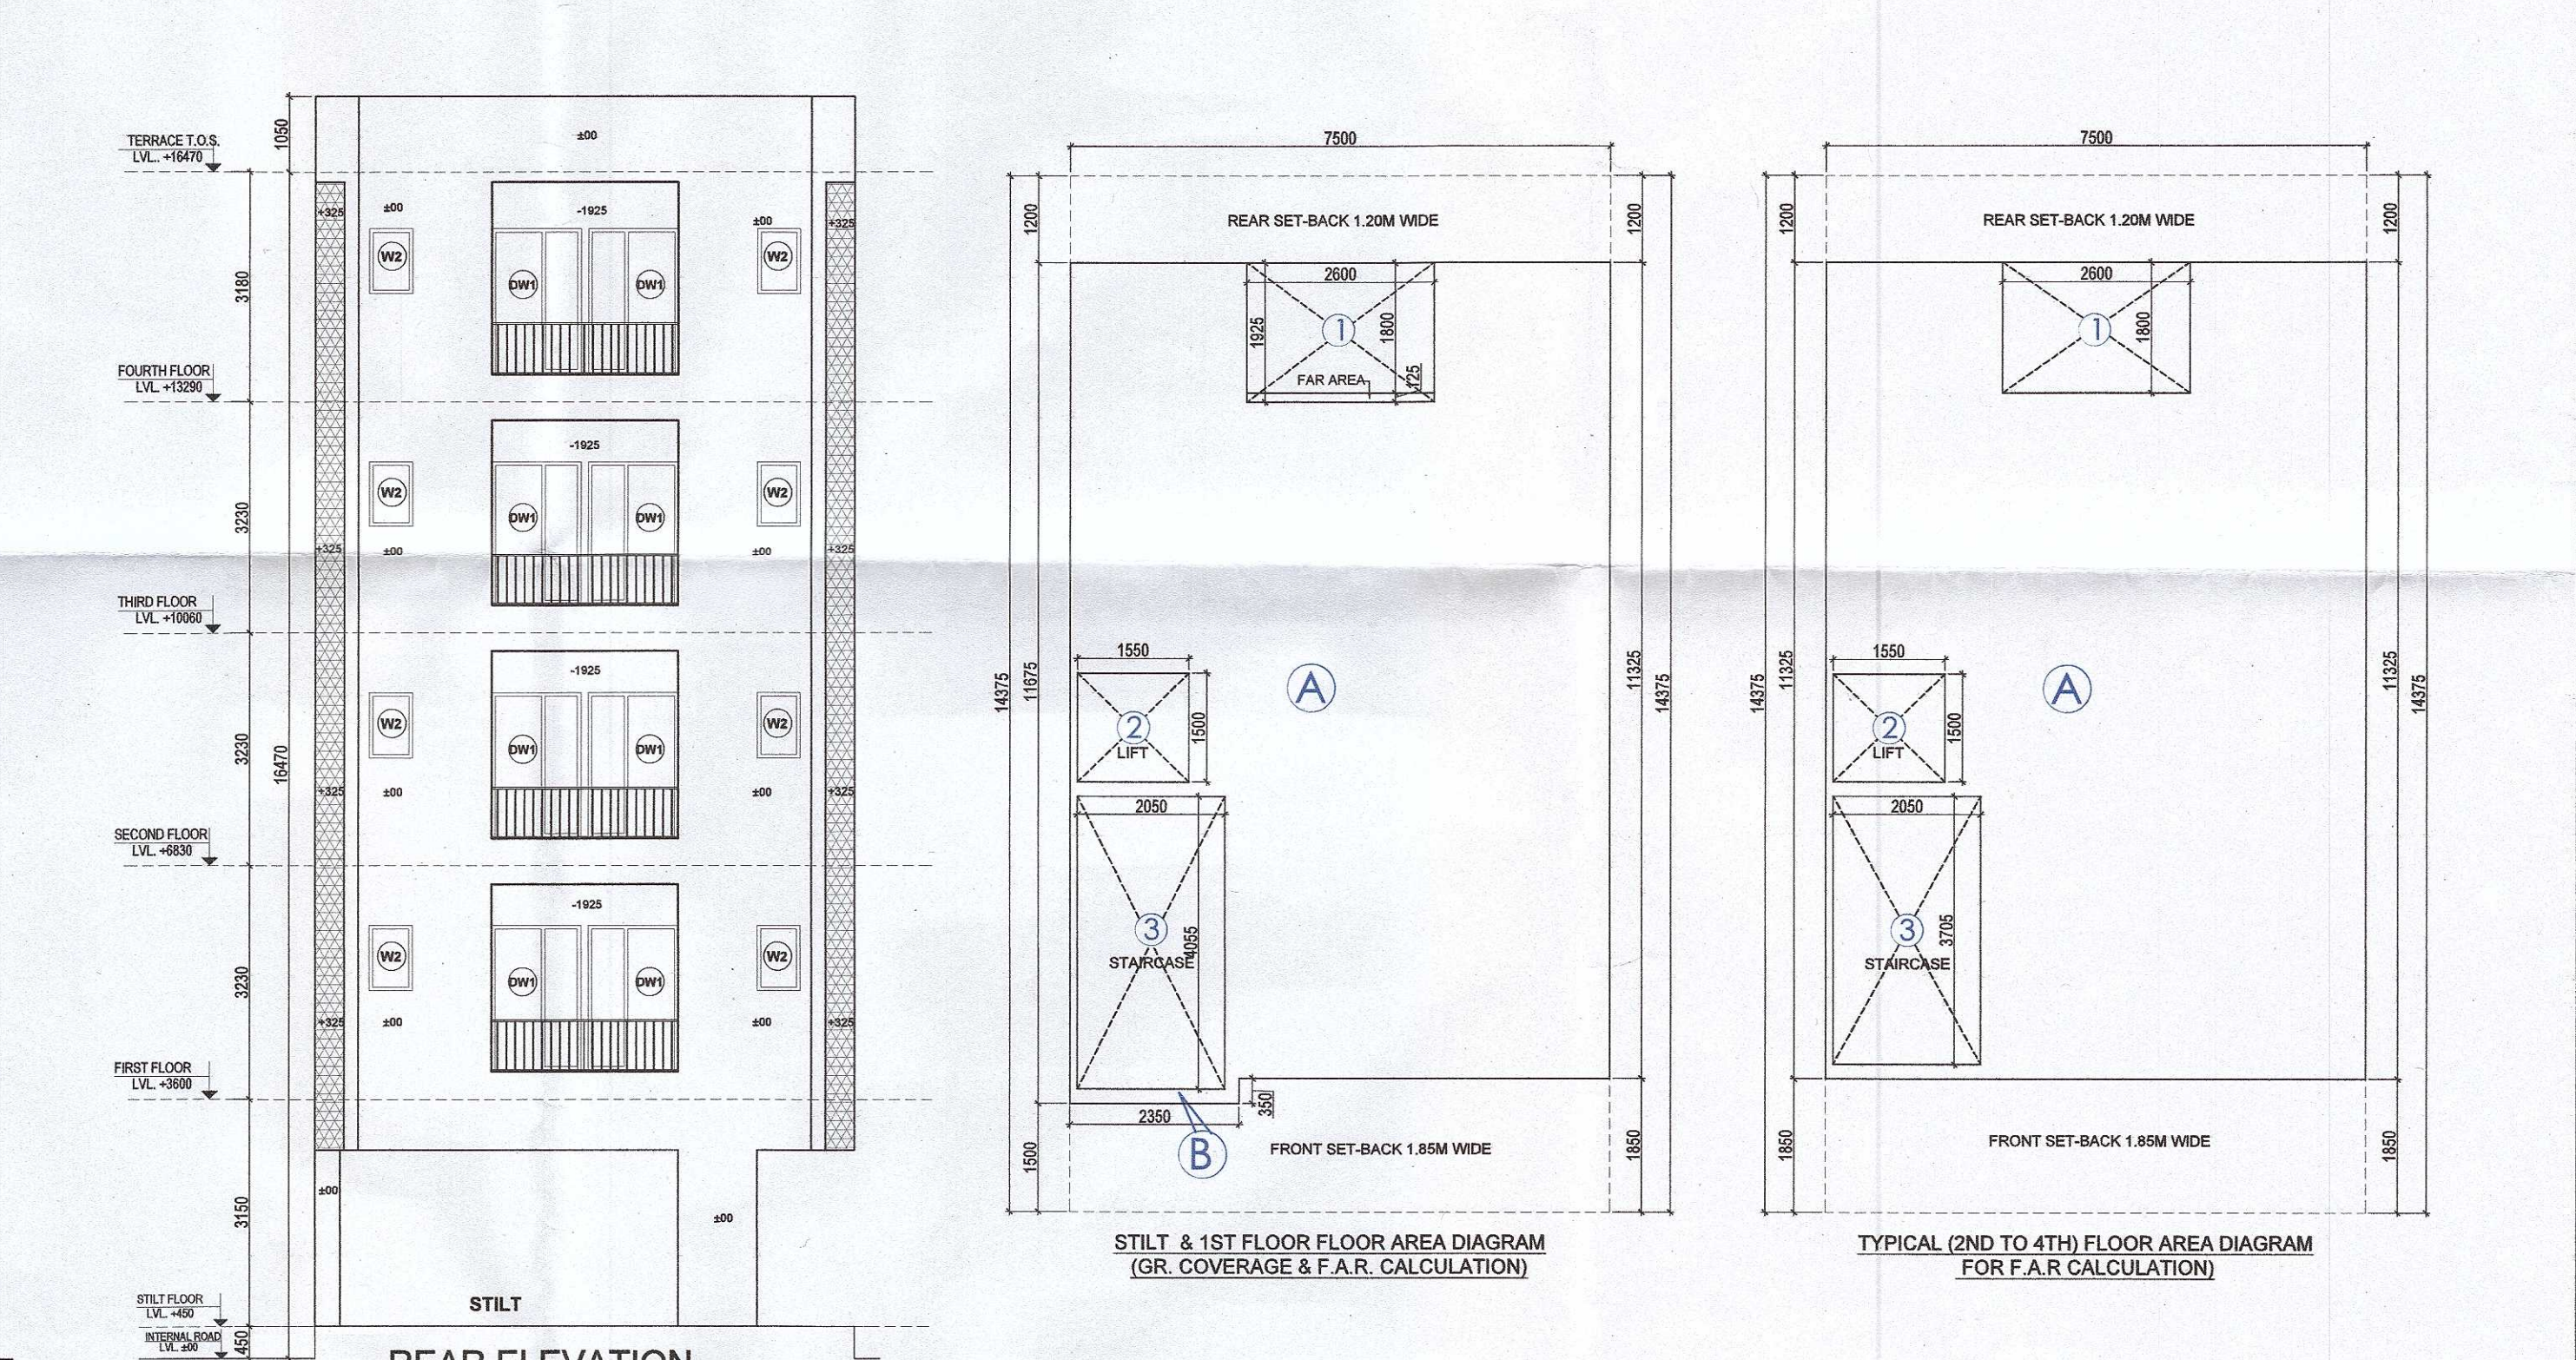
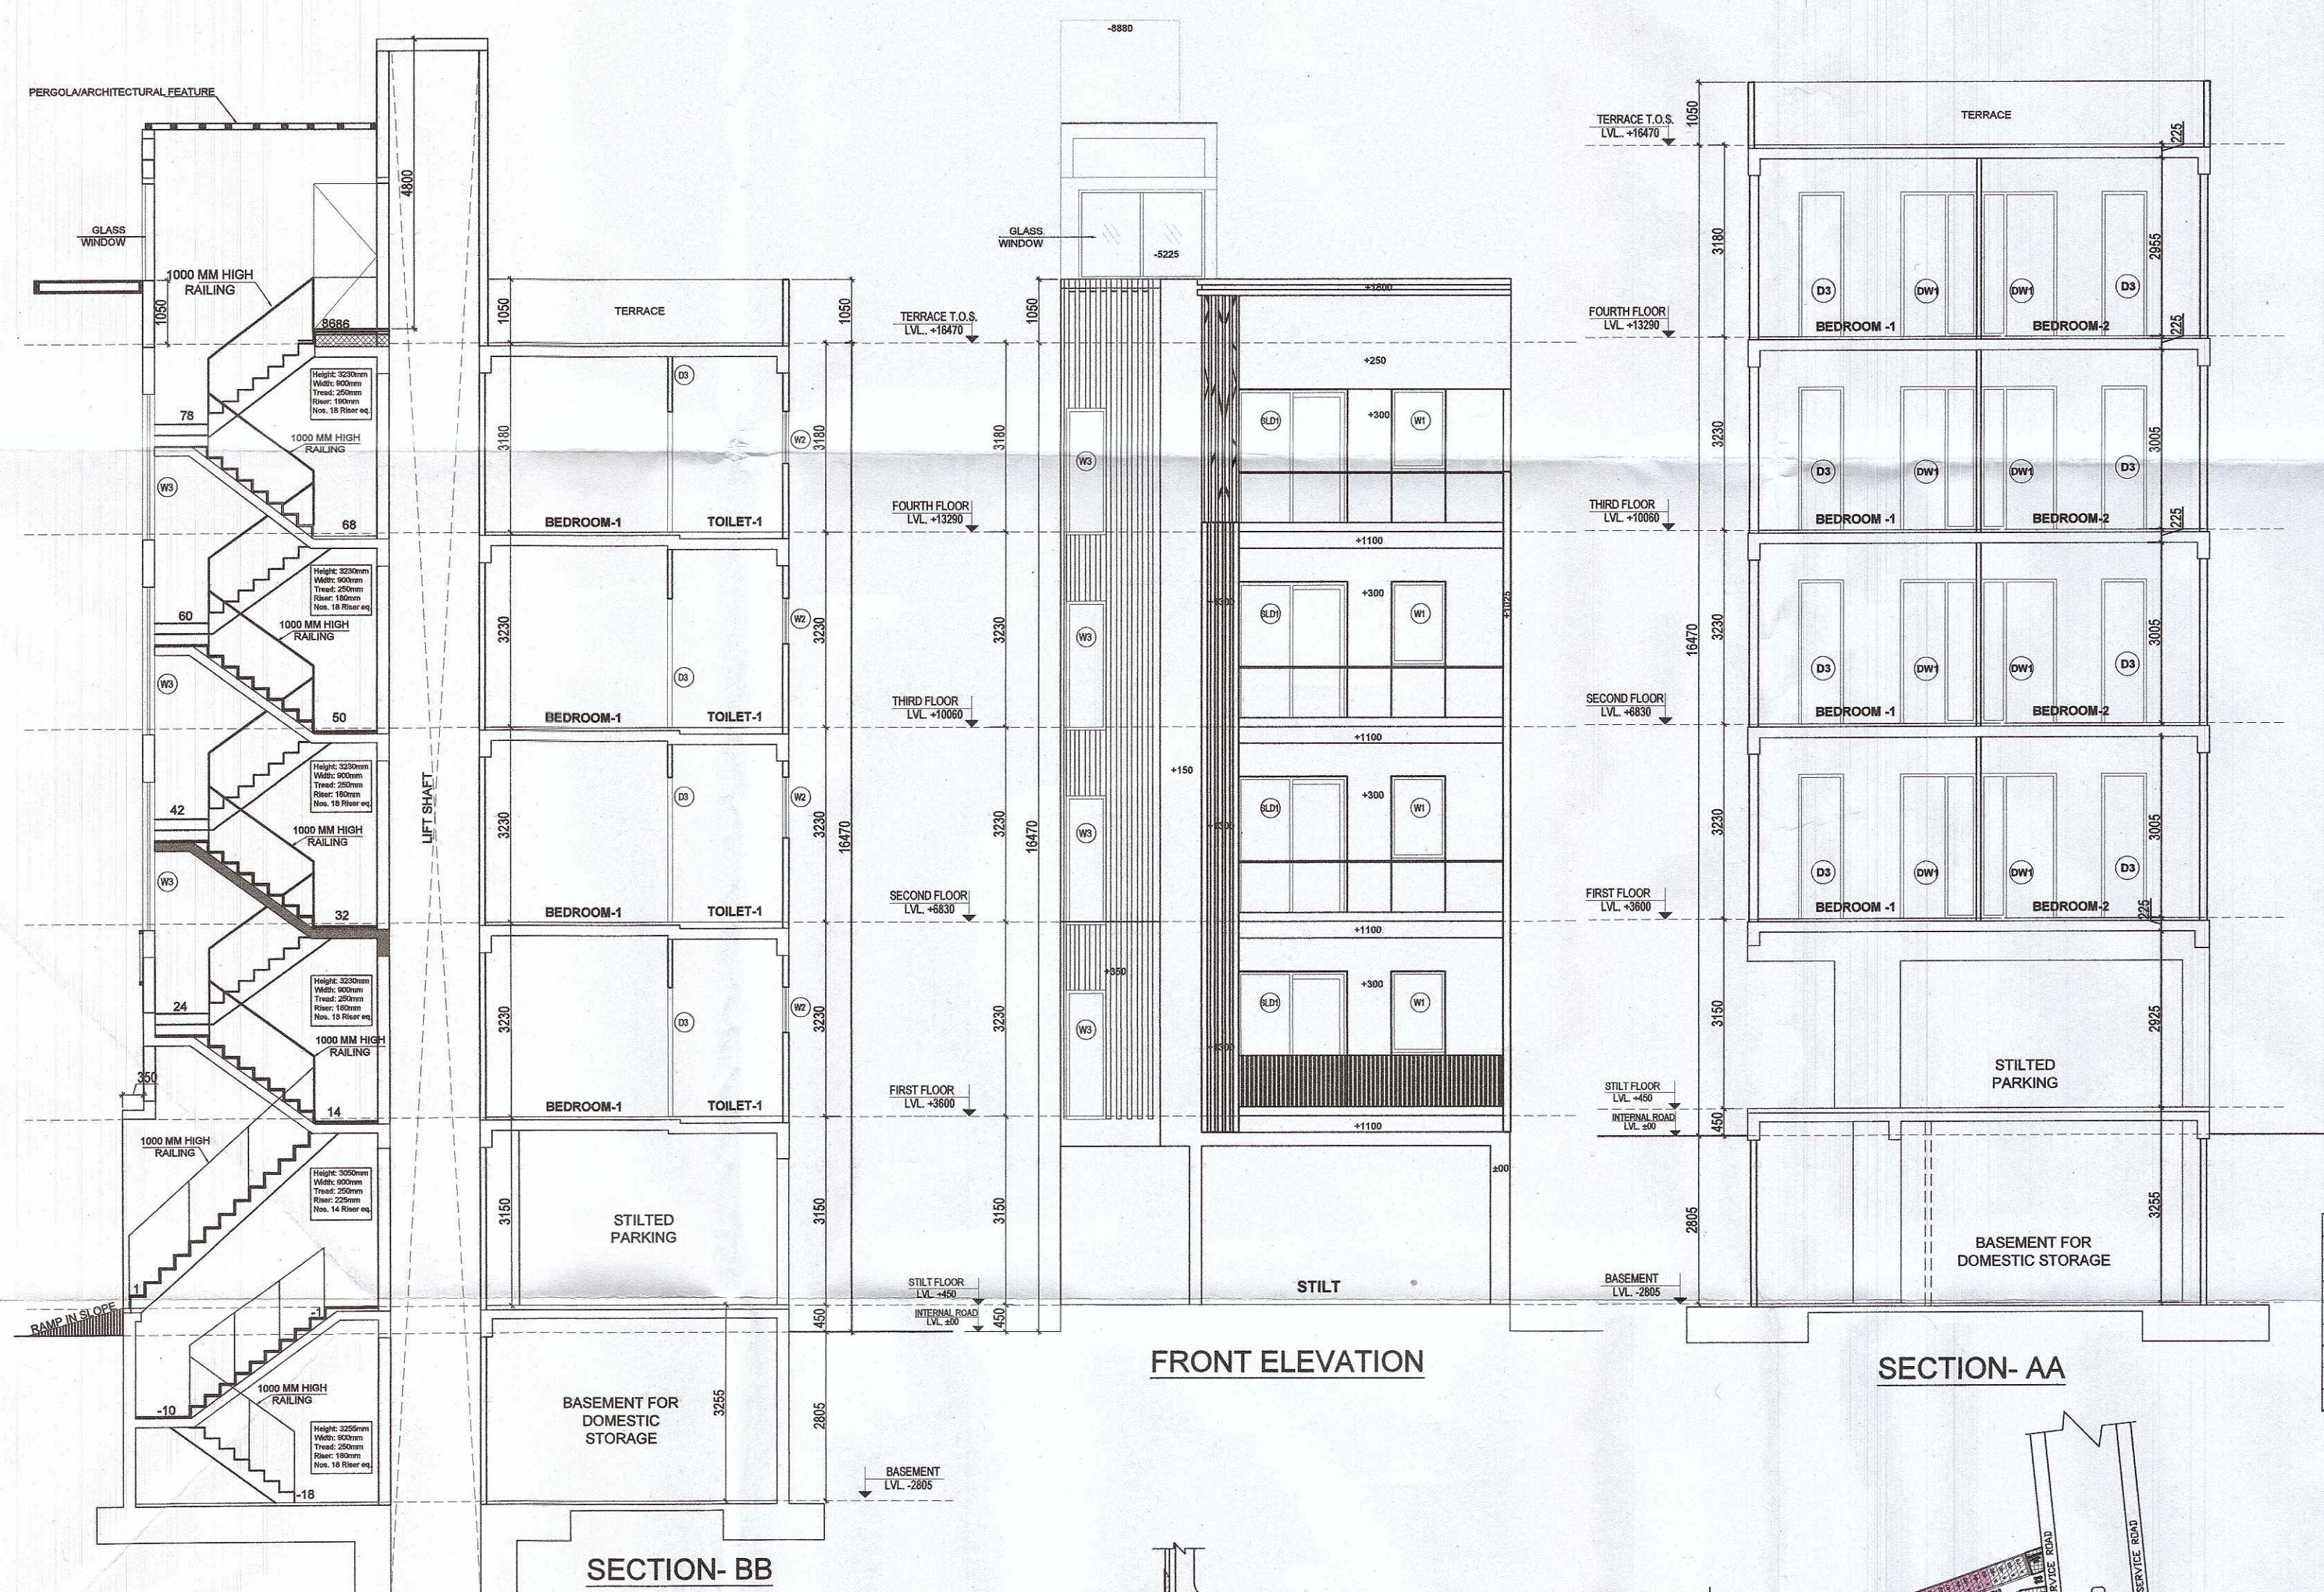


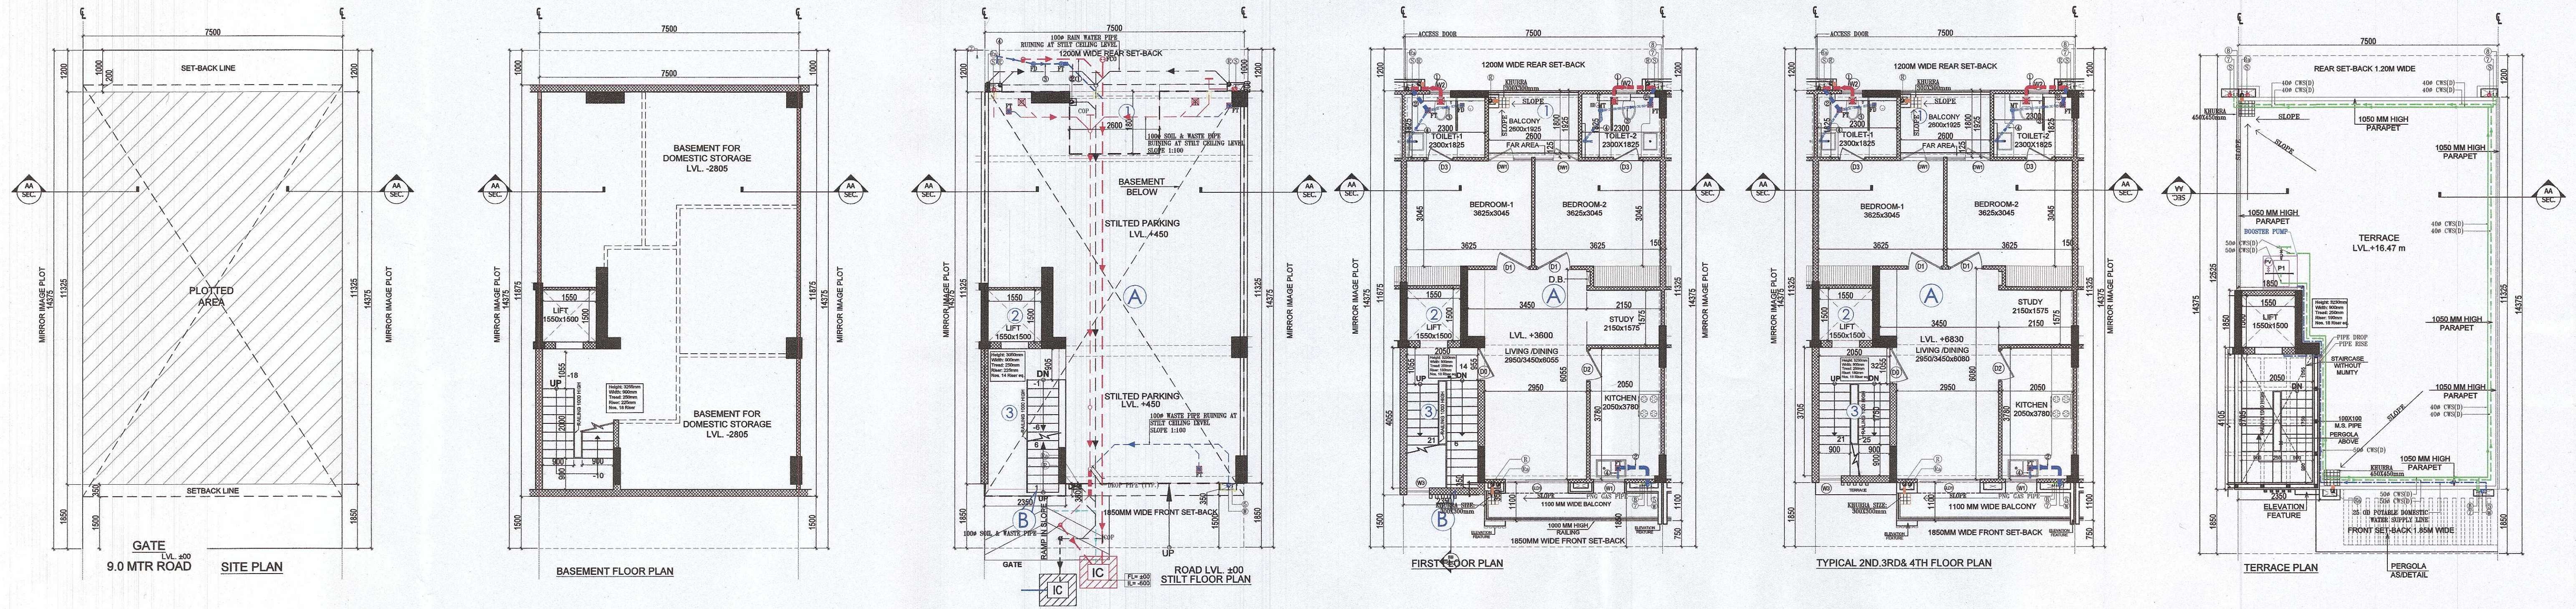

AREA CALCULATION			
PLOT AREA (7.50MX14.376M)	=	107.8125	SQMT. 10%
PERM. GROUND COVERAGE @75% OF PLOT AREA	=	80.859	SQMT. 75.00
PROPOSED GROUND COVERAGE	=	80.755	SQMT. 74.80
PERMISSIBLE F.A.R @ 284% OF PLOT AREA	=	284.625	SQMT. 284.00
PROPOSED F.A.R	=	283.779	SQMT. 283.22

NOTE:- PLOT No.-D-71, D-72, D-73, D-74 REMOVED

PROJECT NAME & ADDRESS
PROPOSED BUILDING PLAN ON PLOT NO.- D-112, D-119, D-131 (3 PLOTS)
FOR RESIDENTIAL PLOTTED COLONY UNDER DEEN DAYAL
JAN AWAS YOUNA SCHEME -2016 IN SECTOR-81, GURUGRAM (HR.),
LAND MEASURING 23.9999 ACRES, BEING DEVELOPED BY
SUPOSHAA REALCON PRIVATE LIMITED.

OWNER'S NAME
M/s. SUPOSHAA REALCON PRIVATE LIMITED.

DRAWING TITLE
TYPE: D - FLOOR PLANS WITH AREA CALCULATION, ELEVATIONS & SECTIONS (LEFT SIDE)

AUTHORIZED SIGNATORY
Sundil Kumar

ARCHITECT SIGNATURE
RANV GANDHI
LIC. No.-CA/191/13852

DATE:
SHEET- 01 OF 01
SCALE 1:100

SYMBOL	DESCRIPTION
1	110 OD UPVC SOIL PIPE
2	110 OD UPVC WASTE PIPE
3	75 OD UPVC RAIN WATER PIPE FOR BALCONY
4	110 OD UPVC RAIN WATER PIPE FOR TERRACE
5	110 OD UPVC SOIL PIPE
6	110 OD UPVC WASTE PIPE
7	50 OD UPVC WASTE PIPE FOR FLOOR DRAIN OUTLET
8	50 OD UPVC WASTE PIPE FOR FLOOR DRAIN OUTLET
9	50 OD UPVC WASTE PIPE FOR KITCHEN SINK
10	40 OD UPVC WASTE PIPE FOR WASH BASIN SINK
11	25 OD POTABLE DOMESTIC WATER SUPPLY LINE TO O.B.T.
12	DOMESTIC WATER SUPPLY PIPE FROM O.B.T. TO 1ST TO 4TH FLOOR
13	DOMESTIC WATER SUPPLY PIPE FROM O.B.T. TO 1ST TO 2ND FLOOR
14	DOMESTIC BOOSTER PUMP
15	PRESSURE TANK
16	60MM DIA. CUTOUT FOR WASH BASIN SINK
17	150X150 mm CUTOUT FOR FLOOR DRAIN
18	150X150 mm CUTOUT FOR FLOOR TRAP
19	200X200 mm CUTOUT FOR WC

S.NO.	TYPE	SIZE	CALL LEVEL	UNTEL LEVEL
1	D	90X2400	00	2400
2	D0	105X2400	00	2400
3	D1	100X2400	00	2400
4	D2	90X2400	00	2400
5	D3	75X2400	00	2400
6	DW1	125X2400	00	2400
7	SLJF	100X2400	00	2400
8	W1	90X1150	1050	2400
9	W2	60X1200	1200	2400
10	W3	60X2400	660	2400

