
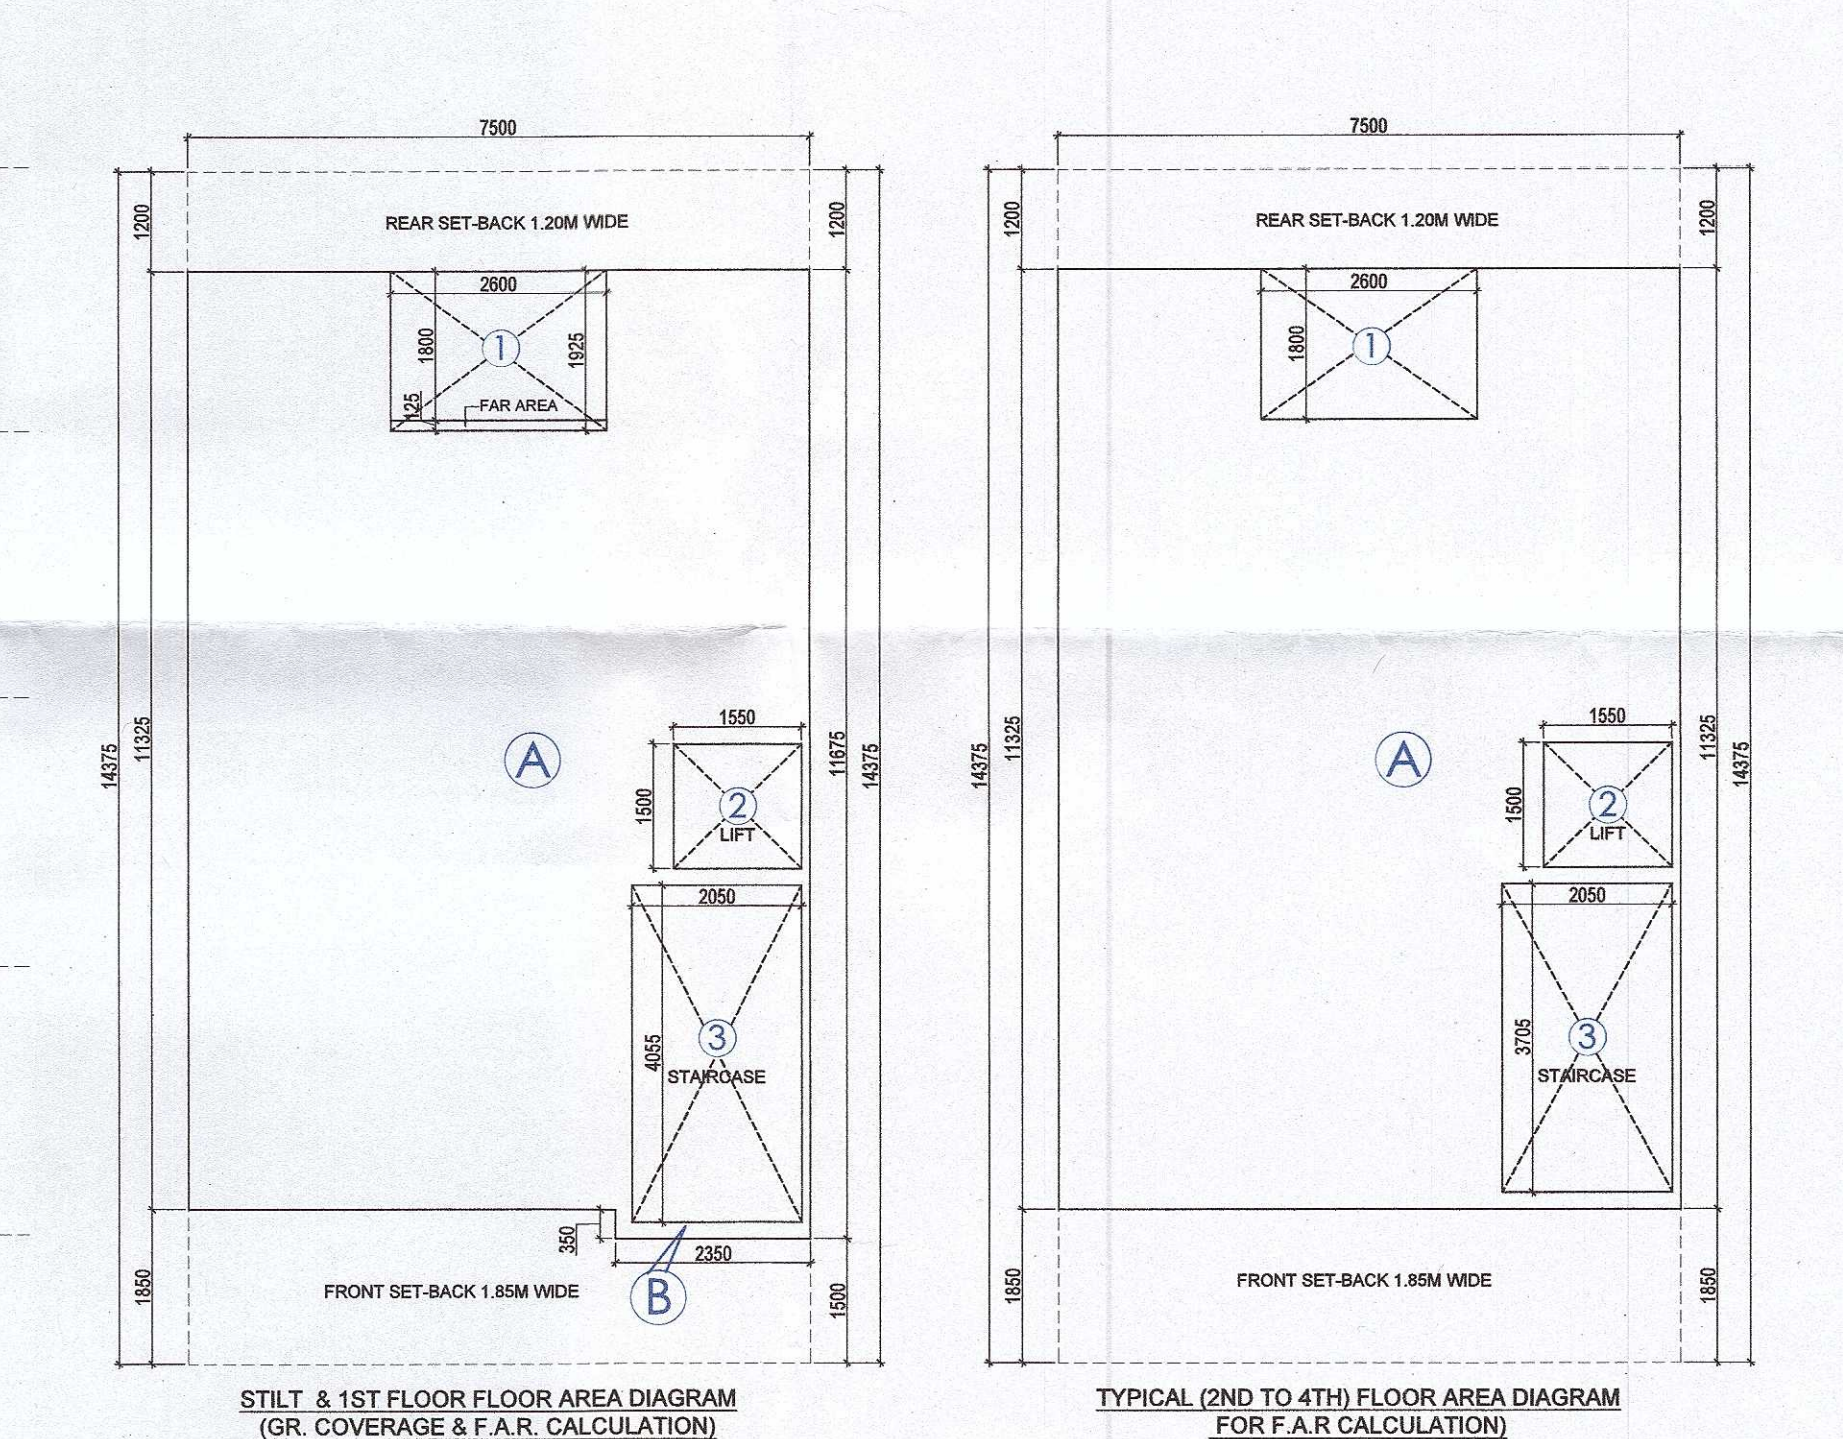
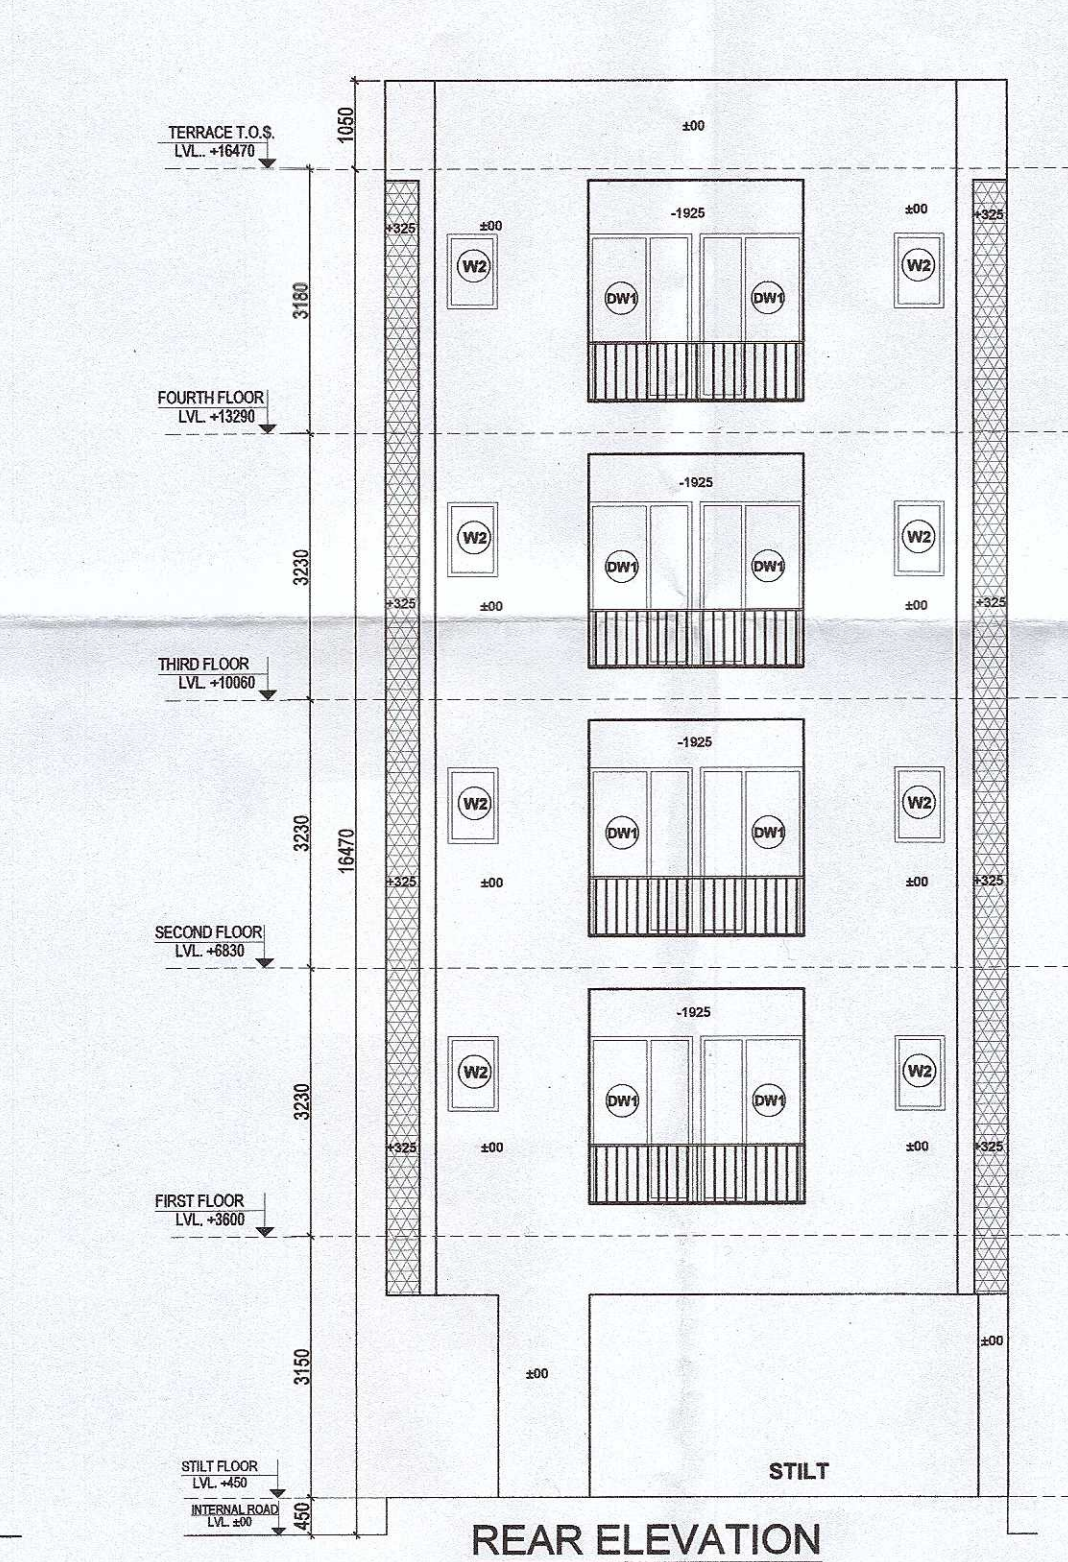
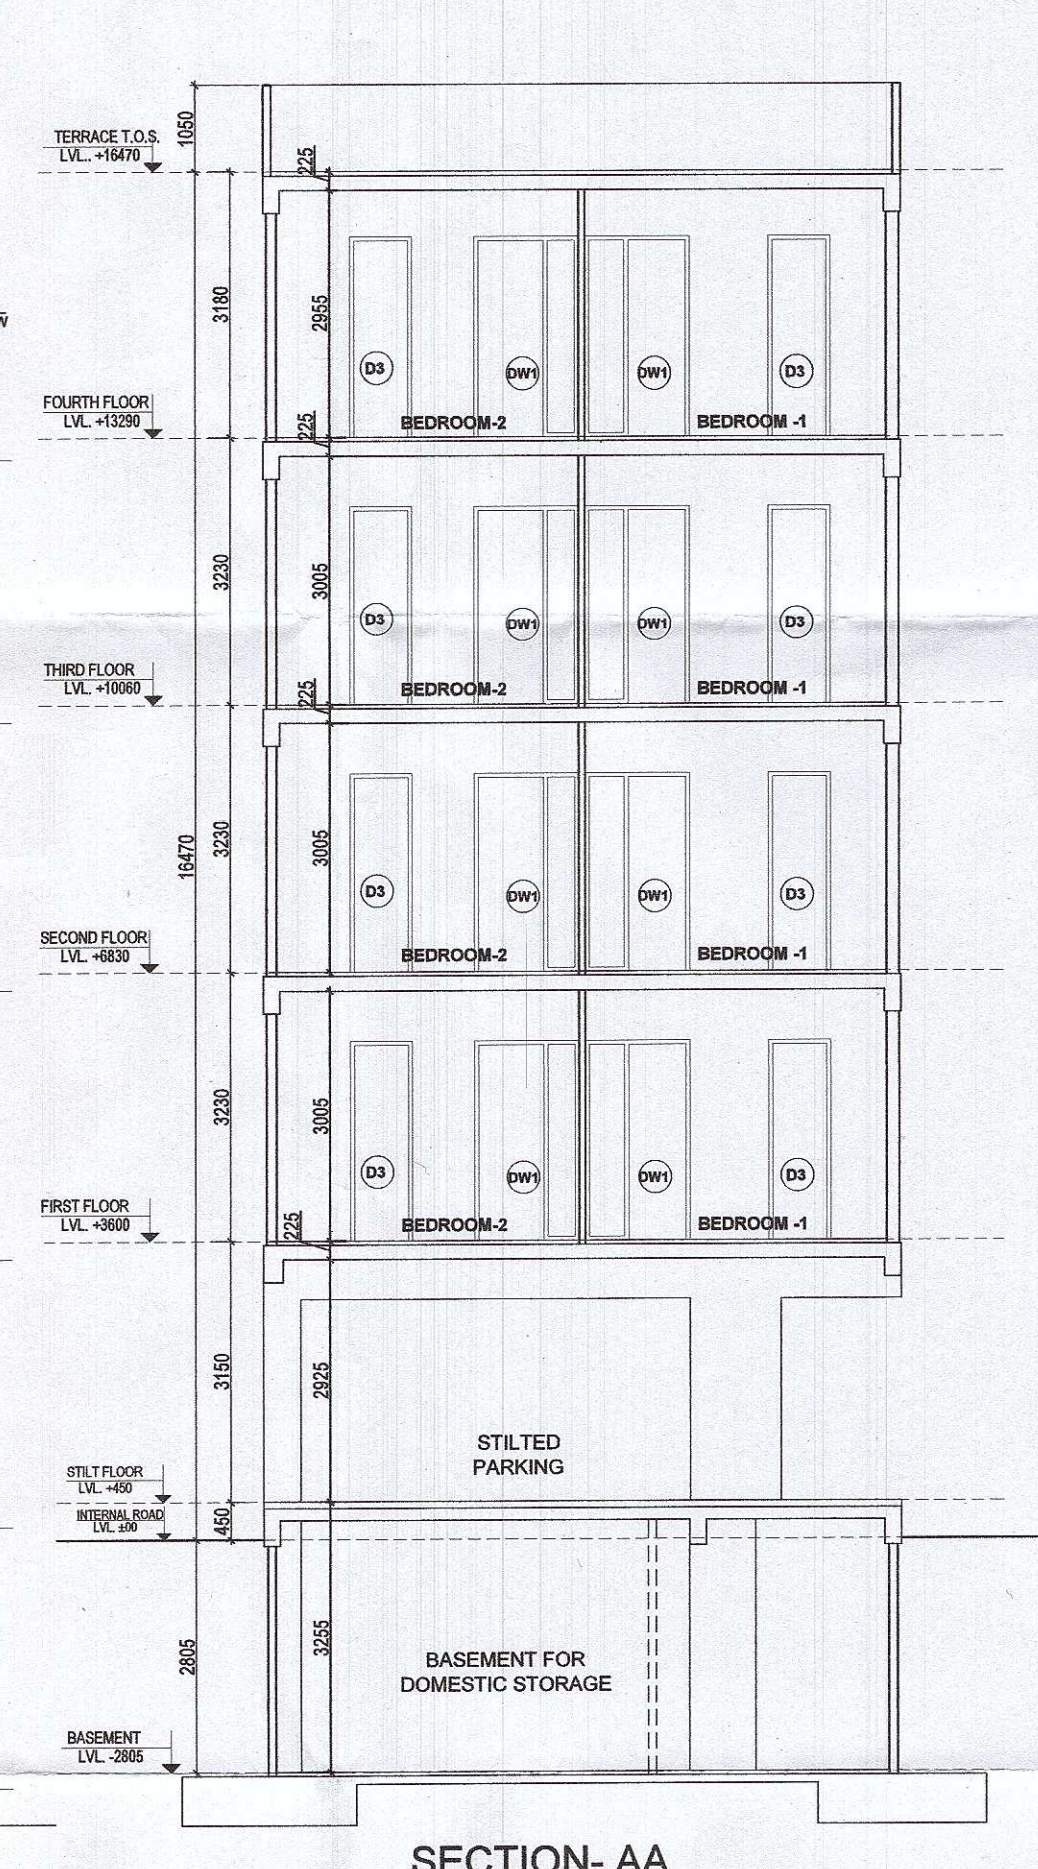
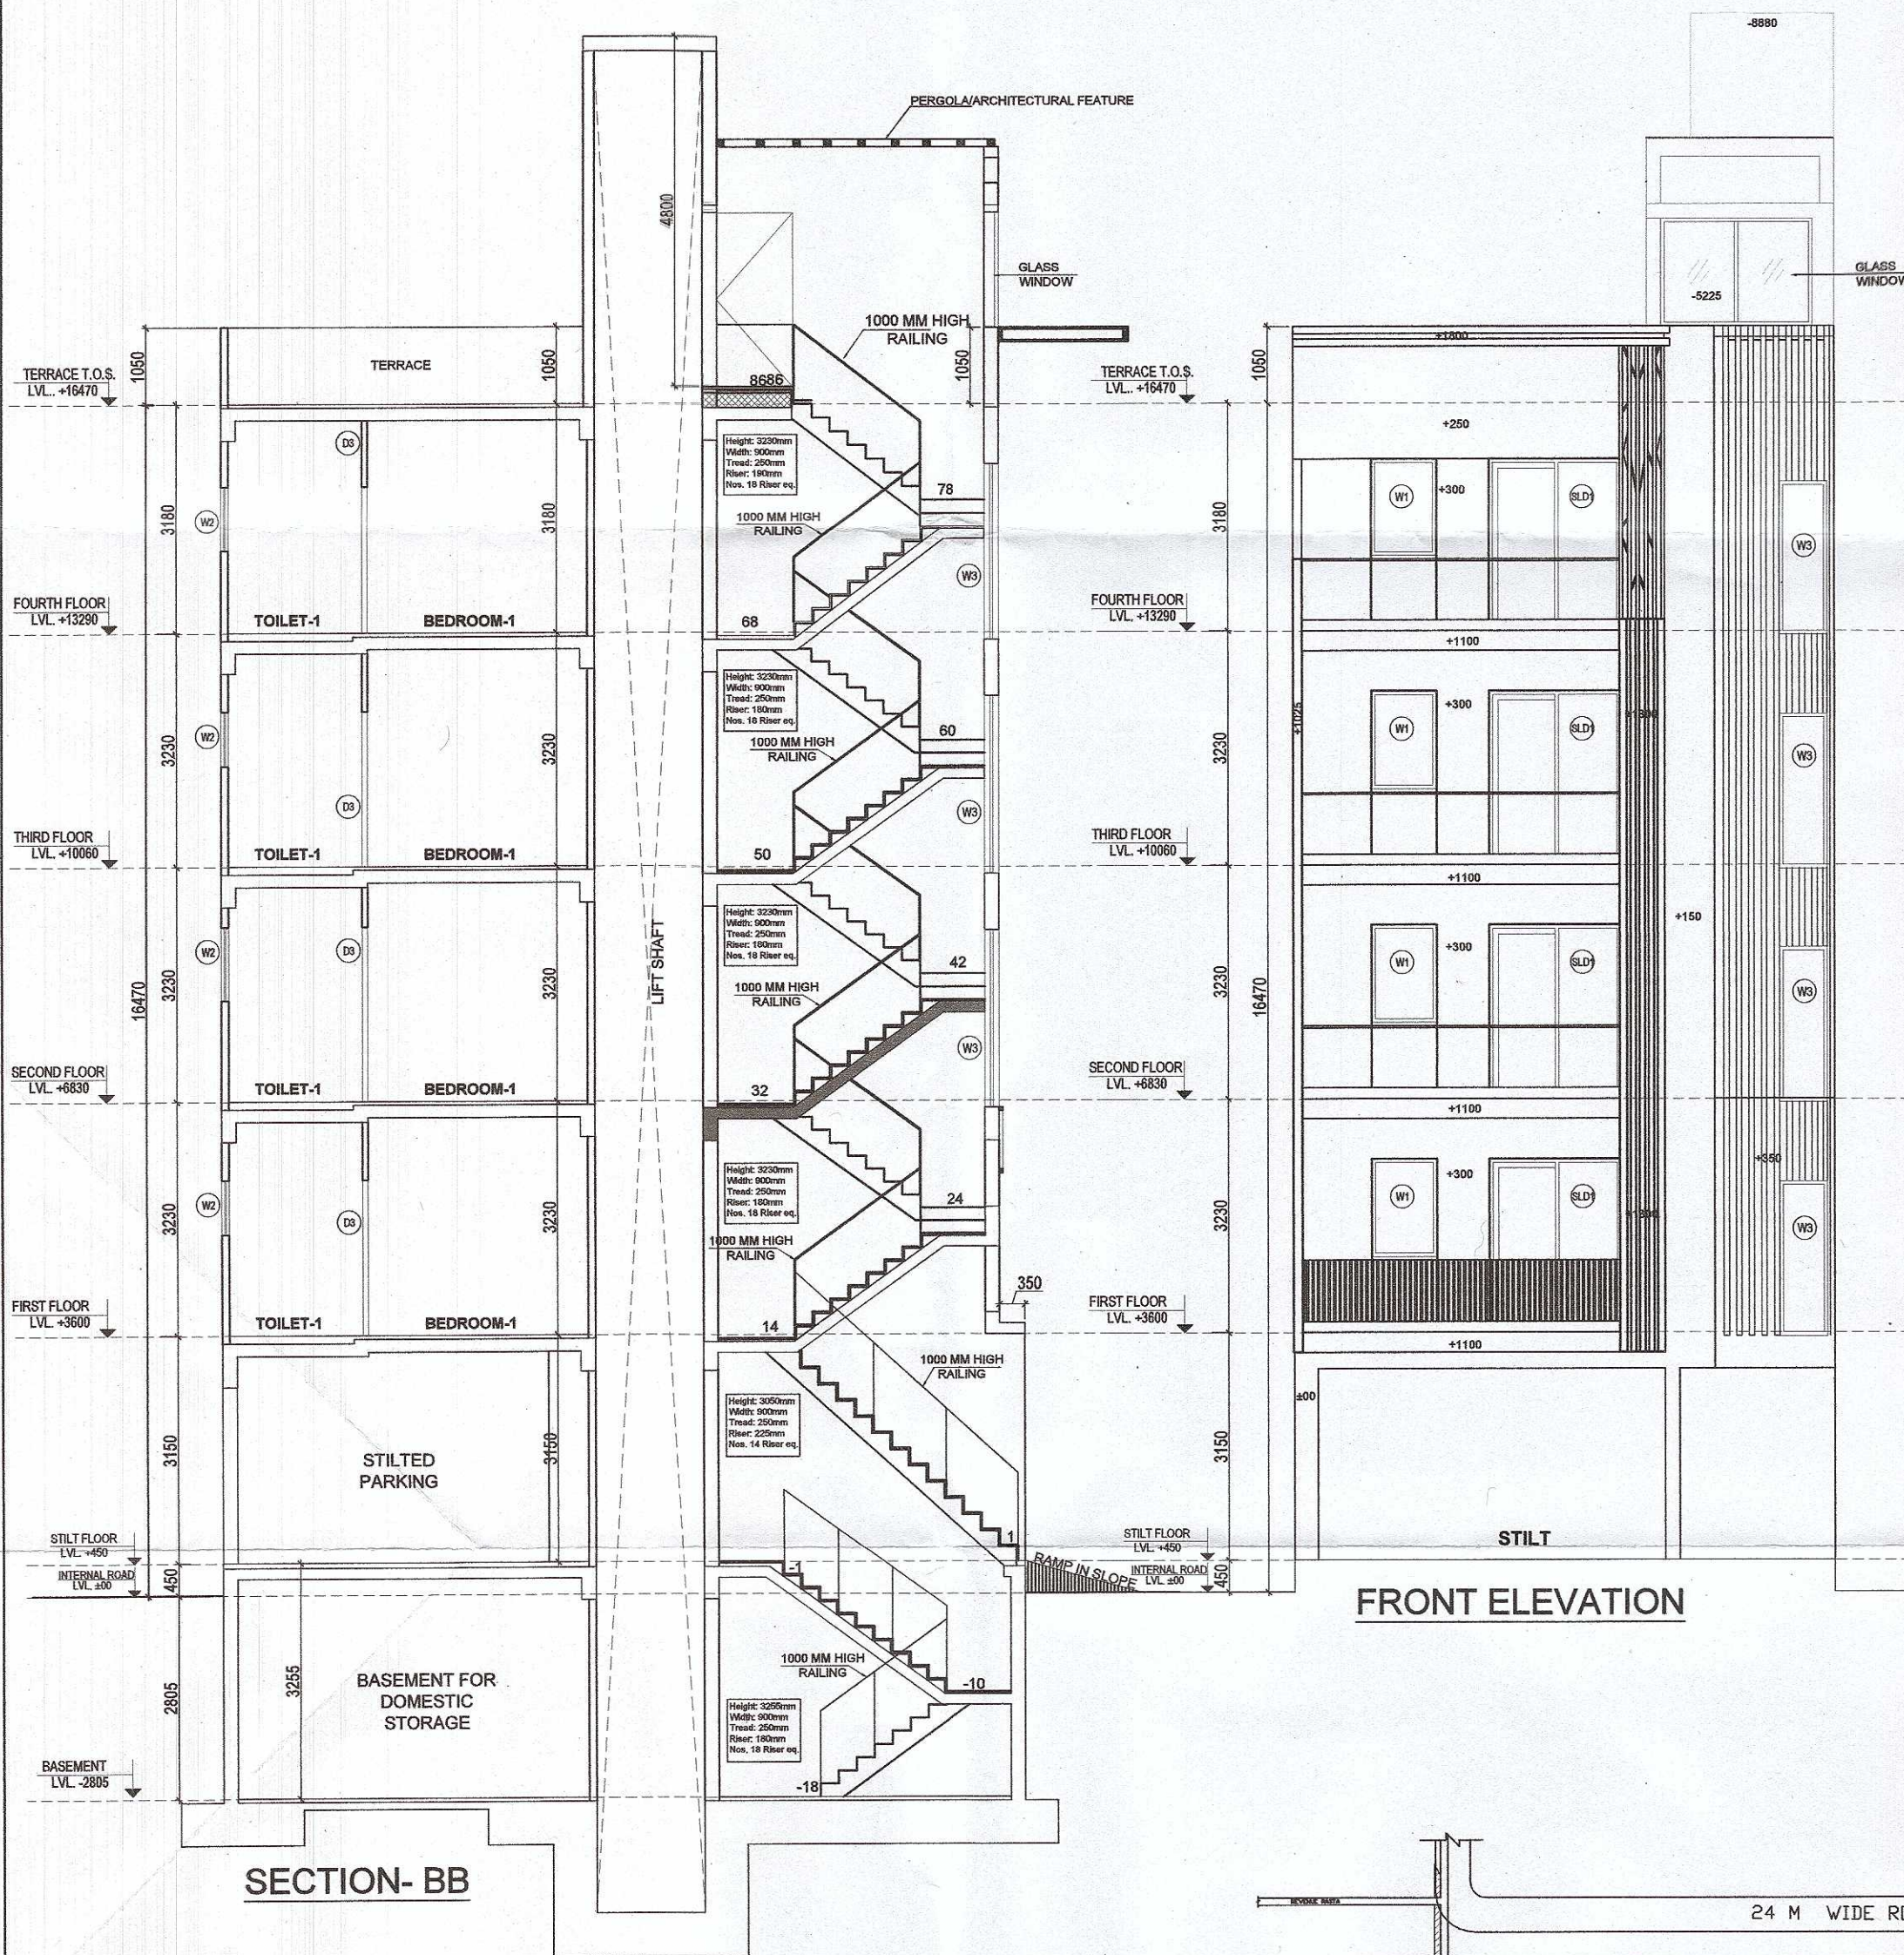


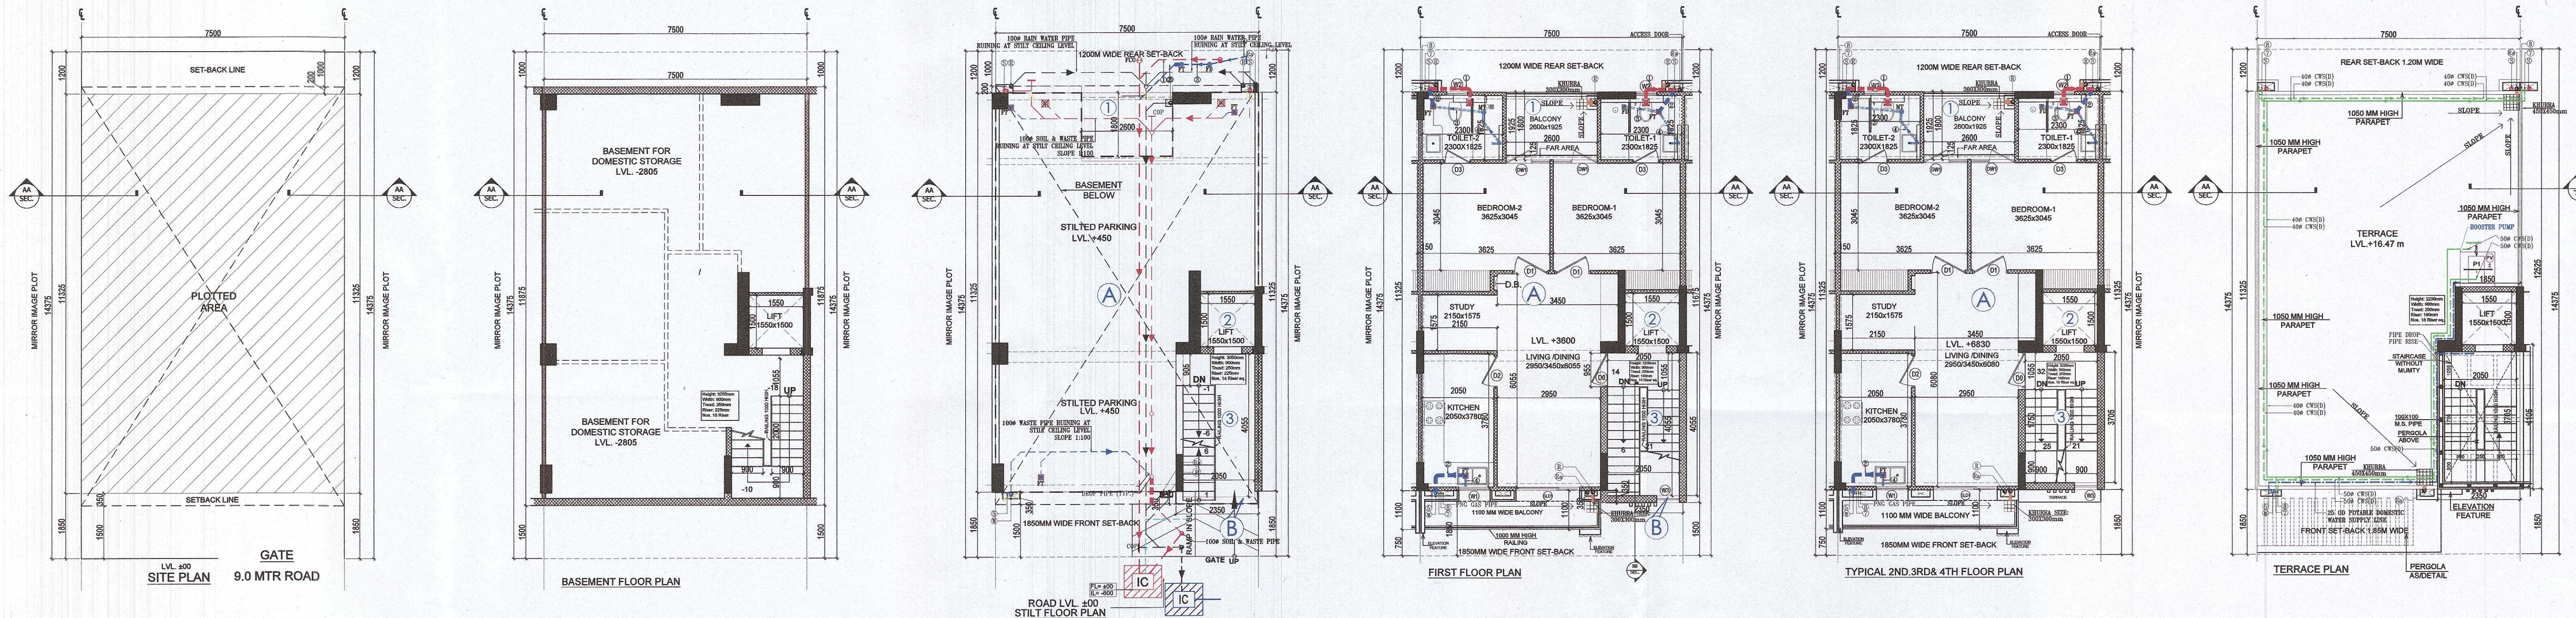

AREA CALCULATION				
PLOT AREA (7.50MX14.375M)	=	107.8125	SQMT.	10%
PERM. GROUND COVERAGE @75% OF PLOT AREA	=	80.859	SQMT.	75.00
PROPOSED GROUND COVERAGE	=	80.755	SQMT.	74.90
PERMISSIBLE F.A.R. @ 284% OF PLOT AREA	=	284.625	SQMT.	284.00
PROPOSED F.A.R.	=	283.779	SQMT.	283.22

NOTE:- PLOT No.-D-71, D-72, D-73, D-74 REMOVED

PROJECT NAME & ADDRESS
REVISED BUILDING PLAN ON PLOT NO.- D-23, D-25, D-27, D-29, D-31, D-33, D-35, D-49, D-51, D-53, D-55, D-57, D-59, D-61, D-65, (15 FROZEN PLOTS), D-1, D-15, D-17, D-19, D-21, D-37, D-39, D-41, D-43, D-45, D-47, D-53, D-55, D-67, D-69, (15 PLOTS) FOR RESIDENTIAL PLOTTED COLONY UNDER DEEN DAYAL JAN AWAS YOUNA SCHEME -2016 IN SECTOR-61, GURUGRAM (HR.), LAND MEASURING 23.29999 ACRES. BEING DEVELOPED BY SUPOSHAA REALCON PRIVATE LIMITED.

OWNER'S NAME
M/s. SUPOSHAA REALCON PRIVATE LIMITED.

DRAWING TITLE
TYPE: D - FLOOR PLANS WITH AREA CALCULATION, ELEVATIONS & SECTIONS (RIGHT SIDE)


ARCHITECT SIGNATURE
RAJIV KANDHI ARCHITECT
LIC. No.-CA/191/13852

AUTHORIZED SIGNATORY
Sundil Kumar

DATE:
SHEET- 01 OF 01
SCALE 1:100

LEGEND:-	DESCRIPTION
110 ØD UPVC SOIL PIPE	
110 ØD UPVC WASTE PIPE	
75 ØD UPVC RAIN WATER PIPE FOR BALCONY	
110 ØD UPVC RAIN WATER PIPE FOR TERRACE	
110 ØD UPVC SOIL PIPE	
110 ØD UPVC WASTE PIPE	
50 ØD UPVC WASTE PIPE FOR FLOOR DRAIN OUTLET	
63 ØD UPVC WASTE PIPE FOR FLOOR DRAIN OUTLET	
50 ØD UPVC WASTE PIPE FOR KITCHEN SINK	
40 ØD UPVC WASTE PIPE FOR WASH BASIN SINK	
25 ØD POLYETHYLENE WATER SUPPLY LINE TO O.B.T.	
Ø100 DOMESTIC WATER SUPPLY PIPE	
DOMESTIC WATER SUPPLY PIPE FROM O.B.T. TO 1ST TO 2ND FLOOR	
DOMESTIC WATER SUPPLY PIPE FROM O.B.T. TO 3RD TO 4TH FLOOR	
DOMESTIC BOOSTER PUMP	
PRESSURE VESSEL	
60X65 mm CUTOUT FOR WASH BASIN SINK	
150X150 mm CUTOUT FOR FLOOR DRAIN	
150X150 mm CUTOUT FOR FLOOR TRAP	
250X250 mm CUTOUT FOR ST	

S.NO.	TYPE	SIZE	CILL LEVEL	LINTEL LEVEL
1	D	865X2400	00	2400
2	D	1055X2400	00	2400
3	D1	1000X2400	00	2400
4	D2	900X2400	00	2400
5	D3	750X2400	00	2400
6	DW1	1200X2400	00	2400
7	SD1	1600X2400	00	2400
8	W1	800X1350	1050	2400
9	W2	600X1200	1200	2400
10	W3	600X2400	650	ABOVECEILING

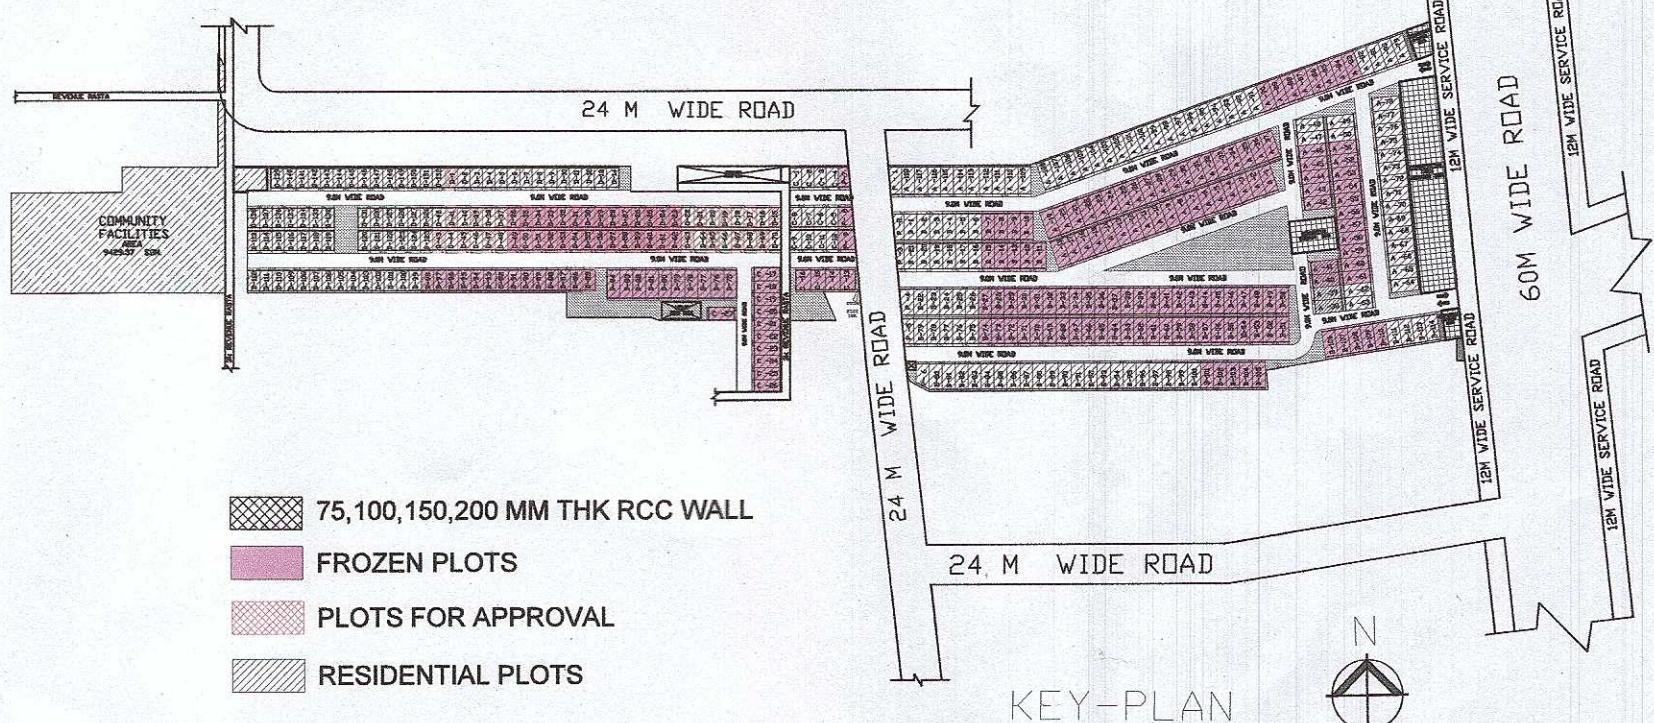

75,100,150,200 MM THK RCC WALL
FROZEN PLOTS
PLOTS FOR APPROVAL
RESIDENTIAL PLOTS

6
T-D