


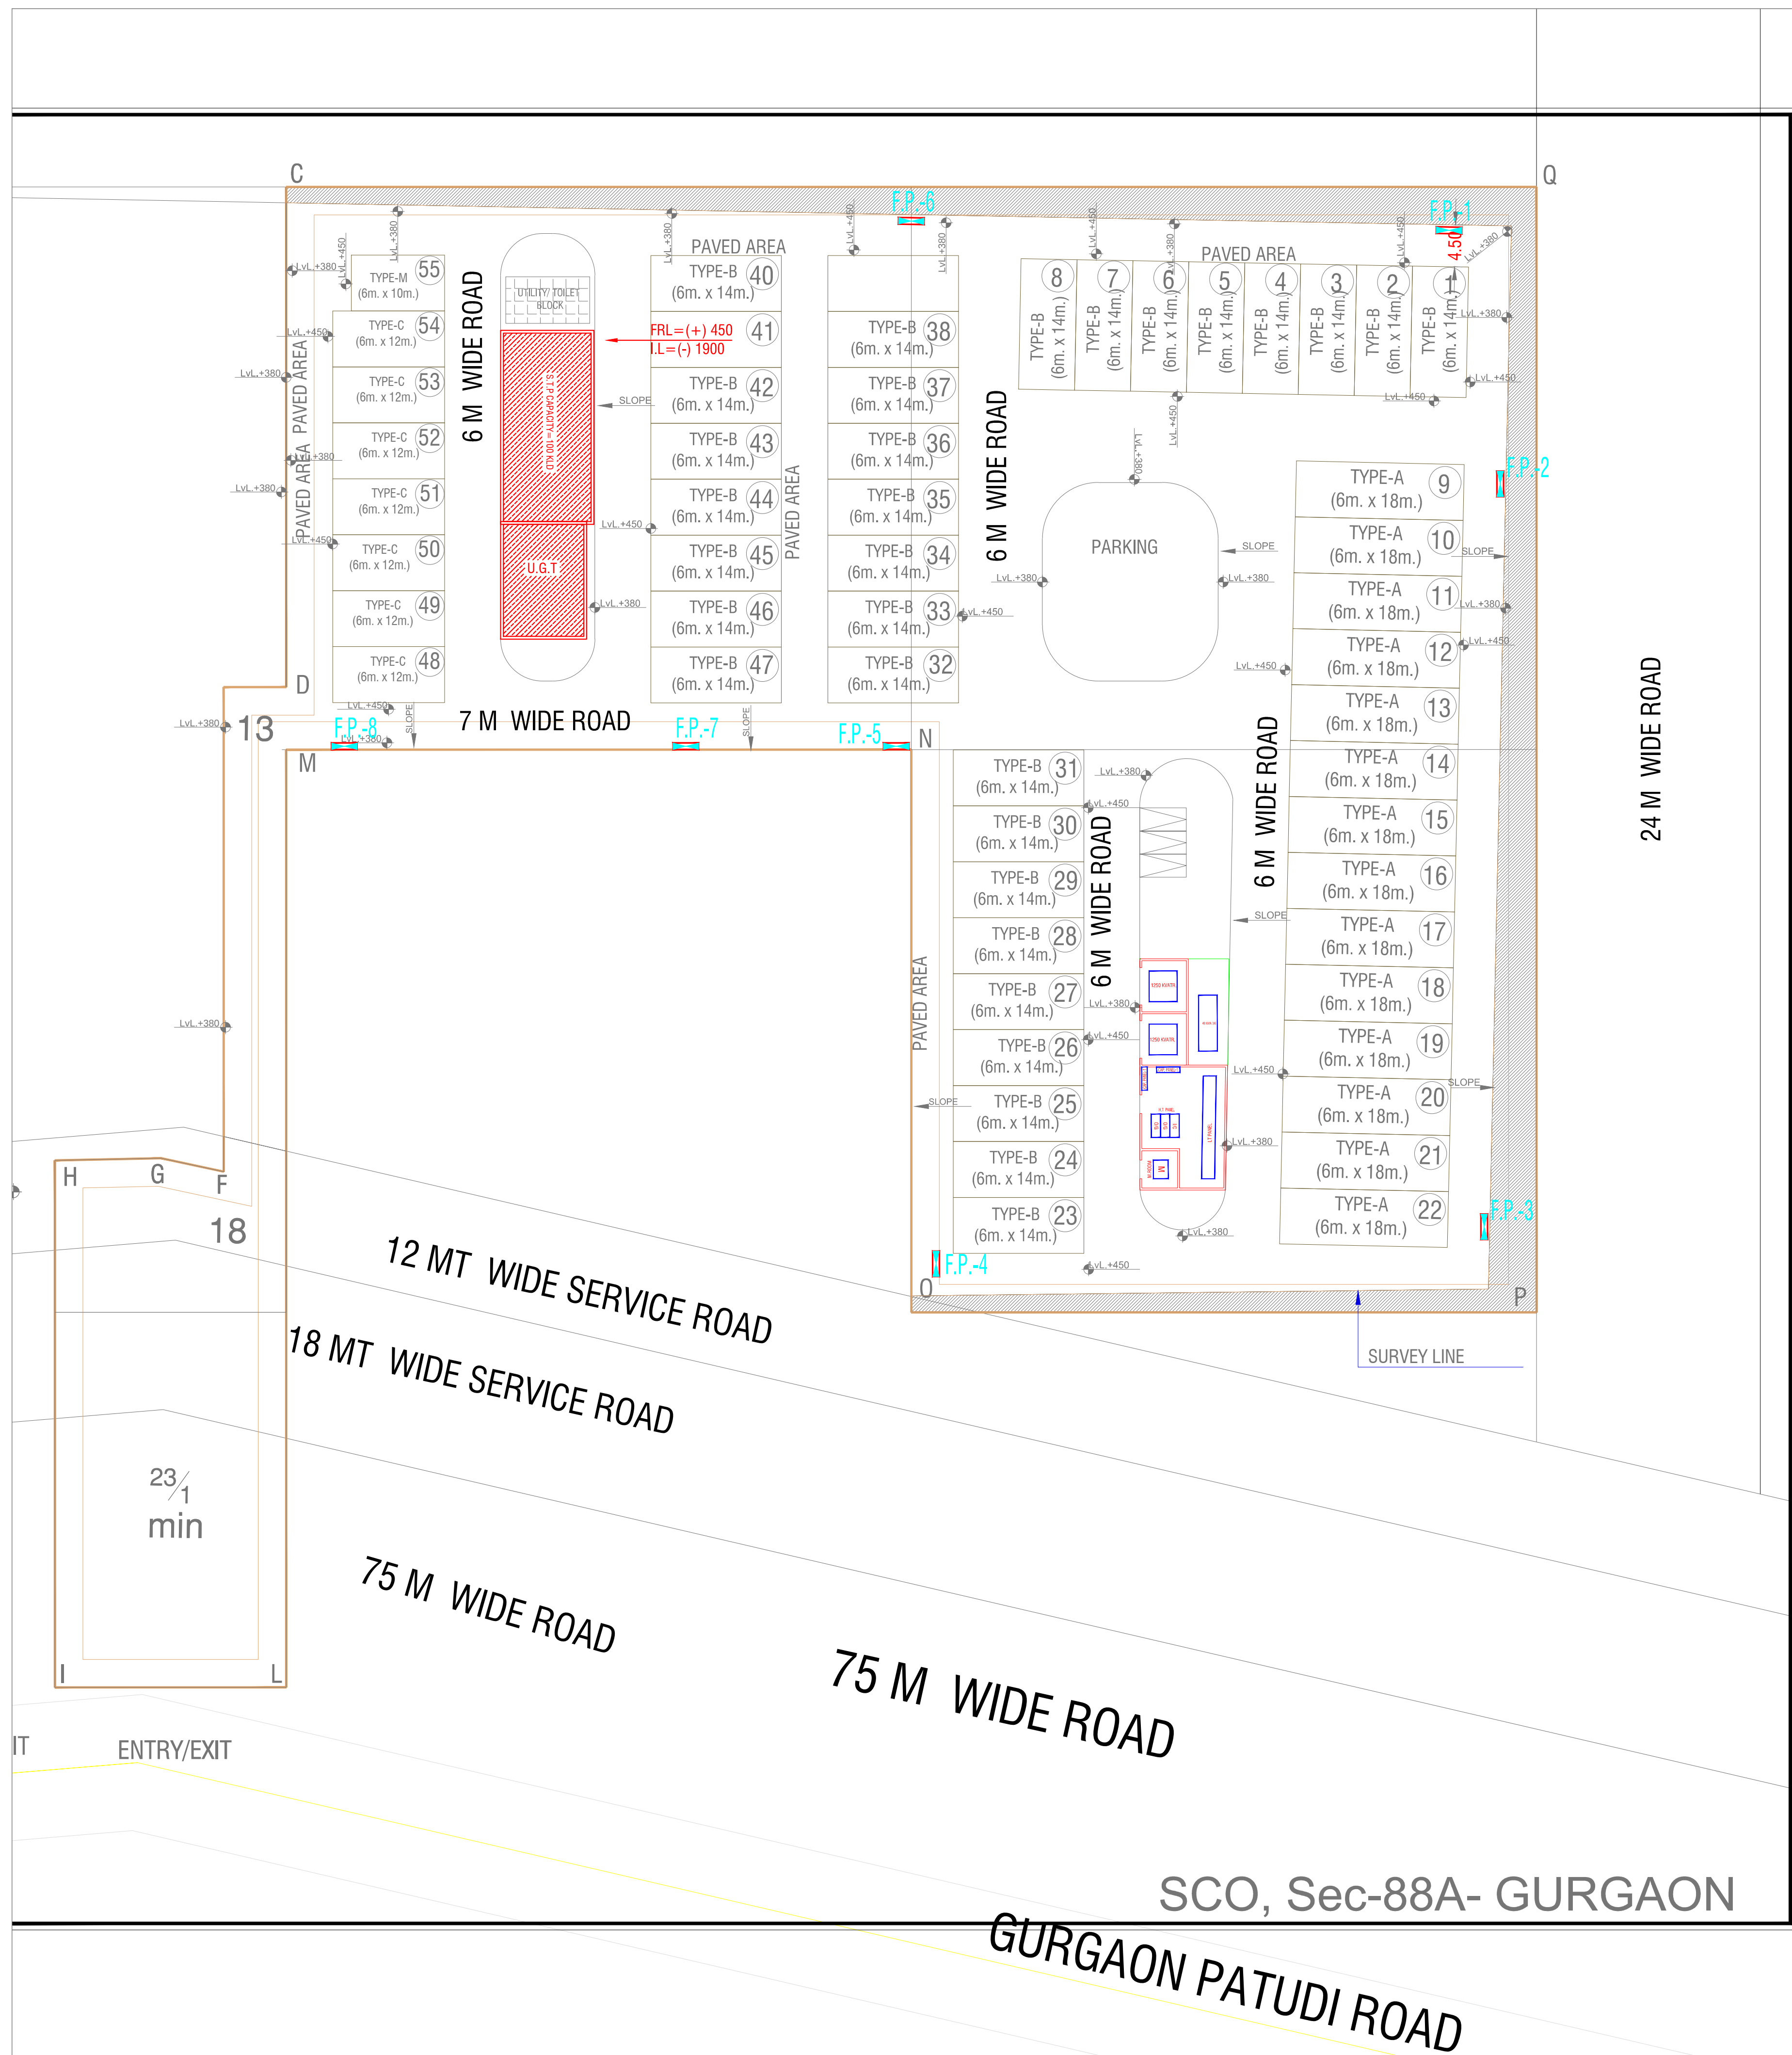

PROJECT NAME AND ADDRESS :
LAYOUT PLAN OF PROPOSED PLOTTED COMMERCIAL COLONY FOR AN AREA 3.428 ACRES, IN SECTOR-88 A, GURUGRAM MANESAR URBAN COMPLEX BEING DEVELOPED BY YOHAAN BUILDCON LLP.

OWNER'S NAME:

SIGNATURE GLOBAL

Architects:
ARCHITECT'S SIGNATURE:
AR. AMAN THAKRAL
CA/2016/79767
AMBIN DESIGNS

MEP CONSULTANTS:
PARADISE CONSULTANTS
PLOT NO. 96, POCKET-1, BASEMENT
JASOLA VIHAR NEW DELHI - 110025
PH+011-46132800, 41030619
E-mail: paradiseconsultants@gmail.com

DRAWING TITLE :
ELECTRICAL SITE PLAN

scale :	drawn by :
date :	checked by :
project no :	approved by :
drawing no :	
REVISION	