


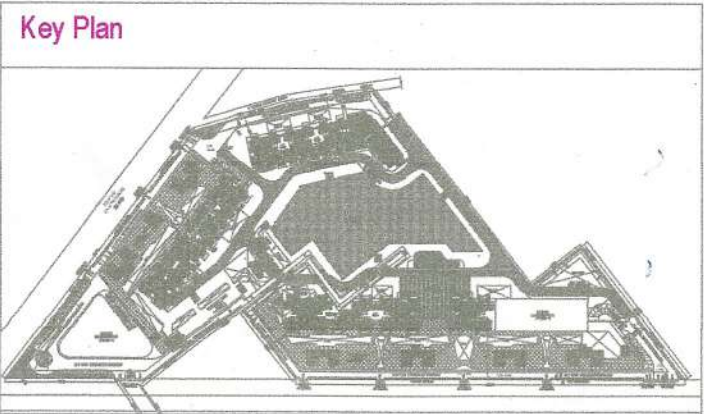

DOOR WINDOW SCHEDULE					
TYPE	WIDTH	HEIGHT	SILL LVL	UNTEL LVL	REMARKS
D1	1050	2400	± 00	2400	ENTRANCE (ONE HOUR FIRE RATED DOOR)
D2	900	2250	± 00	2250	BEDROOMS & MUMTY
D3	750	2250	± 00	2250	TOILETS
D4	800	2100	± 00	2100	MUMTY
D5	1250	2400	± 00	2400	STILT LOBBY ENTRANCE
D61	2500	2400	± 00	2400	BEDROOM
D62	2500	2400	± 00	2400	BEDROOM
D63	2400	2400	± 00	2400	DRAWING
D64	2025	2400	± 00	2400	BEDROOM
D65	1800	2400	± 00	2400	BEDROOM
D66	1400	2400	± 00	2400	BEDROOM
DW1	1800	1500	+0500	2400	KITCHEN
DW2	1285	2400	± 00	2400	BED ROOM
DW3	1150	1500	+0500	2400	KITCHEN
DW4	1075	2400	± 00	2400	BED ROOM
W1	500	1500	+0500	2400	TOILETS
W2	425	1500	+0500	2400	TOILETS
W1	1250	UP TO BOTTOM OF STAIR	+000 FROM P.S. FL. LVL	-	STAIRCASE
W2	800	2100	000	2100	MACHINE ROOM
W3	1250	2100	000	2100	BED ROOM
W4	1250	2000	+000	2100	BED ROOM
FD1	1500	2100	± 00	2100	FIRE DOOR
FD2	1250	2100	± 00	2100	FIRE DOOR
FD3	1500	2100	± 00	2100	FIRE DOOR

LEGEND FOR PLUMBING	
①	110 OD SWR PVC SOIL & VENT PIPE
②	110 OD SWR PVC WASTE & VENT PIPE
③	90 OD SWR PVC ANTI-SYPHONAGE PIPE
④	F.W.S DOWN TAKE
⑤	D.W.S DOWN TAKE
⑥	D.W.S RISER TO O.H.T. FILLING
⑦	D.W.S RISER TO O.H.T. FILLING
⑧	110 OD UPVC RAIN WATER PIPE (FOR BALCONY)
⑨	110 OD UPVC RAIN WATER PIPE (FOR TERRACE)
FT	FLOOR TRAP
FD	FLOOR DRAIN
UT	URINAL TRAP

PLUMBING NOTE:-
* WASH BASIN TO FLOOR TRAP 50 OD UPVC WASTE PIPE
* FLOOR DRAIN TO FLOOR TRAP 63 OD UPVC WASTE PIPE
* FLOOR TRAP TO VERTICAL WASTE STACK 110 OD WASTE PIPE
* W.C TO VERTICAL SOIL STACK 110 OD SOIL PIPE

Owner:
OWNER'S NAME :
Vibrant infratech Pvt. Ltd & Others
in Collaboration with Union Buildmart Pvt. Ltd

Architect:
gpm GIAN P. MATHUR AND ASSOCIATES (P) LTD.
C-55, East Of Kailash, New Delhi-110005
T : 011-46595990 / F : 011-46595912
E : info@gpmindia.com / W : www.gpmindia.com

Project Title:
GROUP HOUSING COLONY
UNDER (MIX LAND USE) TOWN ZONE FOR
(80% GH COMPONENT & 20% COMMERCIAL COMPONENT)
ON THE AREA MEASURING 15.03125 ACRES
(LICENCE NO.-106 OF 2021, DATED 16.12.2021)
AT SECTOR -113, GURUGRAM

Status **SUBMISSION DRAWING**

Sheet Title
**RESIDENTIAL BLOCK-TOWER-5A
TERRACE, MECHANICAL VENTILATION LAYOUT**

Owner's Sign
Architect's Sign
GIAN P. MATHUR
ARCHITECT
B. Arch., M.C.A., I.T.A.
CA No. 80/5769

SCALE: 1: 100
DATE:
DWG. No.
SD/MV/M3M-113/T-5A/106

03 NO. AXIAL FLOW FAN FOR
LIFT WELL PRESS. 20000 CFM EACH
FAN LOCATED AT BELDW MACHINE ROOM


PRESS. GRILLE

TOWER-5B
TERRACE LVL


TOWER-5B
MUMTY & OH TANK LVL

TOWER-5A
TERRACE LVL LAYOUT

TOWER-5A
MUMTY & OH TANK LVL LAYOUT

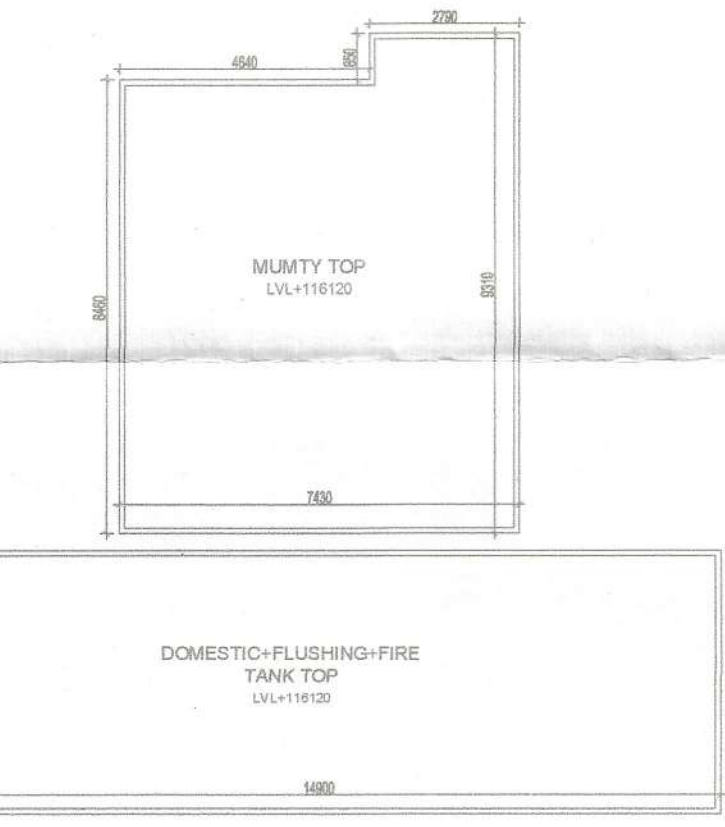

TOWER-5A
MYUMTY & OH TANK TOP PLAN

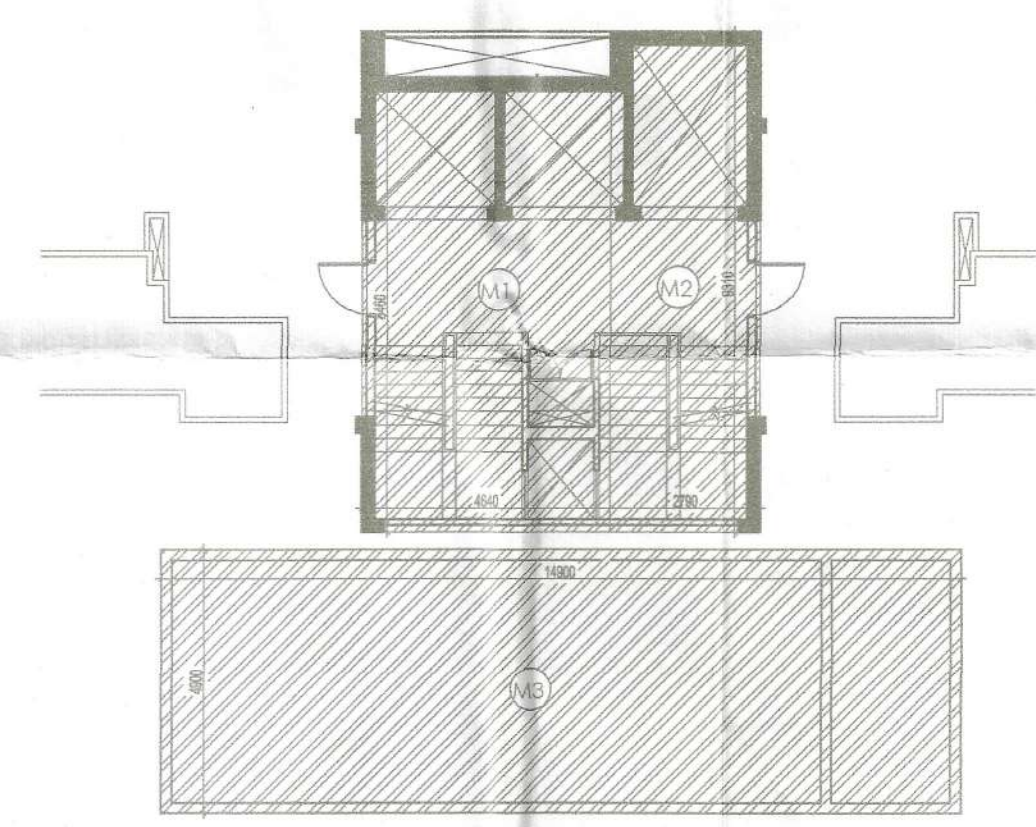

TOWER-5A
MUMTY & OH TANK AREA DIAGRAM

FAR AREA AT STILT LVL-TOWER-5A (All Distances are in Meter & Areas in Sqm)				
ADDITIONS (A)				
ITEM	NO.S	WIDTH (MTR.)	LENGTH (MTR.)	AREA(SQ. MT.) = NO. X LENGTH X WIDTH
A	1	35.570	19.425	698.717
TOTAL(A) =				698.717
DEDUCTION (B)				
				AREA(SQ. MT.)

CERTIFIED THAT THESE PLANS
ARE AS PER ORIGINAL PLANS
APPROVED BY M I TEP,
CHANDIGARH NIDEMEMO NO.
LC-4175/JECDS/2022/
27733.

DATED 21/06/2023
GIAN P. MATHUR
ARCHITECT
CA No. 80/5769

OWNER SIG.

LEGENDS:-	
	EXHAUST AIR DUCT
	FRESH AIR DUCT
	FRESH AIR GRILLE
	EXHAUST AIR GRILLE
	PRESSURIZATION DUCT
	LOUVER
	AXIAL FLOW FAN

V Consulting
Fire Consultant
(Fire Fighting, Electrical & Ventilation)
B-50, Basement
Somi Nagar, New Delhi

LEGEND:-	
	AREA FAR
	AREA NON FAR
	SERVICE SHAFT (CUTOUT)
	2 HRS. FIRE RATED FULL HEIGHT WALL