
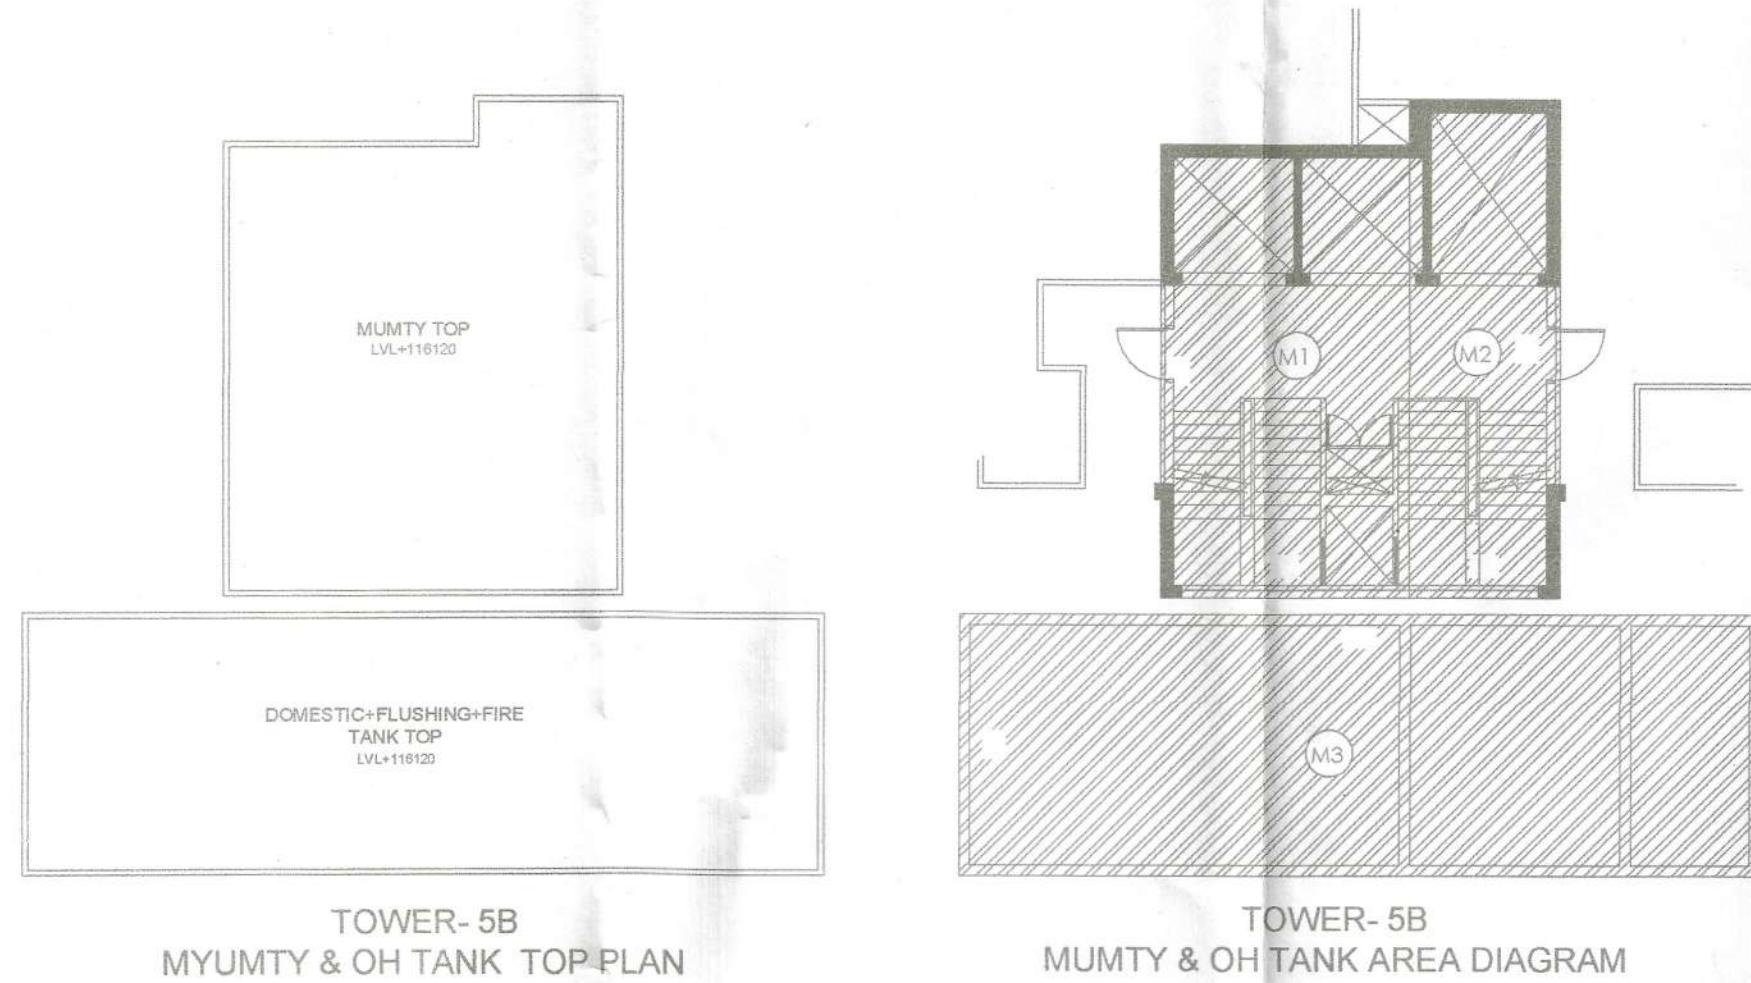


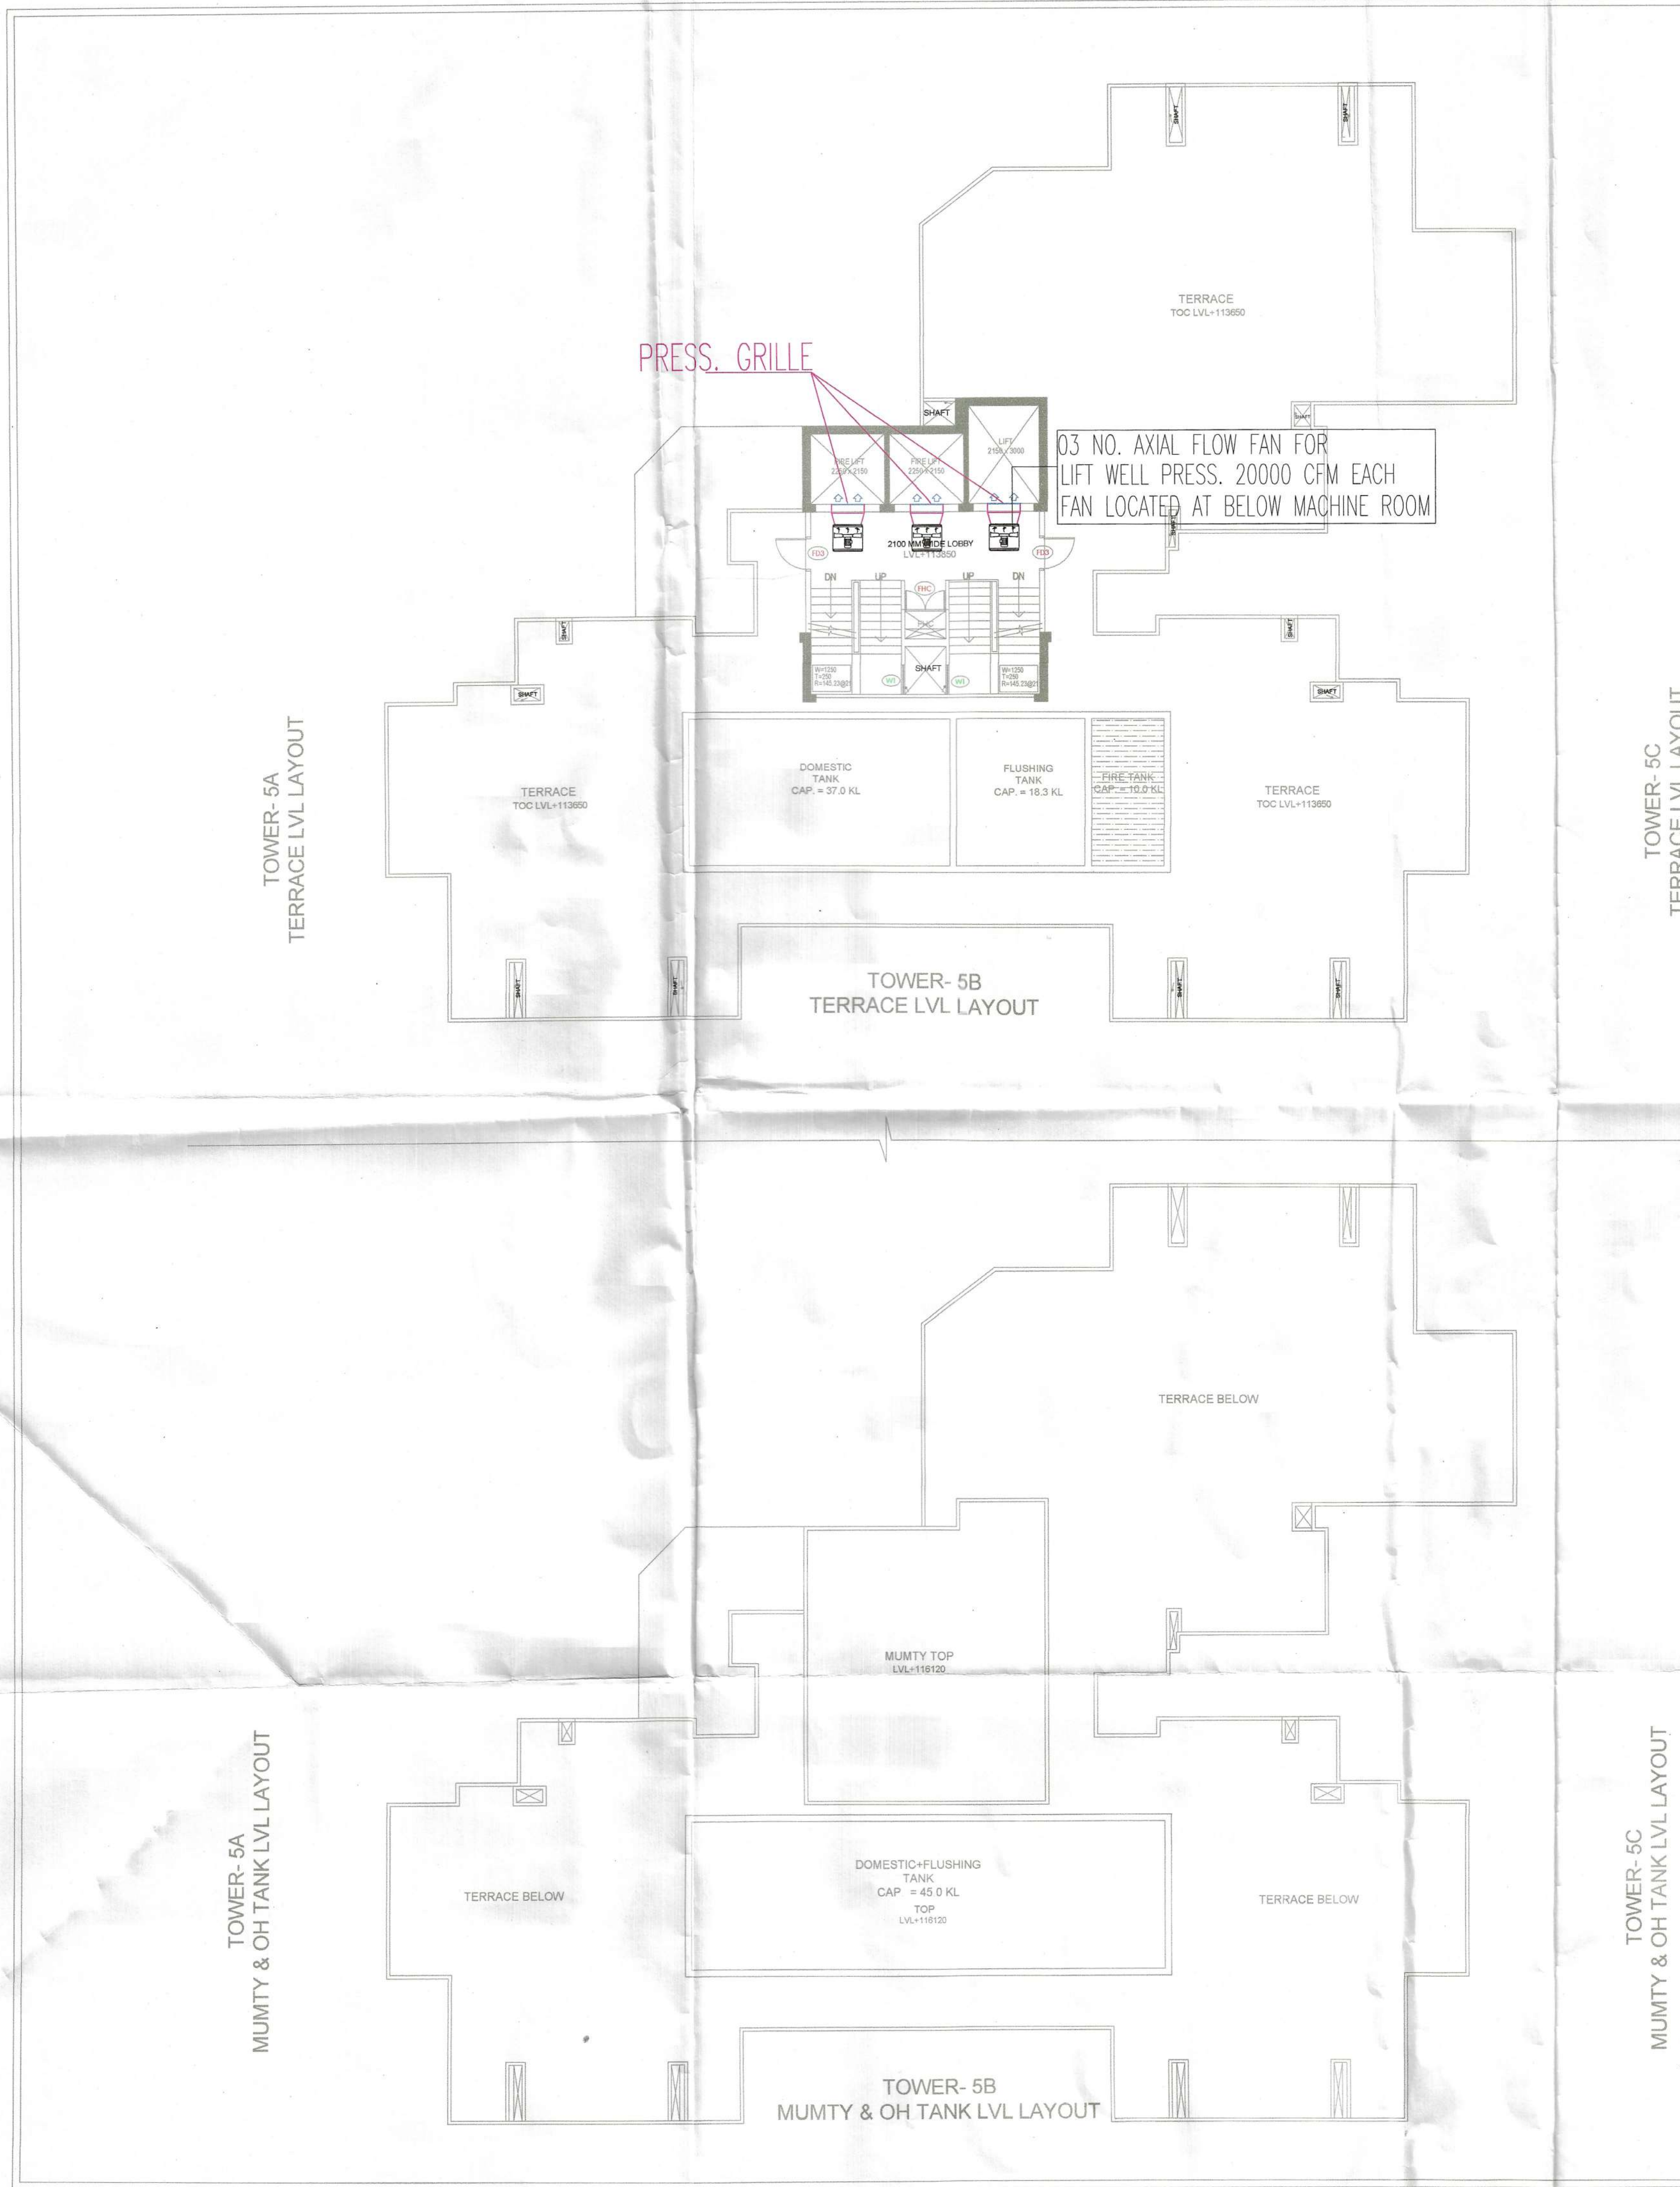


LEGENDS:-	
	EXHAUST AIR DUCT
	FRESH AIR DUCT
	FRESH AIR GRILLE
	EXHAUST AIR GRILLE
	PRESSURIZATION DUCT
	LOUVER
	AXIAL FLOW FAN

FAR AREA AT STILT LVL - TOWER - 5B (All Distances are in Meter & Areas in Sqm)				
ADDITIONS (A)				
ITEM	NO.S	WIDTH (MTR.)	LENGTH (MTR.)	AREA(SQ.MT.) = NO.X LENGTH X WIDTH
A	1	24.120	19.425	468.531
TOTAL(A) =				468.531
DEDUCTION (B)				
				AREA(SQ.MT.)

CERTIFIED THAT THESE PLANS ARE AS PER ORIGINAL PLANS APPROVED BY DG, TCP, CHANDIGARH NIDE MEMO NO. LC-4175/JEDS) 2022/27733 - DATED: 12-09-2022
OWNER SIG. ARCHITECT SIG. GIAN P. MATHUR ARCHITECT B. Arch., M.C.A. I.I.A CA No. 80/5769

V Consulting
Fire Consultant
(Fire Fighting, Electrical & Ventilation)
B-50, Basement
Soami Nagar, New Delhi

LEGEND:-	
	AREA FAR
	AREA NON FAR
	SERVICE SHAFT (CUTOUT)
	2 HRS FIRE RATED FULL HEIGHT WALL

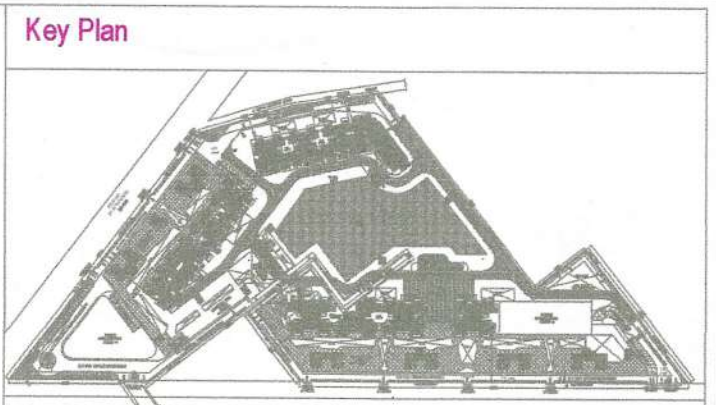

DOOR WINDOW SCHEDULE					
TYPE	WIDTH	HEIGHT	SILL LVL.	LINTEL LVL.	REMARKS
D1	1050	2400	± 00	2400	ENTRANCE (ONE HOUR FIRE RATED DOOR)
D2	800	2250	± 00	2250	BEDROOMS & MUMTY
D3	750	2250	± 00	2250	TOILETS
D4	800	2100	± 00	2100	MUMTY
D5	1250	2400	± 00	2400	STILT LOBBY ENTRANCE
SD1	2500	2400	± 00	2400	BEDROOM
SD2	2500	2400	± 00	2400	BEDROOM
SD3	2400	2400	± 00	2400	DRAWING
SD4	2250	2400	± 00	2400	BEDROOM
SD5	1800	2400	± 00	2400	BEDROOM
SD6	1400	2400	± 00	2400	BEDROOM
DW1	1800	1250	± 1050	2400	KITCHEN
DW2	1200	1250	± 00	2400	BED ROOM
DW3	1150	1250	± 1050	2400	KITCHEN
DW4	1075	1250	± 00	2400	BED ROOM
V1	600	1250	± 1050	2400	TOILETS
V2	425	1250	± 1050	2400	TOILETS
W1	1250	UP TO BOTTOM OF BEAM	± 00 FROM FIN FL LVL	-	STAIRCASE
W2	800	2100	800	2100	MACHINE ROOM
W3	1200	2100	900	2100	BED ROOM
FWC	1200	2000	± 100	2100	FWC
FD1	1500	2100	± 00	2100	FIRE DOOR
FD2	1250	2100	± 00	2100	FIRE DOOR
FD3	1050	2100	± 00	2100	FIRE DOOR

LEGEND FOR PLUMBING	
①	110 OD SWR PVC SOIL & VENT PIPE
②	110 OD SWR PVC WASTE & VENT PIPE
③	90 OD SWR PVC ANTI-SYPHONAGE PIPE
④	F.W.S DOWN TAKE
⑤	D.W.S DOWN TAKE
⑥	D.W.S RISER TO O.H.T. FILLING
⑦	D.W.S RISER TO O.H.T. FILLING
⑧	110 OD uPVC RAIN WATER PIPE (FOR BALCONY)
⑨	110 OD uPVC RAIN WATER PIPE (FOR TERRACE)
FT	FLOOR TRAP
FD	FLOOR DRAIN
UT	URINAL TRAP

PLUMBING NOTE:-
* WASH BASIN TO FLOOR TRAP 50 OD uPVC WASTE PIPE
* FLOOR DRAIN TO FLOOR TRAP 63 OD uPVC WASTE PIPE
* FLOOR TRAP TO VERTICAL WASTE STACK 110 OD WASTE PIPE
* W.C TO VERTICAL SOIL STACK 110 OD SOIL PIPE

Owner:
OWNER'S NAME :
Vibrant infratech Pvt. Ltd & Others
in Collaboration with Union Buildmart Pvt. Ltd

Architect:
GIAN P. MATHUR AND ASSOCIATES (P) LTD.
C - 55, East Of Kailash, New Delhi-110095
T : 011-46595599 / F 011-46595512
E : info@gpmindia.com/ W : www.gpmindia.com

Project Title:
GROUP HOUSING COLONY
UNDER (MIX LAND USE) TOD ZONE FOR
(80% GH COMPONENT & 14% COMMERCIAL COMPONENT)
ON THE AREA MEASURING 15.03125 ACRES
(LICENCE NO.:106 OF 2021, DATED 16.12.2021)
AT SECTOR -113, GURUGRAM

Status SUBMISSION DRAWING

Sheet Title
RESIDENTIAL BLOCK-TOWER-5B
TERRACE, MECHANICAL VENTILATION LAYOUT

Owner's Sign Architect's Sign
GIAN P. MATHUR
ARCHITECT
B. Arch., M.C.A. I.I.A
CA No. 80/5769

SCALE: 1:100
DATE: DWG. No.
SD/MM/M3M-113/T-5B/106