


Key Plan

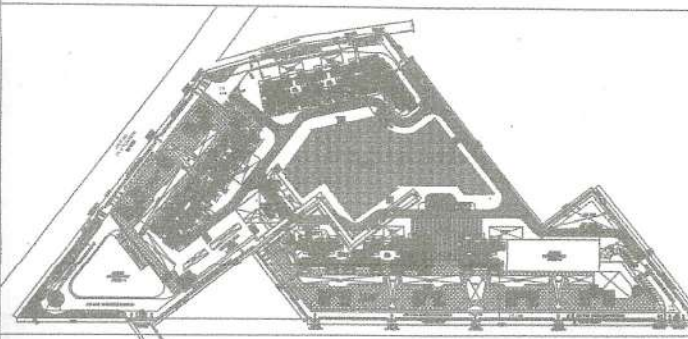

DOOR WINDOW SCHEDULE						
TYPE	WIDTH	HEIGHT	SEL. LVL.	UNTEL. LVL.	REMARKS	
D1	1050	2400	± 00	2400	ENTRANCE	
D2	900	2250	± 00	2250	ENTRANCE (ONE-HOUR FIRE RATED DOOR)	
D3	750	2250	± 00	2250	TOILETS	
D4	900	2100	± 00	2100	MUMTY	
D5	1250	2400	± 00	2400	STILT LOBBY ENTRANCE	
SD1	2400	2400	± 00	2400	BEDROOM	
SD2	2400	2400	± 00	2400	BEDROOM	
SD3	2400	2400	± 00	2400	BEDROOM	
SD4	2400	2400	± 00	2400	BEDROOM	
SD5	1800	2400	± 00	2400	BEDROOM	
SD6	1400	2400	± 00	2400	BEDROOM	
DW1	1050	1200	+1050	2400	KITCHEN	
DW2	1200	2400	± 00	2400	BED ROOM	
DW3	1150	1200	+1050	2400	KITCHEN	
DW4	1075	2400	± 00	2400	BED ROOM	
V1	600	1350	+1050	2400	TOILETS	
V2	450	1350	+1050	2400	TOILETS	
VF1	1250	UP TO BOTTOM OF RISER	-400 FROM F.W. LVL		STAIRCASE	
VF2	900	2100	900	2100	MACHINE ROOM	
VF3	1200	2100	900	2100	BED ROOM	
FD1	1200	2100	+100	2100	FIRE DOOR	
FD2	1200	2100	± 00	2100	FIRE DOOR	
FD3	1050	2100	± 00	2100	FIRE DOOR	

LEGEND FOR PLUMBING

- ① 110 OD SWR PVC SOIL & VENT PIPE
- ② 110 OD SWR PVC WASTE & VENT PIPE
- ③ 90 OD SWR PVC ANTI-SYPHONAGE PIPE
- ④ F.W.S DOWN TAKE
- ⑤ D.W.S DOWN TAKE
- ⑥ D.W.S RISER TO O.H.T. FILLING
- ⑦ D.W.S RISER TO O.H.T. FILLING
- ⑧ 110 OD uPVC RAIN WATER PIPE (FOR BALCONY)
- ⑨ 110 OD uPVC RAIN WATER PIPE (FOR TERRACE)
- FT FLOOR TRAP
- FD FLOOR DRAIN
- UT URINAL TRAP

PLUMBING NOTE:-

- * WASH BASIN TO FLOOR TRAP 50 OD uPVC WASTE PIPE
- * FLOOR DRAIN TO FLOOR TRAP 63 OD uPVC WASTE PIPE
- * FLOOR TRAP TO VERTICAL WASTE STACK 110 OD WASTE PIPE
- * W.C TO VERTICAL SOIL STACK 110 OD SOIL PIPE

Owner:

OWNER'S NAME :
Vibrant infratech Pvt. Ltd & Others
in Collaboration with Union Buildmart Pvt. Ltd

Architect:

GIAN P. MATHUR AND ASSOCIATES (P) LTD.
C-55, East Of Kailash, New Delhi-110055
T : 011-46599599 / F : 011-46599512
E : info@gpmindia.com / W : www.gpmindia.com

Project Title:

GROUP HOUSING COLONY
UNDER (MIX LAND USE) TOD ZONE FOR
(86% GH COMPONENT & 14% COMMERCIAL COMPONENT)
ON THE AREA MEASURING 15.03125 ACRES
(LICENCE NO. 106 OF 2021, DATED 16.12.2021)
AT SECTOR -113, GURUGRAM

Status SUBMISSION DRAWING

Sheet Title

RESIDENTIAL BLOCK-TOWER-5C
TERRACE, MECHANICAL VENTILATION LAYOUT

Owner's Sign

Architect's Sign

GIAN P. MATHUR
ARCHITECT
B. Arch., M. Arch., I.I.A.
CA No. 80/2769

SCALE: 1: 100

DATE:

DWG. No.

SD/MV/M3M-113/T-5C/107

LEGENDS:-

- EXHAUST AIR DUCT
- FRESH AIR DUCT
- FRESH AIR GRILLE
- EXHAUST AIR GRILLE
- PRESSURIZATION DUCT
- LOUVER
- AXIAL FLOW FAN

V Consulting CL
Fire Consultant
(Fire Fighting, Electrical & Ventilation)
B-50, Basement
Soami Nagar, New Delhi

LEGEND:-	
	AREA FAR
	AREA NON FAR
	SERVICE SHAFT (CUTOUT)
	2 HRS FIRE RATED FULL HEIGHT WALL

FAR AREA AT STILT LVL -TOWER -5C (All Distances are in Meter & Areas in Sqm)				
ADDITIONS (A)				
ITEM	NO.S	WIDTH (MTR.)	LENGTH (MTR.)	AREA(SQ.MT.) = NO.X LENGTH X WIDTH
A	1	24.120	19.925	480.591
TOTAL(A) =				480.591
DEDUCTION (B)				
				AREA(SQ.MT.)

CERTIFIED THAT THESE PLANS
ARE AS PER ORIGINAL PLANS
APPROVED BY DG, TCD, CHANDIGARH
NIDE MEMO NO. LC-4175 / JCDP
2022 / 27783.

DATE: 08.08.2022
GIAN P. MATHUR
ARCHITECT
B. Arch., M. Arch., I.I.A.
CA No. 80/2769

OWNER SIG.

ARCHITECT SIG.

TERRACE
03 NO. AXIAL FLOW FAN FOR
LIFT WELL PRESS. 20000 CFM EACH
FAN LOCATED AT BELOW MACHINE ROOM

PRESS. GRILLE

TOWER-5B
TERRACE LVL LAYOUT

TOWER-5B
MUMTY & OH TANK

TOWER-5C
TERRACE LVL LAYOUT

TOWER-5C
MUMTY & OH TANK LVL LAYOUT

TOWER-5C
MUMTY & OH TANK TOP PLAN

TOWER-5C
MUMTY & OH TANK AREA DIAGRAM