


Key Plan

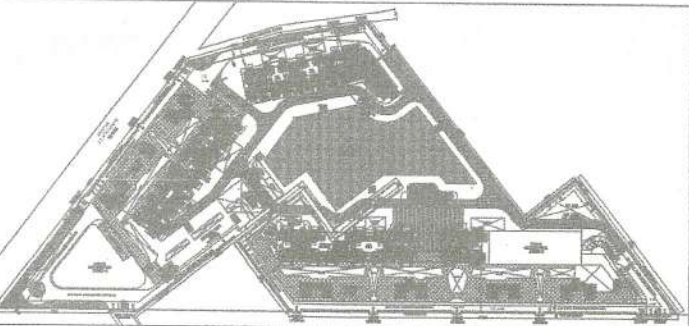

DOOR WINDOW SCHEDULE					
TYPE	WIDTH	HEIGHT	ILL. LVL.	LINTEL LVL.	REMARKS
D1	1050	2400	+00	2400	ENTRANCE (ONE HOUR FIRE RATED DOOR)
D2	900	2250	+00	2250	BEDROOMS & MUMTY
D3	750	2250	+00	2250	TOILETS
D4	900	2100	+00	2100	MUMTY
D5	1250	2400	+00	2400	STILT LOBBY ENTRANCE
D201	2800	2400	+00	2400	BEDROOM
D202	2800	2400	+00	2400	BEDROOM
D203	2400	2400	+00	2400	BEDROOM
D204	2200	2400	+00	2400	BEDROOM
D205	1800	2400	+00	2400	BEDROOM
D206	1400	2400	+00	2400	BEDROOM
DW1	1800	1350	+1050	2400	KITCHEN
DW2	1200	2400	+00	2400	BED ROOM
DW3	1150	1350	+1050	2400	KITCHEN
DW4	1075	2400	+00	2400	BED ROOM
V1	900	1350	+1050	2400	TOILETS
V2	425	1350	+1050	2400	TOILETS
WH	1250	UP TO BOTTOM OF BEAM	+000 FROM FIN FL. LVL.	-	STAIRCASE
WT	900	2100	000	2100	MACHINE ROOM
FWC	1250	2000	+100	2100	FWC
FD1	1500	2100	+00	2100	FIRE DOOR
FD2	1250	2100	+00	2100	FIRE DOOR
FD3	1050	2100	+00	2100	FIRE DOOR

LEGEND FOR PLUMBING

- 110 OD SWR PVC SOIL & VENT PIPE
- 110 OD SWR PVC WASTE & VENT PIPE
- 90 OD SWR PVC ANTI-SYPHONAGE PIPE
- F.W.S. DOWN TAKE
- D.W.S. DOWN TAKE
- D.W.S. RISER TO O.H.T. FILLING
- D.W.S. RISER TO O.H.T. FILLING
- 110 OD uPVC RAIN WATER PIPE (FOR BALCONY)
- 110 OD uPVC RAIN WATER PIPE (FOR TERRACE)
- FT FLOOR TRAP
- FD FLOOR DRAIN
- UT URINAL TRAP

PLUMBING NOTE:-
* WASH BASIN TO FLOOR TRAP 50 OD uPVC WASTE PIPE
* FLOOR DRAIN TO FLOOR TRAP 63 OD uPVC WASTE PIPE
* FLOOR TRAP TO VERTICAL WASTE STACK 110 OD WASTE PIPE
* W.C TO VERTICAL SOIL STACK 110 OD SOIL PIPE

Owner:

OWNER,S NAME :
Vibrant infratech Pvt. Ltd & Others
in Collaboration with Union Buildmart Pvt. Ltd

Architect:

GIAN P. MATHUR AND ASSOCIATES (P) LTD.
C-55, East Of Kailash, New Delhi-110065
T : 011-46590599 / F 011-46590512
E : info@gpmindia.com / W : www.gpmindia.com

Project Title:

GROUP HOUSING COLONY
UNDER (MIX LAND USE) TOD ZONE FOR
(85% GH COMPONENT & 15% COMMERCIAL COMPONENT)
ON THE AREA MEASURING 15.03125 ACRES
(LICENCE NO.:106 OF 2021, DATED 16.12.2021)
AT SECTOR -113, GURUGRAM

Status SUBMISSION DRAWING

Sheet Title

RESIDENTIAL BLOCK-TOWER-6A
TERRACE, MECHANICAL VENTILATION LAYOUT

Owner's Sign

Architect's Sign

GIAN P. MATHUR
ARCHITECT
B. Arch., M.C.A. I.I.A.
CA No. 805169

SCALE: 1:100


DATE:

DWG. No.


SD/MV/M3M-113/T-6A/107

PRESS. GRILLE


03 NO. AXIAL FLOW FAN FOR
LIFT WELL PRESS. 20000 CFM EACH
FAN LOCATED AT BELOW MACHINE ROOM

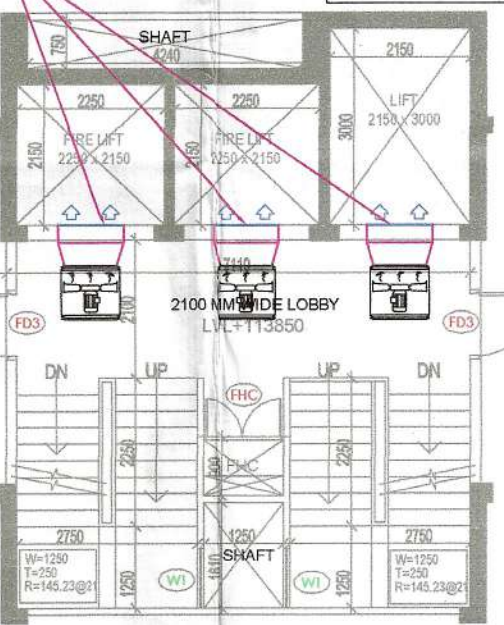

TOWER-6A
TERRACE LVL LAYOUT

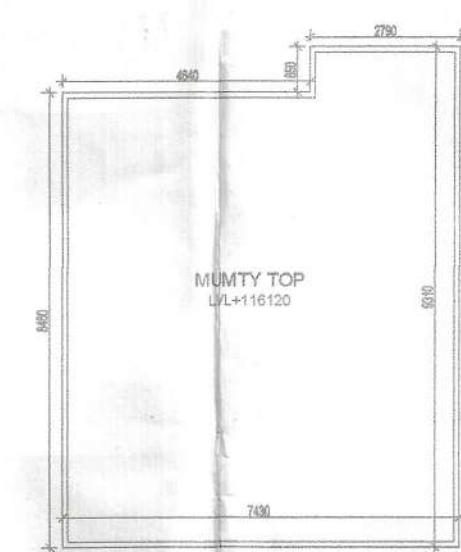

TOWER-6A
MYUMTY & OH TANK TOP PLAN

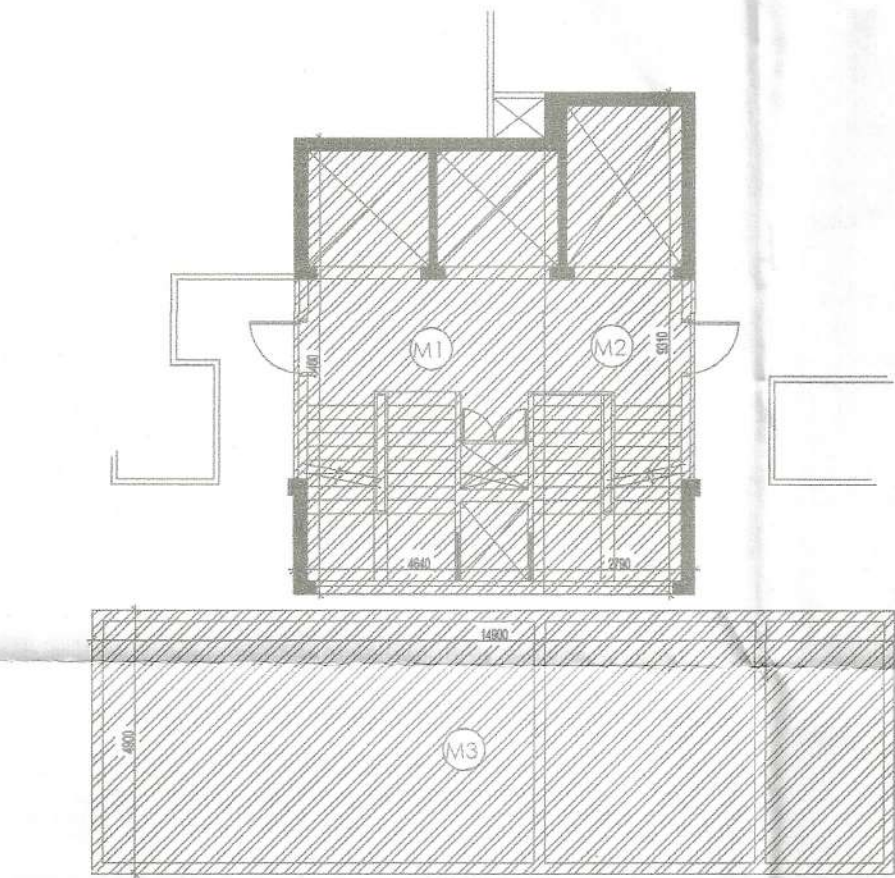

TOWER-6A
MUMTY & OH TANK AREA DIAGRAM

TOWER-6A
MUMTY & OH TANK LVL LAYOUT

FAR AREA AT STILT LVL -TOWER-6A (All Distances are in Meter & Areas in Sqm)				
ADDITIONS (A)				
ITEM	NO.S	WIDTH (MTR.)	LENGTH (MTR.)	AREA(SQ.MT.) = NO.X LENGTH X WIDTH
A	1	24.120	19.925	480.591
TOTAL(A) =				480.591
DEDUCTION (B)				
				AREA(SQ.MT.)

CERTIFIED THAT THESE PLANS ARE
AS PER ORIGINAL PLANS.
APPROVED BY DQ, TCD, CHANDIMARH
VIDE MEMO NO. LC-4175/JECDS/
2022/27733.

DATED: 12-09-2022
GIAN P. MATHUR
ARCHITECT
B. Arch., M.C.A. I.I.A.
CA No. 805169
OWNER SIG. ARCHITECT SIG.

LEGENDS:-	
	EXHAUST AIR DUCT
	FRESH AIR DUCT
	FRESH AIR GRILLE
	EXHAUST AIR GRILLE
	PRESSURIZATION DUCT
	LOUVER
	AXIAL FLOW FAN

V Consulting
Fire Consultant
(Fire Fighting, Electrical & Ventilation)
B-50, Basement
Sohni Nagar, New Delhi

LEEND:-	
	AREA FAR
	AREA NON FAR
	SERVICE SHAFT (CUTOUT)
	2 HRS FIRE RATED FULL HEIGHT WALL