

[illegible]

LEGEND	
-----	SET-BACK LINE
=====	SITE BOUNDARY
=====	BUILDING LINE
=====	BASEMENT LINE

PLUMBING LEGEND:	
1	1 1/2" OD SOIL & VENT PIPE
2	1 1/2" OD WASTE & VENT PIPE
2A	1 1/2" OD HUR. WASTE & VENT PIPE
2B	1 1/2" OD WASTE PIPE F&B
3	75 OD VENT PIPE
4	COLD WATER SUPPLY PIPE (DWS)
5	1 1/2" COLD WATER SUPPLY PIPE (DWS)
6	COLD WATER SUPPLY FOR RITAL
7	DOMESTIC WATER TANK RISER
8	FLUSHING WATER TANK RISER
9	200 OD RAIN WATER PIPE
10	SOFT WATER INLET
11	1 1/2" OD RAIN WATER PIPE
12	75 OD RAIN WATER PIPE

[illegible]

HYVAC CONSULTANT:-
DEW POINT CONSULTANTS
PVT. LTD.
TA-8 & TA-10, Crown Plaza, Mathura Road,
Sector-15A, Faridabad 121 032; TELE/FAX - (0129)

STRUCTURE CONSULTANT:
PRISTINE IDEAS
40/221, LGF, CR PARK, NEW DELHI - 110019
P : 01149053477, info@pristineideas.org

ORIENTATION :  1 OF 1

OWNER'S SIGNATURE:  For Minal Buildcon Pvt. Ltd.

Manmeet S. Batra
Architect CA-0013535






CLIENT :
M/s MARTIAL BUILDCON PVT. LTD.
ADDRESS :

APPROVAL OF REVISED BUILDING PLANS OF
COMMERCIAL COLONY AREA MEASURING 11.1375
ACRES (LICENCE NO. 89 OF 2010 DATED 28/10/2010;
LICENCE NO. 100 OF 2010 DATED 26/11/2010;
LICENCE NO. 101 OF 2010 DATED 26/11/2010;

PROJECT CONSULTANTS:
DESIGN PLUS ASSOCIATE SERVICES
PRIVATE LIMITED
E-145 OKHLA INDUSTRIAL ESTATE,

DRAWN :	RO-HLLA	CHECKED :	NA
JOB NO :	DPA	DRAWING NO :	A-SD-08-114

16TH,17TH & 18TH FLOOR PL

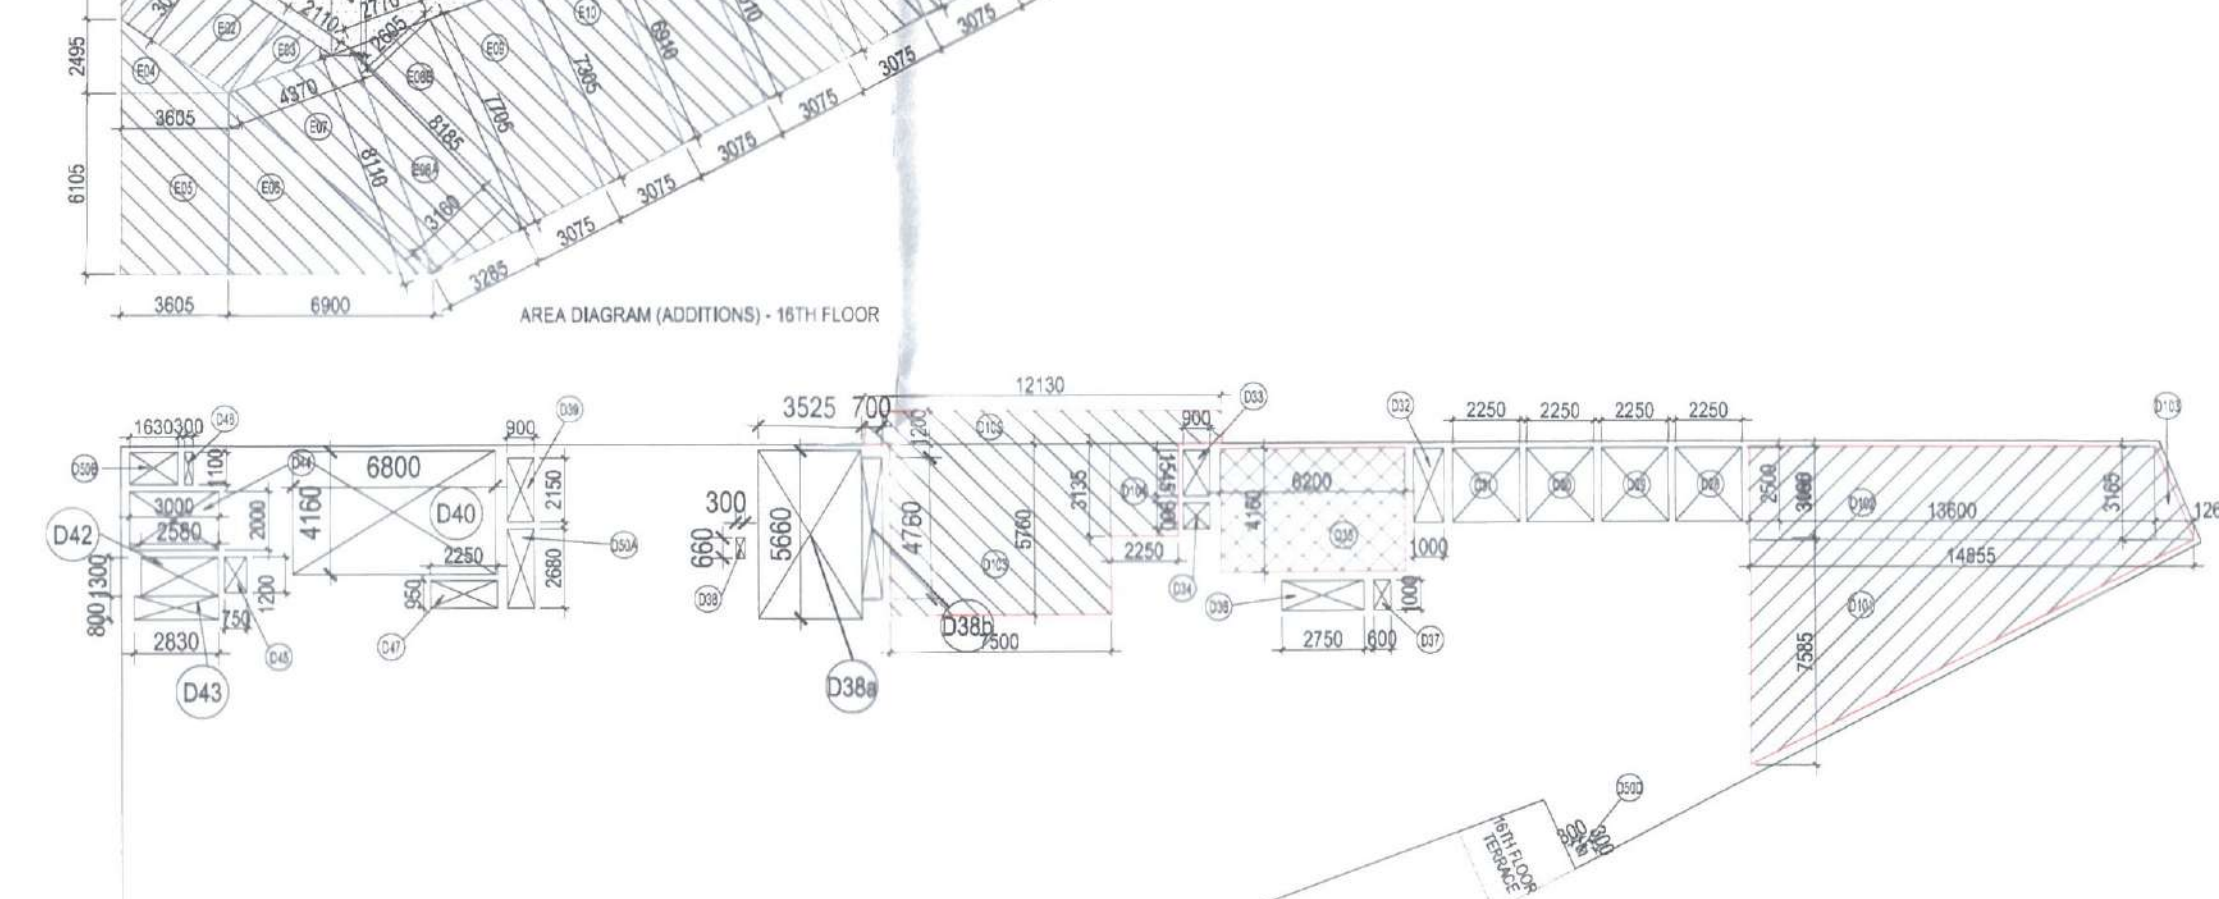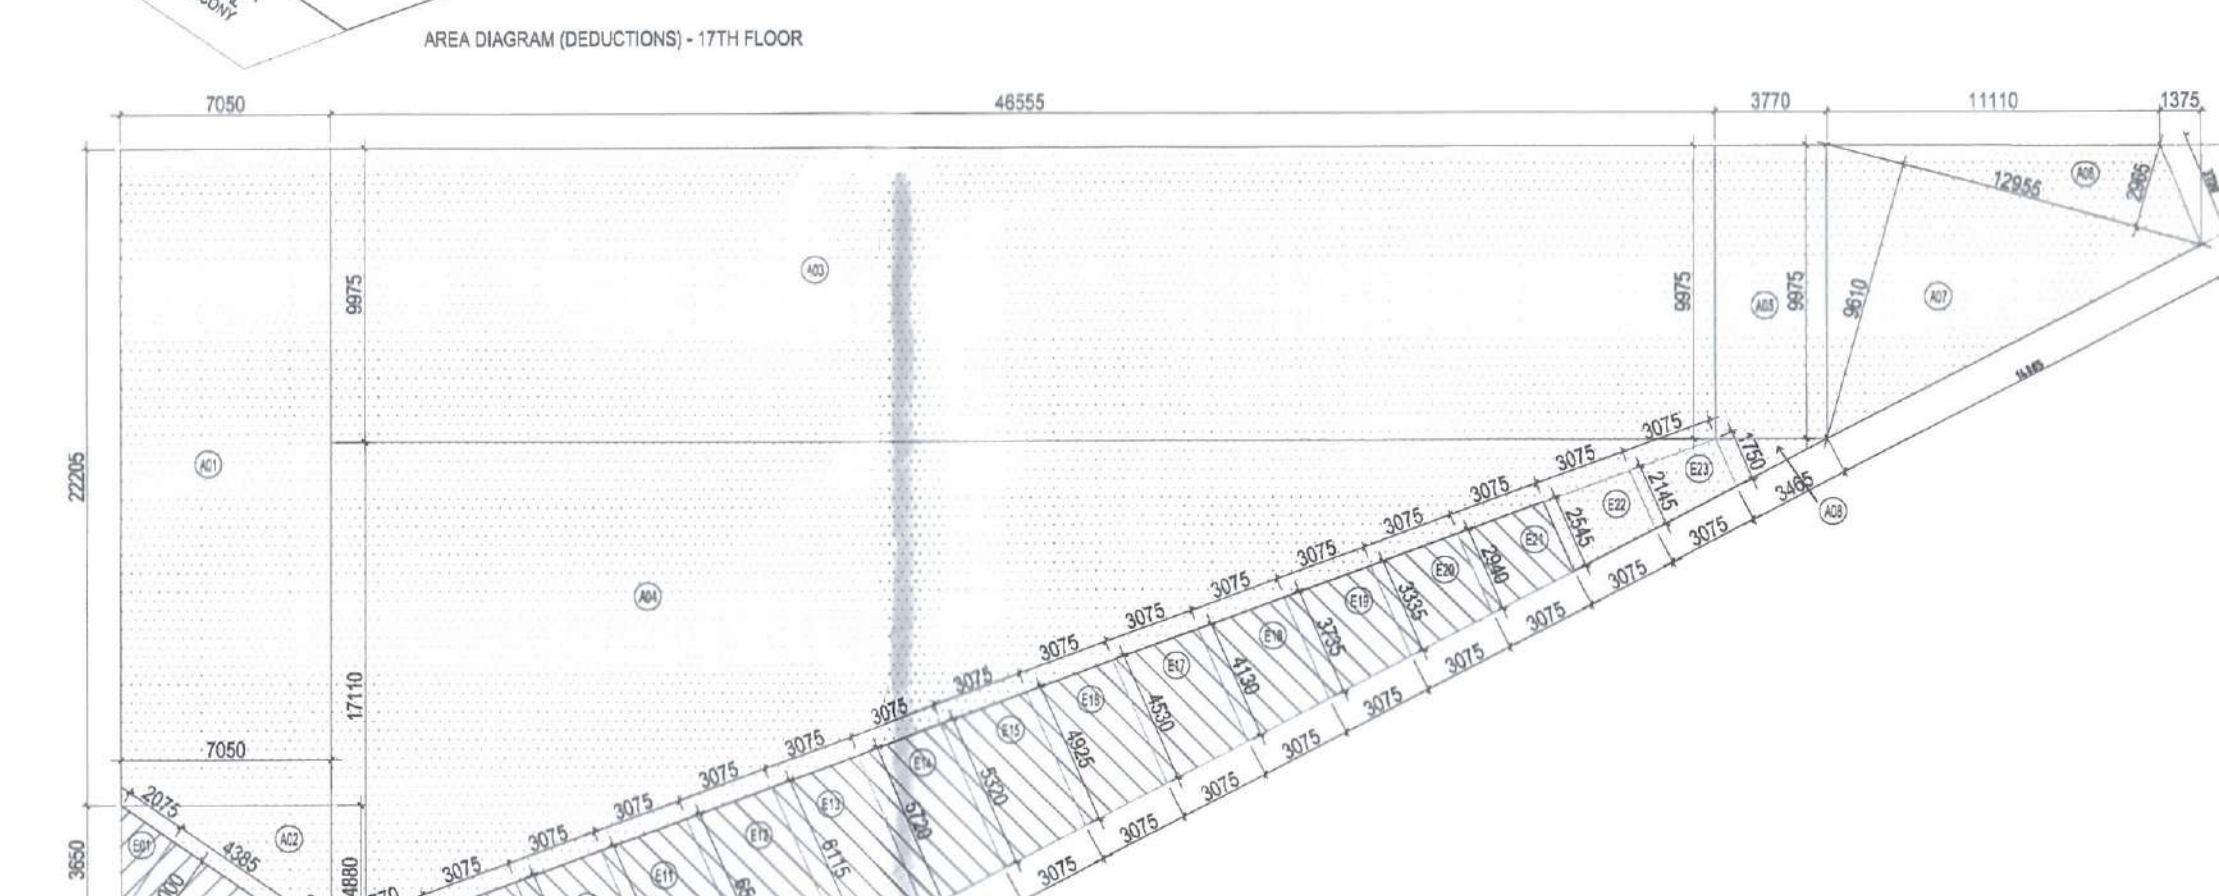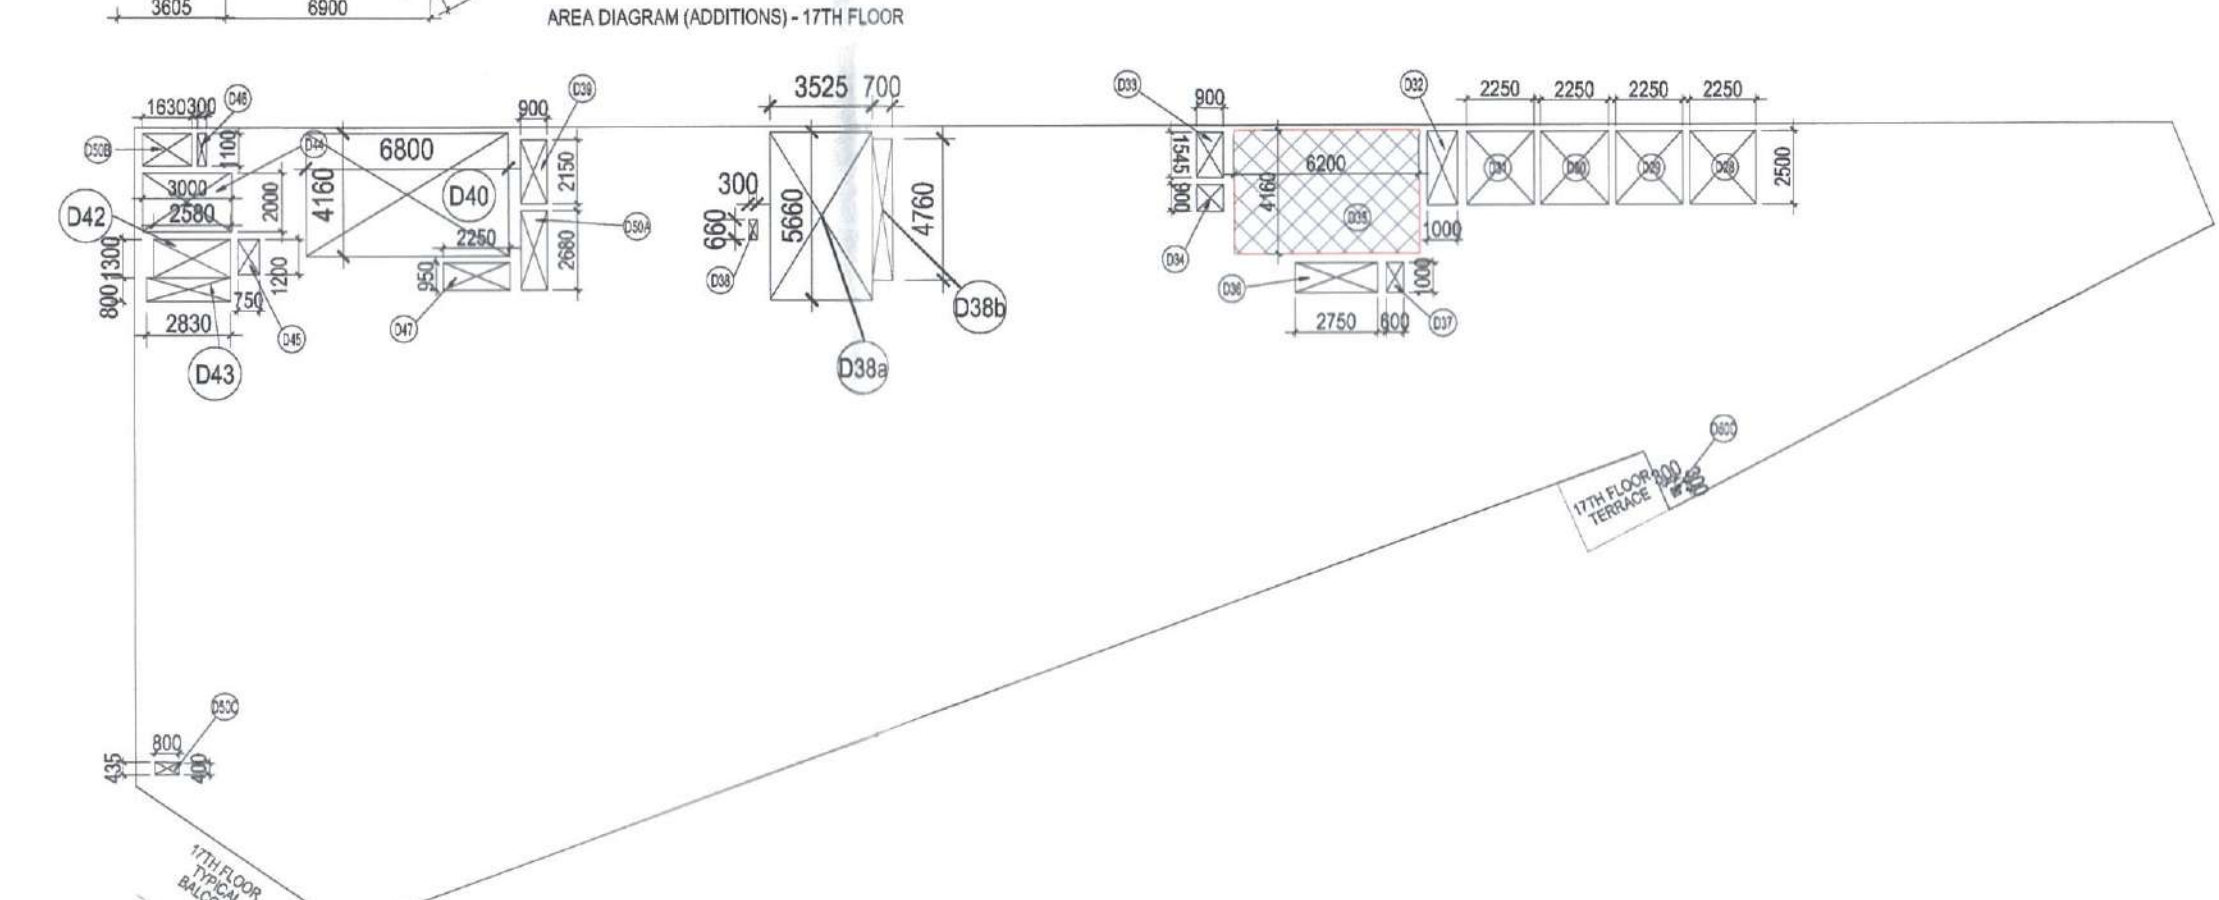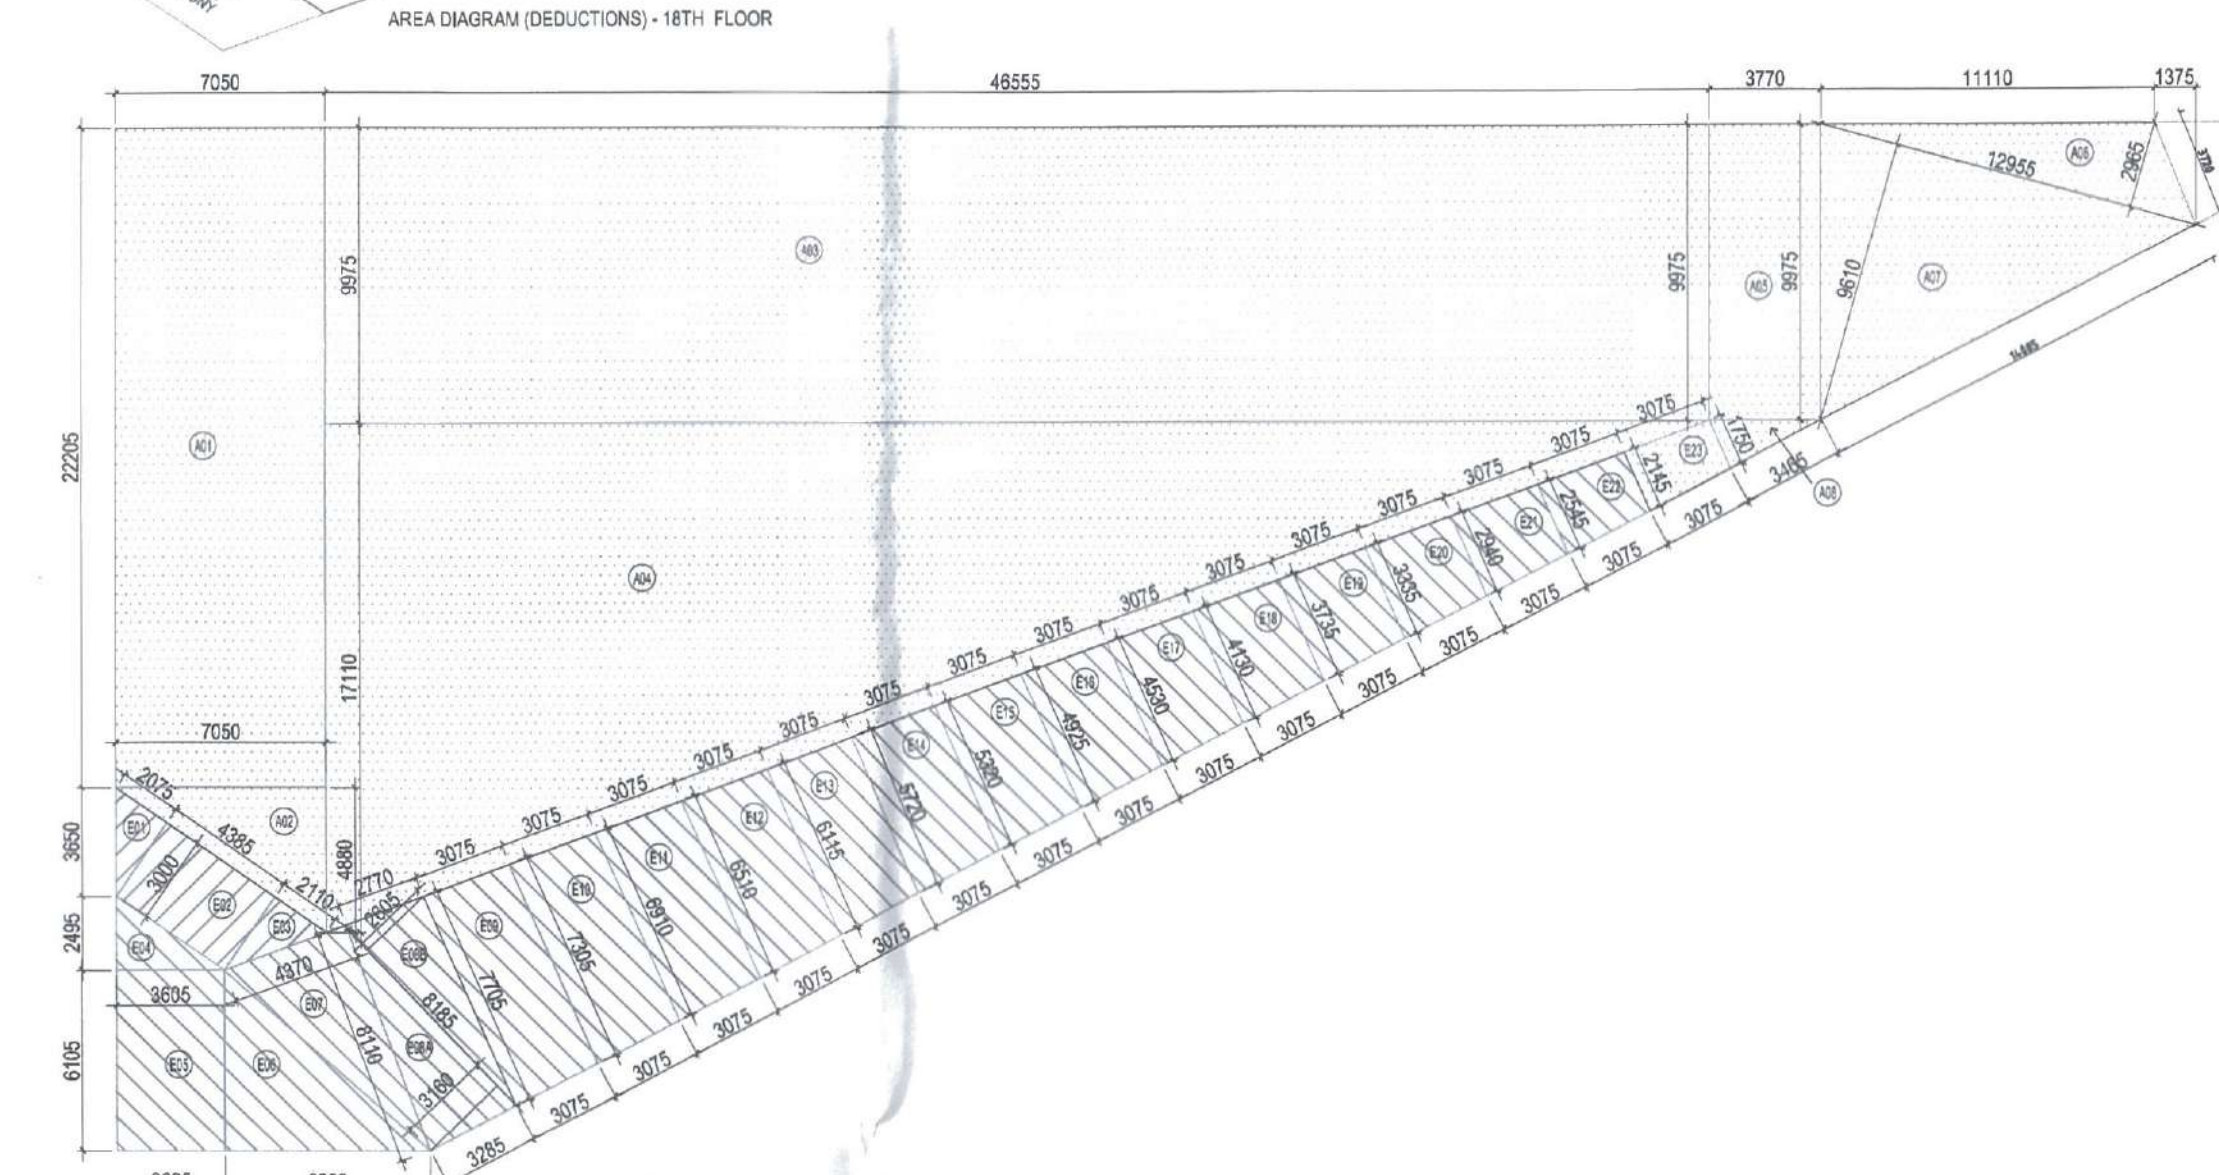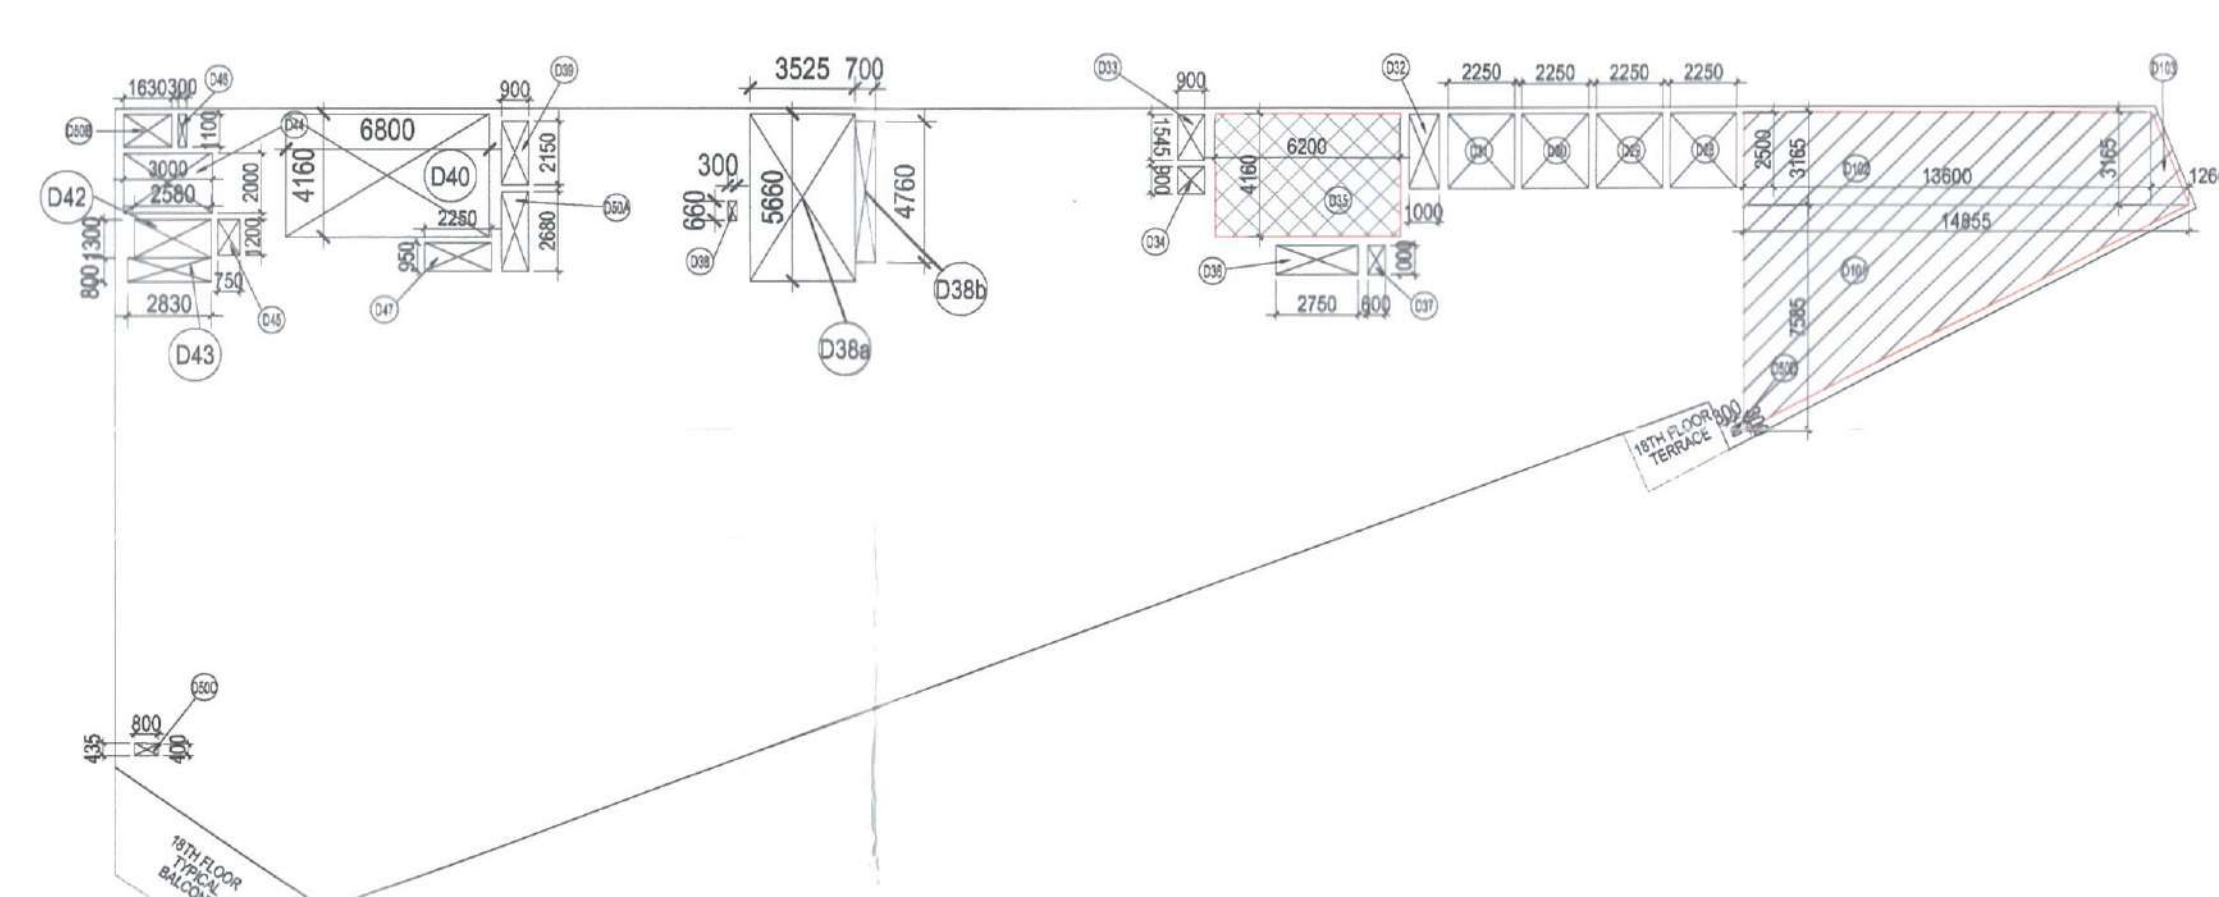

OFFICE FLOOR						
S.NO.	FORMULA	FLOOR FACTOR		WORTH-1 / FLOOR-2	HEIGHT	AREA OF FLOOR
		CLIMATE / GLASS	WORTH-2 / FLOOR-1			
D01	TRIANGLE	1.00	1.00	1.00	1.00	46.38
D02	RECTANGLE	1.00	1.00	1.00	1.00	41.94
D03	RECTANGLE	1.00	1.00	1.00	1.00	41.94
D04	RECTANGLE	1.00	1.00	1.00	1.00	41.94
D54	RECTANGLE	1.00	1.00	1.00	1.00	41.94
OFFICE FLOOR						
OFFICE FLOOR				F - FLOOR - OFFICE FLOOR		

OFFICE FLOOR / TERRACE		927.467				
OFFICE FLOOR BALCONY / TERRACE						
S.N.O.	FORMULA	FACTOR & QUANTITY	WIDTH - 1 / BASE - 1	WIDTH - 2 / BASE - 2	HIGHT	AREA
E01	TRIANGLE	0.500	2.025	0.000	3.000	3.115
E02	RECTANGLE	1.000	4.385	0.000	3.000	13.155
E03	TRIANGLE	0.500	2.110	0.000	3.000	3.165
E23	TRIANGLE	0.500	2.145	1.750	3.075	5.980
OFFICE FLOOR BALCONY / TERRACE		25.42				
OFFICE FLOOR BALCONY / TERRACE			OFFICE FLOOR BALCONY / TERRACE			

25.21

17th floor						
OFFICE WORK AREA						
OFFICE FLOOR ADDITION						
S.NO.	FORMULA	FACTOR & QUANTITY	WIDTH / BASE - 1	WIDTH - 2 / BASE - 2	HEIGHT	AREA
A/21	RECTANGLE	1.000	7.050	0.000	22.250	156.54
A/22	TRIANGLE	0.500	7.050	0.000	4.880	17.20
A/23	RECTANGLE	1.000	46.550	0.000	8.970	464.38
A/24	TRIANGLE	0.500	46.550	0.000	17.10	398.73
A/25	TRIANGLE	0.500	3.770	0.000	8.970	17.00
A/26	TRIANGLE	0.500	12.950	0.000	2.960	19.20
A/27	TRIANGLE	0.500	12.950	0.000	9.610	62.34
A/28	TRIANGLE	0.500	1.750	0.000	3.460	3.05
A/29	TRAP-2-LIM	2.500	2.145	7.750	3.375	1148.40
OFFICE FLOOR ADDITION						1148.40

S.NO.	FORMULA	OFFICE FLOOR			
		WALL IN QUANT	DOOR W/ BASE	WINDOW IN QUANT	HEIGHT AREA
D01	RECTANGLE	1.000	2.000	3.000	2.500
D02	RECTANGLE	1.000	2.000	3.000	2.500
D03	RECTANGLE	1.000	2.000	3.000	2.500
D210	RECTANGLE	1.000	2.000	3.000	2.500
D211					


OFFICE FLOOR / FAR		+ FAR (ADDITION) - FAR REDUCTION				
		10M.E31				
OFFICE FLOOR BALCONY / TERRACE						
S.NO.	FORMULA	FACTOR + QUANTI TY	WIDTH - 1 / BASE - 1	WIDTH - 2 / BASE - 2	HEIGHT	AREA
E01	TRIANGLE	0.500	2.075	0.000	3.000	3.113
E02	RECTANGLE	1.000	4.345	0.000	3.000	13.355
E03	TRIANGLE	0.500	2.110	0.000	3.000	3.145
E22	TRIANGLE	0.500	2.545	2.145	3.075	7.211
OFFICE FLOOR BALCONY / TERRACE						26.64
OFFICE FLOOR BALCONY / TERRACE						

OFFICE FLOOR BALCONY / TERRACE			24.643			
14th floor						
OFFICE FLOOR AREA						
S.NO.	FORMULA	FACTOR & COEFF. TYP.	WIDTH -1 / BASE -1	WIDTH -2 / BASE -2	HEIGHT	AREA
A01	RECTANGLE	1.000	7.050	0.000	22.205	156.55
A02	TRIANGLE	0.500	7.050	0.000	48.800	17.28
A03	RECTANGLE	1.000	48.555	0.000	9.975	484.39
A04	TRIANGLE	0.500	48.555	0.000	17.180	41.00
A05	RECTANGLE	1.000	3.720	0.000	9.975	37.19
A06	TRIANGLE	0.500	12.950	0.000	9.965	18.06
A07	TRIANGLE	0.500	12.950	0.000	9.910	62.24
A08	TRIANGLE	0.500	1.750	0.000	3.645	3.10
T02	TRIANGLE	0.500	2.540	2.165	3.075	7.24
T03	TRIANGLE	0.500	1.415	1.750	3.075	5.98


OFFICE FLOOR ADDITION						1317
FLOOR		OFFICE FLOOR REDUCTION				
S.NO.	FORMULA	WORTH-1 TH	WORTH-2 TH	WORTH-3 TH	WORTH-4 TH	AREA
D01	RECTANGLE	1.00	1.00	1.00	1.00	4.83
D02	RECTANGLE	1.00	1.00	1.00	1.00	3.15
D03	RECTANGLE	1.00	1.00	1.00	1.00	1.84
D04	RECTANGLE	1.00	1.00	1.00	1.00	1.84
D05	RECTANGLE	1.00	1.00	1.00	1.00	1.84
D06	RECTANGLE	1.00	1.00	1.00	1.00	1.84
D07	RECTANGLE	1.00	1.00	1.00	1.00	1.84
D08	RECTANGLE	1.00	1.00	1.00	1.00	1.84
D09	RECTANGLE	1.00	1.00	1.00	1.00	1.84
D10	RECTANGLE	1.00	1.00	1.00	1.00	1.84
D11	RECTANGLE	1.00	1.00	1.00	1.00	1.84
D12	RECTANGLE	1.00	1.00	1.00	1.00	1.84
D13	RECTANGLE	1.00	1.00	1.00	1.00	1.84
D14	RECTANGLE	1.00	1.00	1.00	1.00	1.84
D15	RECTANGLE	1.00	1.00	1.00	1.00	1.84
D16	RECTANGLE	1.00	1.00	1.00	1.00	1.84
D17	RECTANGLE	1.00	1.00	1.00	1.00	1.84
D18	RECTANGLE	1.00	1.00	1.00	1.00	1.84
D19	RECTANGLE	1.00	1.00	1.00	1.00	1.84
D20	RECTANGLE	1.00	1.00	1.00	1.00	1.84
D21	RECTANGLE	1.00	1.00	1.00	1.00	1.84
D22	RECTANGLE	1.00	1.00	1.00	1.00	1.84
D23	RECTANGLE	1.00	1.00	1.00	1.00	1.84
D24	RECTANGLE	1.00	1.00	1.00	1.00	1.84
D25	RECTANGLE	1.00	1.00	1.00	1.00	1.84
D26	RECTANGLE	1.00	1.00	1.00	1.00	1.84
D27	RECTANGLE	1.00	1.00	1.00	1.00	1.84
D28	RECTANGLE	1.00	1.00	1.00	1.00	1.84
D29	RECTANGLE	1.00	1.00	1.00	1.00	1.84
D30	RECTANGLE	1.00	1.00	1.00	1.00	1.84
D31	RECTANGLE	1.00	1.00	1.00	1.00	1.84
D32	RECTANGLE	1.00	1.00	1.00	1.00	1.84
D33	RECTANGLE	1.00	1.00	1.00	1.00	1.84
D34	RECTANGLE	1.00	1.00	1.00	1.00	1.84
D35	RECTANGLE	1.00	1.00	1.00	1.00	1.84
D36	RECTANGLE	1.00	1.00	1.00	1.00	1.84
D37	RECTANGLE	1.00	1.00	1.00	1.00	1.84
D38	RECTANGLE	1.00	1.00	1.00	1.00	1.84
D39	RECTANGLE	1.00	1.00	1.00	1.00	1.84
D40	RECTANGLE	1.00	1.00	1.00	1.00	1.84
D41	RECTANGLE	1.00	1.00	1.00	1.00	1.84
D42	RECTANGLE	1.00	1.00	1.00	1.00	1.84
D43	RECTANGLE	1.00	1.00	1.00	1.00	1.84
D44	RECTANGLE	1.00	1.00	1.00	1.00	1.84
D45	RECTANGLE	1.00	1.00	1.00	1.00	1.84
D46	RECTANGLE	1.00	1.00	1.00	1.00	1.84
D47	RECTANGLE	1.00	1.00	1.00	1.00	1.84
D48	RECTANGLE	1.00	1.00	1.00	1.00	1.84
D49	RECTANGLE	1.00	1.00	1.00	1.00	1.84
D50	RECTANGLE	1.00	1.00	1.00	1.00	1.84

OFFICE FLOOR BALCONY / TERRACE		= FAR ADDITION - FAR DEDUCTION	
		BR0.412	
OFFICE FLOOR BALCONY / TERRACE			
S.NO.	FORMULA	FACTOR & QUANTITY	WIDTH-1 / BASE-1 WIDTH-2 / BASE-2 HEIGHT AREA
E01	TRIANGLE	0.500	2.075 0.000 3.000 3.113
E02	RECTANGLE	1.000	4.385 0.000 3.000 13.155
E03	TRIANGLE	0.500	2.110 0.000 3.000 3.165
E21	TRIANGLE	0.500	2.940 2.545 1.075 8.165
OFFICE FLOOR BALCONY / TERRACE			
OFFICE FLOOR BALCONY / TERRACE		OFFICE FLOOR BALCONY / TERRACE	
		27.865	


OFFICE FLOOR REFUGE TERRACE						
S.NO.	FORMULA	FACTOR & QUANTITY	WIDTH - 1 / BASE - 1	WIDTH - 2 / BASE - 2	HEIGHT	AREA
0323	RECTANGLE	1.000	7.500	0.000	5.760	43.200
0324	RECTANGLE	1.000	2.250	0.000	3.135	7.058
0325	RECTANGLE	1.000	12.130	0.000	1.200	14.555
OFFICE FLOOR REFUGE TERRACE						
OFFICE FLOOR REFUGE TERRACE			OFFICE FLOOR REFUGE TERRACE			
			64.813			

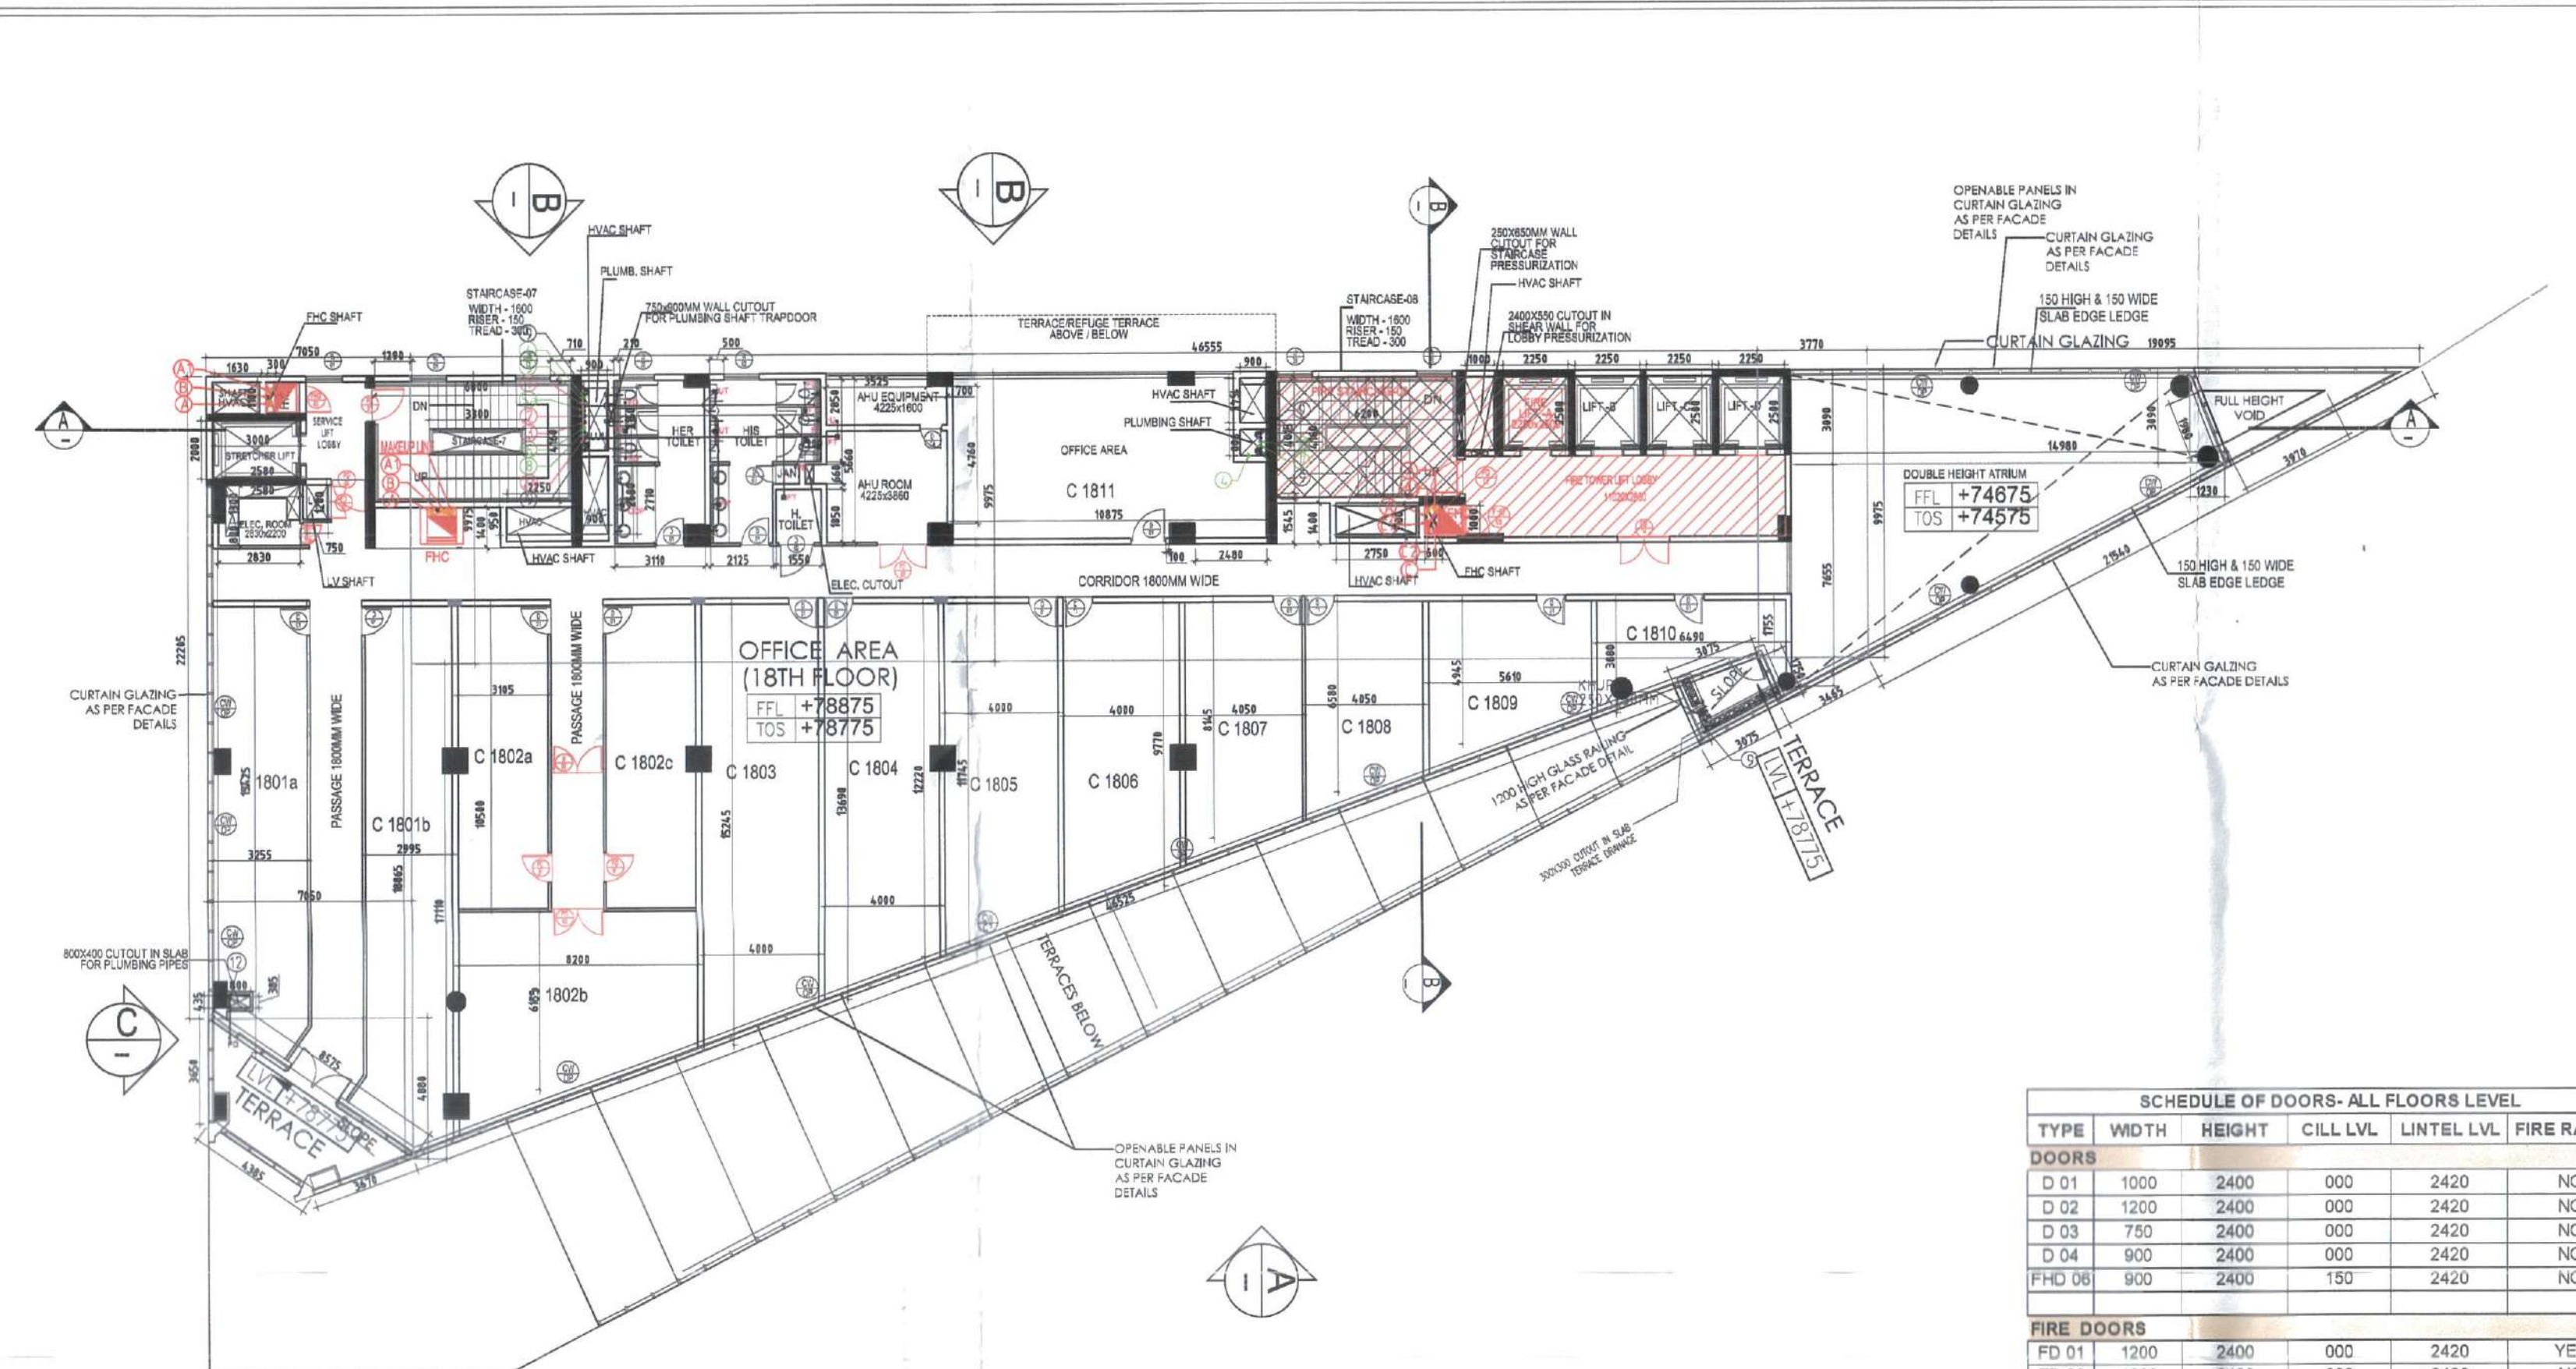

EIGHTEENTH FLOOR PLAN (LVL+78875MM)
SCALE 1 : 125

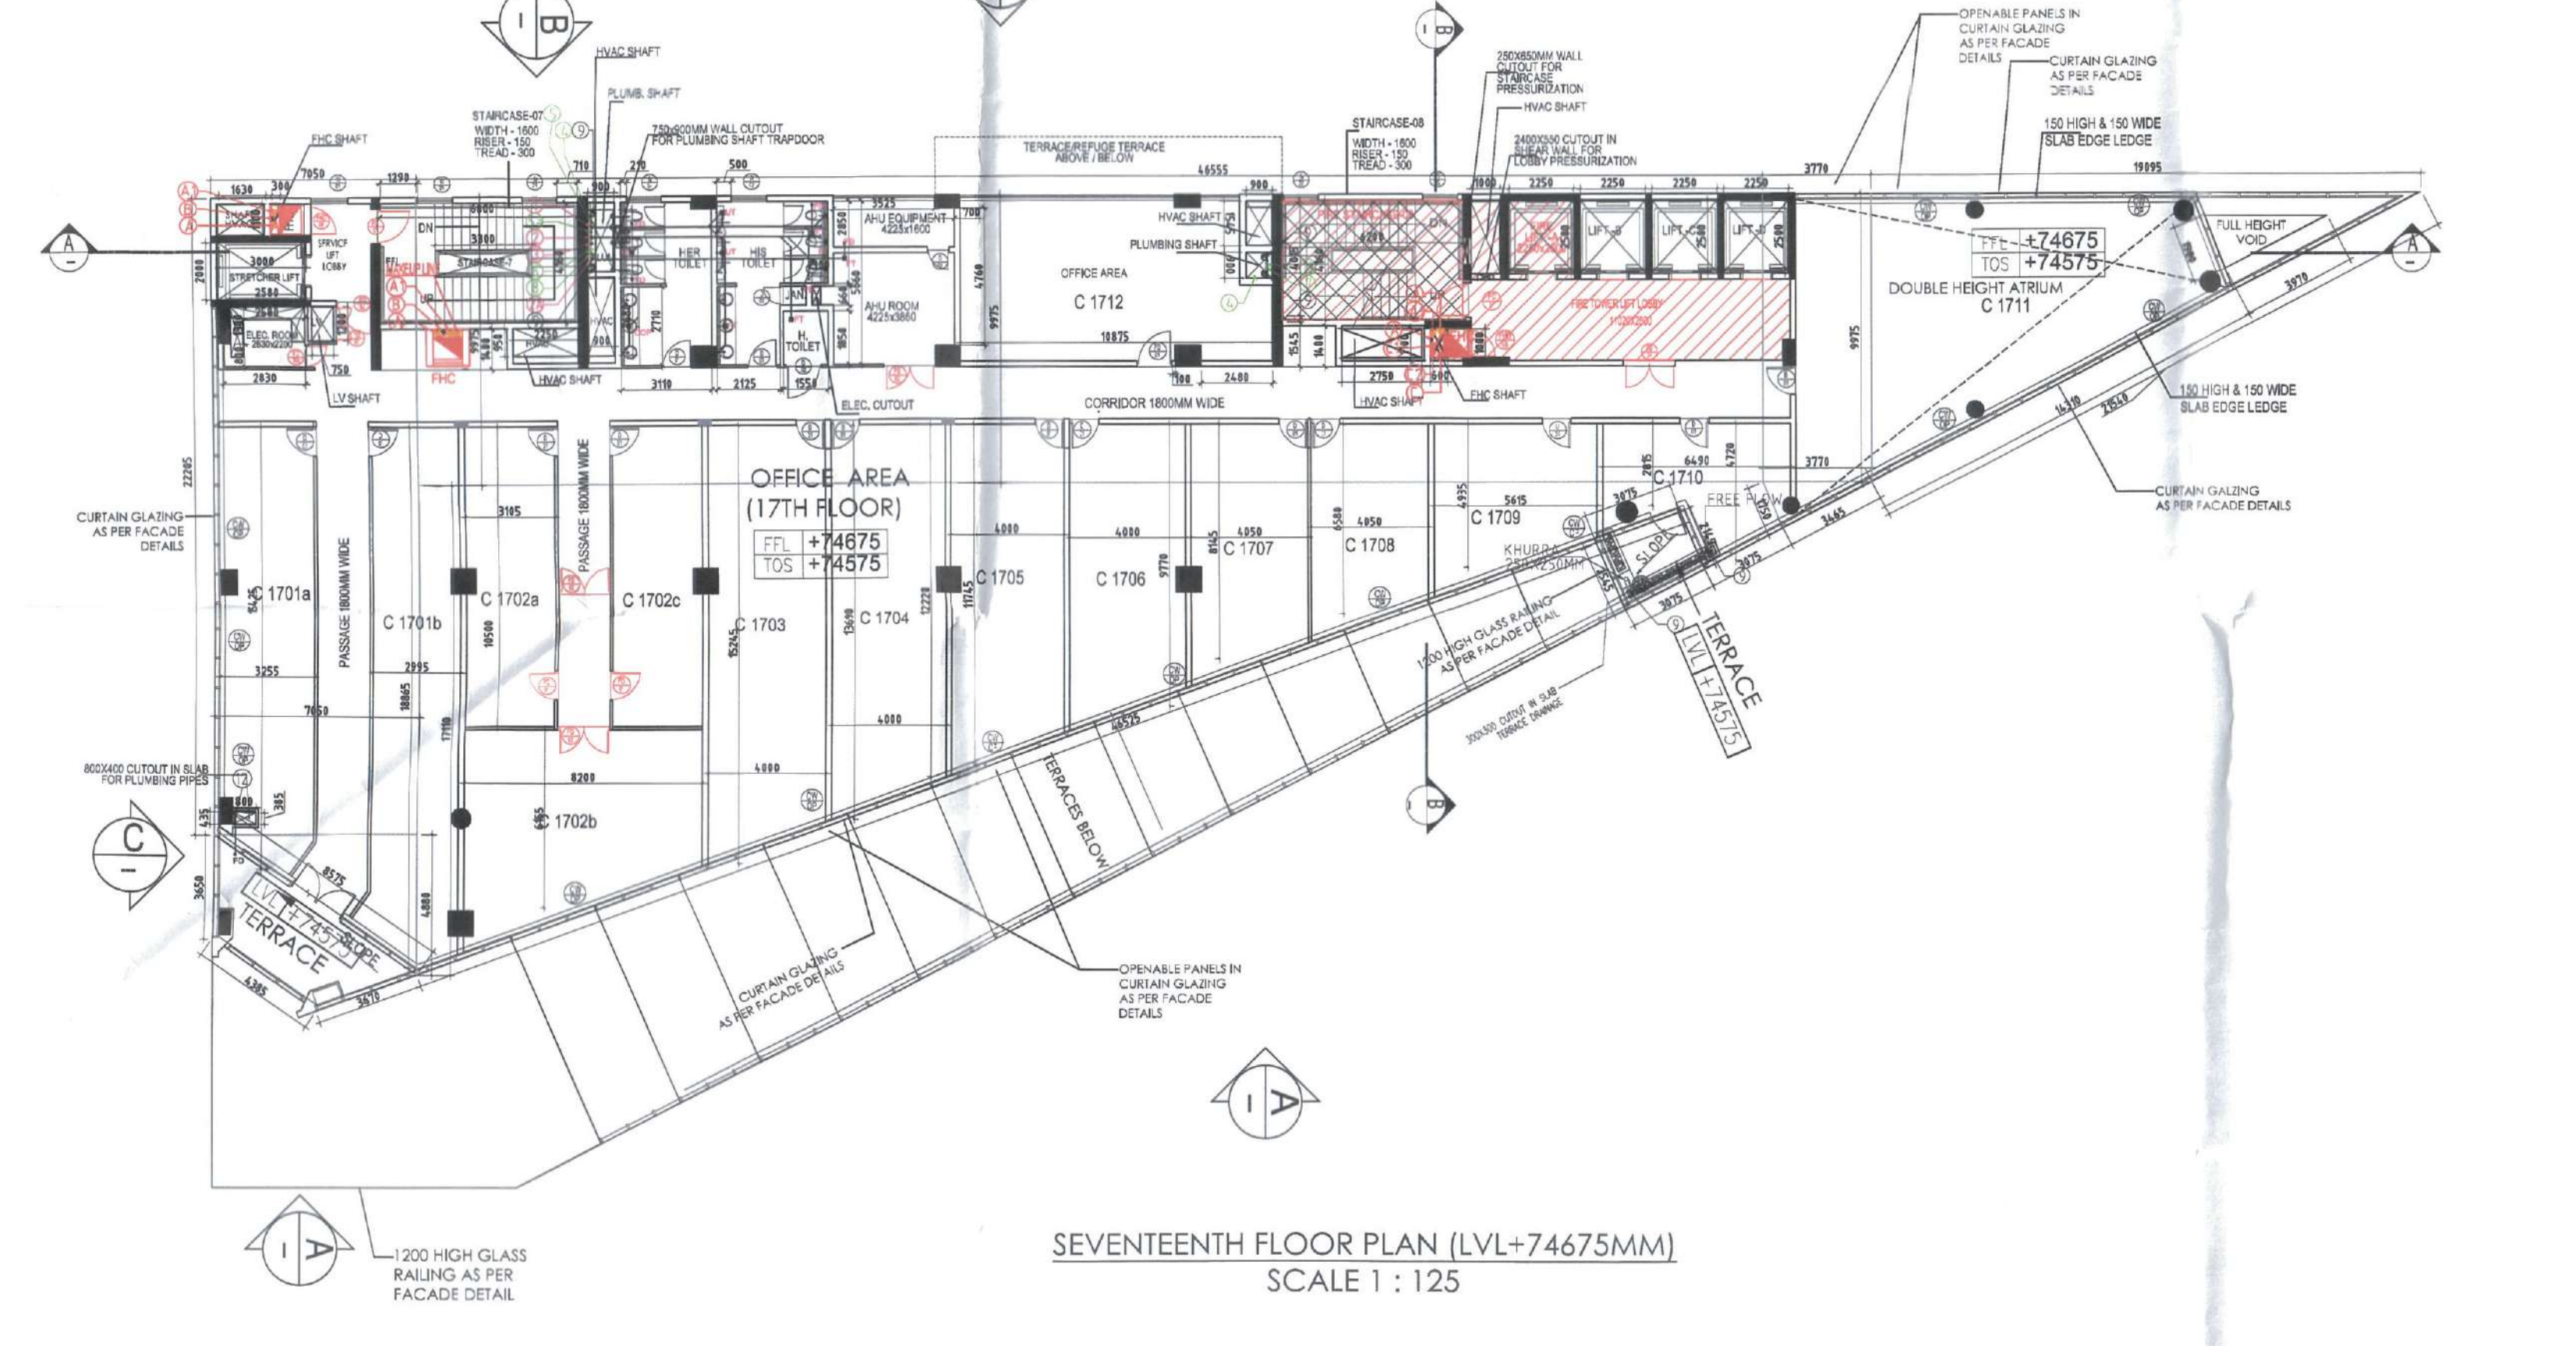

SEVENTEENTH FLOOR PLAN (LVL+74675MM)
SCALE 1 : 125

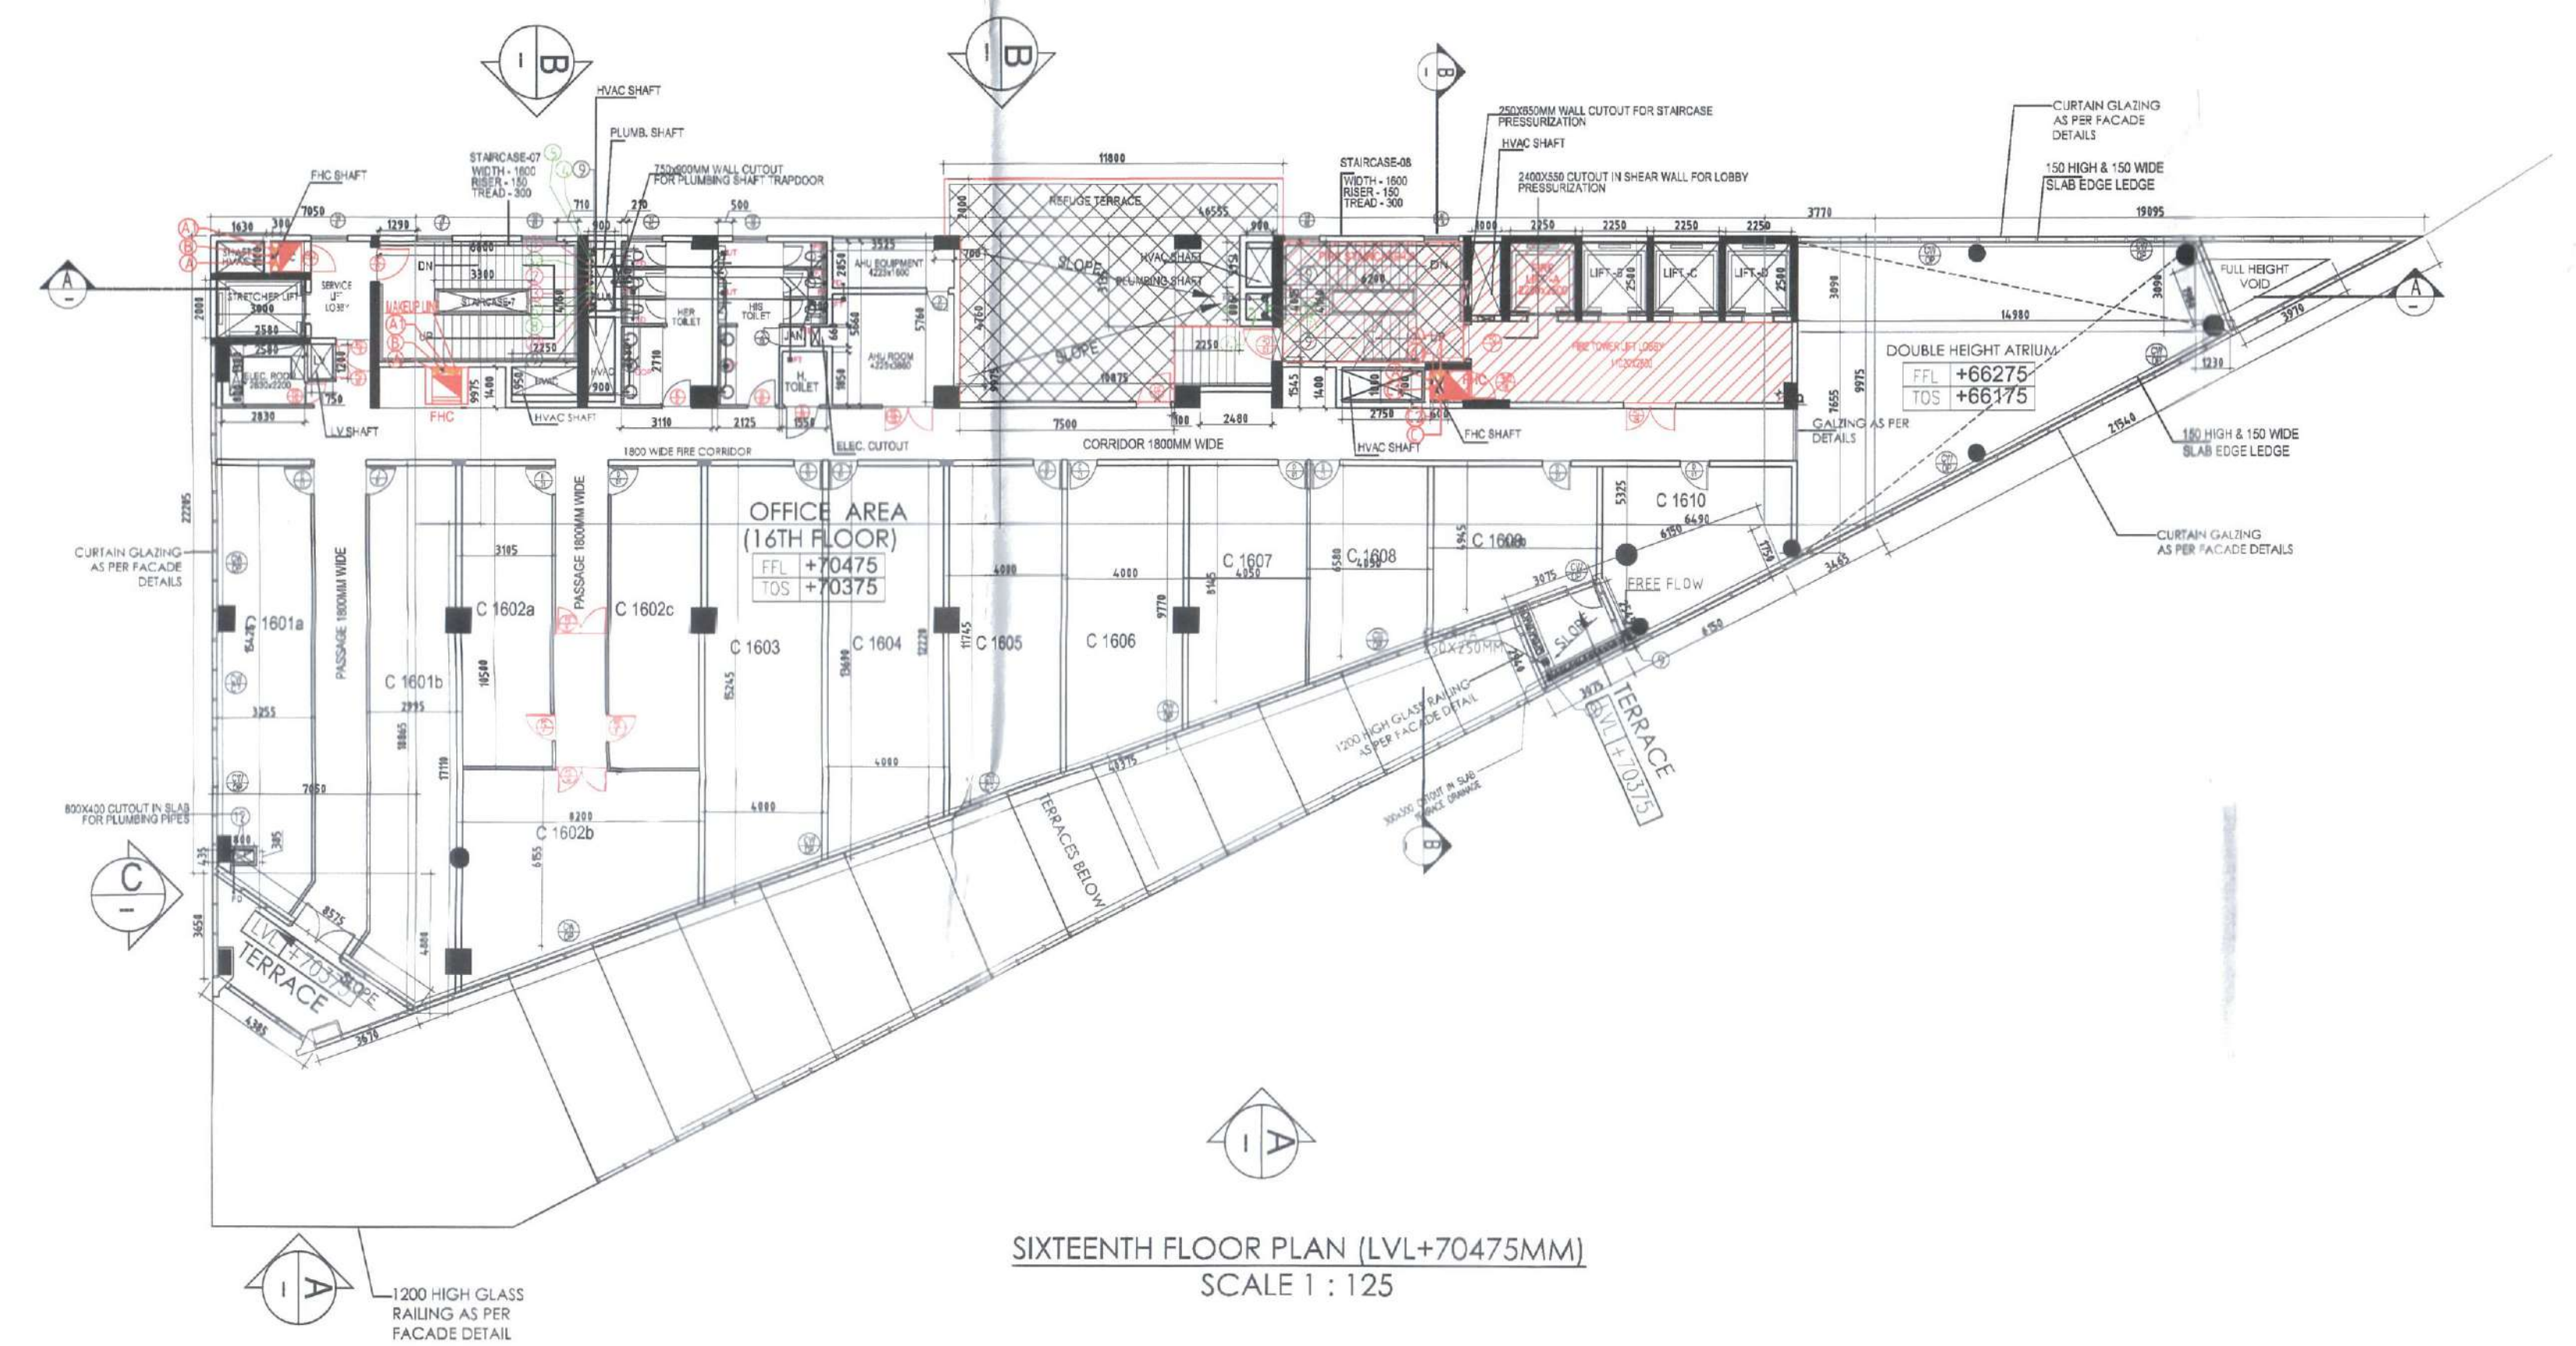

SIXTEENTH FLOOR PLAN (LVL+70475MM)
SCALE 1 : 125