


NOTES:
1. BUILDING IS ARTIFICIALLY LIGHTED MECHANICALLY VENTILATED FULLY AIR-CONDITIONED & HAS AUTOMATIC SPRINKLER SYSTEM ON ALL FLOORS.
2. BUILDING WILL BE DESIGNED (STRUCTURES) AS PER RELEVANT IS CODES FOR EARTH QUAKE RESISTANCE.
3. TRAVEL DISTANCE COMPLIANCE TO NATIONAL BUILDING CODE 2005 FOR FULLY SPRINKLED COMMERCIAL BUILDING.
4. WATER HARVESTING SYSTEM SOLAR WATER SYSTEM & LED LIGHTING WILL BE PROVIDED AS REQUIRED.

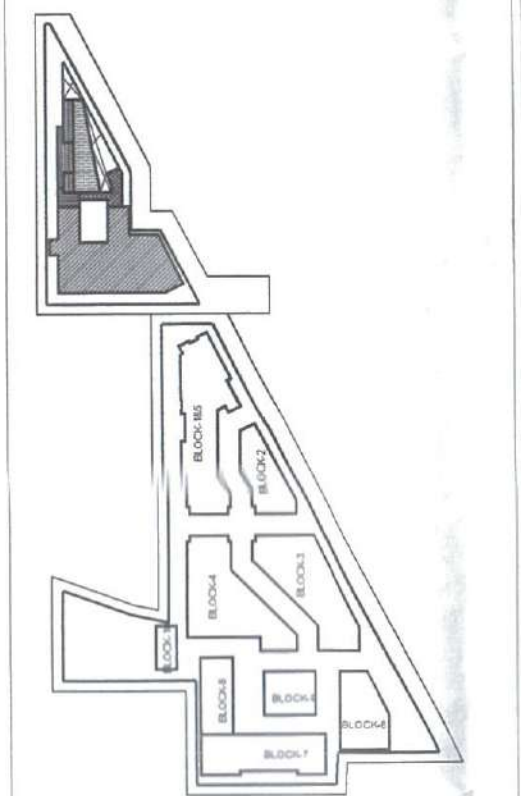

KEY PLAN
LEGEND
SET-BACK LINE
SITE BOUNDARY
BUILDING LINE
BASEMENT LINE



ELEVATION-C (SIDE ELEVATION)



ELEVATION-B (REAR ELEVATION)

This is a PROJECT APPROVED BUILDING PLAN
with the approval of the
Department of Urban Planning
& Construction
Government of India
Ministry of Urban Affairs
New Delhi

PLUMBING & FIRE FIGHTING CONSULTANT:
C P VIDYA AND ASSOCIATES
312A, Udhav Avenue, South City-II, Sector 45
Gurgaon, Haryana - 122018, Phone: +91 124 4072938
Email: cpvidyaassociates@gmail.com

DEVELOPER:
DEW POINT CONSULTANTS PVT. LTD.
TA-8 & TA-16, Crown Plaza, Mathura Road,
Sector 54A, Faridabad 121 002, TELEFAX: (0129)
407229 / 407229 E-mail:
jprasad@depoint.com

ELECTRICAL CONSULTANT:
AMPOWER CONSULTANCY SERVICES
B-122 Second Floor, Naraina Industrial Area
Phase - 1, Near Bluebonnets,
New Delhi-110028
Ph No: 41414735 / 45054718; e-mail:
vamsi@ampower.in

STRUCTURE CONSULTANT:
PRISTINE IDEAS
40221, L-10, SE PAK, NEW DELHI - 110019
P: 011 49053477, info@pristineideas.org

NOTE:
ALL DIMENSIONS ARE IN MILLIMETERS
ORIENTATION: SHEET NO: 1 OF 2
SUBJECT OF DRAWING: ELEVATIONS

OWNER'S SIGNATURE:
ARCHITECT'S SIGNATURE:
CONSULTANT'S SIGNATURE:

CLIENT:
M/s MARTIAL BUILDCON PVT. LTD.
ADDRESS:
OFFICE NO. 2, 2ND FLOOR, L-373
MAHAPAL PUR, EXTENSION NEW
DELHI - 110073

PROJECT TITLE:
APPROVAL OF REVISED BUILDING PLANS OF
COMMERCIAL COLONY AREA AS PERING 11.1.175
ACRES (LICENCE NO. 89 OF 2010 DATED 26/04/2010)
LICENCE NO. 100 OF 2010 DATED 26/04/2010
LICENCE NO. 11 OF 2011 DATED 26/04/2011
LICENCE NO. 36 OF 2013 DATED 31/03/2013 WITH
CORRECTIVE DRAWING NO. 1479 OF 2013 DATED
04/02/2010 IN SECTION 47, GURUGRAM, HARYANA
URBAN COMPLEXING DEVELOPED BY: M/s
MARTIAL BUILDCON PVT. LTD.

PROJECT CONSULTANT:
DESIGN PLUS ASSOCIATE SERVICES PRIVATE LIMITED
E-14/20 INDUSTRIAL ESTATE,
PHASE-II, NEW DELHI-110028
T: 491 1864, 491 1955, 4552220
P: 491 1860

DATE: 28.08.2018
SCALE: 1:500
SHEET: 1 OF 2
JOB NO: DPA DRAWING NO: ASD-UP-120