

SN	TYPE	FIGHTING PIPE	LEGEND:-
A	IRRIANT	PPE ZONE-1	
B	IRRIANT	PPE ZONE-2	
C	IRRIANT	PPE ZONE-3	
D	SPARKLER	PPE ZONE-1	
E	SPARKLER	PPE ZONE-2	
F	SPARKLER	PPE ZONE-3	
G	SPARKLER	STAND BY PPE ZONE-1	
H	SPARKLER	STAND BY PPE ZONE-2	
I	SPARKLER	STAND BY PPE ZONE-3	
J	DOAN	PPE	
K	DOAN	PPE	
INC	FIRE	HOSE CABINET	




TYPICAL 3RD FLOOR AREA CALCULATION									
GROSS AREA		1	2	3	4	5	6	7	8
1	1	X	X	X	X	1,930			1,930
2	2	X	X	X	X	3,900			3,900
3	3	X	X	X	X	11,350			11,350
4	4	X	X	X	X	1,540			1,540
5	5	X	X	X	X	1,700			1,700
6	6	X	X	X	X	3,700			3,700
7	7	X	X	X	X	10,870			10,870
8	8	X	X	X	X	1,640			1,640
9	9	X	X	X	X	14,820			14,820
10	10	X	X	X	X	3,350			3,350
11	11	X	X	X	X	8,250			8,250
12	12	X	X	X	X	15,850			15,850
13	13	X	X	X	X	15,560			15,560
14	14	X	X	X	X	8,225			8,225
15	15	X	X	X	X	9,625			9,625
16	16	X	X	X	X	15,330			15,330
17	17	X	X	X	X	12,675			12,675
18	18	X	X	X	X	1,590			1,590
19	19	X	X	X	X	4,375			4,375
20	20	X	X	X	X	2,850			2,850
21	21	X	X	X	X	1,440			1,440
22	22	X	X	X	X	3,750			3,750
23	23	X	X	X	X	2,030			2,030
24	24	X	X	X	X	5,660			5,660
25	25	X	X	X	X	6,625			6,625
26	26	X	X	X	X	1,625			1,625
27	27	X	X	X	X	3,800			3,800
28	28	X	X	X	X	1,900			1,900
29	29	X	X	X	X	2,700			2,700
30	30	X	X	X	X	1,900			1,900
31	31	X	X	X	X	1,900			1,900
32	32	X	X	X	X	1,900			1,900
33	33	X	X	X	X	1,900			1,900
34	34	X	X	X	X	1,900			1,900
35	35	X	X	X	X	1,900			1,900
36	36	X	X	X	X	1,900			1,900
37	37	X	X	X	X	1,900			1,900
38	38	X	X	X	X	1,900			1,900
39	39	X	X	X	X	1,900			1,900
40	40	X	X	X	X	1,900			1,900
41	41	X	X	X	X	1,900			1,900
42	42	X	X	X	X	1,900			1,900
43	43	X	X	X	X	1,900			1,900
44	44	X	X	X	X	1,900			1,900
45	45	X	X	X	X	1,900			1,900
46	46	X	X	X	X	1,900			1,900
47	47	X	X	X	X	1,900			1,900
48	48	X	X	X	X	1,900			1,900
49	49	X	X	X	X	1,900			1,900
50	50	X	X	X	X	1,900			1,900
51	51	X	X	X	X	1,900			1,900
52	52	X	X	X	X	1,900			1,900
GROSS-B						TOTAL	=	\$44,997	\$50M
a	a			X	X	0.00		0.040	\$50M
b	b			X	X	0.00		0.040	\$50M
c	c			X	X	1.825		19.450	\$50M
d	d			X	X	0.150		0.044	\$50M
e	e			X	X	0.175		0.044	\$50M
f	f			X	X	2.100		2.415	\$50M
g	g			X	X	1.950		2.445	\$50M
h	h			X	X	0.000		0.040	\$50M
i	i			X	X	0.000		0.040	\$50M
j	j			X	X	0.000		0.040	\$50M
k	k			X	X	0.000		0.040	\$50M
l	l			X	X	0.000		0.040	\$50M
m	m			X	X	1.400		1.920	\$50M
n	n			X	X	0.000		0.050	\$50M
o	o			X	X	0.000		0.050	\$50M
p	p			X	X	0.000		0.050	\$50M
q	q			X	X	0.000		0.050	\$50M
r	r			X	X	0.000		0.050	\$50M
s	s			X	X	0.000		0.050	\$50M
t	t			X	X	0.000		0.050	\$50M
u	u			X	X	0.000		0.050	\$50M
v	v			X	X	2.000		2.000	\$50M
w	w			X	X	0.000		0.050	\$50M
x	x			X	X	1.250		2.488	\$50M
y	y			X	X	1.950		2.488	\$50M
z	z			X	X	2.250		2.700	\$50M
aa	aa			X	X	2.250		2.700	\$50M
ab	ab			X	X	5.250		3.150	\$50M
GROSS-C						TOTAL	=	13,720	\$50M
ac	ac		1	X	X	3.800		10.200	\$50M
ad	ad		1	X	X	1.200		0.750	\$50M
ae	ae		1	X	X	1.500		14.575	\$50M
FAR AREA OF 2ND TO 31ST FLOOR						TOTAL	=	29,015	\$50M
FAR AREA OF 2ND TO 31ST FLOOR						GROSS-A	=	GROSS-B	-
							=	80,201	-
							=	GROSS-C	-
BUILT-UP AREA OF 2ND TO 31ST FLOOR						GROSS-D	=	GROSS-D	-
							=	844,388	-
TOTAL						TOTAL	=	844,388	\$50M

OWNER'S SEAL
& SIGNATURE

ARCHITECT'S SEAL

Chandraya
AVINASH CHANDRA VAIDYA
Architect No. CA/75/02006
H. No. 163, PH-II
New Paltam Vihar, Gurgaon

AUG-2022.	Scale : 1:100	Drawing No.:
Drawing Title:-		

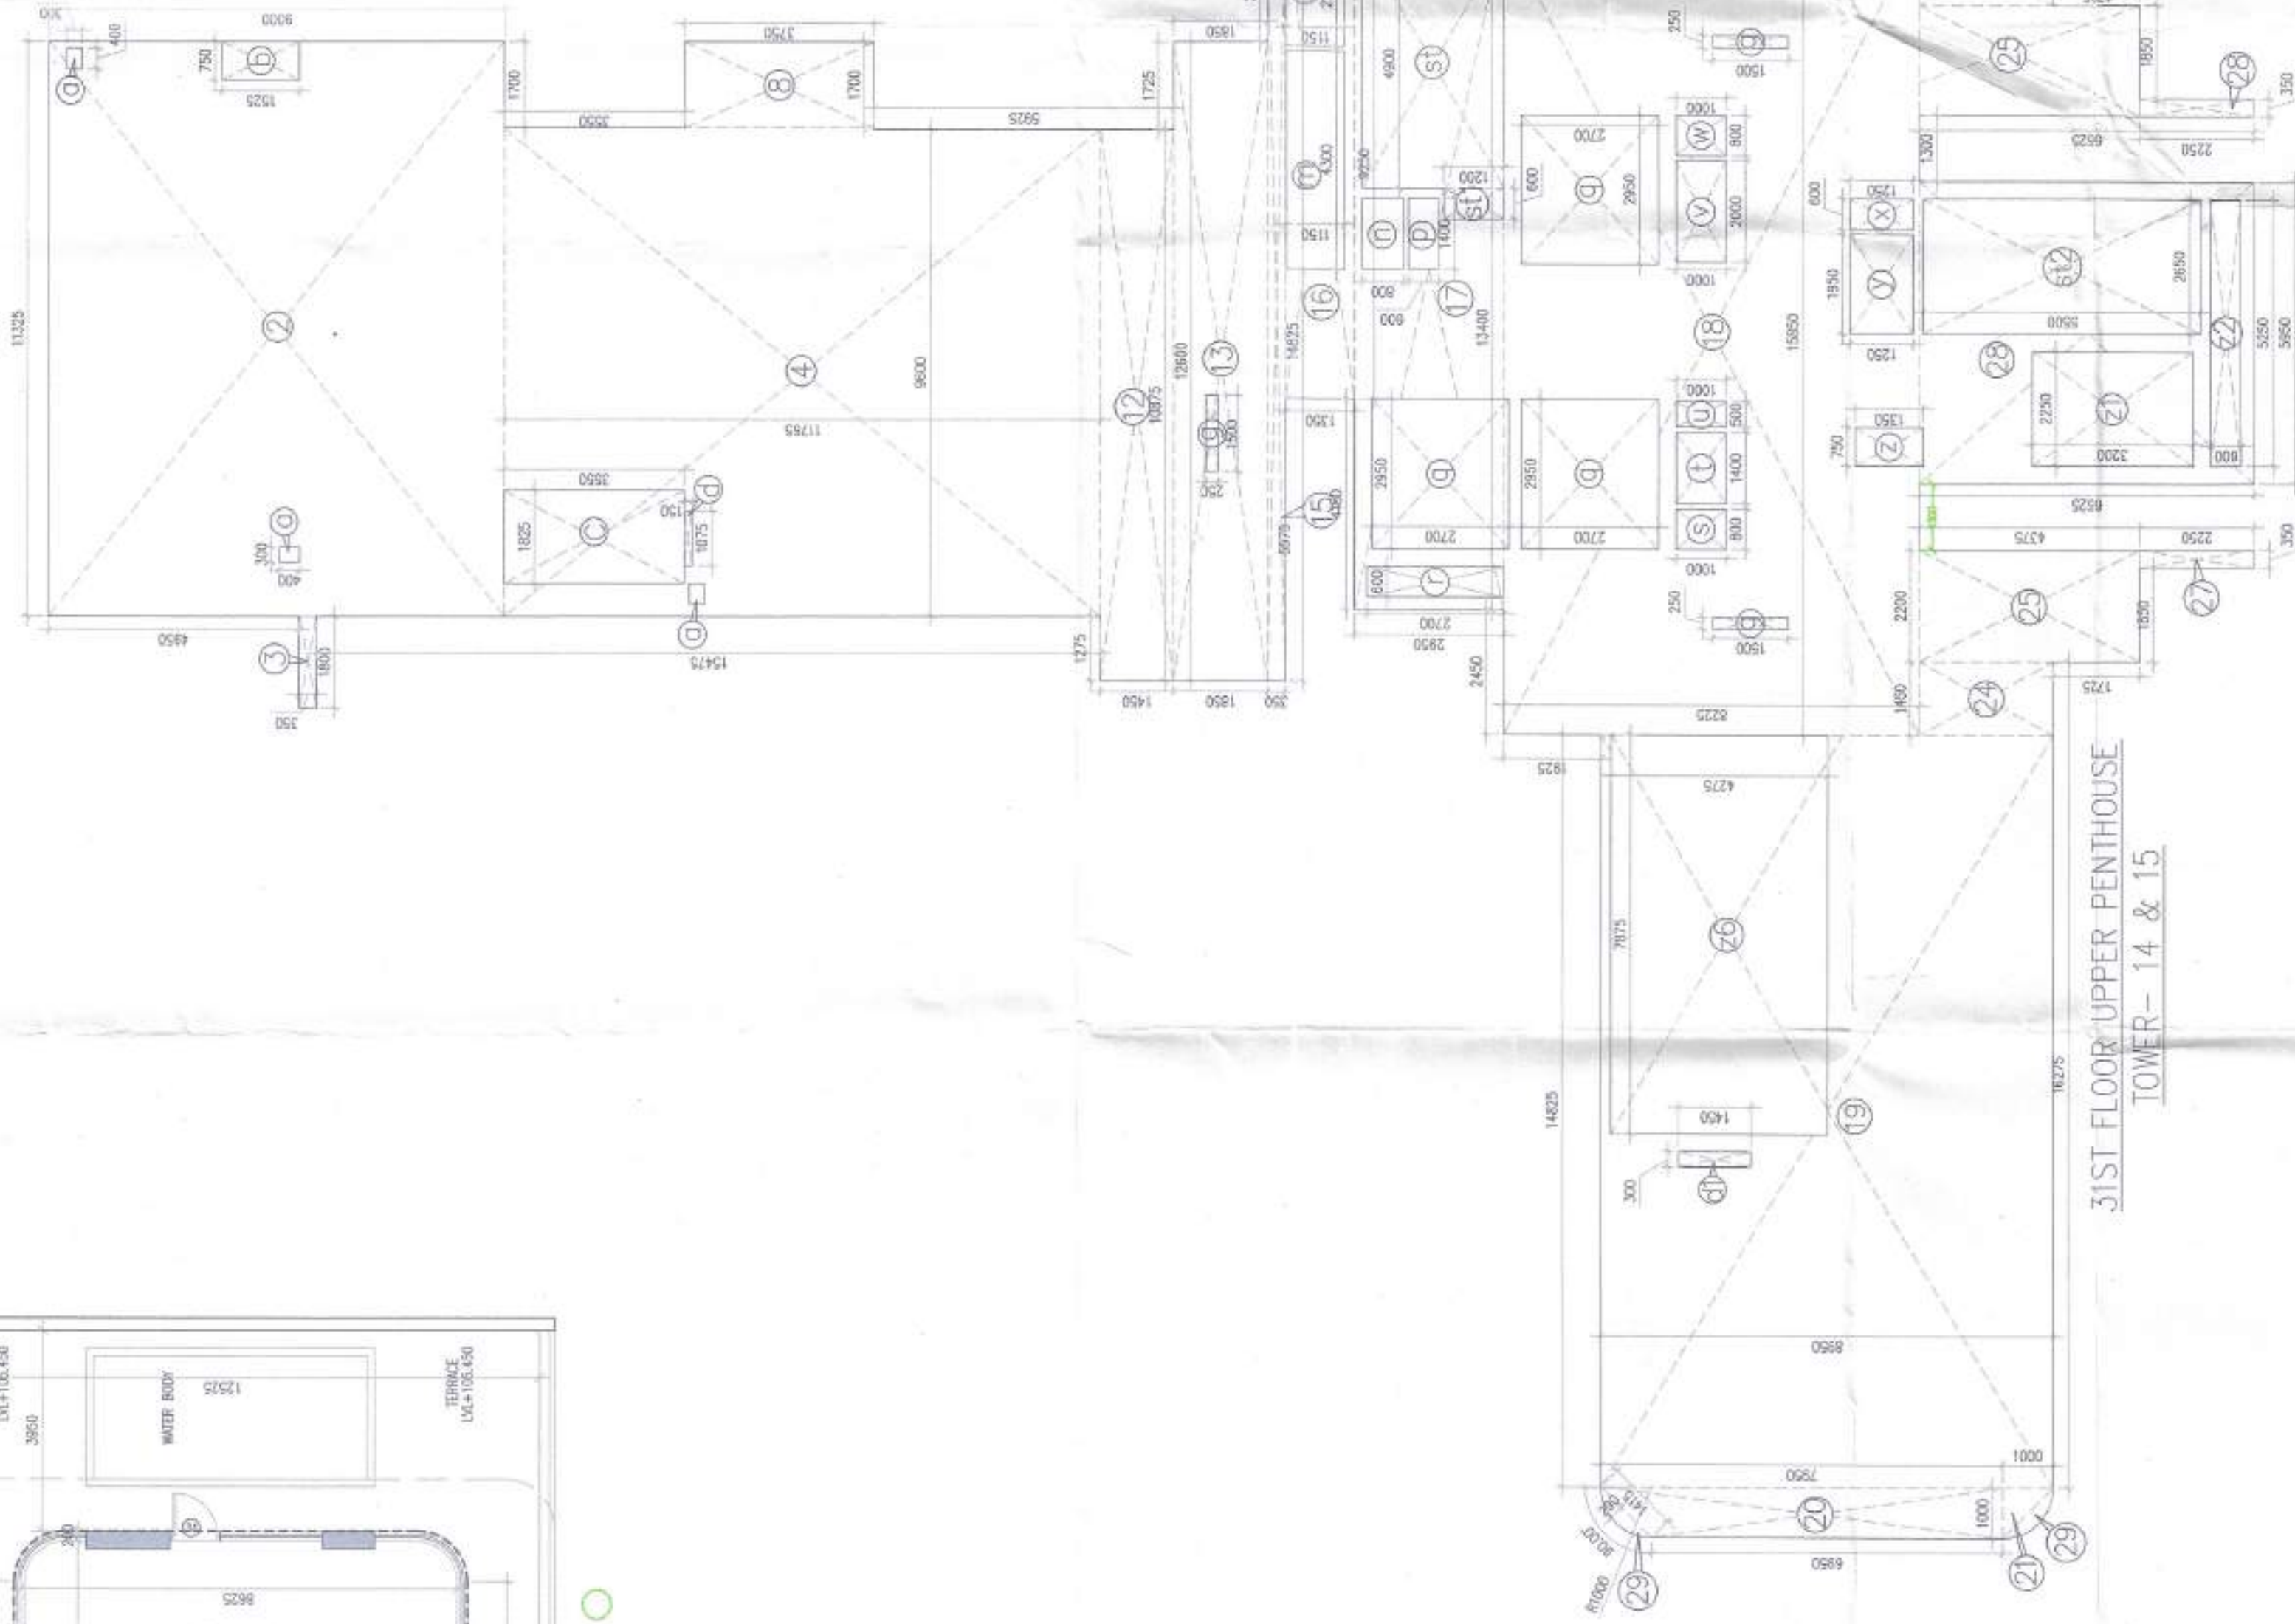[illegible]

AUG.-2022.	Scale : 1:100	Drawing No.
Drawing Title:-		

TOWER-14

31ST FLOOR PLAN

& FAR AREA

CALCULATION DIAGRAM

A-06

BUILDING HAS AUTOMATIC SPRINKLER SYSTEM
WHEREVER REQUIRED BY NBC




PROJECT: PROPOSED GROUP HOUSING COLONY MEASURING 24.10 ACRES (LICENCE NO 80 OF 2012 DATED 17/08/2012) IN SECTOR 106, GURUGRAM MANESAR (URBAN) COMPLEX BEING DEVELOPED BY ARMD DEVELOPERS LTD. & OTHERS.

OWNER'S SEAL
& SIGNATUREARCHITECT'S SEAL
& SIGNATURE

claiduqiz
AVIRASH CHANDRA VAIDYA
Architect No. CA/75/02006
H, No. 103, PH-II
New Palm Vihar, Gurgaon

U.C.-2022.	Scale : 1:100	Drawing No.
Drawing Title:- TOWER-14 FIRST FLOOR PLAN & FAR AREA		

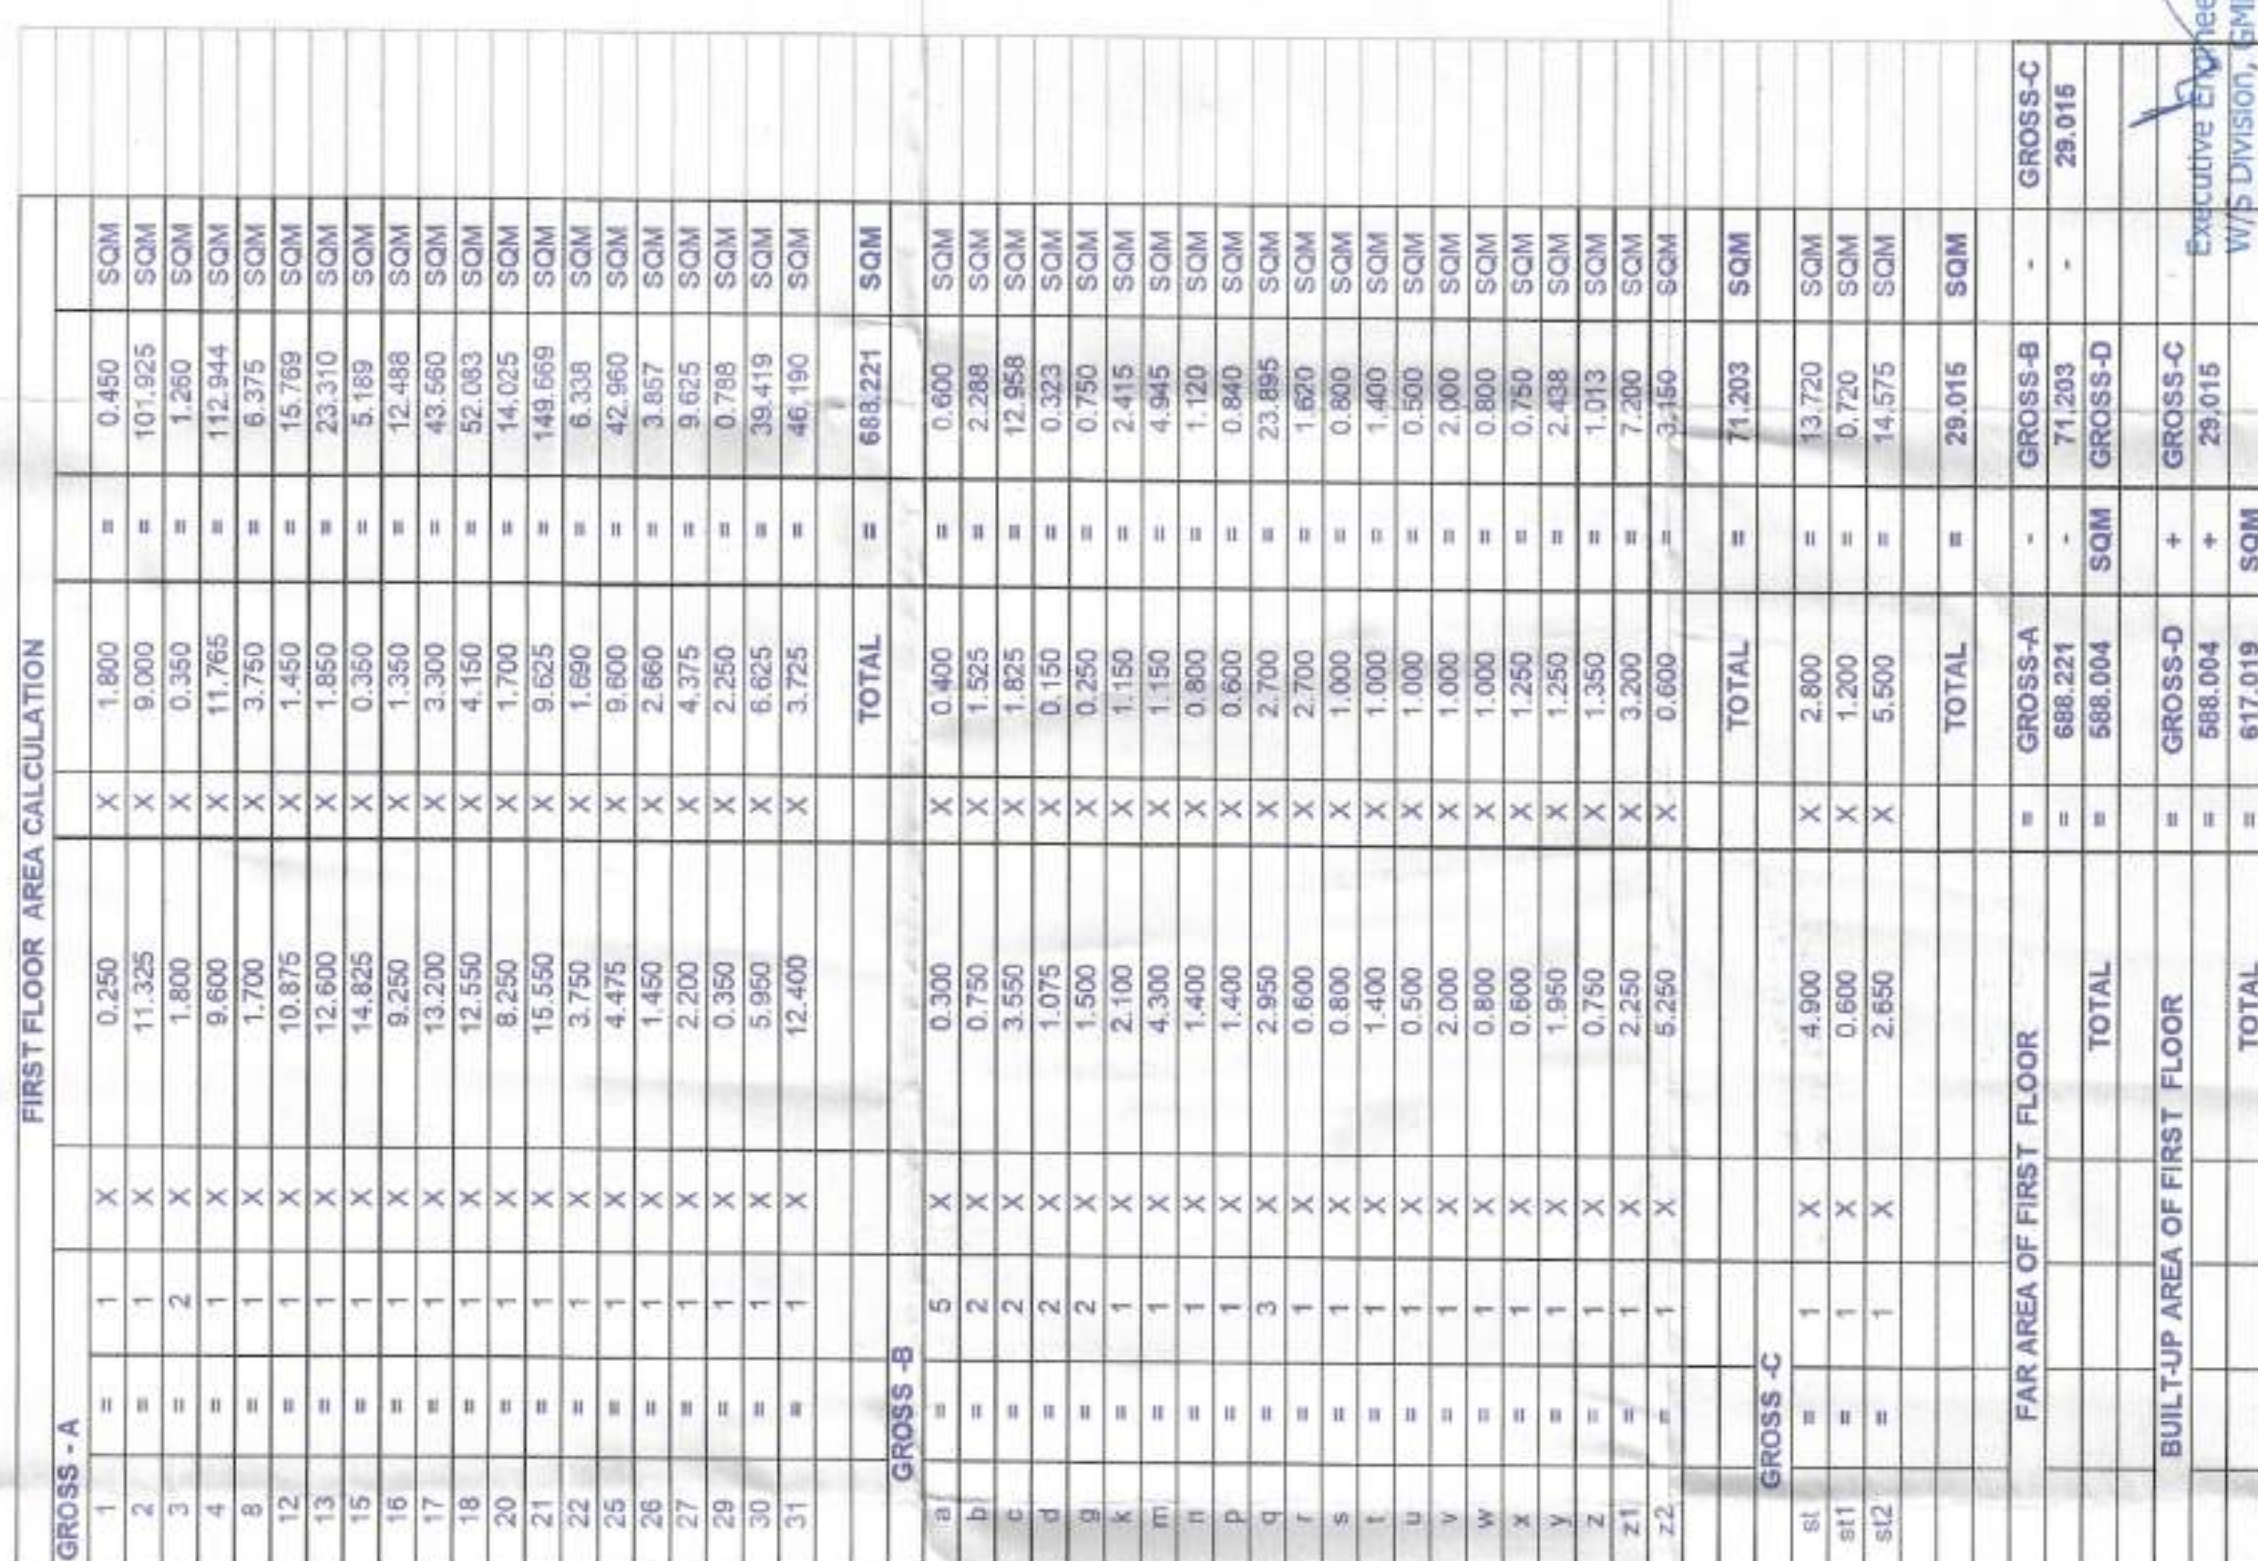

Building Plans have been checked and found in order as per Public Health Services point of view

Executive Engineer-V,
New, Division, GMDA,
Gurugram

Chief Engineer,
(Infra-II), GMDA


[illegible][illegible]

SN	FIRE FIGHTING PIPE LEGEND -
A	HYDRANT PIPE ZONE-1
B	HYDRANT PIPE ZONE-2
C	HYDRANT PIPE ZONE-3
D	SPRINKLER PIPE ZONE-1
E	SPRINKLER PIPE ZONE-2
F	SPRINKLER PIPE ZONE-3
G	SPRINKLER STAND BY PIPE ZONE-1
H	SPRINKLER STAND BY PIPE ZONE-2
I	SPRINKLER STAND BY PIPE ZONE-3
J	DOWN PFC
K	DOWN PFC
THC	FIRE HOSE CABINET

1. BUILDING HAS AUTOMATIC SPRINKLER SYSTEM WHEREVER REQUIRED BY NBC

2. BUILDING WILL BE DESIGNED STRUCTURES AS PER RELEVANT IS CODES FOR EARTH QUAKE RESISTANCE

3. WE SHALL BE PERMANENTLY LIGHT & VENTILATED WHEREVER REQUIRED.

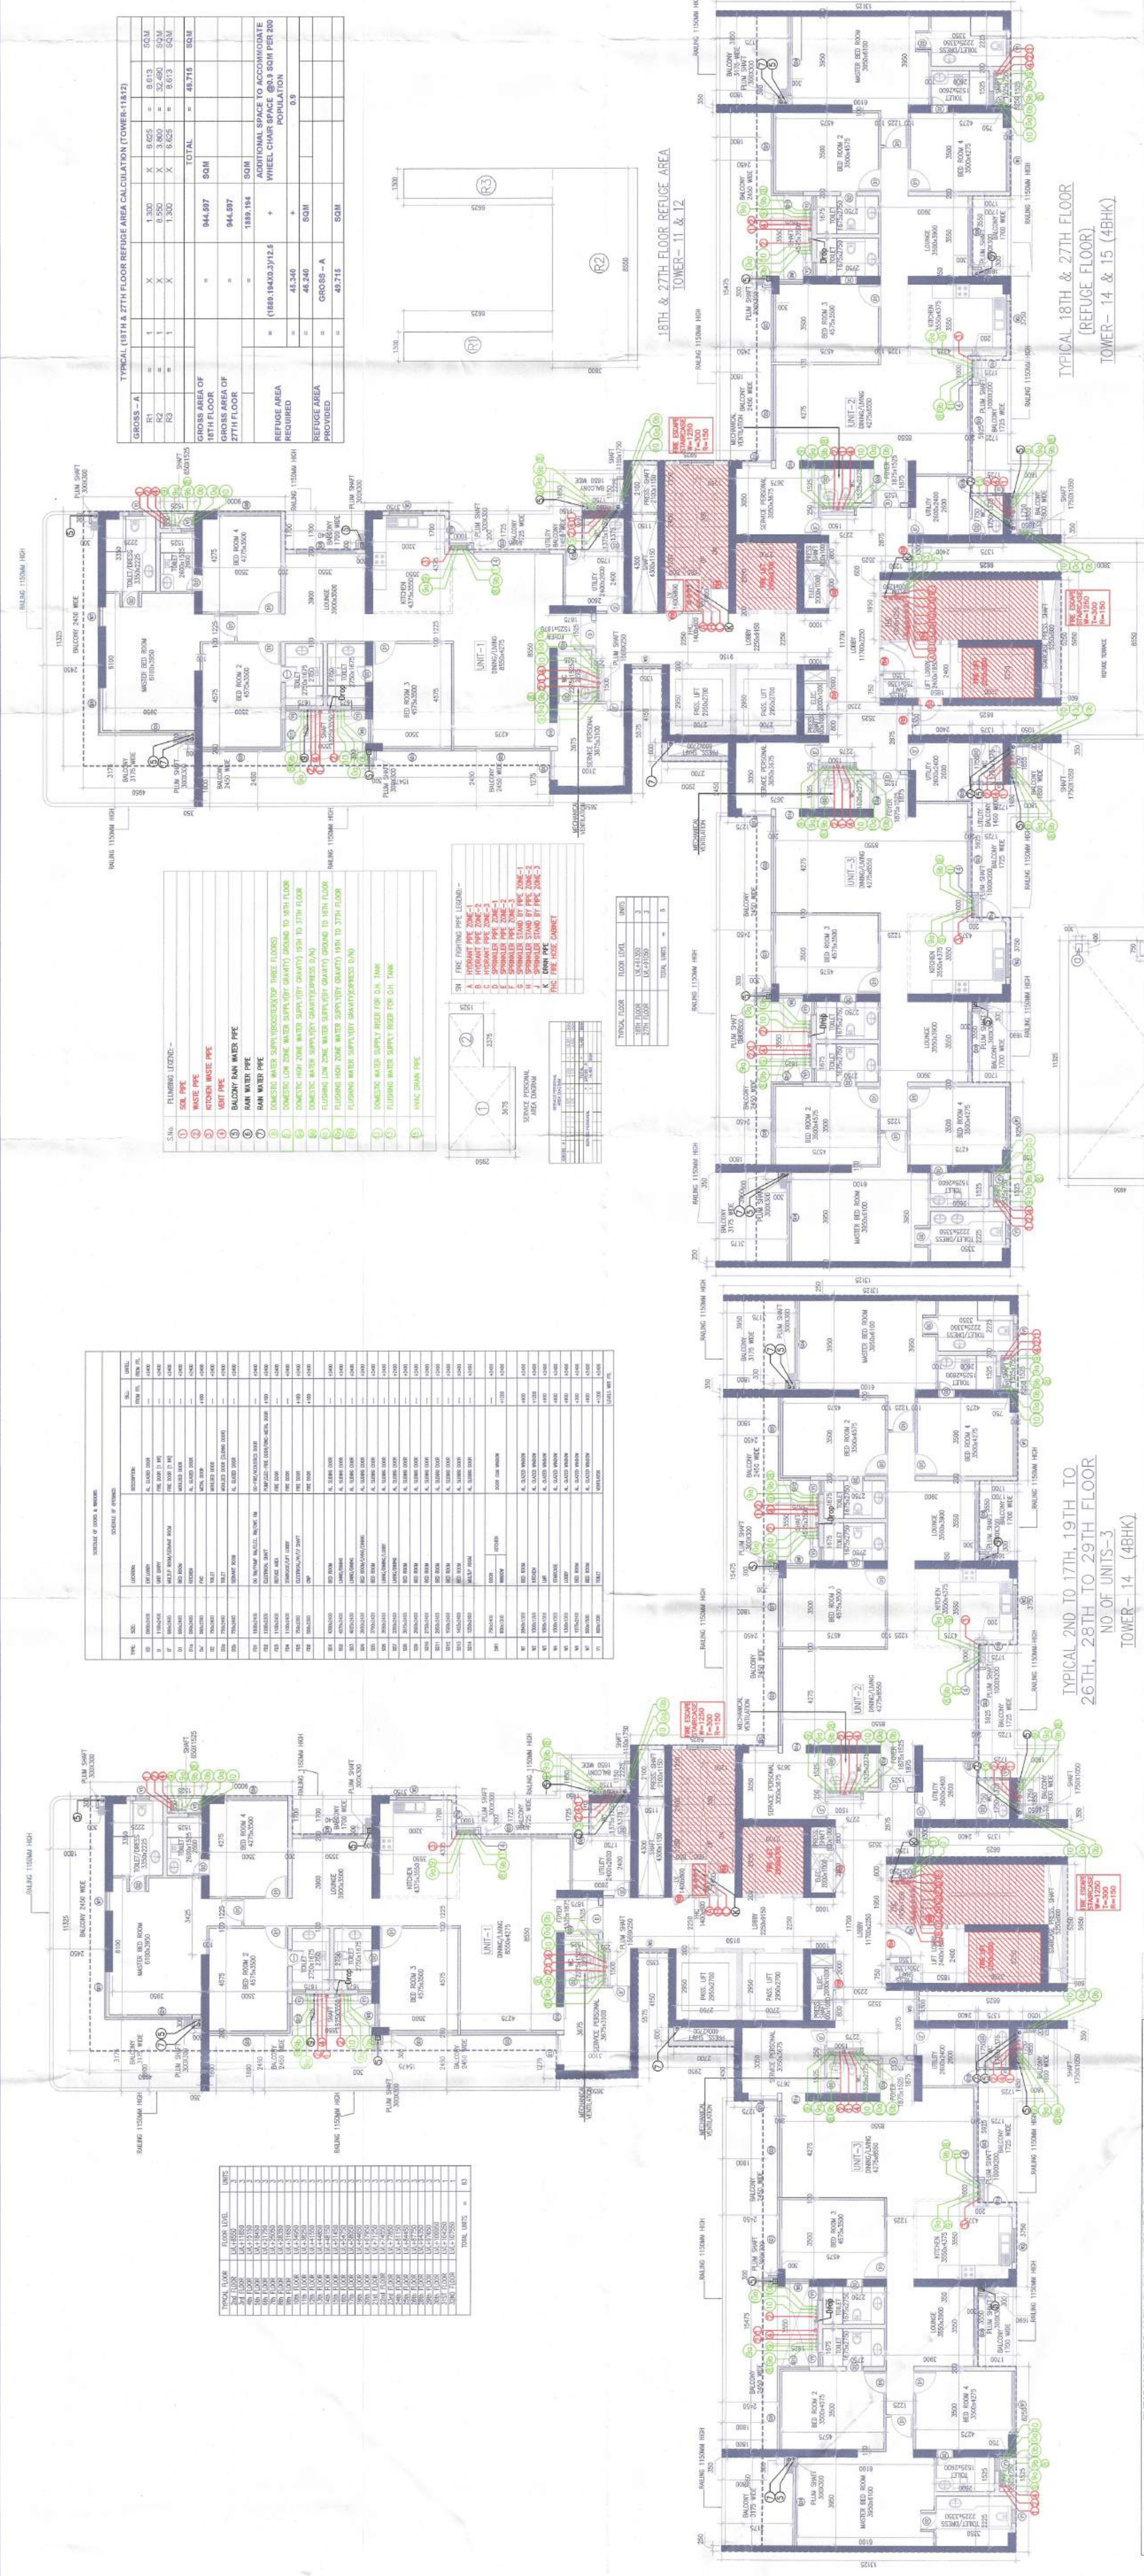

PROJECT: PROPOSED BUILDING PLAN OF GROUP HOUSING COLONY MEASURING 24.10 ACRES (LICENSE NO. 80 OF 2012 DATED 17/09/2012) IN SECTOR 106, GURGOGRAM, NARRAR URBAN COMPLEX BEING DEVELOPED BY ANMD DEVELOPERS LTD. & OTHERS.

OWNER'S SEAL & SIGNATURE

ARCHITECT'S SEAL & SIGNATURE

Sanctioned By: DINESH KUMAR P.A.(P) MEMBER BPAC

TO BE READ WITH THIS OFFICE DATED: 17/09/2012

Scale: 1:100

Drawing Title: TOWER-14

Drawing No: AUG-2022

Project: PROPOSED BUILDING PLAN OF GROUP HOUSING COLONY MEASURING 24.10 ACRES (LICENSE NO. 80 OF 2012 DATED 17/09/2012) IN SECTOR 106, GURGOGRAM, NARRAR URBAN COMPLEX BEING DEVELOPED BY ANMD DEVELOPERS LTD. & OTHERS.

OWNER'S SEAL & SIGNATURE

ARCHITECT'S SEAL & SIGNATURE

Sanctioned By: DINESH KUMAR P.A.(P) MEMBER BPAC

TO BE READ WITH THIS OFFICE DATED: 17/09/2012

Scale: 1:100

Drawing Title: TOWER-14

Drawing No: AUG-2022

