


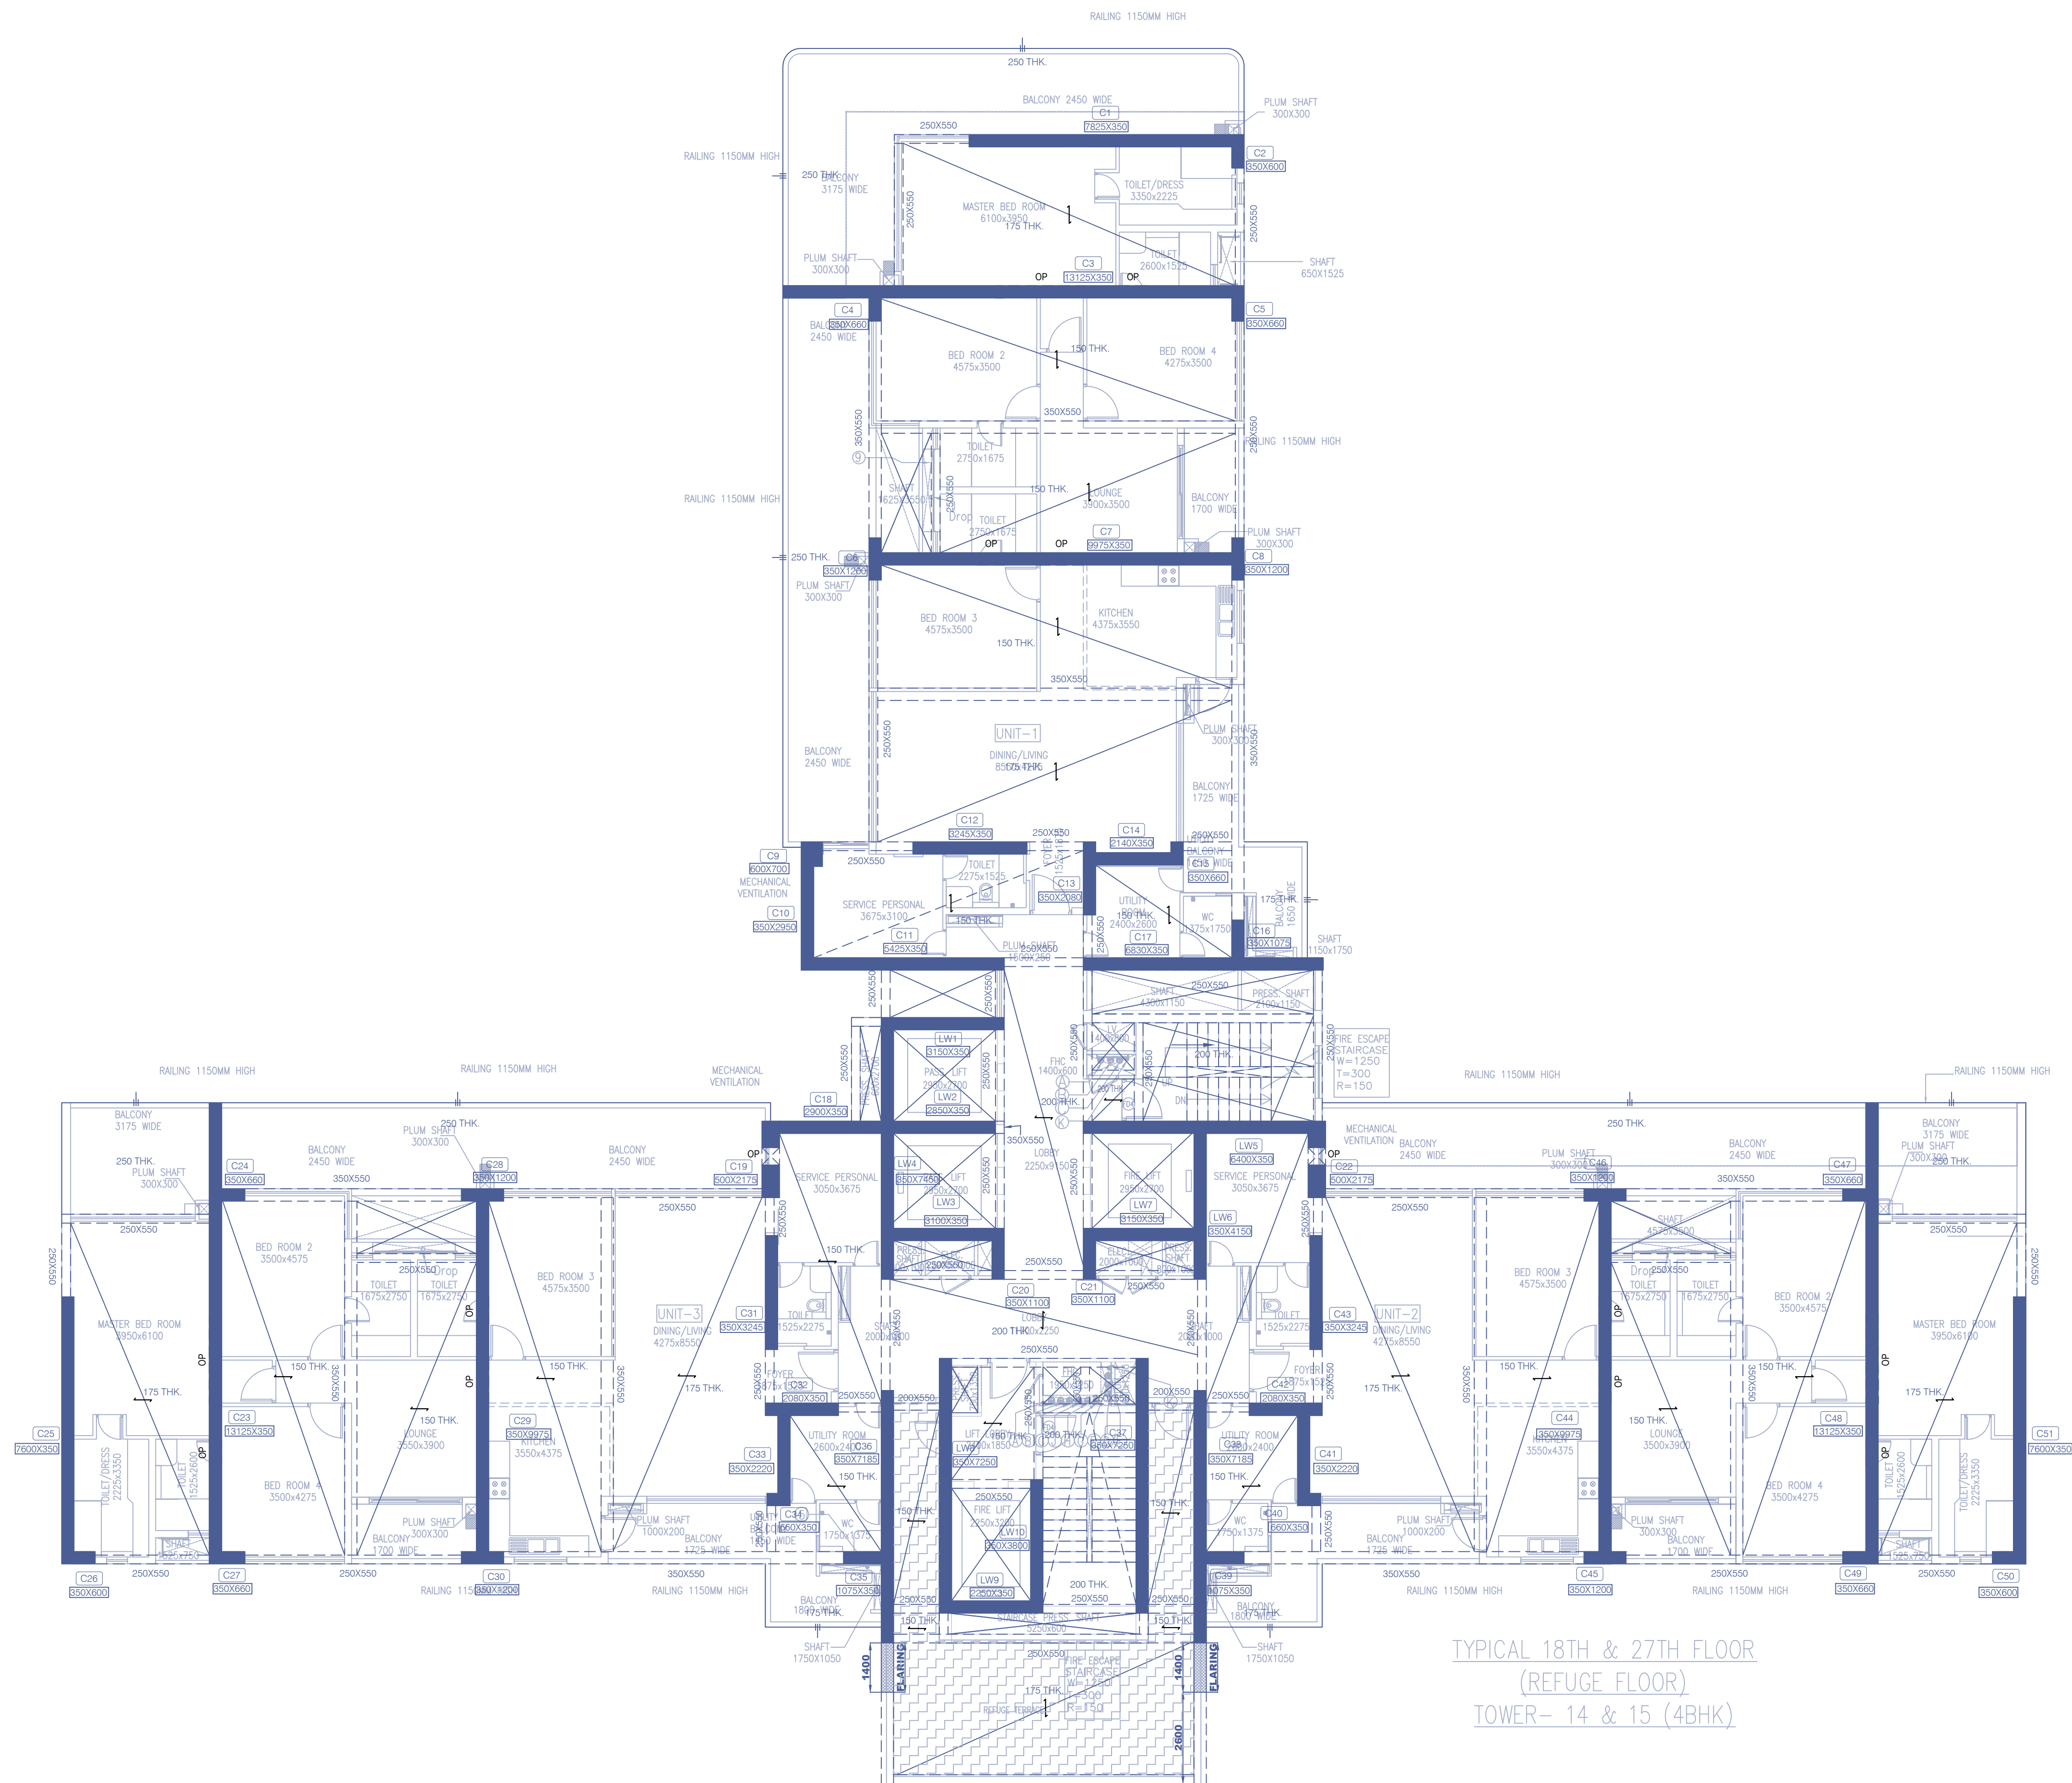

18TH & 27TH REFUGE FLOOR FRAMING PLAN

Note :-

1. BUILDING HAS AUTOMATIC SPRINKLER SYSTEM WHEREVER REQUIRED BY NBC.

2. BUILDING WILL BE DESIGNED (STRUCTURES) AS PER RELEVANT CODES FOR EARTH QUAKE RESISTANCE.

PROJECT:

PROPOSED BUILDING PLAN OF GROUP HOUSING COLONY MEASURING 24.10 ACRES (LICENCE NO 80 OF 2012 DATED 17/08/2012) IN SECTOR 106, GURUGRAM MANESAR URBAN COMPLEX BEING DEVELOPED BY AIRMD DEVELOPERS LTD. & OTHERS.

OWNER'S SEAL & SIGNATURE

ARCHITECT'S SEAL & SIGNATURE

STRUCTURE ENGG. SEAL & SIGNATURE


Puneet Kumar
B.E./CIVIL M.E. (Structure)
MEMB No. A-533803-S

30.AUG.-2022. Scale : 1:100
Drawing Title:- TOWER - 14
18TH & 27TH REFUGE FLOOR FRAMING PLAN
Drawing No:- STA-014

Note :-

1. BUILDING HAS AUTOMATIC SPRINKLER SYSTEM WHEREVER REQUIRED BY NBC.
2. BUILDING WILL BE DESIGNED (STRUCTURES) AS PER RELEVANT IS CODES FOR EARTH QUAKE RESISTANCE.

PROJECT:

PROPOSED BUILDING PLAN OF GROUP HOUSING COLONY MEASURING 24.10 ACRES (LICENCE NO 80 OF 2012 DATED 17/08/2012) IN SECTOR 106, GURUGRAM MANESAR URBAN COMPLEX BEING DEVELOPED BY AIRMD DEVELOPERS LTD. & OTHERS.

OWNER'S SEAL & SIGNATURE

ARCHITECT'S SEAL & SIGNATURE

STRUCTURE ENGG. SEAL & SIGNATURE



Puneet Kumar
B.E.(CIVIL) M.E. (Structure)
MEMB No. A-533803-S

30.AUG.-2022.

Scale : 1:100


Drawing Title:-
TOWER - 14
30TH FLOOR FRAMING PLAN

Drawing No:-
STA-01-6

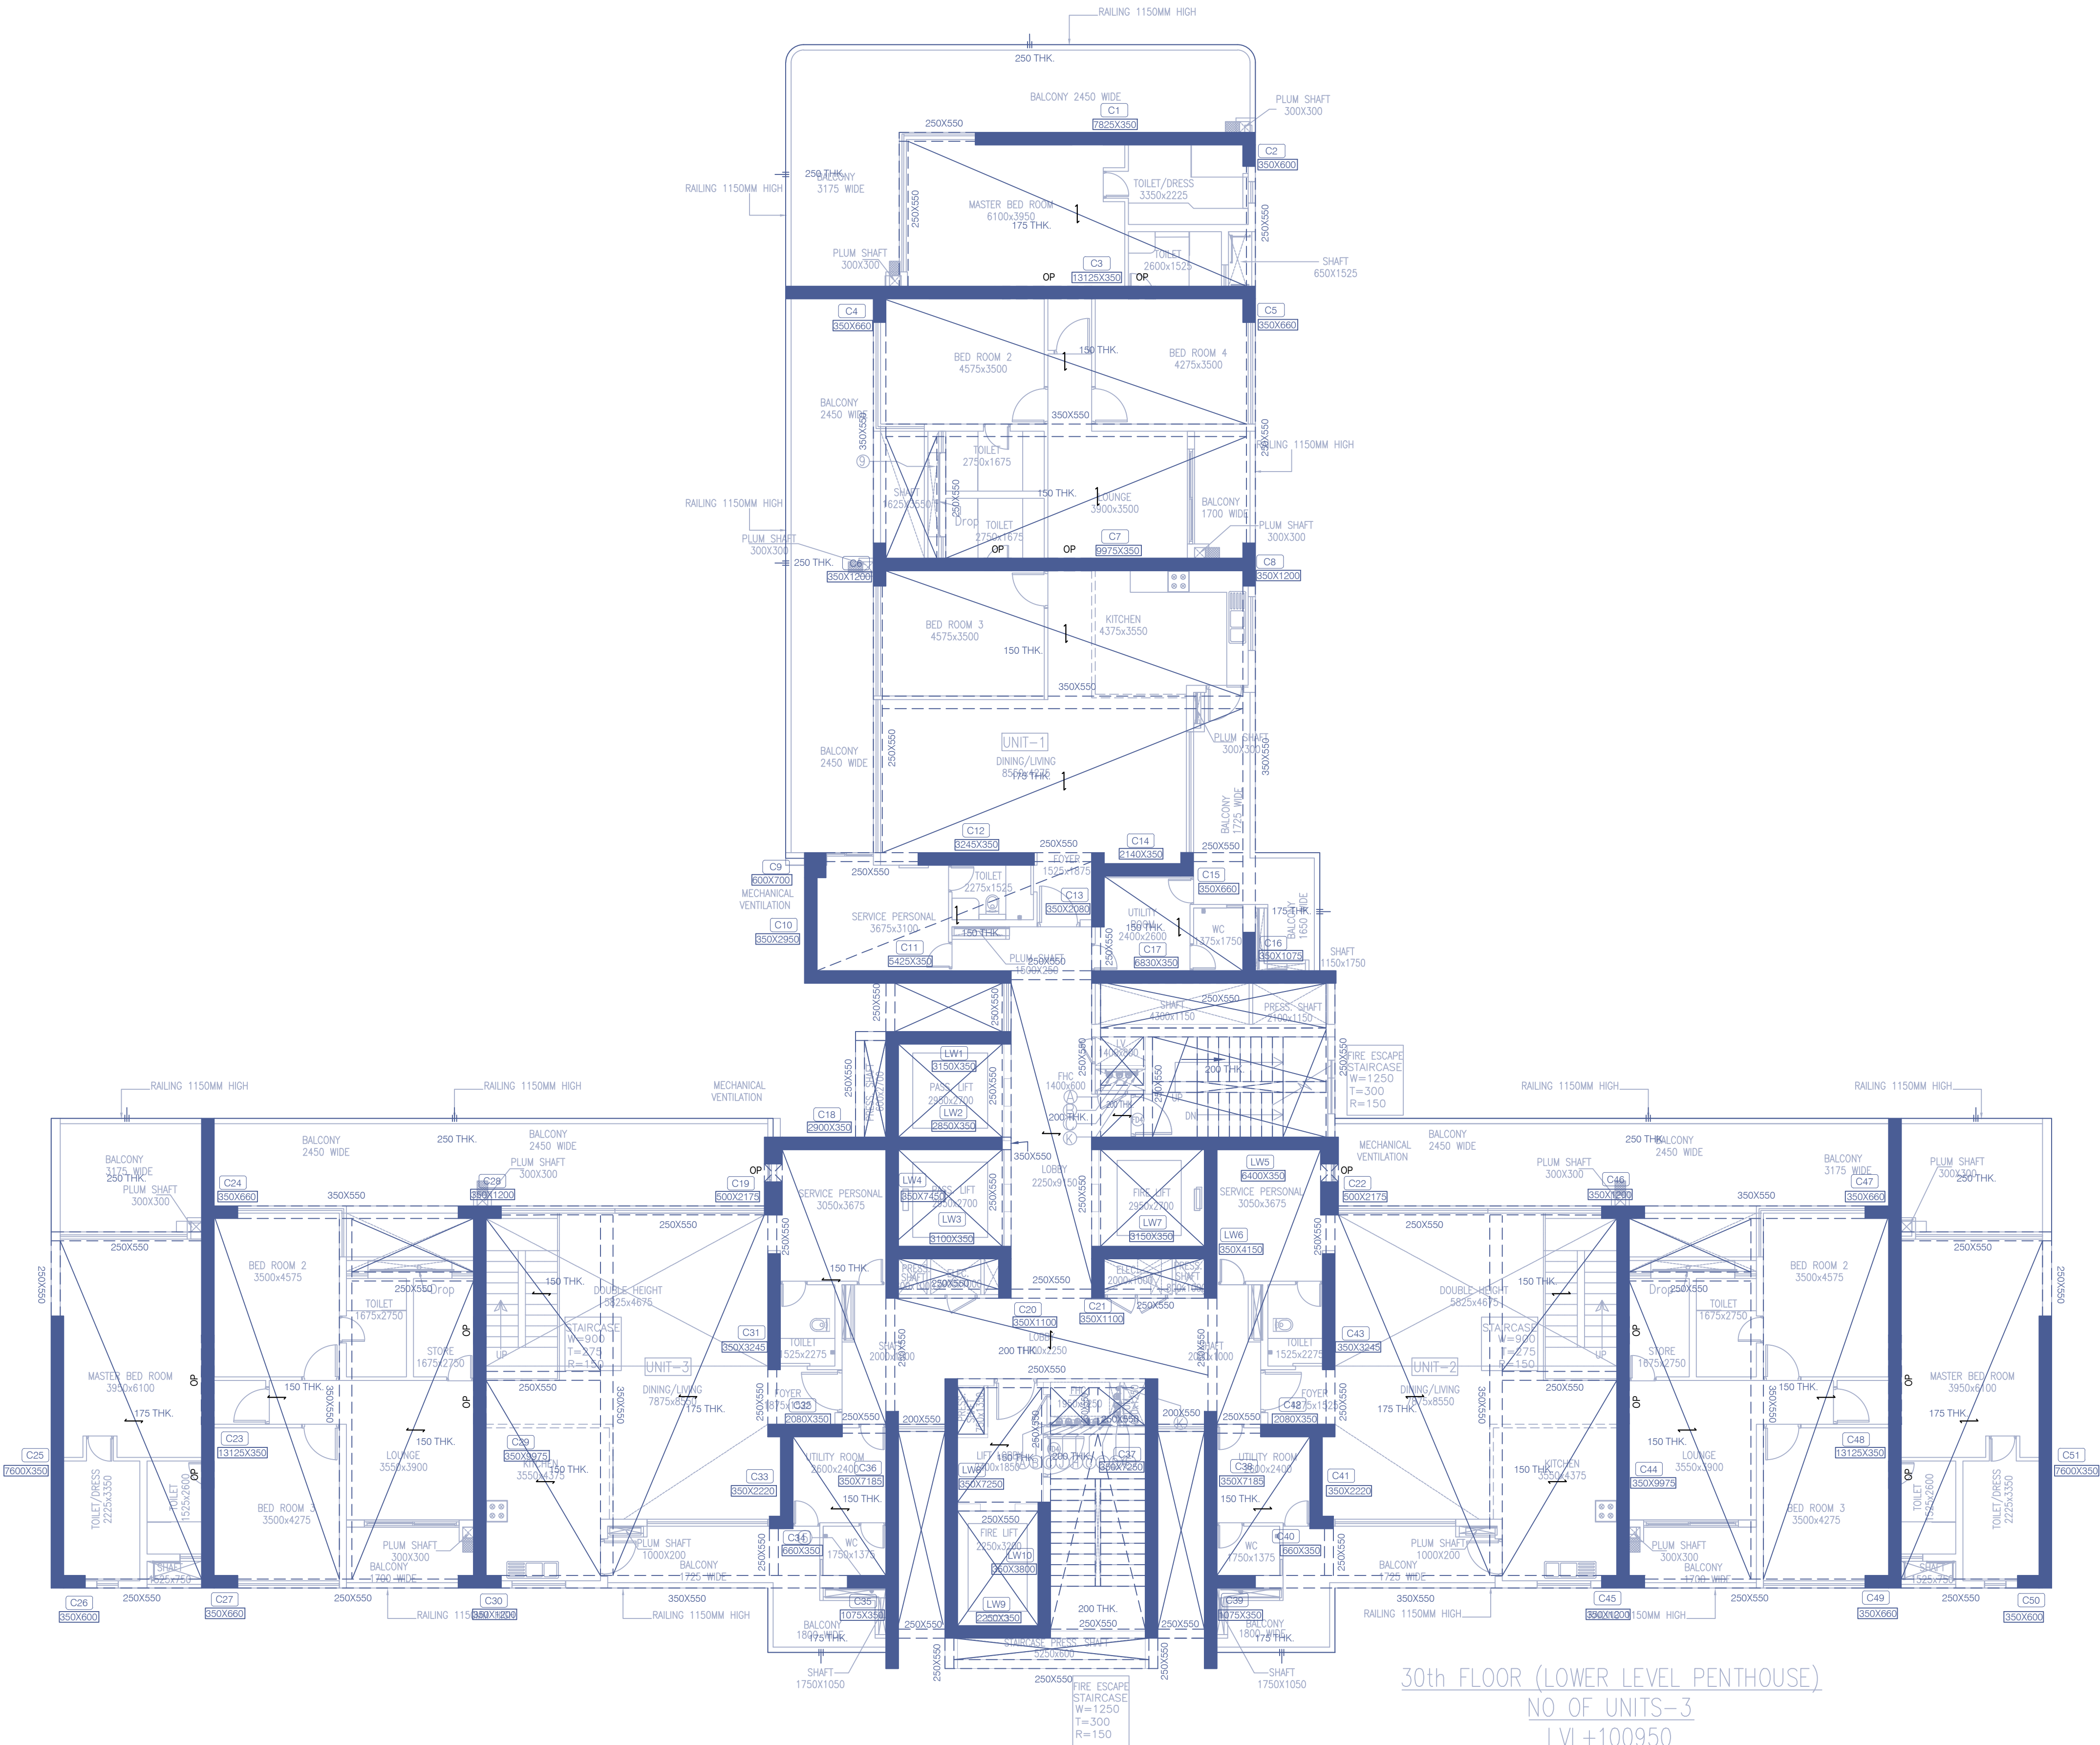

30TH FLOOR FRAMING PLAN
(LOWER LEVEL PENTHOUSE)

30th FLOOR (LOWER LEVEL PENTHOUSE)
NO OF UNITS-3
LVL+100950
TOWER- 14 (4BHK)

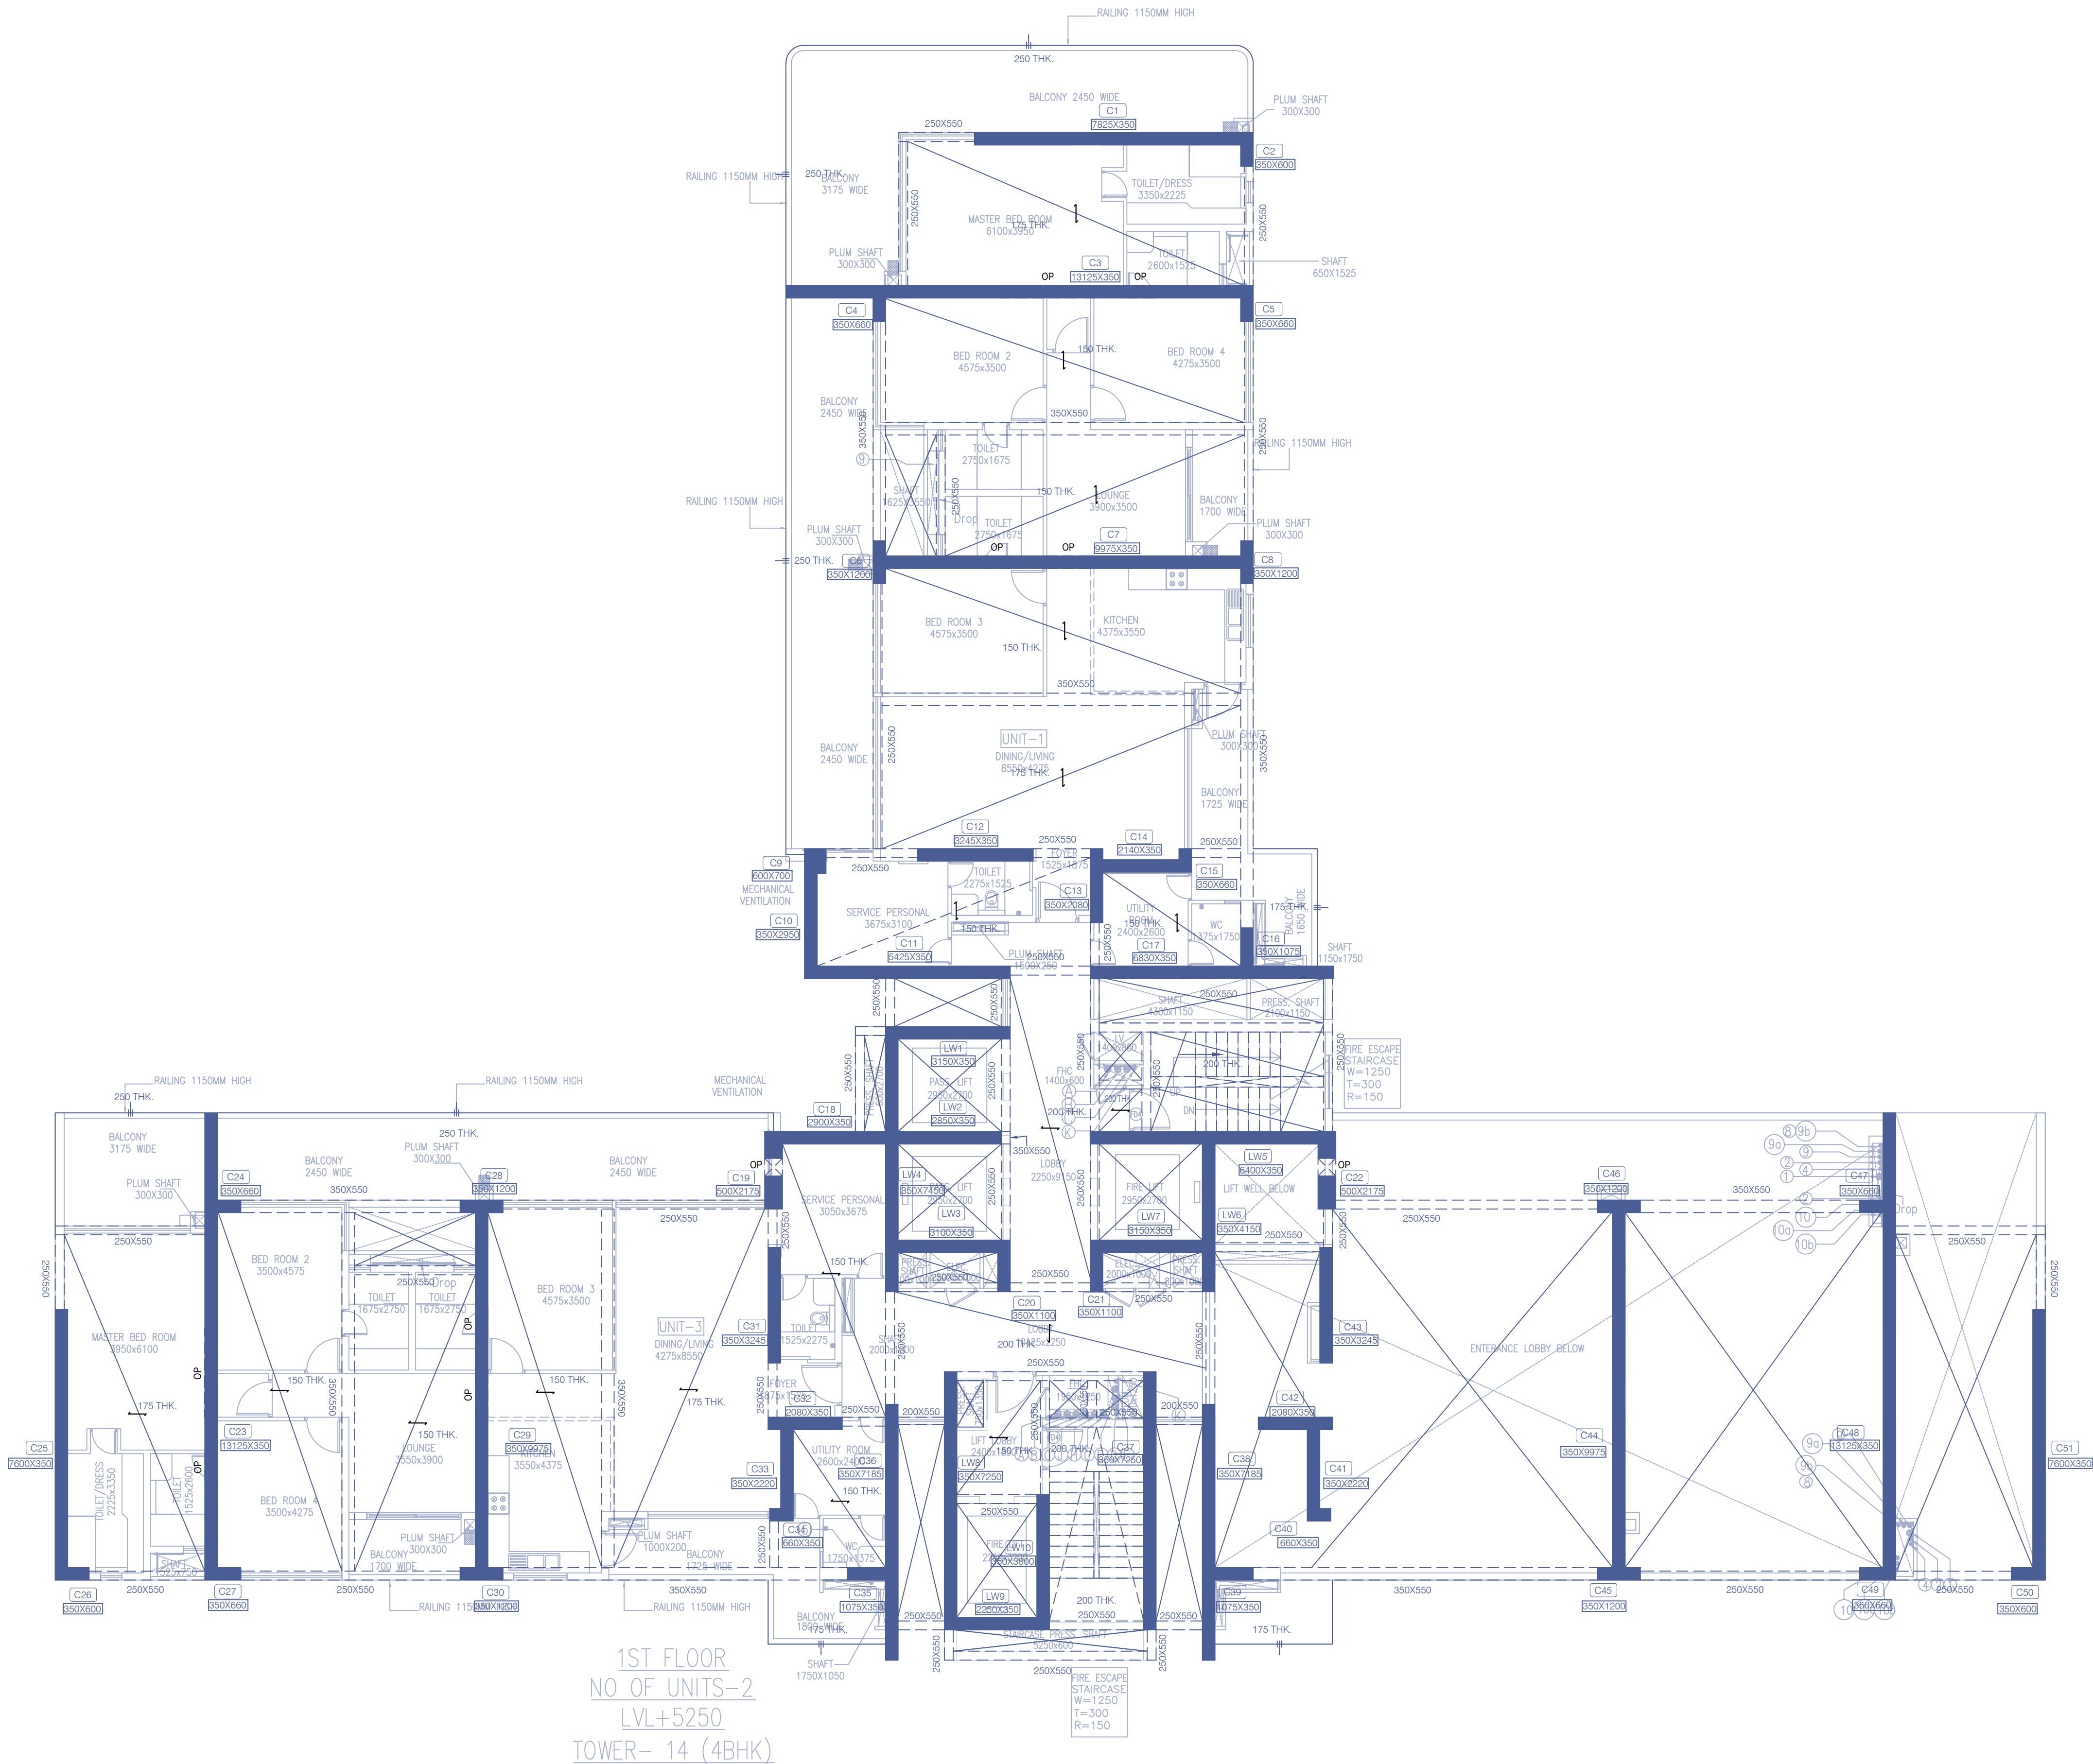

1ST FLOOR FRAMING PLAN

Note :-
1. BUILDING HAS AUTOMATIC SPRINKLER SYSTEM WHEREVER REQUIRED BY NBC.
2. BUILDING WILL BE DESIGNED (STRUCTURES) AS PER RELEVANT CODES FOR EARTH QUAKE RESISTANCE.

PROJECT:

PROPOSED BUILDING PLAN OF GROUP HOUSING COLONY MEASURING 24.10 ACRES (LICENCE NO 80 OF 2012 DATED 17/08/2012) IN SECTOR 106, GURUGRAM MANESAR URBAN COMPLEX BEING DEVELOPED BY AIRMD DEVELOPERS LTD. & OTHERS.


OWNER'S SEAL & SIGNATURE

ARCHITECT'S SEAL & SIGNATURE

STRUCTURE ENGG. SEAL & SIGNATURE

Puneet Kumar
B.E./CIVIL/M.E. (Structure)
MEMB No. A-533803-S

30.AUG.-2022. Scale : 1:100
Drawing Title:- TOWER - 14
1ST FLOOR FRAMING PLAN
Drawing No:- STA-01.3

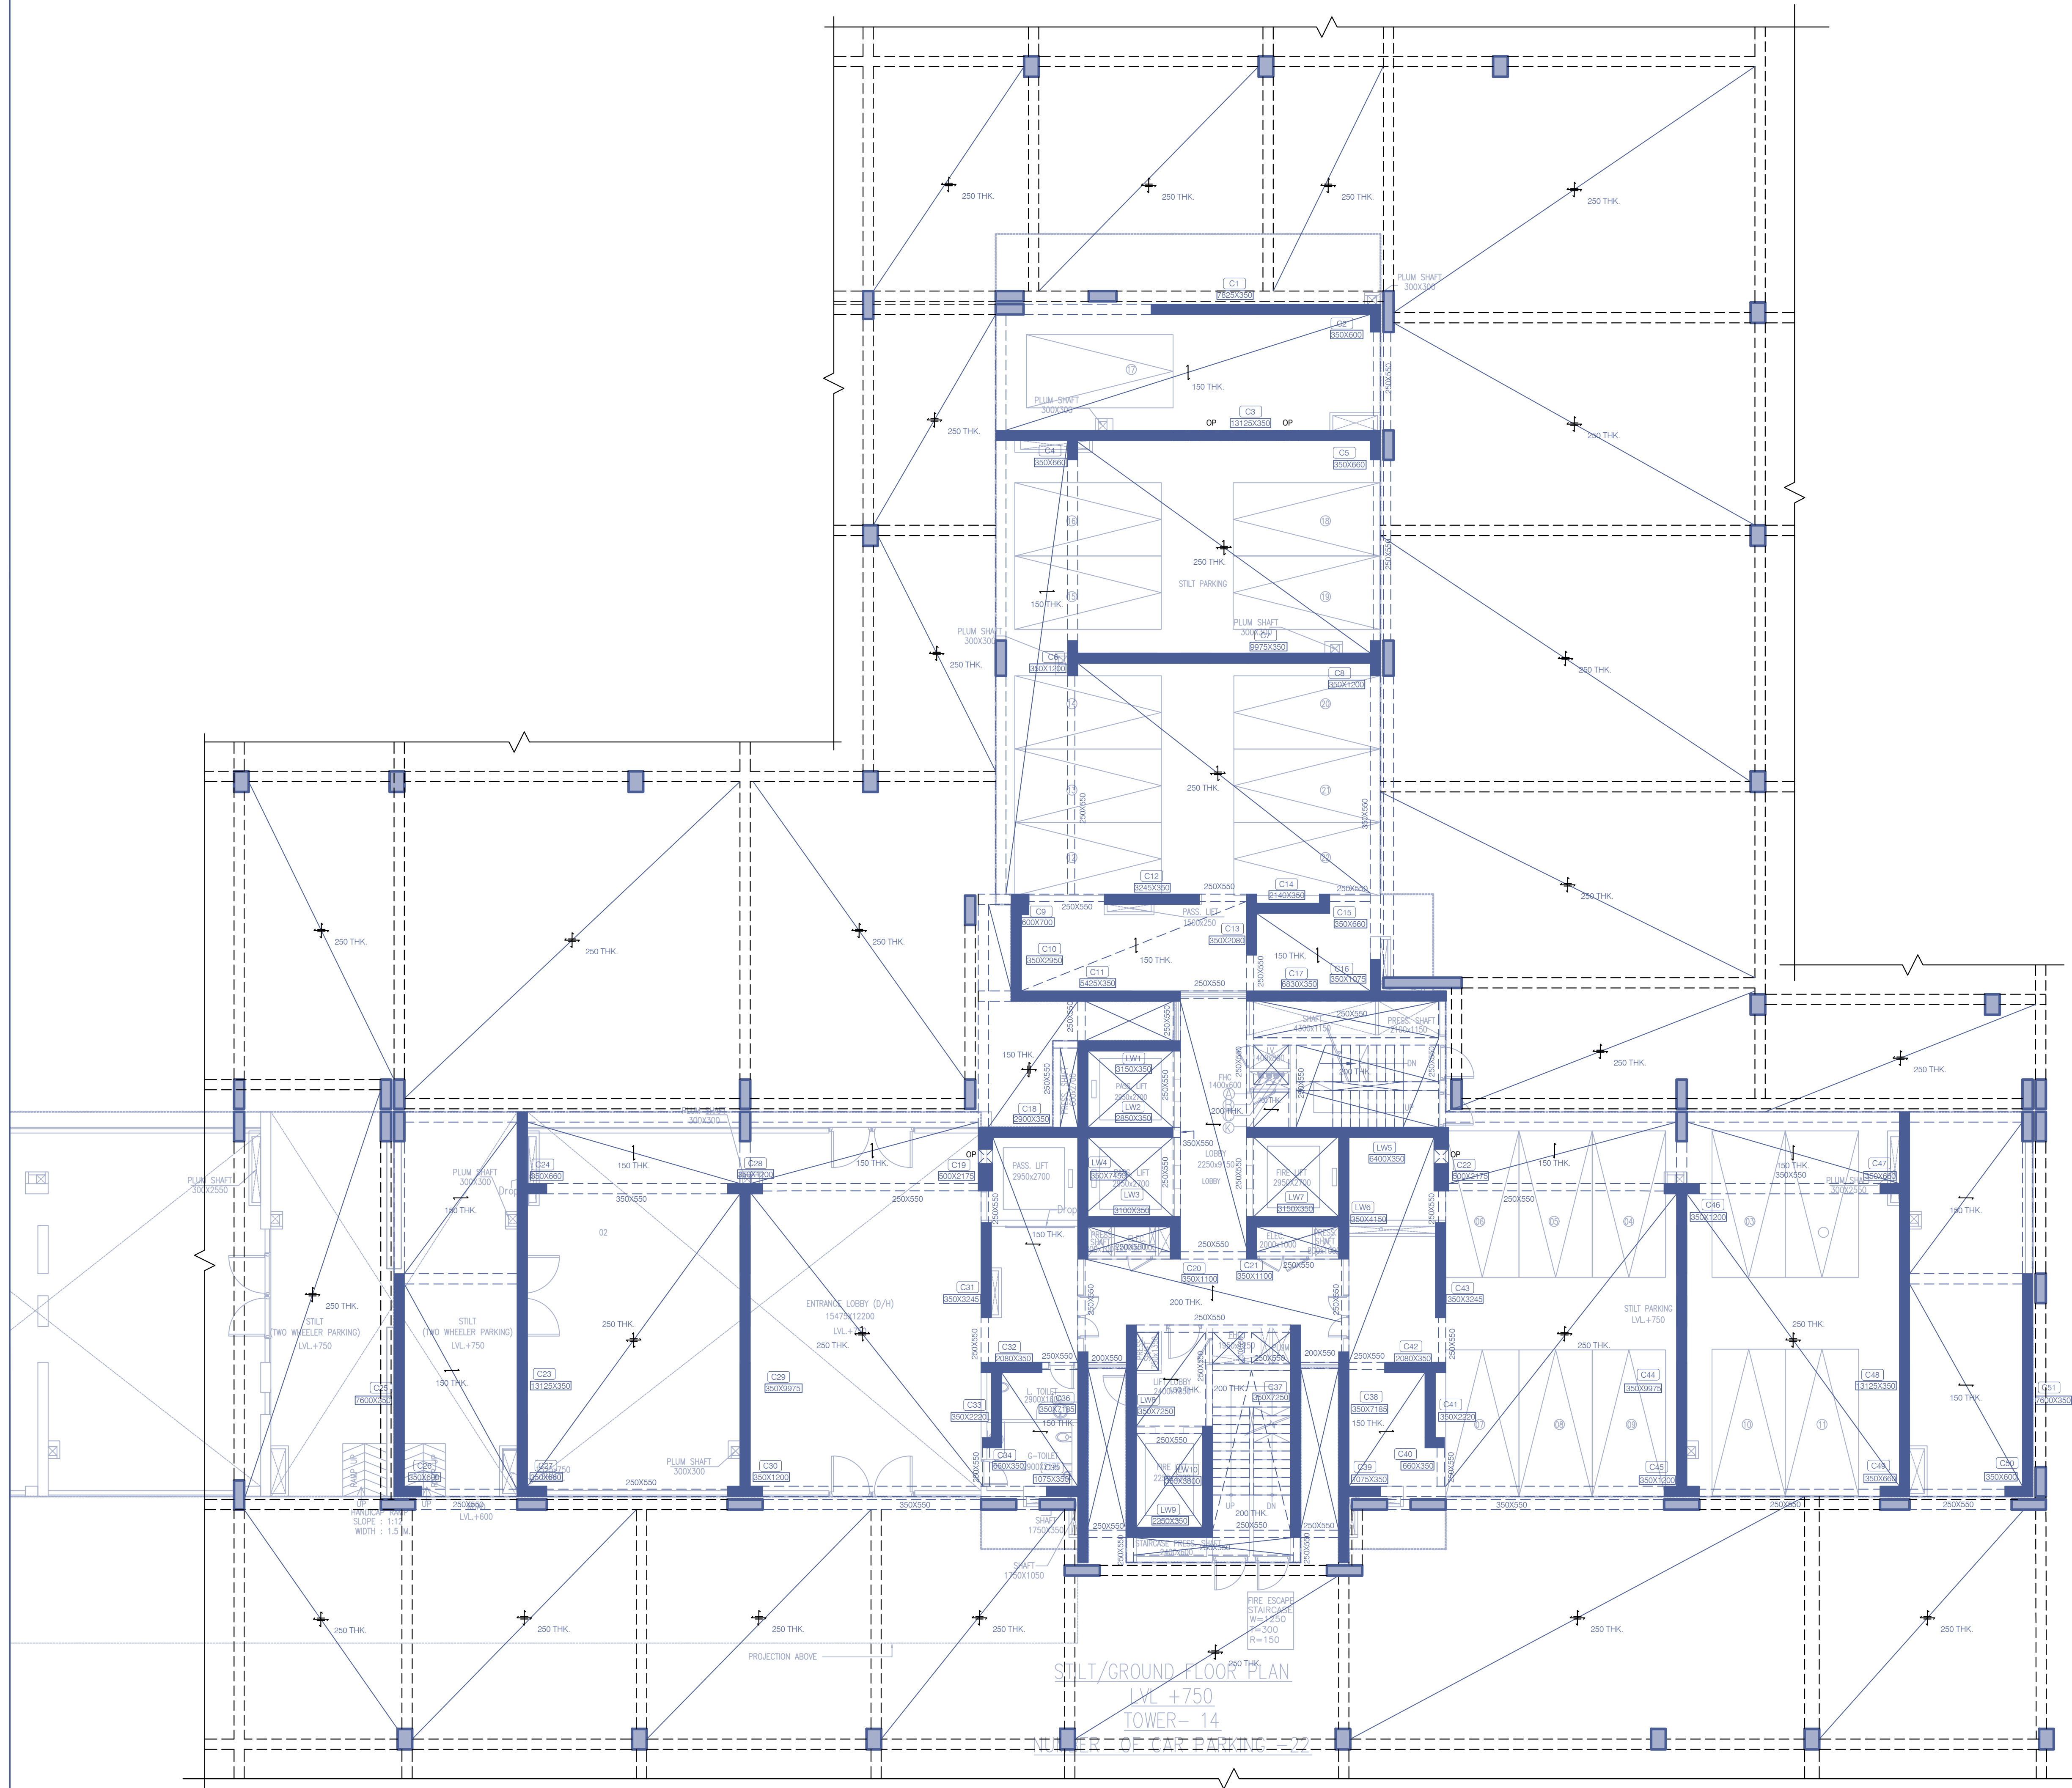

GROUND FLOOR FRAMING PLAN

Note :-

1. BUILDING HAS AUTOMATIC SPRINKLER SYSTEM WHEREVER REQUIRED BY NBC.

2. BUILDING WILL BE DESIGNED (STRUCTURES) AS PER RELEVANT CODES FOR EARTH QUAKE RESISTANCE.

PROJECT:

PROPOSED BUILDING PLAN OF GROUP HOUSING COLONY MEASURING 24.10 ACRES (LICENCE NO 80 OF 2012 DATED 17/08/2012) IN SECTOR 106, GURUGRAM MANESAR URBAN COMPLEX BEING DEVELOPED BY AIRMD DEVELOPERS LTD. & OTHERS.

OWNER'S SEAL & SIGNATURE

ARCHITECT'S SEAL & SIGNATURE

STRUCTURE ENGG. SEAL & SIGNATURE



Puneet Kumar
B.E./CIVIL M.E. (Structure)
MEMB No. A-533803-5

30.AUG.-2022. Scale : 1:100
Drawing Title:- TOWER - 14
GROUND FLOOR FRAMING PLAN
Drawing No:- STA-01-2

Note :-


1. BUILDING HAS AUTOMATIC SPRINKLER SYSTEM WHEREVER REQUIRED BY NBC.

2. BUILDING WILL BE DESIGNED (STRUCTURES) AS PER RELEVANT IS CODES FOR EARTH QUAKE RESISTANCE.

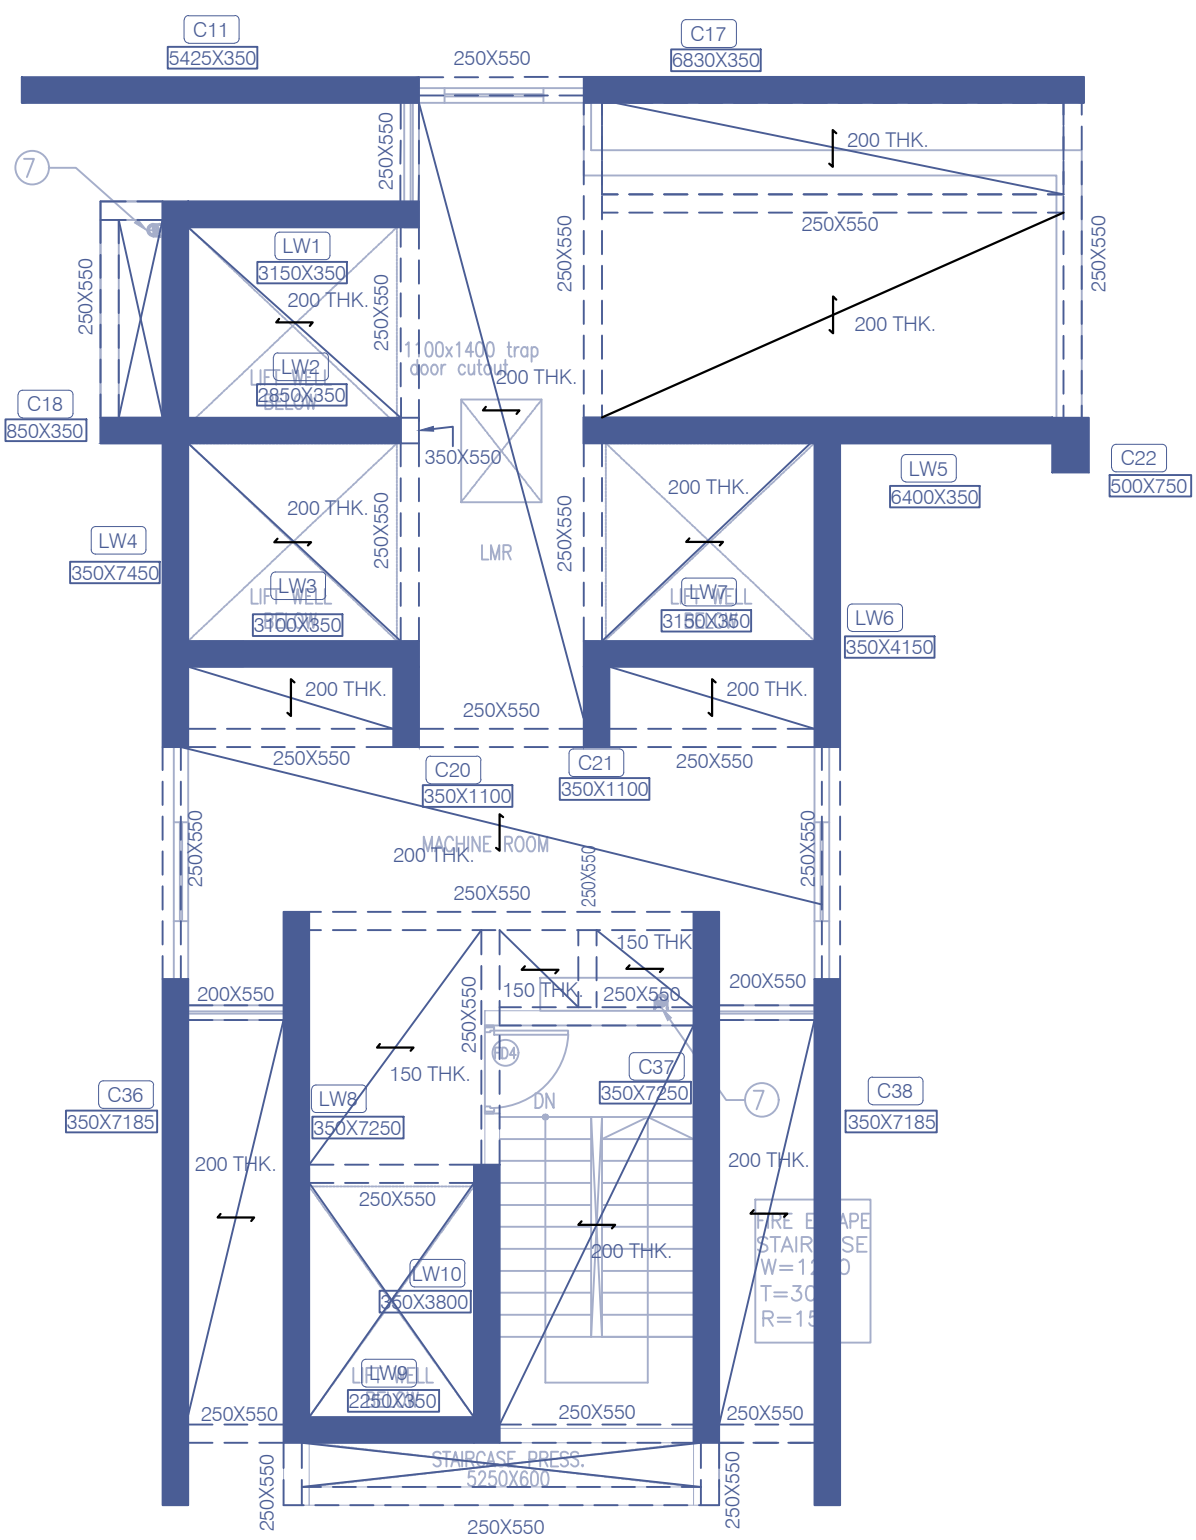

LMR FLOOR PLAN
LVL+113500
TOWER- 14 & 15

LMR & OHWT BOTTOM FRAMING PLAN

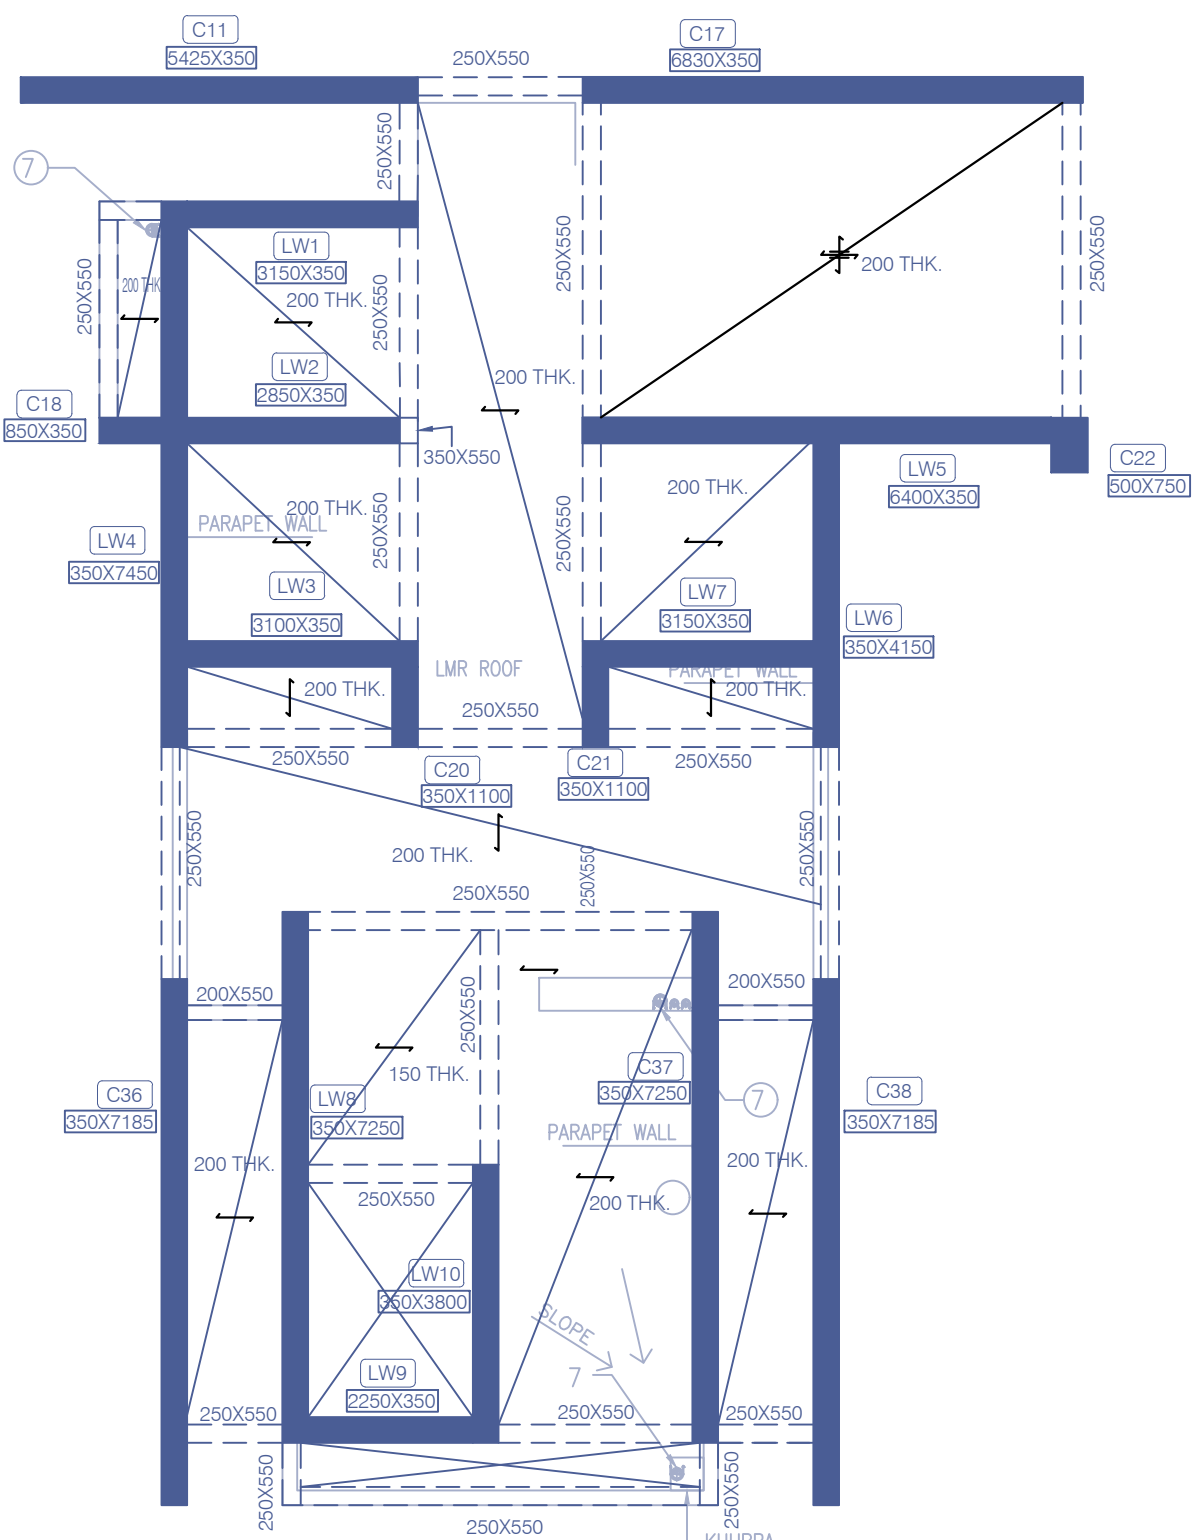

LMR ROOF PLAN
LVL+116800
TOWER- 14 & 15

LMR & OHWT TOP FRAMING PLAN

OWNER'S SEAL
& SIGNATURE

ARCHITECT'S SEAL
& SIGNATURE

STRUCTURE ENGG. SEAL
& SIGNATURE


Puneet Kumar
B.E.(CIVIL) M.E. (Structure)
MEMB No. A-533803-5

30.AUG.-2022. Scale : 1:100
Drawing Title:-
TOWER - 14
LMR & OHWT BOTTOM & TOP FRAMING PLAN
Drawing No:-
STA-01-10

Note :-

1. BUILDING HAS AUTOMATIC SPRINKLER SYSTEM WHEREVER REQUIRED BY NBC.
2. BUILDING WILL BE DESIGNED (STRUCTURES) AS PER RELEVANT CODES FOR EARTH QUAKE RESISTANCE.

PROJECT:

PROPOSED BUILDING PLAN OF GROUP HOUSING COLONY MEASURING 24.10 ACRES (LICENCE NO 80 OF 2012 DATED 17/08/2012) IN SECTOR 106, GURUGRAM MANESAR URBAN COMPLEX BEING DEVELOPED BY AIRMD DEVELOPERS LTD. & OTHERS.

OWNER'S SEAL & SIGNATURE

ARCHITECT'S SEAL & SIGNATURE

STRUCTURE ENGG. SEAL & SIGNATURE

Puneet Kumar
Puneet Kumar
B.E./CIVIL M.E. (Structure)
MEMB No. A-533803-5

30.AUG.-2022.

Scale : 1:100



Drawing Title:-


TOWER - 14

4BHK - FOUNDATION PILE LAYOUT

Drawing No:-


ST-A-01

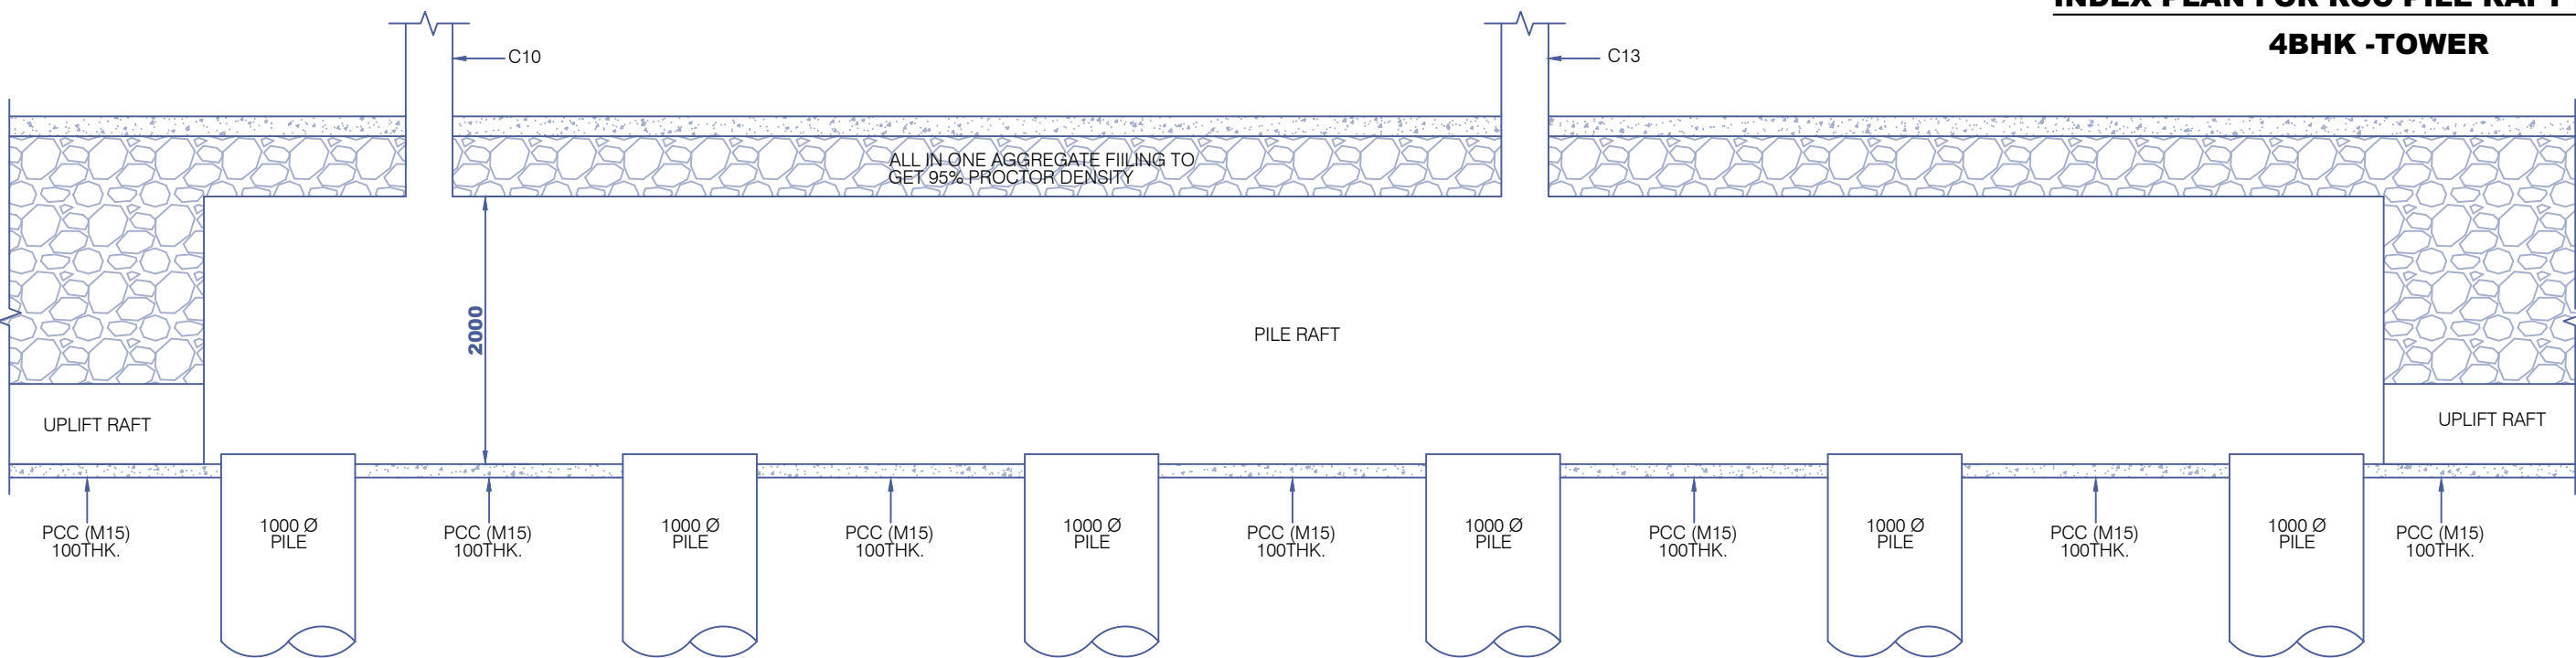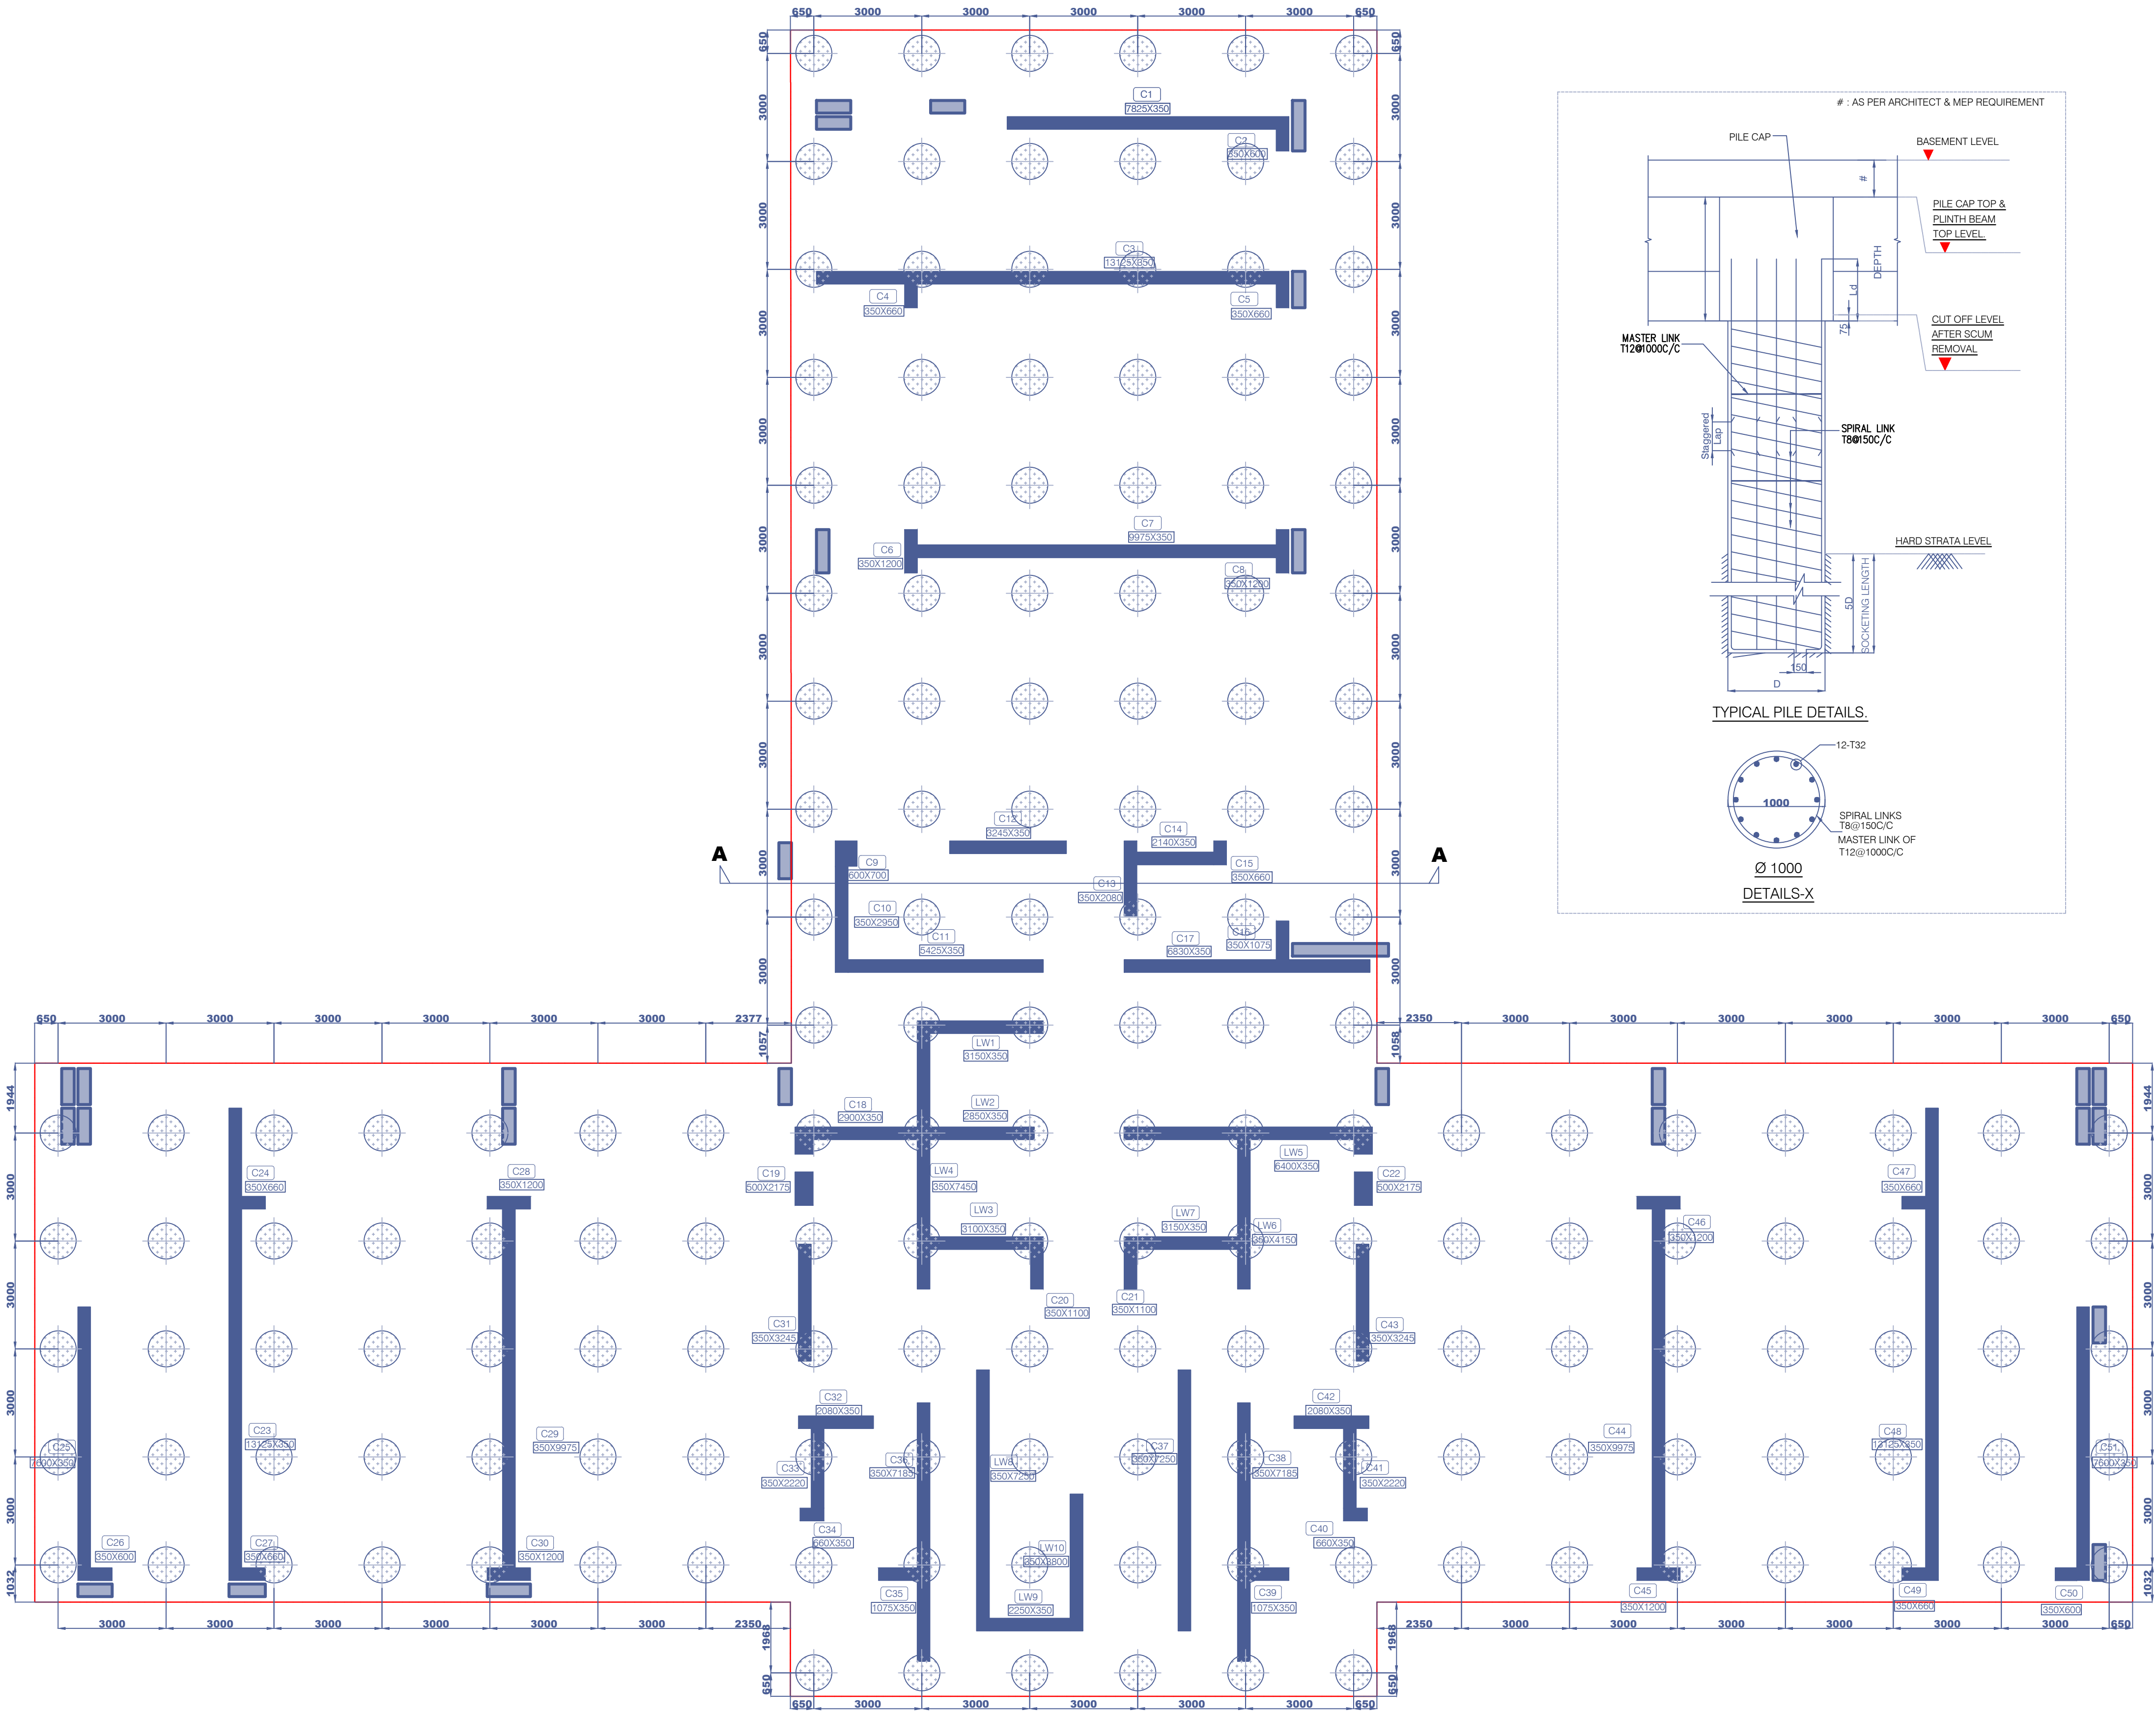

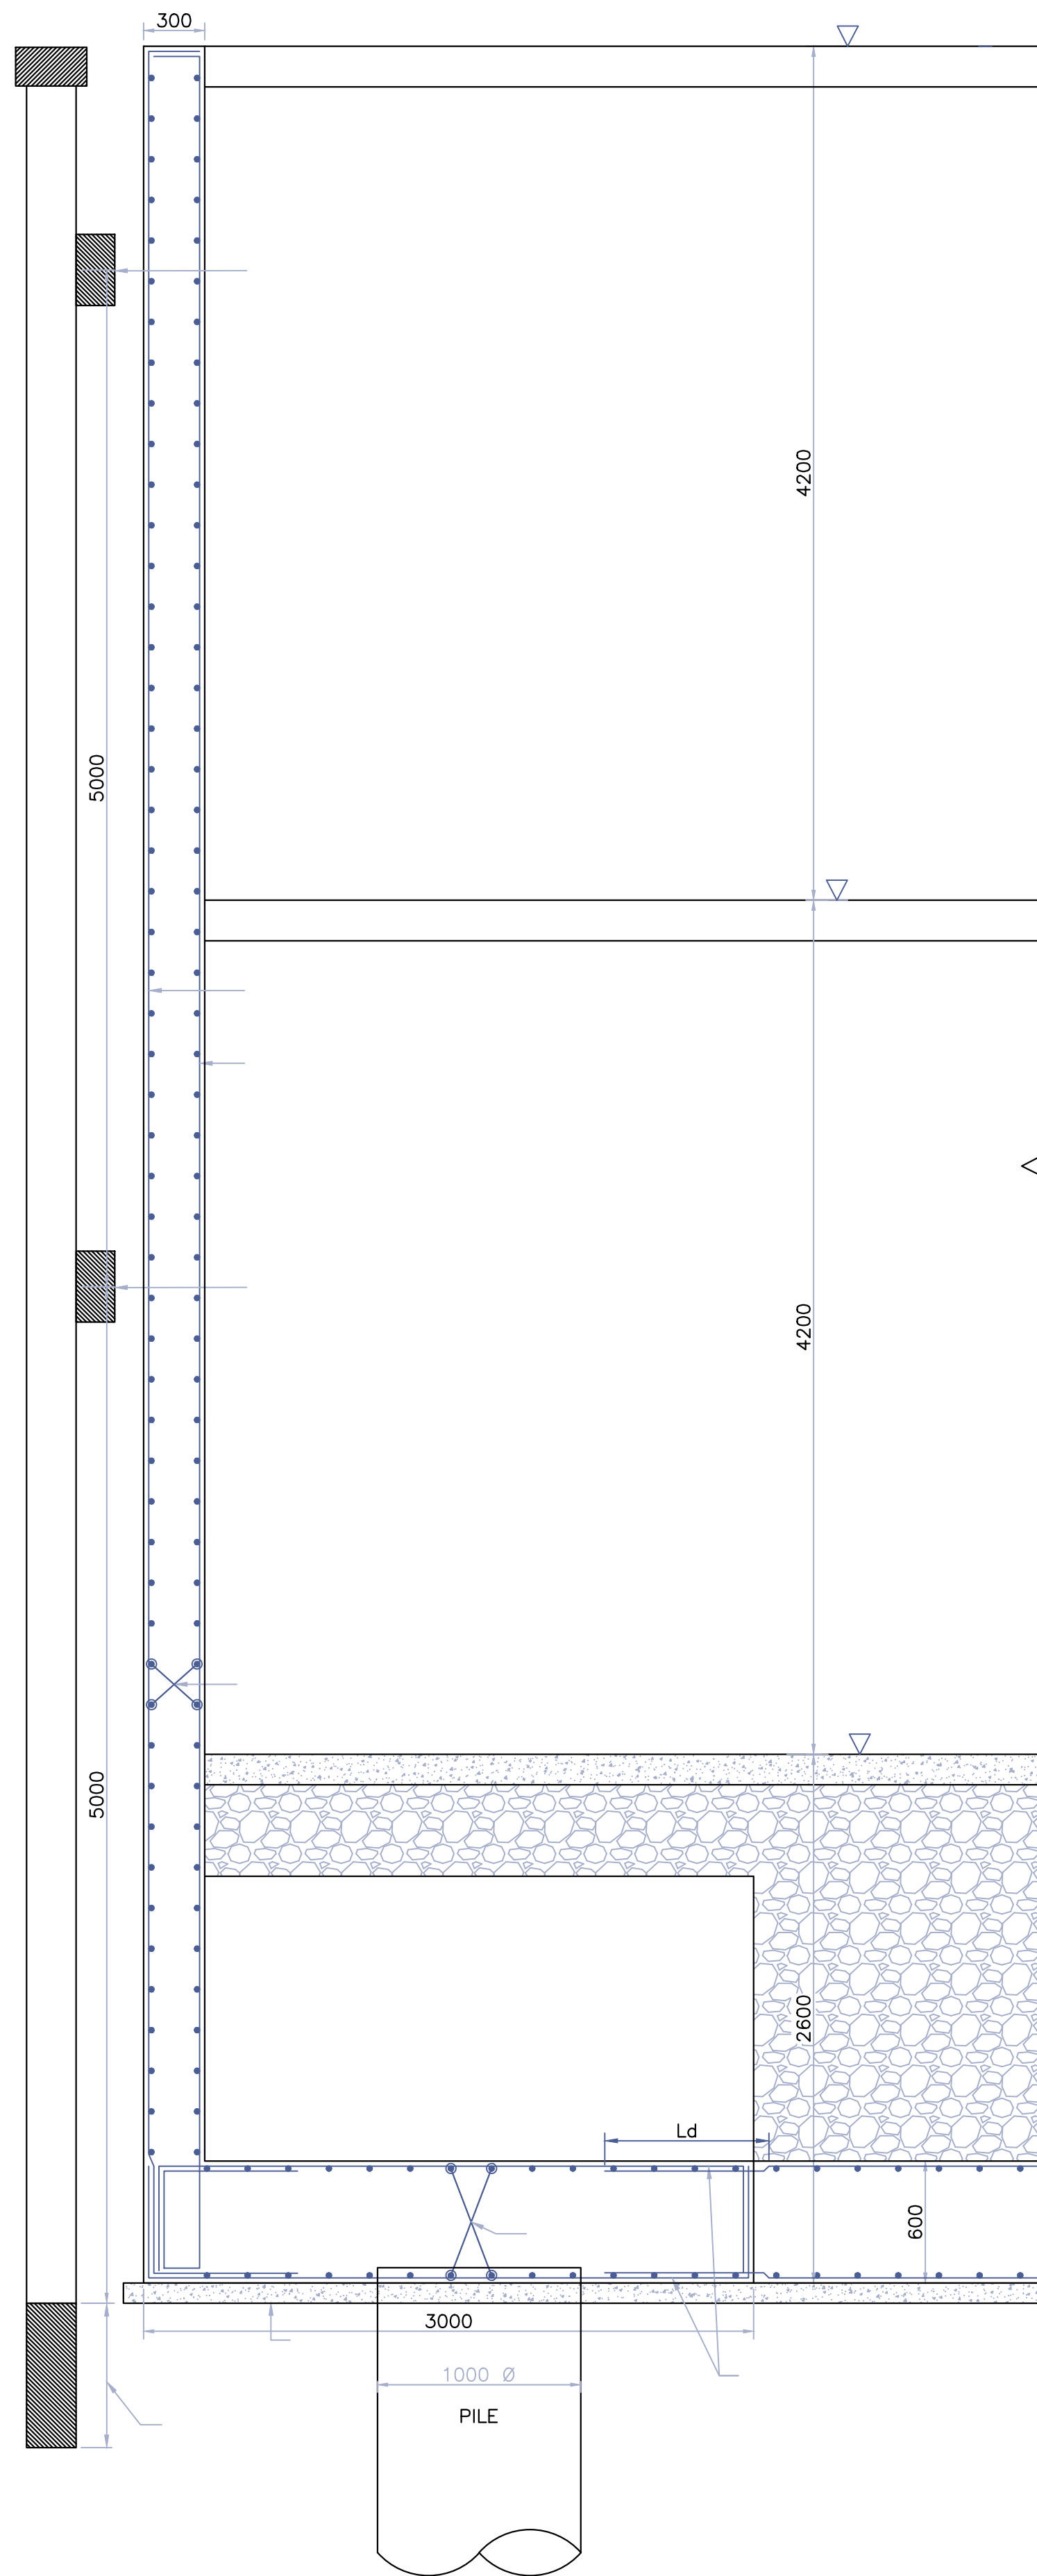

TYPICAL RETAINING WALL SECTION

Note :-		
1. BUILDING HAS AUTOMATIC SPRINKLER SYSTEM WHEREVER REQUIRED BY NBC.		
2. BUILDING WILL BE DESIGNED (STRUCTURES) AS PER RELEVANT IS CODES FOR EARTH QUAKE RESISTANCE.		
PROJECT:		
PROPOSED BUILDING PLAN OF GROUP HOUSING COLONY MEASURING 24.10 ACRES (LICENCE NO 80 OF 2012 DATED 17/08/2012) IN SECTOR 106, GURUGRAM MANESAR URBAN COMPLEX BEING DEVELOPED BY AIRMD DEVELOPERS LTD. & OTHERS.		
OWNER'S SEAL & SIGNATURE		
ARCHITECT'S SEAL & SIGNATURE		
STRUCTURE ENGG. SEAL & SIGNATURE		
Puneet Kumar B.E./CIVIL M.E. (Structure) MEMB No. A-533803-5		
30.AUG.-2022.	Scale : 1:100	
Drawing Title:- TOWER - 14 RETAINING WALL SECTION DETAILS		Drawing No:- STA-01

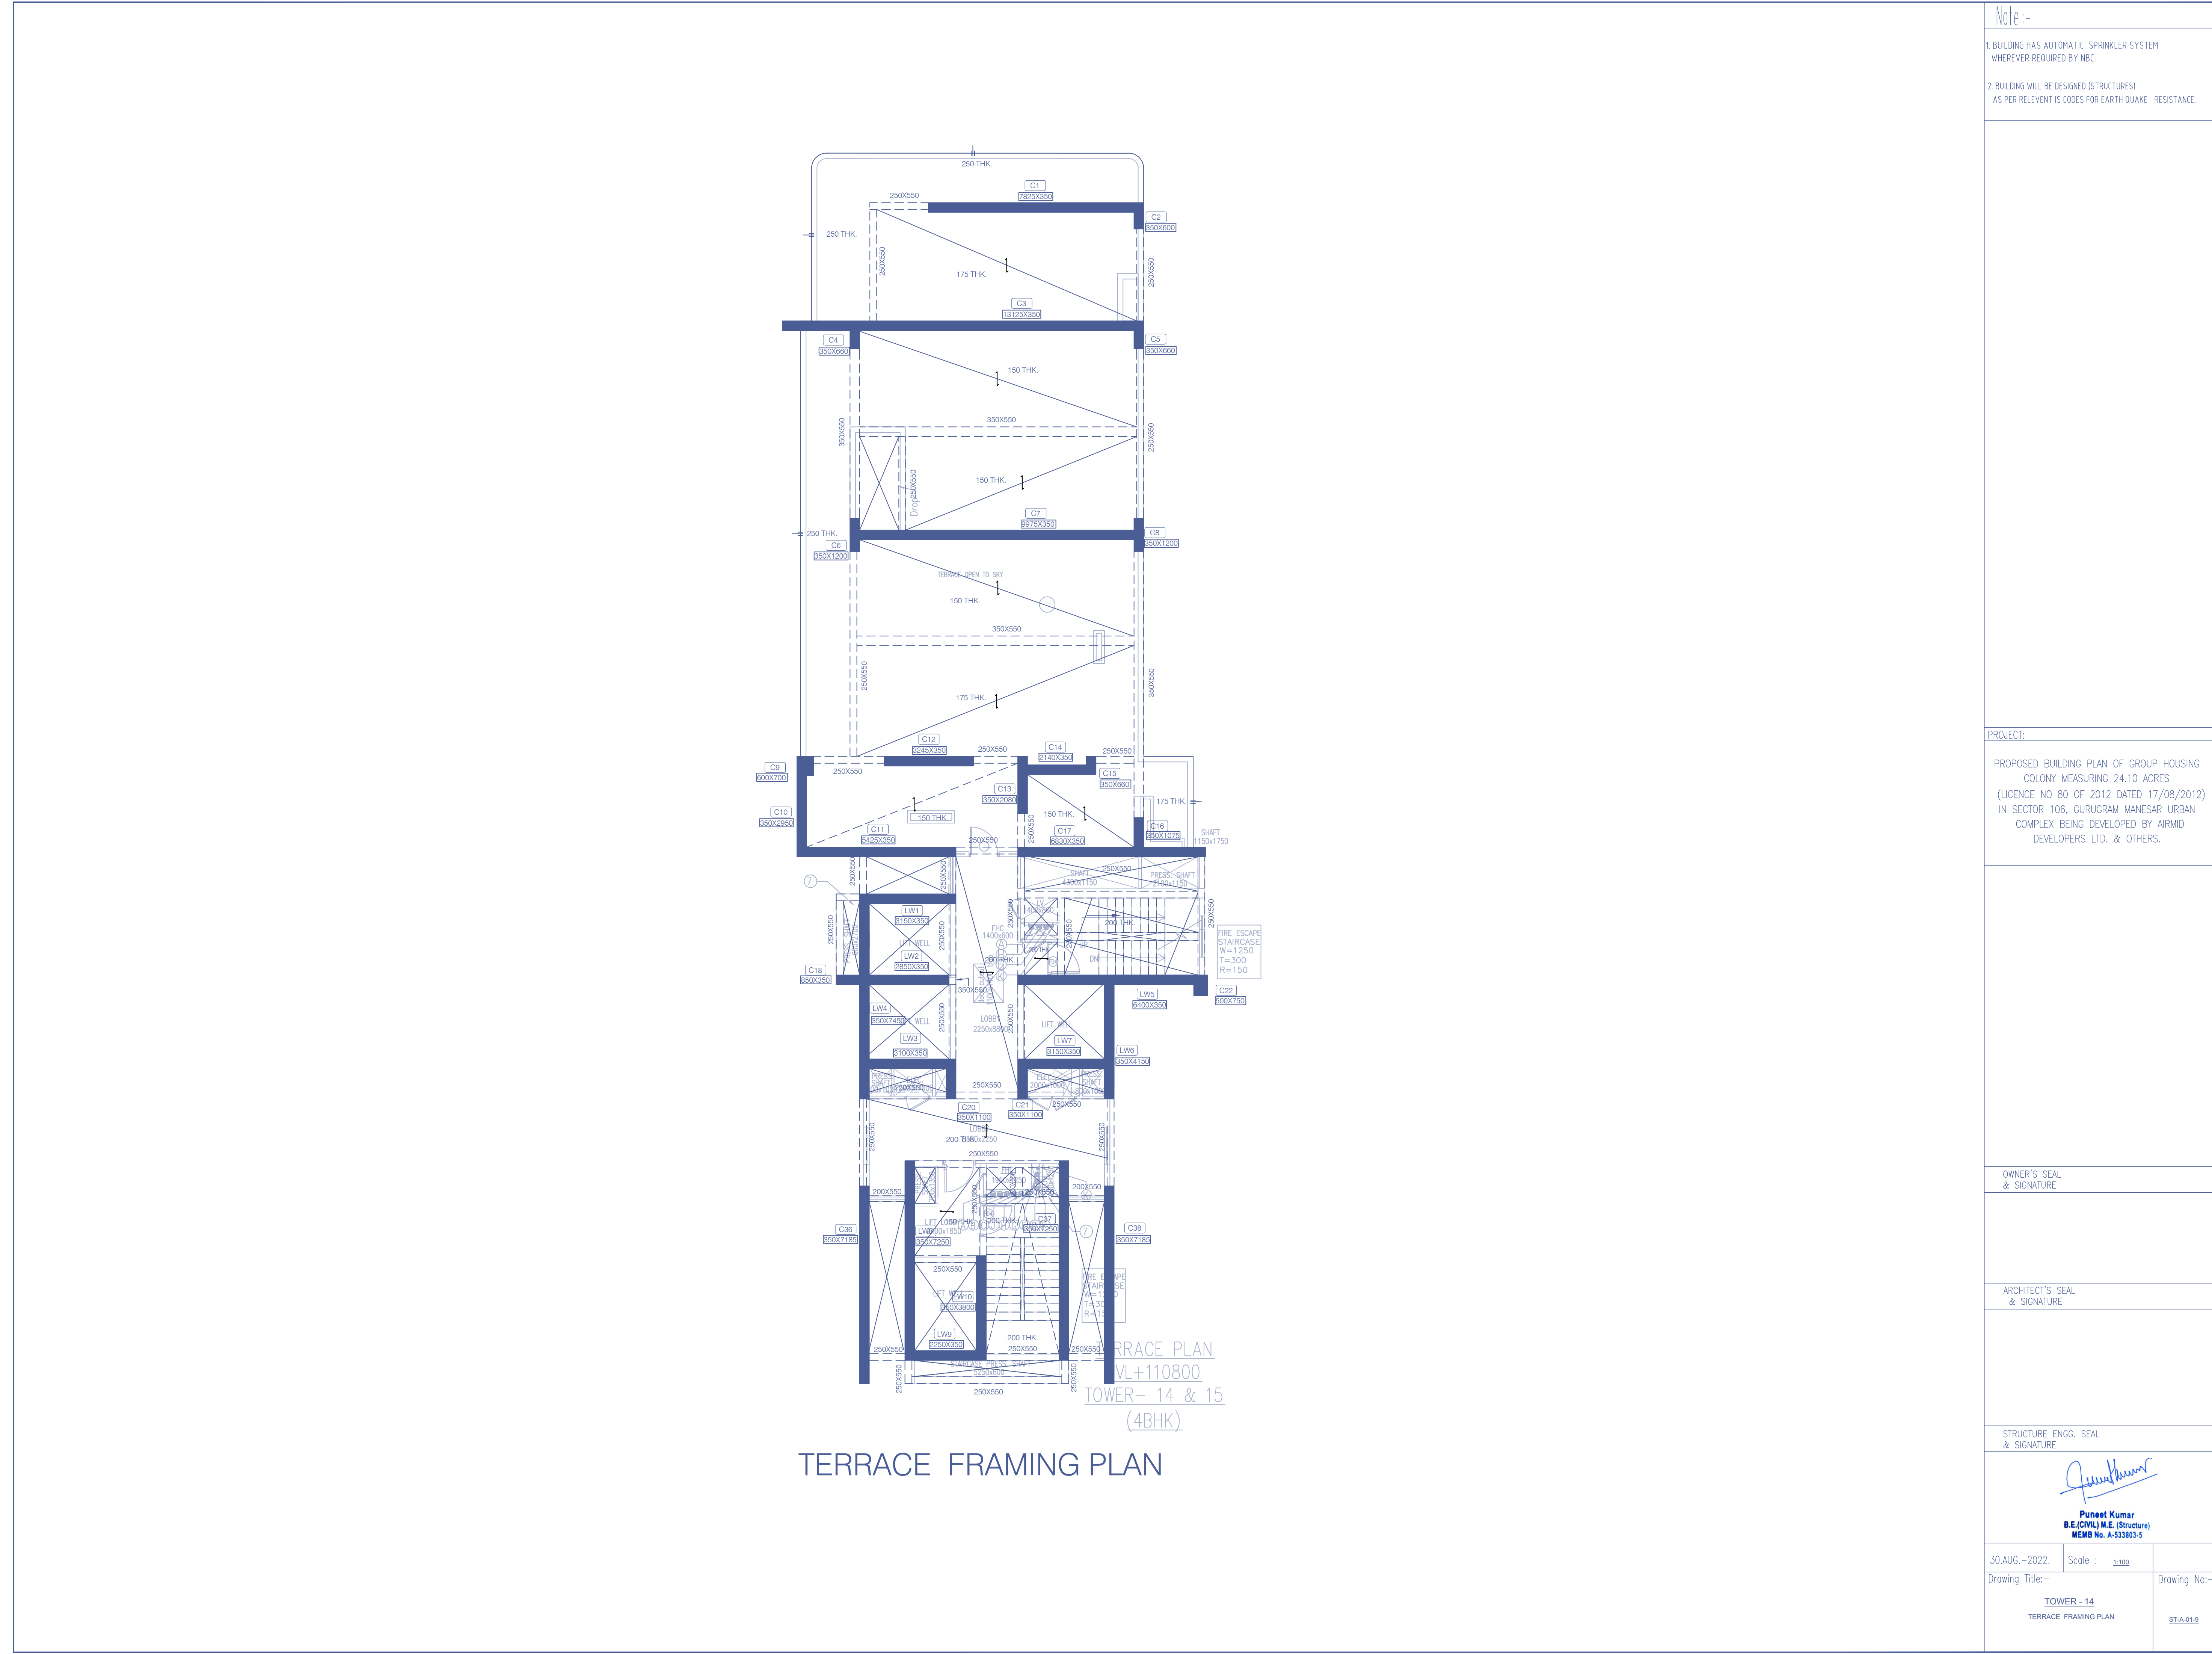

TERRACE FRAMING PLAN

Note :-
1. BUILDING HAS AUTOMATIC SPRINKLER SYSTEM WHEREVER REQUIRED BY NBC.
2. BUILDING WILL BE DESIGNED (STRUCTURES) AS PER RELEVANT CODES FOR EARTHQUAKE RESISTANCE.

PROJECT:

PROPOSED BUILDING PLAN OF GROUP HOUSING COLONY MEASURING 24.10 ACRES (LICENCE NO 80 OF 2012 DATED 17/08/2012) IN SECTOR 106, GURUGRAM MANESAR URBAN COMPLEX BEING DEVELOPED BY AIRMD DEVELOPERS LTD. & OTHERS.

OWNER'S SEAL & SIGNATURE

ARCHITECT'S SEAL & SIGNATURE


STRUCTURE ENGG. SEAL & SIGNATURE


Puneet Kumar
B.E.(CIVIL) M.E. (Structure)
MEMB No. A-533803-5

30.AUG.-2022.
Drawing Title:-
TOWER - 14
TERRACE FRAMING PLAN

Scale : 1:100

Drawing No:-
STA-01-9

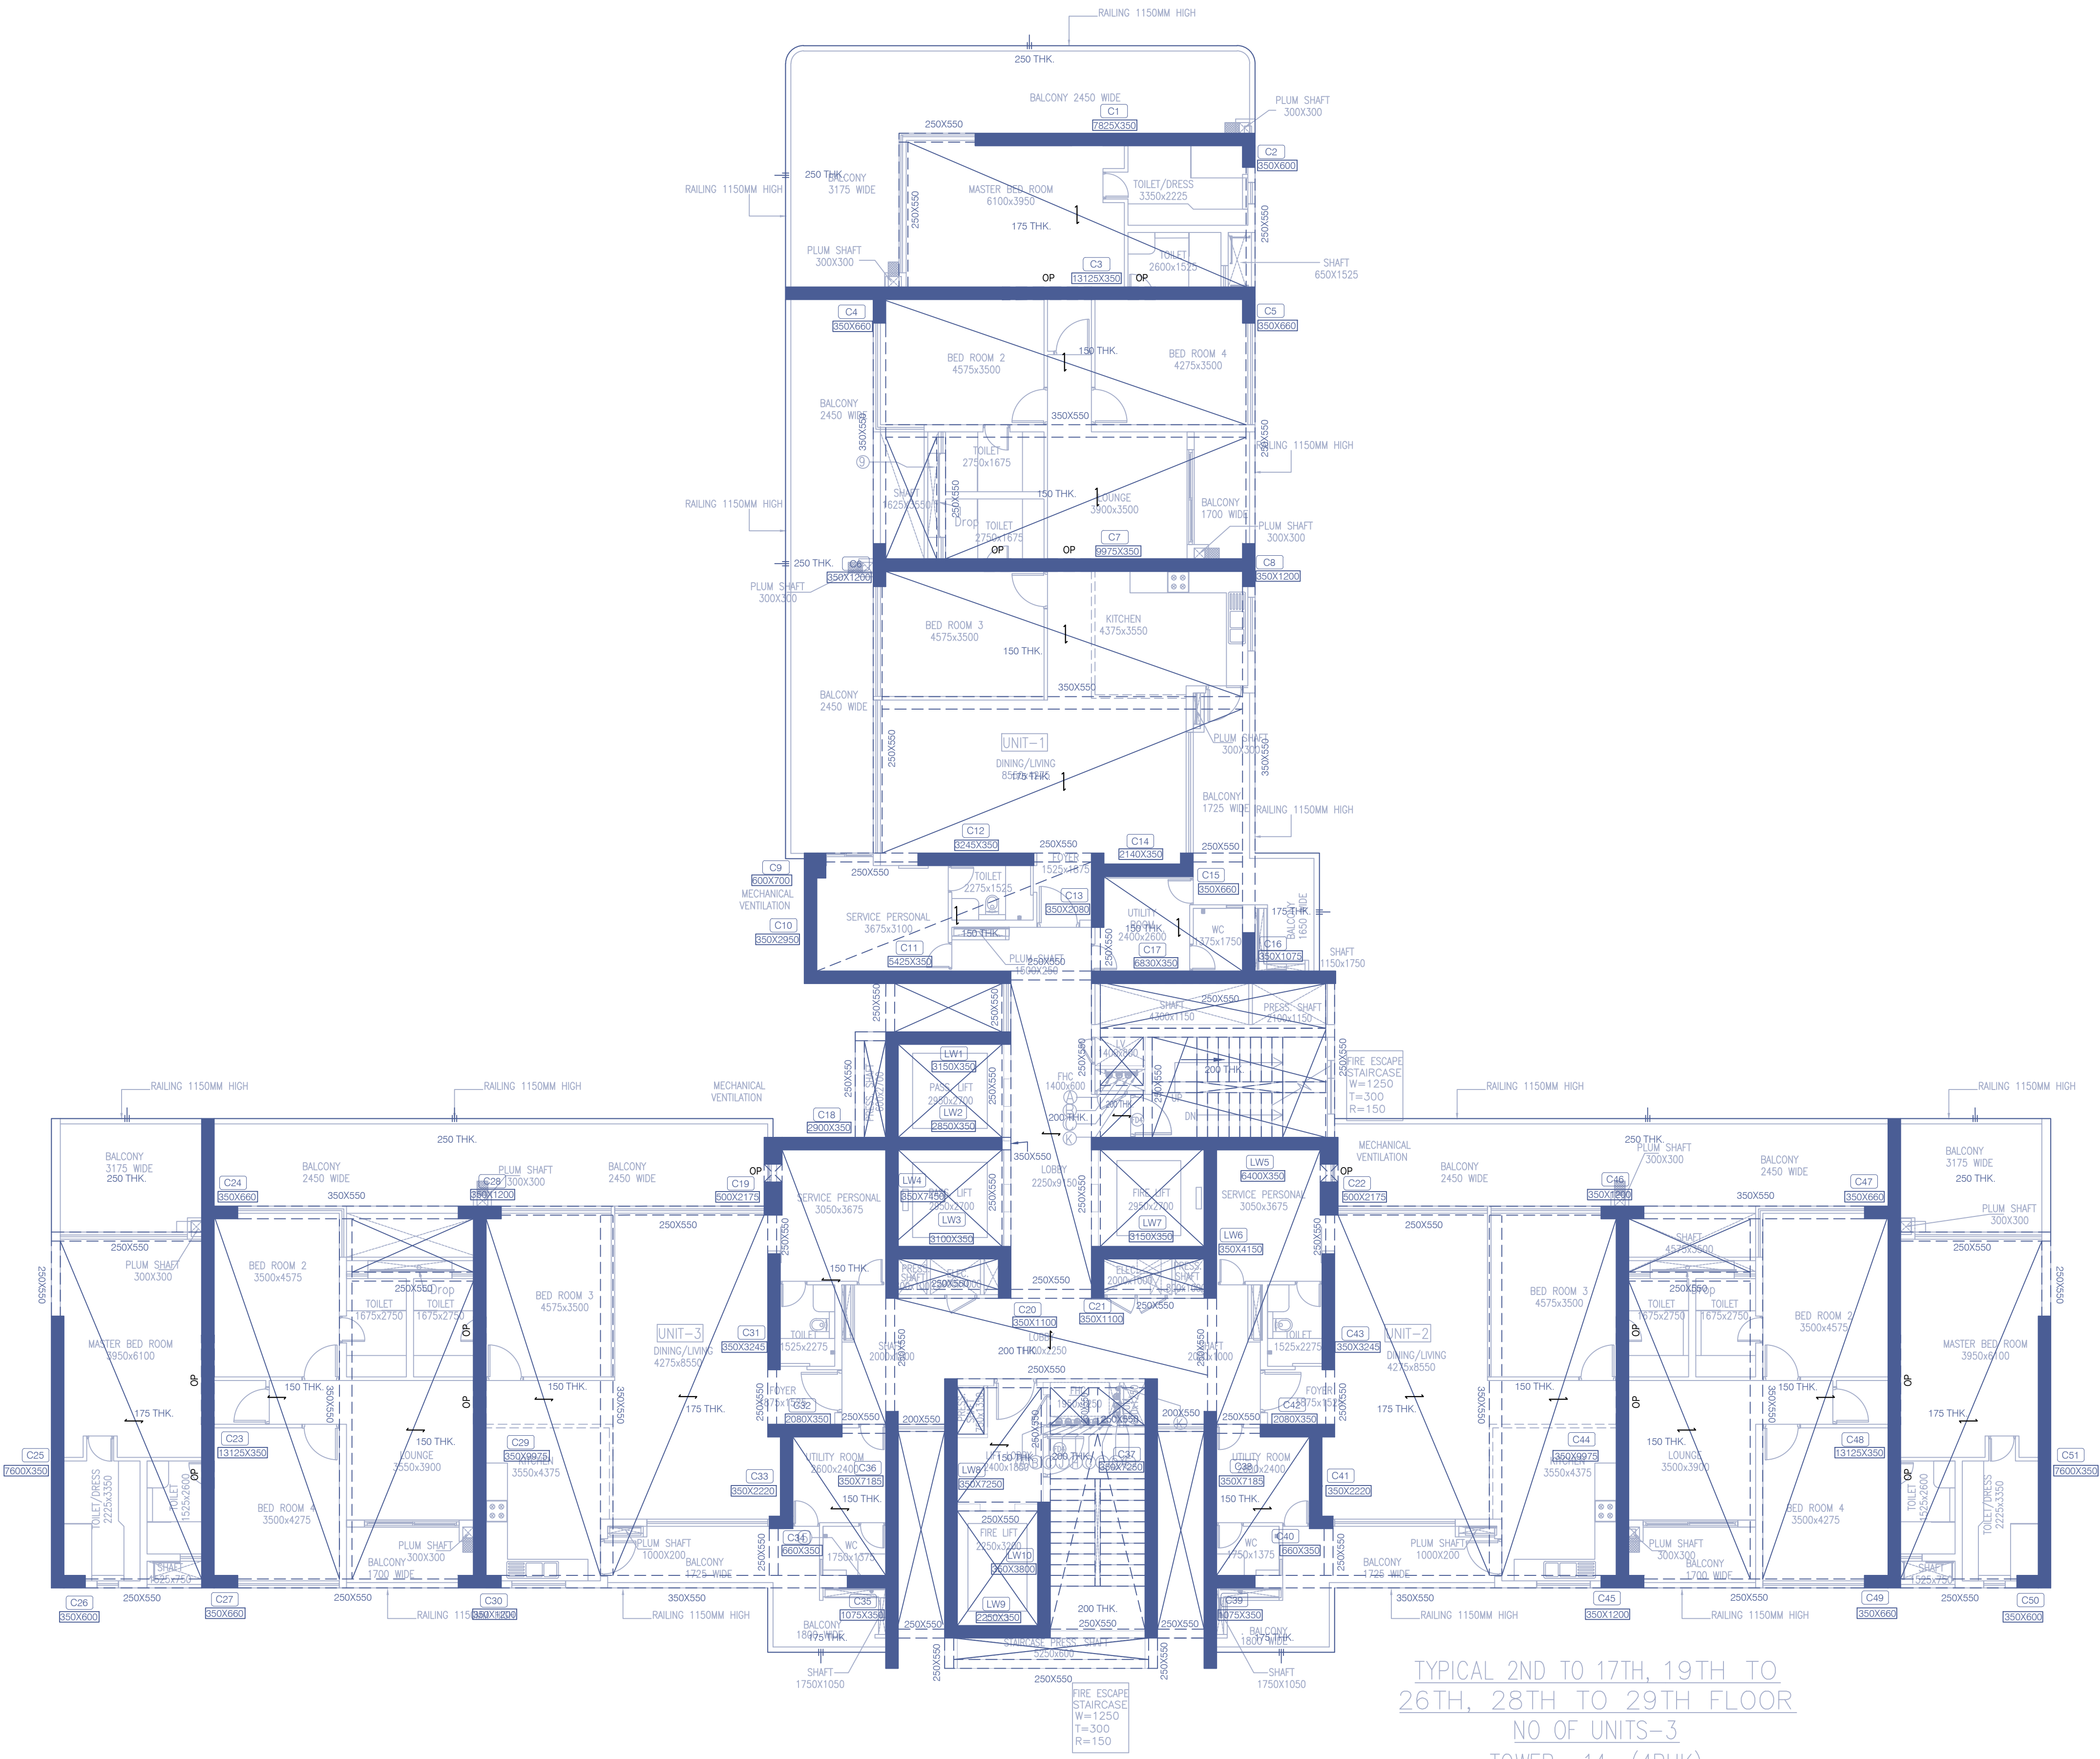

TYPICAL FLOOR FRAMING PLAN

Note :-

1. BUILDING HAS AUTOMATIC SPRINKLER SYSTEM WHEREVER REQUIRED BY NBC.
2. BUILDING WILL BE DESIGNED (STRUCTURES) AS PER RELEVANT IS CODES FOR EARTH QUAKE RESISTANCE.

PROJECT:

PROPOSED BUILDING PLAN OF GROUP HOUSING COLONY MEASURING 24.10 ACRES (LICENCE NO 80 OF 2012 DATED 17/08/2012) IN SECTOR 106, GURUGRAM MANESAR URBAN COMPLEX BEING DEVELOPED BY AIRMD DEVELOPERS LTD. & OTHERS.

OWNER'S SEAL & SIGNATURE

ARCHITECT'S SEAL & SIGNATURE

STRUCTURE ENGG. SEAL & SIGNATURE


Puneet Kumar
B.E.(CIVIL) M.E. (Structure)
MEMB No. A-533803-S

30.AUG.-2022. Scale : 1:100
Drawing Title:- TOWER - 14
TYPICAL FLOOR FRAMING PLAN
Drawing No:- STA-01-5