


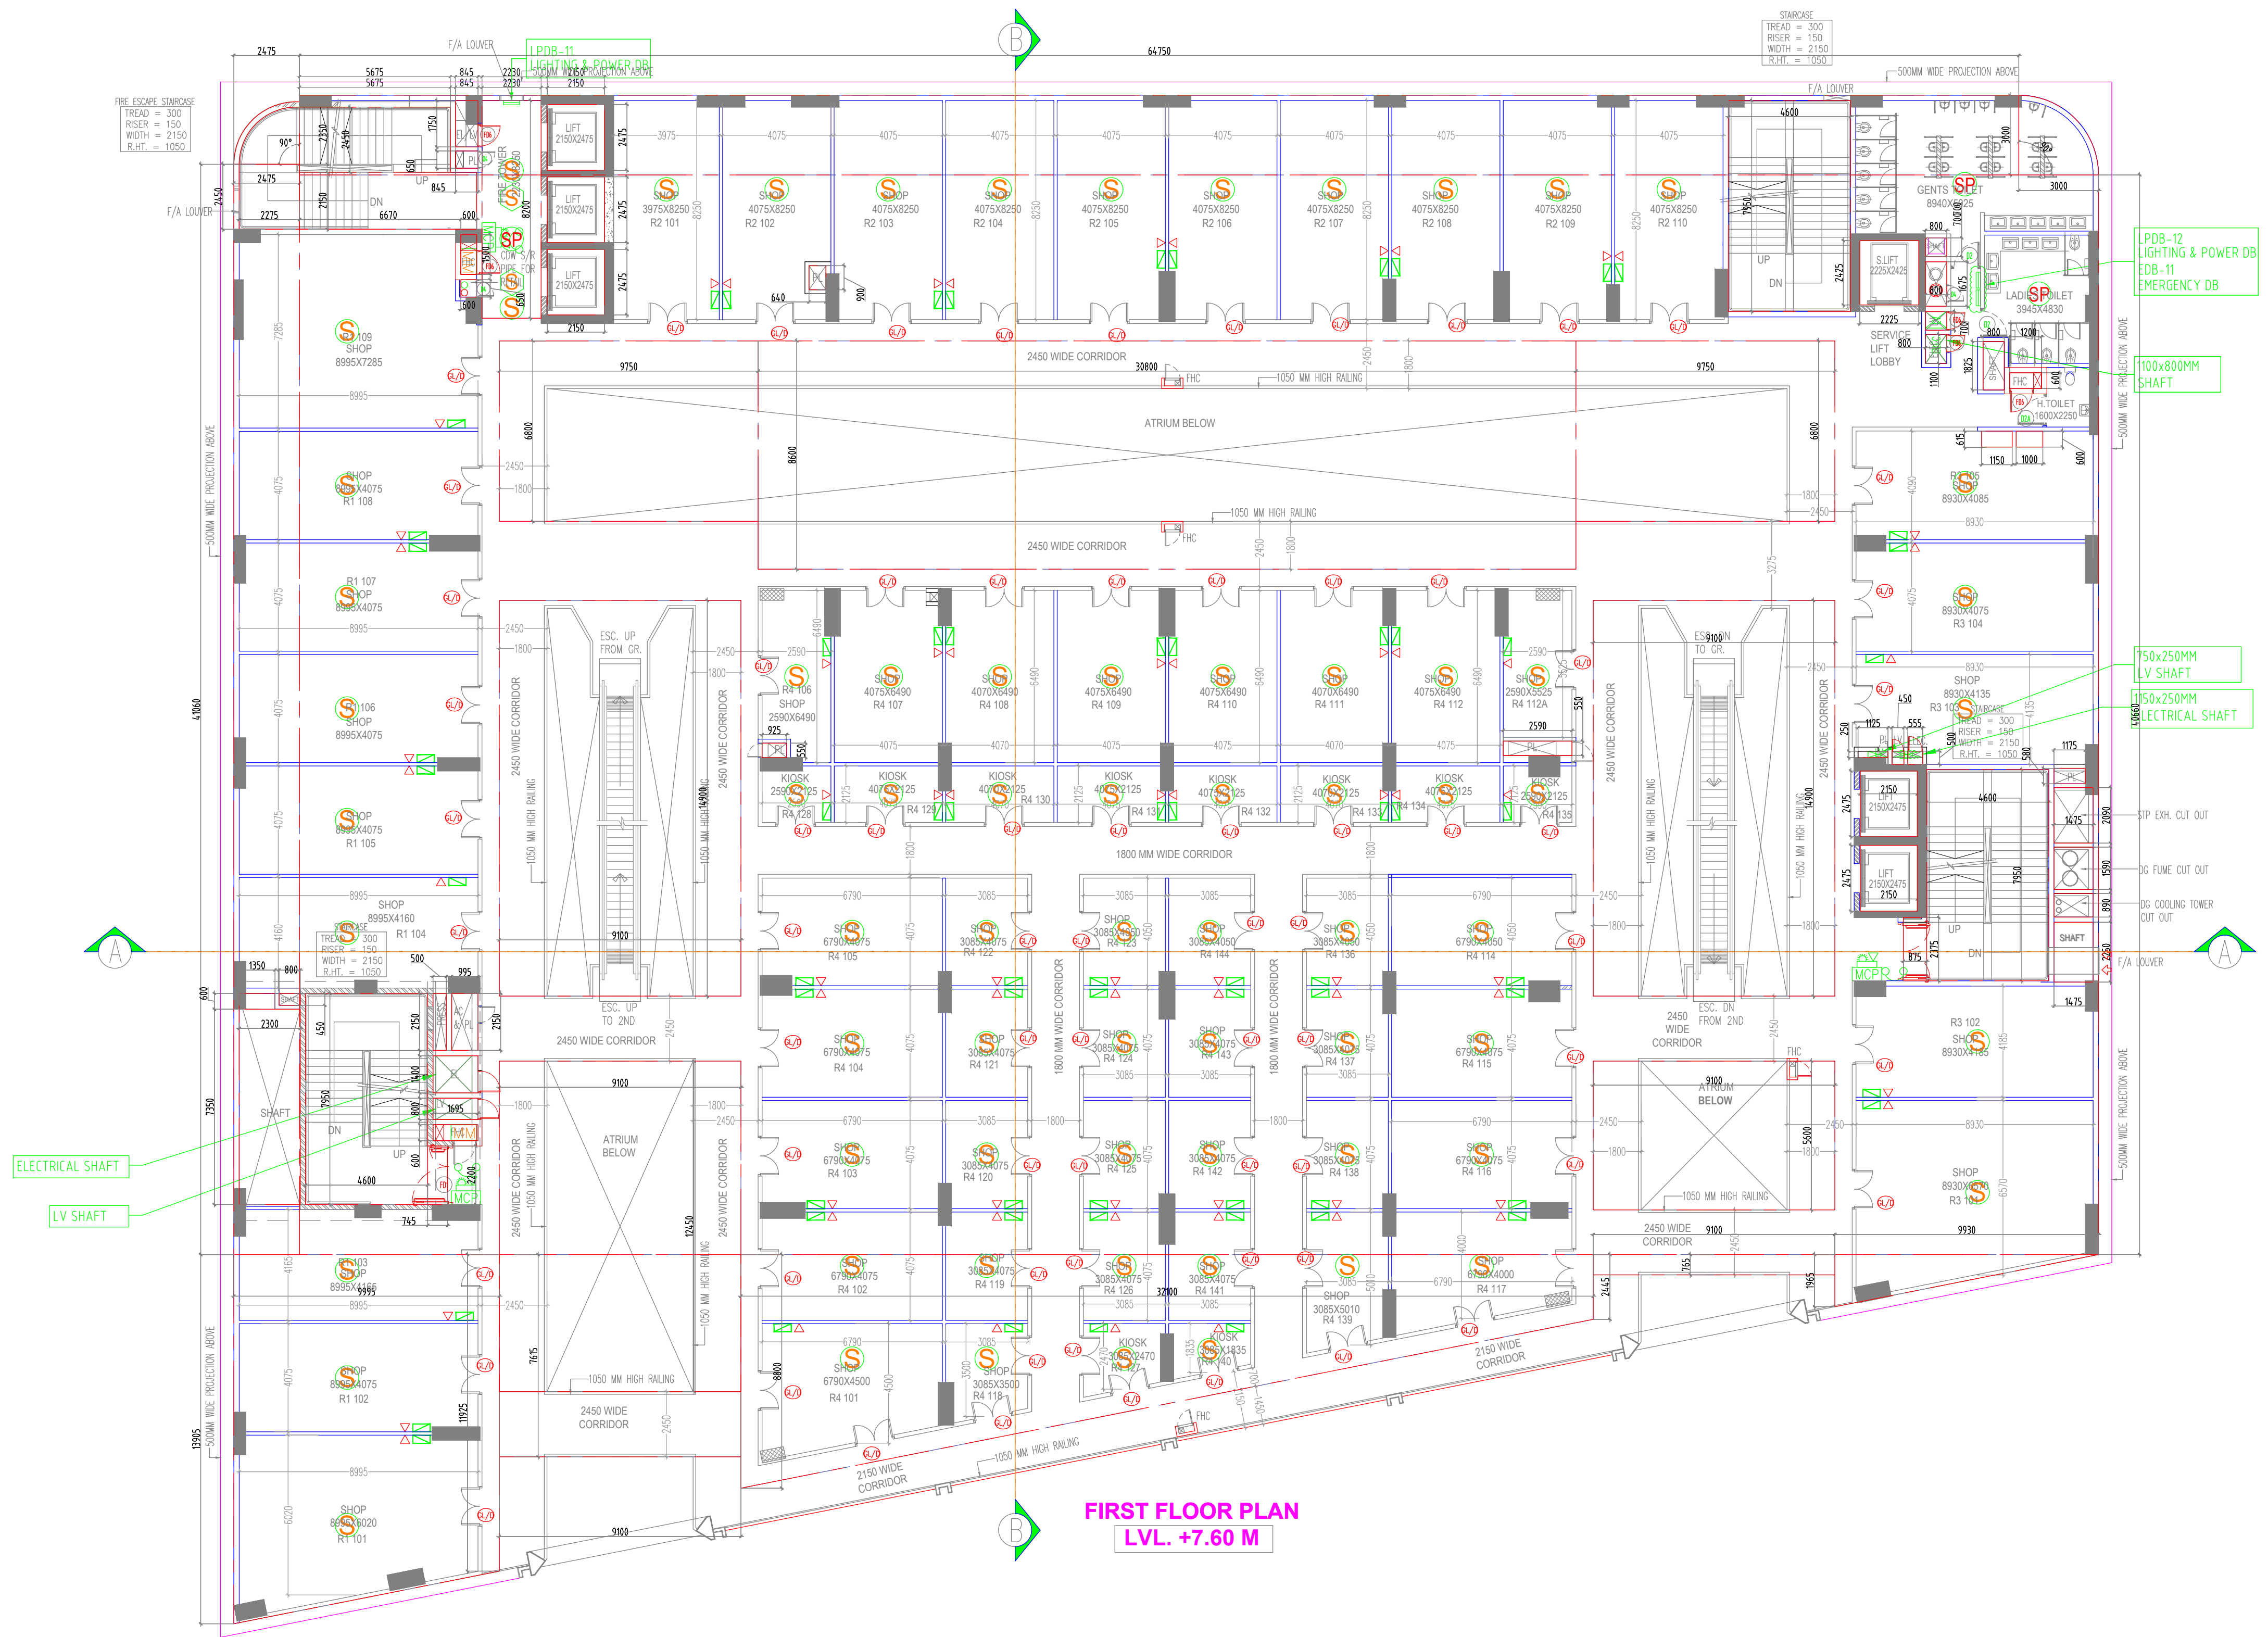

SYM	DESCRIPTION
S	SMOKE DETECTOR
H	HEAT DETECTOR
M	MULTI-CRETA DETECTOR
C	HOOTER
CP	MANUAL CALL POINT
CM	CONTROL MODULE
TB	TALK BACK
SD	SMOKE DETECTOR ABOVE FALSE CEILING
CS	CEILING SPEAKER
MM	MONITOR MODULE
BT	BEAM DETECTOR TRANSMITTER
BR	BEAM DETECTOR RECEIVER

NOTE: DETECTOR SHALL BE AT MAXIMUM 9M DISTANCE

IS	ISOLATOR
LV	LV BOX
DB	DISTRIBUTION BOARD
PCT	POWER CABLE TRAY
LCT	LV CABLE TRAY

Lekh Buildtech Private Limited
Authorized Signatory

For Dew Point Services Consultants LLP
Akhtar Parvez Ansari
Electrical Consultants

NOTES

- WHOLE BUILDING SHALL BE MECHANICALLY VENTILATED WITH 100% POWER BACKUP AND SPRINKLERS WITH ARTIFICIAL LIGHTING.
- HANDICAP RAMP WITH RAILING
- ALL PARTITION ARE IN 125/150/200MM THICK IN BLOCK WORK .

DRAWING TITLE

FIRE DETECTION AND ALARM
SYSTEM LAYOUT PLAN
FIRST FLOOR PLAN

DRAWING STATUS

FIRE SUBMISSION DRAWING

ELECTRICAL CONSULTANT:

DEW POINT SERVICES CONSULTANTS LLP

TA8 & TA10, Crown Plaza, Mathura Road,
Sector-15A, Faridabad , HR
TELE/FAX - (0129) 4072278 / 4072279
E-mail : pramod@dewpoint.net.in

OWNER'S SIGN ARCHITECT'S SIGN
PROJECT:-
PROPOSED BUILDING PLANS OF COMMERCIAL COMPLEX IN
SECTOR-25 (NEAR CENTRAL MALL), GURUGRAM
MEASURING 5344.61 SQM.

TITLE:- FIRST FLOOR PLAN ORG.NO:- M-ELECT-06
GIAN P. MATHUR AND ASSOCIATES (P) LTD.
C - 55, East Of Kailash, New Delhi-110065
T - 46099591 F - 46099512
E - gpmathur@gmail.com or www.gpmathur.com
SCALE:- 1:150 DATE:- 18/11/2022