


SYM	DESCRIPTION
S	SMOKE DETECTOR
H	HEAT DETECTOR
M	MULTI DETECTA DETECTOR
HT	HOOTER
MC	MANUAL CALL POINT
CM	CONTROL MODULE
TB	TALK BACK
SD	SMOKE DETECTOR ABOVE FALSE CEILING
CS	CEILING SPEAKER
MM	MONITOR MODULE
BT	BEAM DETECTOR TRANSMITTER
BR	BEAM DETECTOR RECEIVER

NOTE: DETECTOR SHALL BE AT MAXIMUM 9M DISTANCE

IS	ISOLATOR
LV	LV BOX
DB	DISTRIBUTION BOARD
PC	POWER CABLE TRAY
LC	LV CABLE TRAY

Lekh Buildtech Private Limited
Authorized Signatory

For Dew Point Services Consultants LLP
Akhil Parvez Ansari
Electrical Consultants

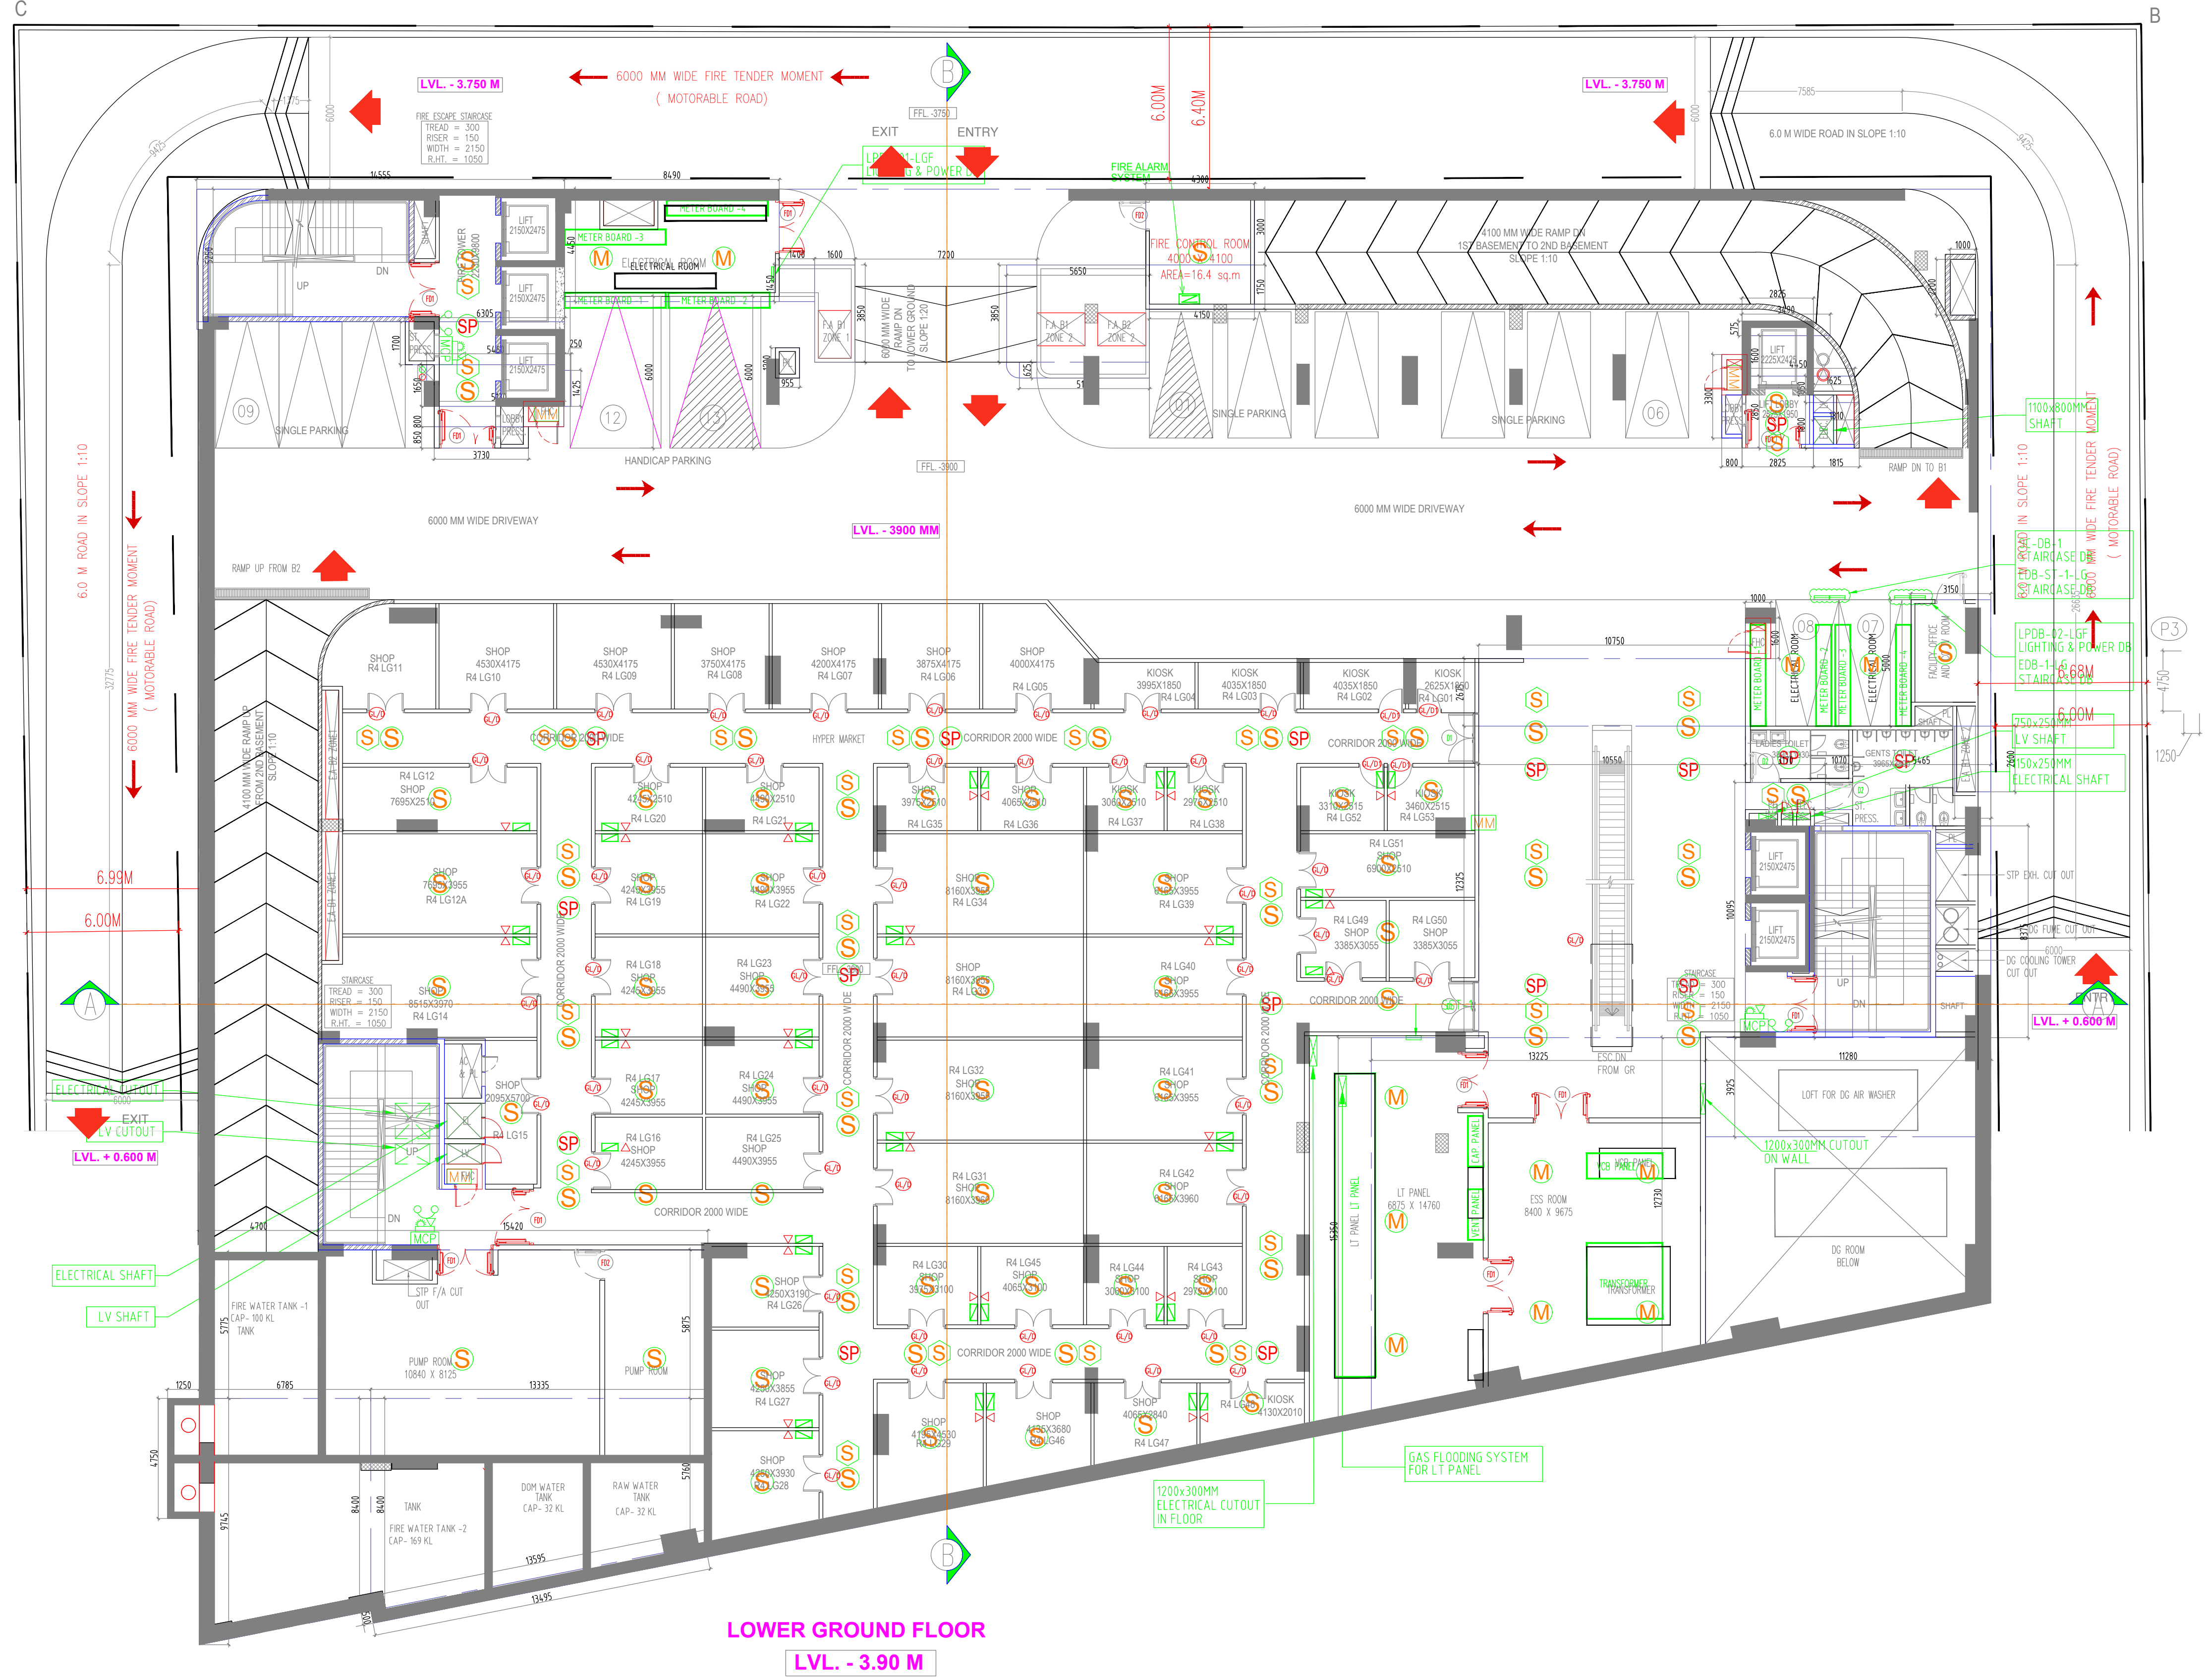

NOTES

1. WHOLE BUILDING SHALL BE MECHANICALLY VENTILATED WITH 100% POWER BACKUP AND SPRINKLERS WITH ARTIFICIAL LIGHTING.
2. HANDICAP RAMP WITH RAILING
3. ALL PARTITION ARE IN 125/150/200MM THICK IN BLOCK WORK .

DRAWING TITLE

FIRE DETECTION AND ALARM
SYSTEM LAYOUT PLAN
LOWER GROUND FLOOR PLAN

DRAWING STATUS

FIRE SUBMISSION DRAWING
ELECTRICAL CONSULTANT:

DEW POINT SERVICES CONSULTANTS LLP
TA8 & TA10, Crown Plaza, Mathura Road,
Sector-15A, Faridabad , HR
TELE/FAX - (0129) 4072278 / 4072279
E-mail : pramod@dewpoint.net.in

OWNER'S SIGN ARCHITECT'S SIGN
PROJECT: -
PROPOSED BUILDING PLANS OF COMMERCIAL COMPLEX IN
SECTOR-25 (NEAR CENTRAL MALL), GURUGRAM
MEASURING 5344.61 SQM.

TITLE:- LOWER GROUND FLOOR PLAN DRG.NO:- M-ELECT-03

100% DRAWING IS THE PROPERTY OF
DEW POINT SERVICES CONSULTANTS LLP
AND SHALL BE KEPT IN CONFIDENTIALITY
AND NOT TO BE REPRODUCED OR
COPIED IN ANY MANNER WITHOUT
WRITTEN PERMISSION

gjom
GIAN P. MATHUR AND ASSOCIATES (P) LTD.
C - 55, East Of Kailash, New Delhi-110065
T : 40995999 / F : 40995112
E : gpmad@rediffmail.in W : www.gpmindia.com

SCALE:- 1:150 DATE:- 18/11/2022