


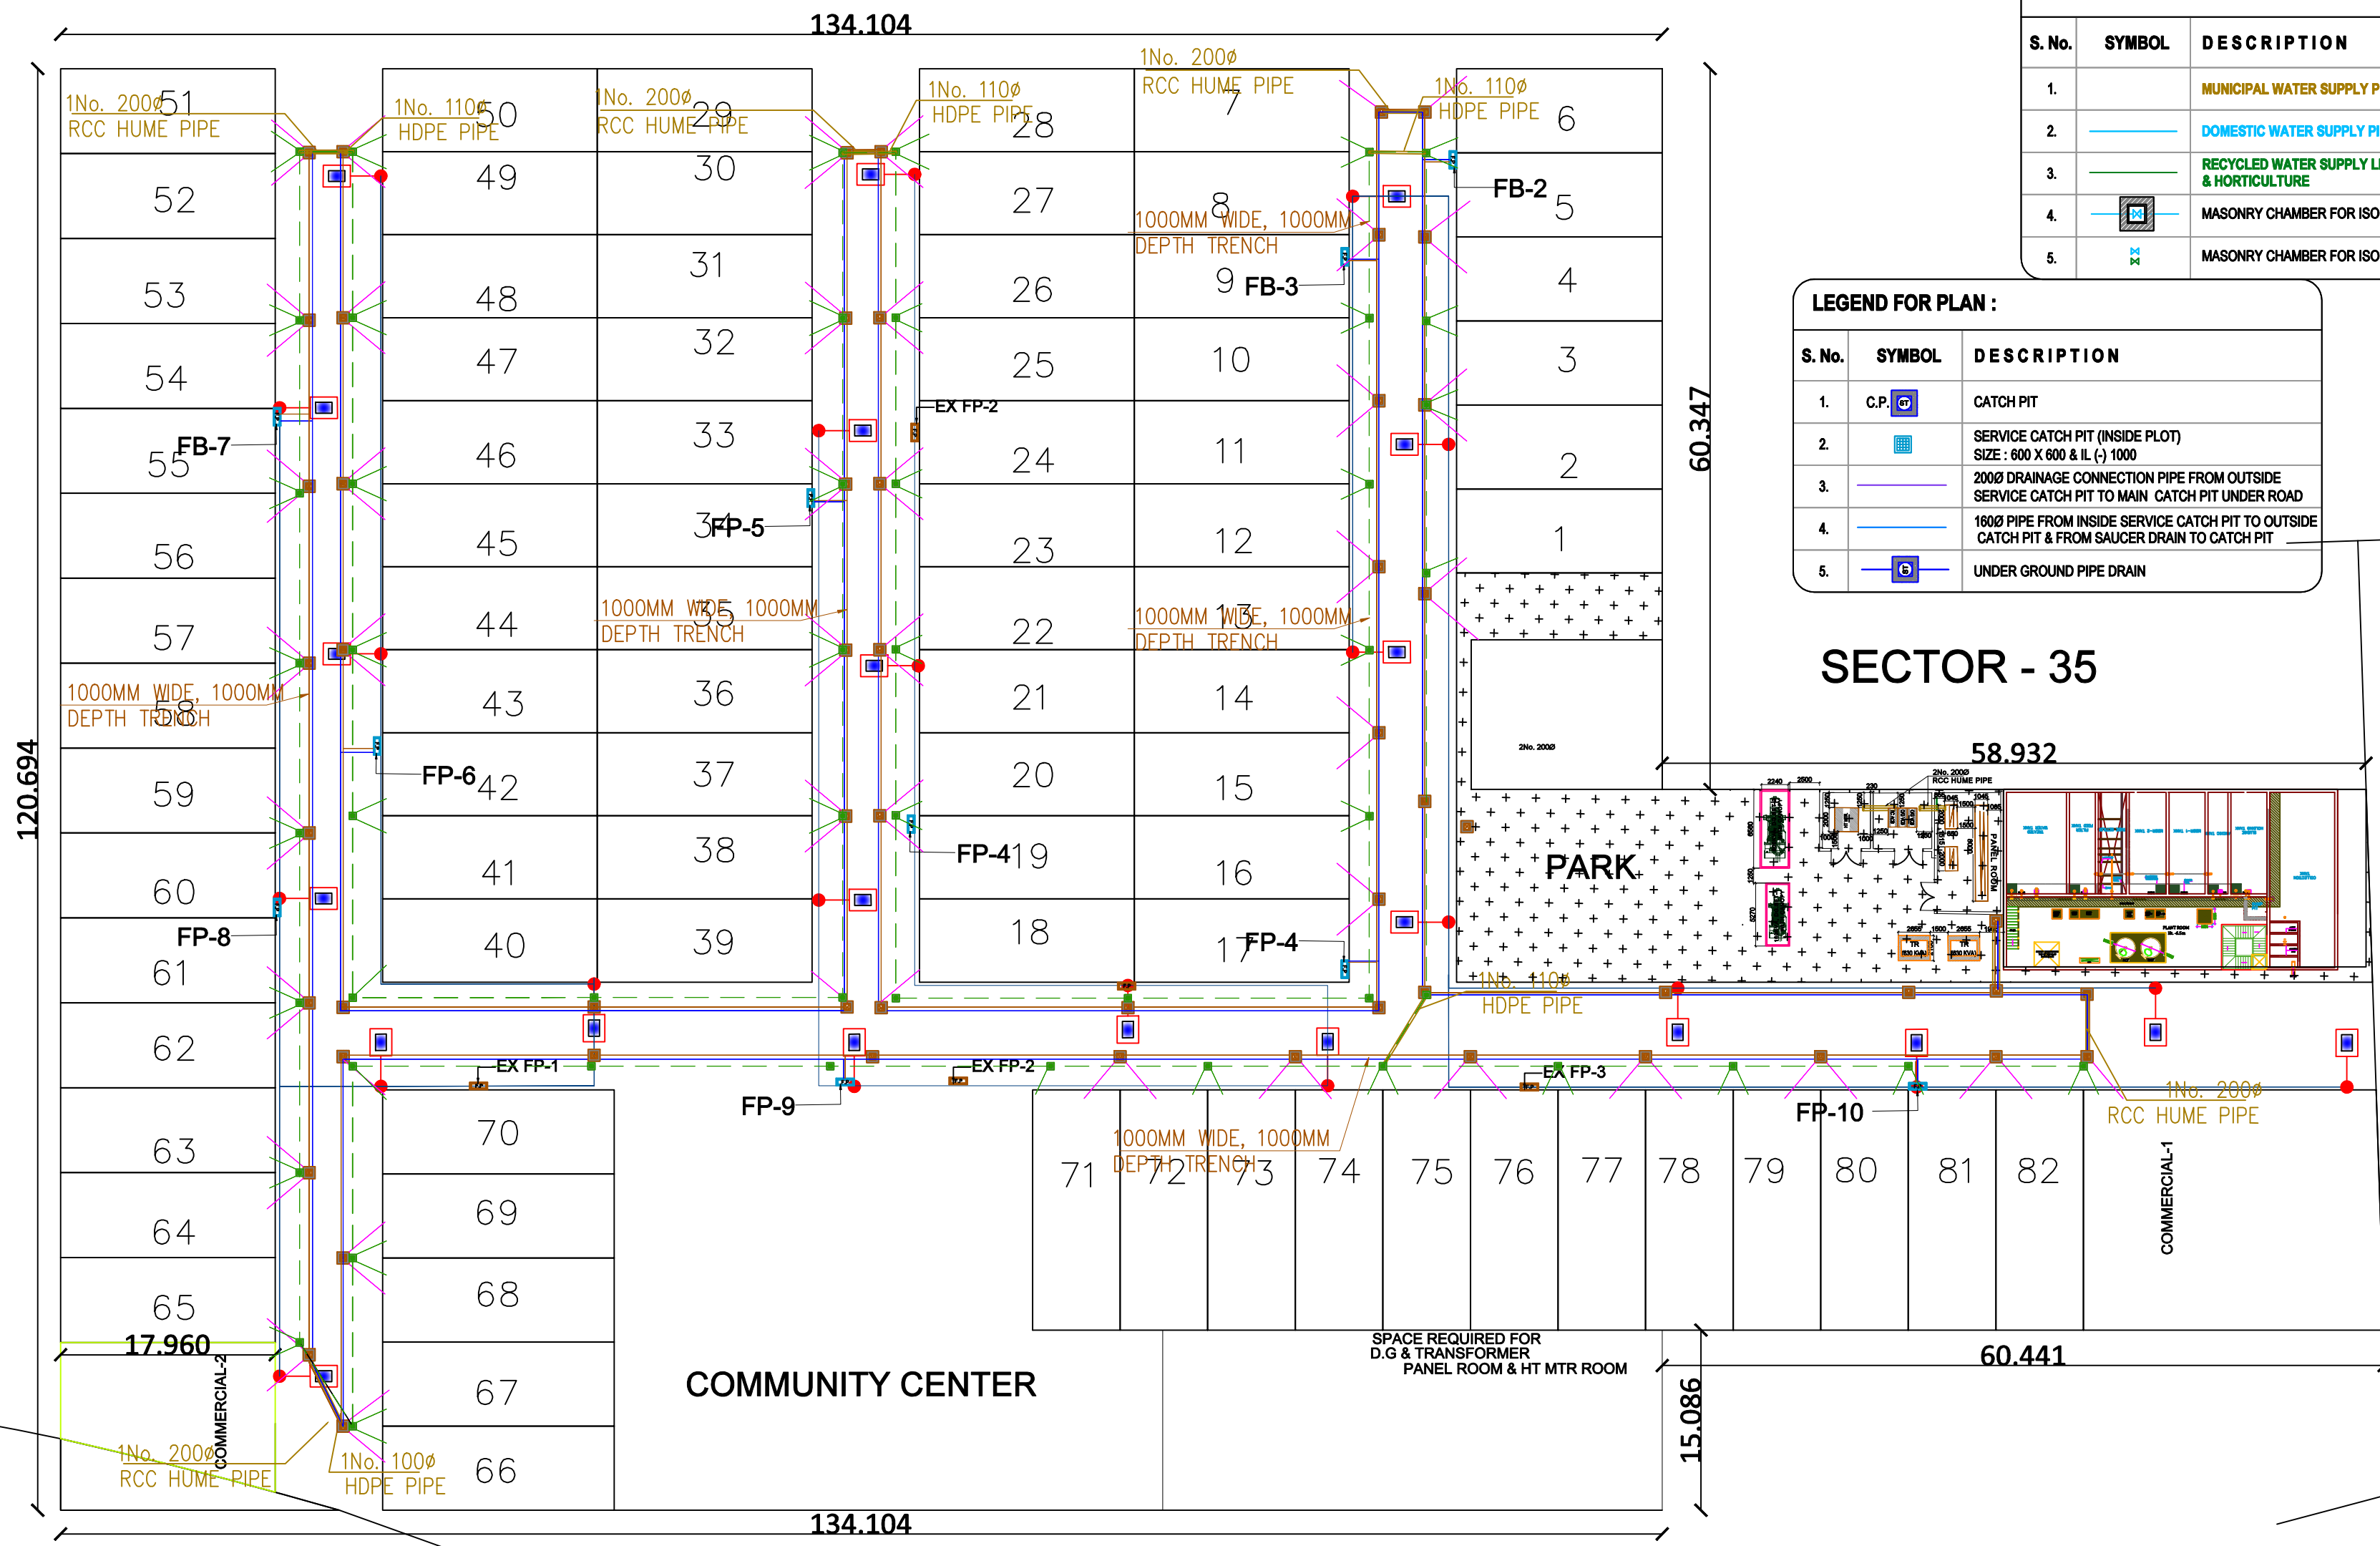

LEGEND FOR PLAN :		
S. No.	SYMBOL	DESCRIPTION
1.		MUNICIPAL WATER SUPPLY PIPE LINE
2.		DOMESTIC WATER SUPPLY PIPE LINE
3.		RECYCLED WATER SUPPLY LINE FOR FLUSHING & HORTICULTURE
4.		MASONRY CHAMBER FOR ISOLATING VALVE
5.		MASONRY CHAMBER FOR ISOLATING VALVE

LEGEND FOR PLAN :		
S. No.	SYMBOL	DESCRIPTION
1.		MANHOLE
2.		SERVICE MANHOLE (INSIDE PLOT) SIZE : 600 X 600 & IL (-) 1000
3.		SERVICE MANHOLE (OUTSIDE PLOT) SIZE : 600 X 600 & IL (-) 1100
4.		1600 BRANCH SEWERAGE CONNECTION PIPE
5.		SEWER LINE


LEGEND FOR PLAN :		
S. No.	SYMBOL	DESCRIPTION
1.		CATCH PIT
2.		SERVICE CATCH PIT (INSIDE PLOT) SIZE : 600 X 600 & IL (-) 1000
3.		2000 DRAINAGE CONNECTION PIPE FROM OUTSIDE SERVICE CATCH PIT TO MAIN CATCH PIT UNDER ROAD
4.		1600 PIPE FROM INSIDE SERVICE CATCH PIT TO OUTSIDE CATCH PIT & FROM SAUCER DRAIN TO CATCH PIT
5.		UNDER GROUND PIPE DRAIN

SECTOR - 35

12.0 M. WIDE SERVICE ROAD
(PART OF 50 M. WIDE GREEN BELT)

38.0 M. WIDE GREEN BELT
(PART OF 50 M. WIDE GREEN BELT)

TO SOHNA SOHNA - GURGAON ROAD TO GURGAON

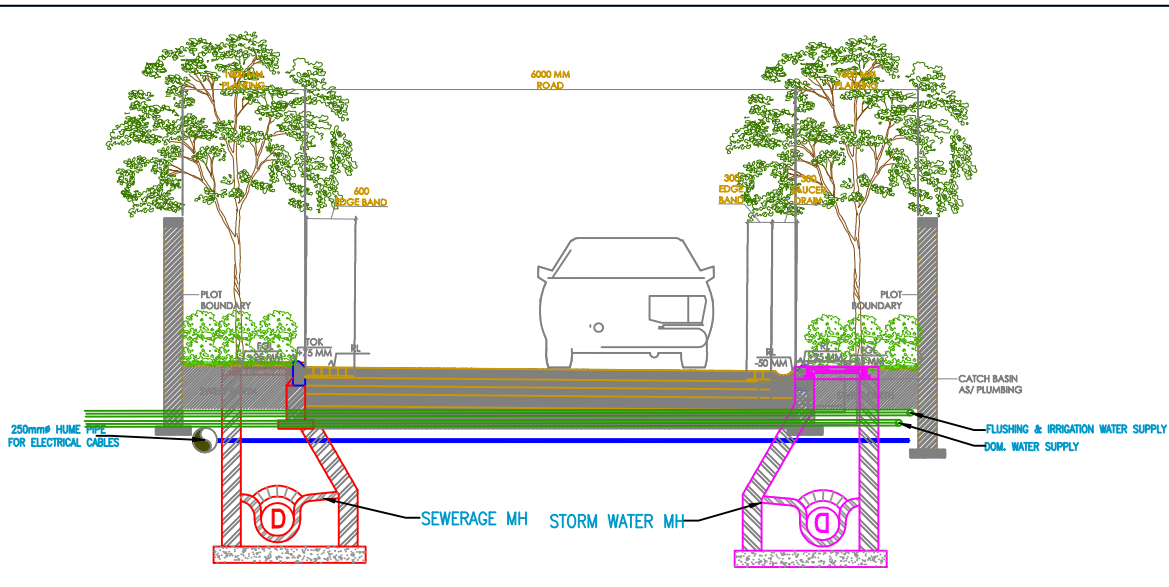

TITLE : EXTERNAL SITE PLAN ELECTRICAL LAYOUT		
Project : PLOTTED HOUSING COLONY OF LAND AT VILLAGE SOHNA DHANI, SOHNA.		
Client : M/S Wings Realtors Pvt. Ltd. Sector-35, Sohna (Haryana)		
P.M.C TRAPEZIUM PROJECTS PVT. LTD. ENGINEERS & CONTRACTORS CONSULTANTS MANPOWER REAL ESTATE		
MEP CONSULTANTS OD & C ONE DESIGN & CONSULTANTS 7/8, LGF, Nehru Enclave, Kalkaji Extension, New Delhi- 110019 E-MAIL:- onedesignconsultants@gmail.com web mail:- info@onedesignconsultants.com MOB:- 99580-79000		
Drawn By: S.P	CHKD: A.S	Scale:
	Date : 18.06-2022	1: 750
Drawing No. ODC-SOH-EXT-EL-RW-004	Sht. Size A3	Rev. No. R0