


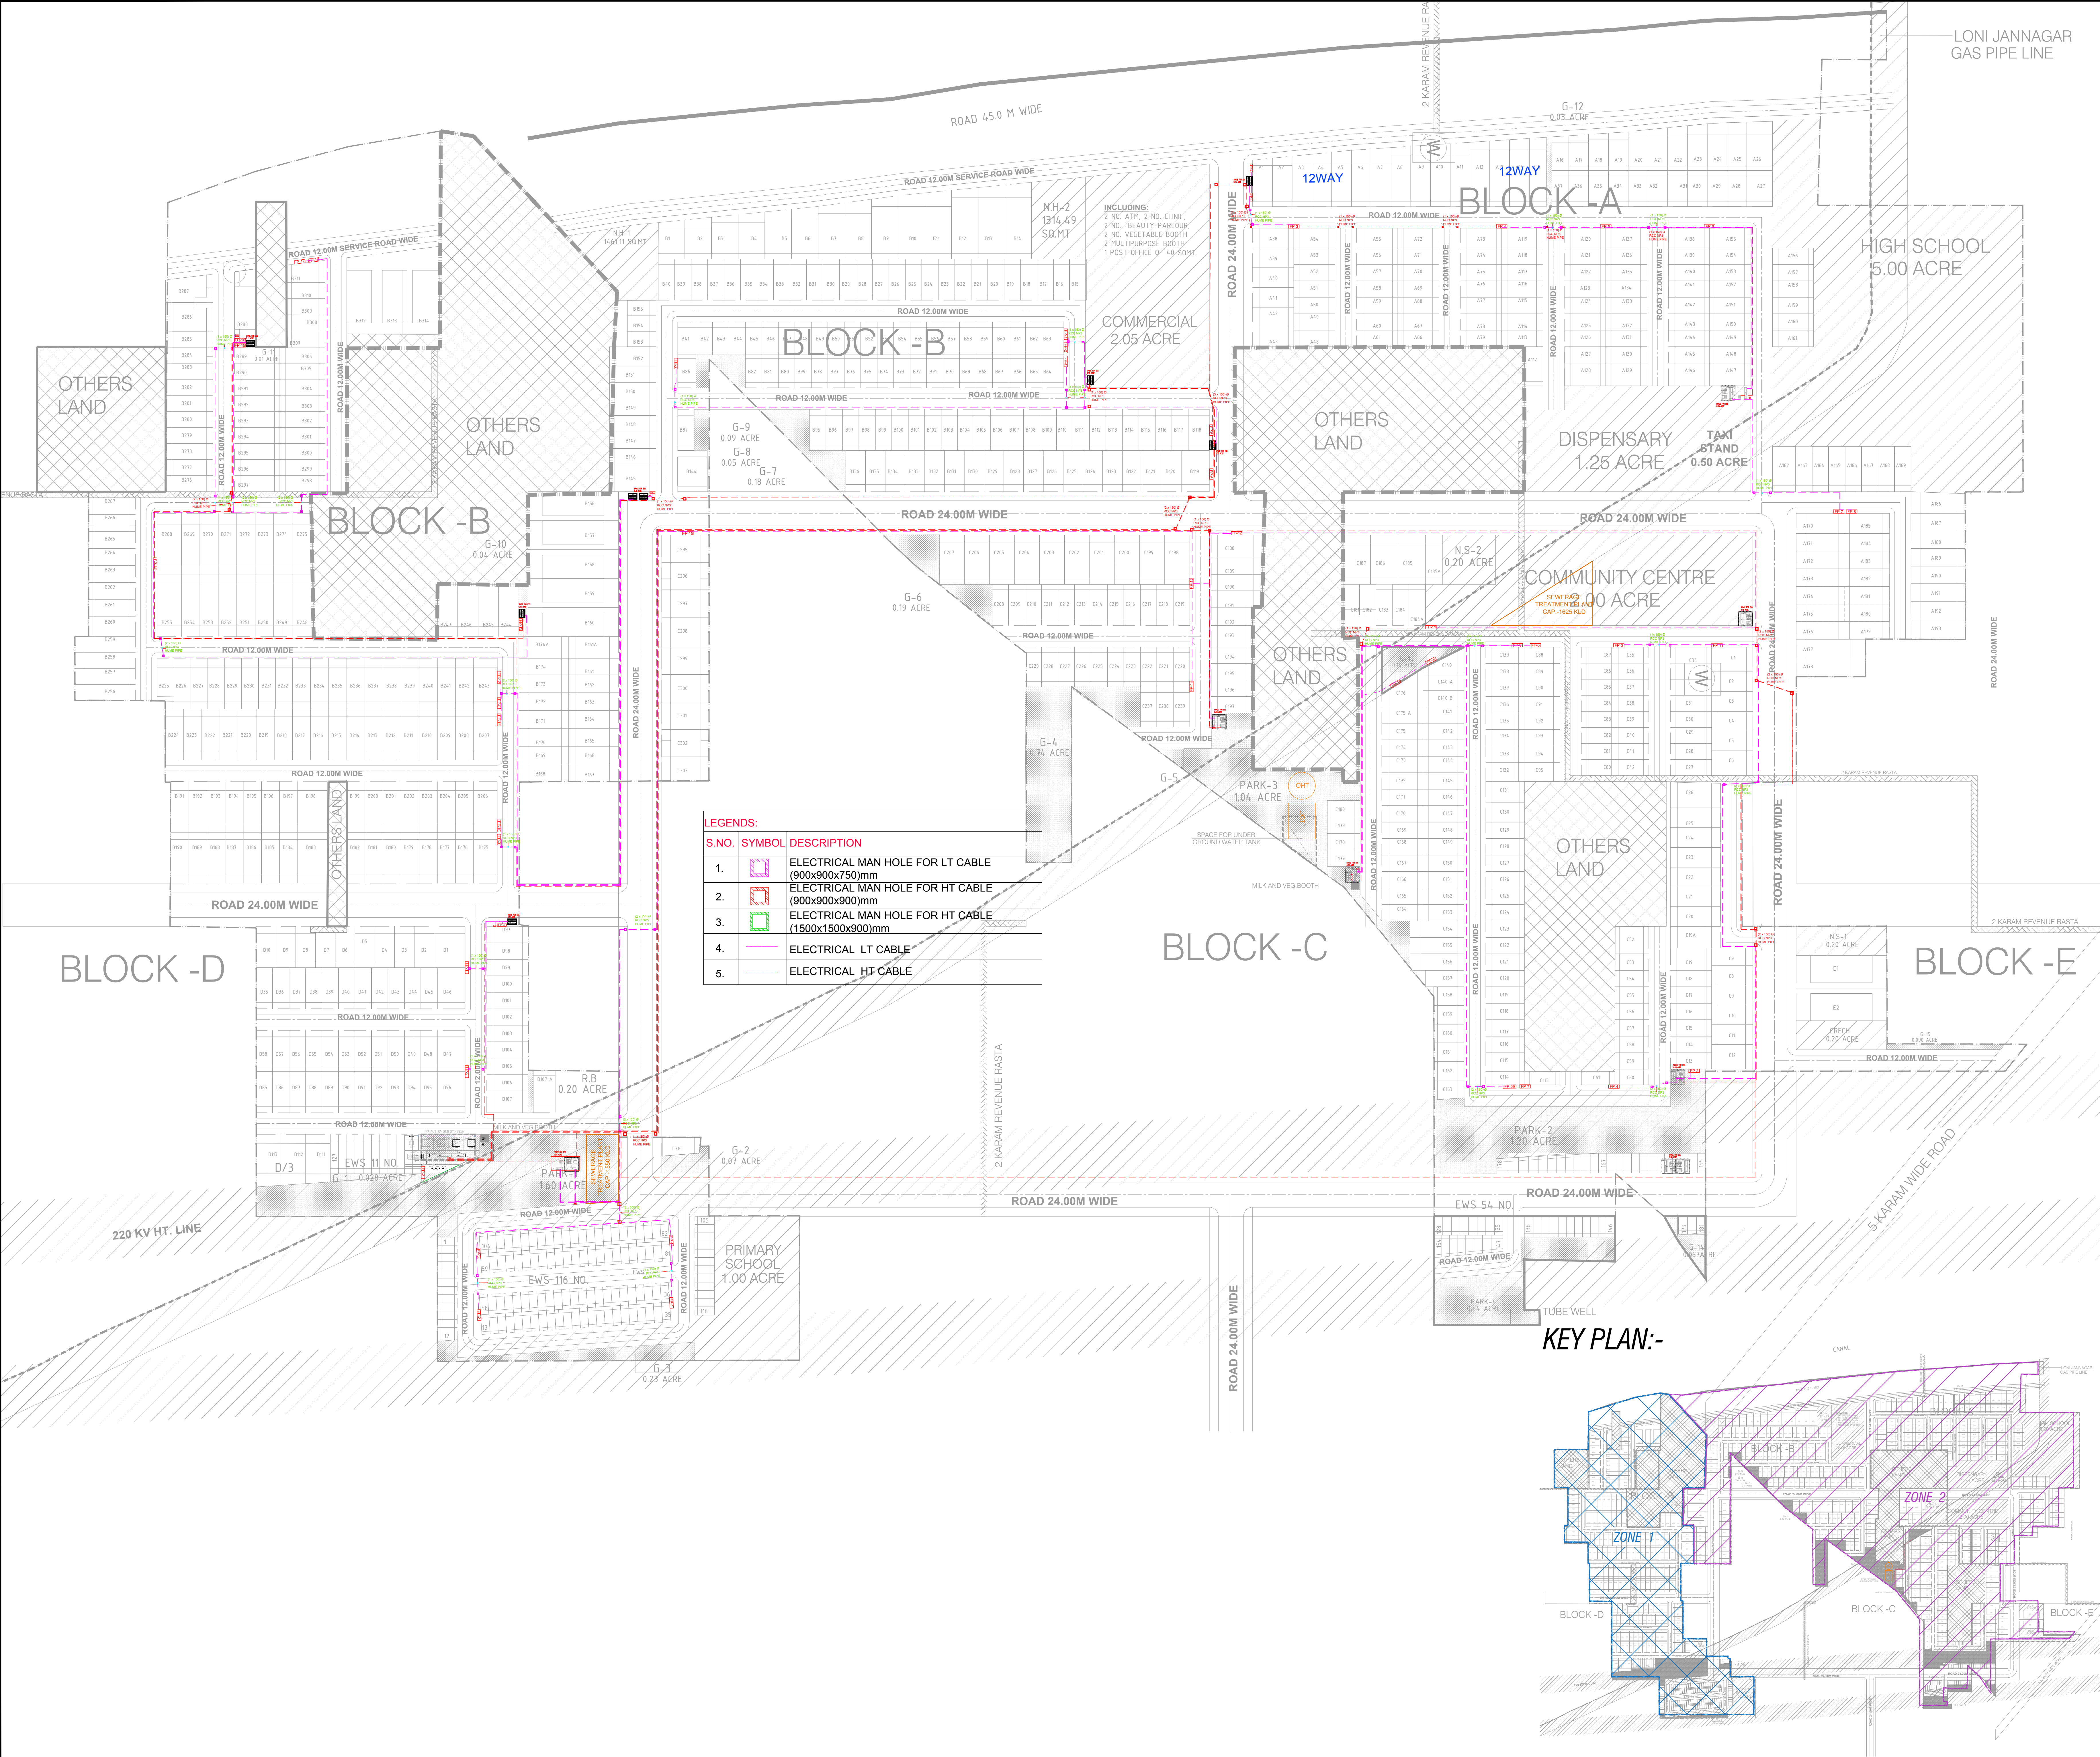

STAGE : TENDER

DATE: 18.09.2021

REV.NO. -

JOB TITLE- HES-TF

REV. NOTES:

DATE: REV. DESCRIPTION

CLIENT :

ARCHITECT:

ICHINEN ATCHITECTS PRIVATE LIMITED  
A-5 SAVODAYA ENCLAVE, NEW DELHI - 110017

MEP CONSULTANTS:

HABITAT ENGINEERING SERVICES CONSULTANT  
A-127, Second Floor, Masoodpur  
Vasant Kunj, New Delhi-110070 Tel:  
9810620402, 7217662363  
Email : -habitatenvirosolutions@gmail.com

PROJECT :

PROPOSED RESIDENTIAL PLOTTED  
COLONY MEASURING 102.194 ACRE  
AT SECTOR -70, FARIDABAD

DWG. TITLE :

ELECTRICAL LAYOUT  
COORDINATED PLAN

DWG. NO : HES/2021/TF/EL/04-A

SCALE : 1:1100 @ A0

DRAWN BY: NAVEEN RATHORE

CHECKED BY: PRAVEEN

APPROVED BY: JANARDAN SINGH