
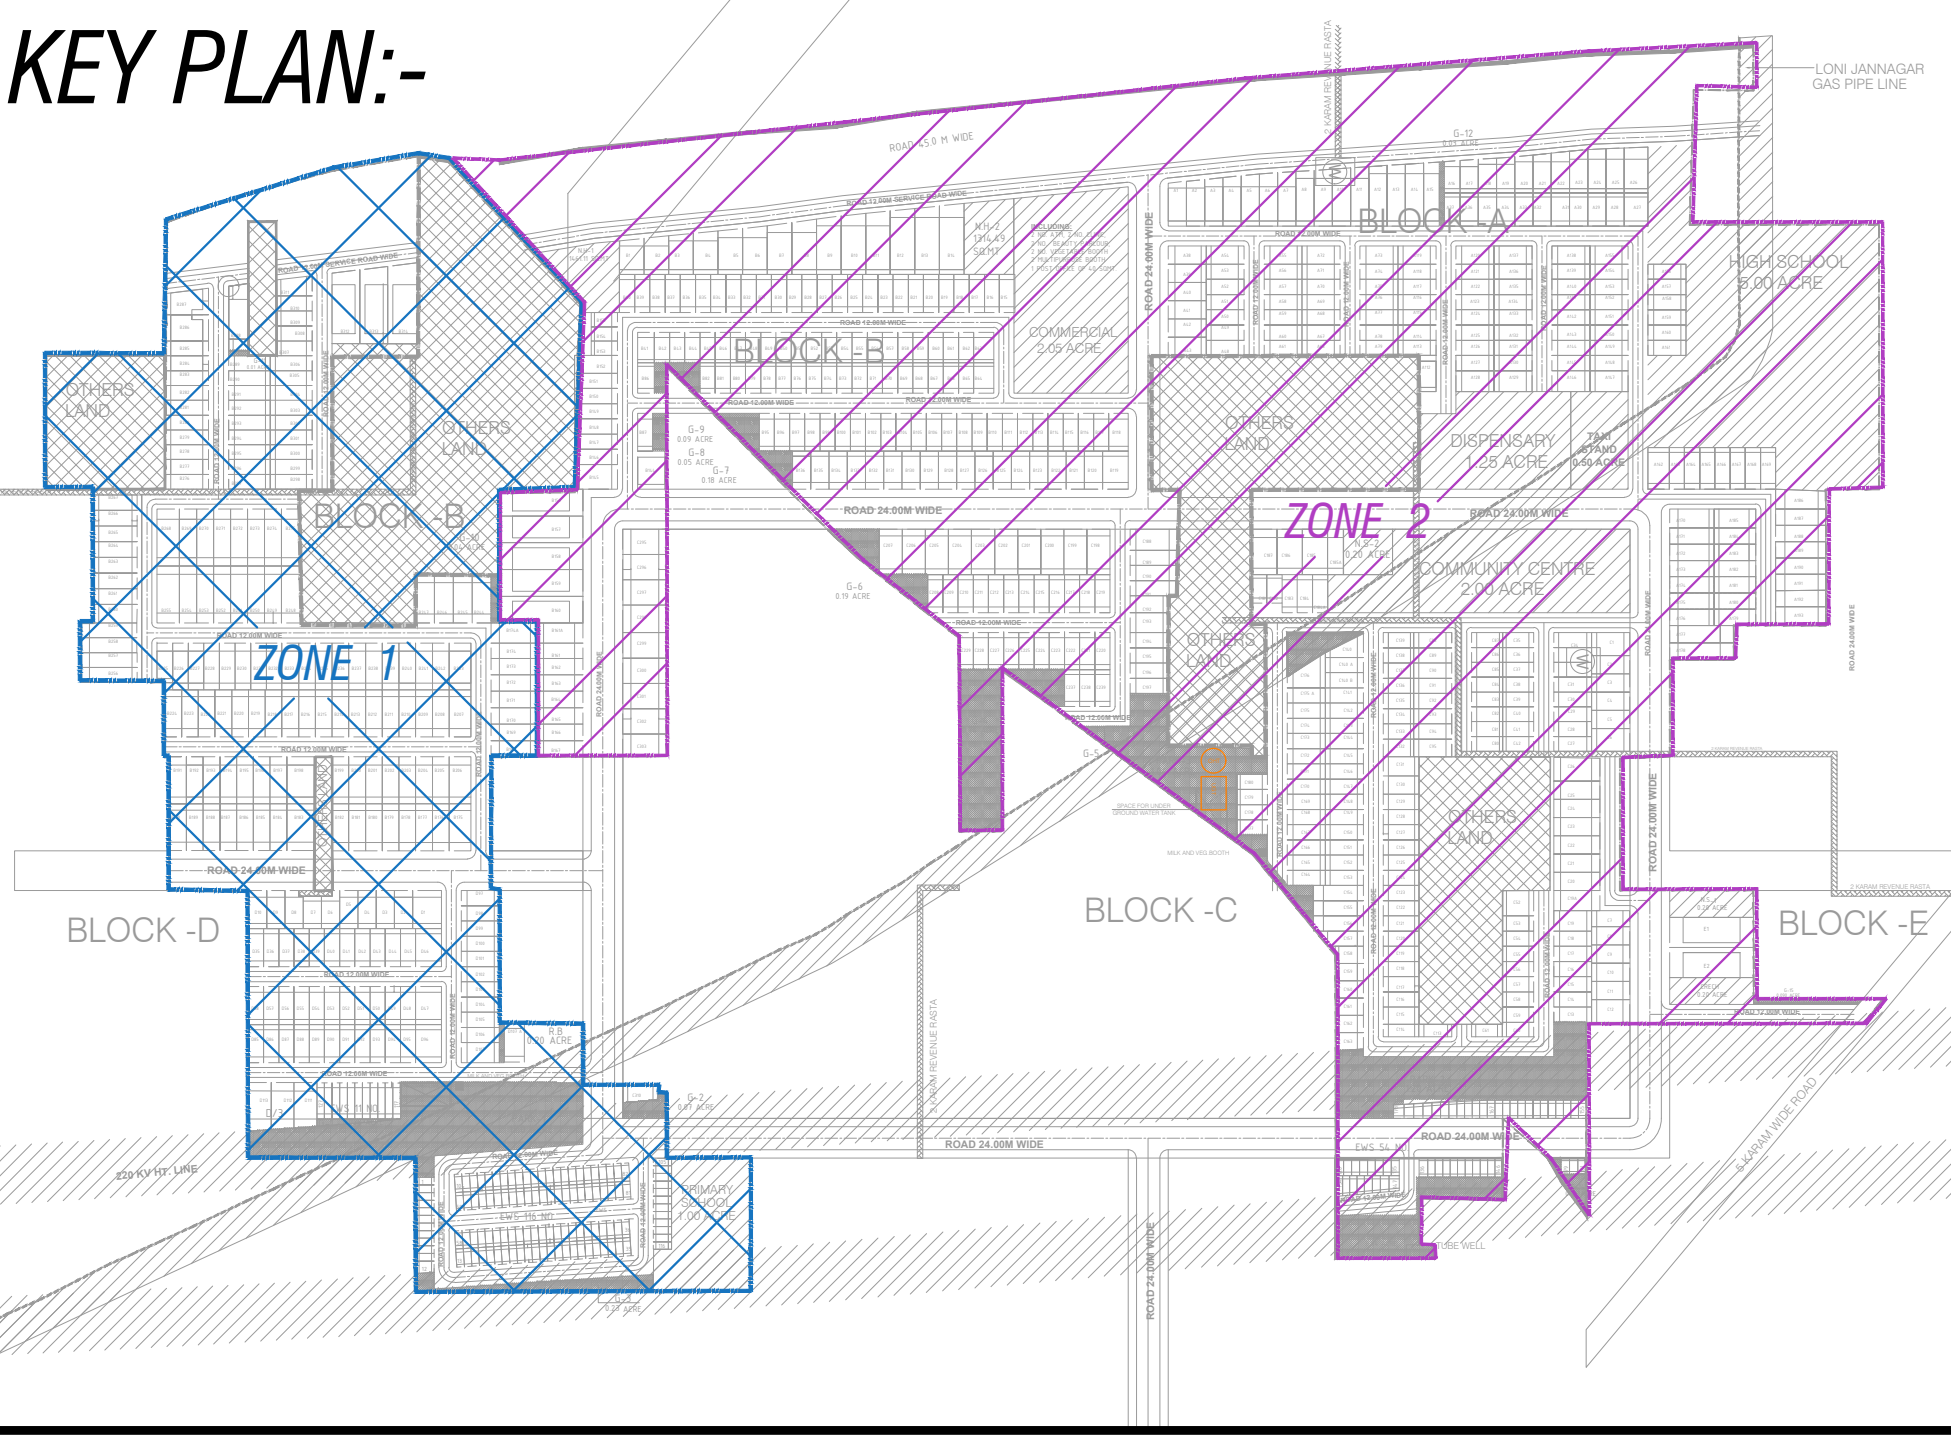


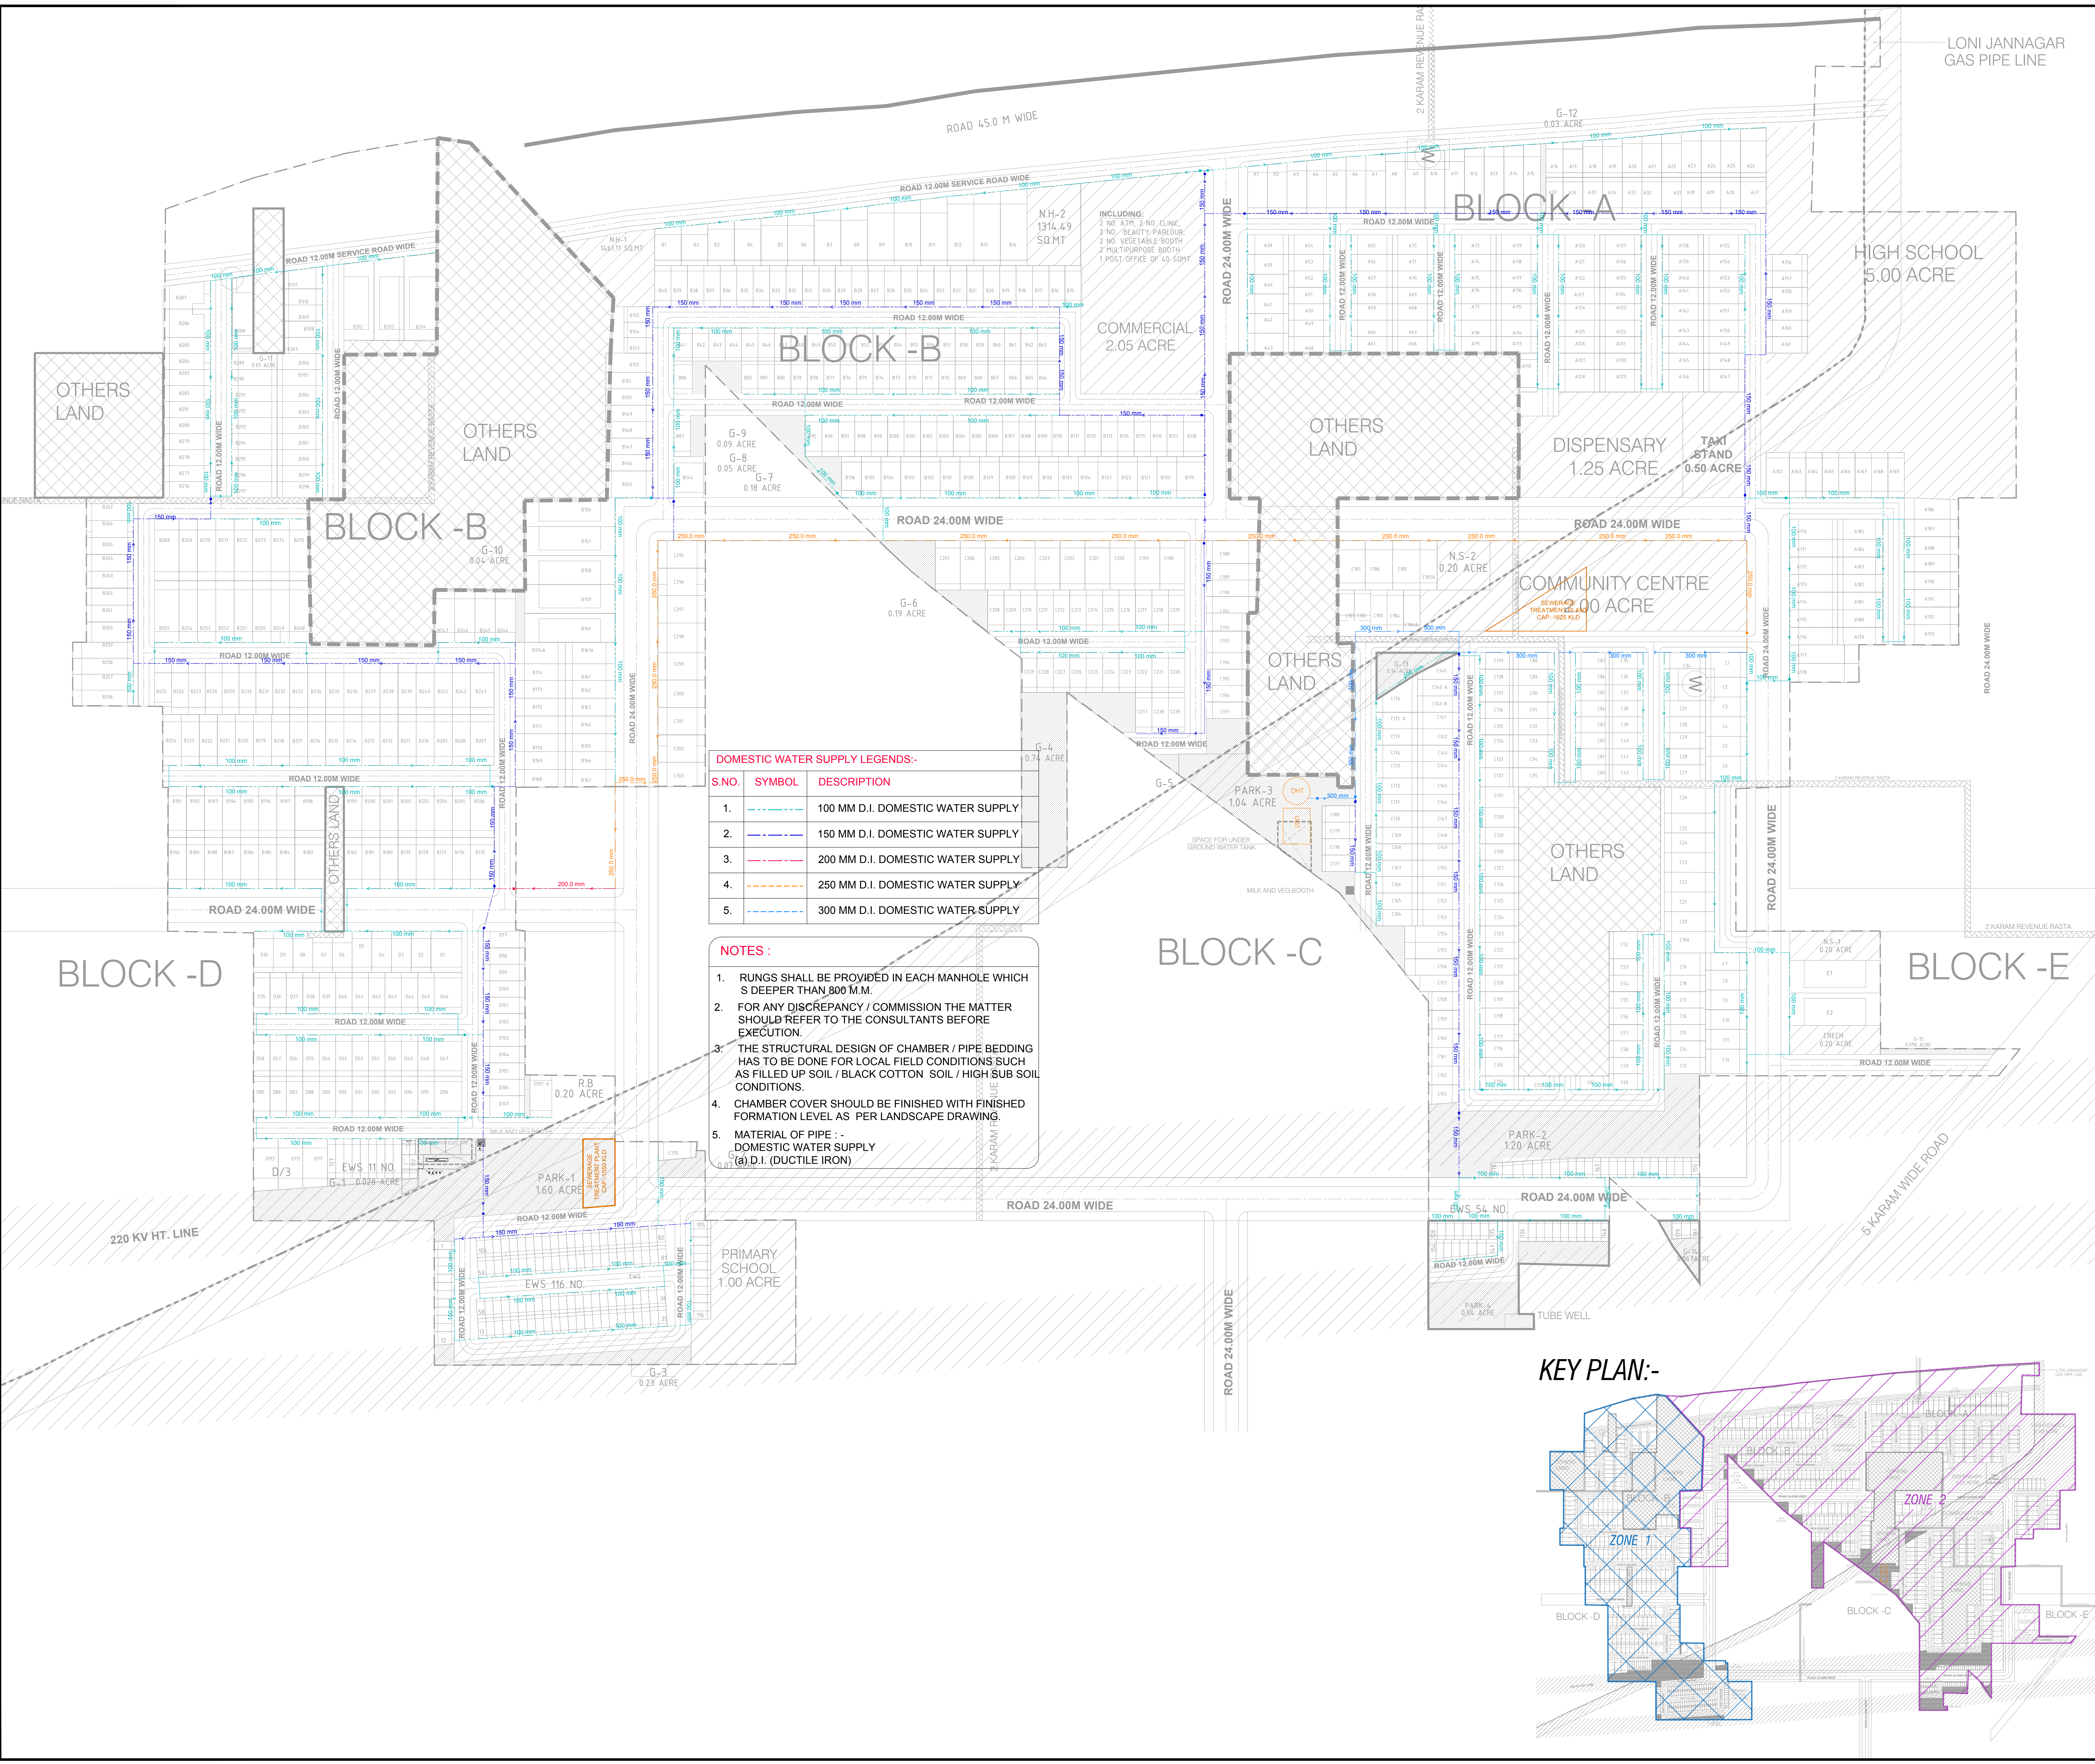

STAGE : TENDER

DATE: 01.09.2021

REV.NO. -

JOB TITLE- HES-TF

REV. NOTES:

DATE: REV. DESCRIPTION

CLIENT :

ARCHITECT:
ICHINEN ATCHITECTS PRIVATE LIMITED
A-5 SAVODAYA ENCLAVE, NEW DELHI - 110017

MEP CONSULTANTS:
HABITAT ENGINEERING SERVICES CONSULTANT
A-127, Second Floor, Masoodpur
Vasant Kunj, New Delhi-110070 Tel:
9810620402, 7217662363
Email : -habitatenvirosolutions@gmail.com

PROJECT :
PROPOSED RESIDENTIAL PLOTTED
COLONY MEASURING 102.194 ACRE
AT SECTOR -70, FARIDABAD

DWG. TITLE :
SITE PLAN
DOMESTIC WATER
SUPPLY LAYOUT

DWG. NO : HES/2021/TF/WS-DOM/03-A

SCALE : 1:1100 @ A0

DRAWN BY: NAVEEN RATHORE

CHECKED BY: PRAVEEN

APPROVED BY: JANARDAN SINGH