



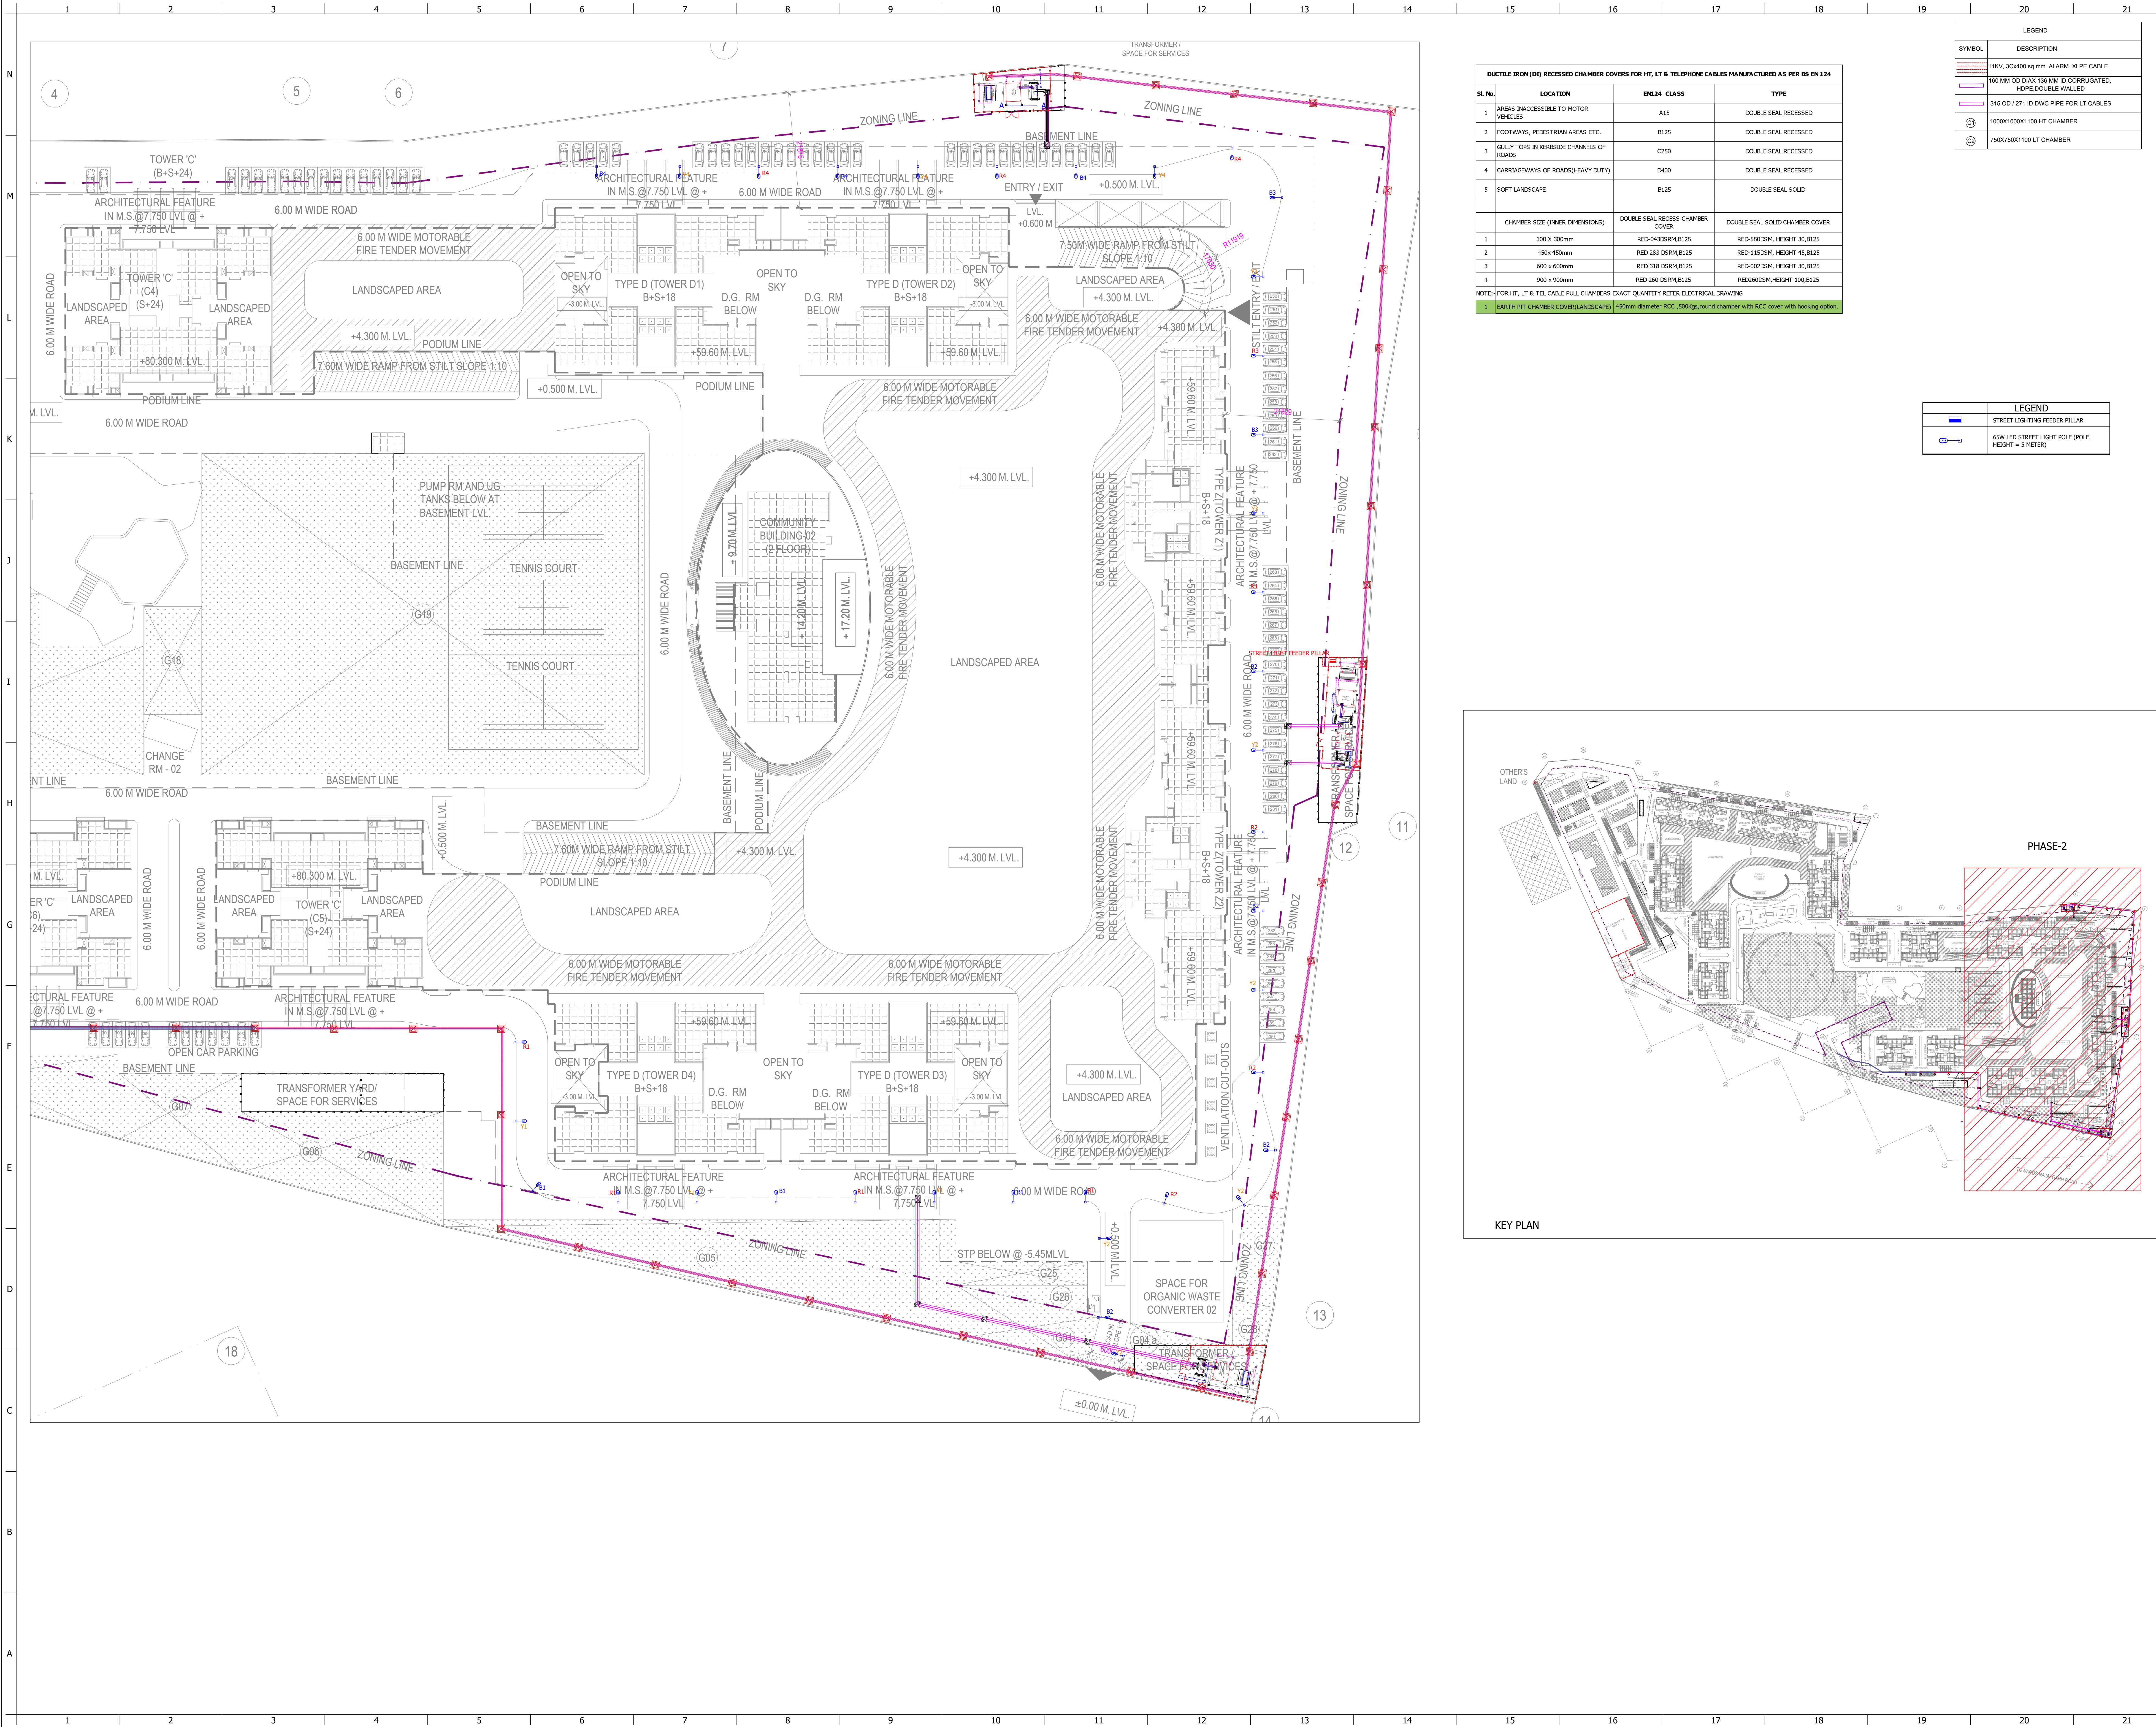

DUCTILE IRON (DI) RECESSED CHAMBER COVERS FOR HT, LT & TELEPHONE CABLES MANUFACTURED AS PER IS EN 124			
SL NO.	LOCATION	EN24 CLASS	TYPE
1	AREAS INACCESSIBLE TO MOTOR VEHICLES	A15	DOUBLE SEAL RECESSED
2	FOOTWAYS, PEDESTRIAN AREAS ETC.	B125	DOUBLE SEAL RECESSED
3	GULLY TIPS IN KERBSIDE CHANNELS OF ROADS	C250	DOUBLE SEAL RECESSED
4	CARRIAGEWAYS OF ROADS (HEAVY DUTY)	D400	DOUBLE SEAL RECESSED
5	SOFT LANDSCAPE	B125	DOUBLE SEAL SOLID
CHAMBER SIZE (INNER DIMENSIONS)		DOUBLE SEAL RECESS CHAMBER COVER	DOUBLE SEAL SOLID CHAMBER COVER
1	300 x 300mm	RED-D140SRM,B125	RED-S500SM, HEIGHT 30,B125
2	450 x 450mm	RED-283 DSRM,B125	RED-L1500M, HEIGHT 45,B125
3	600 x 600mm	RED-318 DSRM,B125	RED-0020SM, HEIGHT 30,B125
4	900 x 900mm	RED-240 DSRM,B125	RED-260DSM, HEIGHT 100,B125
NOTE: FOR HT, LT & TEL CABLE RULL CHAMBERS EXACT QUANTITY REFER ELECTRICAL DRAWING			
1. EARTH PTT CHAMBER COVER(LANDSCAPE) 150mm diameter RCC, 500kg,round chamber with RCC cover with hooking option.			

LEGEND	
	STREET LIGHTING FEEDER PILLAR
	65W LED STREET LIGHT POLE (POLE HEIGHT = 5 METER)

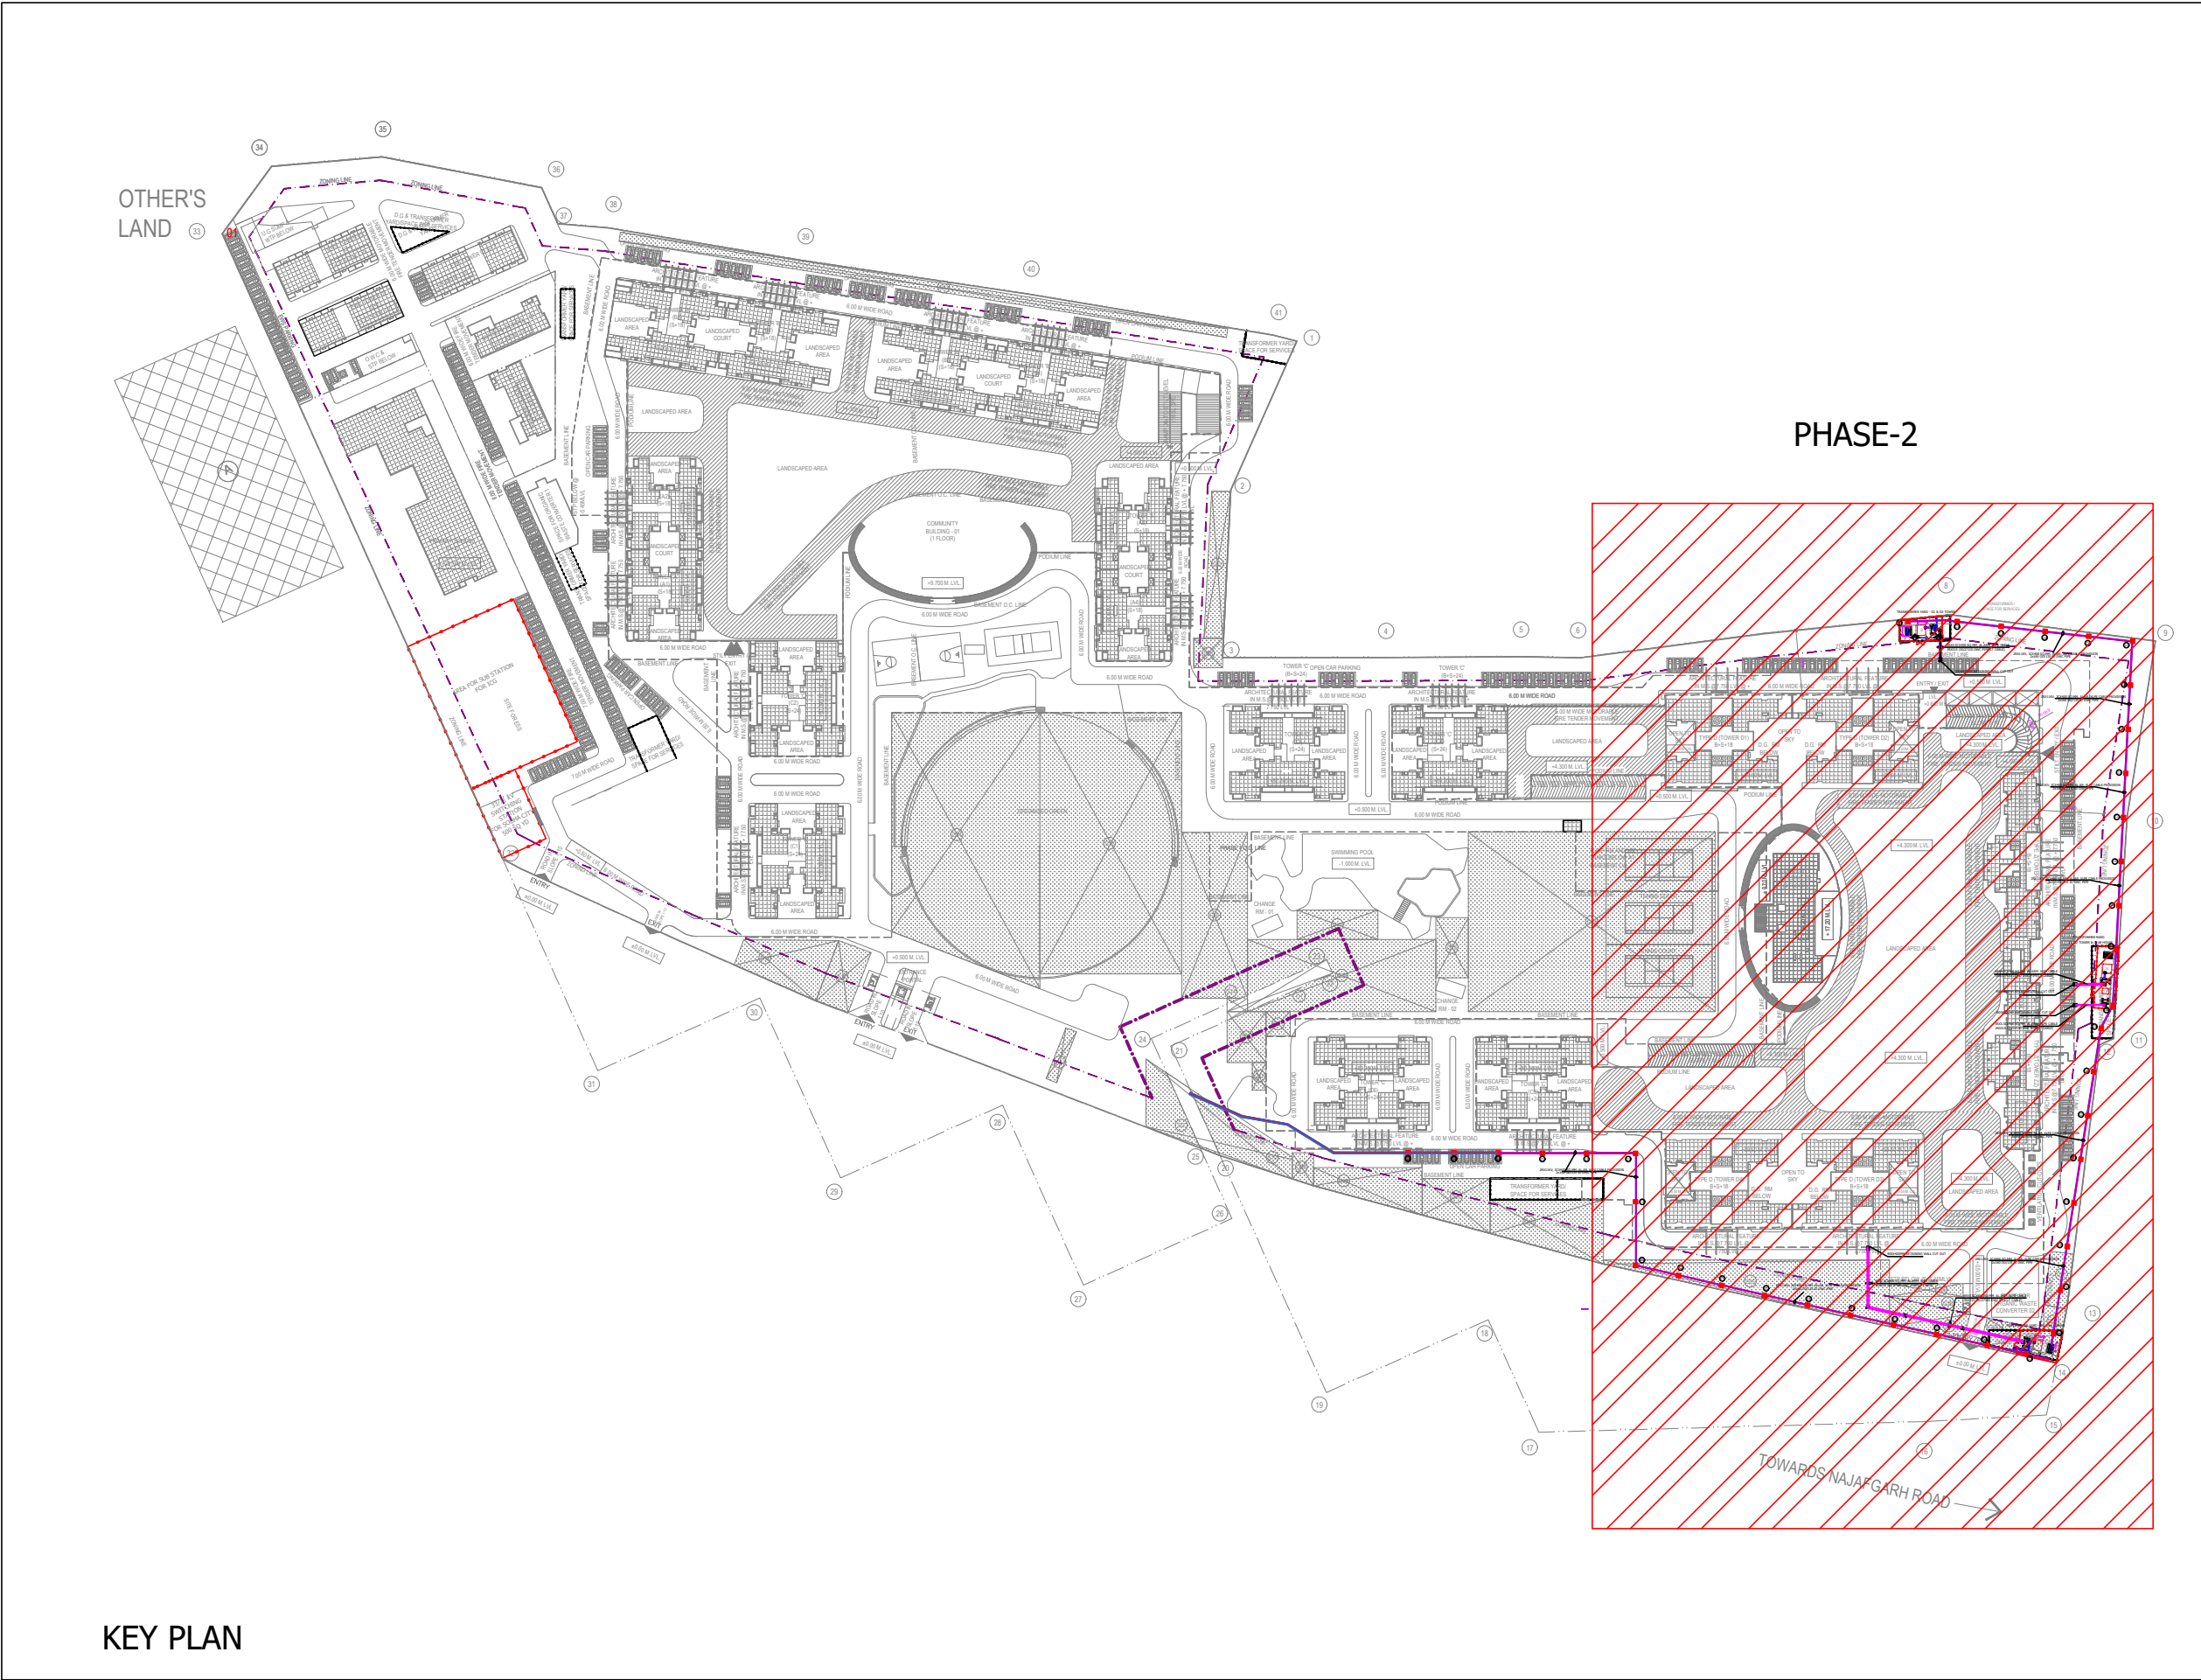

LEGEND	
SYMBOL	DESCRIPTION
	11KV, 3C4X80 sq.mm, ALARM, XLPE CABLE
	160 MM OD DIAx 138 MM ID CORRUGATED, HDPE DOUBLE WALLED
	315 OD / 271 ID DMC PIPE FOR LT CABLES
	1000X1000X1100 HT CHAMBER
	750X750X1100 LT CHAMBER

GENERAL NOTES

- ALL DIMENSIONS IN MM.
- FOLLOW WRITTEN DIMENSIONS ONLY.
- ANY DIMENSION NOTED IN THE PHS SHOULD BE BROUGHT TO THE NOTICE OF THE PHS DEPT WITH IN SEVEN DAYS.
- THESE CDS TO BE USED IN CONSTRUCTION WITH RELEVANT ARCHITECTURAL / STRUCTURAL DRAWINGS.

KEY PLAN:

REVISIONS

NO.	REV.	DATE	DESCRIPTION

REV. / DEALT. / DATE / DESCRIPTIONS

REV.	DEALT.	DATE	DESCRIPTIONS

SOBHA LIMITED.
SOBHA: REGD. & CORPORATE OFFICE,
SARAJAPUR - MARATHAHALLI OUTER RING ROAD (ORR),
DEVARABANAHALLI, BELLANDUR POST, BANGALORE - 560 103, INDIA.
TEL. (080) 40320000, E-mail: mapdesign@sobha.com

CONSULTANTS

ARCHITECTS	SL
STRUCTURAL	SL
MECHANICAL	SL
ELECTRICAL	SL
PAVING	SL
INFRASTRUCTURE	SL

DRAWING TITLE

'STREET LIGHTING LAYOUT FOR PHASE-2 (D1-D4 , Z1&Z2)

PROJECT TITLE

SOBHA CITY GURGAON-PHASE-II
RESIDENTIAL APARTMENTS
AT GURGAON

APPROVED BY

DEVARAKATHI
SUP. HEAD ELECTRICAL & HVAC

PROJECT NO. 0086

DEALT BY

MANIKANTAN

DATE: 17.08.2020

SCALE: 1:500 (B-2)

DWG. NO. 11.02

REV. NO. 01

DATE: 17.08.2020

REV. NO. 01

NORTH