


This drawing is a "COPYRIGHT" contents of this drawing or part reproduced without the permission of the Architect.

ISSUED TO	DATE	REVISION	DESCRIPTION	BY

GENERAL NOTES
 1. All dimensions are in mm unless mentioned otherwise
 2. No dimensions are to be scaled from this drawing.

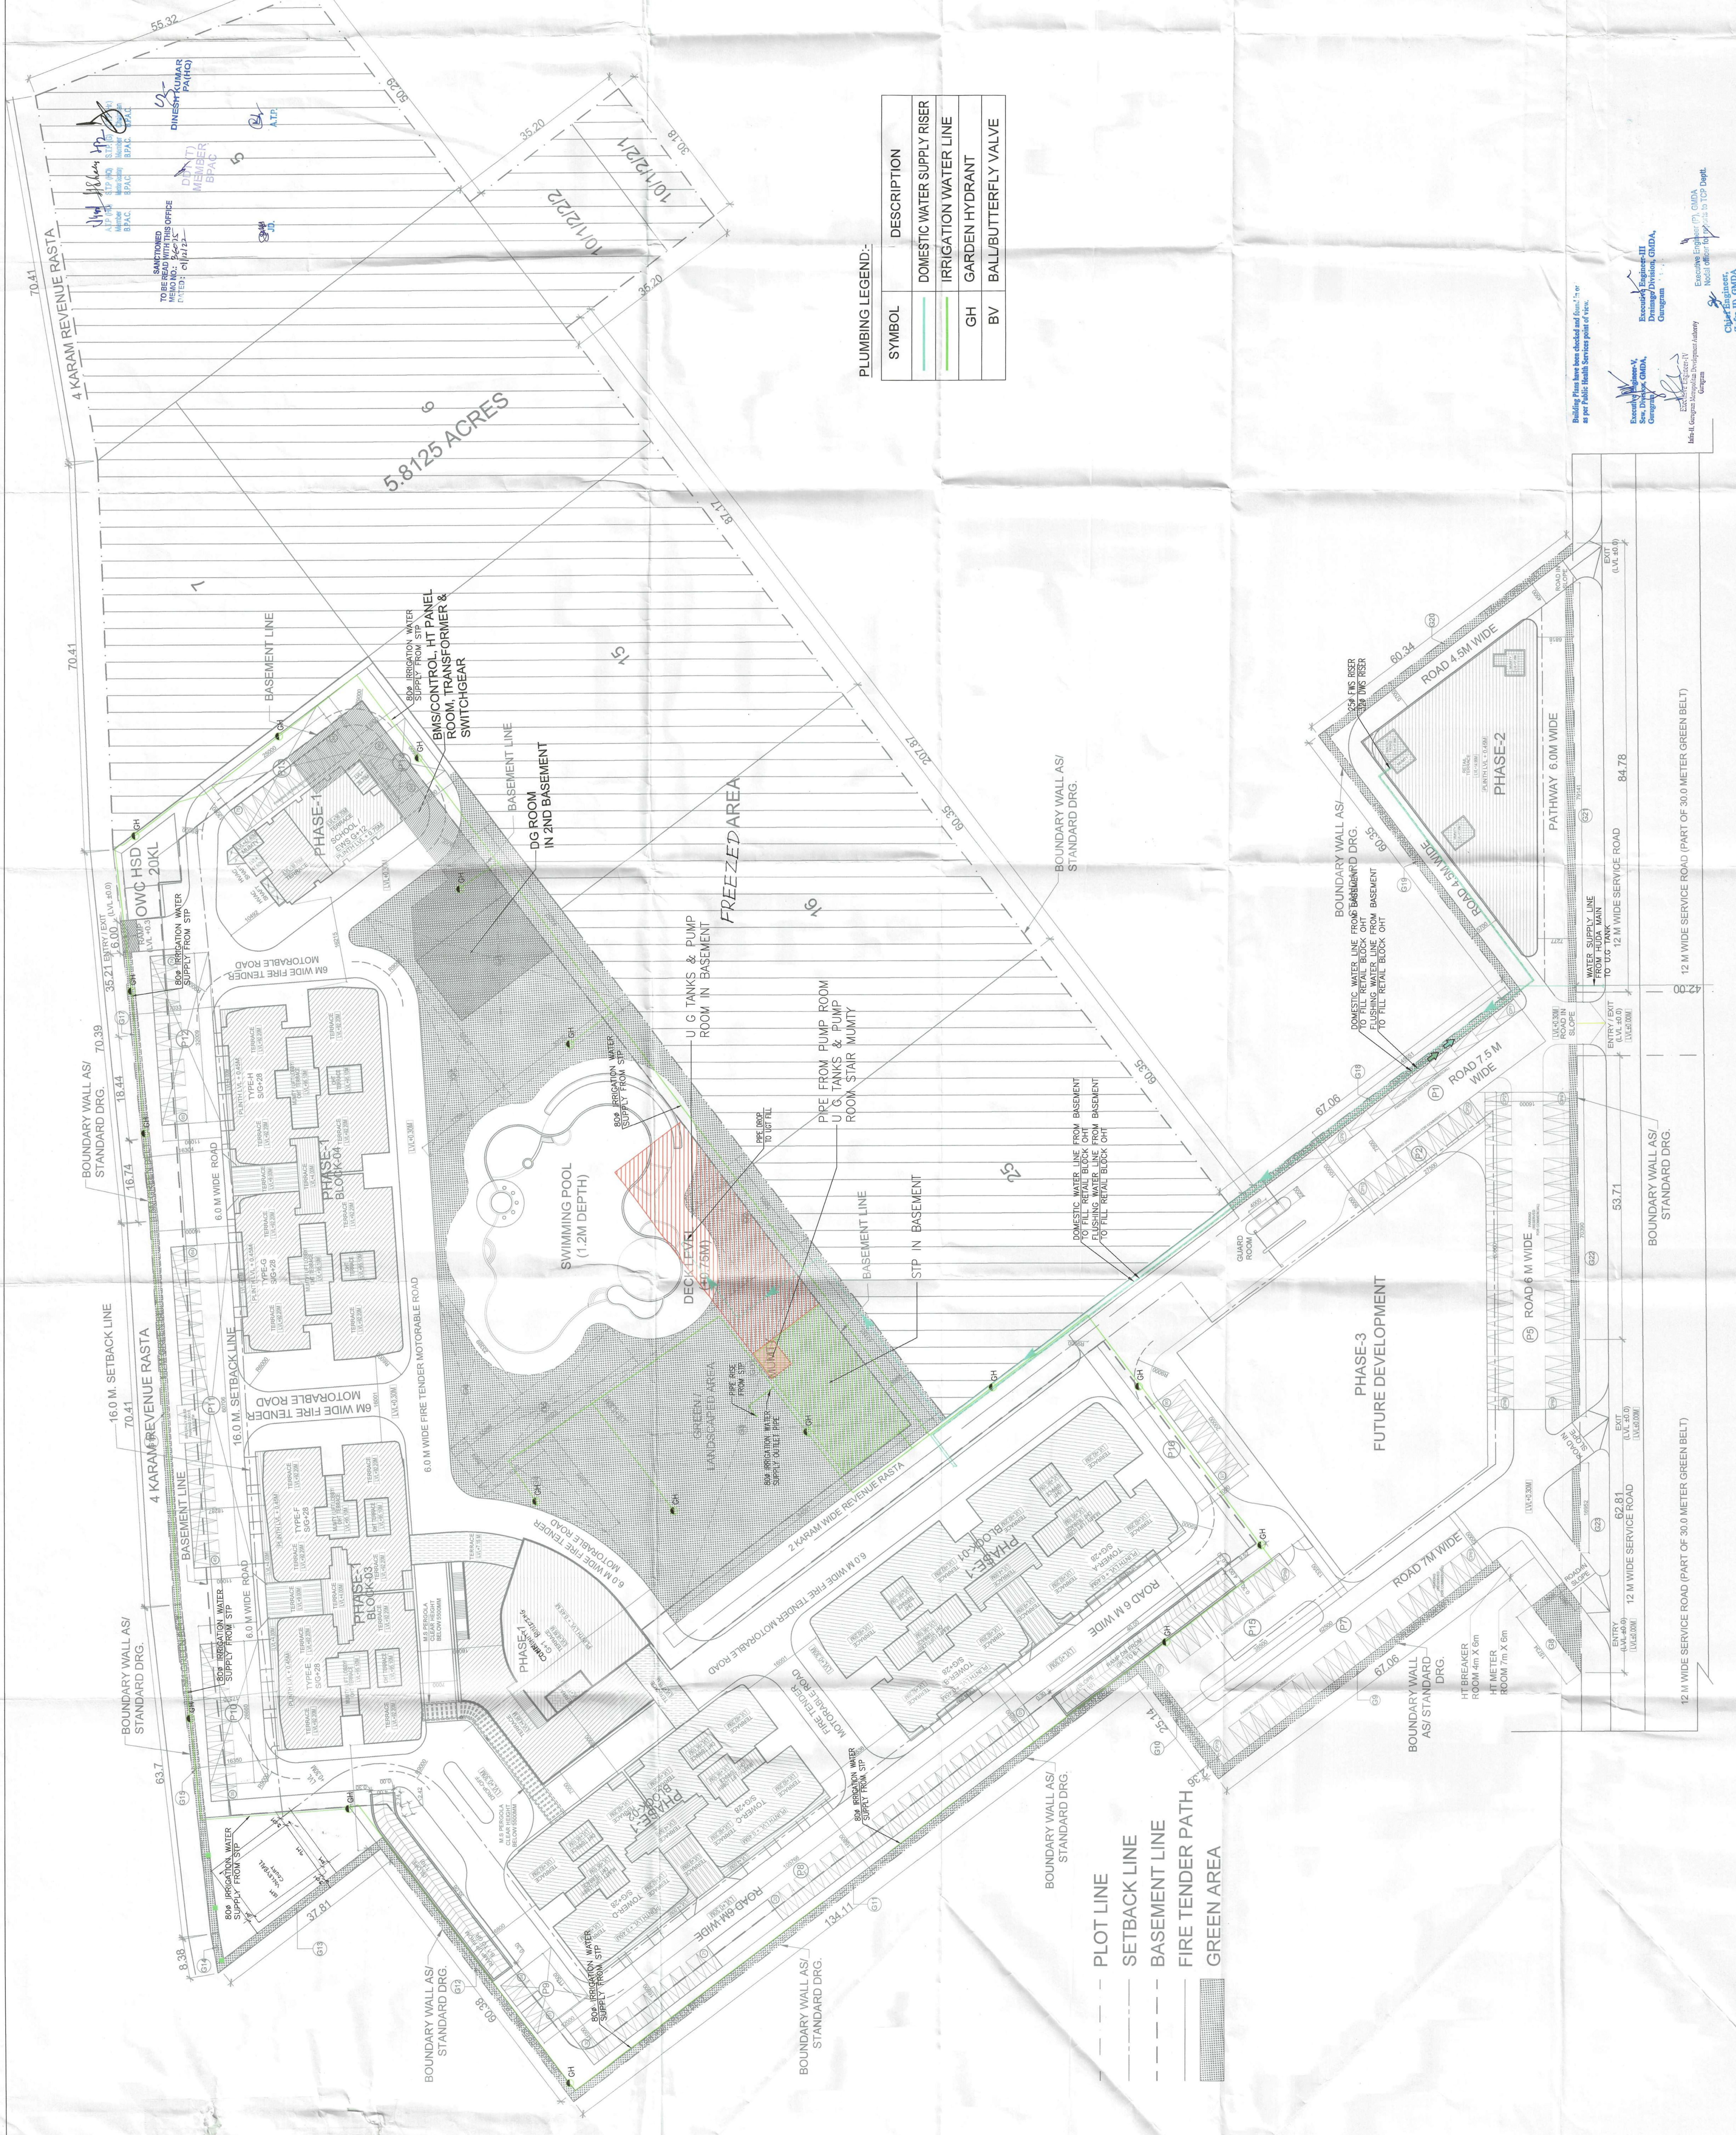

PLUMBING LEGEND:-

SYMBOL	DESCRIPTION
— (Red line)	DOMESTIC WATER SUPPLY RISER
— (Green line)	IRRIGATION WATER LINE
— (Blue line)	GARDEN HYDRANT
— (Black line)	BALL BUTTERFLY VALVE

SUBMISSION DRAWINGS
 COUNTY: NOURISH DEVELOPERS PVT. LTD.
 PROJECT: BUILDING PLAN FOR RESIDENTIAL COLONY UNDER TDD POLICY ON THE AREA MEASURING 5.8125 ACRES FREEZING OF AN AREA MEASURING 5.8125 ACRES FOR THE PURPOSE OF CONSTRUCTION OF COMPACT POCKET (DUE TO NCT), LICENSE NO. 106 OF 2022, DATED 5/8/2022 AT SECTOR-113, DISTRICT GURUGRAM, HARYANA BEING DEVELOPED BY NOURISH DEVELOPERS PVT. LTD.

DATE: SEP. 2022
 CHECKED BY: DEEPAK AGARWAL
 SCALE: 1:500
 DEALT BY: SHANVI GARG
 APPROVED BY: DEEPAK AGARWAL

DRAWING TITLE
 SITE PLAN : WATER SUPPLY LAYOUT

OWNERS SIGN
 ARCHITECTS SIGN

ARCHITECTS
 C. P. KUKREJA ARCHITECTS
 ASHRWAAD BUILDING,
 D-1 GREEN PARK,
 NEW DELHI - 110016
 TEL: 011-26865770
 FAX: 011-26865770
 EMAIL: cpk@cpkarchitects.com

DRAWING NO.
 210205ND-1195UB-LAT-EST-151E-PLAN-SP03

DRG. NO.
 1C