
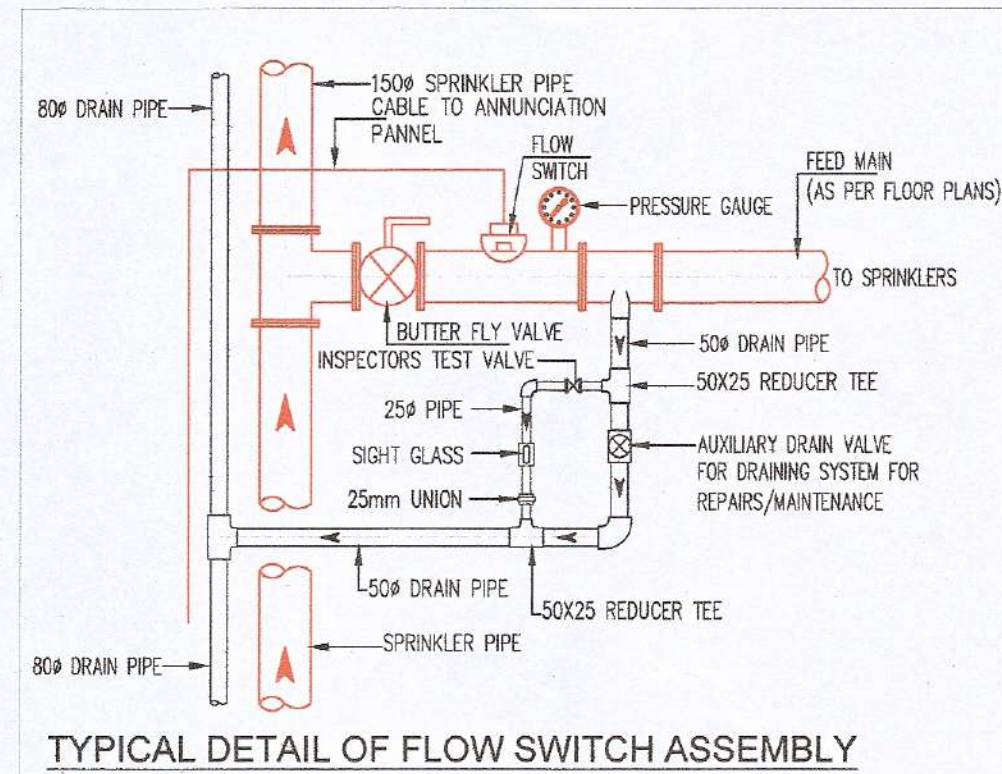
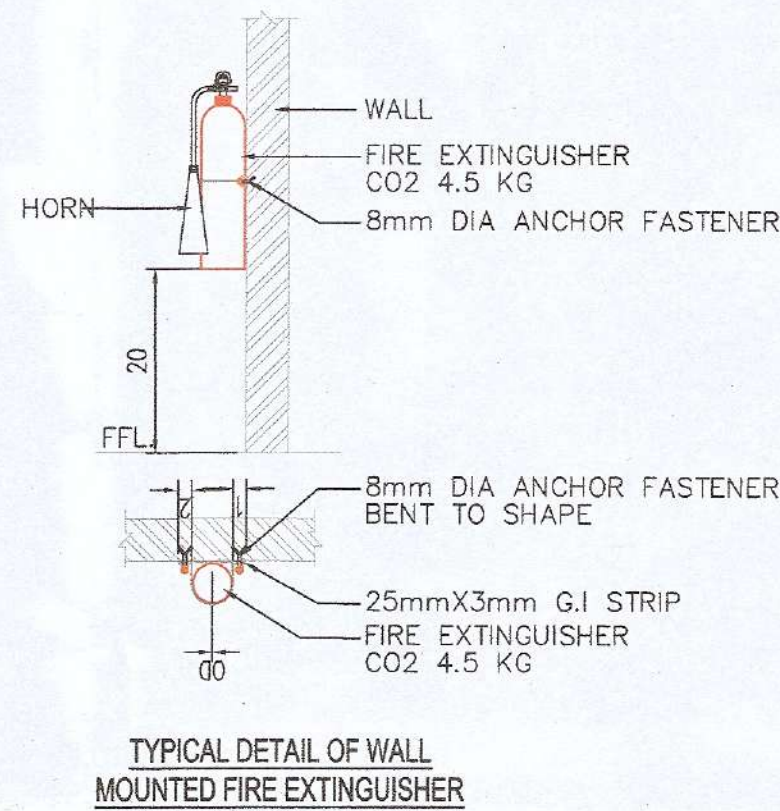


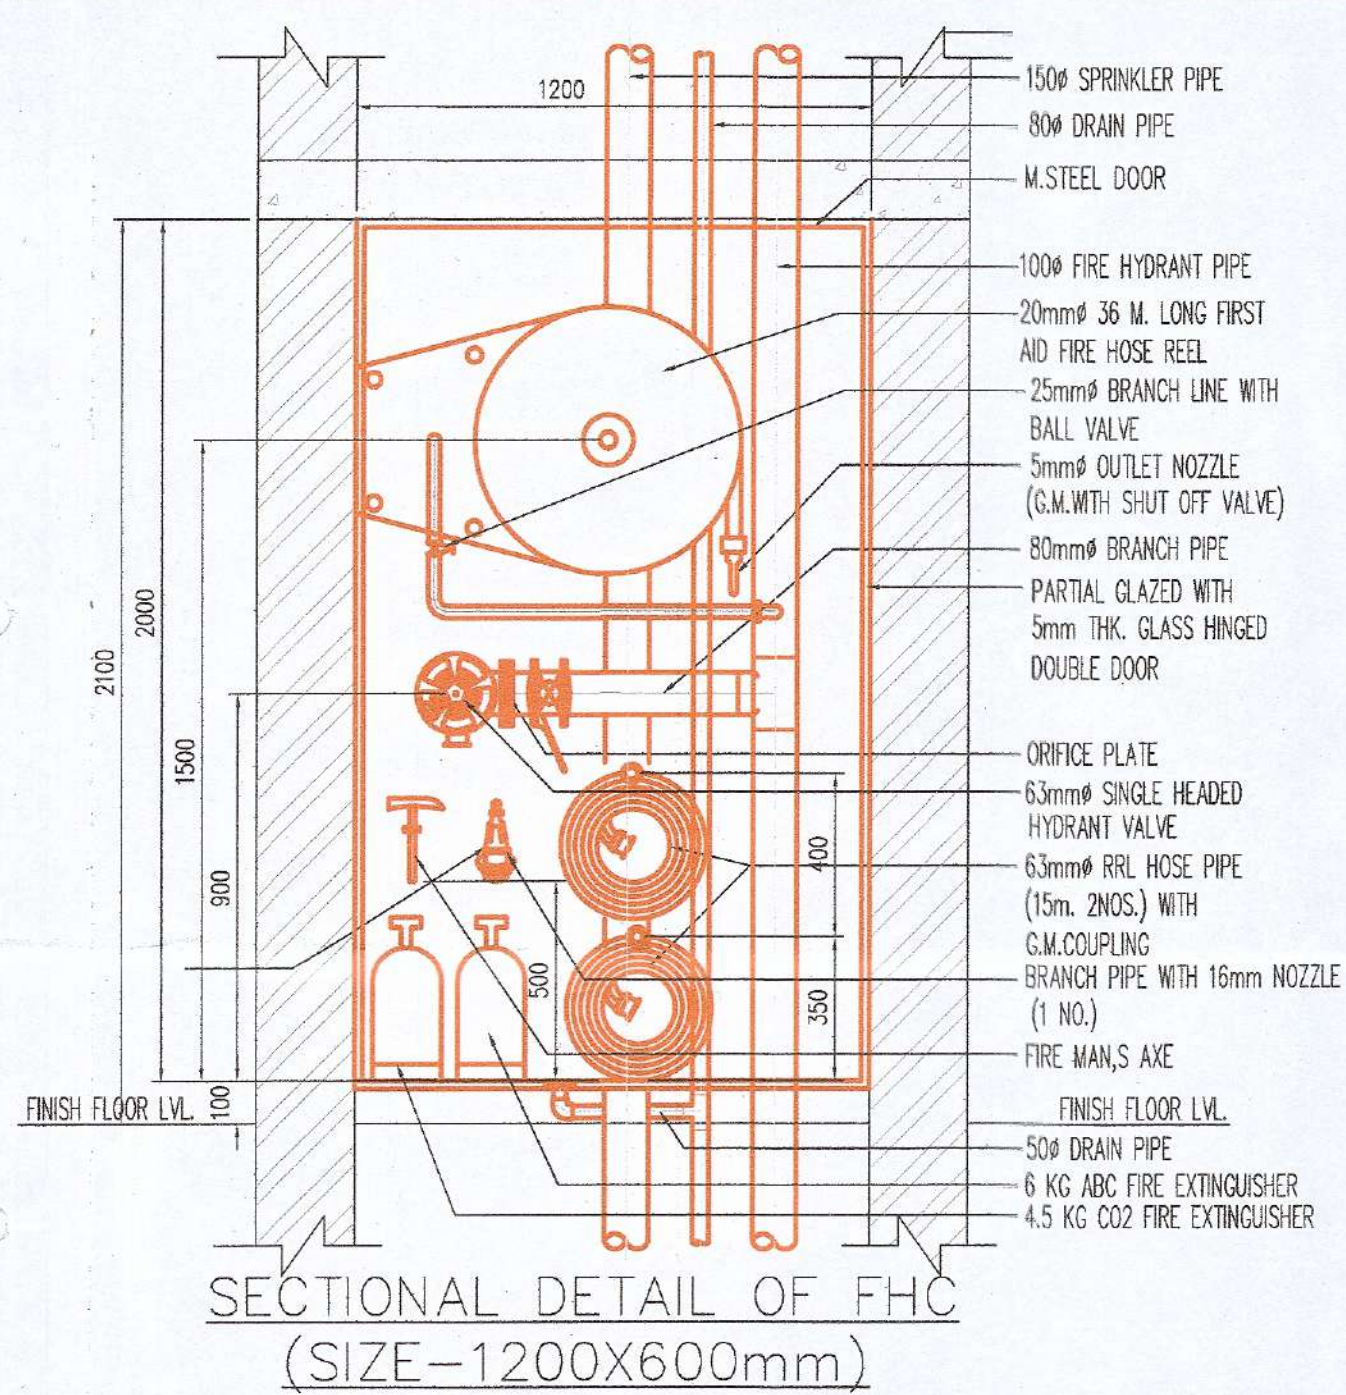


FIRE ALARM LEGEND		
SYMBOL	DESCRIPTION	HEIGHT FROM IN mm
	ZONE MONITOR MODULE	AS PER SITE COORDINATION
	SMOKE DETECTOR	C.M./F.C.M
	MANUAL BREAK GLASS UNIT	1200mm.
	FIRE ALARM HOOTER CUM SPEAKER/SSTROBE	2100mm.
	CEILING SPEAKER	C.M./F.C.M
	FIRE TELEPHONE JACK	1200mm.
	CONTROL MODULE	AS PER SITE COORDINATION
	MONITOR MODULE	AS PER SITE COORDINATION

LEGEND :-	
SYMBOL	DESCRIPTION
	100mm FIRE HYDRANT PIPE FOR LOWER ZONE
	100mm FIRE HYDRANT PIPE FOR UPPER ZONE
	150mm FIRE SPRINKLER PIPE FOR LOWER ZONE
	150mm FIRE SPRINKLER PIPE FOR UPPER ZONE
	80mm SPRINKLER DRAIN PIPE
	BUTTER FLY VALVE
	NON RETURN VALE
	AIR RELIEF VALVE
	PENDENT TYPE SPRINKLER MODEL K-5.6(80.6)
	UPRIGHT TYPE SPRINKLER MODEL K-5.6(80.6)
	SIDE WALL TYPE SPRINKLER MODEL K-5.6(80.6)
	FIRE HOSE CABINET WITH SINGLE OUTLET LANDING VALVE, 2 NOS. RRL HOSE PIPES, BRANCH PIPE WITH NOZZLE & FIRST AID HOSE REEL
	4.5 kg. CO2 TYPE FIRE EXTINGUISHER
	8kg ABC TYPE FIRE EXTINGUISHER
	SPRINKLER PIPE
	FIRE HYDRANT PIPE
	FIRE MAN'S AXE STAINLESS STEEL 1kg
	FLOW SWITCH
	ORIFICE PLATE- STAINLESS STEEL 6mm
	4.5 kg. CO2 TYPE FIRE EXTINGUISHER ON WALL (1M HIGH ABOVE FFL)
	FIRE DOOR 1 HR. FIRE RATING DOOR
	FIRE DOOR 1 HR. FIRE RATING DOOR
	FIRE DOOR 1 HR. FIRE RATING DOOR

NORTH POINT			
N	E	S	W
NO. OF PRINTS	DATE	ISSUED TO	REMARKS
REVISION	DATE	DESCRIPTION	BY

GENERAL NOTES

- All dimensions are in mm unless mentioned otherwise
- No dimensions are to be scaled from this drawing.

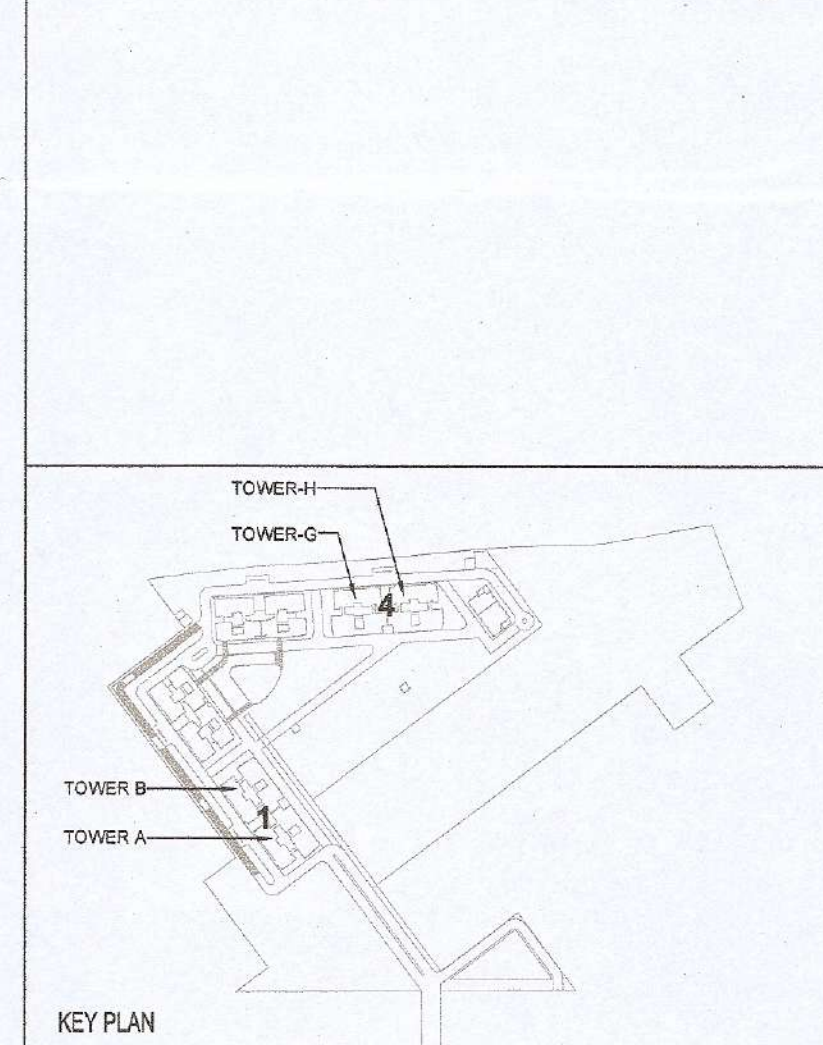

FIRE SUBMISSION DRAWING

CLIENT:
NOURISH DEVELOPERS PVT. LTD.

PROJECT:
BUILDING PLAN FOR RESIDENTIAL COLONY UNDER TDP POLICY - ON THE AREA MEASURING 10.30 ACRES (AFTER FREEZING OF AN AREA MEASURING 5.8125 ACRES (48K-10M) FALLING UNDER NCZ AND NON COMPACT POCKET DUE TO NCZ) (LICENCE NO. 106 OF 2022, DATED 5/8/2022 AT SECTOR-113 DISTRICT GURUGRAM, HARYANA BEING DEVELOPED BY NOURISH DEVELOPERS PVT. LTD.

DATE	CHECKED BY	PROJECT ARCH.
SEP. 2022	PRAMOD SINGH	DEEPAK AGARWAL
SCALE	DEALT BY	APPROVED BY
1:125	NEGI	YASHVEER SINGH

DRAWING TITLE
TOWER A AND TOWER B (BLOCK 1)
TYPICAL FLOOR PLAN (3rd-5th, 7th, 9th, 11th-18th, & 20th-25th)
FIRE FIGHTING SYSTEM AND FIRE ALARM SYSTEM LAYOUT
TOWER- G & H (BLOCK 4) IS SIMILAR BUT MIRRORED (FOR FIRE SUBMISSION)


OWNER'S SIGN.
Certified that these plans are as per original plans approved by DG, TCP, Chandigarh
Vide Memo No. 2P-1632/PA (CDK) 2022/36375
Dated- 01-12-2022
Authorised Signatory

ARCHITECT'S SIGN.

ARCHITECTS:-
C. P. KUKREJA ARCHITECTS
ASHIRWAD BUILDING,
D-1, GREEN PARK,
NEW DELHI - 110016
PHONE :- 011 26863953 FAX :- 011 26865770
EMAIL-cpk@cukukreja.com

MEP CONSULTANT:-
C. P. KUKREJA ARCHITECTS
ASHIRWAD BUILDING,
D-1, GREEN PARK,
NEW DELHI - 110016
PHONE :- 011 26863953 FAX :- 011 26865770
EMAIL-cpk@cukukreja.com

DRAWING NO.
21020/SWD-113/SUB./LATEST/BLOCK-01&04/F-TYP
CAD NO.

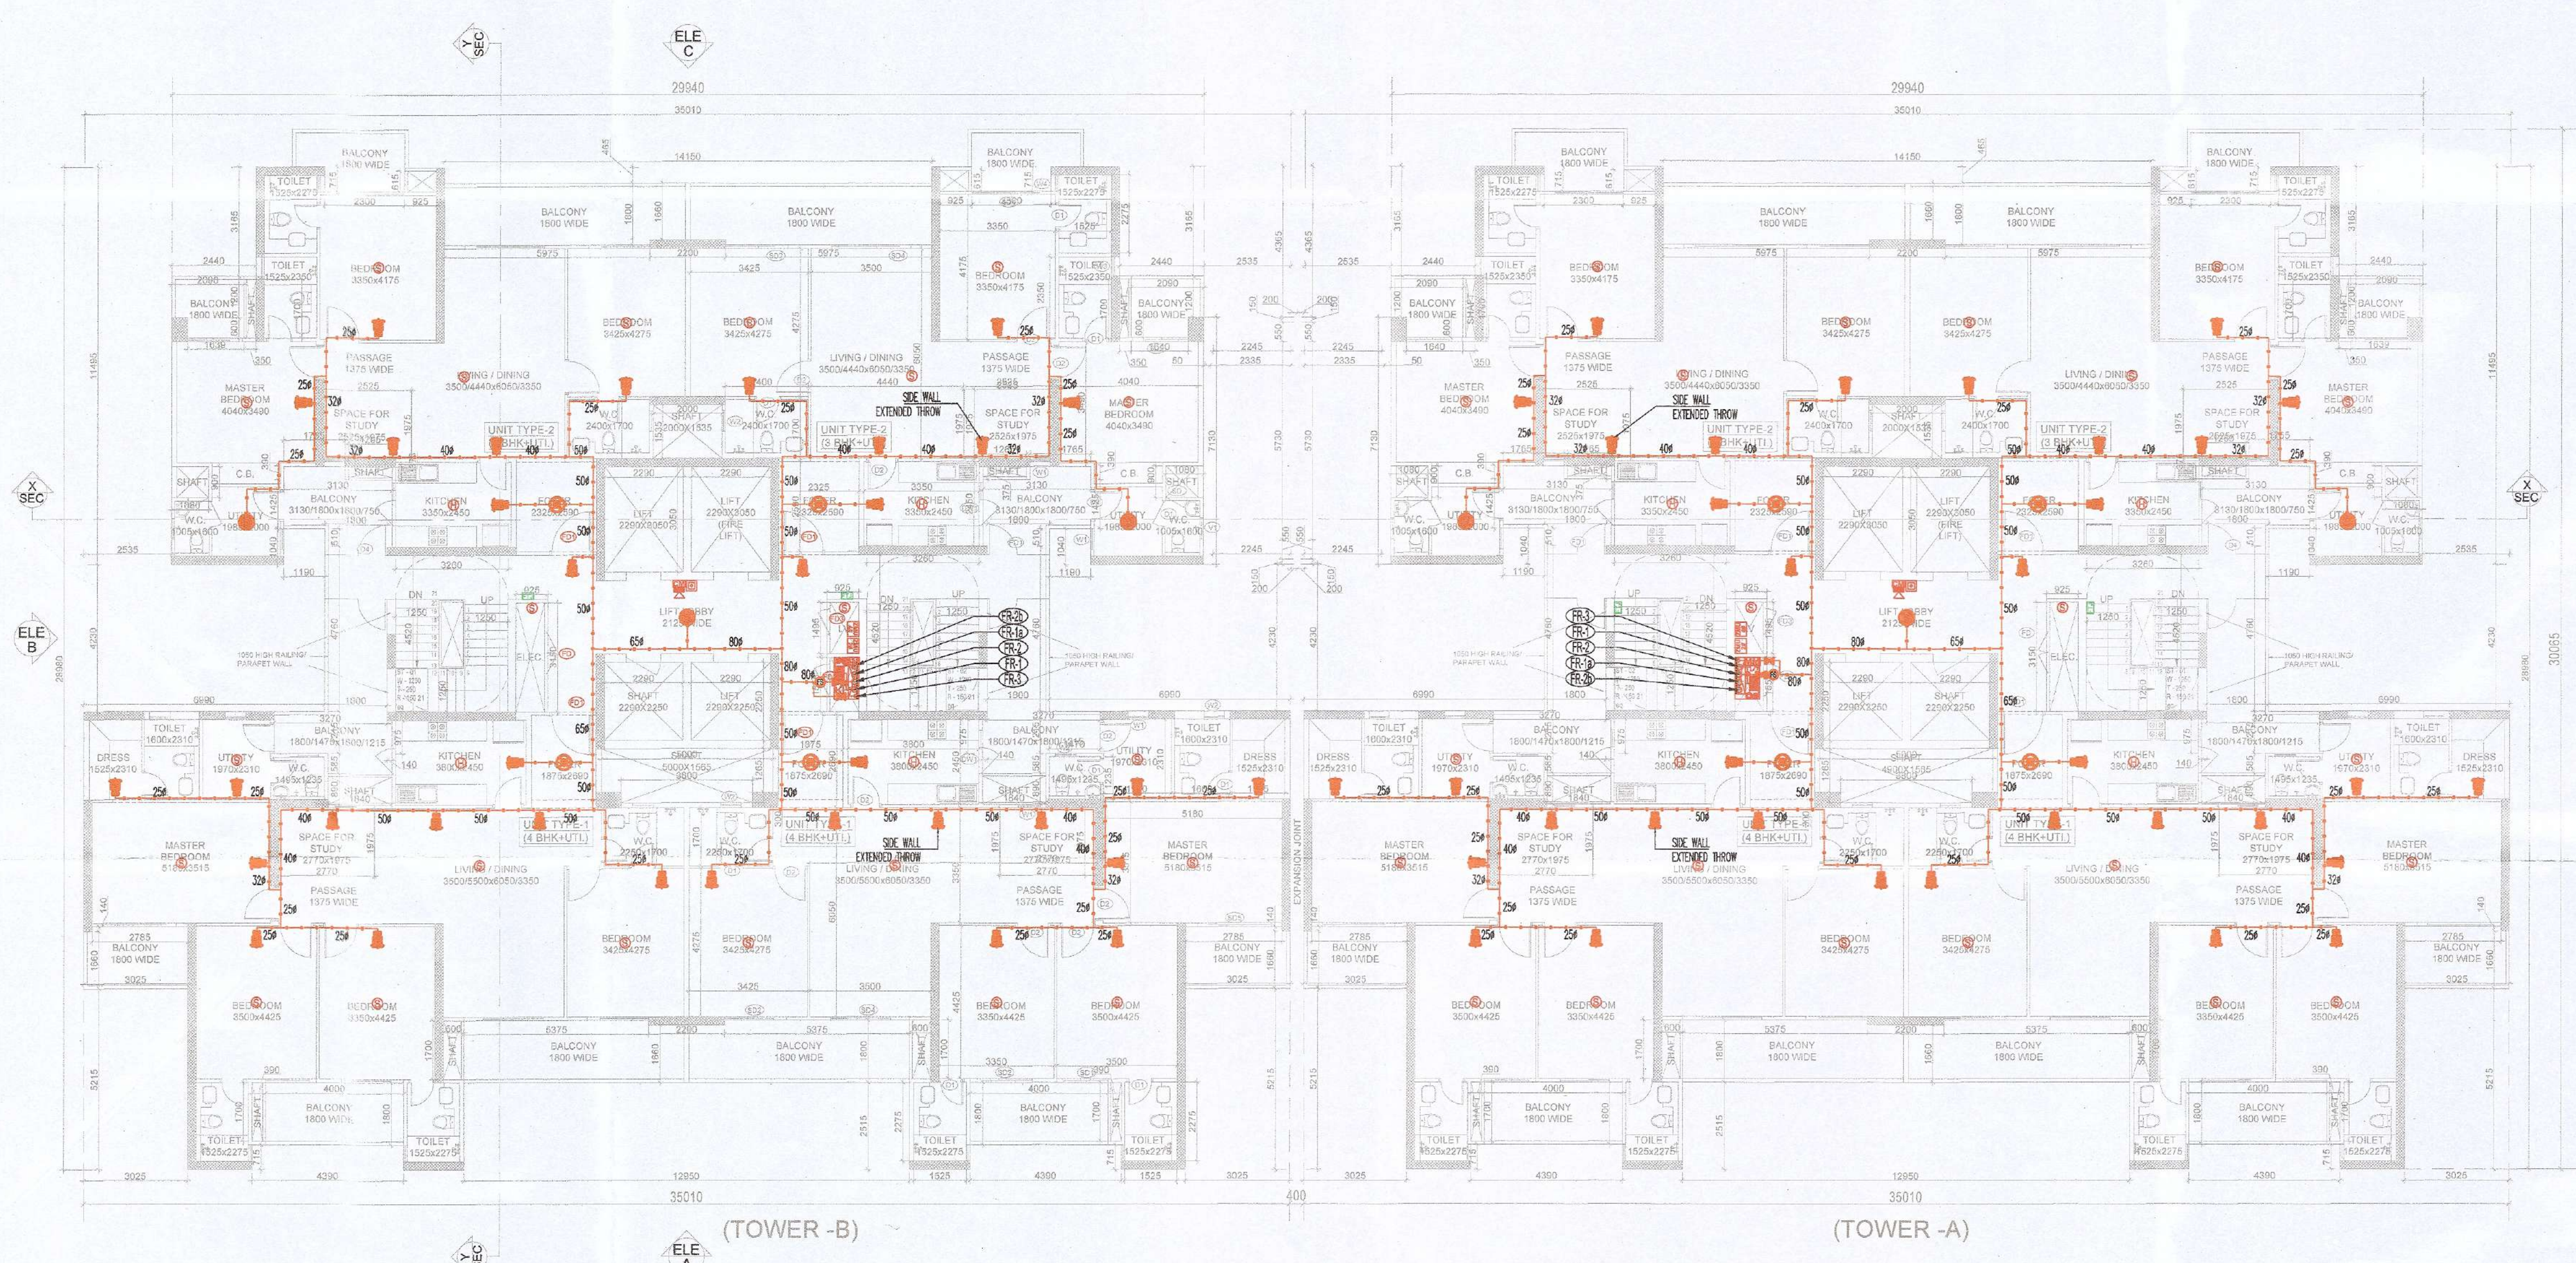

TYPICAL FLOOR PLAN - (3rd-5th 7th 9th 11th-18th)