
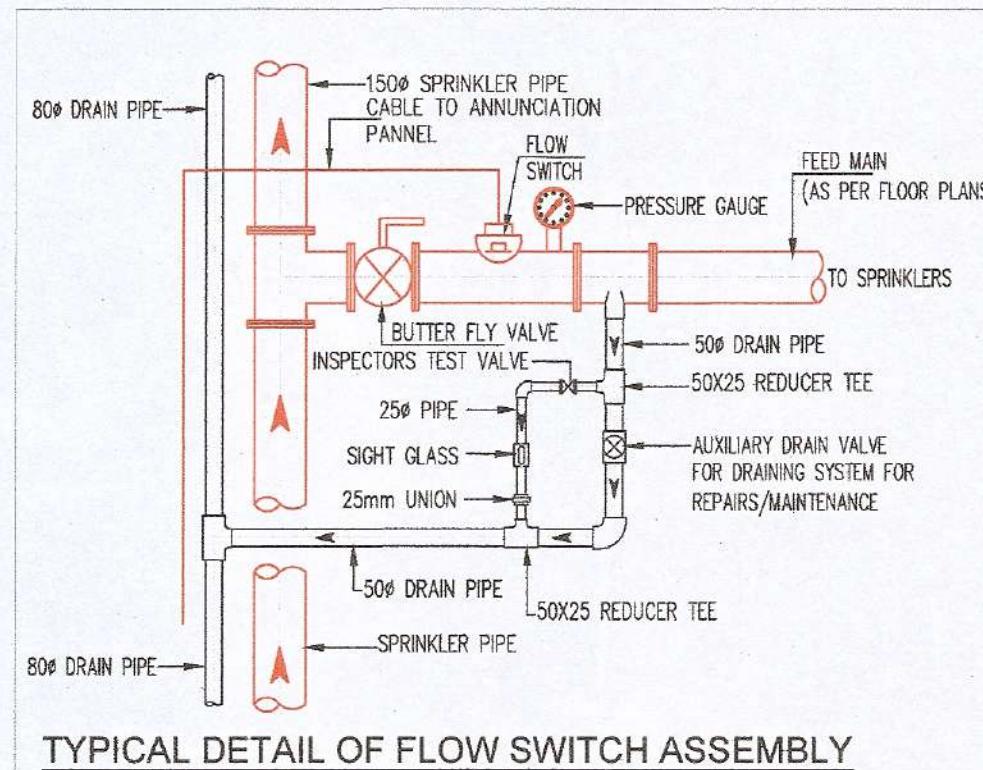
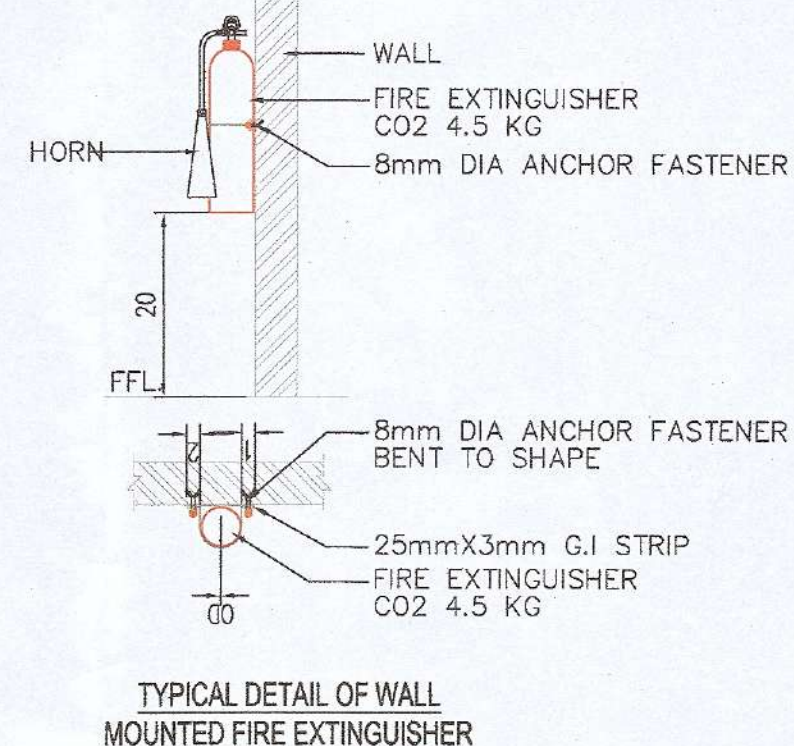


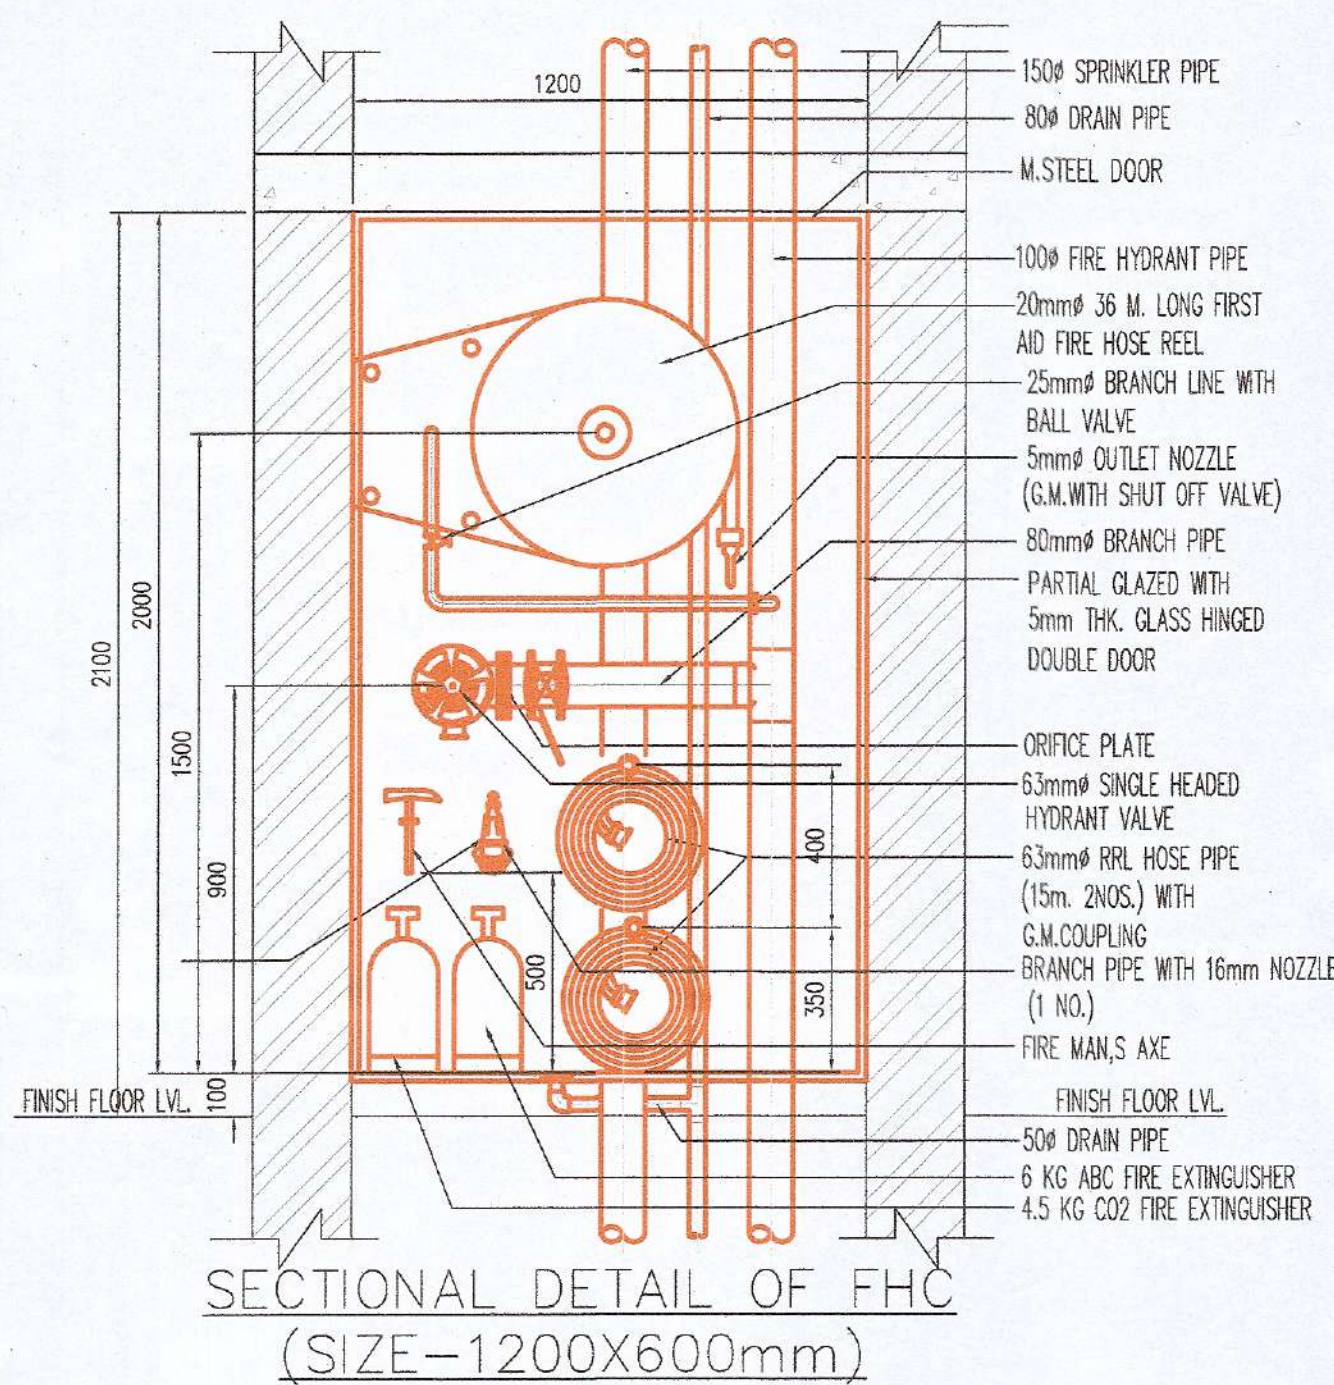


FIRE ALARM LEGEND		
SYMBOL	DESCRIPTION	HEIGHT FROM IN mm.
	ZONE MONITOR MODULE	AS PER SITE COORDINATION
	SMOKE DETECTOR	C.M./F.C.M
	FIRE ALARM HOOTER CUM SPEAKER/SSTROBE	1200mm.
	CEILING SPEAKER	2100mm.
	FIRE TELEPHONE JACK	C.M./F.C.M
	CONTROL MODULE	AS PER SITE COORDINATION
	MONITOR MODULE	AS PER SITE COORDINATION

LEGEND :-	
SYMBOL	DESCRIPTION
	100% FIRE HYDRANT PIPE FOR LOWER ZONE
	100% FIRE HYDRANT PIPE FOR UPPER ZONE
	150mm FIRE SPRINKLER PIPE FOR LOWER ZONE
	150mm FIRE SPRINKLER PIPE FOR UPPER ZONE
	80% SPRINKLER DRAIN PIPE
	BUTTER FLY VALVE
	NON RETURN VALVE
	AIR RELIEF VALVE
	PENDENT TYPE SPRINKLER MODEL K-5.6(80.6)
	UPRIGHT TYPE SPRINKLER MODEL K-5.6(80.6)
	SIDE WALL TYPE SPRINKLER MODEL K-5.6(80.6)
	FIRE HOSE CABINET WITH SINGLE OUTLET LANDING VALVE, 2 NOS. RRL HOSE PIPES, BRANCH PIPE WITH NOZZLE & FIRST AID HOSE REEL
	4.5 kg. CO2 TYPE FIRE EXTINGUISHER
	8kg ABC TYPE FIRE EXTINGUISHER
	SPRINKLER PIPE
	FIRE HYDRANT PIPE
	FIRE MAN'S AXE STAINLESS STEEL 1kg
	FLOW SWITCH
	ORIFICE PLATE- STAINLESS STEEL 6mm
	4.5 kg. CO2 TYPE FIRE EXTINGUISHER ON WALL (1M HIGH ABOVE FFL)
	FIRE DOOR 1 HR. FIRE RATING DOOR
	FIRE DOOR 1 HR. FIRE RATING DOOR
	FIRE DOOR 1 HR. FIRE RATING DOOR

REVISION			
NO. OF PRINTS	DATE	ISSUED TO	REMARKS
REVISION	DATE	DESCRIPTION	BY

GENERAL NOTES

- All dimensions are in mm unless mentioned otherwise.
- No dimensions are to be scaled from this drawing.

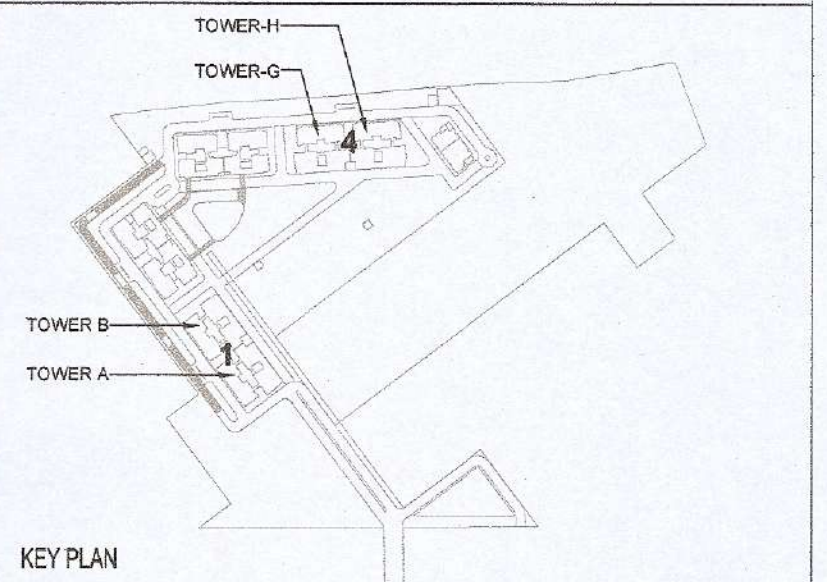

KEY PLAN

FIRE SUBMISSION DRAWING

CLIENT:
NOURISH DEVELOPERS PVT. LTD.

PROJECT:
BUILDING PLAN FOR RESIDENTIAL COLONY UNDER TAD POLICY - ON THE AREA MEASURING 10.30 ACRES (AFTER FREEZING OF AN AREA MEASURING 5.8125 ACRES (46K-10M) FALLING UNDER NCZ AND NON COMPACT POCKET DUE TO NCZ) (LICENCE NO. 106 OF 2022, DATED 5/8/2022 AT SECTOR-113 DISTRICT GURUGRAM, HARYANA BEING DEVELOPED BY NOURISH DEVELOPERS PVT. LTD.

DATE	CHECKED BY	PROJECT ARCH.
SEP. 2022	PRAMOD SINGH	DEEPAK AGARWAL
SCALE	DEALT BY	APPROVED BY
1:125	NEGI	YASHVEER SINGH

DRAWING TITLE
TOWER A AND TOWER B (BLOCK 1)
10TH FLOOR PLAN
FIRE FIGHTING SYSTEM AND FIRE ALARM SYSTEM LAYOUT
TOWER- G & H (BLOCK 4) IS SIMILAR BUT MIRRORRED (FOR FIRE SUBMISSION)

OWNER'S SIGN.


Certified that these plans are as per original plans approved by DG, TCP, Chandigarh
Vide Memo No. 20-1632/PA/CL/2022/36075
Date: 01-12-2022
Authorized Signatory

ARCHITECT'S SIGN.

C. P. KUKREJA ARCHITECTS

ARCHITECTS-
C. P. KUKREJA ARCHITECTS
ASHIRWAD BUILDING,
D-1, GREEN PARK,
NEW DELHI - 110016
PHONE :- 011 26863953 FAX :- 011 26865770
EMAIL-cpk-a@cpkukreja.com

MEP CONSULTANT:-
C. P. KUKREJA ARCHITECTS
ASHIRWAD BUILDING,
D-1, GREEN PARK,
NEW DELHI - 110016
PHONE :- 011 26863953 FAX :- 011 26865770
EMAIL-cpk-a@cpkukreja.com

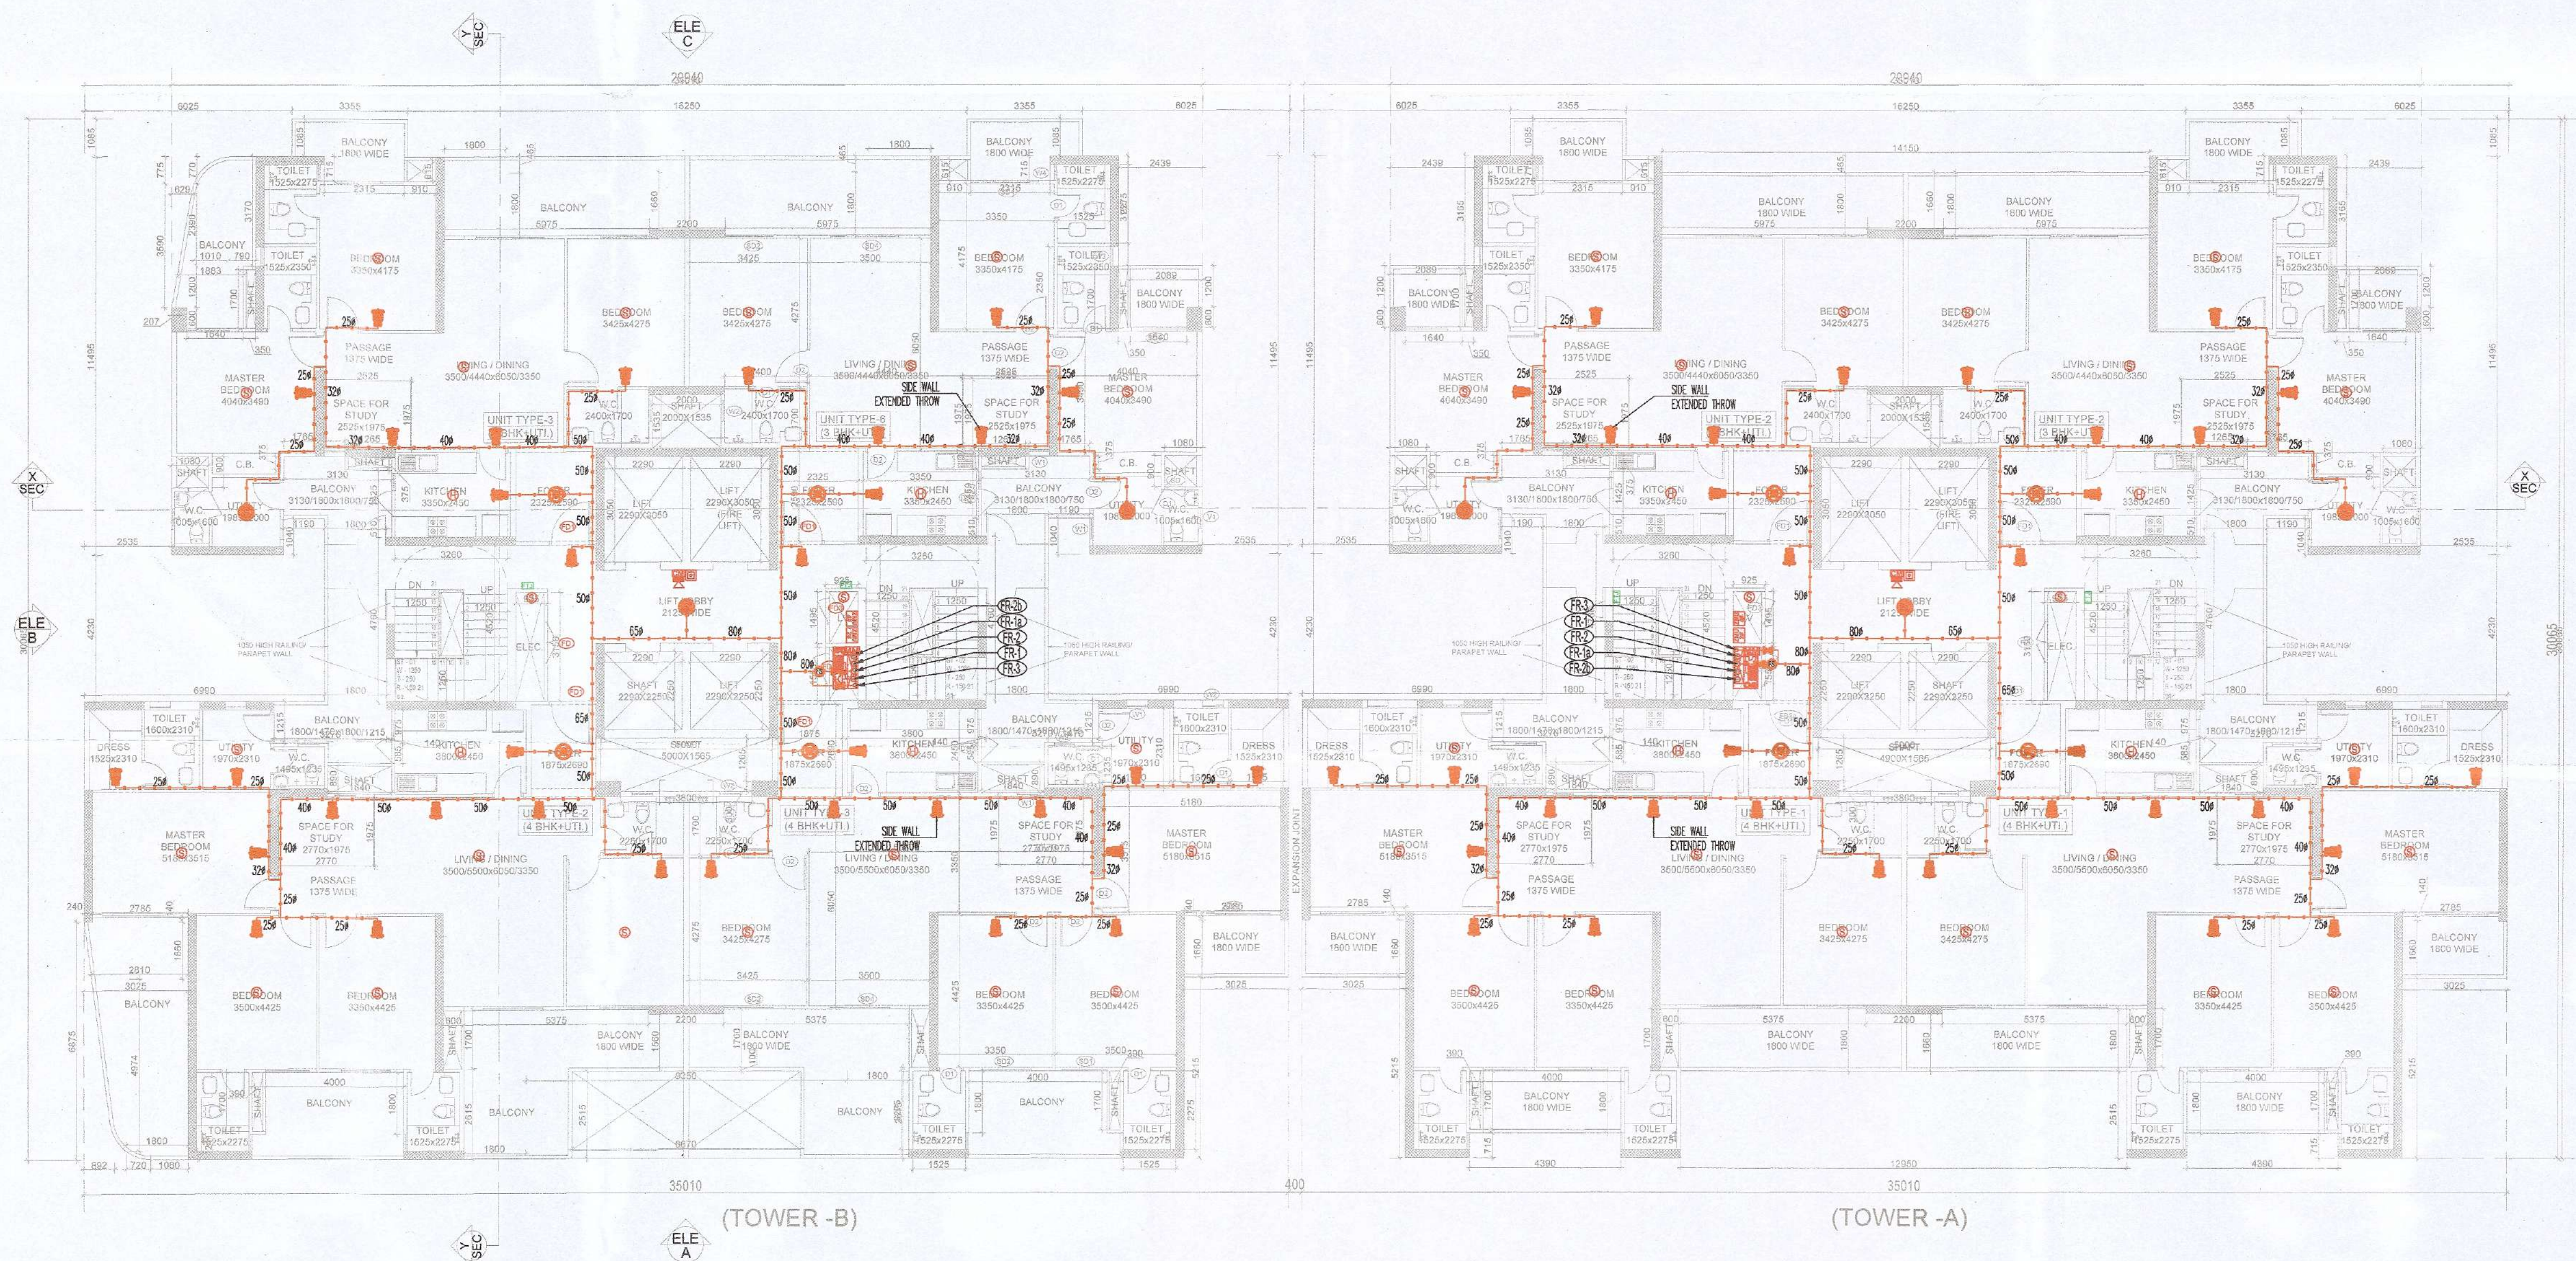

10th FLOOR PLAN