
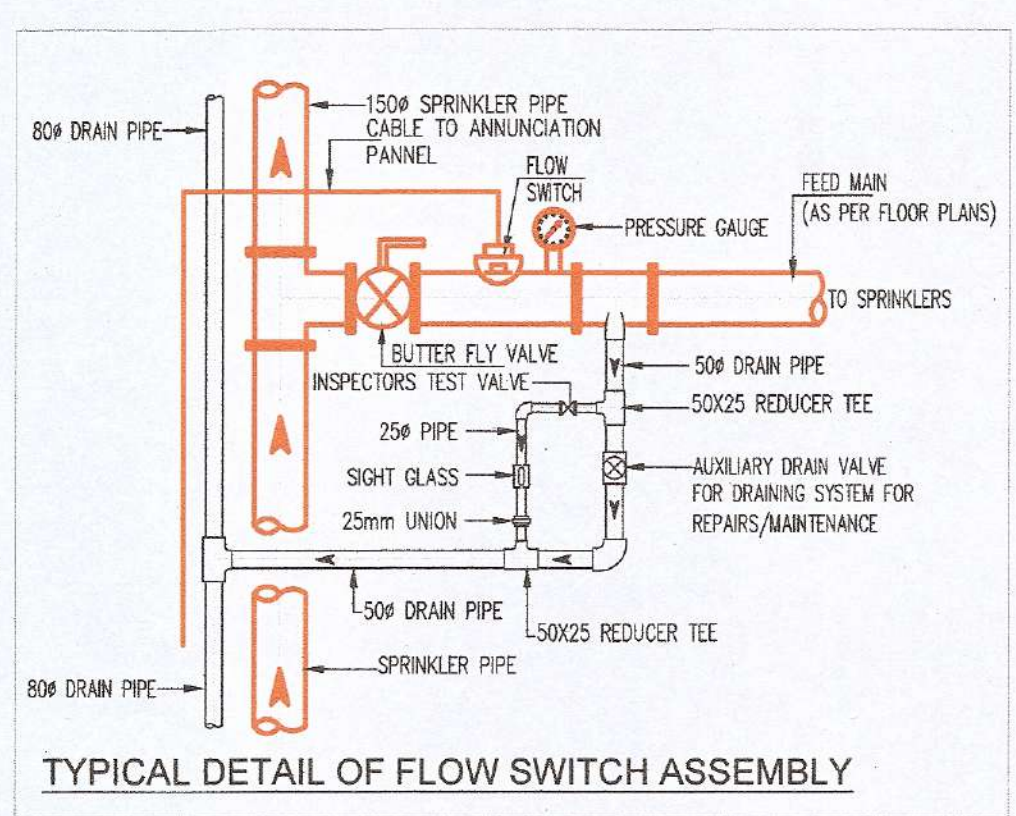
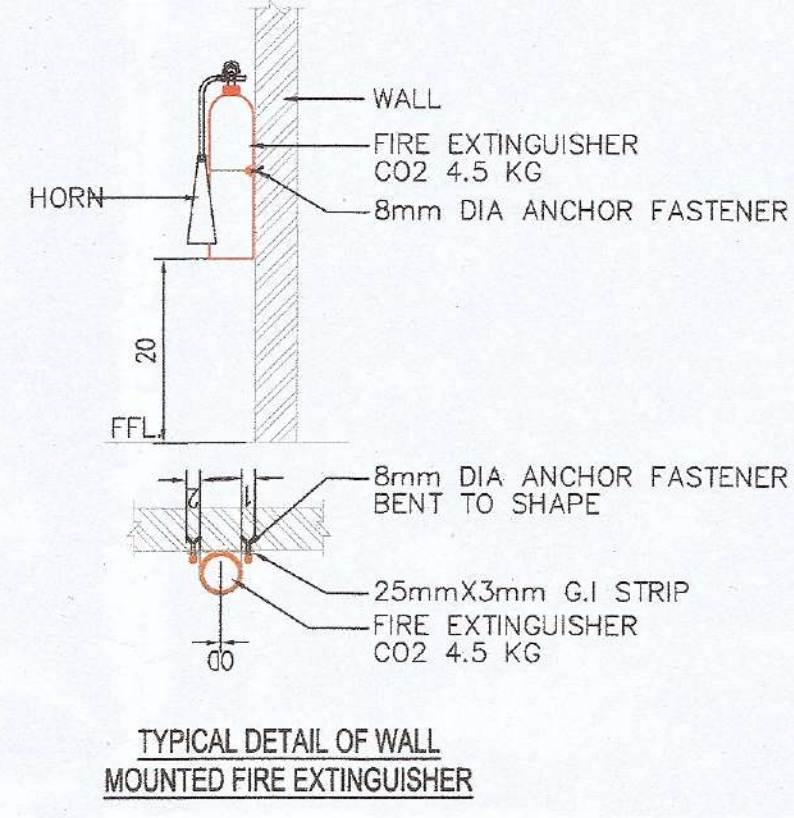


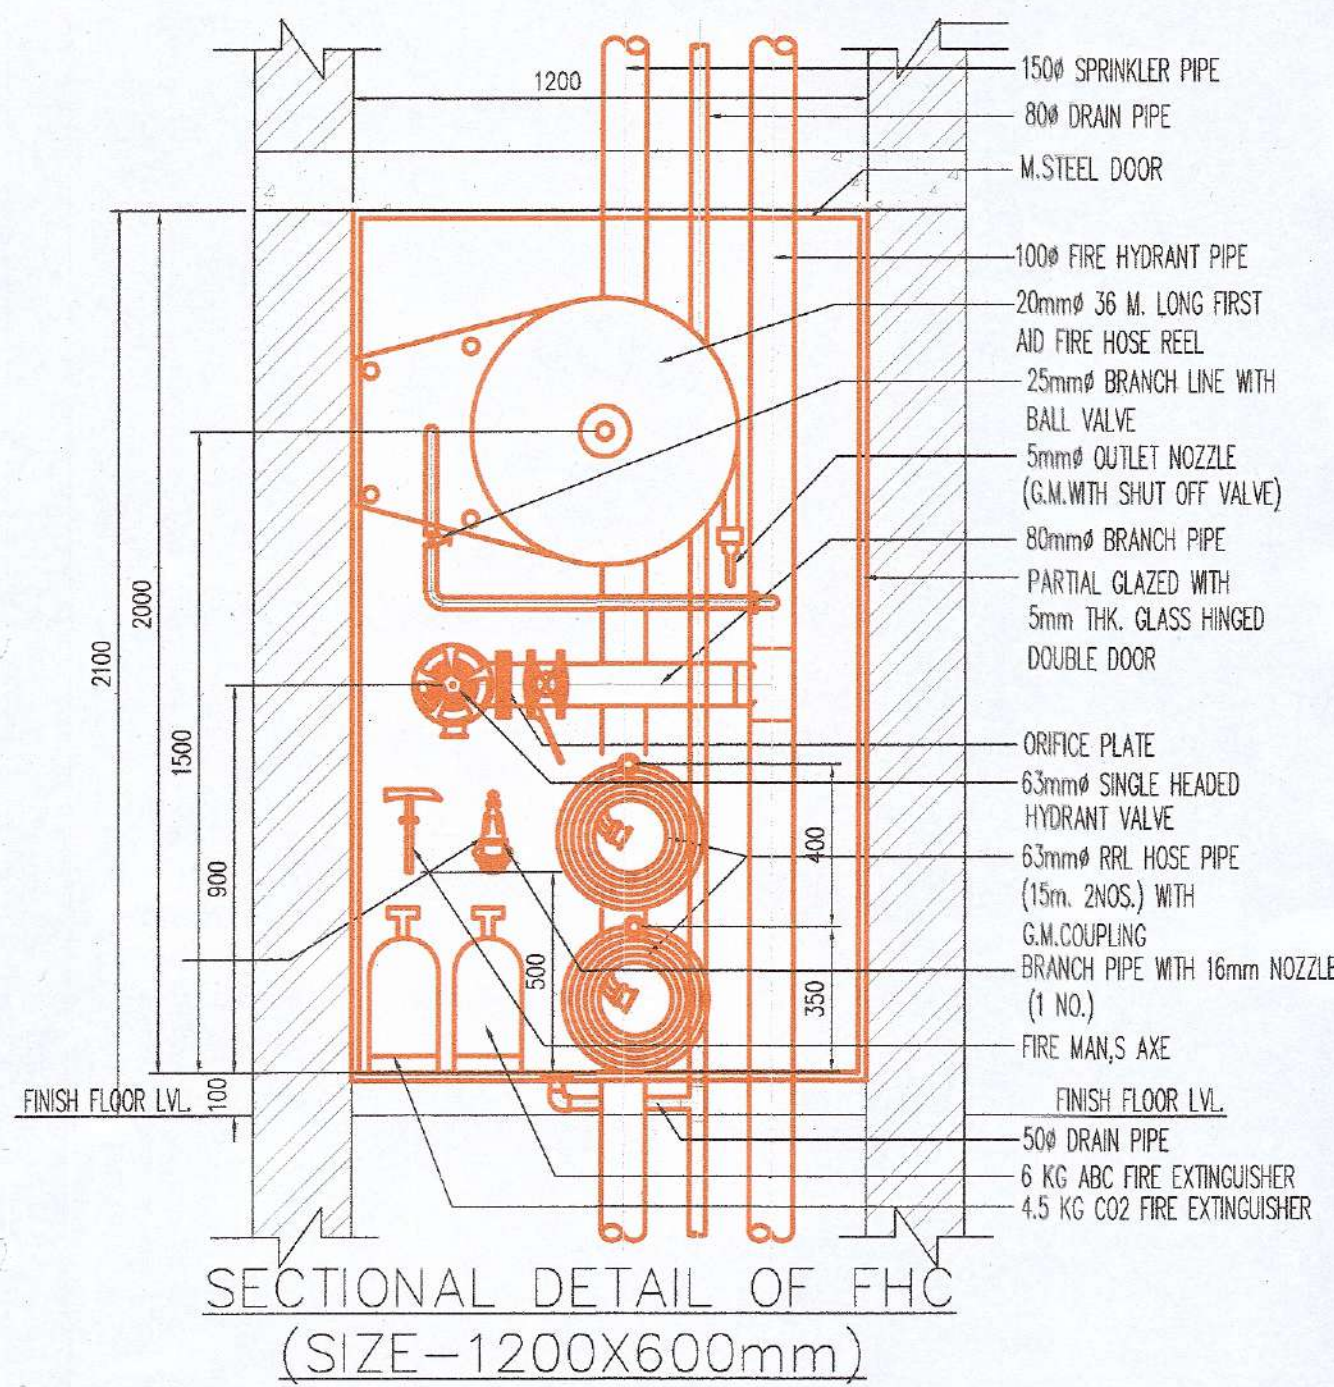


FIRE ALARM LEGEND		
SYMBOL	DESCRIPTION	HEIGHT FROM IN mm.
	SMOKE DETECTOR	C.M./F.C.M
	MANUAL BREAK GLASS UNIT	1200mm.
	FIRE ALARM HOOTER CUM SPEAKER/STROBE	2100mm.
	CEILING SPEAKER	C.M./F.C.M
	FIRE TELEPHONE JACK	1200mm.
	CONTROL MODULE	AS PER SITE COORDINATION
	MONITOR MODULE	AS PER SITE COORDINATION
	ZONE MONITOR MODULE	AS PER SITE COORDINATION

LEGEND :-	
SYMBOL	DESCRIPTION
	1000 FIRE HYDRANT PIPE FOR LOWER ZONE
	1000 FIRE HYDRANT PIPE FOR UPPER ZONE
	1500 FIRE SPRINKLER PIPE FOR LOWER ZONE
	1500 FIRE SPRINKLER PIPE FOR UPPER ZONE
	80M SPRINKLER DRAIN PIPE
	BUTTER FLY VALVE
	NON RETURN VALVE
	AIR RELIEF VALVE
	PENDENCE TYPE SPRINKLER MODEL K-5.6(80.6)
	UPRIGHT TYPE SPRINKLER MODEL K-5.6(80.6)
	SIDE WALL TYPE SPRINKLER MODEL K-5.6(80.6)
	FIRE HOSE CABINET WITH SINGLE OUTLET LANDING VALVE, 2 NOS. RRL HOSE PIPES, BRANCH PIPE WITH NOZZLE & FIRST AID HOSE REEL
	4.5 kg. CO2 TYPE FIRE EXTINGUISHER
	6kg ABC TYPE FIRE EXTINGUISHER
	SPRINKLER PIPE
	FIRE HYDRANT PIPE
	FIRE MAN'S AXE STAINLESS STEEL 1kg
	FLOW SWITCH
	ORIFICE PLATE- STAINLESS STEEL 6mm
	4.5 kg. CO2 TYPE FIRE EXTINGUISHER ON WALL (1M HIGH ABOVE FFL)
	FIRE DOOR 2 HR. FIRE RATING DOOR
	FIRE DOOR 1 HR. FIRE RATING DOOR
	FIRE DOOR 1 HR. FIRE RATING DOOR

REVISION			
NO. OF PRINTS	DATE	ISSUED TO	REMARKS
REVISION	DATE	DESCRIPTION	BY

GENERAL NOTES
 1. All dimensions are in mm unless mentioned otherwise.
 2. No dimensions are to be scaled from this drawing.

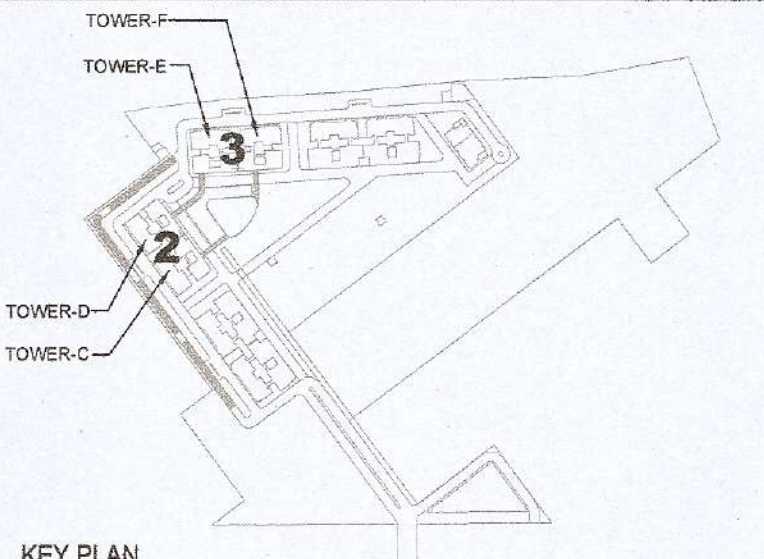

FIRE SUBMISSION DRAWING
 CLIENT: NOURISH DEVELOPERS PVT. LTD.

PROJECT: BUILDING PLAN FOR RESIDENTIAL COLONY UNDER 100 POLICY ON THE AREA MEASURING 10.30 ACRES (AFTER FREEZING OF AN AREA MEASURING 5.8125 ACRES (46K-10M) FALLING UNDER NCZ AND NON COMPACT POCKET DUE TO NCZ) (LICENCE NO. 106 OF 2022, DATED 5/8/2022 AT SECTOR-113 DISTRICT GURUGRAM, HARYANA BEING DEVELOPED BY NOURISH DEVELOPERS PVT. LTD.

DATE	CHECKED BY	PROJECT ARCH.
SEP. 2022	PRAMOD SINGH	DEEPAK AGARWAL
SCALE	DEALT BY	APPROVED BY
1:100	NEGI	YASHVEER SINGH

DRAWING TITLE
TOWER-C & D (BLOCK-2)
TYPICAL FLOOR PLAN (3rd-5th, 7th, 9th, 11th-18th, & 20th-25th)
FIRE FIGHTING SYSTEM AND FIRE ALARM SYSTEM LAYOUT
TOWER-E & F (BLOCK-3) IS SIMILAR BUT MIRRORED (FOR FIRE SUBMISSION)


OWNER'S SIGN.
 Certified that these plans are as per original plans approved by DG, TCP, Chandigarh
 Vide Memo No. 22-1632/PA(DK)/2022/36075
 Dated 01-12-2022
 Authorised Signatory

ARCHITECT'S SIGN.

ARCHITECTS:-
C. P. KUKREJA ARCHITECTS
 ASHIRWAD BUILDING,
 D-1, GREEN PARK,
 NEW DELHI - 110016
 PHONE : 011 28863953 FAX : 011 28865770
 EMAIL: cpka@cpkureja.com

MEP CONSULTANT:-
C. P. KUKREJA ARCHITECTS
 ASHIRWAD BUILDING,
 D-1, GREEN PARK,
 NEW DELHI - 110016
 PHONE : 011 28863953 FAX : 011 28865770
 EMAIL: cpka@cpkureja.com

DRAWING NO.	DRG. NO.
21020/SWD-113/SUB/LATEST/BLOCK-02&03/F-TYP	9
CAD NO.	

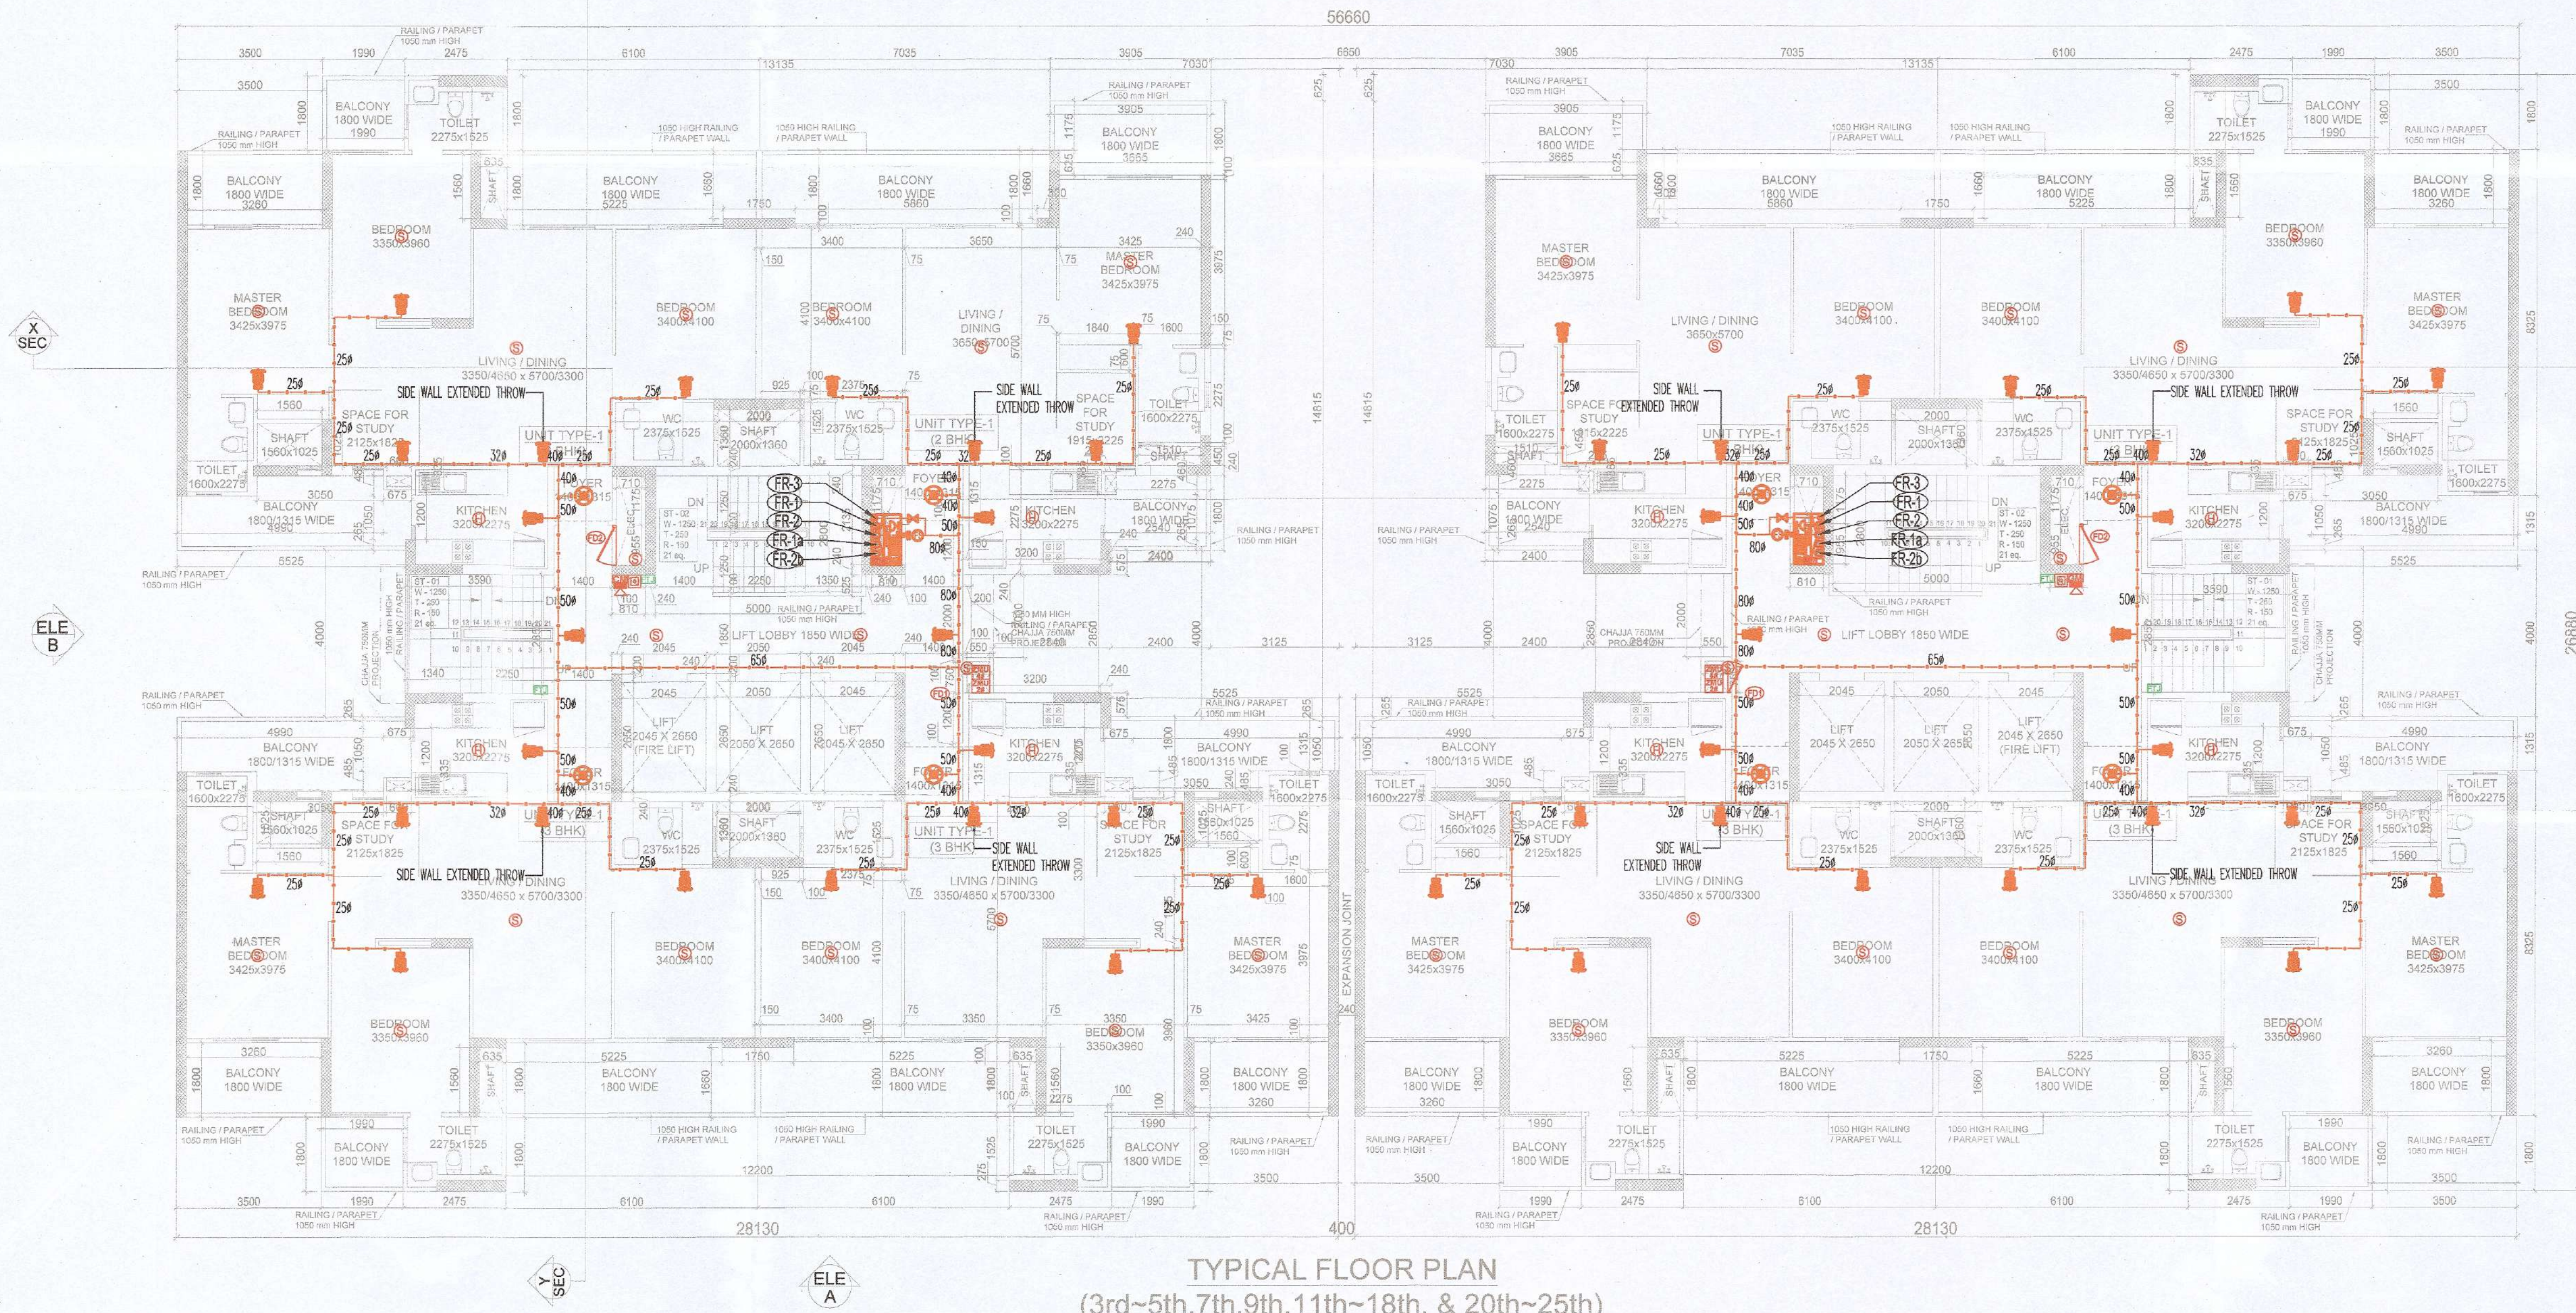

TYPICAL FLOOR PLAN
(3rd-5th, 7th, 9th, 11th-18th, & 20th-25th)