


Checked and found ok for Public Health
 (Plumbing) Services only subject to comments in
 accompanying letter No. S/100/11/10 S.D. 25/11/11

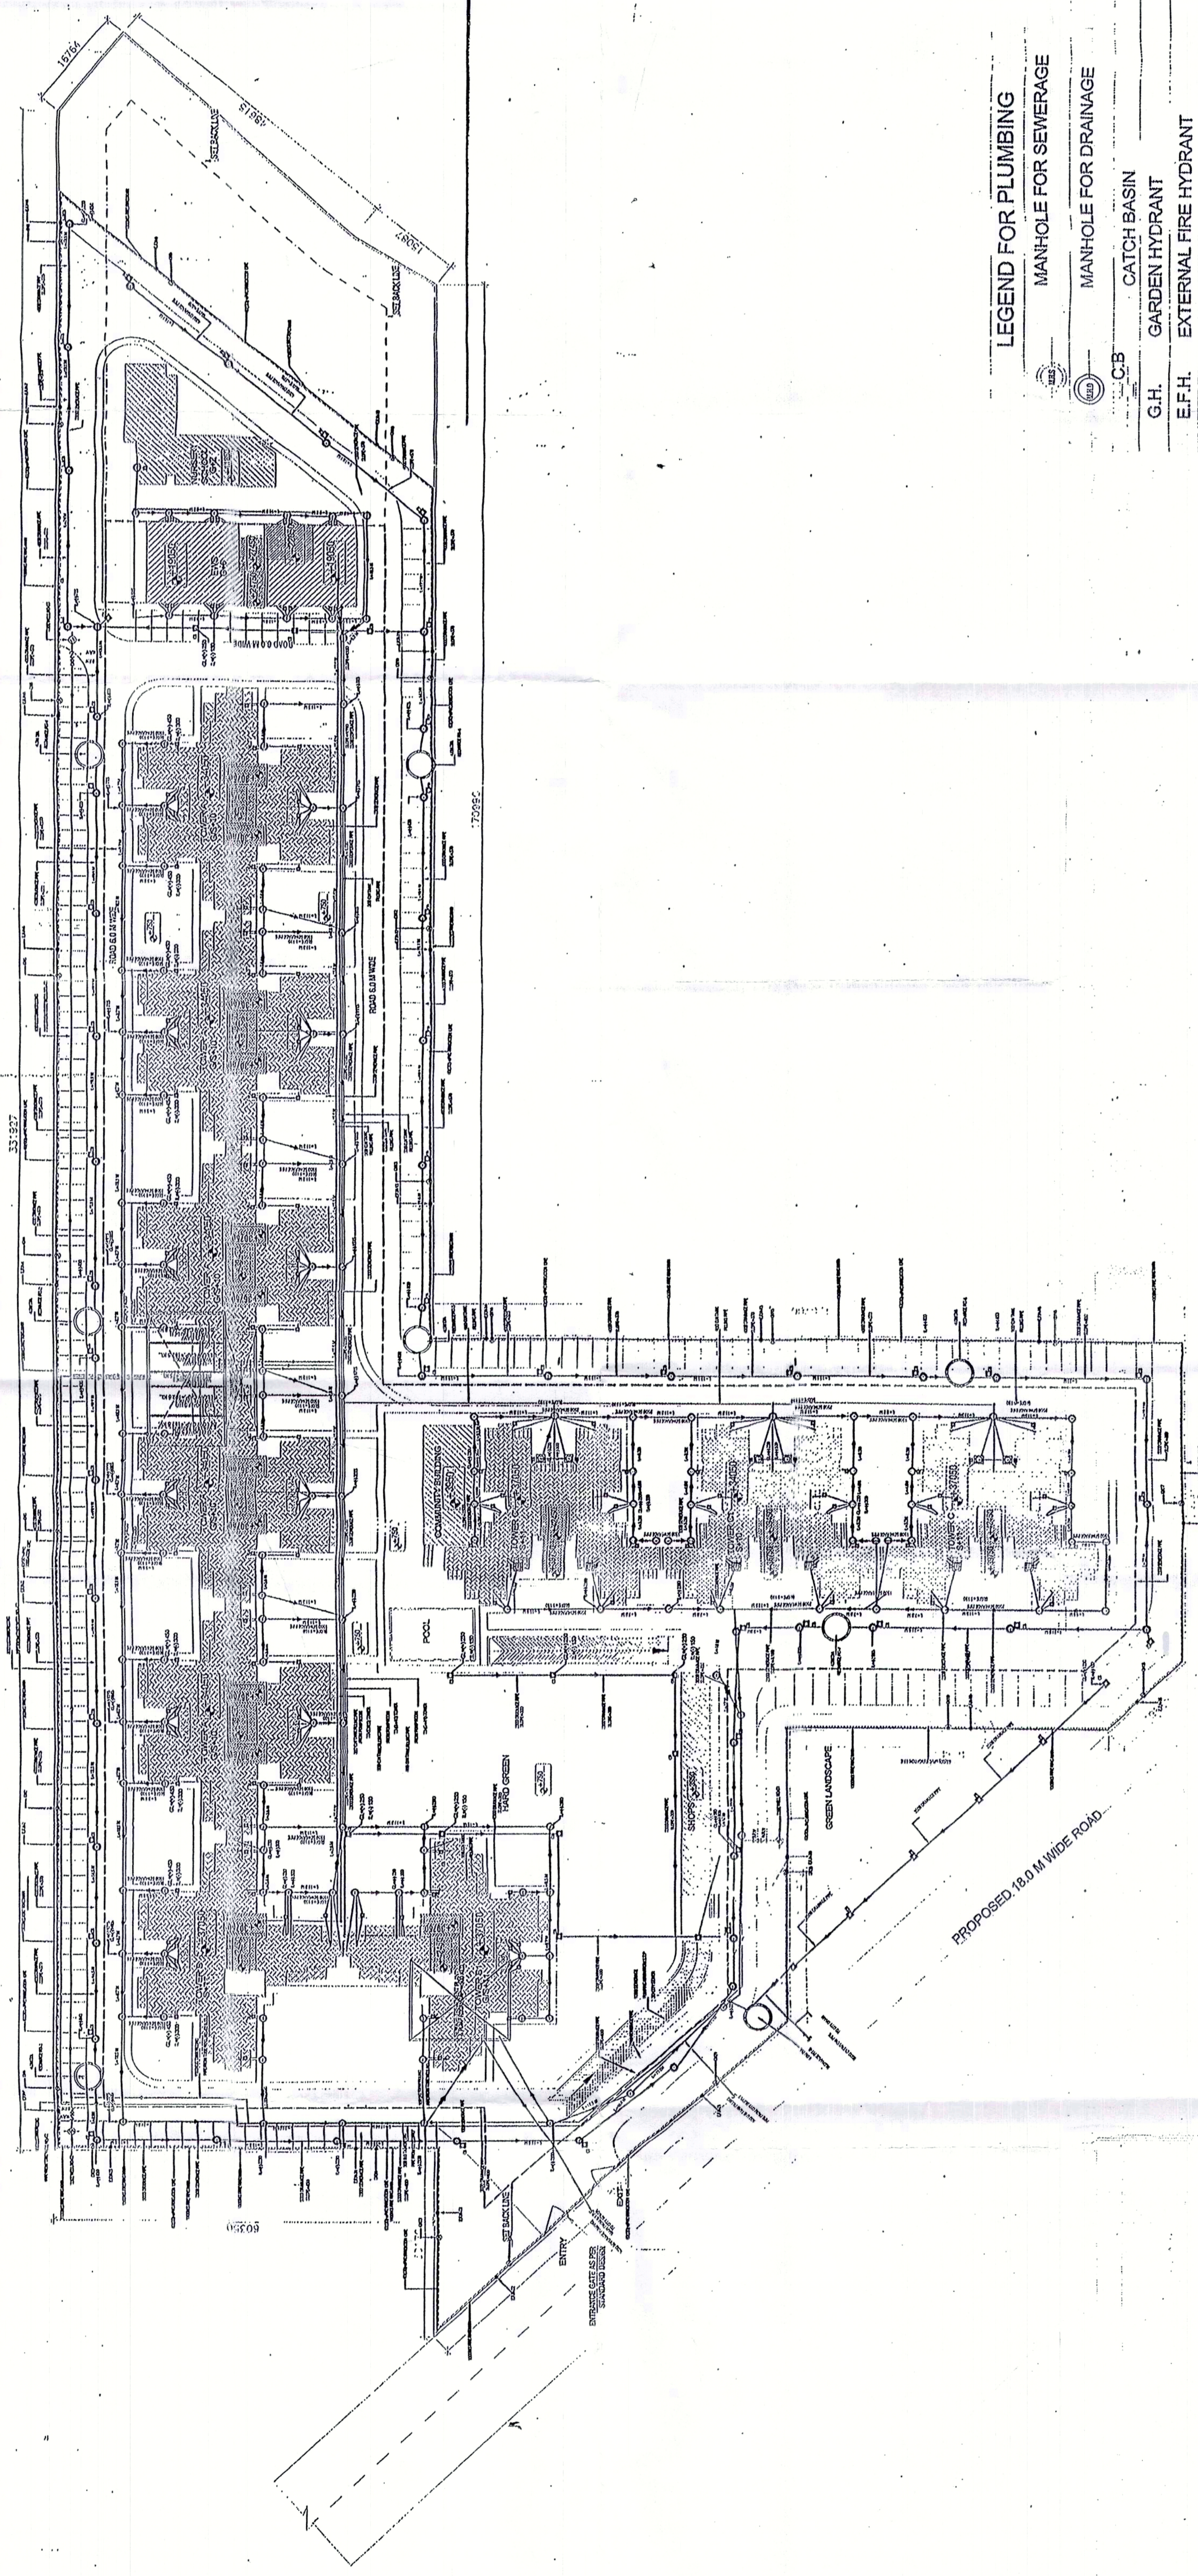

NOTE: THE PROVISION OF FIRE SAFETY MEASURES IN THE MULTI
 STOREY BUILDING CONCERNING TO THE PROVISIONS OF RULES 1987/
 NBC SHALL BE ENSURED.

OWNERS SIGN: _____ ARCHITECTS SIGN: _____

For Brihaspati Construction P. Ltd.
 Director C.O.A. Regn. No. C-172289

PROPOSED PLAN OF GROUP
 HOUSING (LICENSE NO. -142 OF 2008
 DATED 19.07.2008), AT SECTOR- 3,
 VILLAGE-DHARUHERA,
 DISTT. - REWARI, (HARYANA)

OWNER
 M/S BRIHASPATI CONSTRUCTION PVT. LTD.

SHEET TITLE
 SITE PLAN WITH EXTERNAL SERVICES

DRAWING NO.
A-02



SCALE
 1:500

DATE

ARCHITECTS

C-17, Basement, ANAND NIKETAN,
 New Delhi - 110 021
 India
 PHONES - 91-11-2626137-48, 2626138
 FAX - 91-11-2626138 E-MAIL - info@4thdimension.com
 http://www.4thdimension.com

© & ® THIS DRAWING IS THE PROPERTY OF THE ARCHITECTS AND
 IS NOT TO BE COPIED OR REPRODUCED WITHOUT PERMISSION

LEGEND FOR PLUMBING

	MANHOLE FOR SEWERAGE
	MANHOLE FOR DRAINAGE
	CATCH BASIN
	G.H. GARDEN HYDRANT
	E.F.H. EXTERNAL FIRE HYDRANT
	G.L. GROUND LEVEL
	I.L. INVERT LEVEL
	C.L. CONNECTION LEVEL
	M. METRE
	L. LENGTH
	G.T. GULLY TRAP
	C.B. CATCH BASIN
	B.F.V. BUTTER FLY VALVE
	N.R.V. NON-RETURN VALVE

1 SITE PLAN WITH SERVICES
 SCALE: 1:500