


Authority Stamp

- NOTES**
1. Dimensions are not to be scaled.
 2. All dimensions are in mm.
 3. All windows and ventilators are operable.
 4. Lift well are mechanically Pressurized.
 5. Fire services install as per NBC.
 6. 100% power backup for emergency services.

key plan

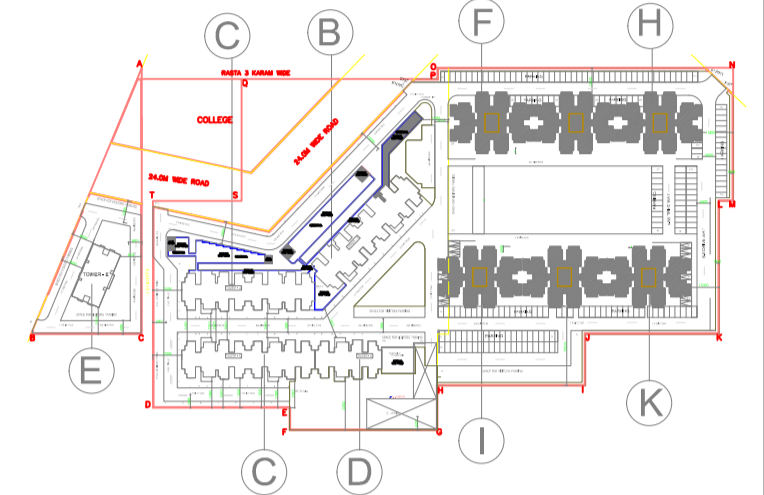

Owner's Sign&Stamp

Architect's Sign&Stamp

Clients:

Architects :
JPS DESIGN STUDIO
 FLAT NO T3, MANISH TWIN PLAZA, PLOT NO. 2
 SECTOR - 4 DWARKA, DELHI - 110078
 PHONE # 01141410230
 EMAIL - mail @jpsdesignstudios.com

Structures :

Project Title :
REVISED BUILDING PLAN FOR AFFORDABLE GROUP HOUSING
 AREA MEASURING 5.0 + 4.1125 ACRES
 (LICENCE NO 11 OF 2014 DATED 10-06-2014)


IN SECTOR-102, GURGAON MANESAR URBAN COMPLEX
 BEING DEVELOPED BY M/s NANI RESORTS & FLORICULTURE PVT.LTD.

Drawing Title :
 SITE PLAN
DRAINAGE LAYOUT

LEGEND:-

S.NO.	DESCRIPTION	SYMBOL
1.	STORM WATER LINE	
2.	STORM WATER MANHOLE	
3.	RAIN WATER HARVESTING	RWH


Scale :	1:300	Project No :	Rev :
Date :	20.02.2019	Drawing Code :	Drawing No :
Drawn By :	VIKRAM		01
Checked By :	R.K.RAWAT		
Sheet Size : A0:841x1189mm, Drawing Status :			

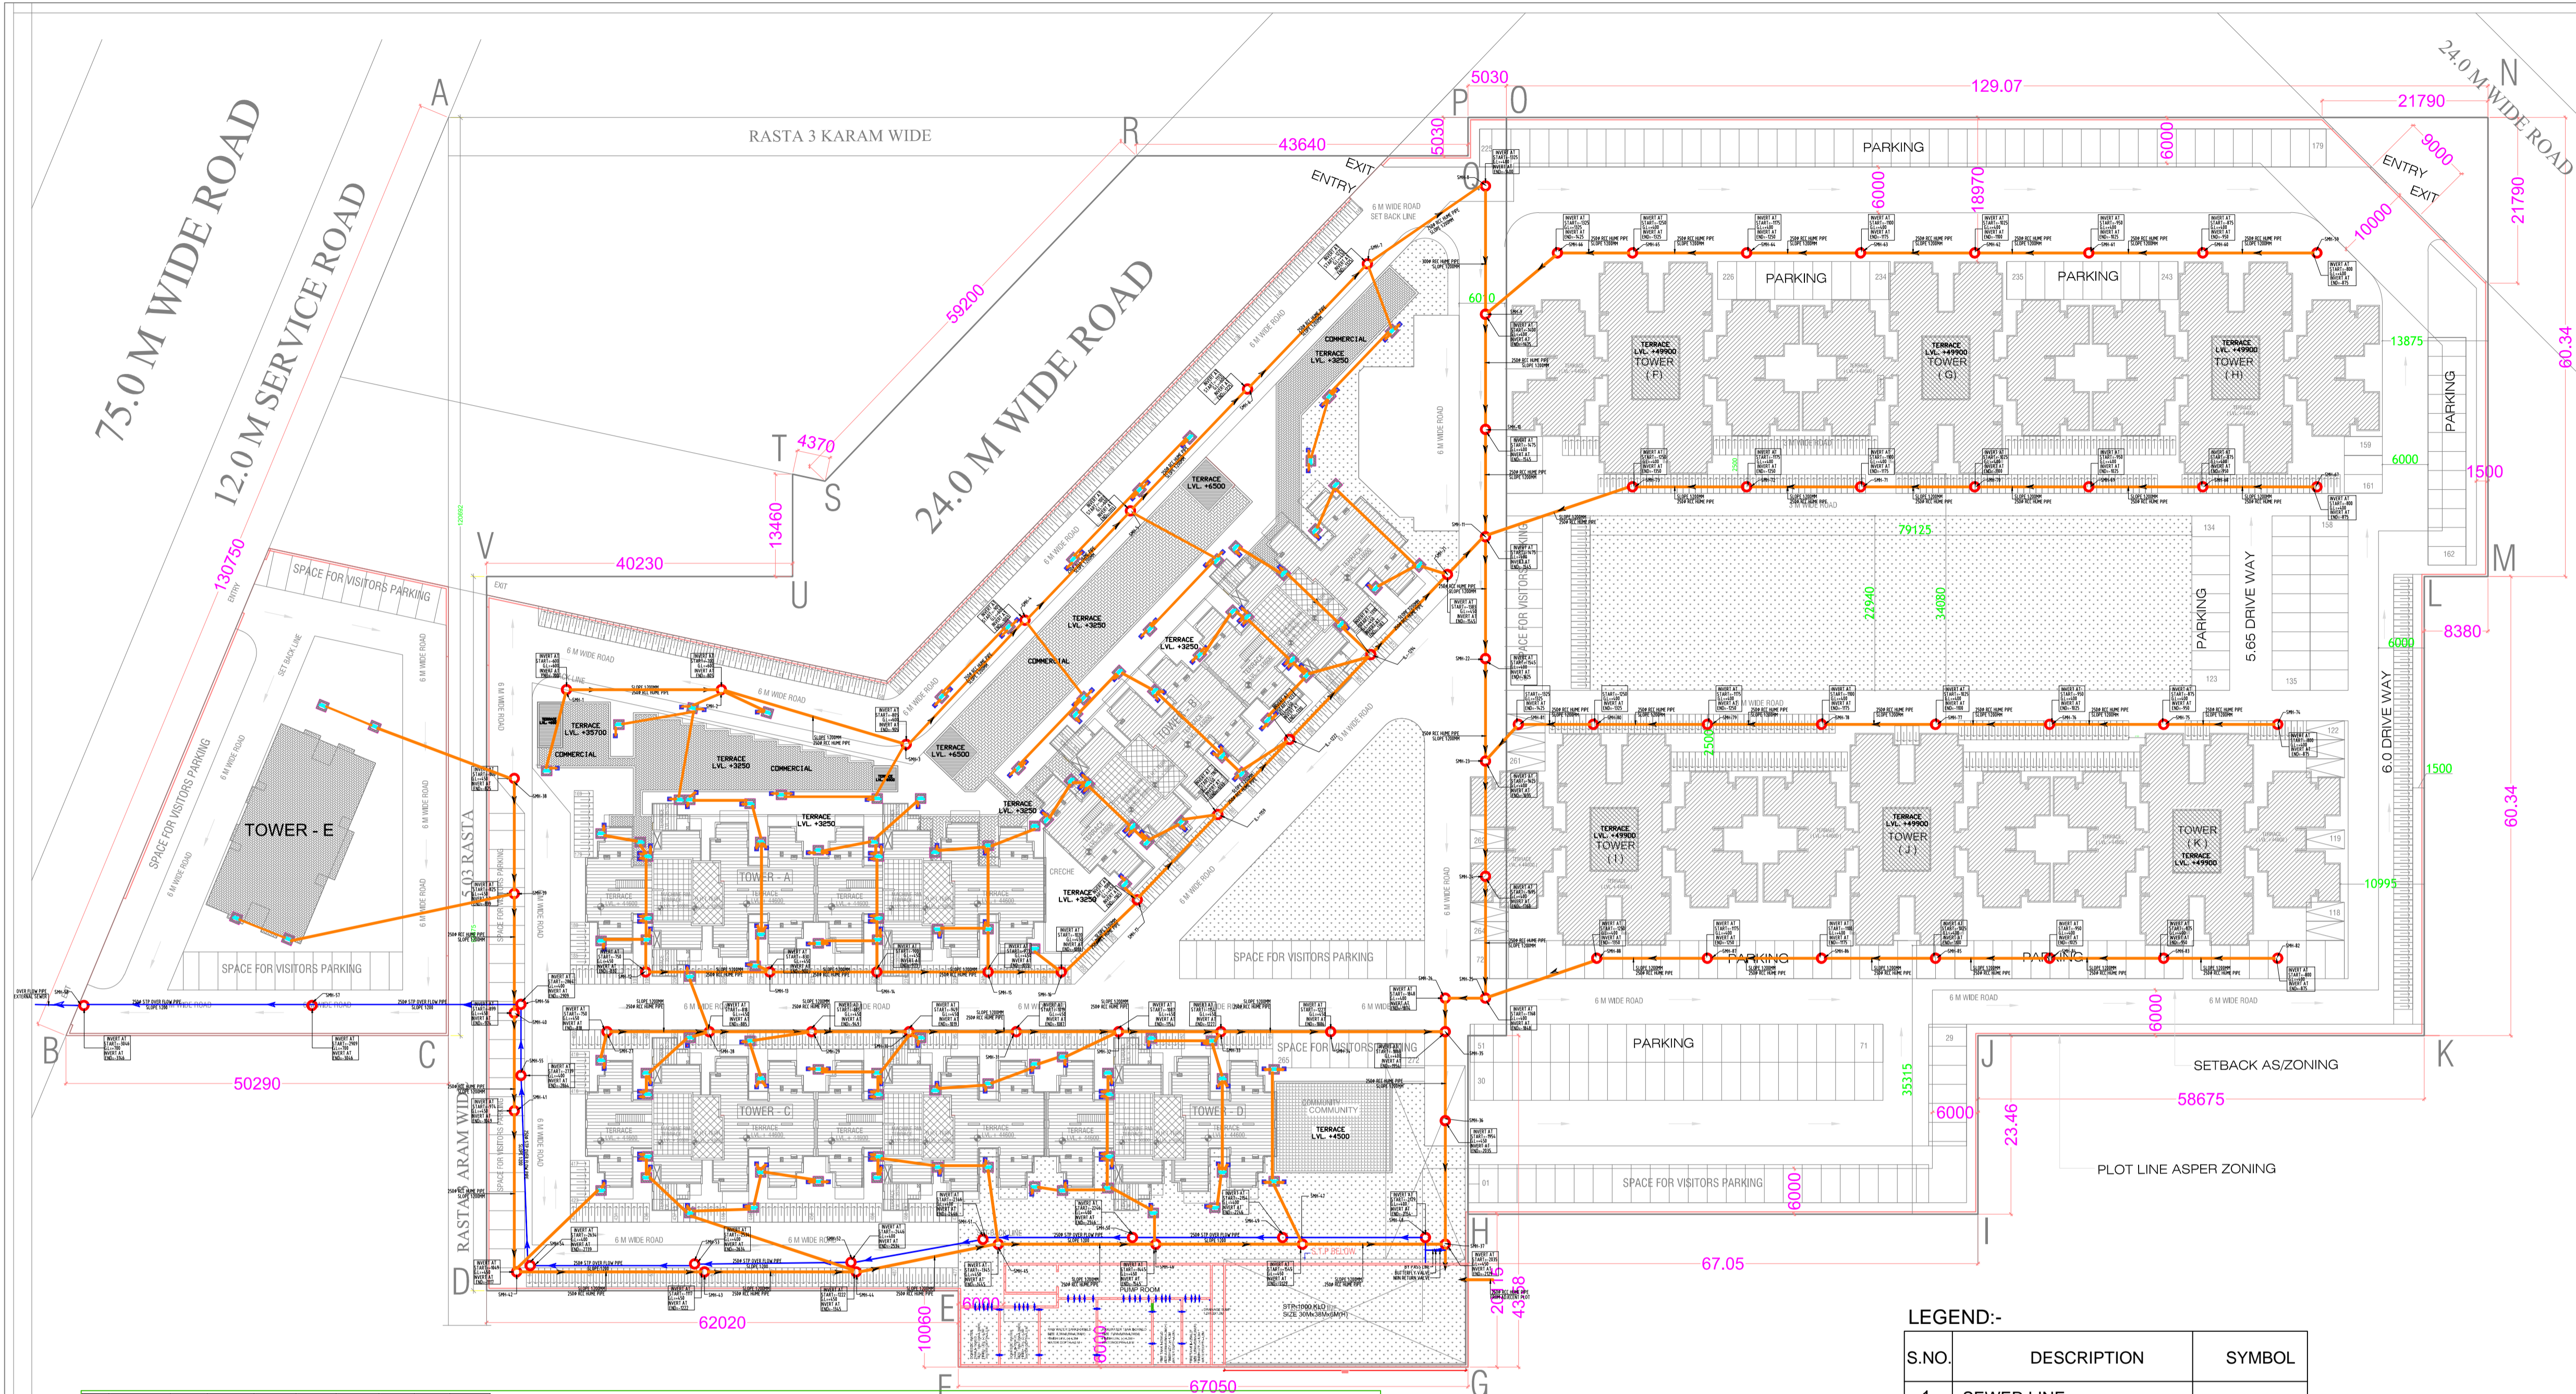

Authority Stamp

N O T E S

1. Dimensions are not to be scaled.
2. All dimensions are in mm.
3. All windows and ventilators are operable.
4. Lift well are mechanically Pressurized.
5. Fire services install as per NBC.
6. 100% power backup for emergency services.

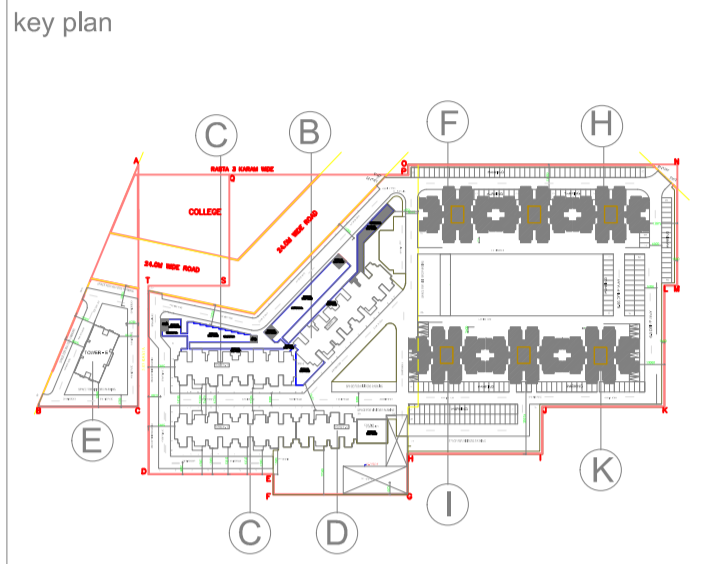

Owner's Sign&Stamp

Architect's Sign&Stamp

Clients:

Architects :

JPS DESIGN STUDIO
 FLAT NO 13, MANISH TWIN PLAZA, PLOT NO. 2
 SECTOR - 4 DWARKA, DELHI - 110078
 PHONE # 01141410230
 EMAIL : mail@jpsdesignstudios.com

Structures :

Project Title :

REVISED BUILDING PLAN FOR AFFORDABLE GROUP HOUSING AREA MEASURING 5.0 + 4.1125 ACRES (LICENCE NO 11 OF 2014 DATED 10-06-2014)

IN SECTOR-102, GURGAON MANESAR URBAN COMPLEX

BEING DEVELOPED BY M/s NANI RESORTS & FLORICULTURE PVT.LTD.

Drawing Title :


SITE PLAN
SEWERAGE LAYOUT

Scale : **1:300** Project No : Rev :
 Date : 20.02.2019 Drawing Code : Drawing No :
 Drawn By : VIKRAM
 Checked By : R.K.RAWAT
 Sheet Size : A0:841x1189mm, Drawing Status : **01**

LEGEND:-


S.NO.	DESCRIPTION	SYMBOL
1.	SEWER LINE	—
2.	SEWER MANHOLE	○

Sr No.	NodeNo.	Length (feet)	Pipe Dia of S/W LINE Pipes	Gradient (%)	Ground Level (mm)	Invert at Start (mm)	Invert at End (mm)	Depth of S.W.L.	Zone of M.S.
1	1-2	20	1.0	200	0.00	-800	-780	1200	900 DIA
2	2-3	21	1.0	200	0.00	-790	-806	1300	900 DIA
3	3-4	20	1.0	200	0.00	-805	-806	1400	900 DIA
4	4-5	19.5	1.0	200	0.00	-865	-1003	1300	900 DIA
5	5-6	22	1.0	200	0.00	-1003	-1113	1300	900 DIA
6	6-7	20.5	1.0	200	0.00	-1113	-1225	1713	1200 DIA
7	7-8	20	1.0	200	0.00	-1225	-1325	1625	1200 DIA
8	8-9	15	1.0	200	0.00	-1325	-1400	1725	1200 DIA
9	9-10	15	1.0	200	0.00	-1400	-1475	1800	1200 DIA
10	10-11	14	1.0	200	0.00	-1475	-1546	1875	1200 DIA
11	11-12	16	1.0	200	0.00	-780	-830	1200	900 DIA
12	12-13	14	1.0	200	0.00	-800	-890	1300	900 DIA
13	13-14	14	1.0	200	0.00	-890	-990	1300	900 DIA
14	14-15	14.5	1.0	200	0.00	-990	-970	1300	900 DIA
15	15-16	9.5	1.0	200	0.00	-970	-1020	1420	900 DIA
16	16-17	10.5	1.0	200	0.00	-1020	-1088	1470	900 DIA
17	17-18	10.5	1.0	200	0.00	-1088	-1185	1530	900 DIA
18	18-19	10.5	1.0	200	0.00	-1185	-1233	1610	900 DIA
19	19-20	10.5	1.0	200	0.00	-1233	-1310	1680	1200 DIA
20	20-21	14.5	1.0	200	0.00	-1310	-1383	1780	1200 DIA
21	21-22	11	1.0	200	0.00	-1383	-1494	1830	1200 DIA
22	22-23	14	1.0	200	0.00	-1494	-1625	2020	1200 DIA
23	23-24	14.5	1.0	200	0.00	-1625	-1708	2090	1200 DIA
24	24-25	16	1.0	200	0.00	-1708	-1848	2190	1200 DIA
25	25-26	8.2	1.0	200	0.00	-1848	-1874	2240	1200 DIA
26	26-27	4.4	1.0	200	0.00	-1874	-1896	2274	1200 DIA
27	27-28	10.5	1.0	200	0.00	-780	-818	1200	900 DIA
28	28-29	10.5	1.0	200	0.00	-818	-836	1200	900 DIA
29	29-30	10.5	1.0	200	0.00	-836	-840	1200	900 DIA
30	30-31	14	1.0	200	0.00	-840	-1019	1380	900 DIA
31	31-32	10.5	1.0	200	0.00	-1019	-1087	1480	900 DIA
32	32-33	10.5	1.0	200	0.00	-1087	-1154	1570	900 DIA
33	33-34	14.5	1.0	200	0.00	-1154	-1227	1654	900 DIA
34	34-35	18	1.0	200	0.00	-1227	-1297	1770	1200 DIA
35	35-36	17	1.0	200	0.00	-1297	-1386	1854	1200 DIA
36	36-37	17.7	1.0	200	0.00	-1386	-1494	1934	1200 DIA
37	37-38	18.2	1.0	200	0.00	-1494	-1625	2034	1200 DIA
38	38-39	18.7	1.0	200	0.00	-1625	-1789	2149	1200 DIA
39	39-40	8	1.0	200	0.00	-800	-828	1200	900 DIA
40	40-41	14.7	1.0	200	0.00	-828	-889	1220	900 DIA
41	41-42	16.1	1.0	200	0.00	-889	-974	1289	900 DIA
42	42-43	18.1	1.0	200	0.00	-974	-1049	1374	900 DIA
43	43-44	13.5	1.0	200	0.00	-1049	-1117	1449	900 DIA
44	44-45	21	1.0	200	0.00	-1117	-1222	1617	900 DIA
45	45-46	24.7	1.0	200	0.00	-1222	-1346	1622	900 DIA
46	46-47	20	1.0	200	0.00	-1346	-1446	1746	1200 DIA
47	47-48	5	1.0	200	0.00	-1446	-1546	1646	1200 DIA
48	48-49	5	1.0	200	0.00	-1546	-1646	1746	1200 DIA
49	49-50	19.5	1.0	200	0.00	-1646	-1789	1944	1200 DIA
50	50-51	19.5	1.0	200	0.00	-1789	-1944	2139	1200 DIA
51	51-52	17.7	1.0	200	0.00	-1944	-2054	2244	1200 DIA
52	52-53	20	1.0	200	0.00	-2054	-2194	2344	1200 DIA
53	53-54	20	1.0	200	0.00	-2194	-2364	2544	1200 DIA
54	54-55	29	1.0	200	0.00	-2364	-2584	2739	1200 DIA
55	55-56	9	1.0	200	0.00	-2584	-2684	2684	1200 DIA
56	56-57	27.5	1.0	200	0.00	-2684	-2944	3044	1200 DIA
57	57-58	30	1.0	200	700	-3044	-3194	3144	1200 DIA
58	58-59	15	1.0	200	0.00	-3194	-3300	3300	900 DIA
59	59-60	16	1.0	200	0.00	-3300	-3400	3400	900 DIA
60	60-61	16	1.0	200	0.00	-3400	-3500	3500	900 DIA
61	61-62	16	1.0	200	0.00	-3500	-3600	3600	900 DIA
62	62-63	16	1.0	200	0.00	-3600	-3700	3700	900 DIA
63	63-64	16	1.0	200	0.00	-3700	-3800	3800	900 DIA
64	64-65	16	1.0	200	0.00	-3800	-3900	3900	900 DIA
65	65-66	16	1.0	200	0.00	-3900	-4000	4000	900 DIA
66	66-67	12	1.0	200	0.00	-4000	-4100	4100	900 DIA
67	67-68	16	1.0	200	0.00	-4100	-4200	4200	900 DIA

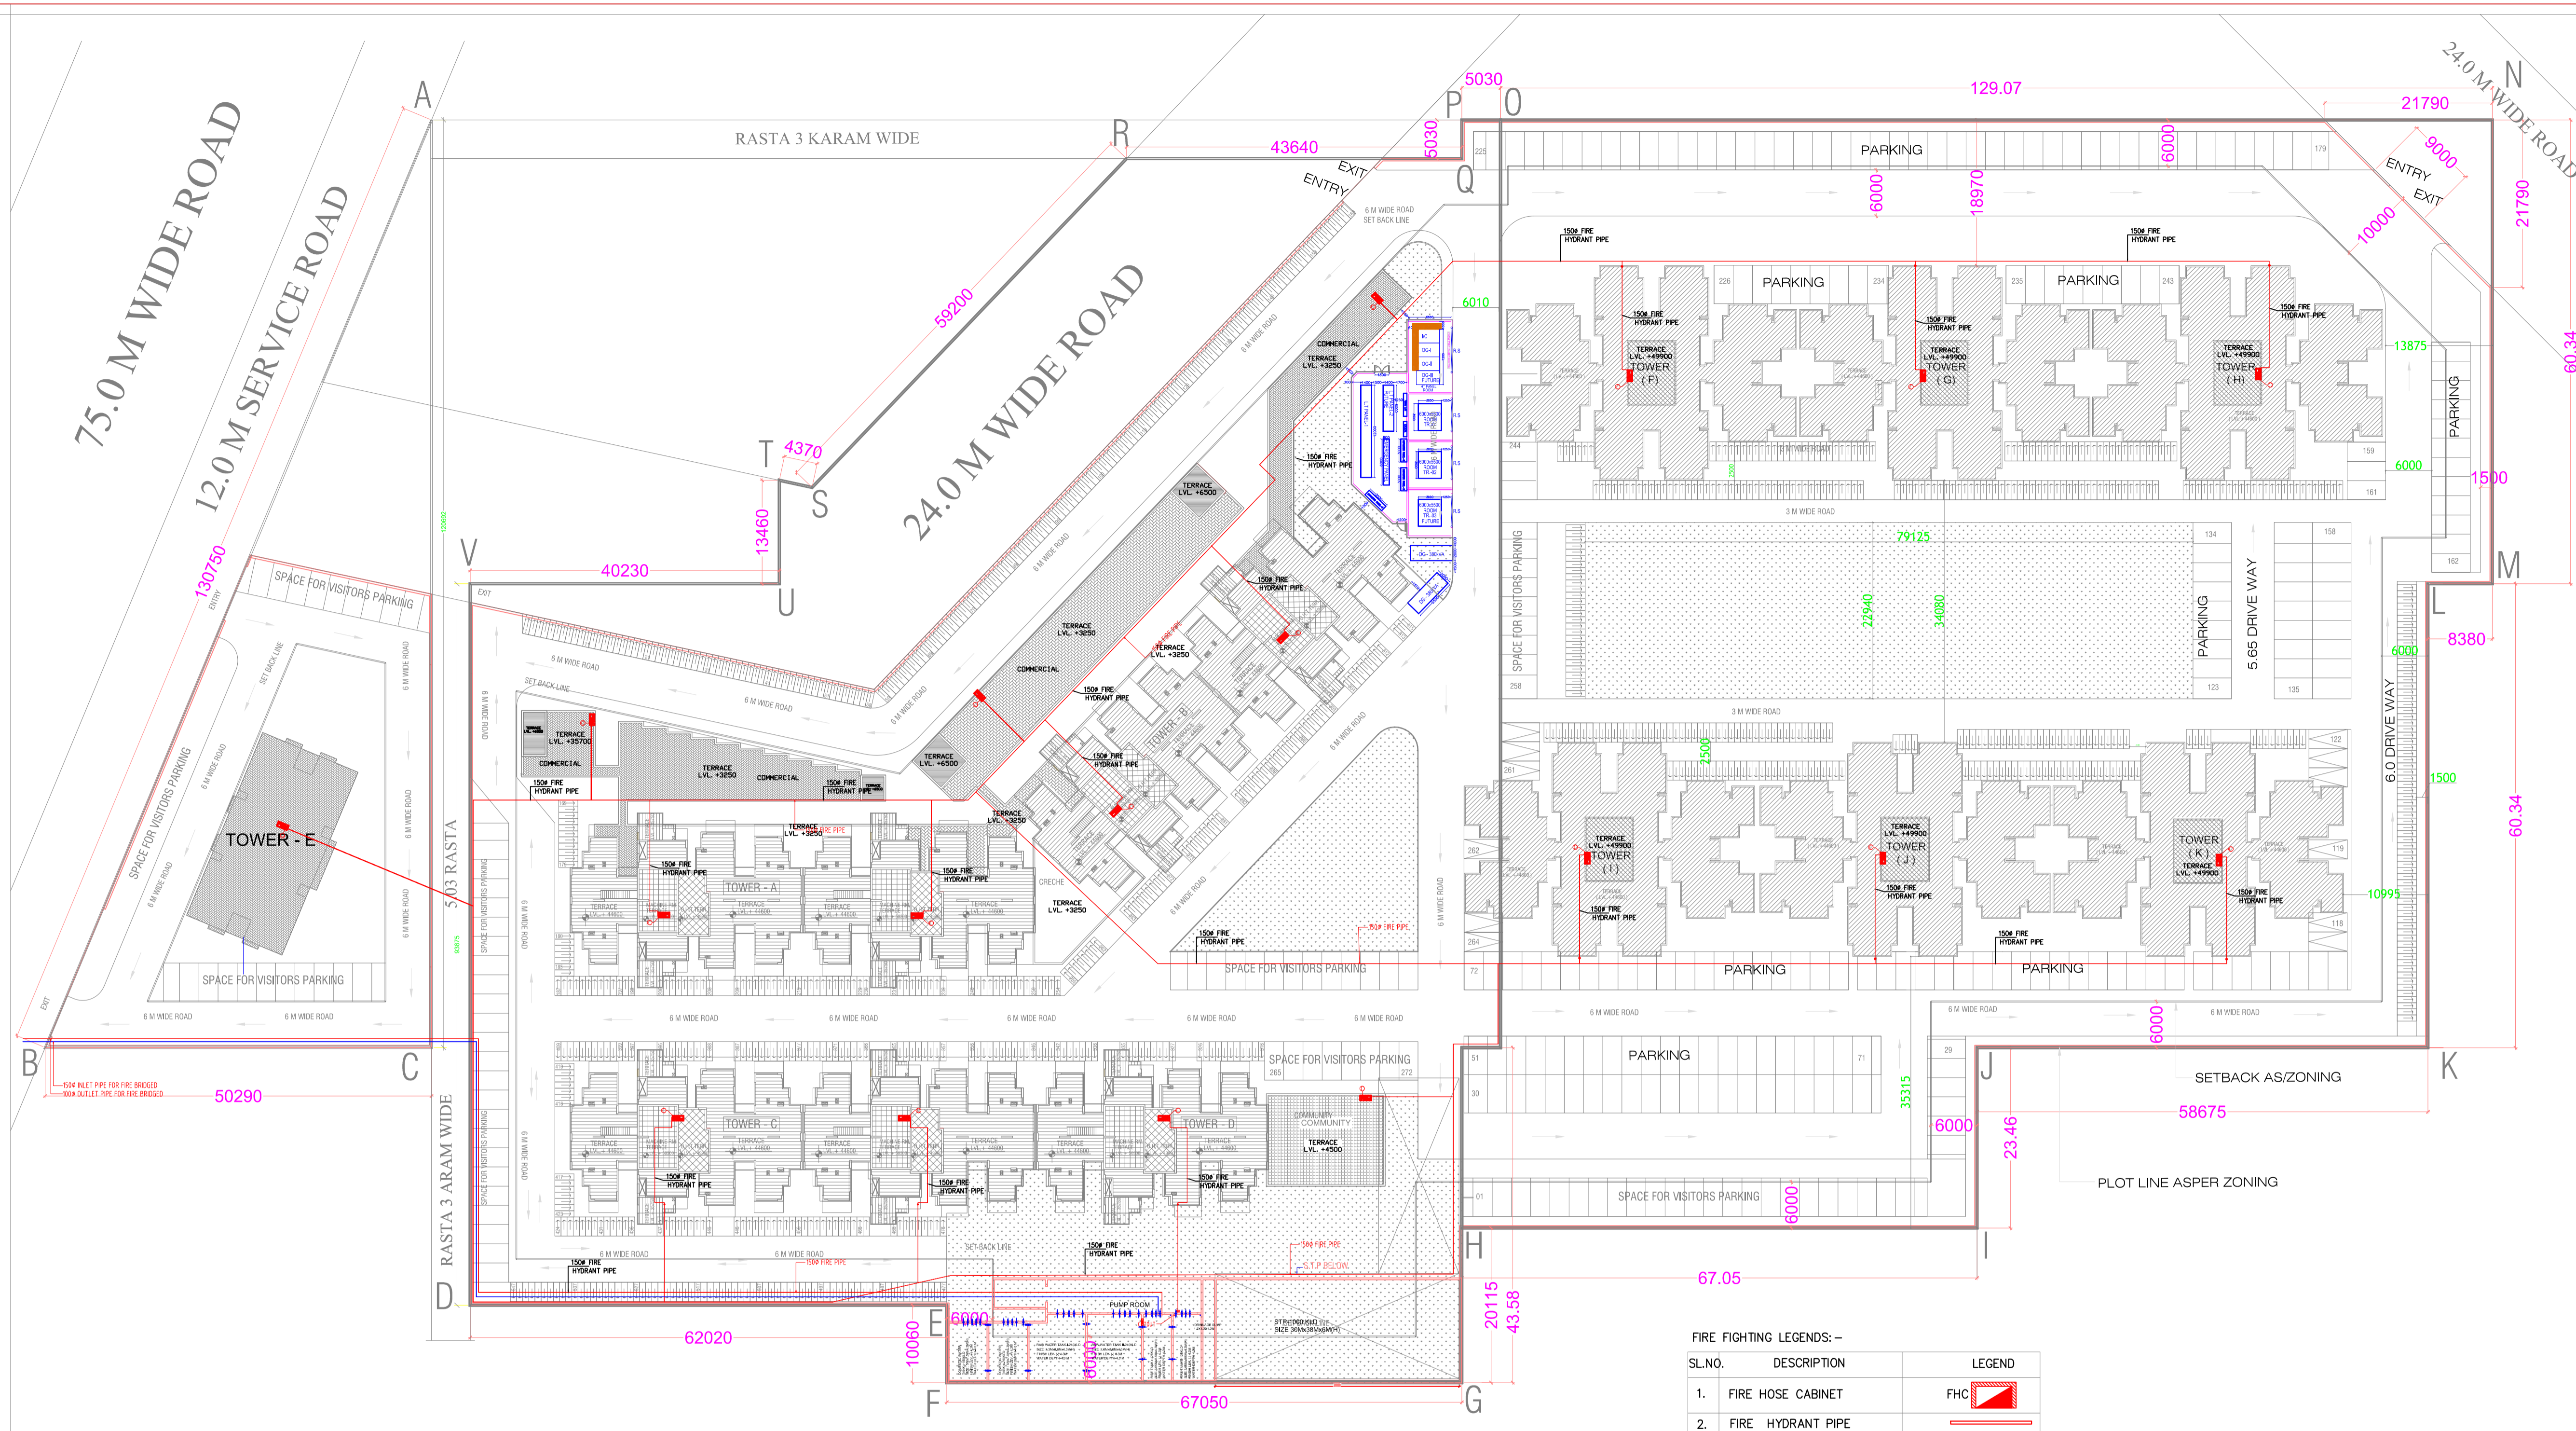

Authority Stamp

- N O T E S**
1. Dimensions are not to be scaled.
 2. All dimensions are in mm.
 3. All windows and ventilators are operable.
 4. Lift well are mechanically Pressurized.
 5. Fire services install as per NBC.
 6. 100% power backup for emergency services.

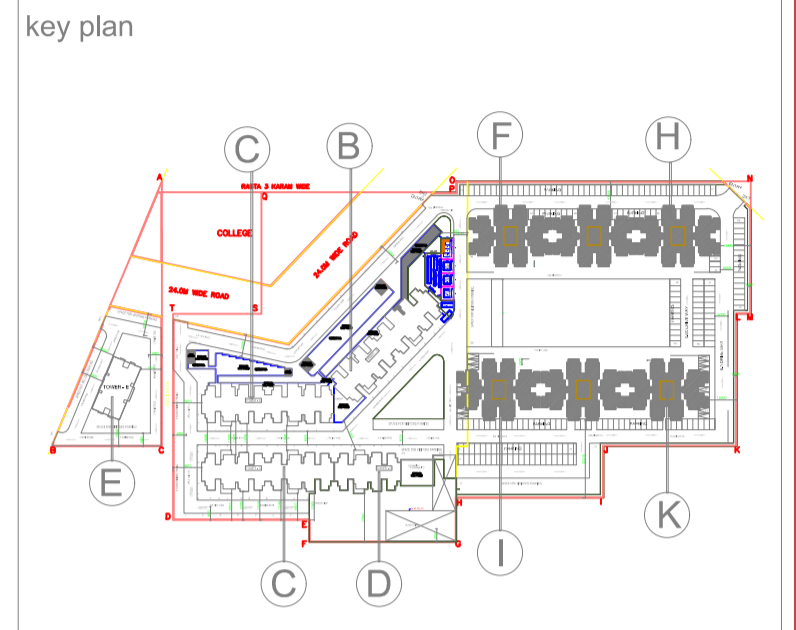

Owner's Sign&Stamp

Architect's Sign&Stamp

Clients:

Architects :
JPS DESIGN STUDIO
 FLAT NO T3, MANISH TWIN PLAZA, PLOT NO. 2
 SECTOR - 4 DWARKA, DELHI - 110078
 PHONE: 91141410230
 EMAIL: mail @jpsdesignstudios.com

Structures :

FIRE FIGHTING LEGENDS: -

SL.NO.	DESCRIPTION	LEGEND
1.	FIRE HOSE CABINET	FHC
2.	FIRE HYDRANT PIPE	

Project Title :
REVISED BUILDING PLAN FOR AFFORDABLE GROUP HOUSING
 AREA MEASURING 5.0 + 4.1125 ACRES
 (LICENCE NO 11 OF 2014 DATED 10-06-2014)

IN SECTOR-102, GURGAON MANESAR URBAN COMPLEX
 BEING DEVELOPED BY M/s NANI RESORTS & FLORICULTURE PVT.LTD.

Drawing Title :
SITE PLAN
DRAINAGE LAYOUT

Scale :	1:300	Project No.:	Rev :
Date :	20.02.2019	Drawing Code :	Drawn No.:
Drawn By :	VIKRAM		01
Checked By :	R.K.RAWAT		
Sheet Size :	A0:841x1189mm	Drawing Status :	