
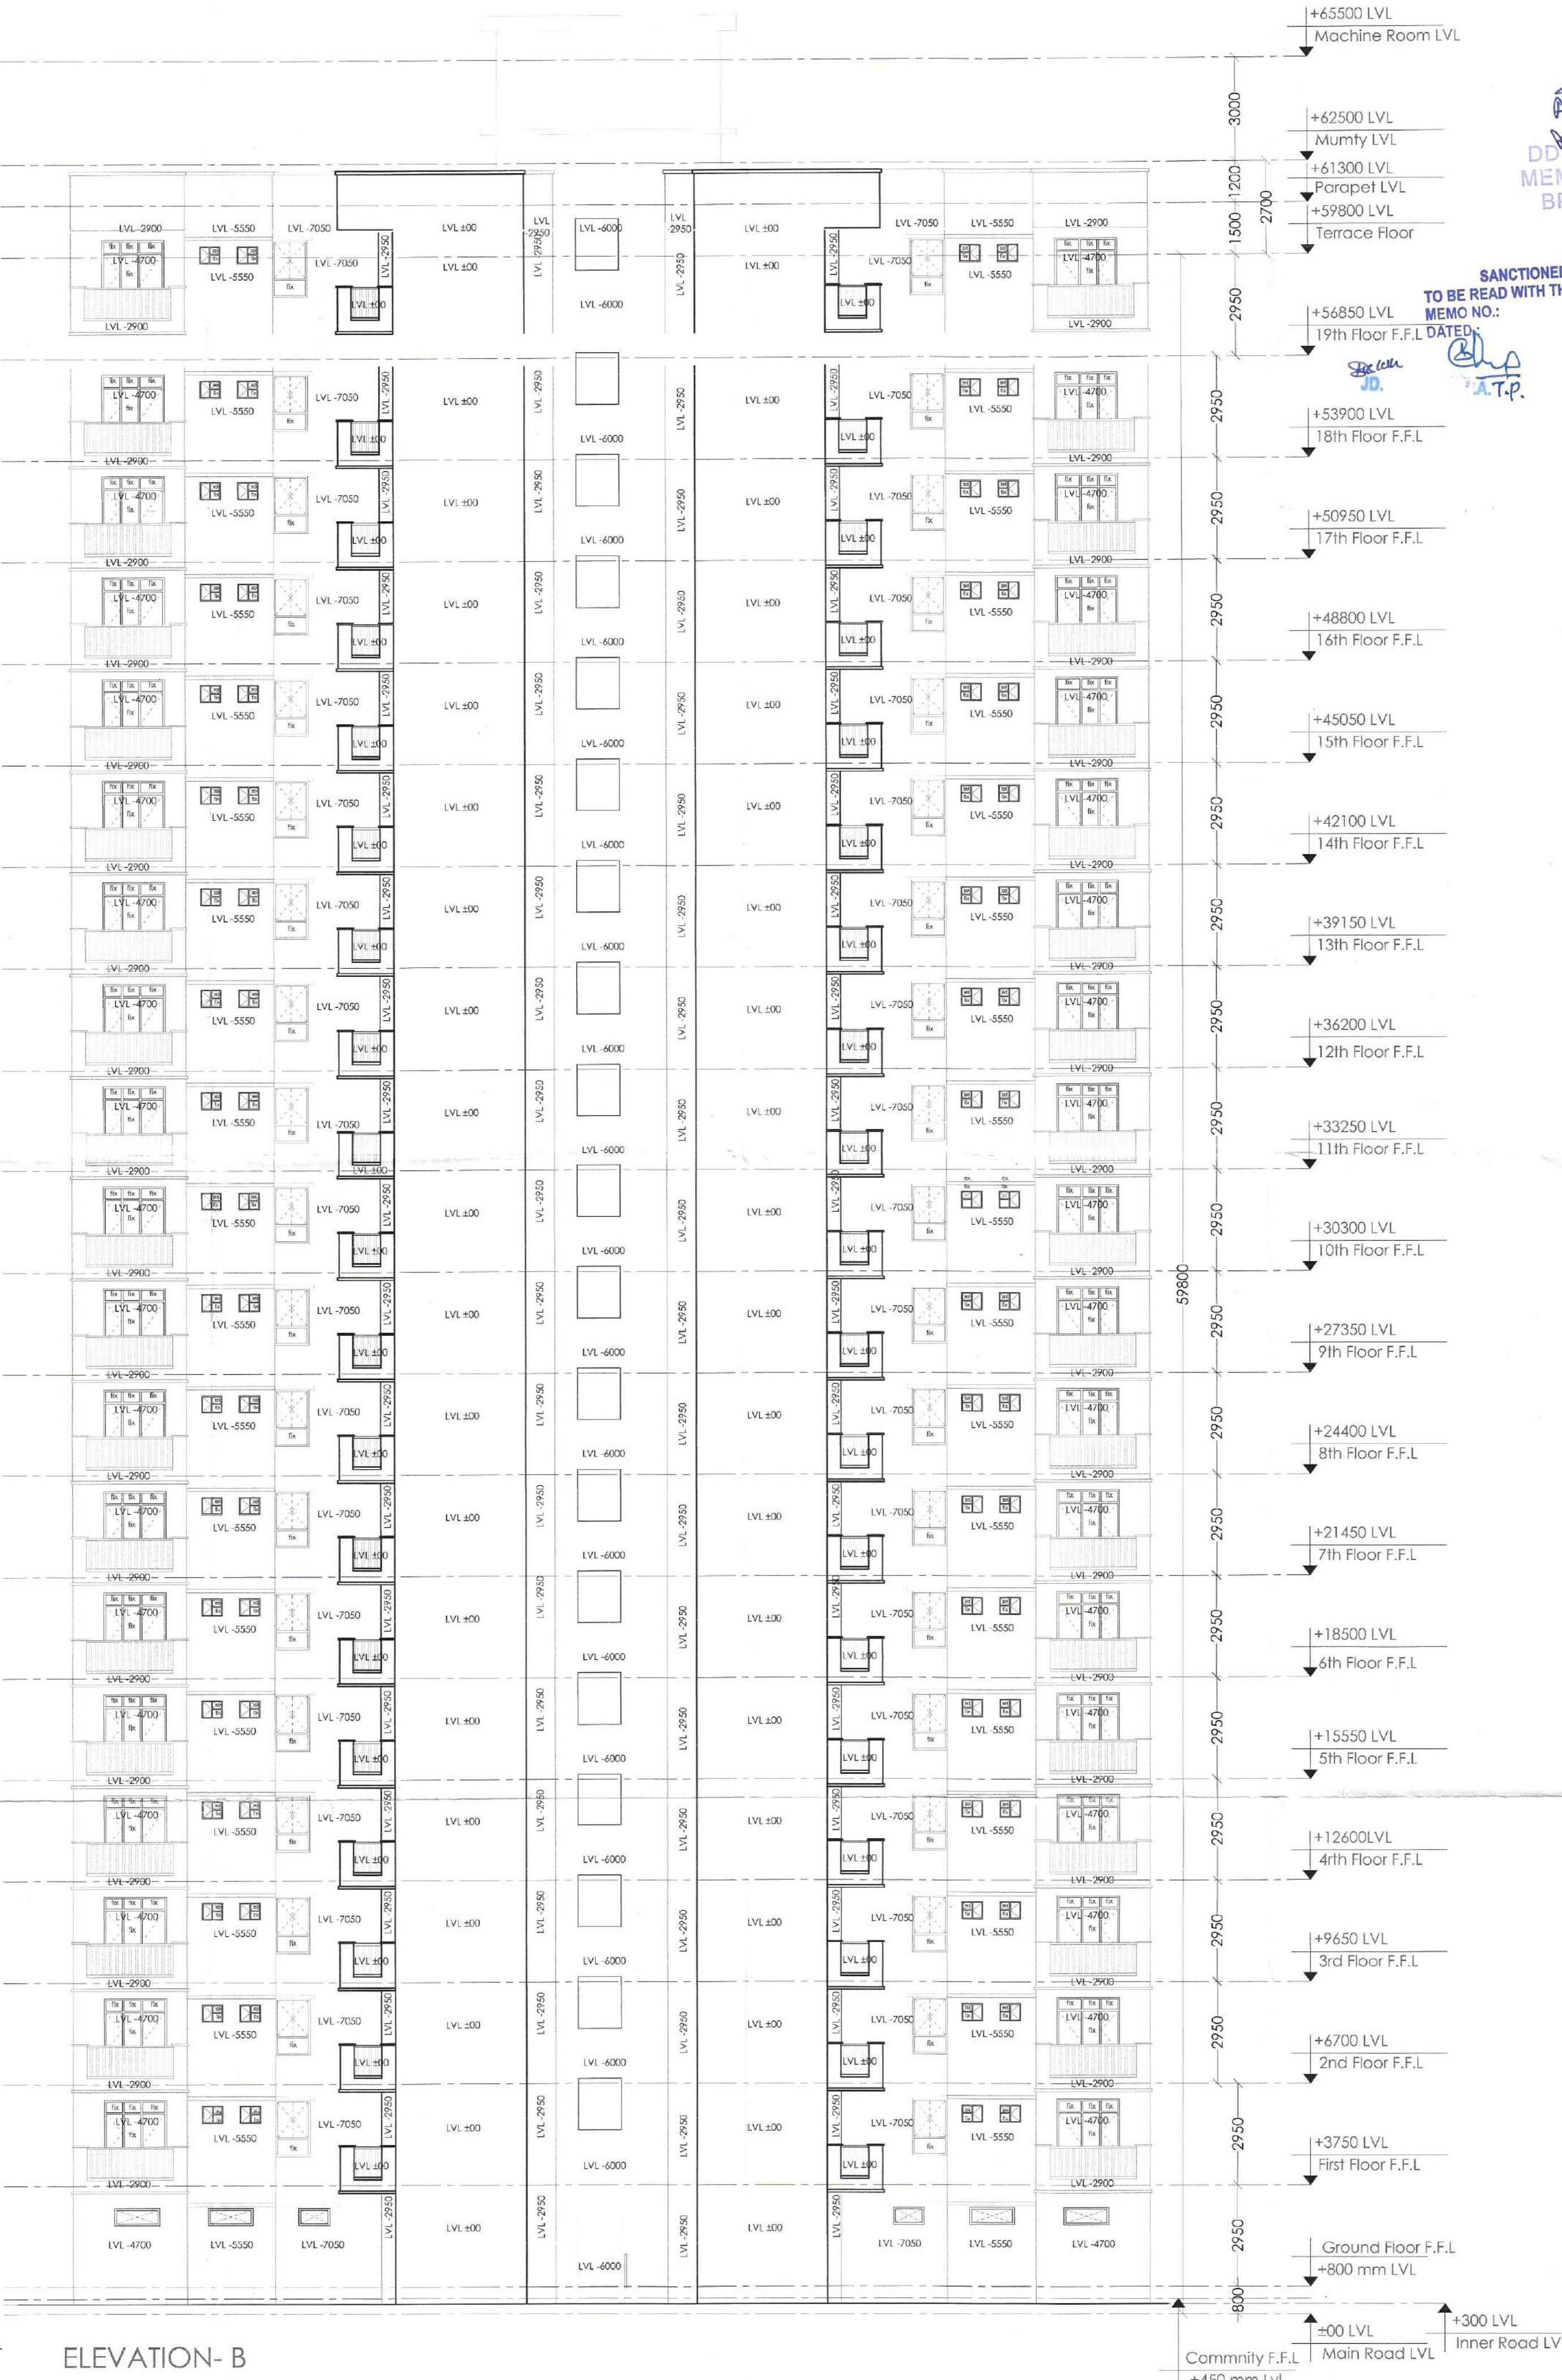


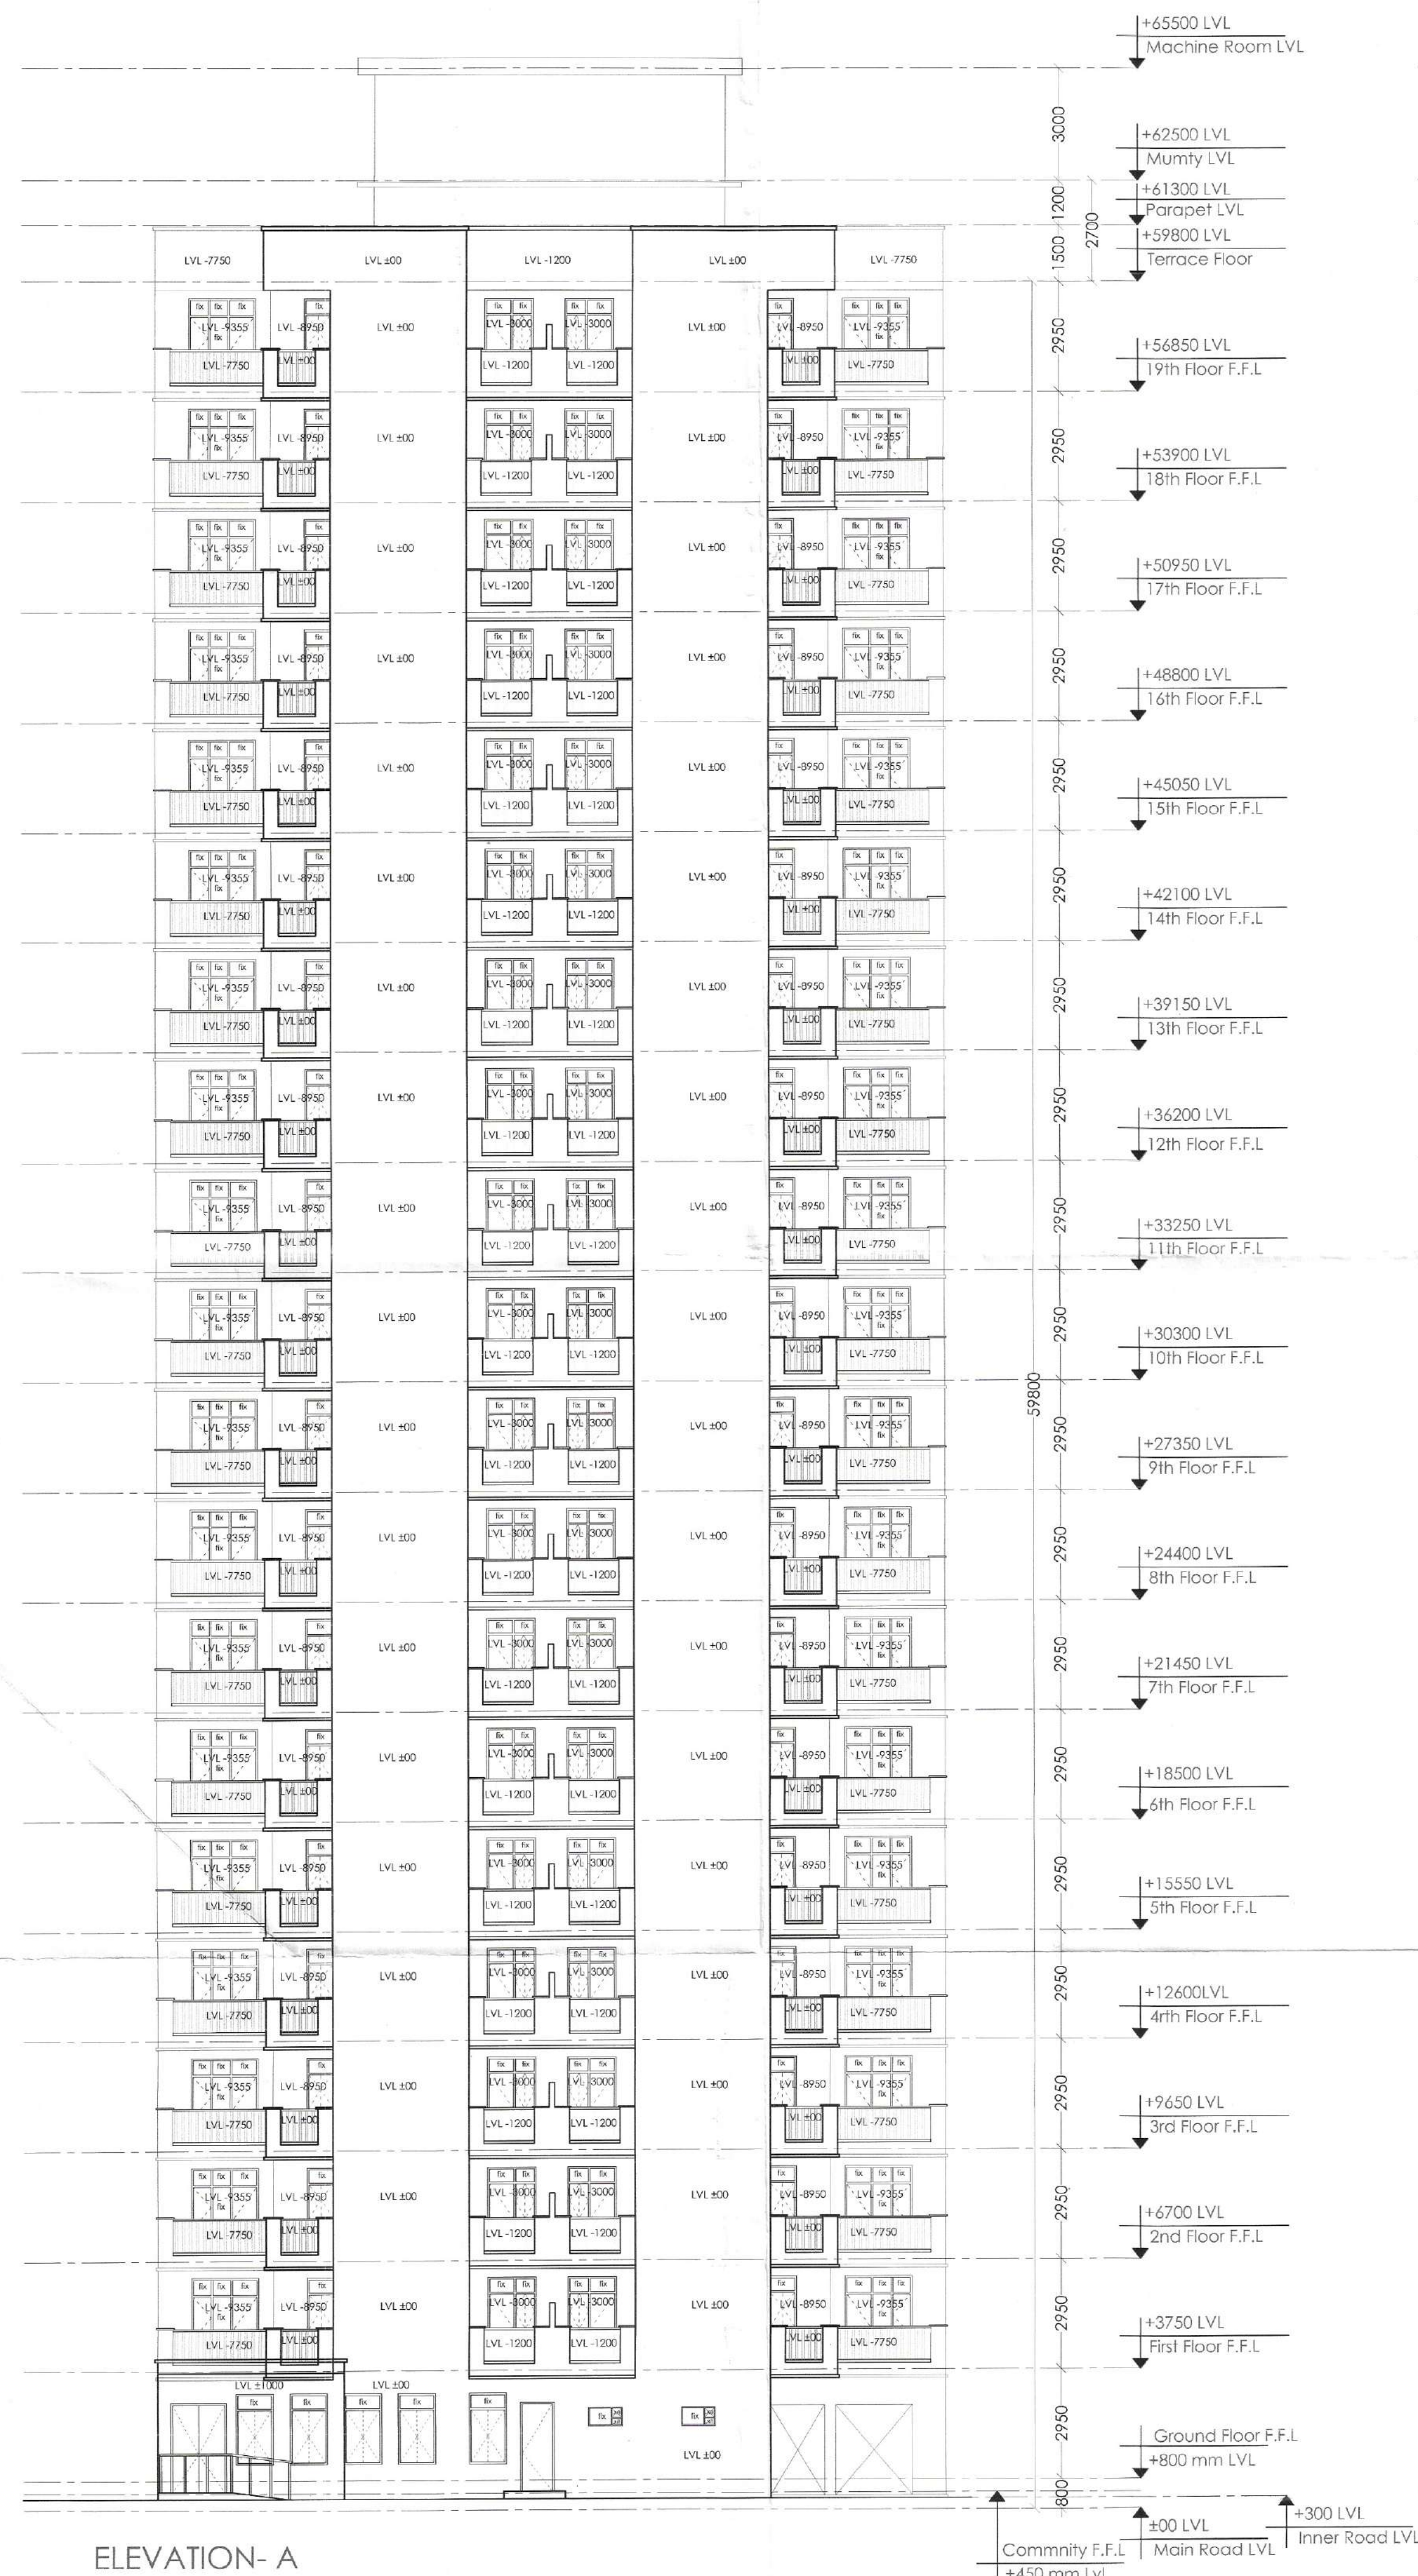

PLOT AREA =
= (10.02847 ACRES)
ALL DIMENSIONS ARE IN MM

AUTHORITY SIGNATURE

NOTES

1. ALL DIMENSIONS ARE IN MILLIMETER UNLESS STATED OTHERWISE.
2. THE CONSTRUCTION OF THE BUILDINGS SHALL BE GOVERNED BY PROVISIONS OF HARYANA BUILDING CODE, 2017 IS SUPPLEMENT TO THE NATIONAL BUILDING CODE OF INDIA, 2016 SHALL BE FOLLOWED.
3. THE GATE AND BOUNDARY WALL BE CONSTRUCTED AS/TO CODE.
4. THE CONSTRUCTION OF BASEMENT BE EXECUTED AS/TO CODE.
5. LIFTS & RAMP IN BUILDING AS/TO CODE.
6. PROPER FIRE SAFETY MEASURES PROVISIONS AS PER CODES.
7. INSTALLATION OF SOLAR POWER PLANT AS/TO CODE.
8. ADEQUATE PARKING SPACES - COVERED, OPEN OR IN THE BASEMENT AS/TO CODE.
9. PROVISION OF SEWAGE TREATMENT PLANT AS/TO CODE.

KEY PLAN

JOB TITLE

PROPOSED BUILDING PLAN OF
AFFORDABLE GROUP HOUSING COLONY
OVER AN AREA
MEASURING 10.02847 ACRES
(LICENCE NO. 73 DATED 01.06.2022) IN
SECTOR-68, GURUGRAM MANESAR
URBAN COMPLEX BEING
DEVELOPED BY
SH. MUKUL YADAV & OTHERS IN
COLLABORATION WITH PAREENA
INFRASTRUCTURE PVT. LTD.

OWNER

SH. MUKUL YADAV &
OTHERS IN COLLABORATION
WITH PAREENA
INFRASTRUCTURE PVT. LTD.

PROJECT

PROPOSED AFFORDABLE
GROUP HOUSING COLONY
AT SECTOR-68, GURUGRAM

CONSULTANTS

PARADISE CONSULTANTS

CONSULTANTS

PLOT NO. 9A, BASEMENT, POCKET 1
NEAR LIVING STYLE MALL, JASOLA VIHAR
NEW DELHI - 110025
EMAIL: paradiseconsultants@gmail.com

ARCHITECT

LINEAR CONCEPTS DESIGNS LLP

407, A08 GD I/L NORTH-EX TOWERS,
NETAJI SUBHASH PLACE,
NEW DELHI - 110034, INDIA
EMAIL: STUDIO@LINEARCONCEPTS.IN
TEL: +91 11 43016035

DESCRIPTION

SUBMISSION DRAWING

SCALE 1 : 100 @ A

SHEET NO.

DATE ISSUED 23-5-2022

DRAWN BY

CHECKED BY

ARCHITECT'S SIGNATURE AND SEAL

OWNER'S SIGNATURE AND SEAL

TOWER-5

ELEVATIONS

PROJECT NO.

DRAWING NO.

AF-AR-13