




SECTION YY'

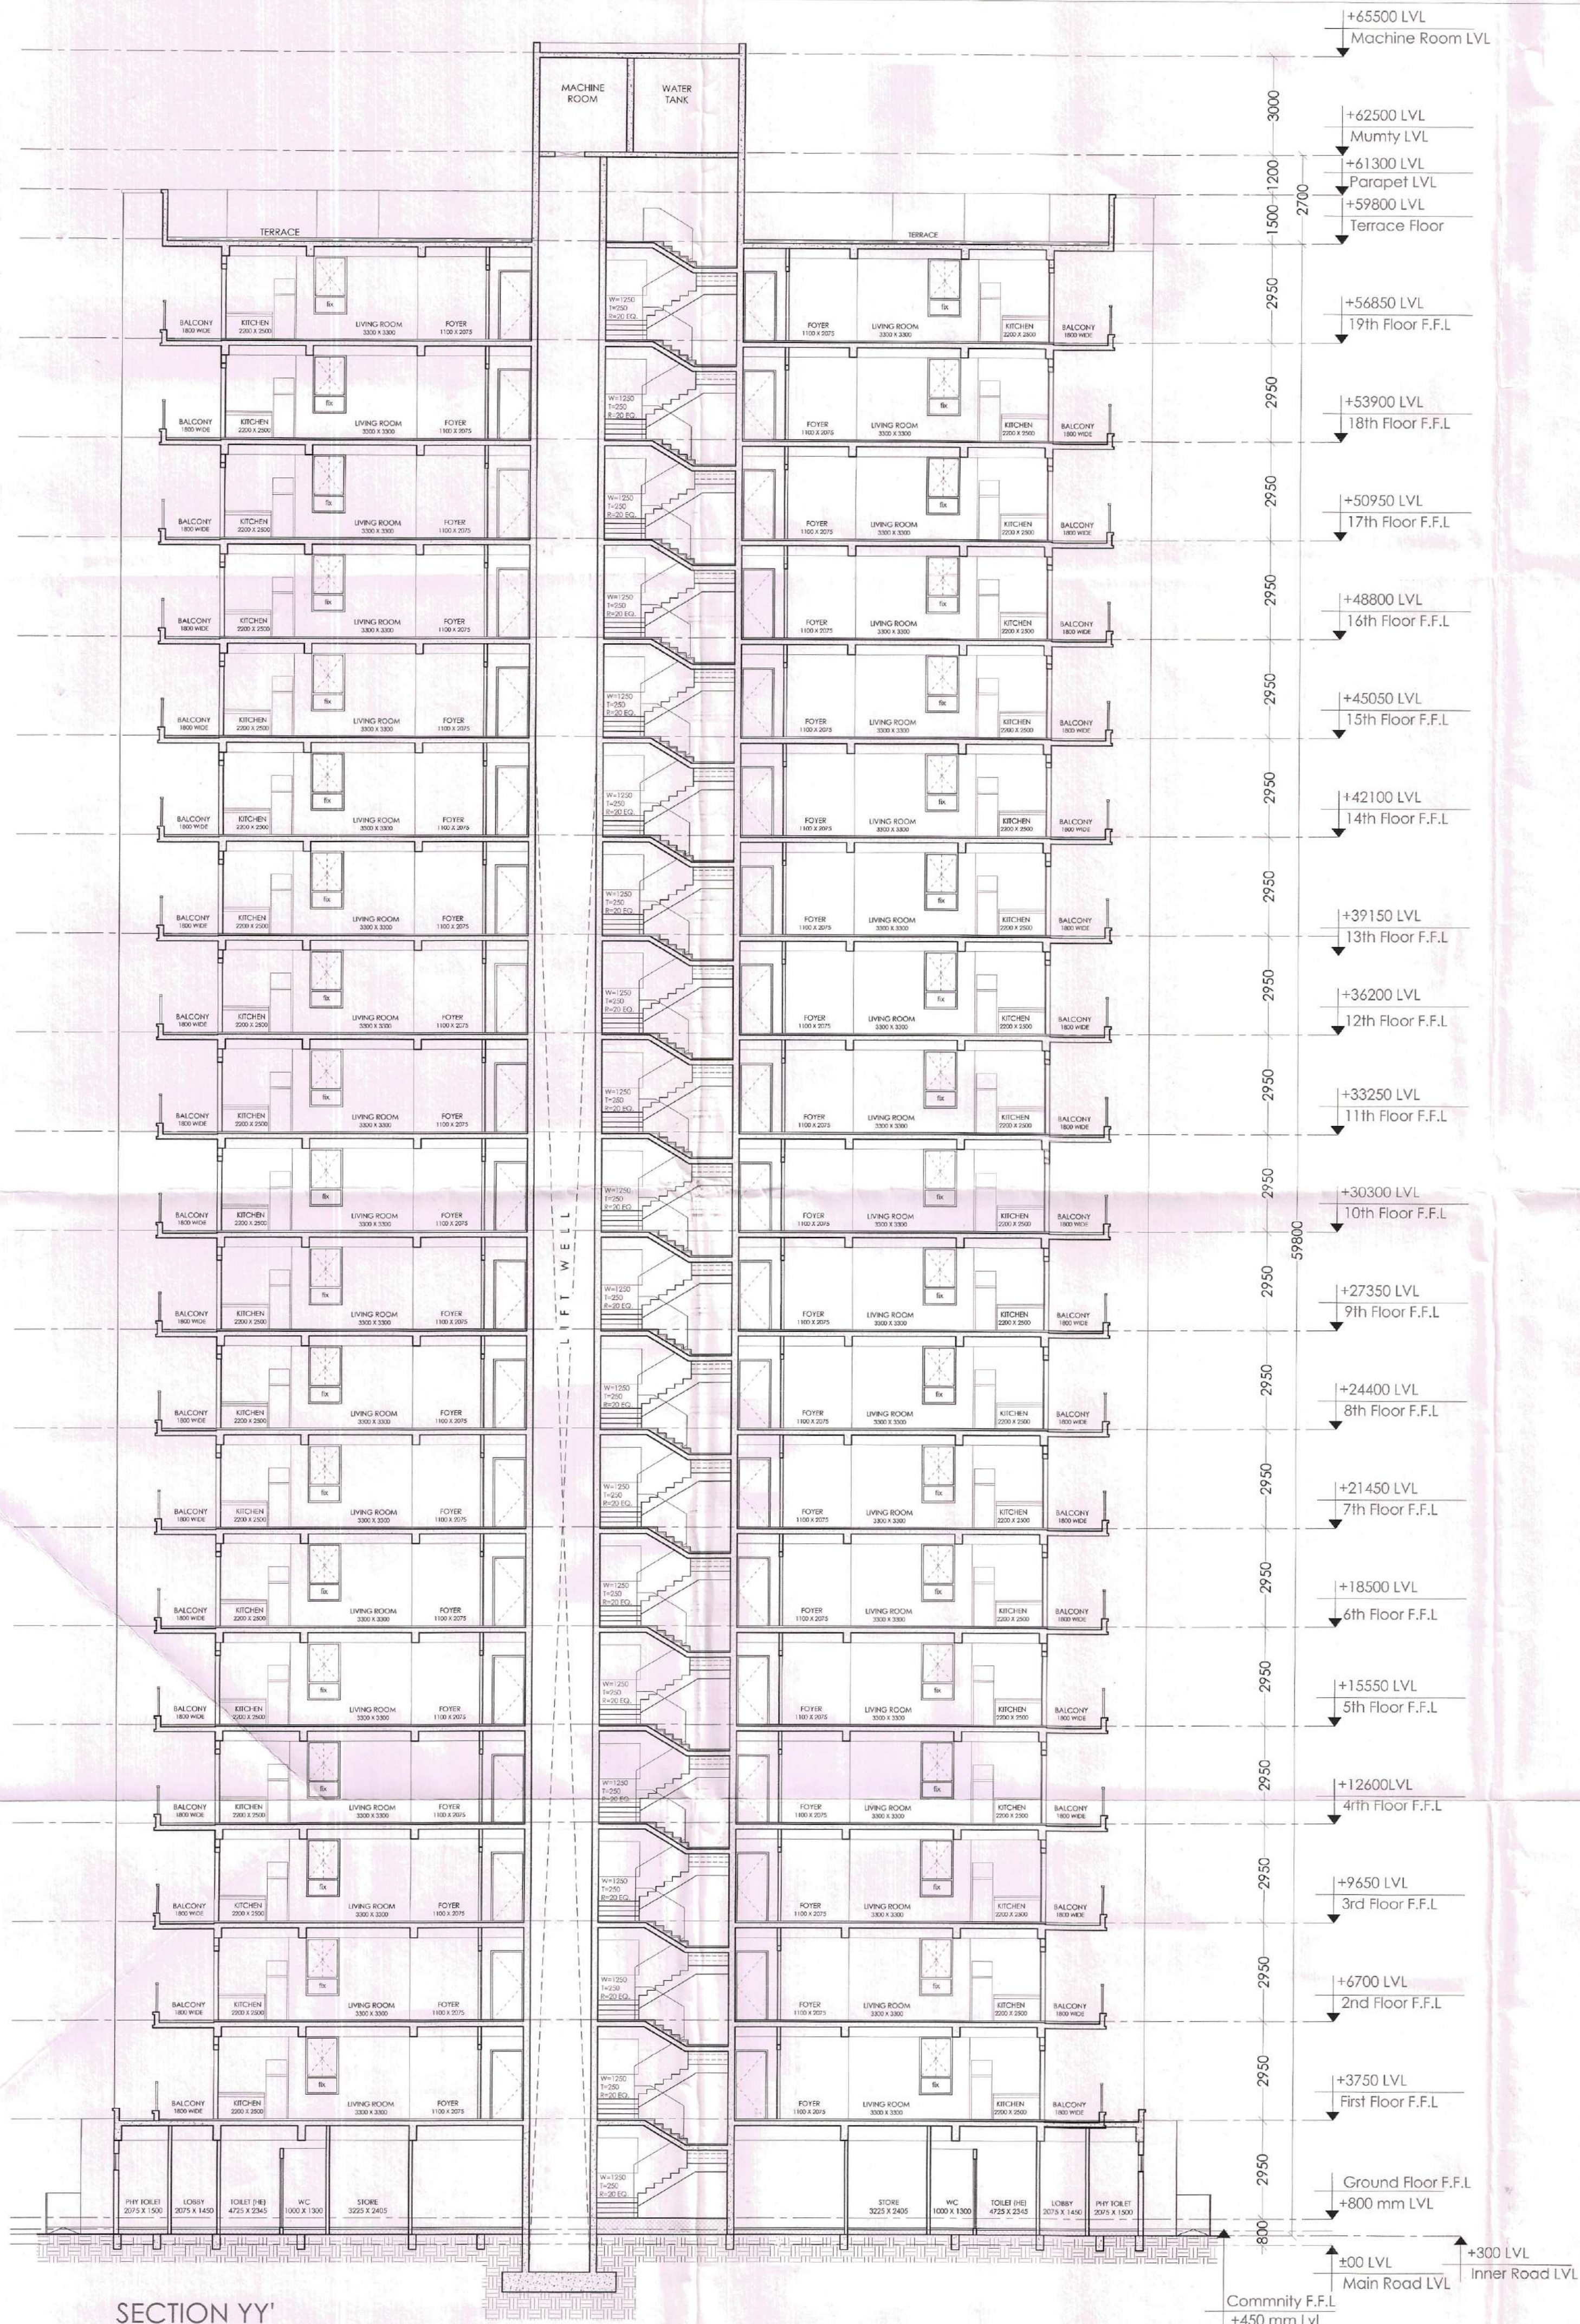

SECTION XX'

PLOT AREA =
= (10.02847 ACRES)
ALL DIMENSIONS ARE IN MM

AUTHORITY SIGNATURE

ATP/1401 S.T.P. Member Secretary B.P.A.C.
S.T.P.(G) Member B.P.A.C.
C.T.P.(Hr.) Chairman B.P.A.C.

DDT
MEMBER
BPA

Ram Avtar Bansi
JD(HQ)


NOTES

1. ALL DIMENSIONS ARE IN MILLIMETER UNLESS STATED OTHERWISE
2. THE CONSTRUCTION OF THE BUILDINGS SHALL BE COVERED BY PROVISIONS OF HARYANA BUILDING CODE, 2017 WHERE HARYANA BUILDING CODE, 2017 IS SILENT THE NATIONAL BUILDING CODE OF INDIA, 2016 SHALL BE FOLLOWED.
3. THE GATE AND BOUNDARY WALL BE CONSTRUCTED AS/CODE.
4. THE CONSTRUCTION OF BASEMENT BE EXECUTED AS/CODE.
5. LIFTS & RAMPS IN BUILDING AS/CODE.
6. PROPER FIRE SAFETY MEASURES PROVISIONS AS PER CODES.
7. INSTALLATION OF SOLAR POWER PLANT AS/CODE.
8. ADEQUATE PARKING SPACES - COVERED, OPEN OR IN THE BASEMENT AS/CODE.
9. PROVISION OF SEWAGE TREATMENT PLANT AS/CODE.

SANCTIONED
TO BE READ WITH THIS OFFICE
MEMO NO.:
DATED: 14/01/2022

ATP/1401

KEY PLAN

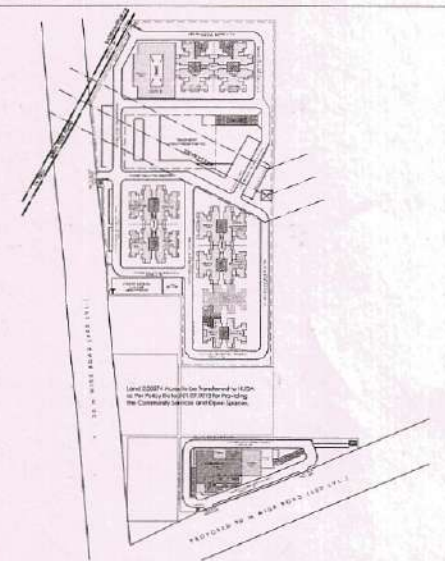

JOB TITLE

PROPOSED BUILDING PLAN OF
AFFORDABLE GROUP HOUSING COLONY
OVER AN AREA
MEASURING 10.02847 ACRES
(LICENCE NO. 73 DATED 01.06.2022) IN
SECTOR-68, GURUGRAM MANESAR
URBAN COMPLEX BEING
DEVELOPED BY
SH. MUKUL YADAV & OTHERS IN
COLLABORATION WITH PAREENA
INFRASTRUCTURE PVT. LTD.

OWNER
SH. MUKUL YADAV &
OTHERS IN COLLABORATION
WITH PAREENA
INFRASTRUCTURE PVT. LTD.

PROJECT
PROPOSED AFFORDABLE
GROUP HOUSING COLONY
AT SECTOR-68, GURUGRAM

CONSULTANTS
PARADISE CONSULTANTS

MEP CONSULTANTS
PLOT NO. 96, BASEMENT, POKET 1
NEAR LIVING STYLE MALL, JASOLA VIHAR
NEW DELHI - 110025
EMAIL: paradiseconsultants@gmail.com

ARCHITECT
LINEAR CONCEPTS DESIGNS LLP
407, A09 GD I.T. NORTH-EX TOWERS,
NETAJI SUBHASH PLACE
NEW DELHI - 110034, INDIA
EMAIL: STUDIO@LINEARCONCEPTS.IN
TEL: +91 11 43016035

DESCRIPTION

SUBMISSION DRAWING

SCALE 1: 100 @ A

SHEET NO.

DATE ISSUED 23-5-2022

DRAWN BY

CHECKED BY

ARCHITECT'S SIGNATURE
AND SEAL

OWNER'S SIGNATURE
AND SEAL



DRAWING BUILDING

TOWER-5

SECTIONS

PROJECT NO.

DRAWING NO.

AF-AR-14