
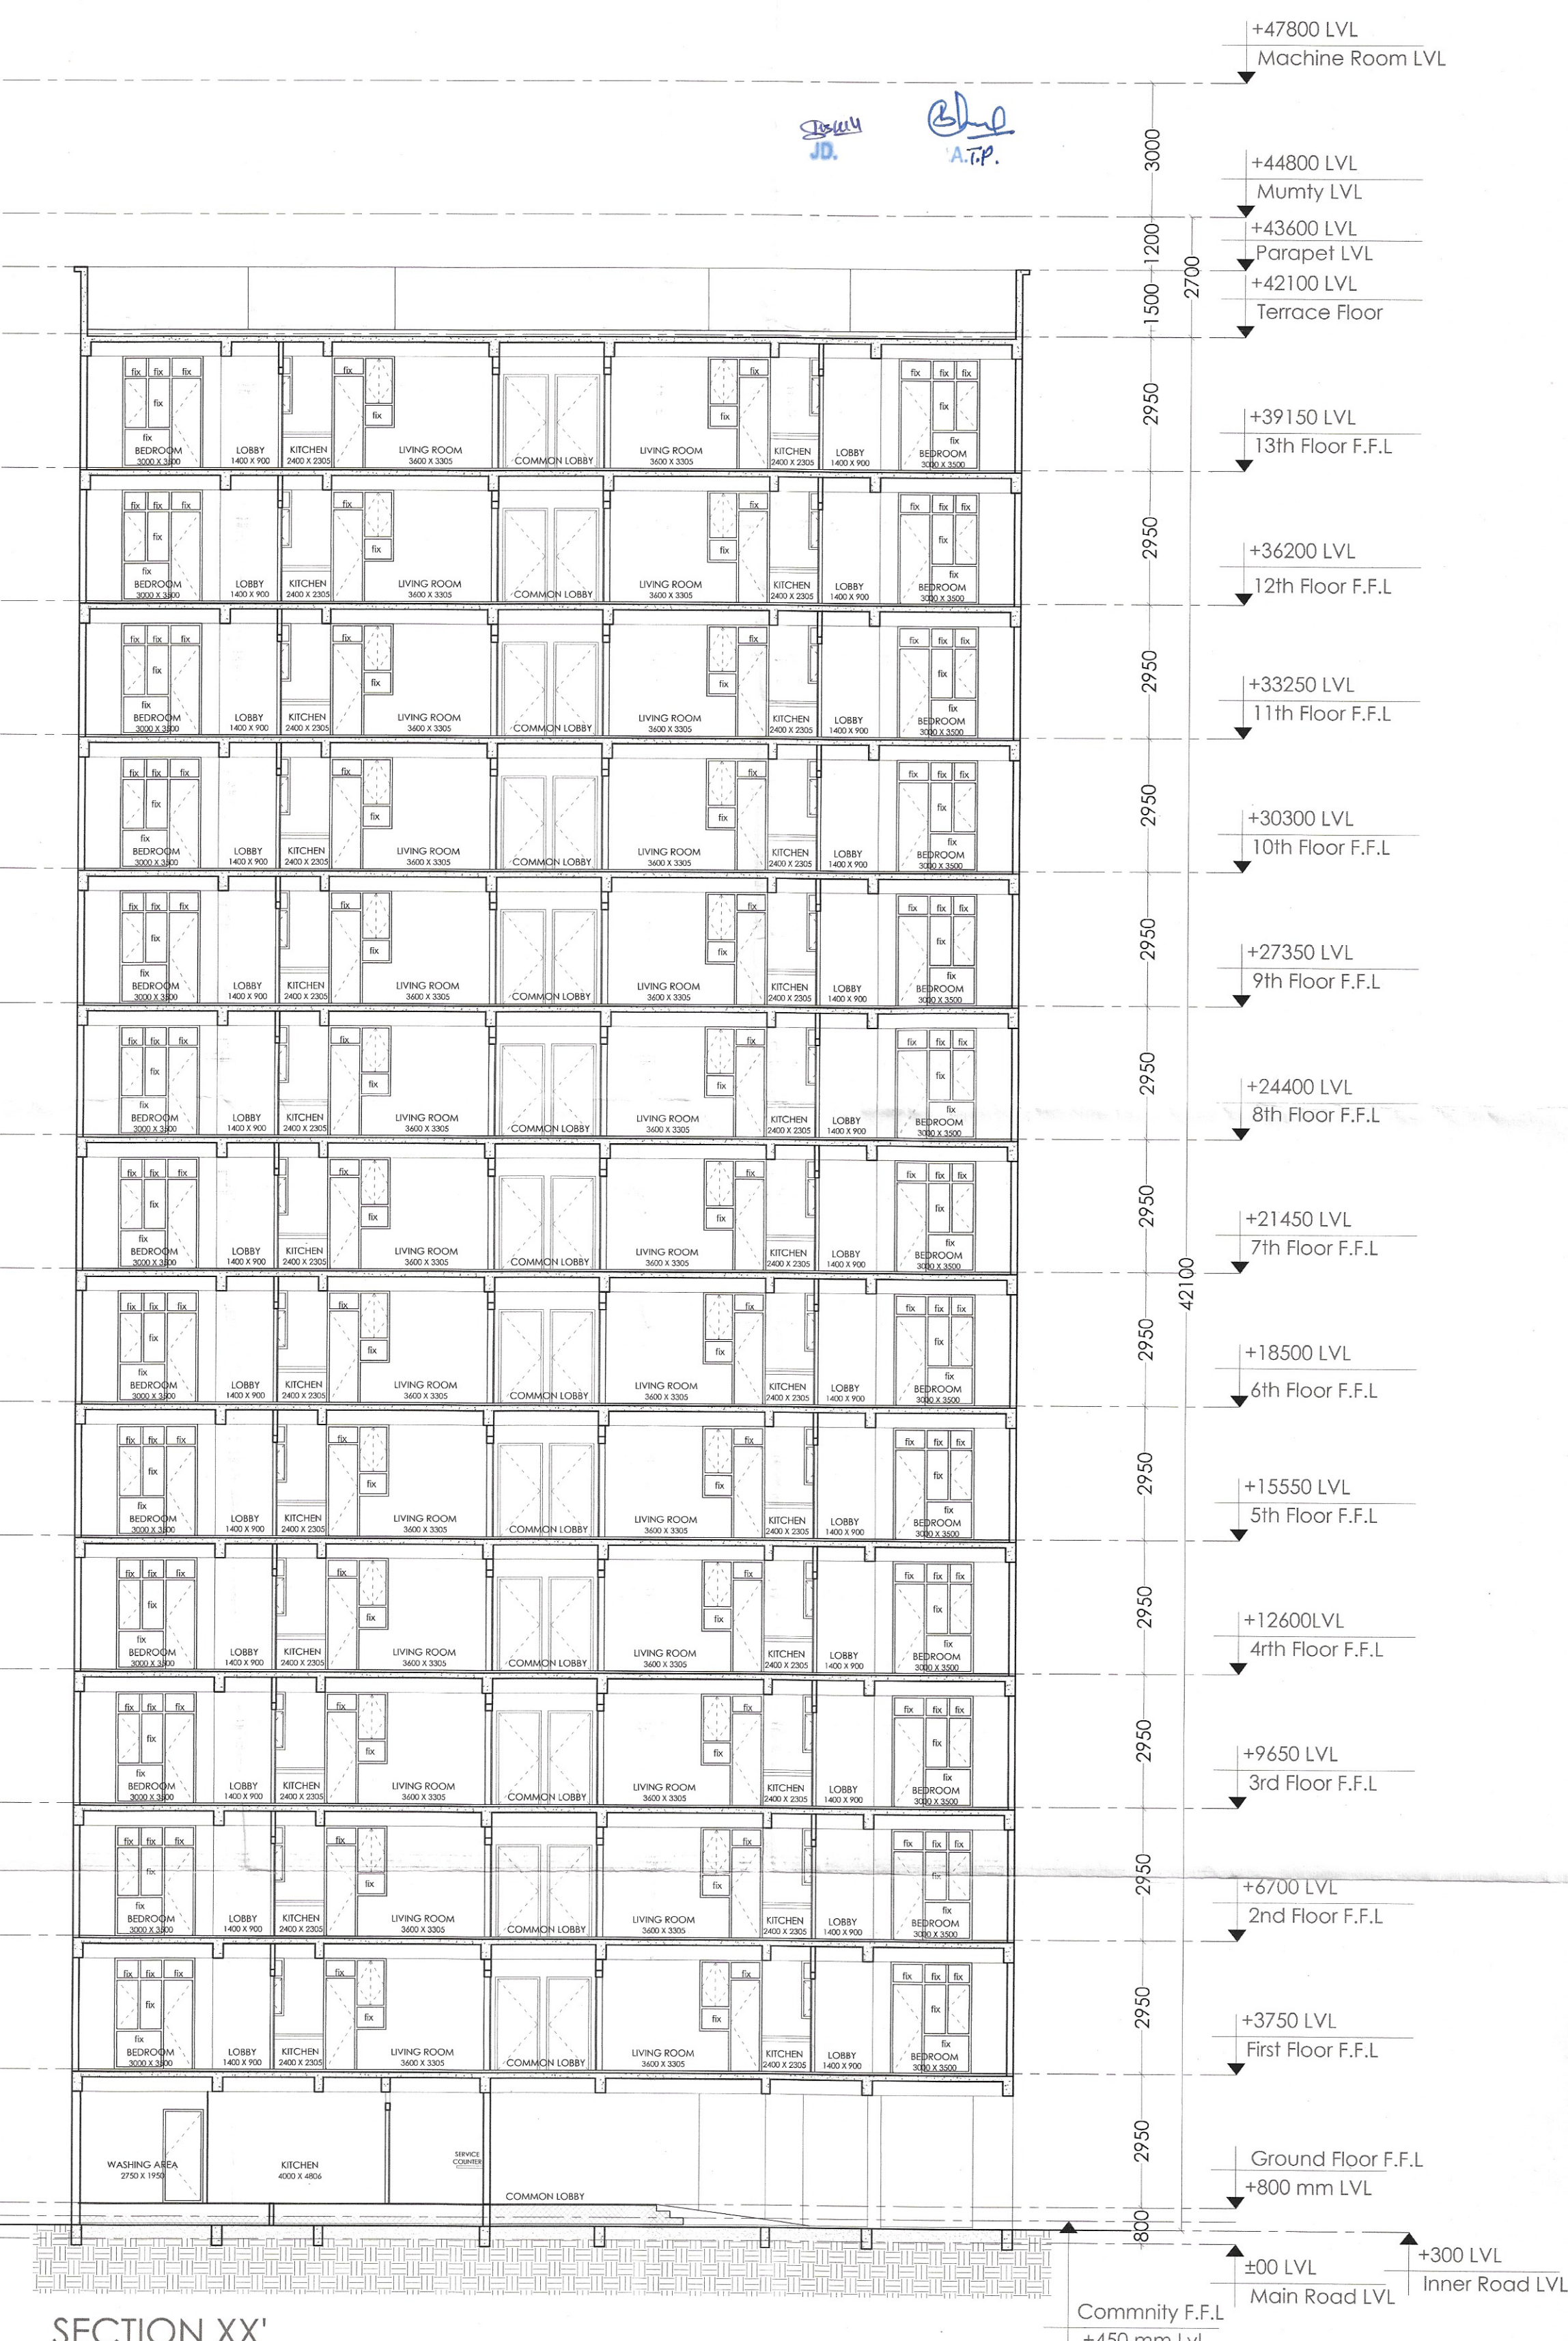


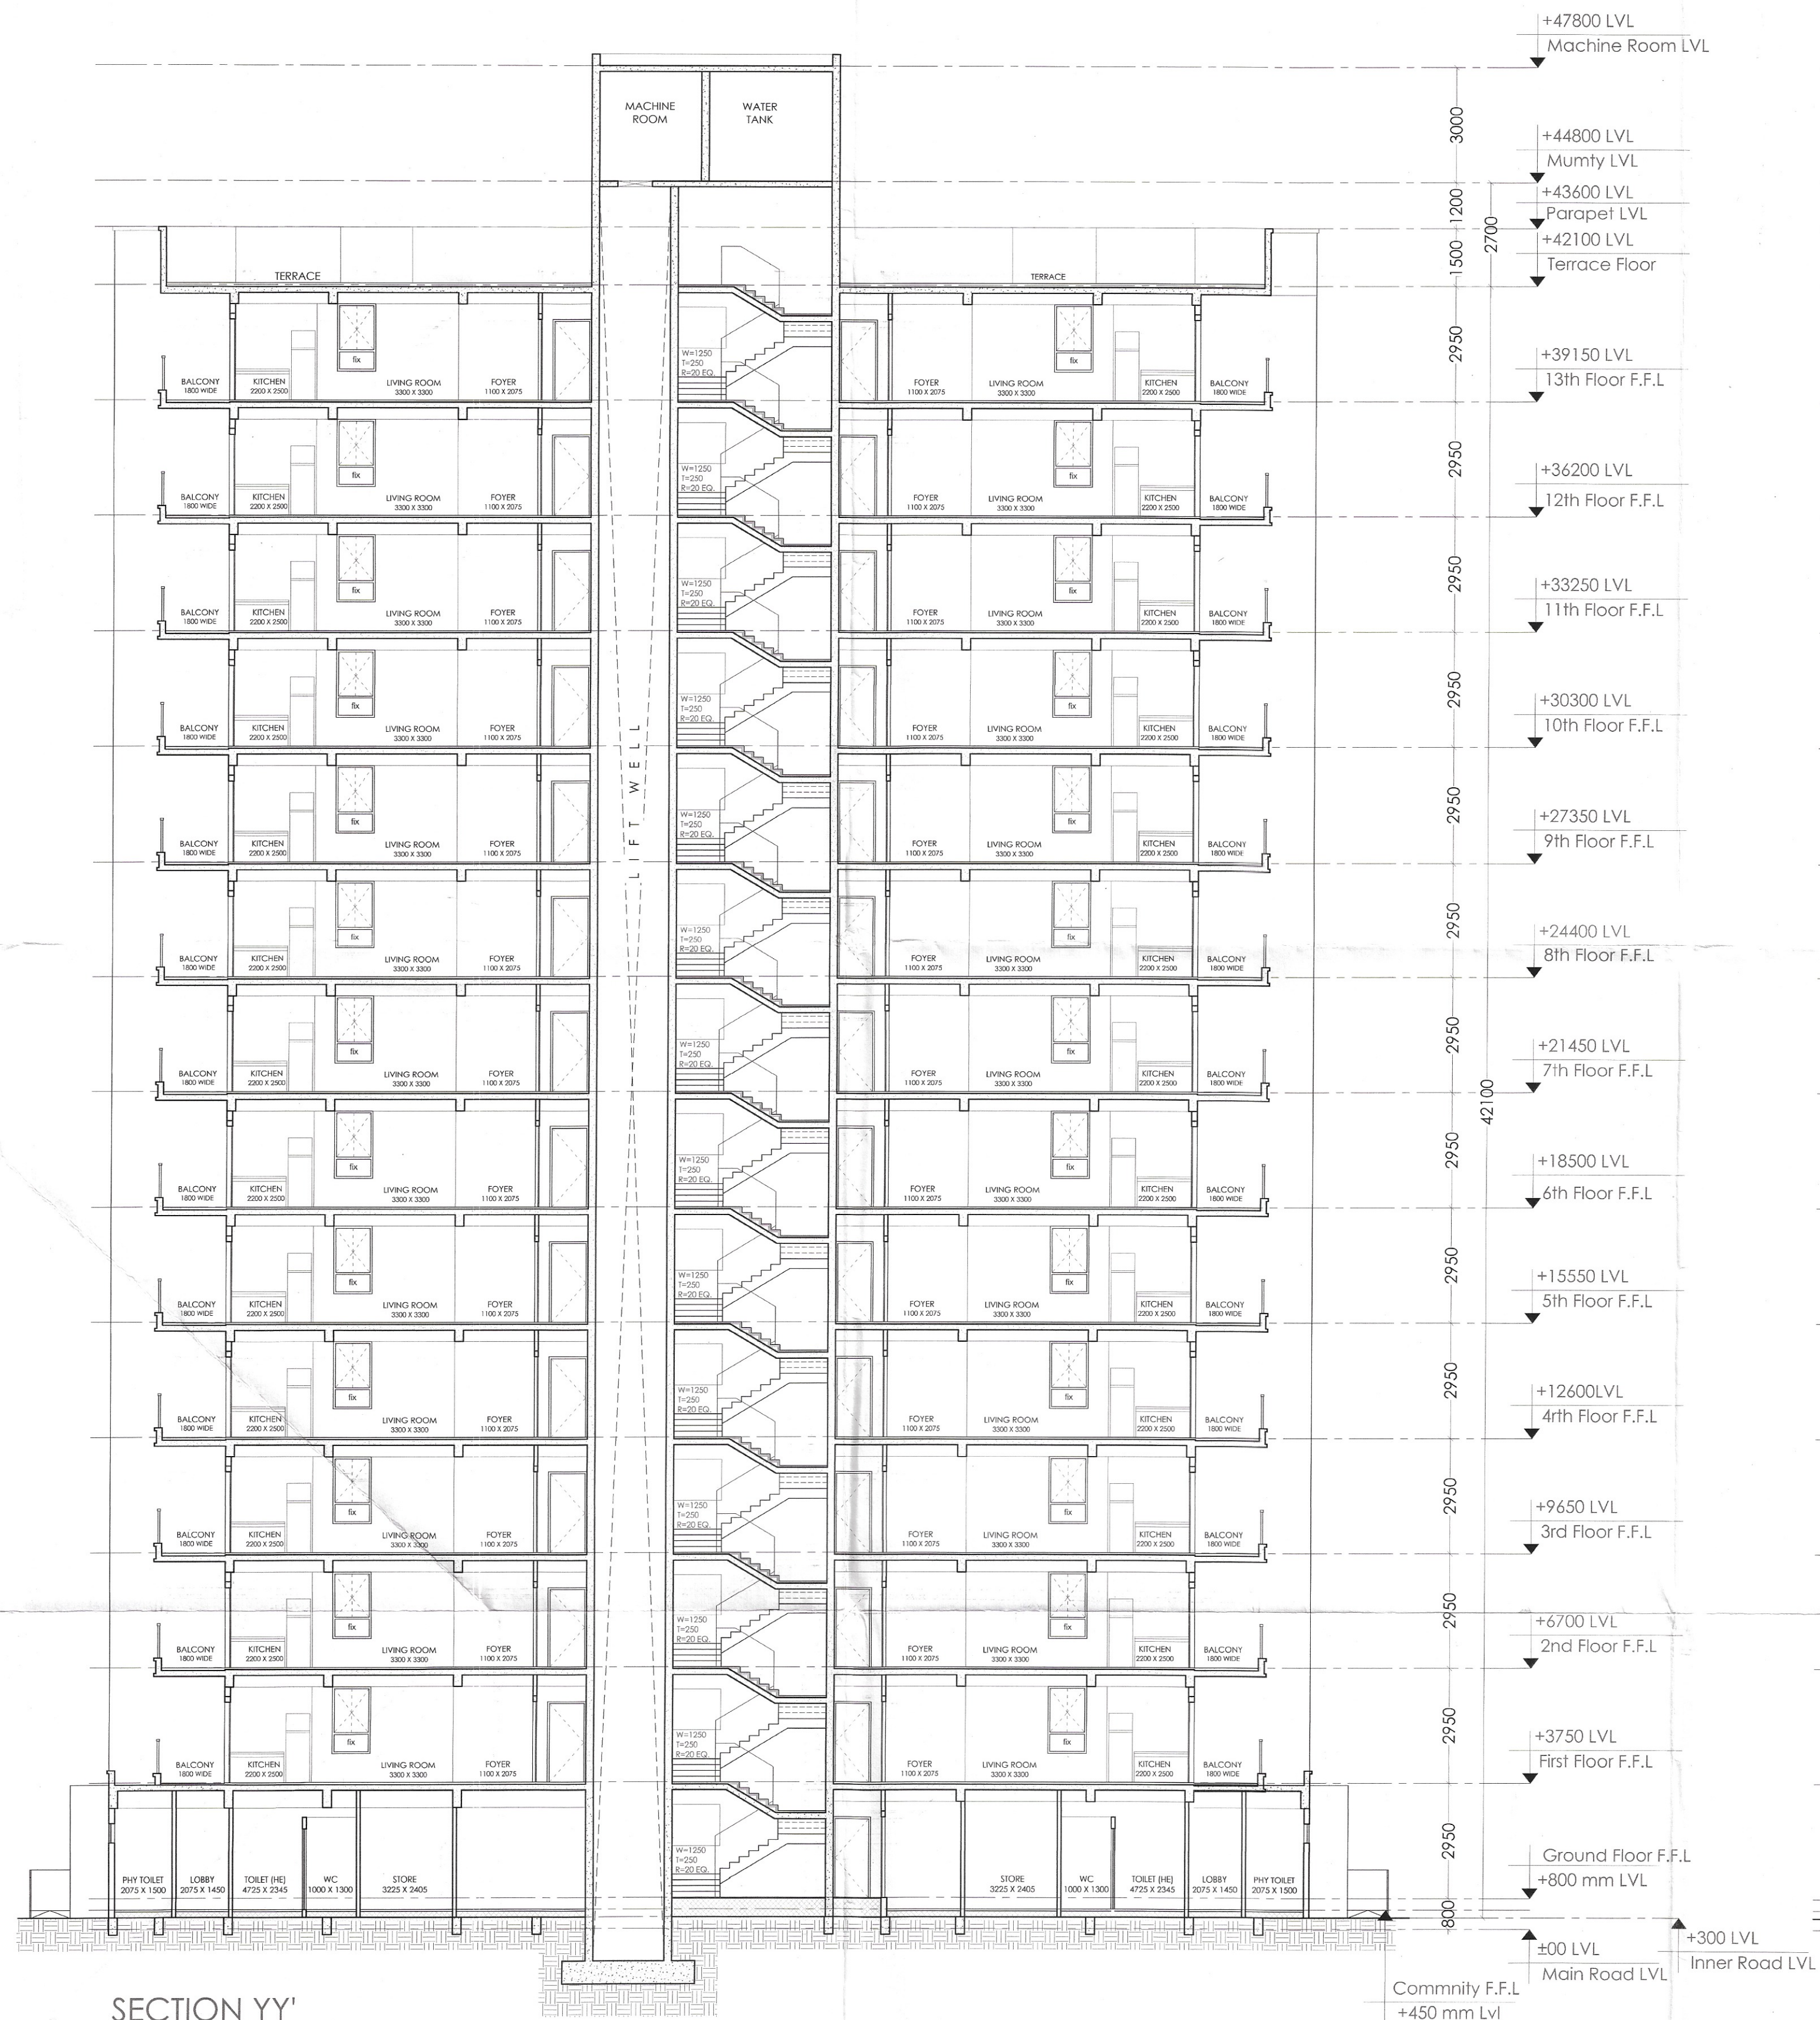

Sanctioned
TO BE READ WITH THIS OFFICE
MEMO NO.:
DATED :

DD (T)
MEMBER
BPAC

Ram Avtar Bassi
JD(HQ)


PLOT AREA =
= (10.02847 ACRES)
ALL DIMENSIONS ARE IN MM

AUTHORITY SIGNATURE

NOTES

1. ALL DIMENSIONS ARE IN MILLIMETER UNLESS STATED OTHERWISE.
2. THE CONSTRUCTION OF THE BUILDINGS SHALL BE GOVERNED BY PROVISIONS OF HARYANA BUILDING CODE, 2017 ISILENT THE NATIONAL BUILDING CODE OF INDIA, 2016 SHALL BE FOLLOWED.
3. THE GATE AND BOUNDARY WALL BE CONSTRUCTED AS/CODE.
4. THE CONSTRUCTION OF BASEMENT BE EXECUTED AS/CODE.
5. LIFT & RAMP IN BUILDING AS/CODE.
6. INSTALLATION OF SOLAR POWER PLANT AS/CODE.
7. ADEQUATE PARKING SPACES COVERED, OPEN OR IN THE BASEMENT AS/CODE.
8. PROVISION OF SEWAGE TREATMENT PLANT AS/CODE.

KEY PLAN

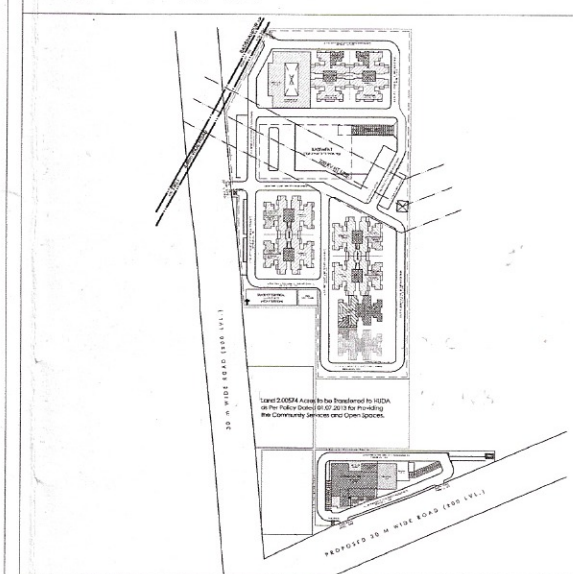

JOB TITLE

PROPOSED BUILDING PLAN OF
AFFORDABLE GROUP HOUSING COLONY
OVER AN AREA
MEASURING 10.02847 ACRES
(LICENCE NO. 73 DATED 01.06.2022) IN
SECTOR-68, GURUGRAM MANESAR
URBAN COMPLEX BEING
DEVELOPED BY
SH. MUKUL YADAV & OTHERS IN
COLLABORATION WITH PAREENA
INFRASTRUCTURE PVT. LTD.

SH. MUKUL YADAV &
OTHERS IN COLLABORATION
WITH PAREENA
INFRASTRUCTURE PVT. LTD.

PROPOSED AFFORDABLE
GROUP HOUSING COLONY
AT SECTOR-68, GURUGRAM

PARADISE CONSULTANTS

PLOT NO. 96, BASEMENT, POCKET I
NEAR LIVING STYLE MALL, JASOLA VIHAR
NEW DELHI - 110025
EMAIL: paradiseconsultants@gmail.com

LINEAR CONCEPTS DESIGNS LLP

407, A09 GD I/L NORTH-EX TOWERS,
NETAJI SUBHASH PLACE
NEW DELHI - 110034, INDIA
EMAIL: STUDIO@LINEARCONCEPTS.IN
TEL: +91 11 43016035

DESCRIPTION

SUBMISSION DRAWING

SCALE 1: 100 @ A

SHEET NO.

DATE ISSUED 23-5-2022

DRAWN BY

CHECKED BY

ARCHITECT'S SIGNATURE AND SEAL

OWNER'S SIGNATURE AND SEAL

GREEN JETI
PAREENA INFRASTRUCTURE PVT. LTD.
DIRECTOR

TOWER-6

SECTIONS

AF-AR-17