




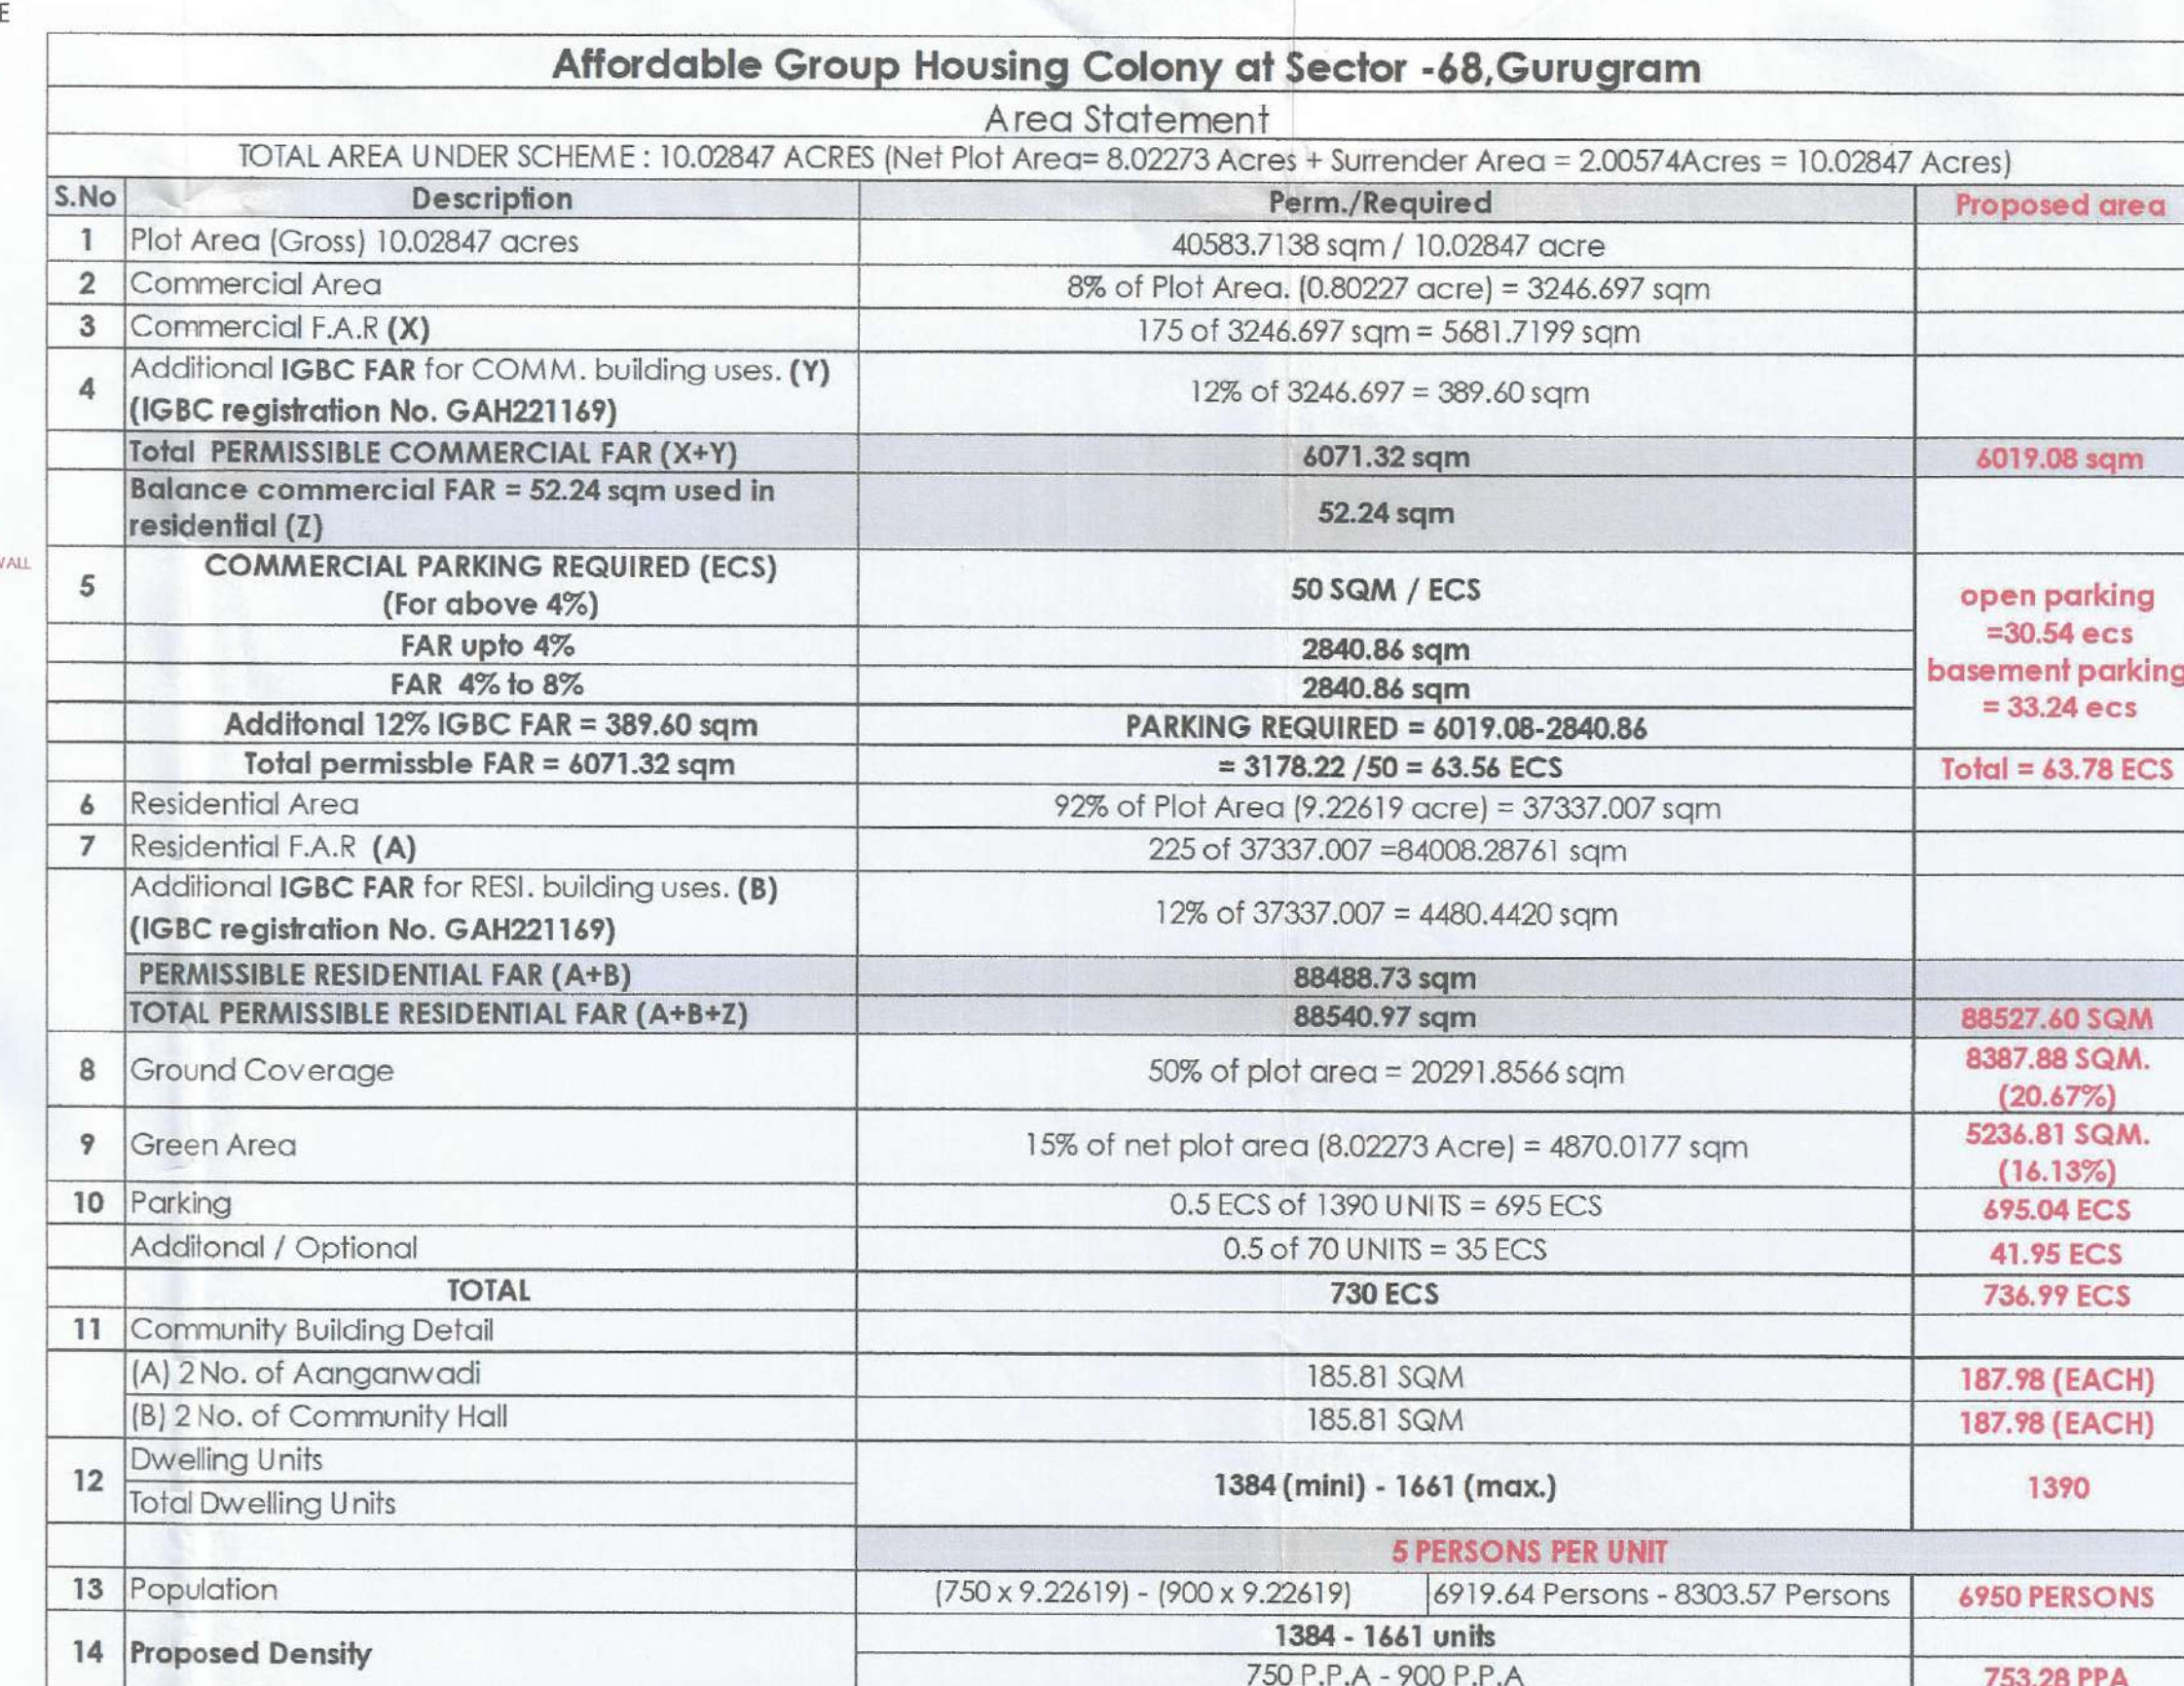

UNIT AREA DETAILS								
TOWER-1 (2 ROOM SET) (G+24)								
TYPOLOGY	GROUND FLOOR (6 UNITS)	TPP. 1ST TO 17TH (8 UNITS) / FUR	18TH FLOOR (8 UNITS)	TPP. 19TH-24TH (8 UNITS) / FUR	TPP. 25TH-24TH (8 UNITS) / FUR	TOTAL	CARPET AREA / UNIT (SQM)	BALCONY AREA / UNIT (SQM)
TYPE-1	2	68	4	8	16	98	60	10.48
TYPE-2	3	34	3	8	12	60	60	10.79
TYPE-3	0	34	1	0	0	35	60	10.35
						192		
TOWER-2 (2 ROOM SET) (G+24)								
TYPOLOGY	GROUND FLOOR (6 UNITS)	TPP. 1ST TO 17TH (8 UNITS) / FUR	18TH FLOOR (8 UNITS)	TPP. 19TH-20TH (8 UNITS) / FUR	TPP. 21TH-24TH (8 UNITS) / FUR	TOTAL	CARPET AREA / UNIT (SQM)	BALCONY AREA / UNIT (SQM)
TYPE-1	3	68	4	8	16	99	60	10.48
TYPE-2	3	34	3	8	12	60	60	10.29
TYPE-3	0	34	1	0	0	35	60	10.35
						184		
TOWER-3 (2 ROOM SET) (G+23)								
TYPOLOGY	GROUND FLOOR (6 UNITS)	TPP. 1ST TO 18TH (8 UNITS) / FUR	TPP. 25ST-28TH (8 UNITS) / FUR	-	-	TOTAL	CARPET AREA / UNIT (SQM)	BALCONY AREA / UNIT (SQM)
TYPE-1	3	80	12	0	0	95	60	10.33
TYPE-2	3	80	9	0	0	92	60	10.36
						187		
TOWER-4 (2 ROOM SET) (G+23)								
TYPOLOGY	GROUND FLOOR (6 UNITS)	TPP. 1ST TO 20TH (8 UNITS) / FUR	TPP. 25ST-28TH (8 UNITS) / FUR	-	-	TOTAL	CARPET AREA / UNIT (SQM)	BALCONY AREA / UNIT (SQM)
TYPE-1	3	80	12	0	0	95	60	10.13
TYPE-2	3	80	9	0	0	92	60	10.28
						187		
TOWER-5 (1 ROOM SET) (G+18)								
TYPOLOGY	GROUND FLOOR (5 UNITS)	TPP. 1ST TO 18TH (8 UNITS) / FUR	19TH FLOOR (8 UNITS) / FUR	-	-	TOTAL	CARPET AREA / UNIT (SQM)	BALCONY AREA / UNIT (SQM)
TYPE-1	0	72	4	0	0	76	34.92	9.71
TYPE-2	0	72	4	0	0	76	35.54	9.94
						152		
TOWER-6 (1 ROOM SET) (G+13)								
TYPOLOGY	GROUND FLOOR (5 UNITS)	TPP. 1ST TO 13TH (8 UNITS) / FUR	-	-	-	TOTAL	CARPET AREA / UNIT (SQM)	BALCONY AREA / UNIT (SQM)
TYPE-1	0	52	0	0	0	52	34.92	9.71
TYPE-2	0	52	0	0	0	52	35.54	9.94
						104		
TOWER-7 (2 ROOM SET) (G+23)								
TYPOLOGY	GROUND FLOOR (6 UNITS)	TPP. 1ST TO 20TH (8 UNITS) / FUR	-	-	-	TOTAL	CARPET AREA / UNIT (SQM)	BALCONY AREA / UNIT (SQM)
TYPE-1	3	80	12	0	0	95	60	10.13
TYPE-2	3	80	9	0	0	92	60	10.36
						187		
TOWER-8 (2 ROOM SET) (G+23)								
TYPOLOGY	GROUND FLOOR (6 UNITS)	TPP. 1ST TO 20TH (8 UNITS) / FUR	TPP. 25ST-28TH (8 UNITS) / FUR	-	-	TOTAL	CARPET AREA / UNIT (SQM)	BALCONY AREA / UNIT (SQM)
TYPE-1	3	80	12	0	0	95	60	10.13
TYPE-2	3	80	9	0	0	92	60	10.36
						187		
TOTAL						1390		
						1390		

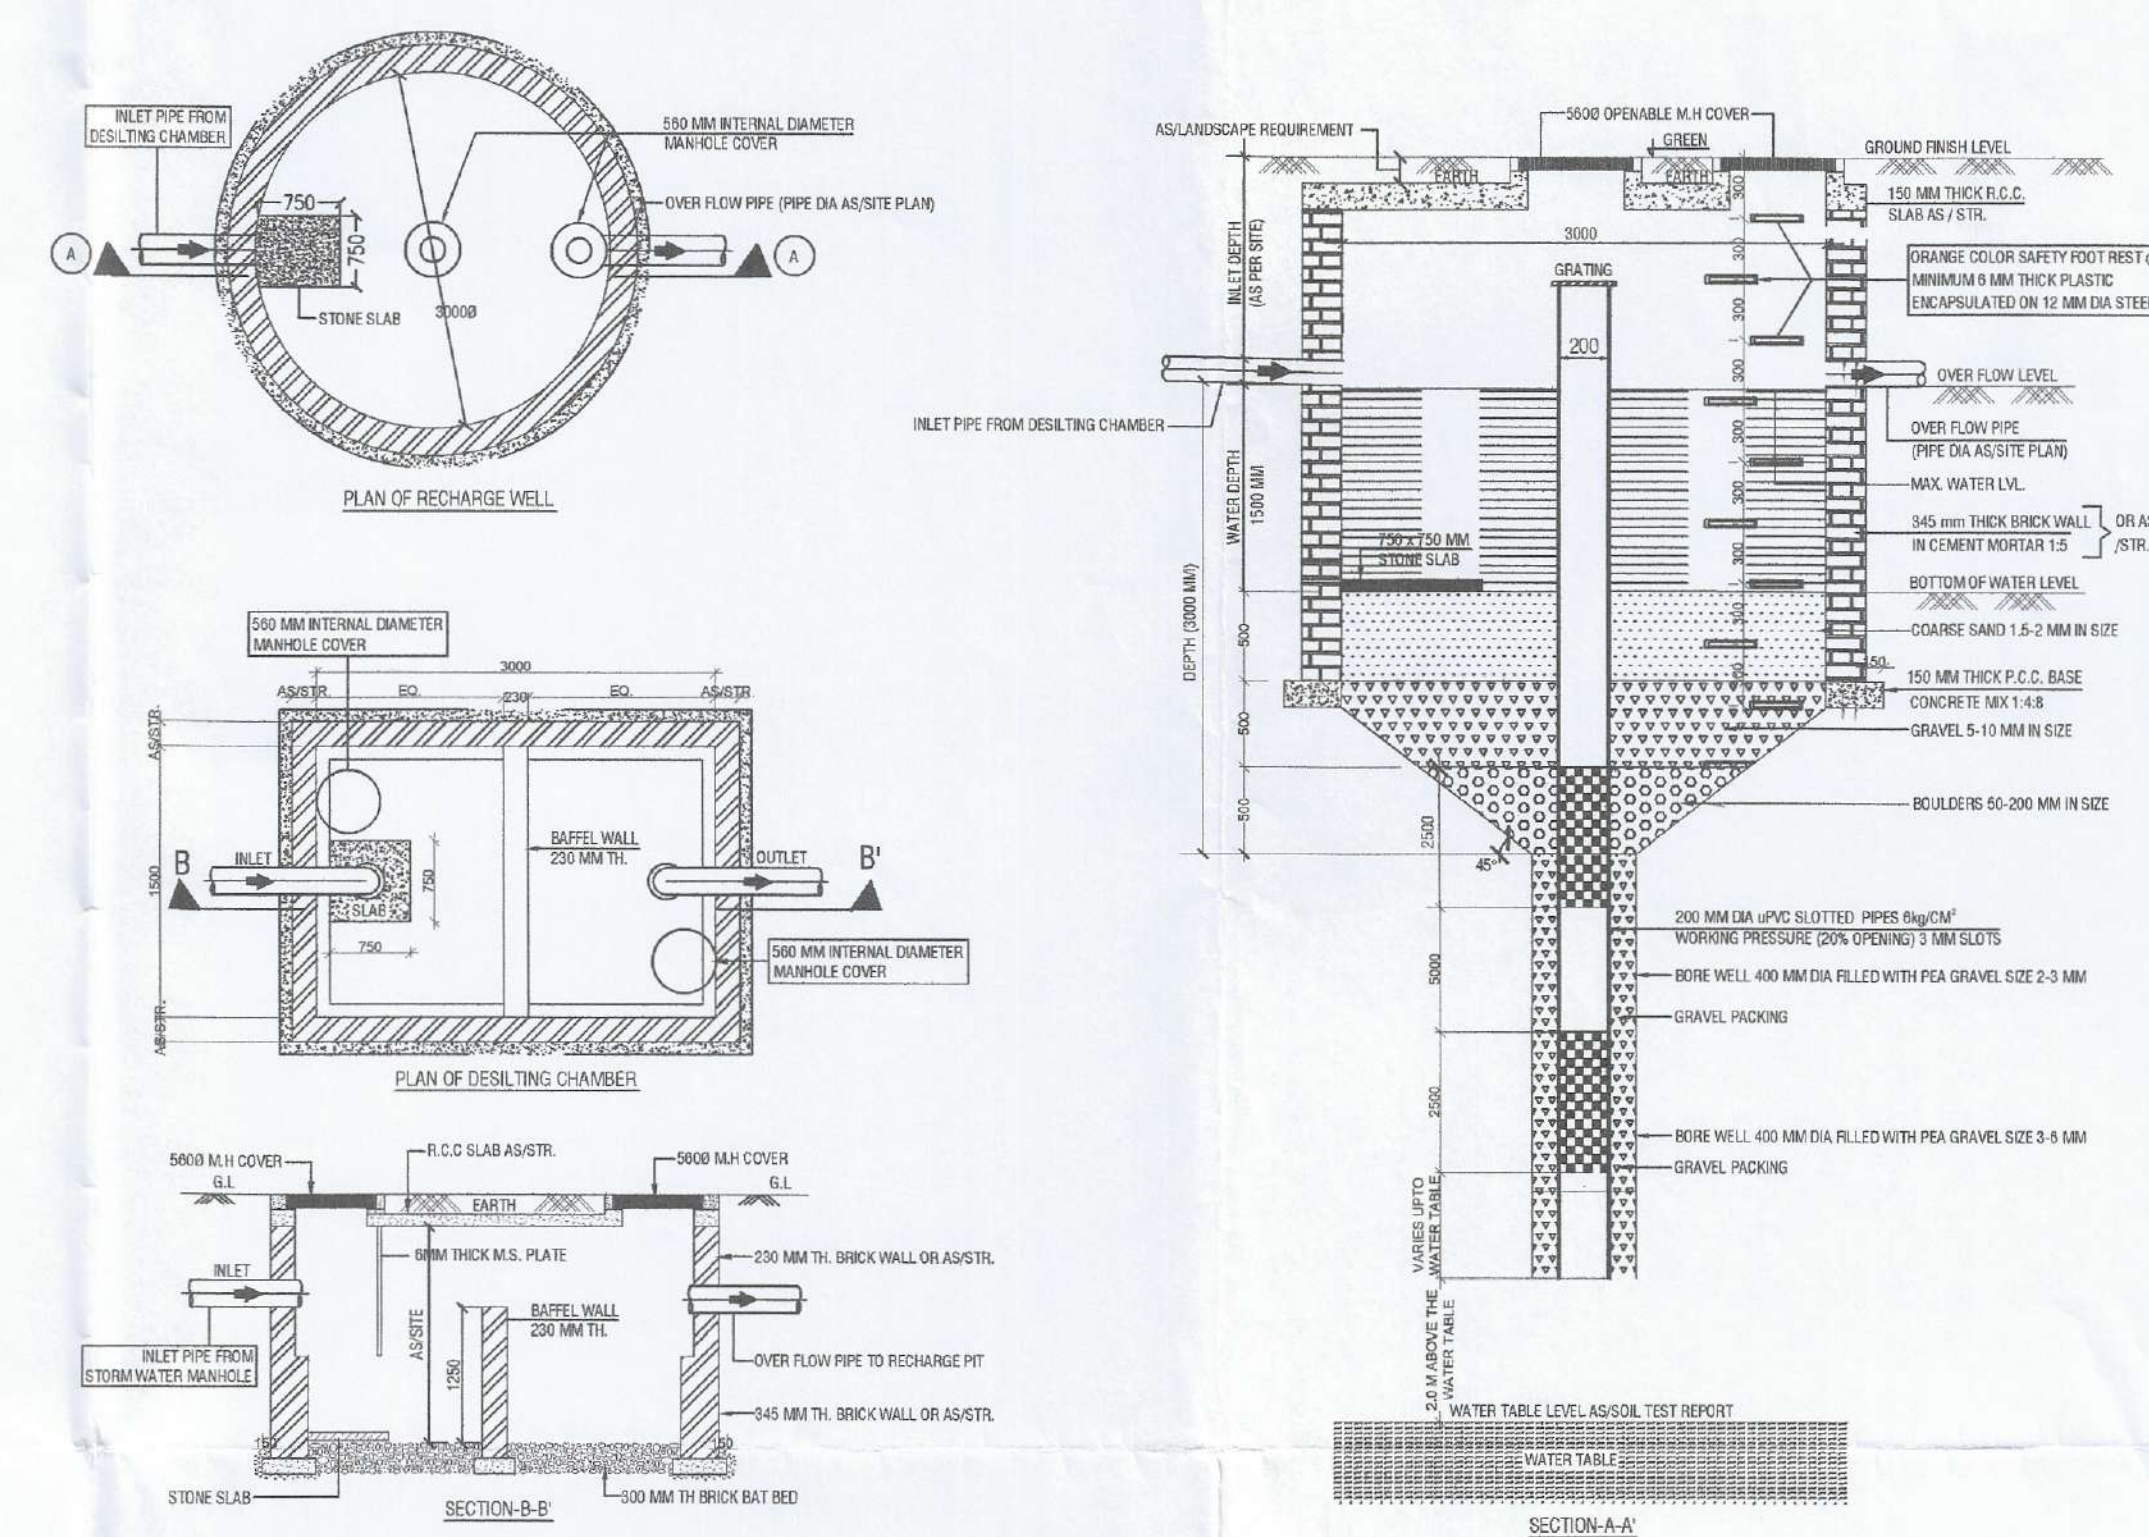

Land 2.00574 Acres to be Transferred to HSVP / DEPTT. as Per Policy Dated 01.07.2013 for Providing the Community Services and Open Spaces.

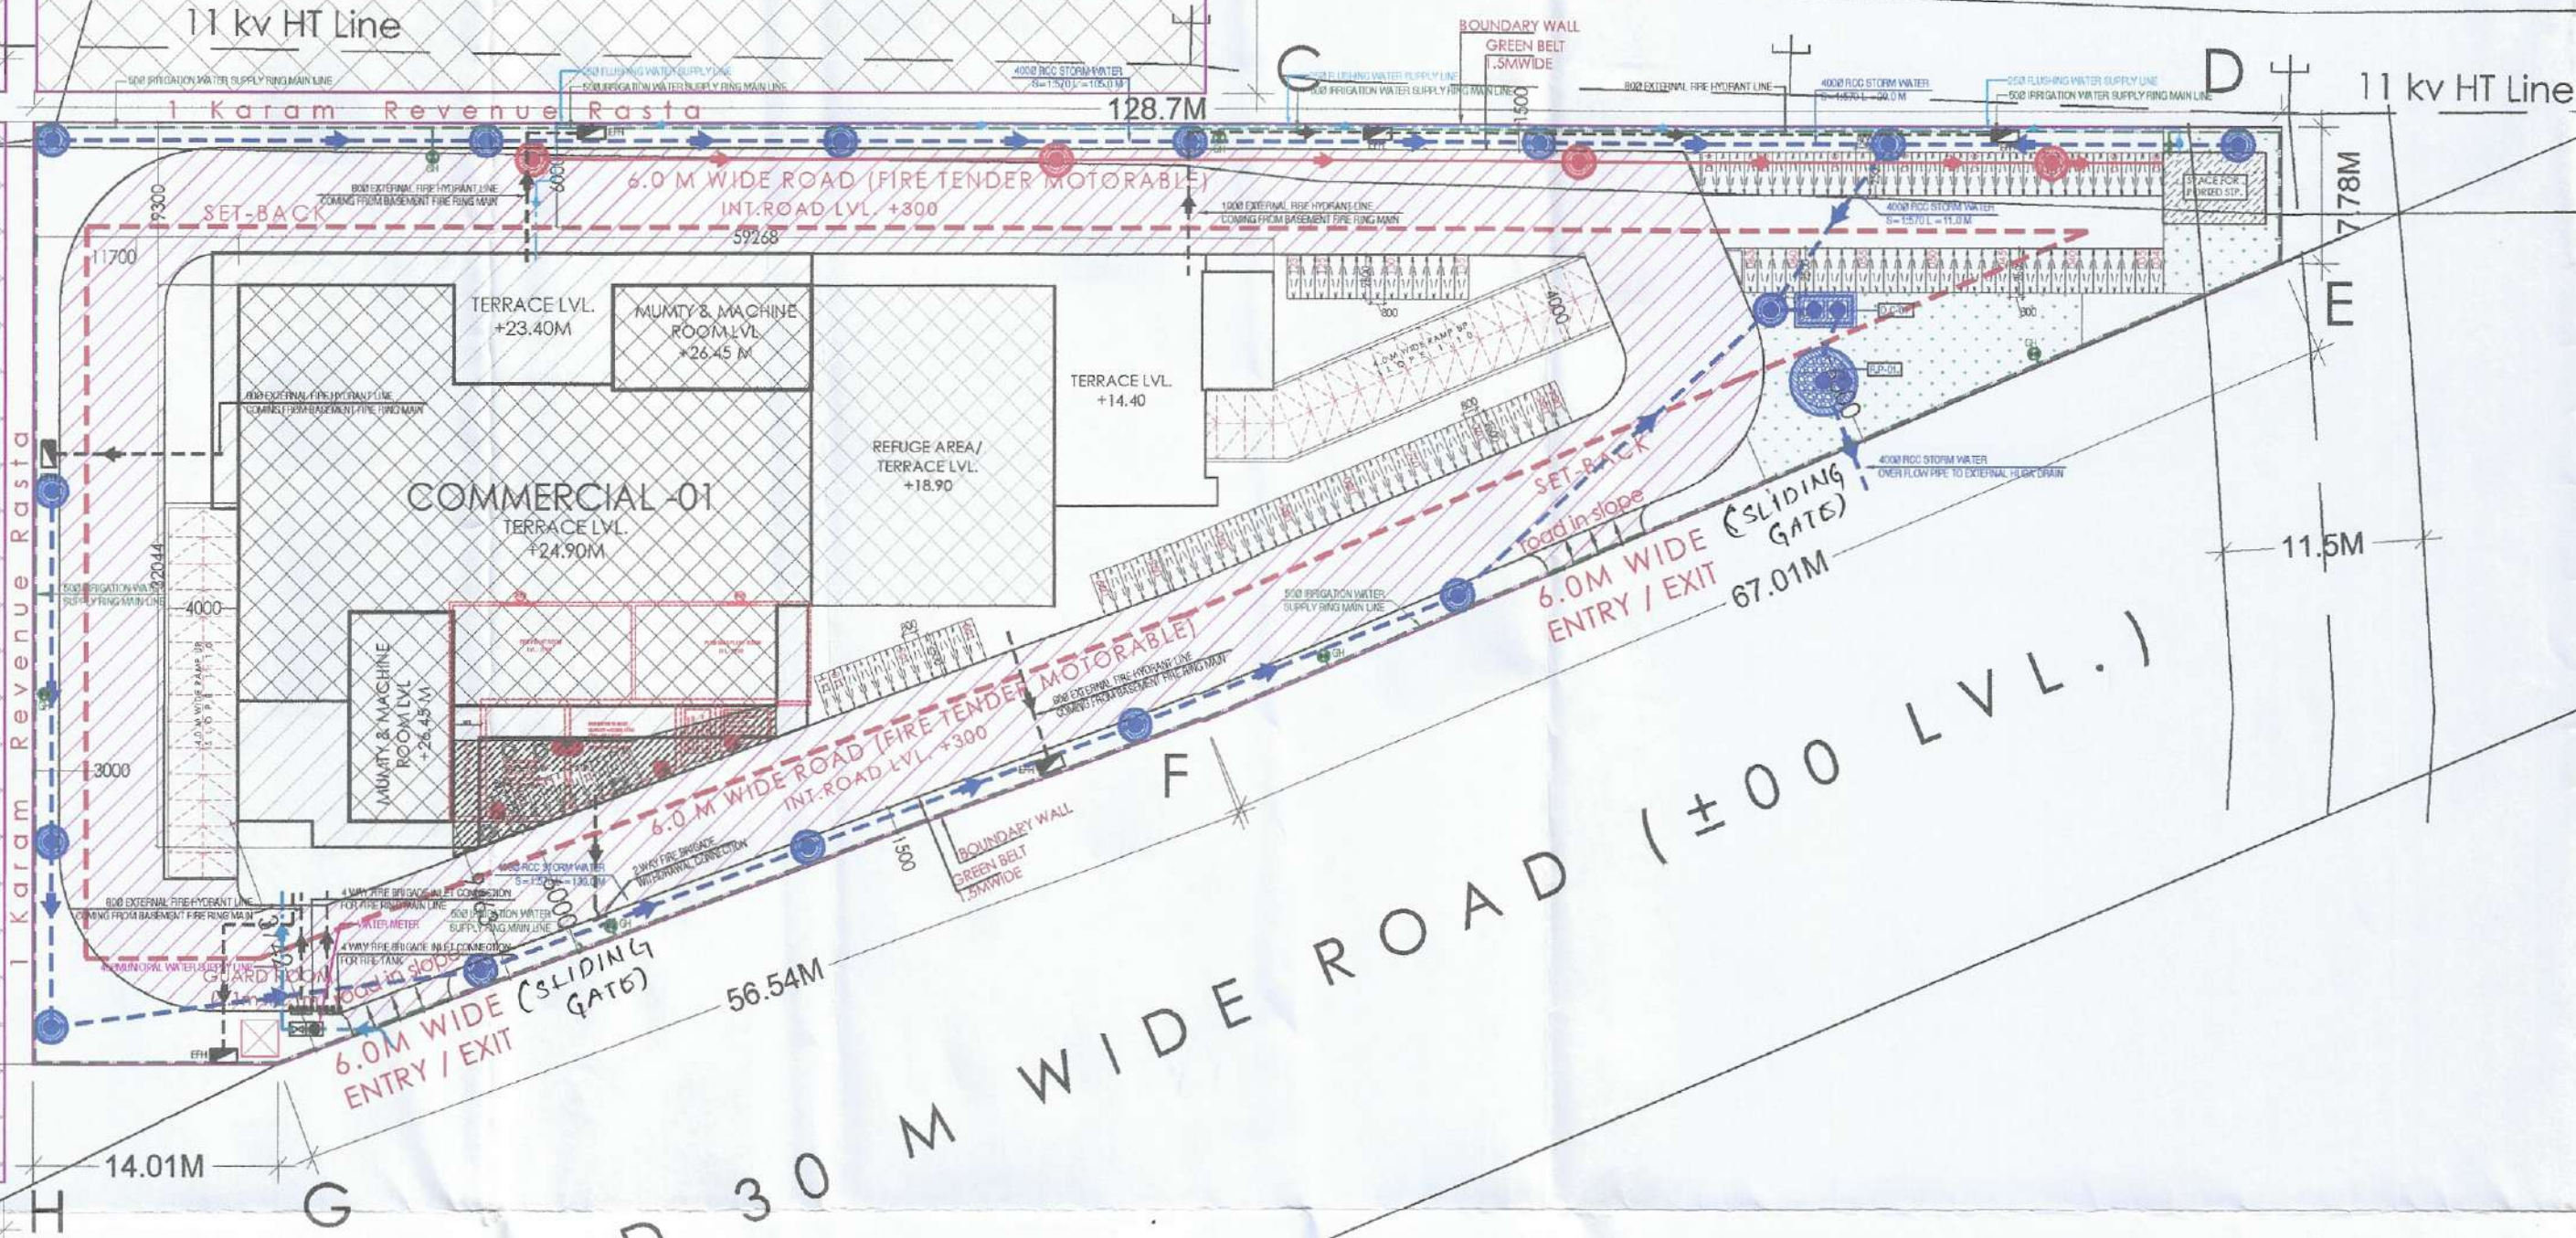

PLUMBING LEGEND :	
	SEWER MANHOLE WITH 5000 S.F.R.C. MANHOLE COVER
	STORM WATER MANHOLE WITH 5000 S.F.R.C. PERFORATED MANHOLE COVER
	CATCH BASIN (800 x 400) MM WITH PERFORATED MANHOLE COVER
	CATCH BASIN (800 x 600) MM WITH PERFORATED MANHOLE COVER
	STORM WATER MANHOLE (600 x 800) MM WITH PERFORATED MANHOLE COVER
	SEWER MANHOLE (600 x 800) MM
	GULLY TRAP (300 x 300) MM
	EXTERNAL DW SEWER LINE (22A AS / DESIGN CHART)
	EXTERNAL RCD STORM WATER LINE (21A AS / DESIGN CHART)
	1500 DI MUNICIPAL WATER SUPPLY LINE
	DOMESTIC WATER SUPPLY LINE
	FLUSHING WATER SUPPLY LINE
	GARDEN IRRIGATION WATER SUPPLY LINE
	M.S PIPE WET RISER LINE
	M.S PIPE SPRINKLER LINE
	EXTERNAL FIRE HYDRANT
	GARDEN HYDRANT WITH CHAMBER (800x300) MM
	RECHARGE PIT 3M DIA
	DESILTING CHAMBER (1500 x 3000) MM
	WATER METER WITH CHAMBER
	BUTTERFLY VALVE WITH CHAMBER
	NON RETURN VALVE (NRV) WITH CHAMBER

DRAWING NO.	AF-PL-01
DRAWING	SITE LAYOUT PLAN PUBLIC HEALTH
BUILDING	

SITE LAYOUT PLAN PUBLIC HEALTH

AF-PL-01