

PLOT AREA = (10.02847 ACRES)
ALL DIMENSIONS ARE IN MM

AUTHORITY SIGNATURE
[Signature]
[Stamp: S.P. MO, S.P. HO, S.P. IN, S.P. J, S.P. A, S.P. B, S.P. C, S.P. D, S.P. E, S.P. F, S.P. G, S.P. H, S.P. I, S.P. J, S.P. K, S.P. L, S.P. M, S.P. N, S.P. O, S.P. P, S.P. Q, S.P. R, S.P. S, S.P. T, S.P. U, S.P. V, S.P. W, S.P. X, S.P. Y, S.P. Z, S.P. AA, S.P. AB, S.P. AC, S.P. AD, S.P. AE, S.P. AF, S.P. AG, S.P. AH, S.P. AI, S.P. AJ, S.P. AK, S.P. AL, S.P. AM, S.P. AN, S.P. AO, S.P. AP, S.P. AQ, S.P. AR, S.P. AS, S.P. AT, S.P. AU, S.P. AV, S.P. AW, S.P. AX, S.P. AY, S.P. AZ, S.P. BA, S.P. BB, S.P. BC, S.P. BD, S.P. BE, S.P. BF, S.P. BG, S.P. BH, S.P. BI, S.P. BJ, S.P. BK, S.P. BL, S.P. BM, S.P. BN, S.P. BO, S.P. BP, S.P. BQ, S.P. BR, S.P. BS, S.P. BT, S.P. BU, S.P. BV, S.P. BW, S.P. BX, S.P. BY, S.P. BZ, S.P. CA, S.P. CB, S.P. CC, S.P. CD, S.P. CE, S.P. CF, S.P. CG, S.P. CH, S.P. CI, S.P. CJ, S.P. CK, S.P. CL, S.P. CM, S.P. CN, S.P. CO, S.P. CP, S.P. CQ, S.P. CR, S.P. CS, S.P. CT, S.P. CU, S.P. CV, S.P. CW, S.P. CX, S.P. CY, S.P. CZ, S.P. DA, S.P. DB, S.P. DC, S.P. DD, S.P. DE, S.P. DF, S.P. DG, S.P. DH, S.P. DI, S.P. DJ, S.P. DK, S.P. DL, S.P. DM, S.P. DN, S.P. DO, S.P. DP, S.P. DQ, S.P. DR, S.P. DS, S.P. DT, S.P. DU, S.P. DV, S.P. DW, S.P. DX, S.P. DY, S.P. DZ, S.P. EA, S.P. EB, S.P. EC, S.P. ED, S.P. EE, S.P. EF, S.P. EG, S.P. EH, S.P. EI, S.P. EJ, S.P. EK, S.P. EL, S.P. EM, S.P. EN, S.P. EO, S.P. EP, S.P. EQ, S.P. ER, S.P. ES, S.P. ET, S.P. EU, S.P. EV, S.P. EW, S.P. EX, S.P. EY, S.P. EZ, S.P. FA, S.P. FB, S.P. FC, S.P. FD, S.P. FE, S.P. FF, S.P. FG, S.P. FH, S.P. FI, S.P. FJ, S.P. FK, S.P. FL, S.P. FM, S.P. FN, S.P. FO, S.P. FP, S.P. FQ, S.P. FR, S.P. FS, S.P. FT, S.P. FU, S.P. FV, S.P. FW, S.P. FX, S.P. FY, S.P. FZ, S.P. GA, S.P. GB, S.P. GC, S.P. GD, S.P. GE, S.P. GF, S.P. GH, S.P. GI, S.P. GJ, S.P. GK, S.P. GL, S.P. GM, S.P. GN, S.P. GO, S.P. GP, S.P. GQ, S.P. GR, S.P. GS, S.P. GT, S.P. GU, S.P. GV, S.P. GW, S.P. GX, S.P. GY, S.P. GZ, S.P. HA, S.P. HB, S.P. HC, S.P. HD, S.P. HE, S.P. HF, S.P. HG, S.P. HI, S.P. HJ, S.P. HK, S.P. HL, S.P. HM, S.P. HN, S.P. HO, S.P. HP, S.P. HQ, S.P. HR, S.P. HS, S.P. HT, S.P. HU, S.P. HV, S.P. HW, S.P. HX, S.P. HY, S.P. HZ, S.P. IA, S.P. IB, S.P. IC, S.P. ID, S.P. IE, S.P. IF, S.P. IG, S.P. IH, S.P. II, S.P. IJ, S.P. IK, S.P. IL, S.P. IM, S.P. IN, S.P. IO, S.P. IP, S.P. IQ, S.P. IR, S.P. IS, S.P. IT, S.P. IU, S.P. IV, S.P. IW, S.P. IX, S.P. IY, S.P. IZ, S.P. JA, S.P. JB, S.P. JC, S.P. JD, S.P. JE, S.P. JF, S.P. JG, S.P. JH, S.P. JI, S.P. JJ, S.P. JK, S.P. JL, S.P. JM, S.P. JN, S.P. JO, S.P. JP, S.P. JQ, S.P. JR, S.P. JS, S.P. JT, S.P. JU, S.P. JV, S.P. JW, S.P. JX, S.P. JY, S.P. JZ, S.P. KA, S.P. KB, S.P. KC, S.P. KD, S.P. KE, S.P. KF, S.P. KG, S.P. KH, S.P. KI, S.P. KJ, S.P. KK, S.P. KL, S.P. KM, S.P. KN, S.P. KO, S.P. KP, S.P. KQ, S.P. KR, S.P. KS, S.P. KT, S.P. KU, S.P. KV, S.P. KW, S.P. KX, S.P. KY, S.P. KZ, S.P. LA, S.P. LB, S.P. LC, S.P. LD, S.P. LE, S.P. LF, S.P. LG, S.P. LH, S.P. LI, S.P. LJ, S.P. LK, S.P. LL, S.P. LM, S.P. LN, S.P. LO, S.P. LP, S.P. LQ, S.P. LR, S.P. LS, S.P. LT, S.P. LU, S.P. LV, S.P. LW, S.P. LX, S.P. LY, S.P. LZ, S.P. MA, S.P. MB, S.P. MC, S.P. MD, S.P. ME, S.P. MF, S.P. MG, S.P. MH, S.P. MI, S.P. MJ, S.P. MK, S.P. ML, S.P. MN, S.P. MO, S.P. MP, S.P. MQ, S.P. MR, S.P. MS, S.P. MT, S.P. MU, S.P. MV, S.P. MW, S.P. MX, S.P. MY, S.P. MZ, S.P. NA, S.P. NB, S.P. NC, S.P. ND, S.P. NE, S.P. NF, S.P. NG, S.P. NH, S.P. NI, S.P. NJ, S.P. NK, S.P. NL, S.P. NM, S.P. NO, S.P. NP, S.P. NQ, S.P. NR, S.P. NS, S.P. NT, S.P. NU, S.P. NV, S.P. NW, S.P. NX, S.P. NY, S.P. NZ, S.P. OA, S.P. OB, S.P. OC, S.P. OD, S.P. OE, S.P. OF, S.P. OG, S.P. OH, S.P. OI, S.P. OJ, S.P. OK, S.P. OL, S.P. OM, S.P. ON, S.P. OO, S.P. OP, S.P. OQ, S.P. OR, S.P. OS, S.P. OT, S.P. OU, S.P. OV, S.P. OW, S.P. OX, S.P. OY, S.P. OZ, S.P. PA, S.P. PB, S.P. PC, S.P. PD, S.P. PE, S.P. PF, S.P. PG, S.P. PH, S.P. PI, S.P. PJ, S.P. PK, S.P. PL, S.P. PM, S.P. PN, S.P. PO, S.P. PP, S.P. PQ, S.P. PR, S.P. PS, S.P. PT, S.P. PU, S.P. PV, S.P. PW, S.P. PX, S.P. PY, S.P. PZ, S.P. QA, S.P. QB, S.P. QC, S.P. QD, S.P. QE, S.P. QF, S.P. QG, S.P. QH, S.P. QI, S.P. QJ, S.P. QK, S.P. QL, S.P. QM, S.P. QN, S.P. QO, S.P. QP, S.P. QQ, S.P. QR, S.P. QS, S.P. QT, S.P. QU, S.P. QV, S.P. QW, S.P. QX, S.P. QY, S.P. QZ, S.P. RA, S.P. RB, S.P. RC, S.P. RD, S.P. RE, S.P. RF, S.P. RG, S.P. RH, S.P. RI, S.P. RJ, S.P. RK, S.P. RL, S.P. RM, S.P. RN, S.P. RO, S.P. RP, S.P. RQ, S.P. RR, S.P. RS, S.P. RT, S.P. RU, S.P. RV, S.P. RW, S.P. RX, S.P. RY, S.P. RZ, S.P. SA, S.P. SB, S.P. SC, S.P. SD, S.P. SE, S.P. SF, S.P. SG, S.P. SH, S.P. SI, S.P. SJ, S.P. SK, S.P. SL, S.P. SM, S.P. SN, S.P. SO, S.P. SP, S.P. SQ, S.P. SR, S.P. SS, S.P. ST, S.P. SU, S.P. SV, S.P. SW, S.P. SX, S.P. SY, S.P. SZ, S.P. TA, S.P. TB, S.P. TC, S.P. TD, S.P. TE, S.P. TF, S.P. TG, S.P. TH, S.P. TI, S.P. TJ, S.P. TK, S.P. TL, S.P. TM, S.P. TN, S.P. TO, S.P. TP, S.P. TQ, S.P. TR, S.P. TS, S.P. TT, S.P. TU, S.P. TV, S.P. TW, S.P. TX, S.P. TY, S.P. TZ, S.P. UA, S.P. UB, S.P. UC, S.P. UD, S.P. UE, S.P. UF, S.P. UG, S.P. UH, S.P. UI, S.P. UJ, S.P. UK, S.P. UL, S.P. UM, S.P. UN, S.P. UO, S.P. UP, S.P. UQ, S.P. UR, S.P. US, S.P. UT, S.P. UY, S.P. UZ, S.P. VA, S.P. VB, S.P. VC, S.P. VD, S.P. VE, S.P. VF, S.P. VG, S.P. VH, S.P. VI, S.P. VJ, S.P. VK, S.P. VL, S.P. VM, S.P. VN, S.P. VO, S.P. VP, S.P. VQ, S.P. VR, S.P. VS, S.P. VT, S.P. VU, S.P. VV, S.P. VW, S.P. VX, S.P. VY, S.P. VZ, S.P. WA, S.P. WB, S.P. WC, S.P. WD, S.P. WE, S.P. WF, S.P. WG, S.P. WH, S.P. WI, S.P. WJ, S.P. WK, S.P. WL, S.P. WM, S.P. WN, S.P. WO, S.P. WP, S.P. WQ, S.P. WR, S.P. WS, S.P. WT, S.P. WU, S.P. WV, S.P. WW, S.P. WX, S.P. WY, S.P. WZ, S.P. XA, S.P. XB, S.P. XC, S.P. XD, S.P. XE, S.P. XF, S.P. XG, S.P. XH, S.P. XI, S.P. XJ, S.P. XK, S.P. XL, S.P. XM, S.P. XN, S.P. XO, S.P. XP, S.P. XQ, S.P. XR, S.P. XS, S.P. XT, S.P. XU, S.P. XV, S.P. XW, S.P. XX, S.P. XY, S.P. XZ, S.P. YA, S.P. YB, S.P. YC, S.P. YD, S.P. YE, S.P. YF, S.P. YG, S.P. YH, S.P. YI, S.P. YJ, S.P. YK, S.P. YL, S.P. YM, S.P. YN, S.P. YO, S.P. YP, S.P. YQ, S.P. YR, S.P. YS, S.P. YT, S.P. YU, S.P. YV, S.P. YW, S.P. YX, S.P. YY, S.P. YZ, S.P. ZA, S.P. ZB, S.P. ZC, S.P. ZD, S.P. ZE, S.P. ZF, S.P. ZG, S.P. ZH, S.P. ZI, S.P. ZJ, S.P. ZK, S.P. ZL, S.P. ZM, S.P. ZN, S.P. ZO, S.P. ZP, S.P. ZQ, S.P. ZR, S.P. ZS, S.P. ZT, S.P. ZU, S.P. ZV, S.P. ZW, S.P. ZX, S.P. ZY, S.P. ZZ]

NOTES
1. ALL DIMENSIONS ARE IN MILLIMETER UNLESS STATED OTHERWISE.
2. THE CONSTRUCTION OF THE BUILDINGS SHALL BE GOVERNED BY PROVISIONS OF HARYANA BUILDING CODE, 1987 AND HARYANA PLANNING AND CONSTRUCTION ACT, 1987.
3. THE NATIONAL BUILDING CODE OF INDIA, 2016 SHALL BE FOLLOWED.
4. THE GATE AND BOUNDARY WALL BE CONSTRUCTED AS PER THE HARYANA BUILDING CODE.
5. THE CONSTRUCTION OF BASEMENT BE EXECUTED AS PER THE HARYANA BUILDING CODE.
6. INSTALLATION OF SOLAR POWER PLANT AS PER THE HARYANA BUILDING CODE.
7. PROVISION OF BASEMENT SPACES - COVERED, OPEN OR IN THE BASEMENT AS PER THE HARYANA BUILDING CODE.
8. PROVISION OF SEWAGE TREATMENT PLANT AS PER THE HARYANA BUILDING CODE.

KEY PLAN
[Diagram showing the location of the project within the plot boundaries and surrounding areas.]

JOB TITLE

PROPOSED BUILDING PLAN OF AFFORDABLE GROUP HOUSING COLONY OVER AN AREA MEASURING 10.02847 ACRES (LICENCE NO. 73 DATED 01.06.2022) IN SECTOR-68, GURUGRAM MANESAR URBAN COMPLEX BEING DEVELOPED BY SH. MUKUL YADAV & OTHERS IN COLLABORATION WITH PAREENA INFRASTRUCTURE PVT. LTD.

SH. MUKUL YADAV & OTHERS IN COLLABORATION WITH PAREENA INFRASTRUCTURE PVT. LTD.

SH. MUKUL YADAV & OTHERS IN COLLABORATION WITH PAREENA INFRASTRUCTURE PVT. LTD.

PROPOSED AFFORDABLE GROUP HOUSING COLONY AT SECTOR-68, GURUGRAM

PARADISE CONSULTANTS

PLOT NO. 96, BASEMENT, POCKET 1, NEW SUPRASH PLAZA, NEW DELHI - 110025
EMAIL: paradiseconsultants@gmail.com

LINEAR CONCEPTS DESIGNS LLP
407, AIR GD IT, NORTH-EX TOWERS,
NEW SUPRASH PLAZA,
NEW DELHI - 110025
EMAIL: STUDIO@LINEARCONCEPTS.IN
TEL: +91 11 43016035

DESCRIPTION


SUBMISSION DRAWING

SCALE 1 : 100 @ A
SHEET NO.
DATE ISSUED 23-5-2022
DRAWN BY
CHECKED BY


ARCHITECT'S SIGNATURE AND SEAL
OWNER'S SIGNATURE AND SEAL

ALL TOWERS
WATER SUPPLY SCHEMATIC PUBLIC HEALTH
PROJECT NO. DRAWING NO. AF-PL-02


(TOWER - 1) (G+24)

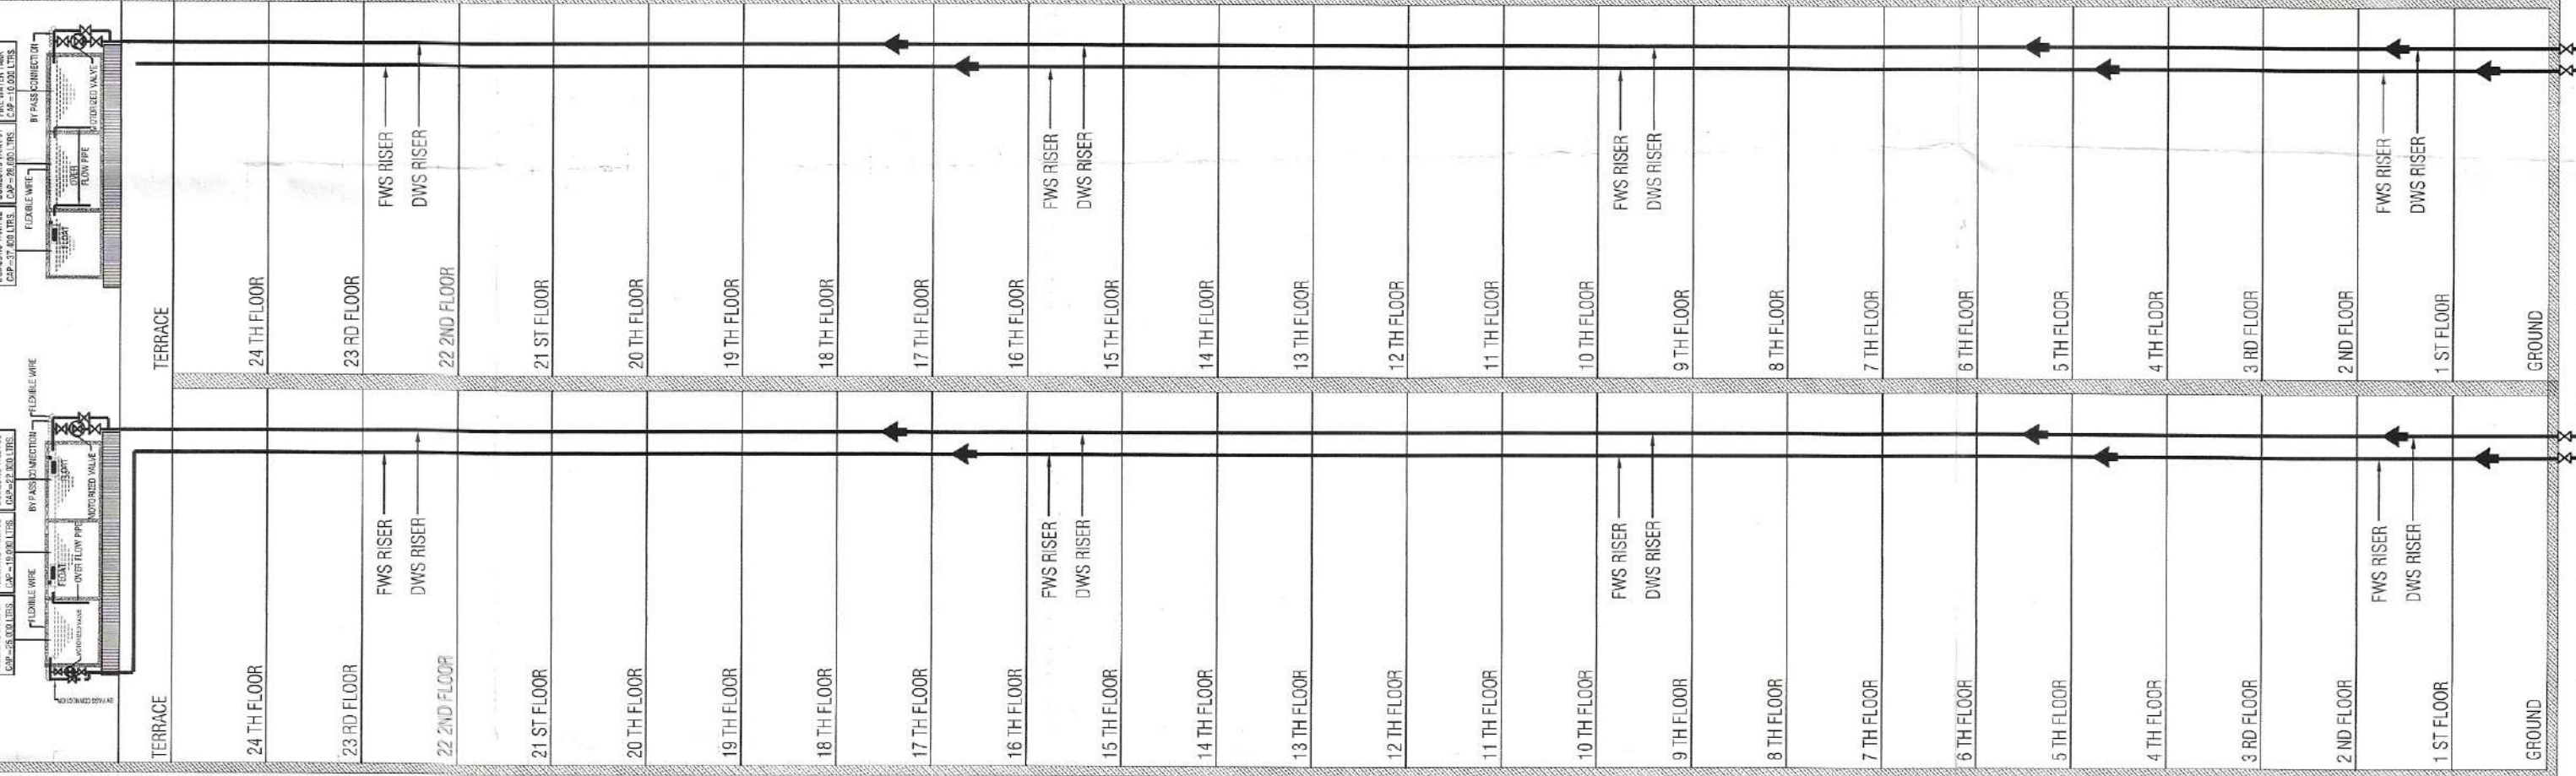


(TOWER - 2) (G+24)

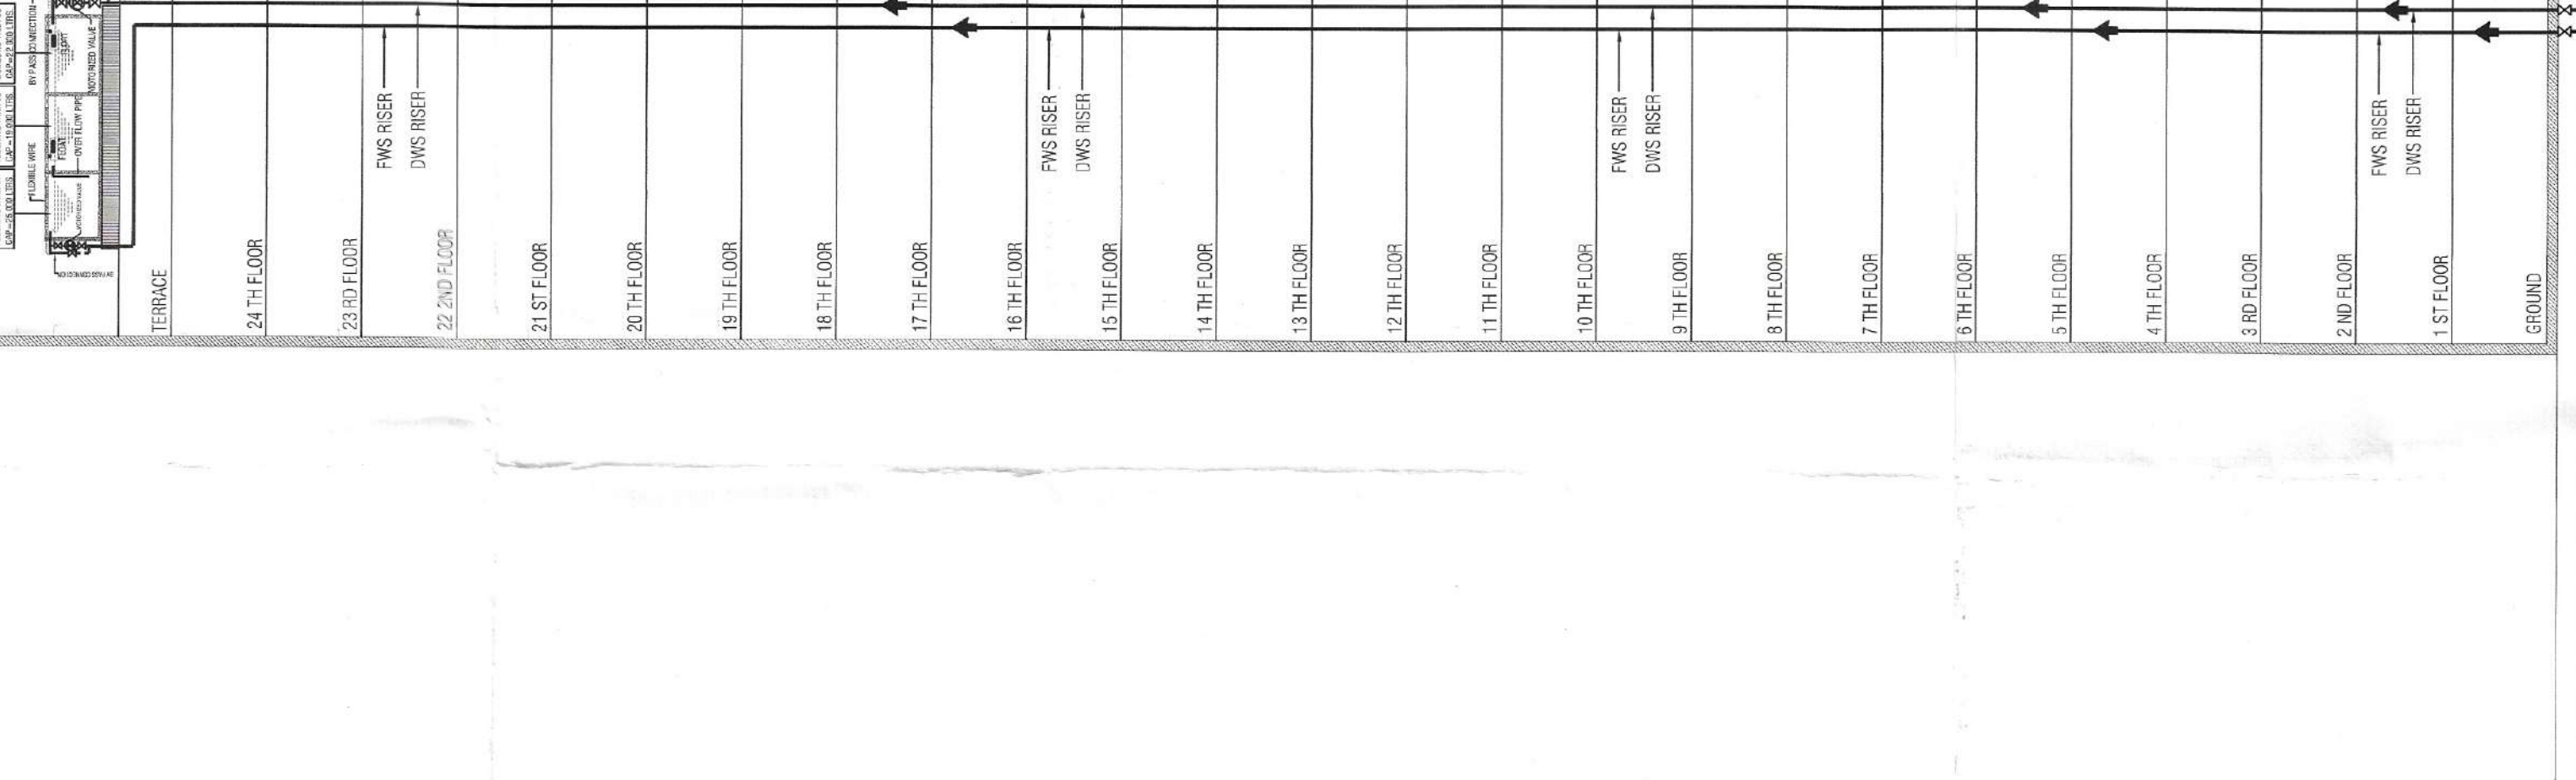


(TOWER - 3) (G+23)

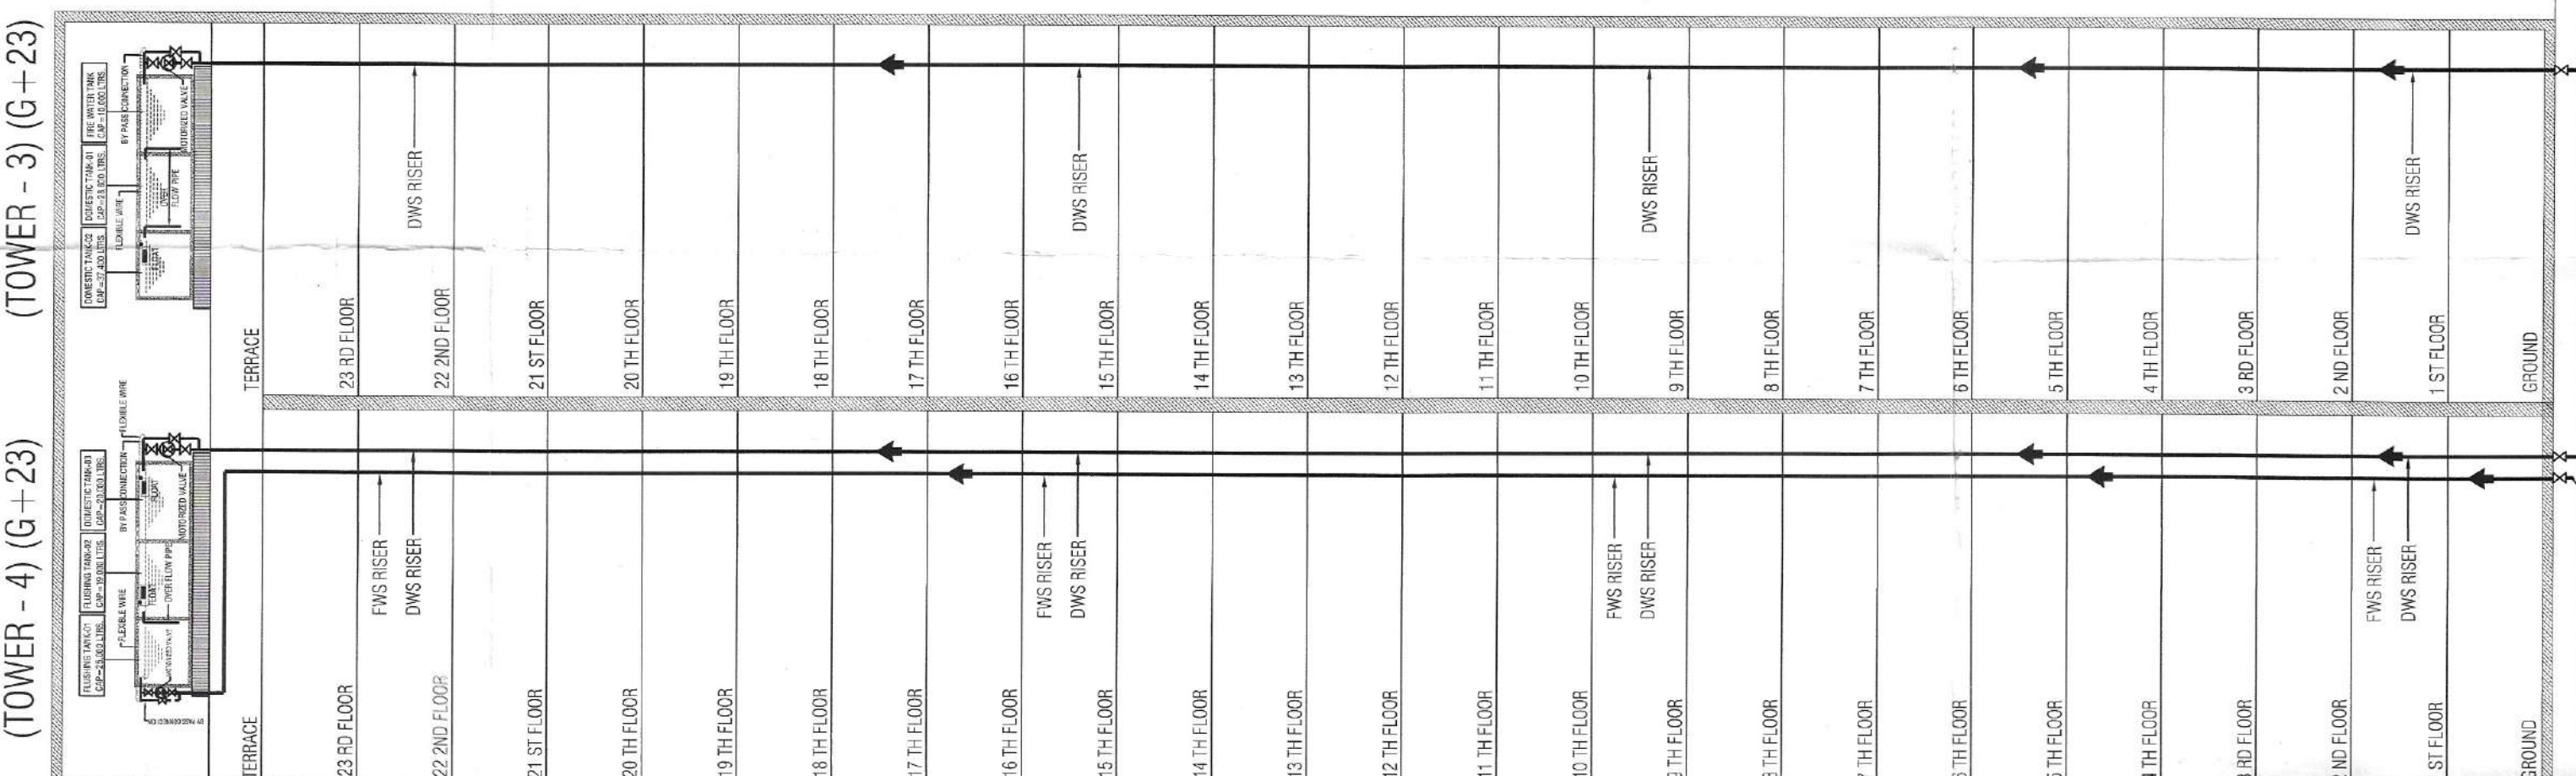


(TOWER - 4) (G+23)

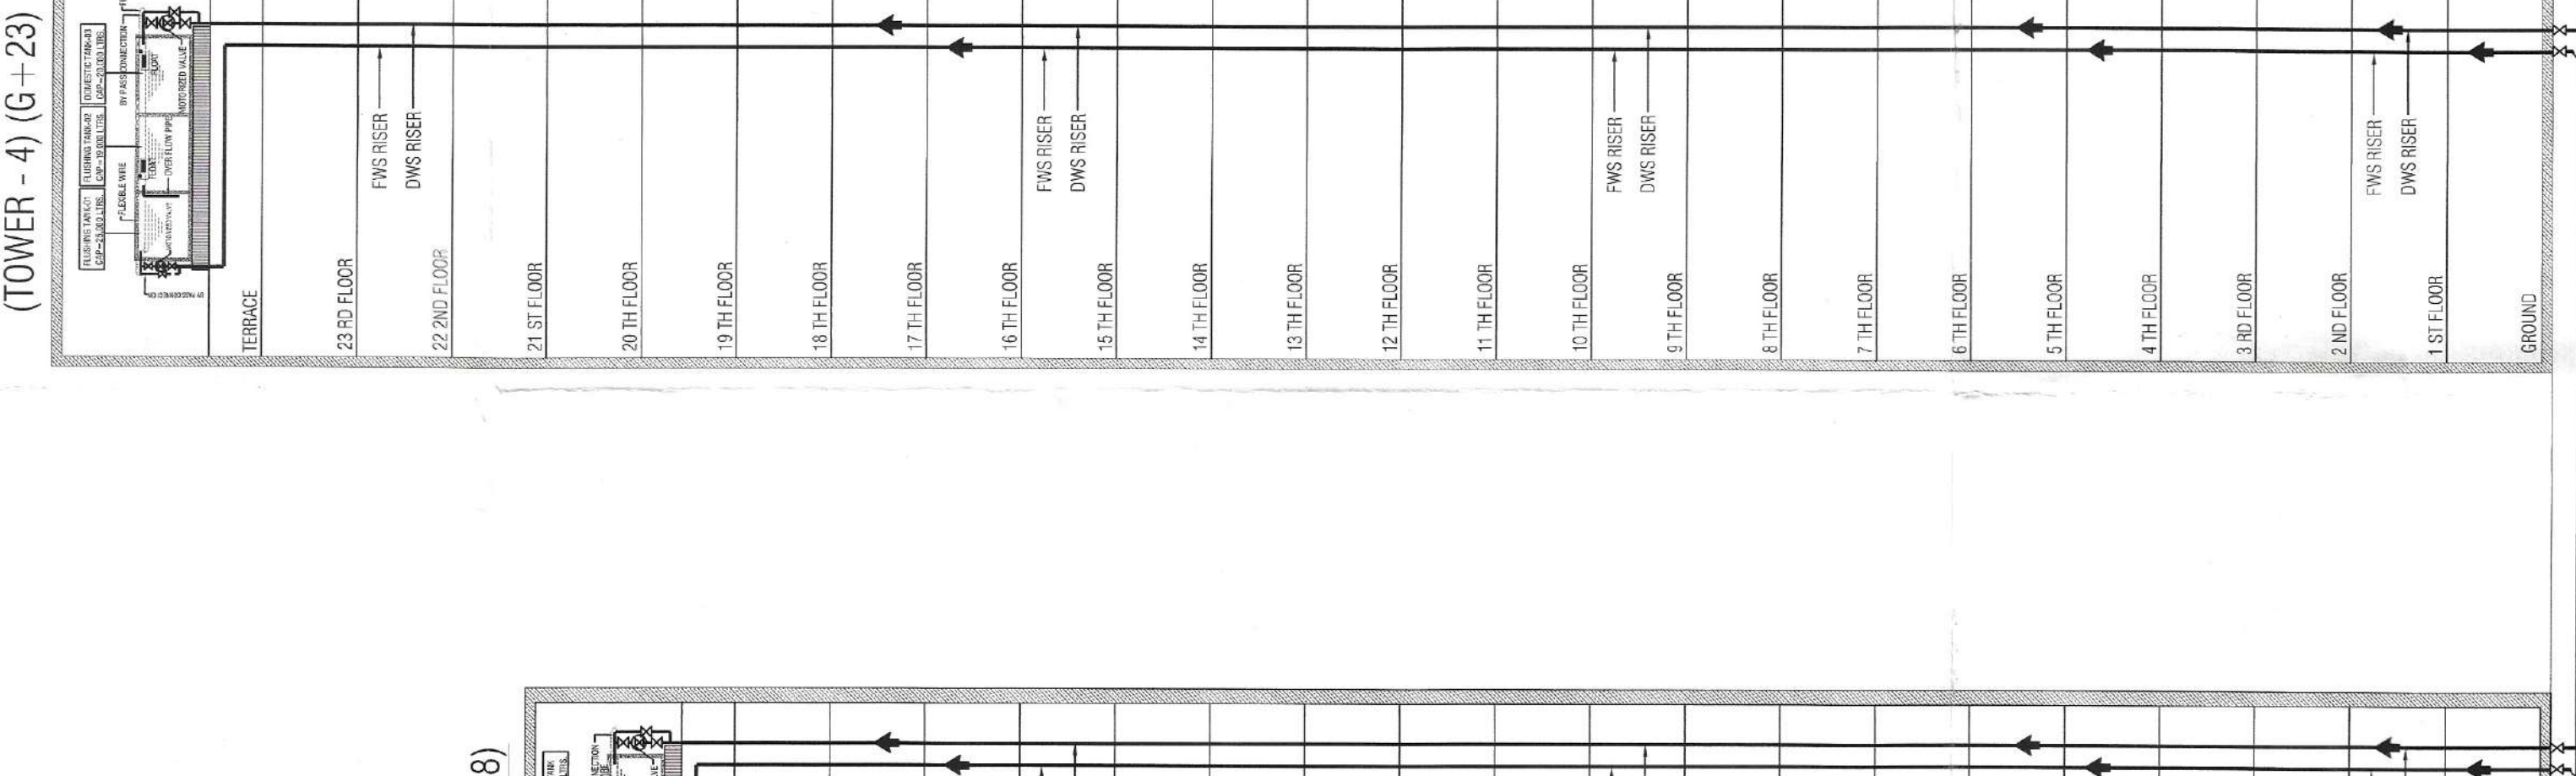


(TOWER - 5) (G+18)

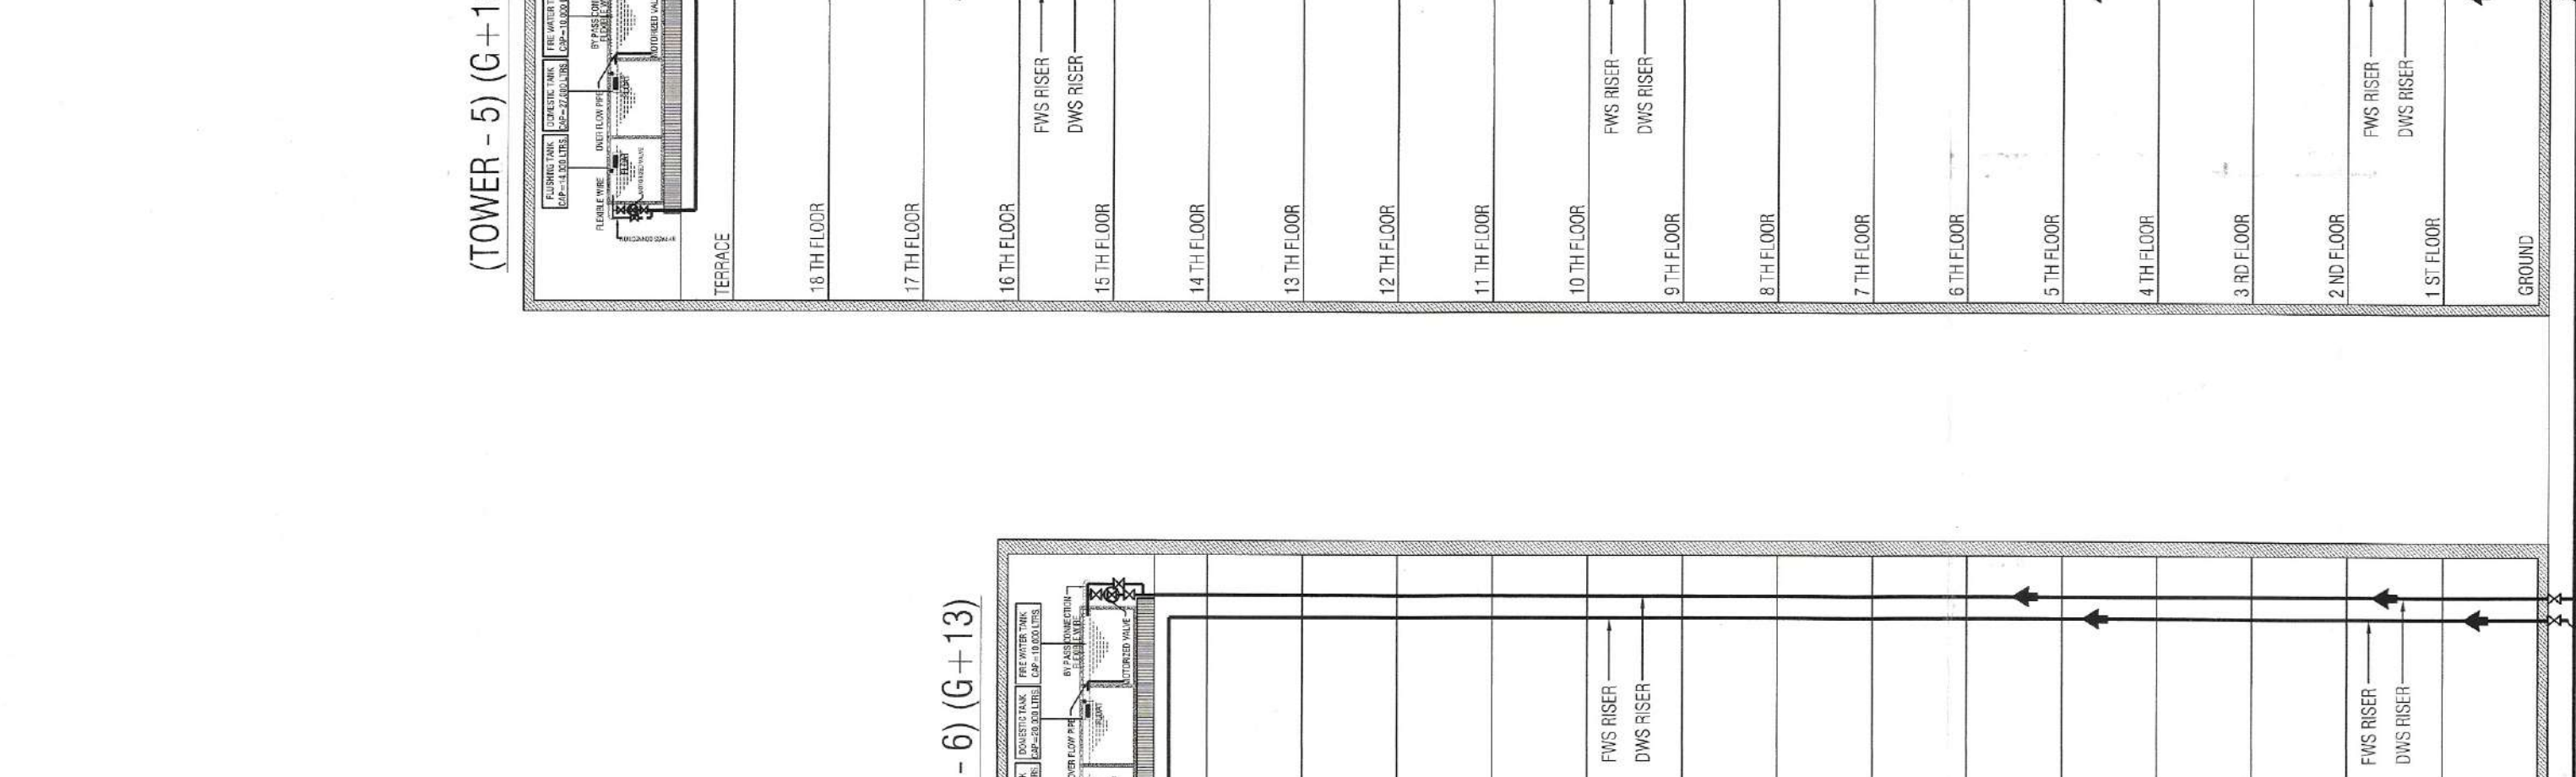



(TOWER - 6) (G+13)

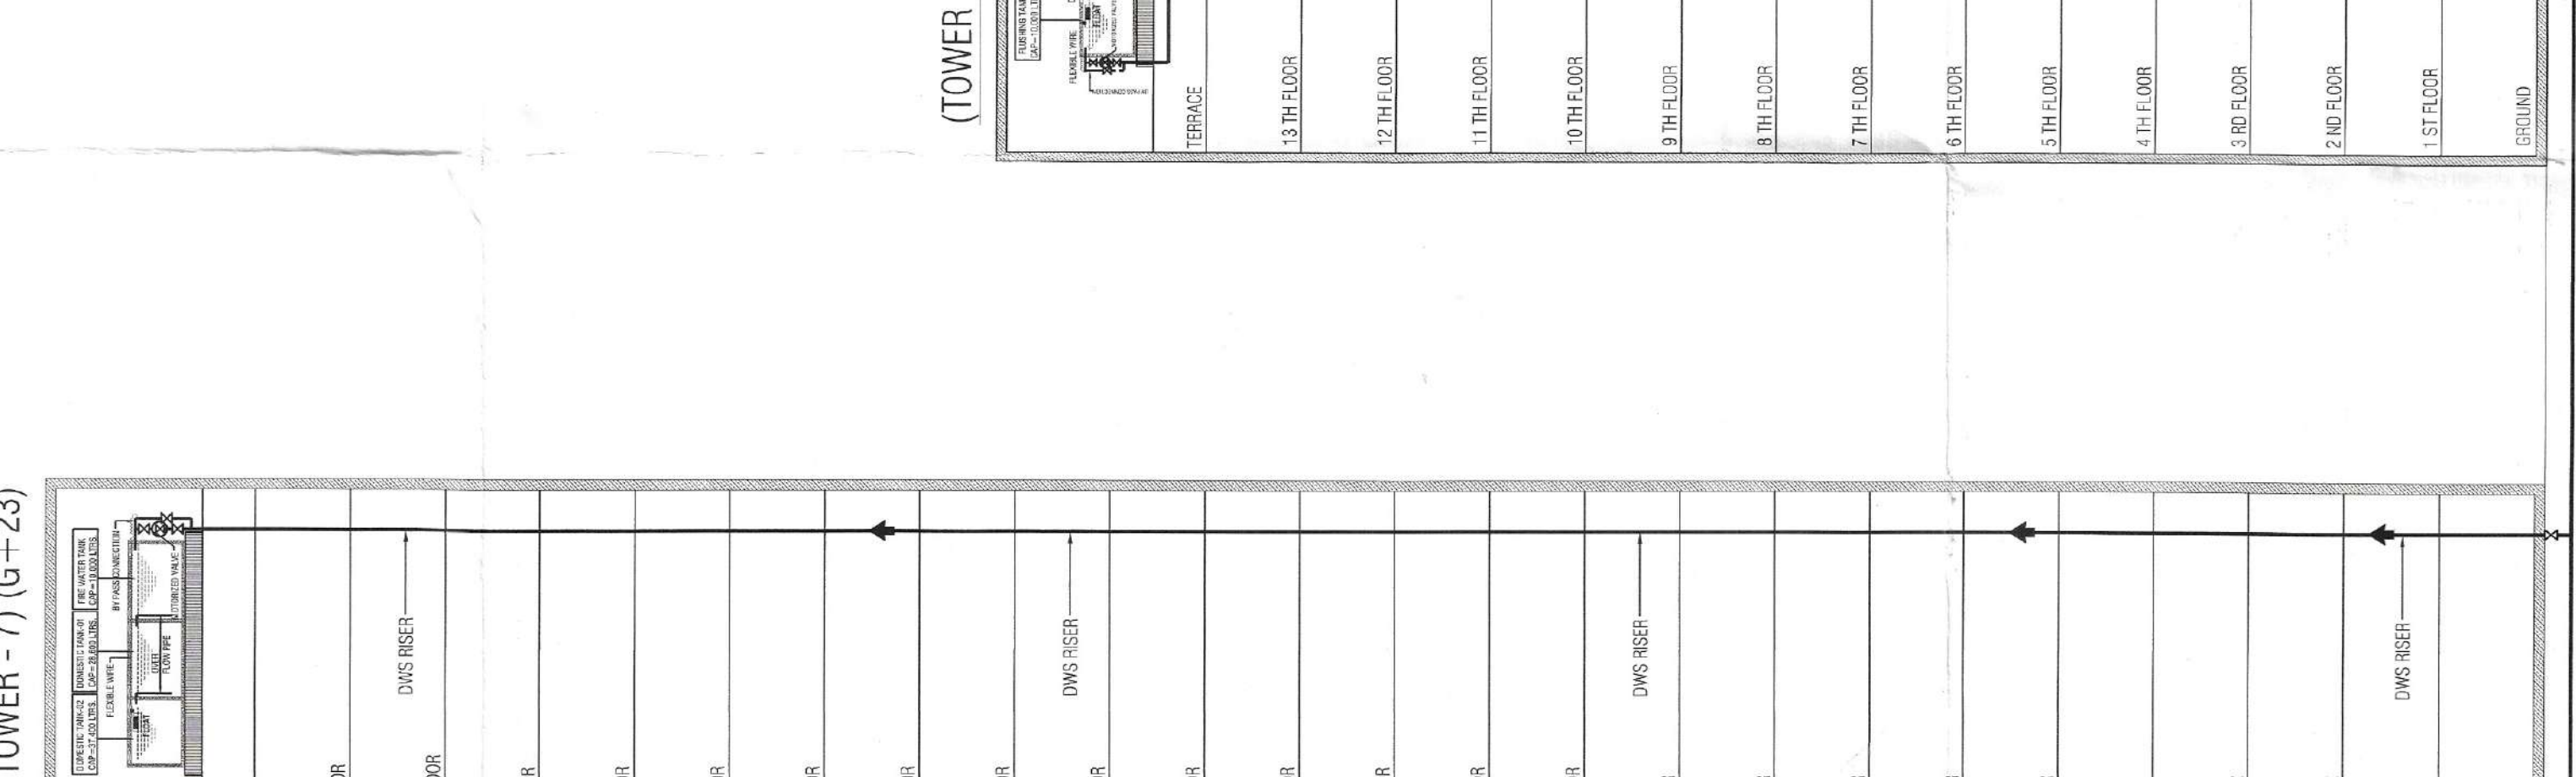

(TOWER - 7) (G+23)

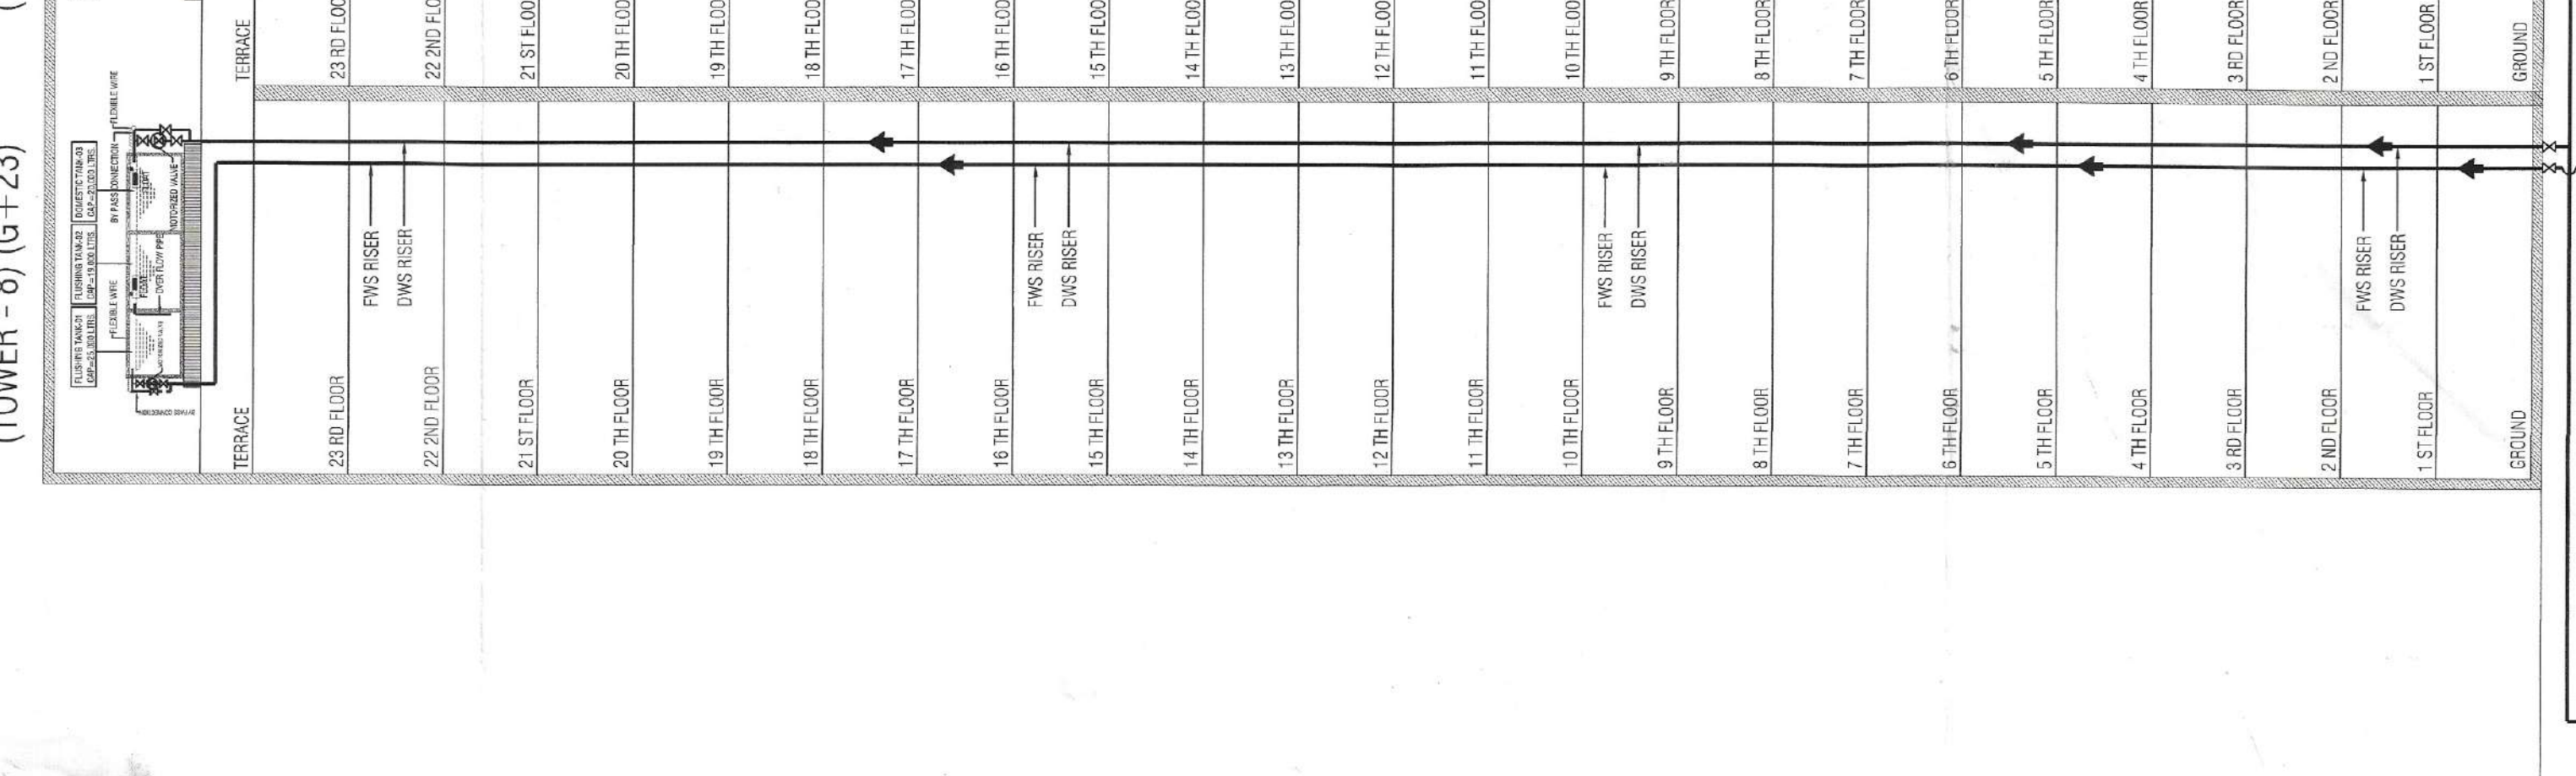

(TOWER - 8) (G+23)

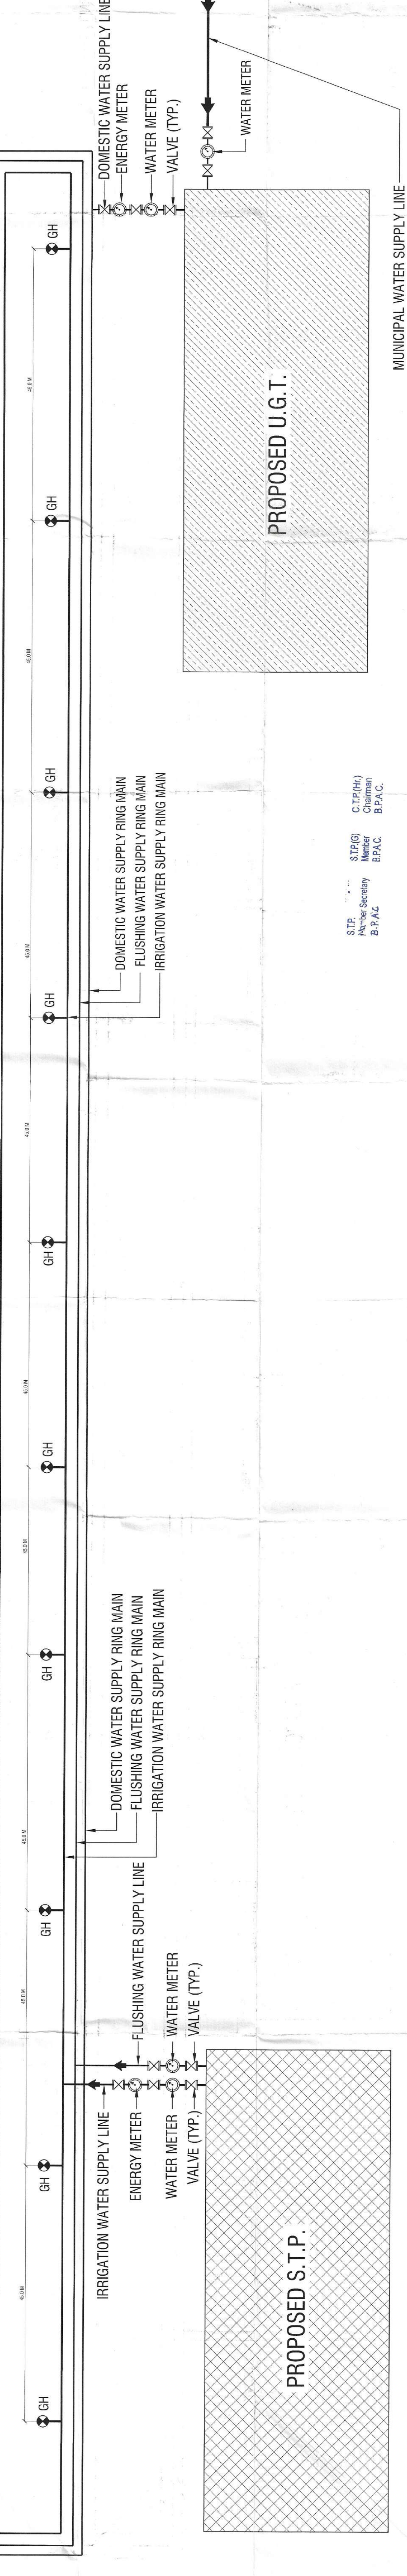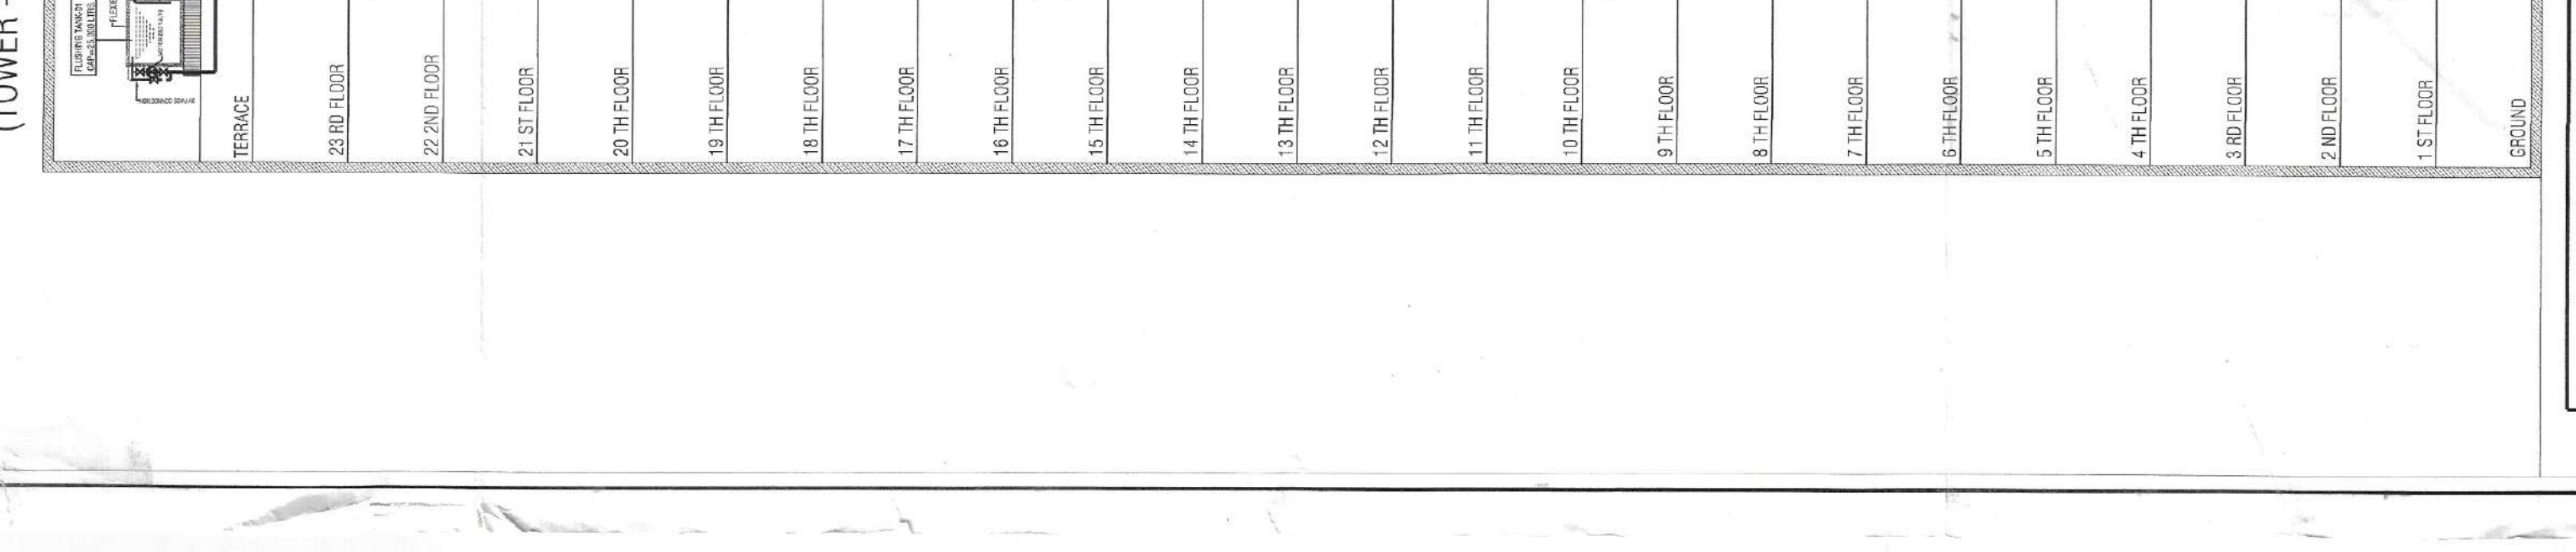

S.T.P. (G) Member B.P.A.C.
C.T.P.H. (G) Chairman B.P.A.C.

S.T.P. (G) Member B.P.A.C.
C.T.P.H. (G) Chairman B.P.A.C.