

BLOCK-I

Sector-63

24 M WIDE ROAD

Sector-63

BLOCK-J

PRIMARY SHCOOL
1.325 Acres

BLOCK-J


PARK-6
1.20 Acres

BLOCK-J


NURSERY
SCHOOL-2
0.38 Acre

PARK-7
1.00 Acres

1

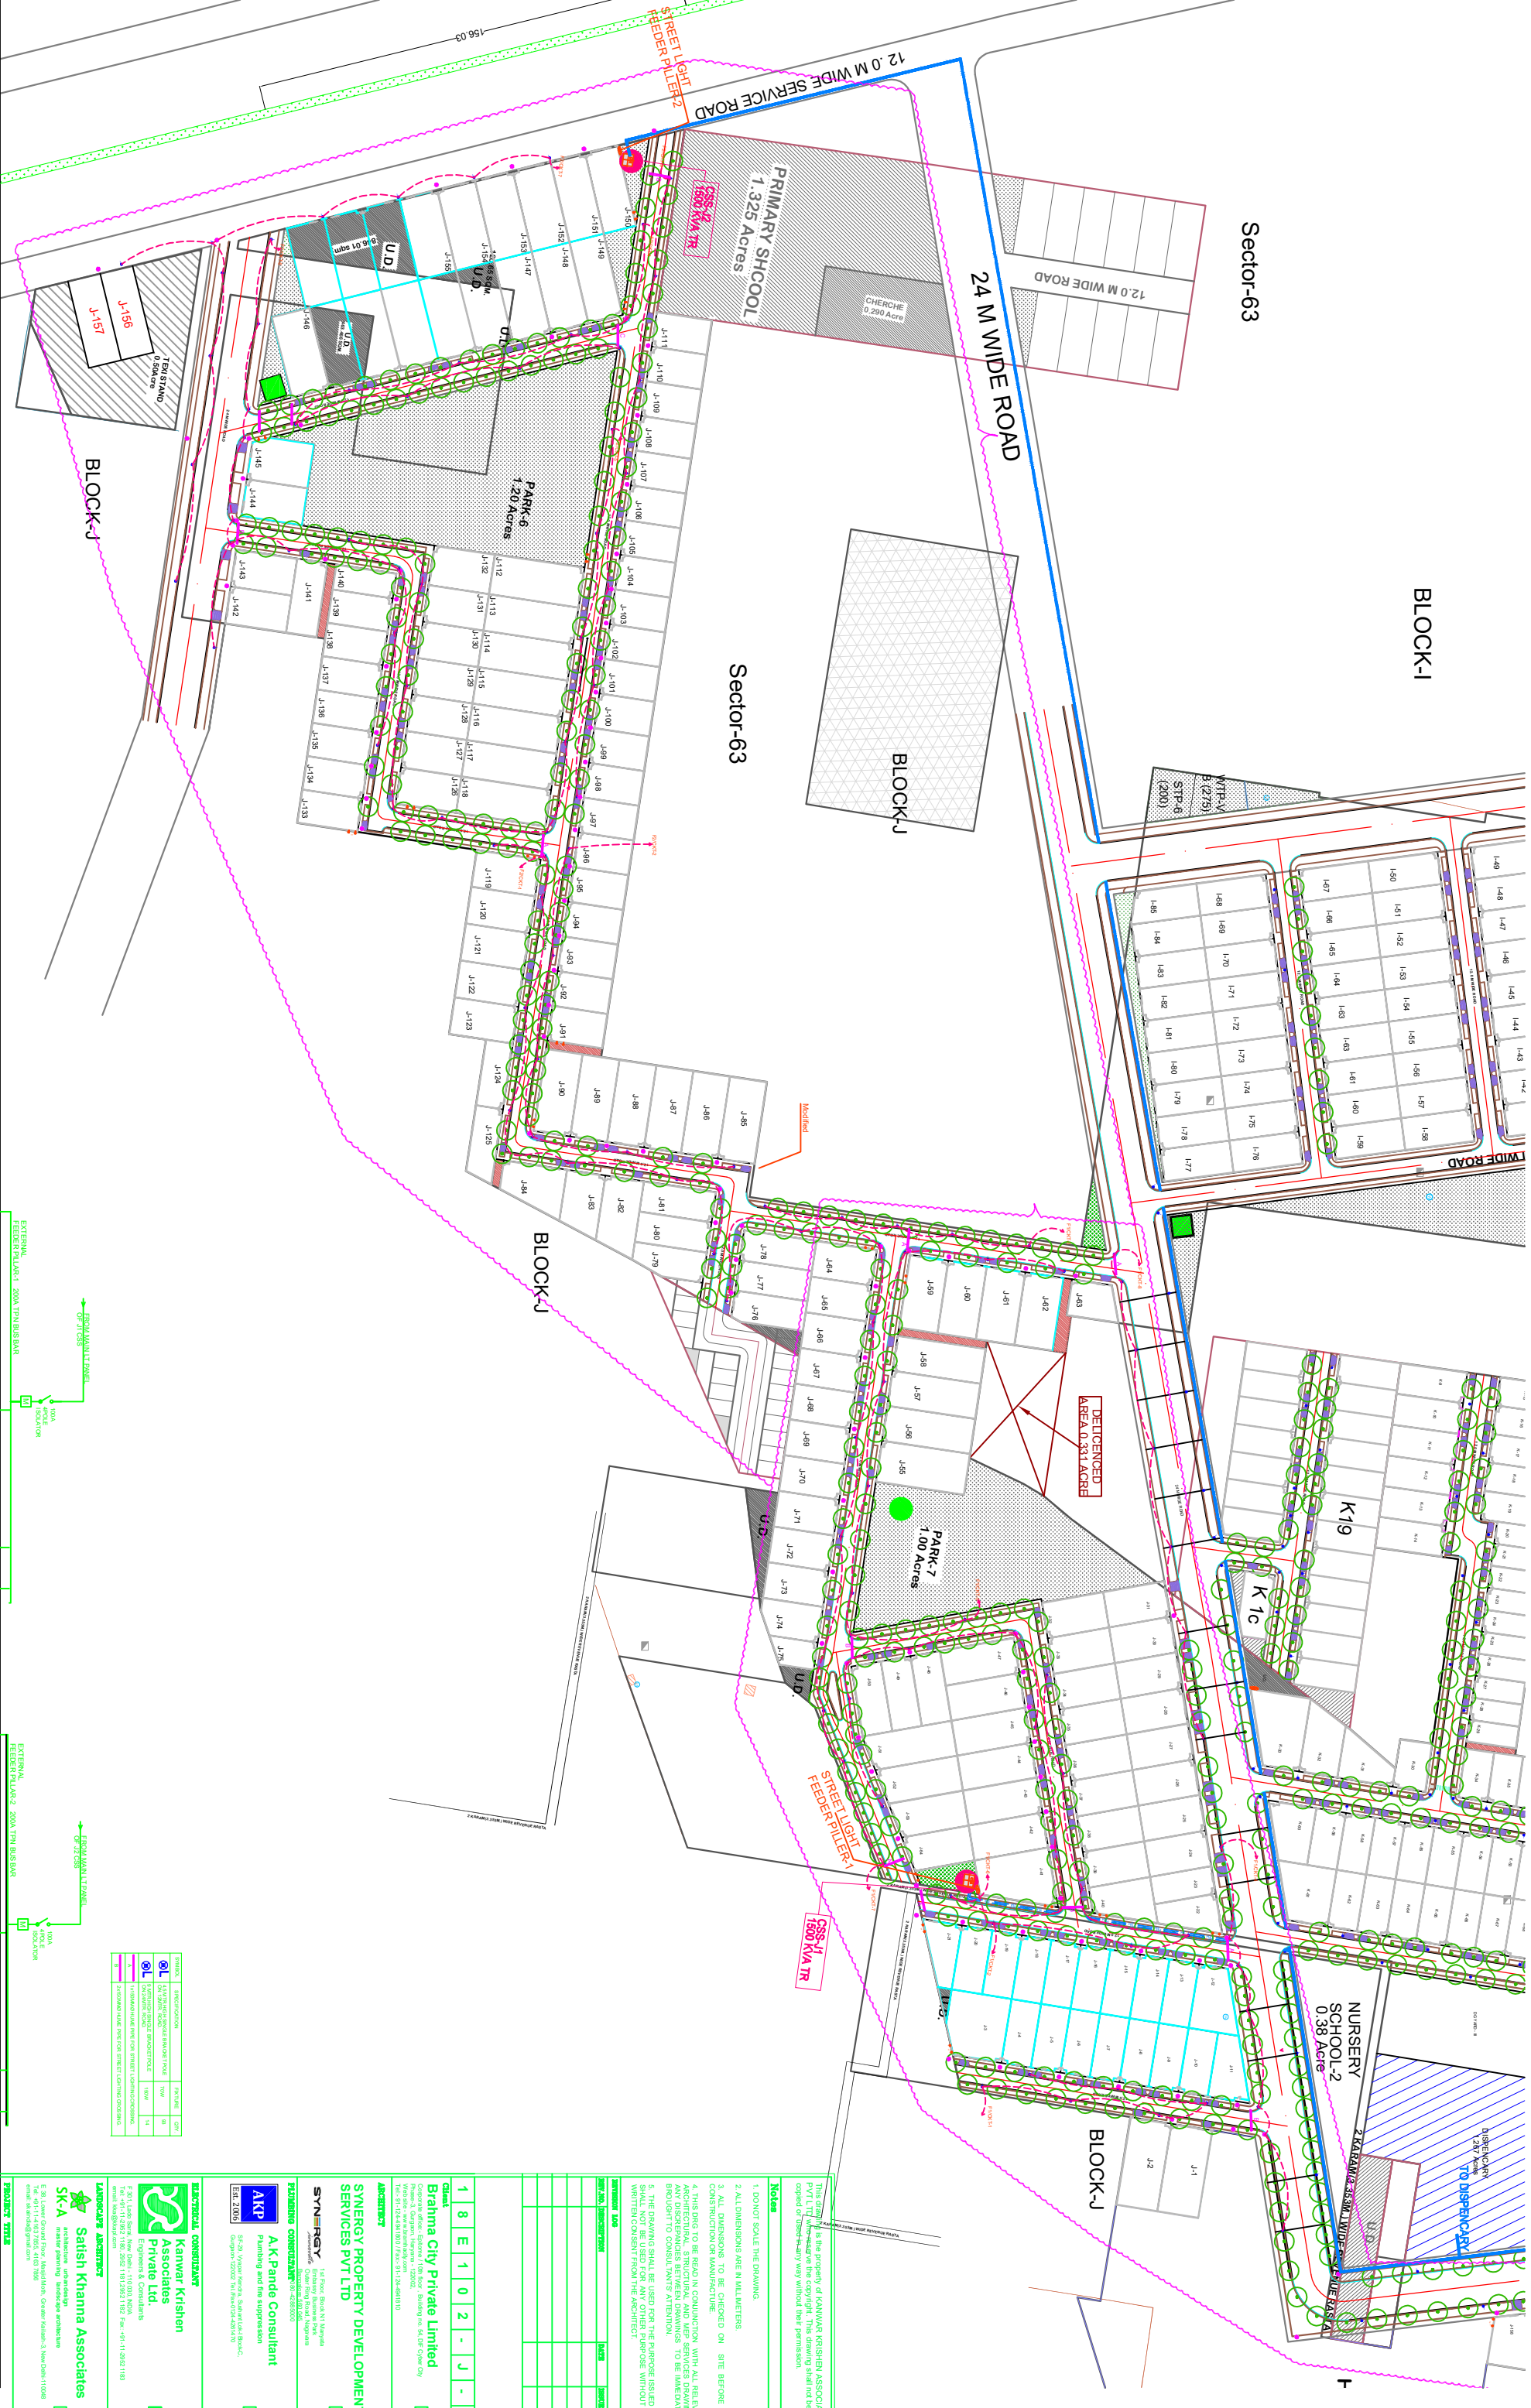

SYMBOL	DESCRIPTION	UNIT	QTY
	100mm dia. concrete pipe	70W	8
	150mm dia. concrete pipe	10W	14
	200mm dia. concrete pipe	10W	14
	300mm dia. concrete pipe	10W	14

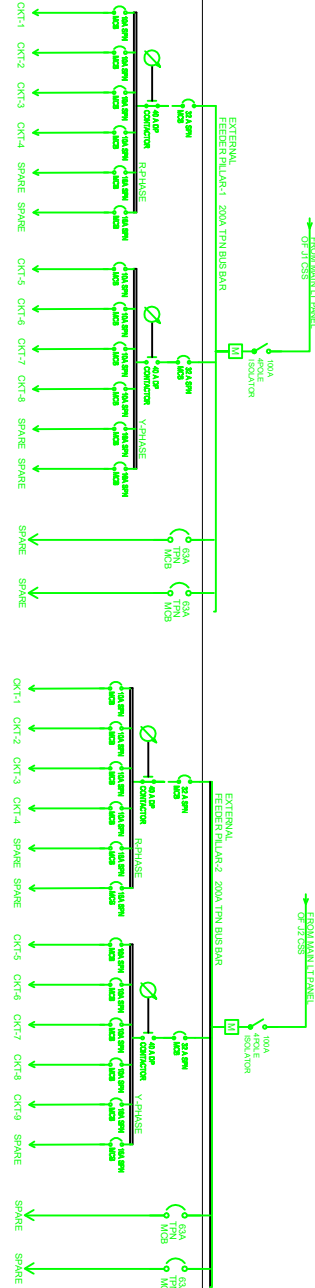

CLIENT

Brahma City Private Limited

PROJECT

SYNERGY PROPERTY DEVELOPMENT SERVICES PVT LTD

DESIGNER

AKP

DATE

01-06-2018

SCALE

1:100

PROJECT TITLE

PROPOSED RESIDENTIAL PLOTTED DEVELOPMENT AT BRAHMA CITY, GURGAON

STREET LIGHTING LAYOUT

BLOCK-J

LANDSCAPE ARCHITECT

SK-A

ARCHITECT

SAISH KHANNA ASSOCIATES

ENGINEER

SAISH KHANNA ASSOCIATES

STRUCTURAL ENGINEER

SAISH KHANNA ASSOCIATES

ELECTRICAL ENGINEER

SAISH KHANNA ASSOCIATES

MECHANICAL ENGINEER

SAISH KHANNA ASSOCIATES

ENVIRONMENTAL ENGINEER

SAISH KHANNA ASSOCIATES

WATER ENGINEER

SAISH KHANNA ASSOCIATES

SEWER ENGINEER

SAISH KHANNA ASSOCIATES

TRAFFIC ENGINEER

SAISH KHANNA ASSOCIATES

SOIL ENGINEER

SAISH KHANNA ASSOCIATES

GEOTECHNICAL ENGINEER

SAISH KHANNA ASSOCIATES

HYDROLOGICAL ENGINEER

SAISH KHANNA ASSOCIATES

CLIMATE ENGINEER

SAISH KHANNA ASSOCIATES

ENVIRONMENTAL IMPACT ASSESSMENT ENGINEER

SAISH KHANNA ASSOCIATES

ENVIRONMENTAL MONITORING ENGINEER

SAISH KHANNA ASSOCIATES

ENVIRONMENTAL RESTORATION ENGINEER

SAISH KHANNA ASSOCIATES

ENVIRONMENTAL RISK ASSESSMENT ENGINEER

SAISH KHANNA ASSOCIATES

ENVIRONMENTAL SUSTAINABILITY ENGINEER

SAISH KHANNA ASSOCIATES

ENVIRONMENTAL TOXICOLOGY ENGINEER

SAISH KHANNA ASSOCIATES

ENVIRONMENTAL ZONING ENGINEER

SAISH KHANNA ASSOCIATES

ENVIRONMENTAL IMPACT ASSESSMENT ENGINEER

SAISH KHANNA ASSOCIATES

ENVIRONMENTAL MONITORING ENGINEER

SAISH KHANNA ASSOCIATES

ENVIRONMENTAL RESTORATION ENGINEER

SAISH KHANNA ASSOCIATES

ENVIRONMENTAL RISK ASSESSMENT ENGINEER

SAISH KHANNA ASSOCIATES

ENVIRONMENTAL SUSTAINABILITY ENGINEER



SAISH KHANNA ASSOCIATES

ENVIRONMENTAL TOXICOLOGY ENGINEER

SAISH KHANNA ASSOCIATES

ENVIRONMENTAL ZONING ENGINEER

SAISH KHANNA ASSOCIATES

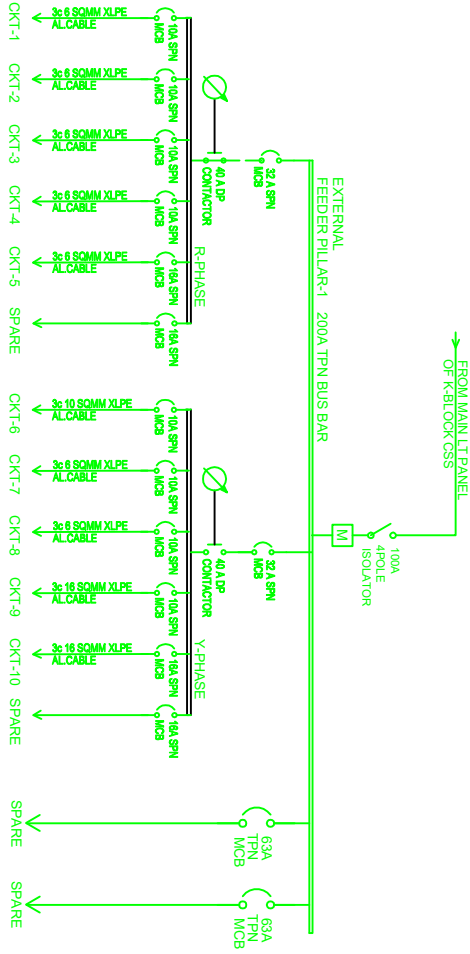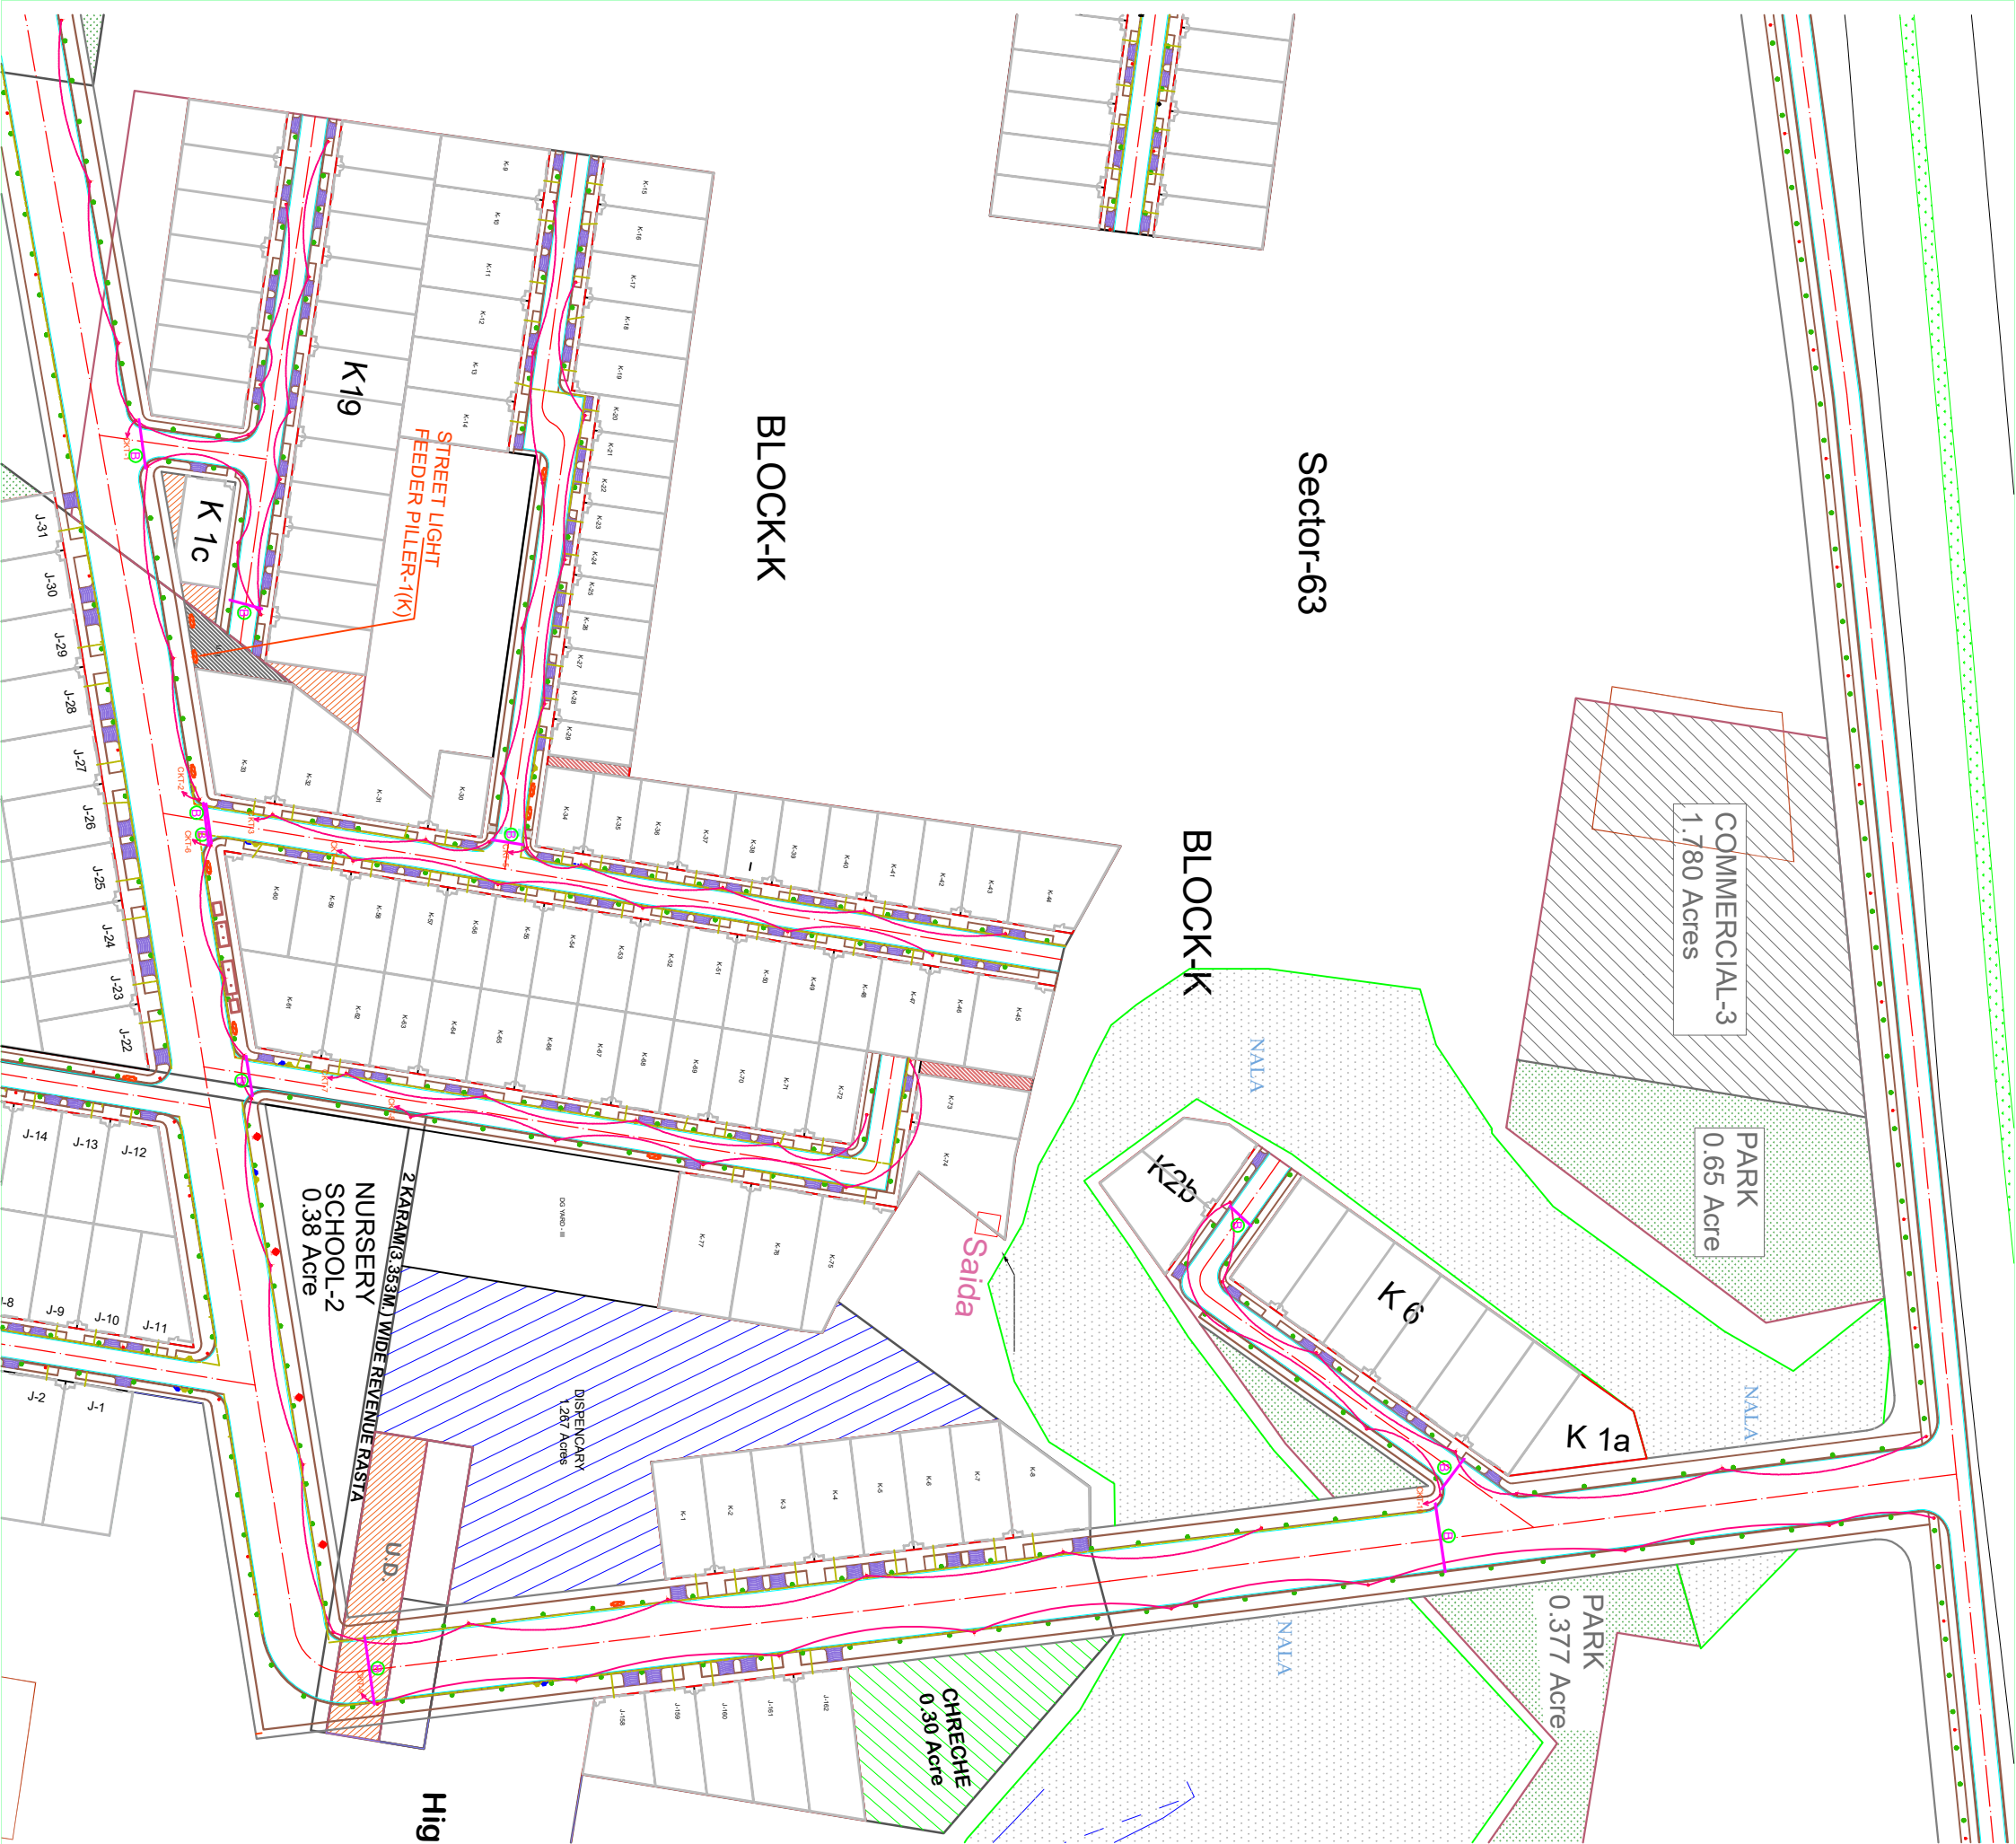

SYMBOL	SPECIFICATION	FIXTURE
	4x 1/2 inch square bracket pole	40W
	3x 1/2 inch square bracket pole	30W
	1x 1/2 inch square bracket pole	10W

This drawing is the property of KANWAR KRISHNJI ASSOCIATES PVT LTD who reserve the copyright. This drawing shall not be copied or used in any way without their permission.

Notes

1. DONOT SCALE THE DRAWING.
2. ALL DIMENSIONS ARE IN MILLIMETERS.
3. ALL DIMENSIONS TO BE CHECKED ON SITE BEFORE ANY CONSTRUCTION OR MANUFACTURE.
4. THIS Dwg TO BE USED IN CONNECTION WITH ALL RELEVANT ARCHITECTURAL, STRUCTURAL AND MEP SERVICES DRAWINGS. ANY DISCREPANCIES BETWEEN DRAWINGS TO BE IMMEDIATELY BROUGHT TO CONSULTANT'S ATTENTION.
5. THE DRAWING SHALL BE USED FOR THE PURPOSE ISSUED AND NOT FOR ANY OTHER PURPOSE WITHOUT THE WRITTEN CONSENT FROM THE ARCHITECT.

DATE	REVISION	BY	CHKD BY
10/10/2023	1	SK-A	SK-A

DATE	REVISION	BY	CHKD BY
10/10/2023	1	SK-A	SK-A

1 8 E 2 1 0 1 K - R0

Brahma City Private Limited
Plot No. 1, Sector 63, Gurgaon, Haryana - 122002. Contact No. 91-11-26481181
Fax: 91-11-26481180 | Email: info@brahmacity.com

SYNERGY
1st Floor, Block 11, Tatyana
Jawahar Road, Gurgaon, Haryana - 122002. Contact No. 91-11-26481181
Fax: 91-11-26481180 | Email: info@synergy.com

A.K.Pandit Consultant
Planning and the supervision
B-20, Vignesh Kona, Sector 10A Block C,
Gurgaon-122002. Contact No. 91-11-26481181
Fax: 91-11-26481180 | Email: info@akp.com

Kanwar Krishen
Associates
Private Ltd.
Engineers & Consultants
1st Floor, Block 11, Tatyana
Jawahar Road, Gurgaon, Haryana - 122002. Contact No. 91-11-26481181
Fax: 91-11-26481180 | Email: info@kanwar.com

Satish Khanna Associates
architectural urban design
master planning landscape architecture
SK-A
E-30, Lower Ground Floor, Wazirpur, Greater Kailash-3, New Delhi-110048
Phone: 91-11-26481181 | Email: info@satishkhanna.com

PROPOSED RESIDENTIAL PLOTTED
DEVELOPMENT AT
BRAHMA CITY, GURGAON

DATE: 10/10/2023
DRAWN BY: SK-A
CHECKED BY: SK-A
DATE: 10/10/2023

GFC

60.0 M WIDE ROAD

CSS-M1

STREET LIGHT
FEEDER PILLAR

Nursing Home
Area 0.260 Acre

NALA

BLOCK-M

COMMERCIAL-1
2.00 Acres

PARK-8
1.00 ACRES


PRIMARY
SCHOOL-2
1.01 Acre

RELIGIOUS
BUILDING-1
Area-0.220
Acre

Community Center

Sector-60

SYMBOL	SPECIFICATION	FIXTURE
	4.5 MTR HIGH SINGLE BRACKET POLE ON 12MTR. ROAD	40W
	9 MTR. HIGH SINGLE BRACKET POLE ON 24MTR. ROAD	75W
	1x150MMØ HUMVE PIPE FOR STREET LIGHTING CROSSING.	
	2x150MMØ HUMVE PIPE FOR STREET LIGHTING CROSSING.	
	3x150MMØ HUMVE PIPE FOR STREET LIGHTING CROSSING.	

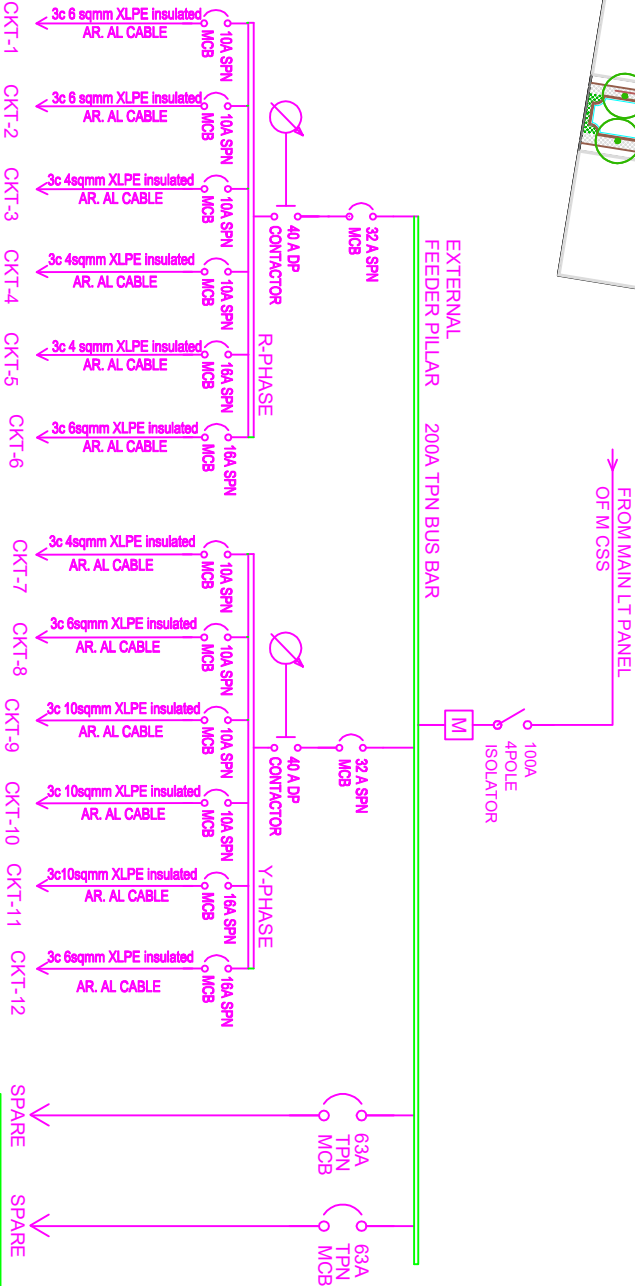

This drawing is the property of KANWAR KRISHNA ASSOCIATES PVT LTD who reserves the copyright. This drawing shall not be copied or used in any way without their permission.

Notes

1. DONOT SCALE THE DRAWING.
2. ALL DIMENSIONS ARE IN MILLIMETERS.
3. ALL DIMENSIONS TO BE CHECKED ON SITE BEFORE ANY CONSTRUCTION OR MANUFACTURE.
4. THIS DRG TO BE READ IN CONJUNCTION WITH ALL RELEVANT DRAWINGS AND SPECIFICATIONS. ANY DISCREPANCIES BETWEEN DRAWINGS TO BE IMMEDIATELY BROUGHT TO CONSULTANTS ATTENTION.
5. THE DRAWING SHALL BE USED FOR THE PURPOSE ISSUED AND SHALL NOT BE USED FOR ANY OTHER PURPOSE WITHOUT THE WRITTEN CONSENT FROM THE ARCHITECT.

REVISION	DATE	REVISION BY	REVISION FOR
1	11-06-2017		
2	11-06-2017		
3	11-06-2017		
4	11-06-2017		
5	11-06-2017		
6	11-06-2017		
7	11-06-2017		
8	11-06-2017		
9	11-06-2017		
10	11-06-2017		

PROJECT TEAM

SK-A **Satish Khanna Associates**
architectural, urban planning, landscape architecture
E-39, Lower Ground Floor, Mayapuri, Okhla, New Delhi-110048
Tel: +91-11-2652-1186, 2652-1183, 2652-1182 Fax: +91-11-2652-1183
email: info@skapvt.com

ENGINEERS & CONSULTANTS
Kanwar Krishen Associates Private Ltd.
E-39, Lower Ground Floor, Mayapuri, Okhla, New Delhi-110048
Tel: +91-11-2652-1186, 2652-1183, 2652-1182 Fax: +91-11-2652-1183
email: info@kanwar.com

PRODUCT TEAM

PROPOSED RESIDENTIAL PLOTTED DEVELOPMENT AT BRAHMA CITY, GURGAON

DRAINAGE STUDY

STREET LIGHTING LAYOUT

BLOCK-M

DATE	11-06-2017	DSB NO.	1007
DRAWN BY	KS		
CHECKED BY	KS		
APPROVED BY	KS		