

1. BUILDING WILL BE DESIGNED (STRUCTURES) AS PER RELEVANT IS CODES FOR EARTH QUAKE RESISTANCE.
2. THE BUILDING IS ARTIFICIALLY LIT AND MECHANICALLY VENTILATED.

LEGEND:-

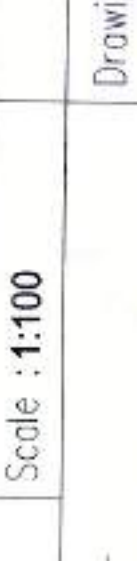
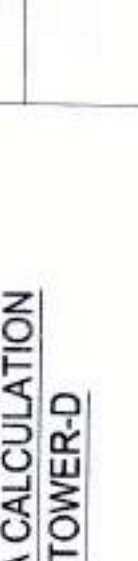
PROJECT :

REVISED BUILDING PLANS OF GROUP HOUSING COLONY AREA MEASURING 25.087 ACRES (LICENCE NO. 123 OF 2012 DATED 20-12-2012 IN SECTOR-63, GURGAON BEING DEVELOPED BY ARJIE BUILDERS & DEVELOPERS PVT. LTD. AND OTHERS IN COLLABORATION WITH DLF HOME DEVELOPERS LTD (EARLIER KNOWN AS DLF NEW GURGAON HOME DEVELOPERS PVT.LTD)

ARCHITECTURE:
ARCOP

ARCOP ASSOCIATES PVT LTD
Plot No. 36B, Sector-32, Institutional Area, Gurugram, Haryana, 122001, India
Tel.: 91-124-4595500
91-124-4595550
Fax: 91-124-4595550

AREA OF GROUND COVERAGE TOWER - (i)									
CHOOSE - A	1	2	3	4	5	6	7	8	9
1	1	1	1	1	1	1	1	1	1
2	1	1	1	1	1	1	1	1	1
3	1	1	1	1	1	1	1	1	1
100	1	1	1	1	1	1	1	1	1
TOTAL	100	100	100	100	100	100	100	100	100

TO BE READ WITH THIS OFFICE DATED: 30-01-2023	 DIPHO STPAHO SPAC BPAC BPAC	 SPAC BPAC BPAC	 SPAC BPAC BPAC	 SPAC BPAC BPAC	 SPAC BPAC BPAC	 SPAC BPAC BPAC	 SPAC BPAC BPAC	 SPAC BPAC BPAC	 SPAC BPAC BPAC
--	---	---	---	---	---	---	---	---	---

OWNER'S ARCHITECT'S SEAL & SIGNATURE	ARCHITECT'S OWNER'S SEAL & SIGNATURE	OWNER'S ARCHITECT'S SEAL & SIGNATURE	ARCHITECT'S OWNER'S SEAL & SIGNATURE	OWNER'S ARCHITECT'S SEAL & SIGNATURE	ARCHITECT'S OWNER'S SEAL & SIGNATURE	OWNER'S ARCHITECT'S SEAL & SIGNATURE	ARCHITECT'S OWNER'S SEAL & SIGNATURE	OWNER'S ARCHITECT'S SEAL & SIGNATURE	ARCHITECT'S OWNER'S SEAL & SIGNATURE
--	--	--	--	--	--	--	--	--	--

JAN.-2023.	Scale : 1:100	Drawing No. - GROUND COVERAGE AREA CALCULATION TOWER-D	Drawing No. - TD-02
------------	---------------	---	------------------------

Note :-

1. BUILDING WILL BE DESIGNED (STRUCTURES) AS PER RELEVANT IS CODES FOR EARTH QUAKE RESISTANCE.
2. THE BUILDING IS ARTIFICIALLY LIT AND MECHANICALLY VENTILATED.

LEGEND:—

PROJECT :

REVISED BUILDING PLANS OF GROUP
HOUSING COLONY AREA MEASURING 25.087
ACRES (LICENCE NO. 123 OF 2012 DATED
20-12-2012 IN SECTOR-63, GURGAON BEING
DEVELOPED BY ARJIE BUILDERS &
DEVELOPERS PVT. LTD. AND OTHERS IN
COLLABORATION WITH DLF HOME
DEVELOPERS LTD (EARLIER KNOWN AS DLF
NEW GURGAON HOME DEVELOPERS PVT.LTD)

ARCHITECTURE:
ARCOP

ARCOP ASSOCIATES PVT LTD
Plot No. 36B, Sector-32, Institutional Area,
Gurugram, Haryana, 122001, India
Tel.: 91-124-4595500
91-124-4595550
Fax: 91-124-4595550

TO BE READ WITH THIS OFFICE
MEMO NO. 2097
DATED: 30-01-2023

Ullmann
STP (HQ) STP (G) (C) (S) (H)
Waste Services Member Chairman
BPAC BPAC BPAC

Building plans have been checked and found in order.

as per Public Health Services point of view.

(Faint handwritten notes at the bottom of the page)

E. (New York) ☒
 Central, USA
 CE (Germany) ☒
 CE (USA)

TYPICAL (1ST TO 16TH,
18TH TO 25TH, 27TH TO
34TH, 36TH TO 39TH)

TOWER-D

ARCHITECTURAL
FEATURE

ARCHITECTURAL
FEATURE

TYPICAL FLOOR PLAN

1ST TO 16TH, 18TH TO 25TH, 27TH TO 34TH, 36TH TO 38TH FLOOR
PLAN
(TOWER-D)

[illegible]

Note :-

1. BUILDING WILL BE DESIGNED (STRUCTURES) AS PER RELEVANT IS CODES FOR EARTH QUAKE RESISTANCE.
2. THE BUILDING IS ARTIFICIALLY LIT AND MECHANICALLY VENTILATED.

LEGEND:-

PROJECT :

REVISED BUILDING PLANS OF GROUP HOUSING COLONY AREA MEASURING 25.087 ACRES (LICENCE NO. 123 OF 2012 DATED 20-12-2012 IN SECTOR-63, GURGAON BEING DEVELOPED BY ARLIE BUILDERS & DEVELOPERS PVT. LTD. AND OTHERS IN COLLABORATION WITH DLF HOME DEVELOPERS LTD (EARLIER KNOWN AS DLF NEW GURGAON HOME DEVELOPERS PVT LTD)

ARCHITECTURE:
ARCOP

ARCOP ASSOCIATES PVT LTD
Plot No. 36B, Sector-32, Institutional Area,
Gurgaon, Haryana, 122001, India
Tel.: 91-124-4595500
91-124-4595550
Fax: 91-124-4595550

TO BE READ WITH THIS OFFICE

DATE: 21.01.2023

TO BE READ WITH THIS OFFICE
DATE: 21.01.2023

TO BE READ WITH THIS OFFICE
DATE: 21.01.2023

Building plans have been checked and found in order
as per Public Health Services Dept of Govt.

Building plans have been checked and found in order
as per Public Health Services Dept of Govt.

ARCHITECT'S SEAL
& SIGNATURE

OWNER'S SEAL
& SIGNATURE

FRATEER BHATTARAI
ARCHITECT
DIPLOMA IN ARCHITECTURE
REG. NO. 123456789
DIPLOMA IN ARCHITECTURE
REG. NO. 123456789

DLF Home Developers Limited

Authorized Signatory

JAN-2023 Scale : 1:100

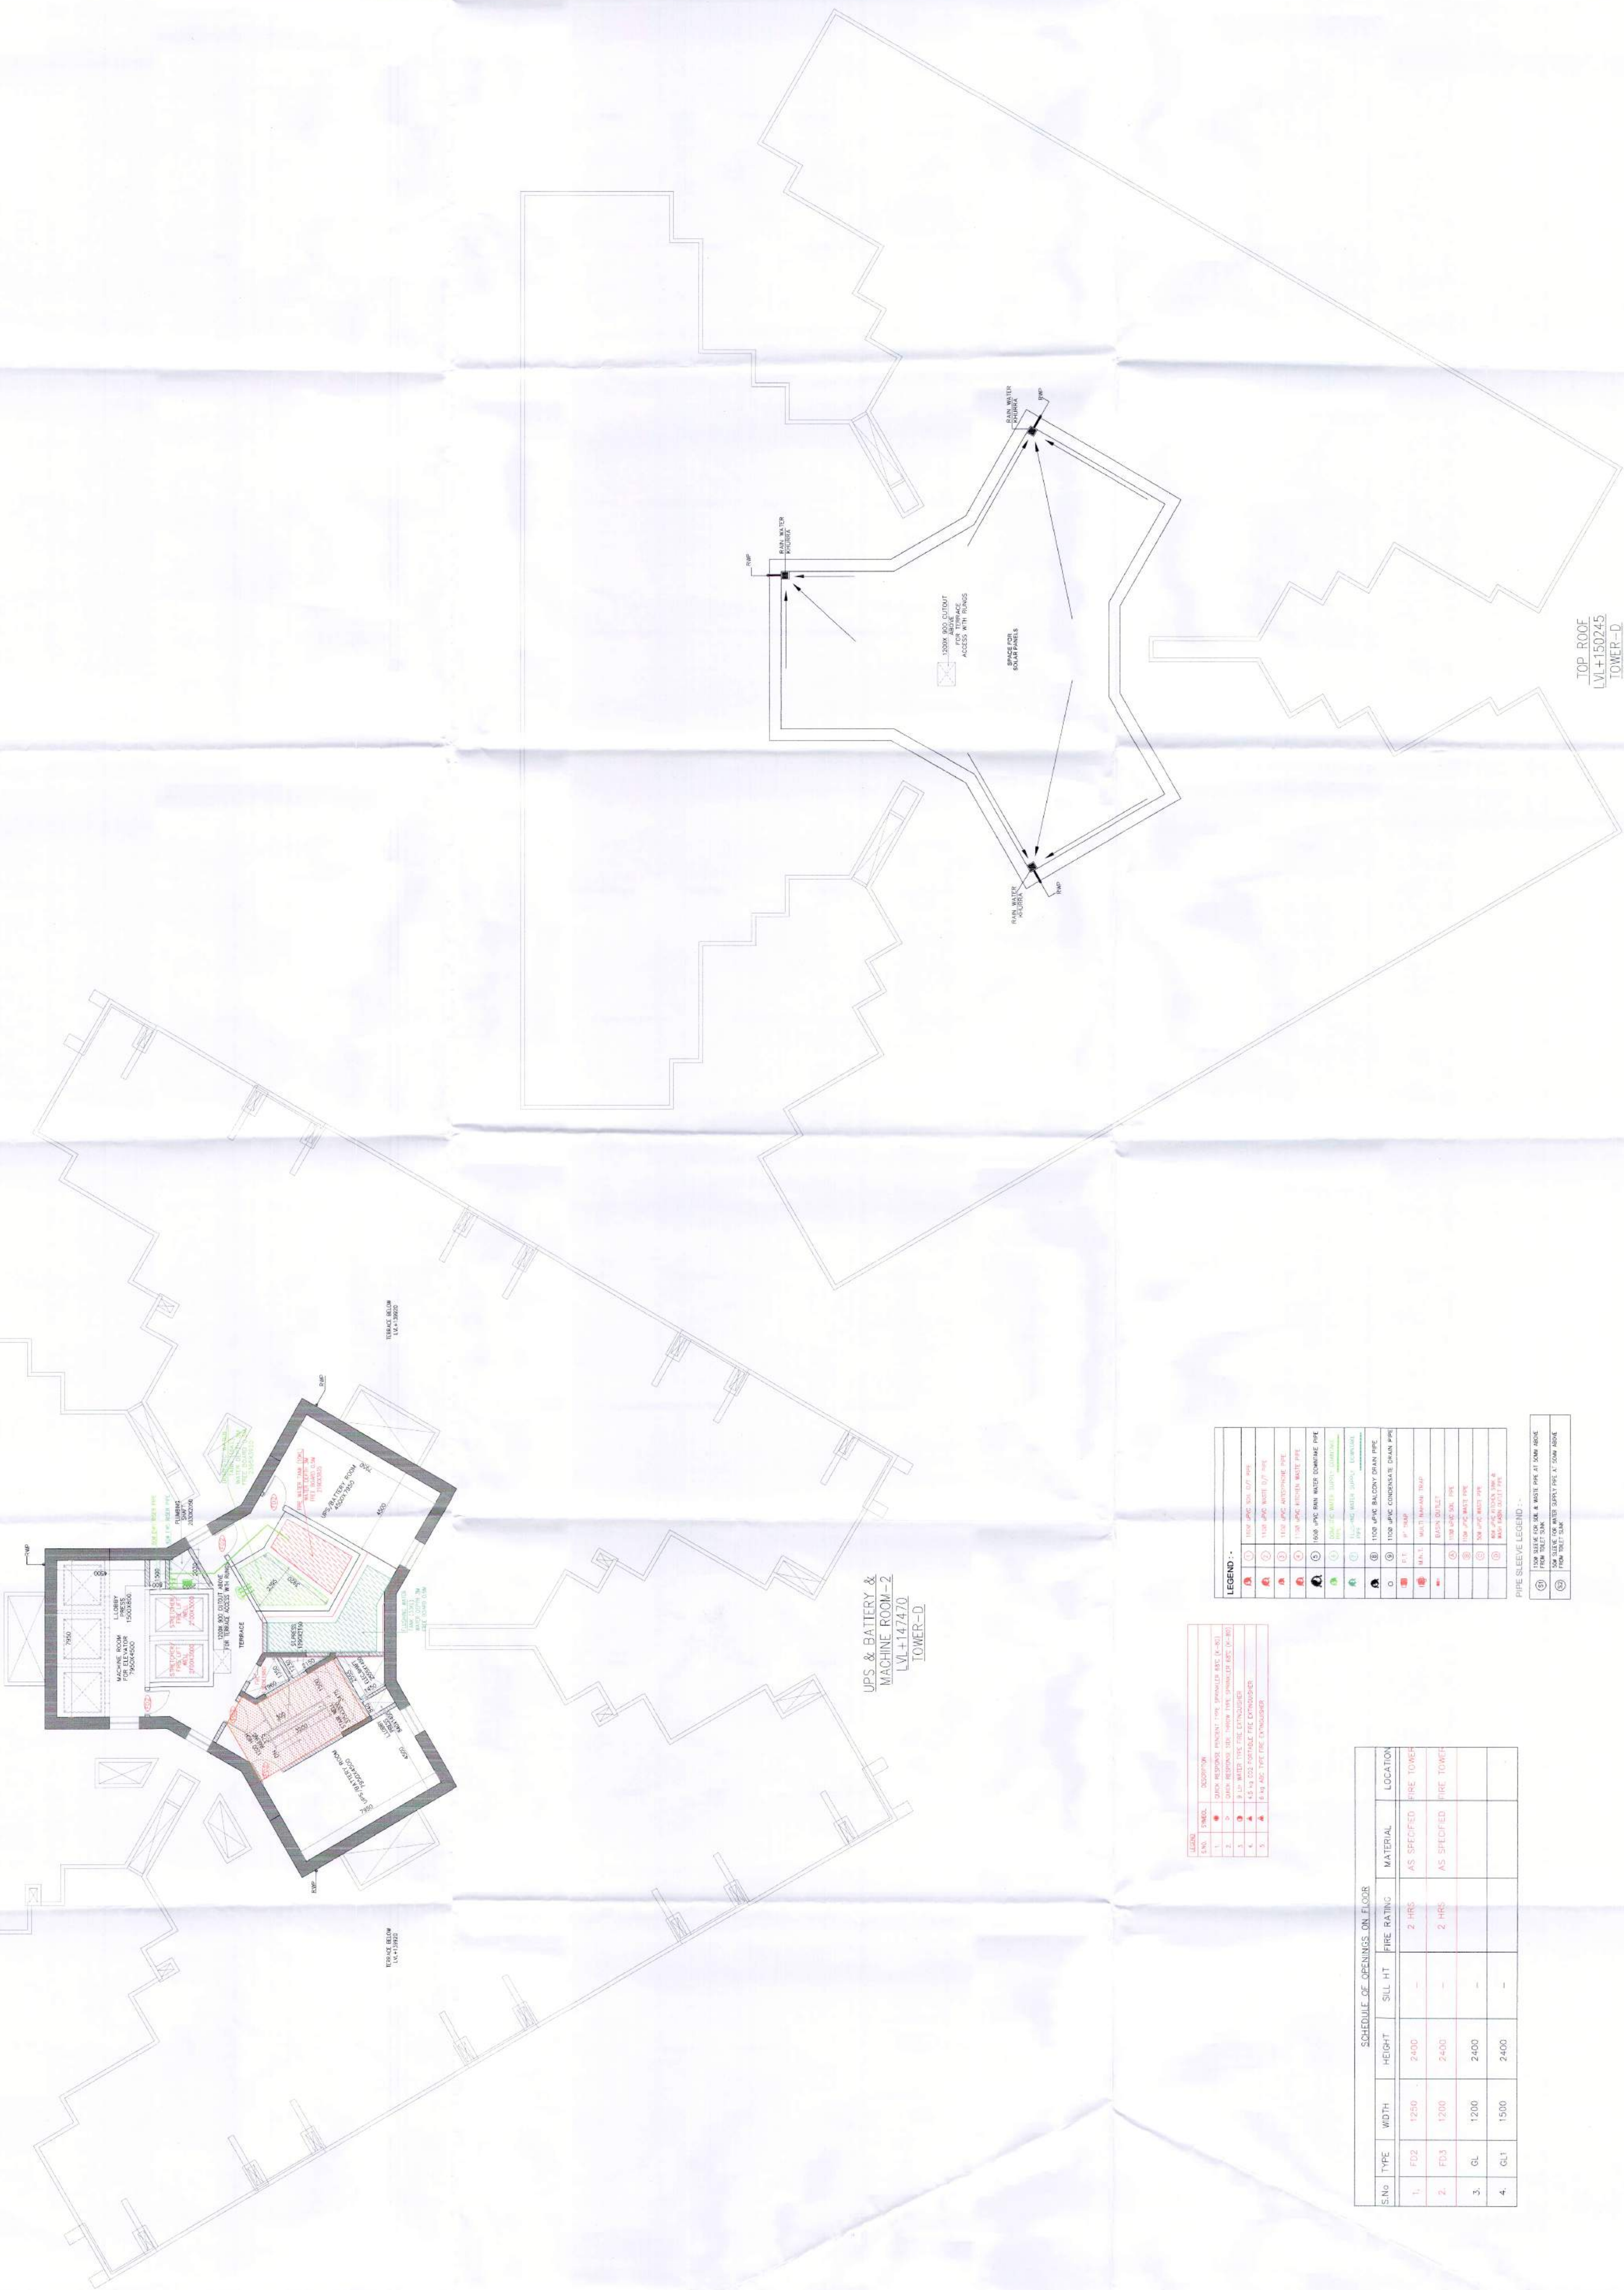
Drawing Title:-

MACHINE ROOM 2 PLAN & ROOF PLAN

TOWER-D

Drawing No:-

TD-06



LEGEND :-	
1	1000 JWC 1000 JWC 1000 JWC
2	1000 JWC 1000 JWC 1000 JWC
3	1000 JWC 1000 JWC 1000 JWC
100	1000 JWC 1000 JWC 1000 JWC

PIPE SLEEVE LEGEND :-	
1	1000 JWC 1000 JWC 1000 JWC
2	1000 JWC 1000 JWC 1000 JWC
3	1000 JWC 1000 JWC 1000 JWC
100	1000 JWC 1000 JWC 1000 JWC

SCHEDULE OF OPENINGS ON FLOOR				
S.No	TYPE	WIDTH	HEIGHT	LOCATION
1.	FD2	1200	2400	AS SPECIFIED FIRE TOWER
2.	FD3	1200	2400	AS SPECIFIED FIRE TOWER
3.	GL	1200	2400	AS SPECIFIED FIRE TOWER
4.	GL1	1500	2400	AS SPECIFIED FIRE TOWER