



[illegible]

GENERAL NOTES: 1. DRAWINGS IN PL & FF SERIES REPRESENTS PLUMBING AND FIRE SUPPRESSION SYSTEM DETAIL. 2. IN CASE OF ANY DISCREPANCY IT SHOULD BE CORRECTED BY THE ARCHITECT / PROJECT MANAGER / CONSULTANT. 3. DRAWING SHOULD NOT BE SCALED. 4. ONLY WRITTEN DIMENSIONS TO BE FOLLOWED. 5. THIS DRAWING SHOULD BE READ IN CONJUNCTION WITH RELEVANT ARCHITECTURAL, LAND SCAPING, STRUCTURAL AND OTHER SERVICES DRAWING. 6. ALL SERVICES SHAFTS SHOULD BE SEALED AT EVERY FLOOR LEVEL AFTER INSTALLING SERVICES.	PSR- PLUMBING SHAFT OF RESIDENTIAL PWS- PLUMBING MASTER SHAFT
---	--


DOOR WINDOW SCHEDULE				
NAME	WIDTH	SILL	LOCATION	UNIT TYPE
D2	900	0	2100	DOORWAY ENTRY
D3	750	0	2100	TOILET KITCHEN
D3A	750	0	2400	SEWANT RM.
FD	1200	0	2100	2 1/2 HR FIRE RATING 2 1/2 HR FIRE RATING
F01	1500	0	2100	LIFT LOBBY
F02	1200	0	2400	2 1/2 HR FIRE RATING 2 1/2 HR FIRE RATING
F03	900	0	2100	2 1/2 HR FIRE RATING
F04	750	0	2100	2 1/2 HR FIRE RATING
V	600	1200	2400	TOILET
V1	600	1050	2250	TOILET
DW1	3000	0	2400	DRAWING/DINING
DW2	2000	0	2400	M. BEDROOM
DW3	1600	0	2400	BEDROOM
DW4	1450	1100	2400	KITCHEN
DW5	1800	0	2400	BEDROOM
DW6	2400	0	2400	DRAWING/DINING
DW7	2200	0	2400	DRAWING/DINING
W1	2000	300	2400	REFUSE FL. COMMON
W2	1800	300	2400	REFUSE FL. COMMON
W3	1550	300	2400	BEDROOM
W4	1450	300	2400	BEDROOM

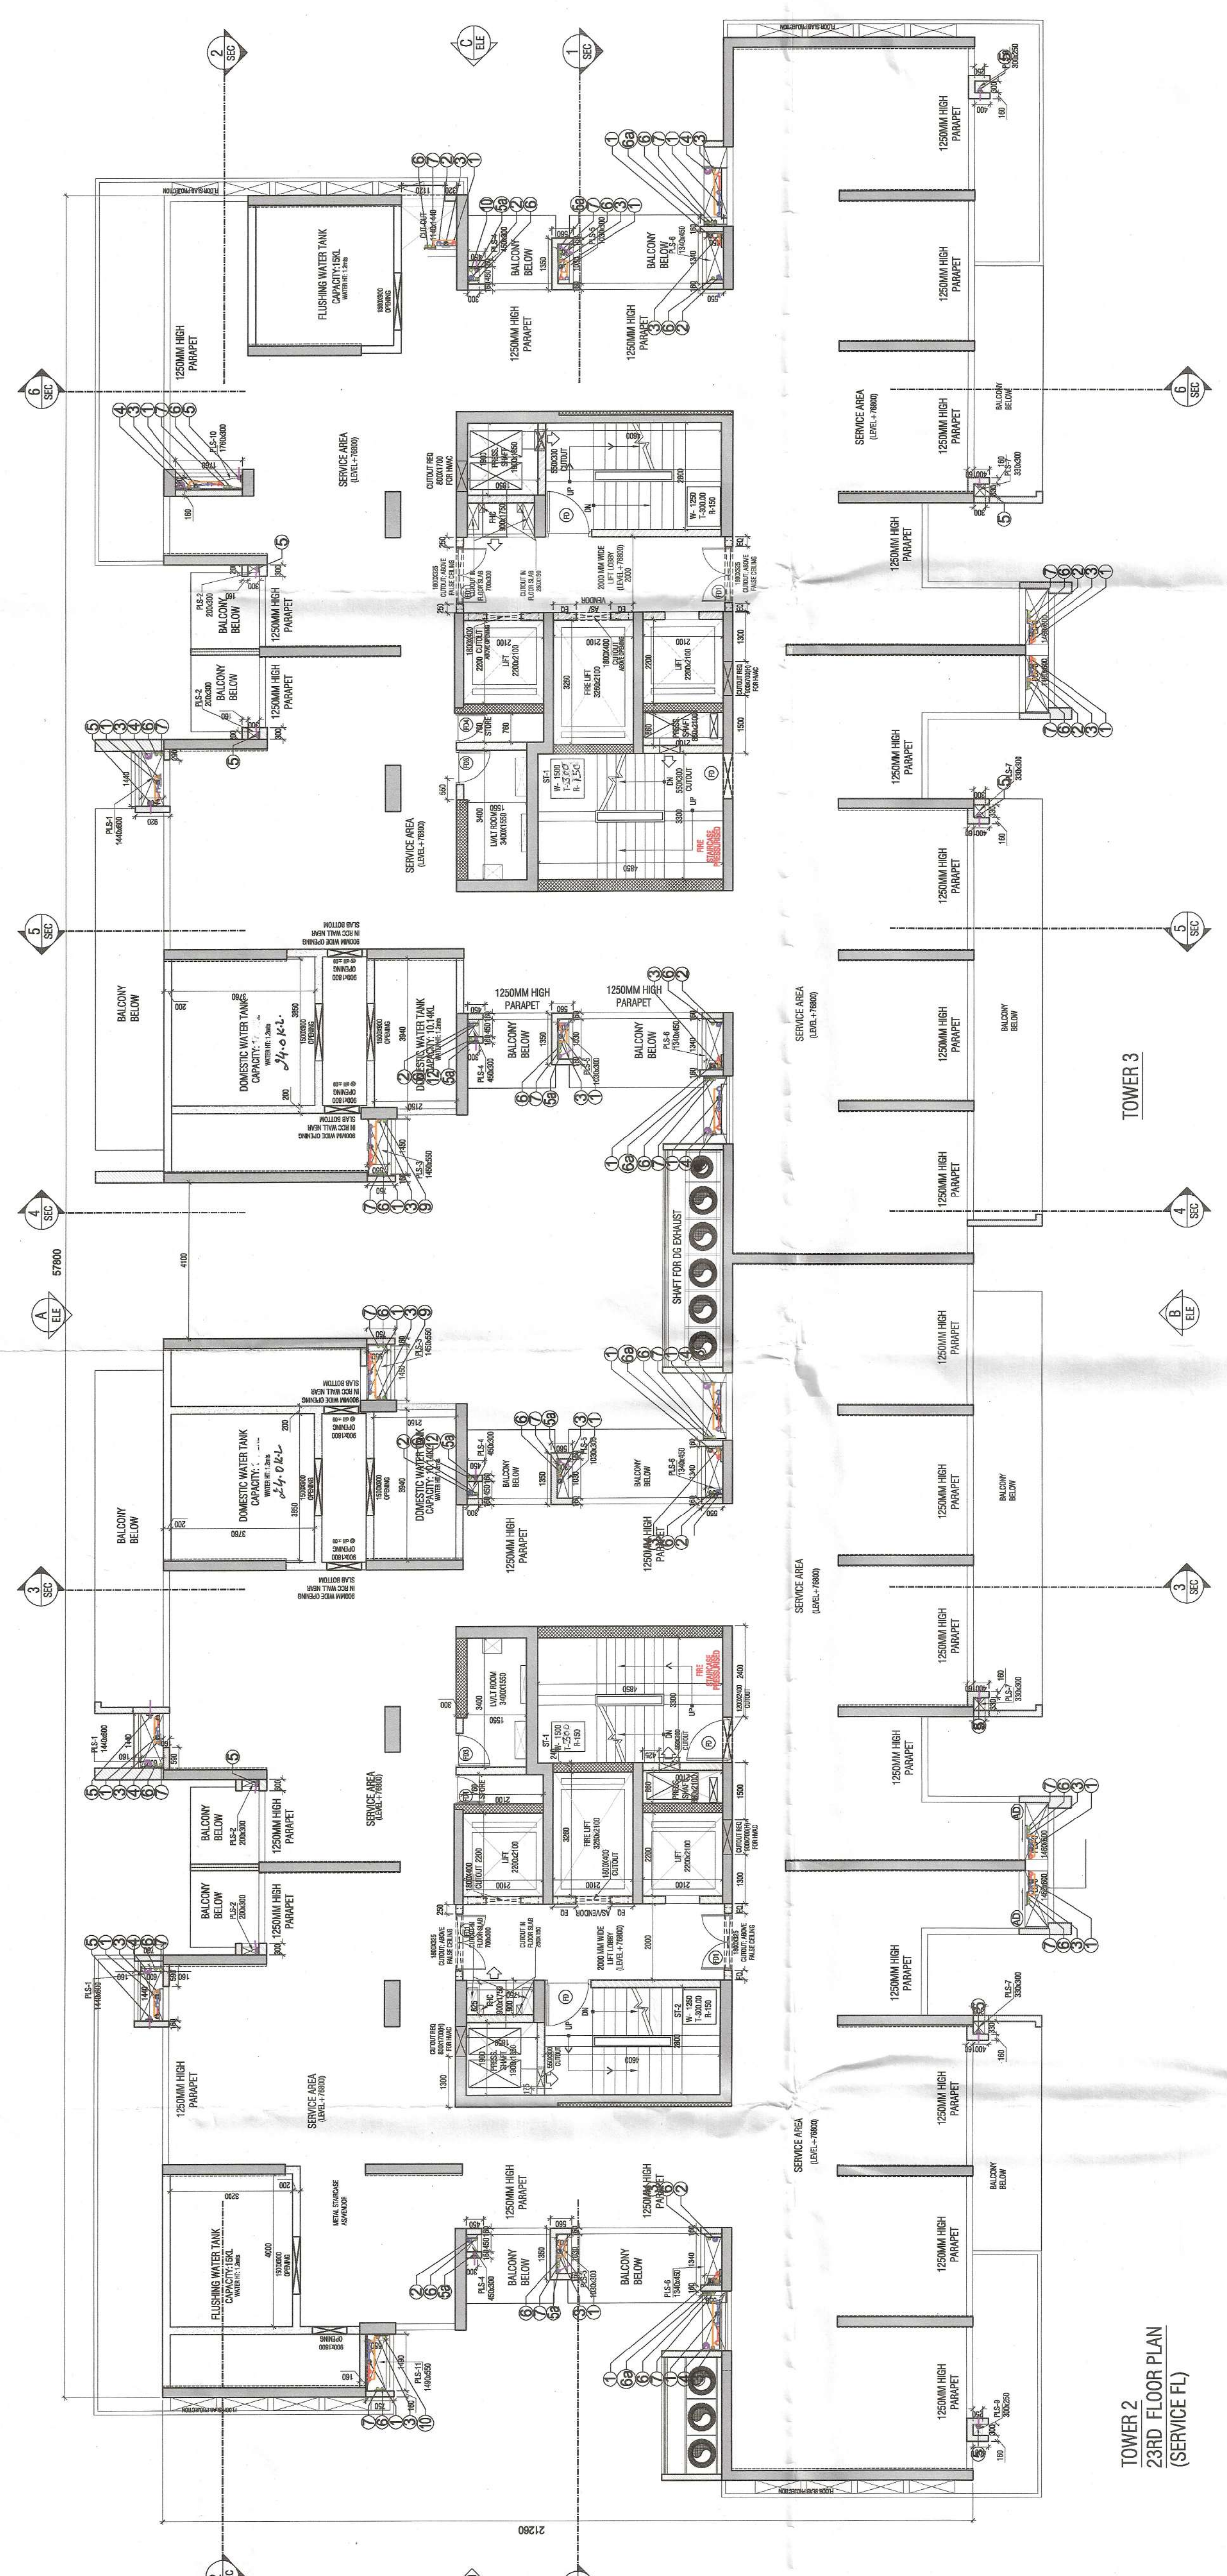


TOWER 2
23RD FLOOR PLAN
(SERVICE FL)

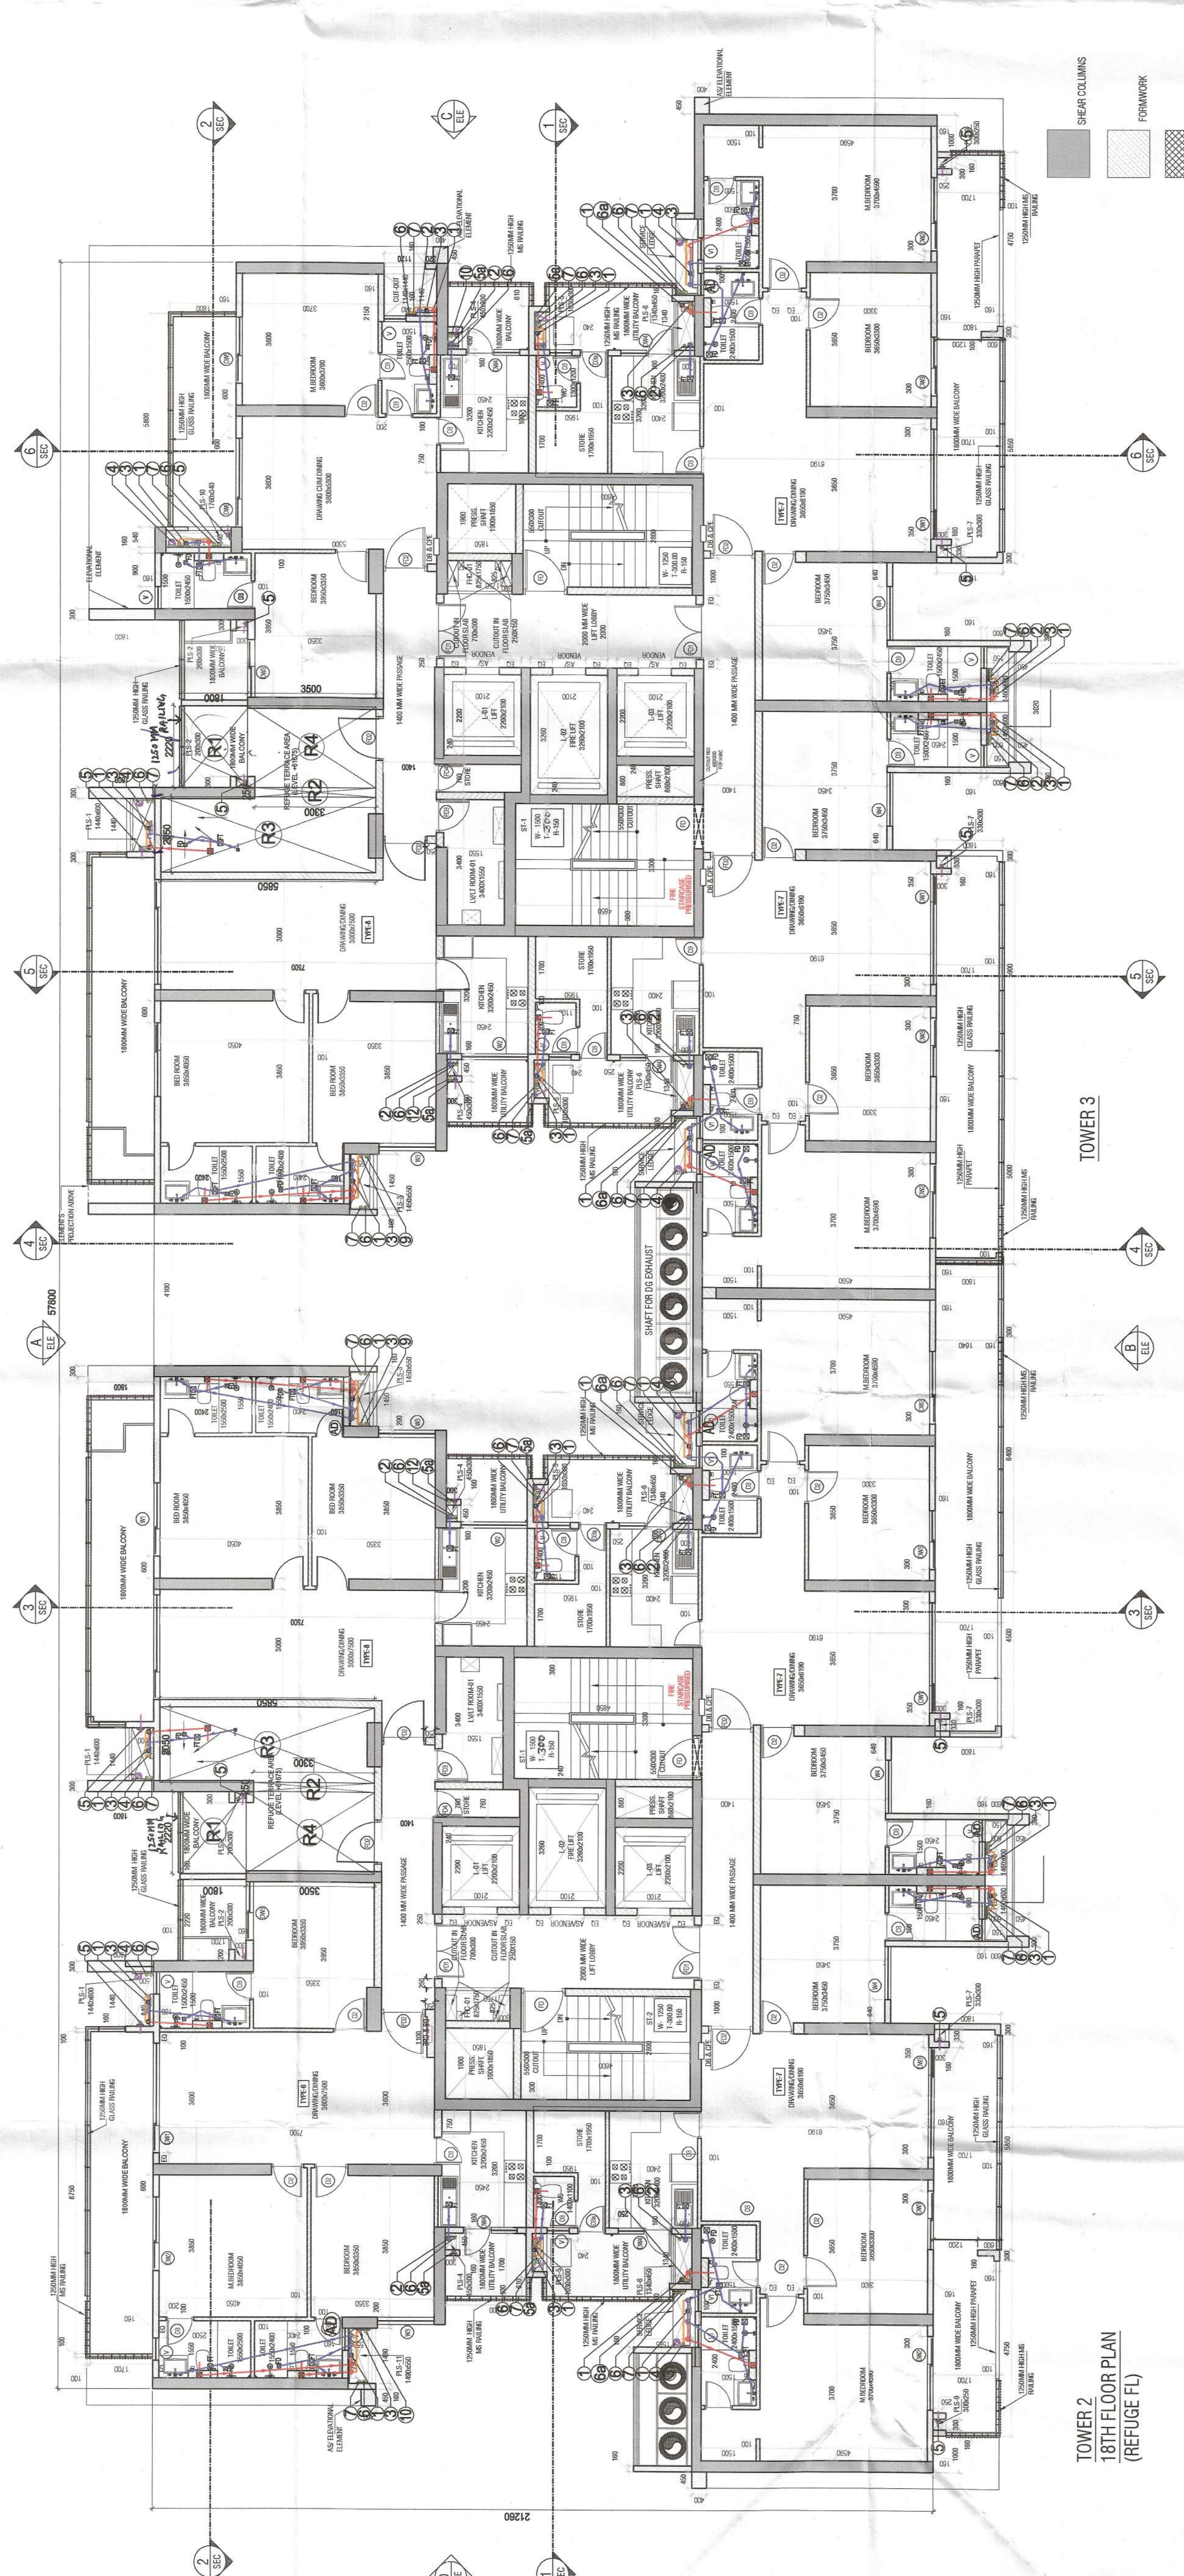

TOWER 2
18TH FLOOR PLAN
(REFUGE FLOOR)

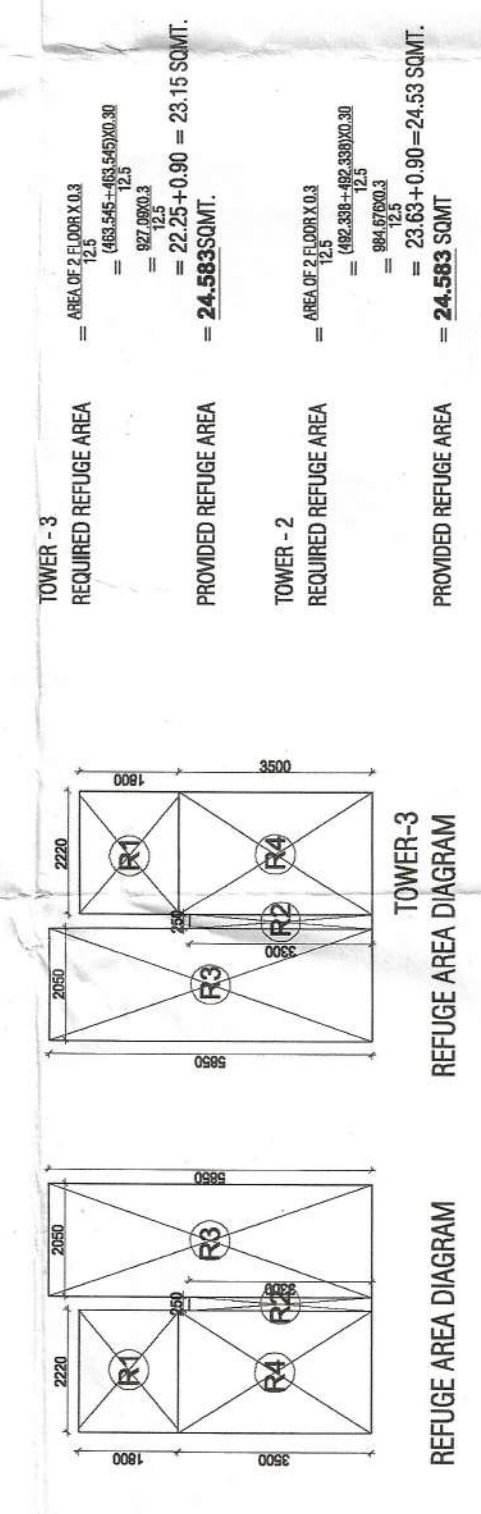

REFUGEE AREA CALCULATIONS			
R1	1	2,220	1,800
R2	1	0,250	3,300
R3	1	2,050	5,850
R4	1	2,220	3,500
TOTAL REFUGEE AREA (C1)			24,563

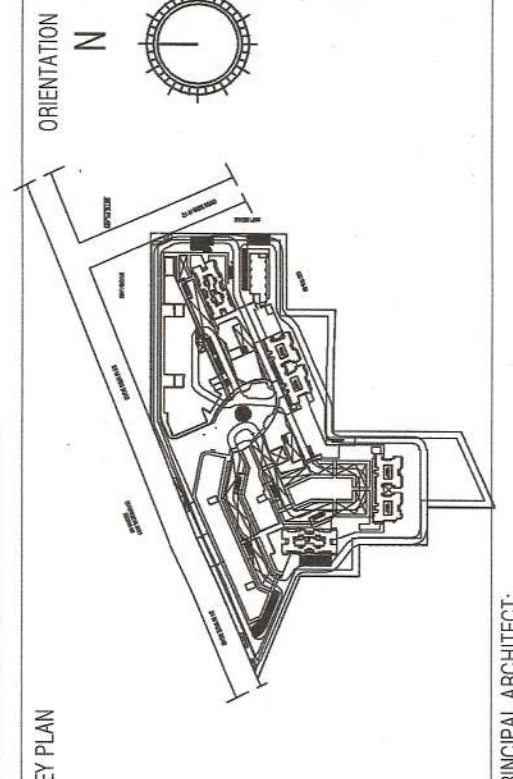[illegible]

ACPL
ACPL Design Ltd
E-24, 24th Floor - 1
New India 1356, India
E: enquiry@acpl.com
www.acpl.com

ISO 9001:2008
Architecture
Mechanical
Planning
E: +91 11 26207145
+91 11 26207146
F: +91 11 26206100

PROJECT:-
REVISED BUILDING PLANS OF MIXED LAND USE COLONY (70% RESIDENTIAL + 30% COMMERCIAL) MEASURING 14.4125 ACRES (LICENCE NO. 15 OF 2017 DATED-02.05.2017) UNDER TOD POLICY DATED 09.02.2016 IN SECTOR-65, GURUGRAM BEING DEVELOPED BY MANGLAM MULTIPLEX PVT. LTD.

	MANOJ KUMAR MULTIPLEX PVT. LTD ALL INDIA DIRECTOR		RAJESH KUMAR ARCHITECT CONSULTANT	ARCHITECT'S SIGNATURE	18TH REFUGE & 23RD SERVICES FLOOR PLAN (TOWER - 2 & 3)	SCALE : 1:100
	MANOJ KUMAR MULTIPLEX PVT. LTD ALL INDIA DIRECTOR		RAJESH KUMAR ARCHITECT CONSULTANT	ARCHITECT'S SIGNATURE	18TH REFUGE & 23RD SERVICES FLOOR PLAN (TOWER - 2 & 3)	SCALE : 1:100