


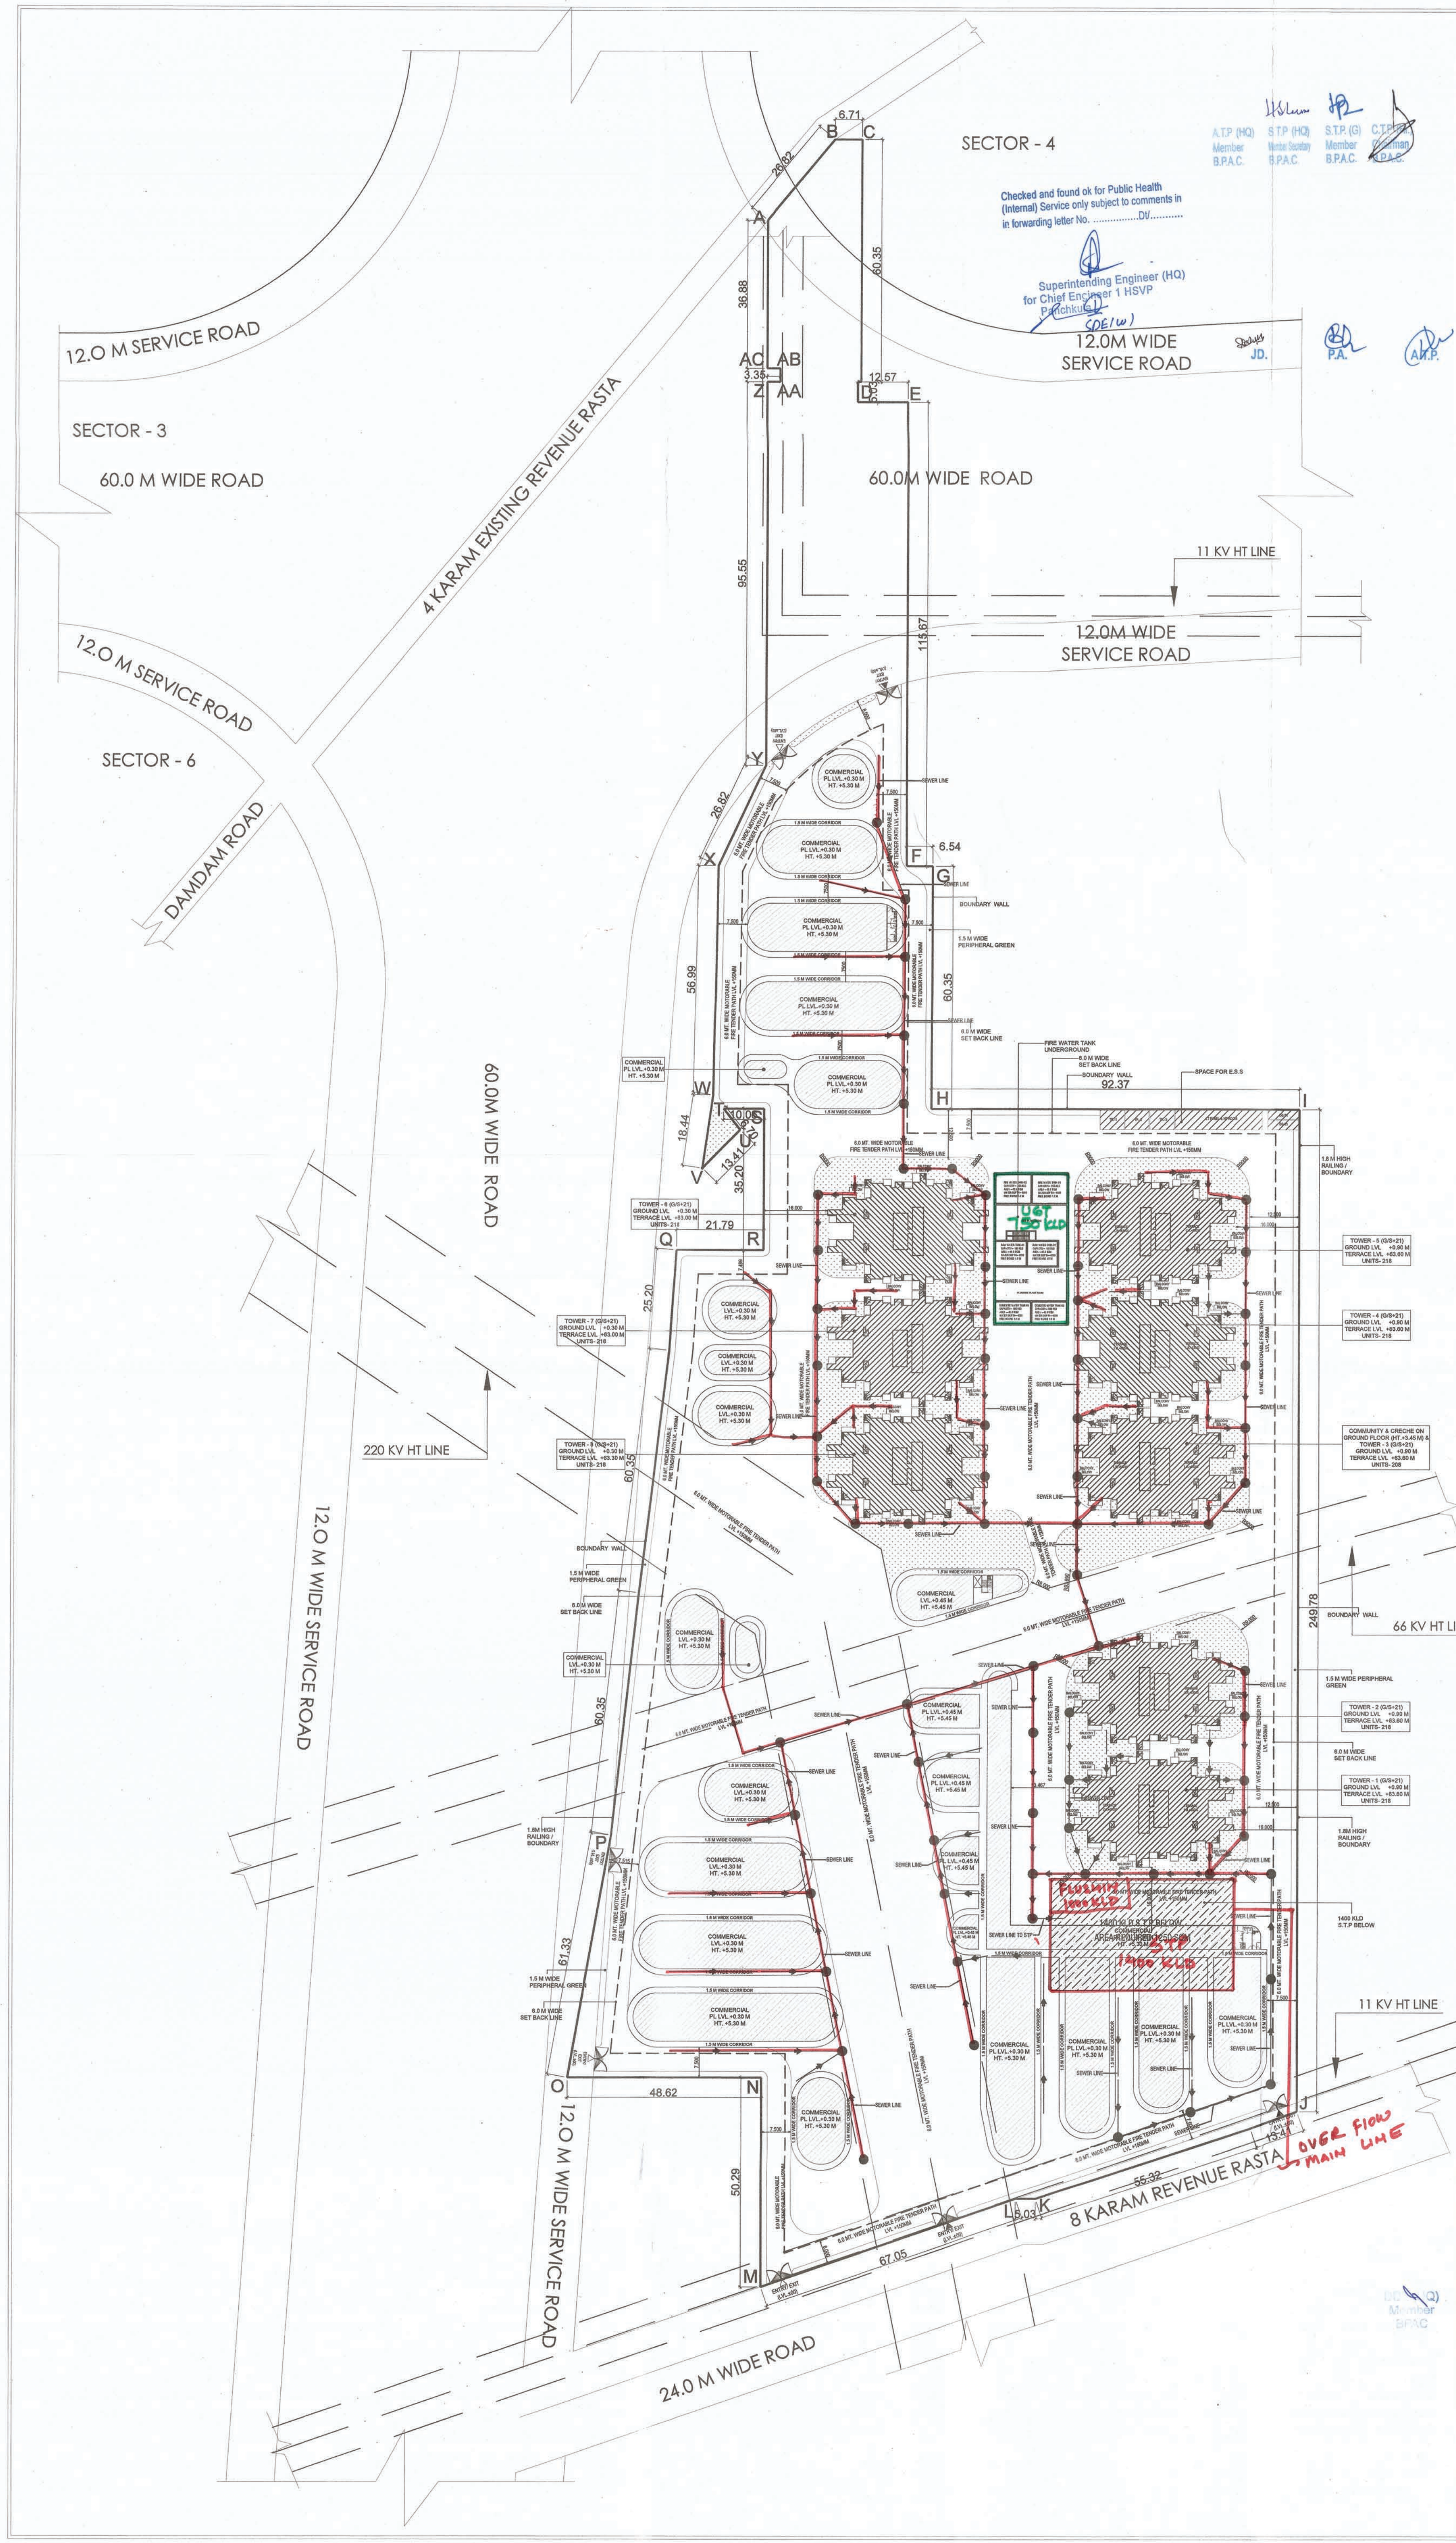

PLUMBING & FIRE SERVICES LEGEND :	
	SEWER MANHOLE WITH 5000 S.F.R.C. MANHOLE COVER.
	STORM WATER MANHOLE WITH 5000 S.F.R.C. PERFORATED MANHOLE COVER.
	CATCH BASIN (450 x 450) MM WITH PERFORATED MANHOLE COVER
	CATCH BASIN (600 x 600) MM WITH PERFORATED MANHOLE COVER
	STORM WATER MANHOLE (900 x 800) MM WITH PERFORATED MANHOLE COVER.
	SEWER MANHOLE (600 x 600) MM
	SEWER MANHOLE (900 x 800) MM
	GULLY TRAP (300 x 300) MM
	EXTERNAL SW SEWER LINE (DIA AS / DESIGN CHART)
	EXTERNAL RCC STORM WATER LINE (DIA AS / DESIGN CHART)
	1500 DI MUNICIPAL WATER SUPPLY LINE
	GI DOMESTIC WATER SUPPLY LINE
	GI FLUSHING WATER SUPPLY LINE
	HDPE GARDEN IRRIGATION WATER SUPPLY LINE
	GARDEN HYDRANT WITH CHAMBER (300x300) MM
	RECHARGE PIT, 3000 MM DIA
	DESILTING CHAMBER (1000 x 2000)MM
	4 WAY FIRE BRIGADE INLET CONNECTION FOR FIRE TANK PIPE DIA 1500
	2 WAY FIRE BRIGADE WITHDRAWAL CONNECTION FROM FIRE TANK, PIPE DIA 1500

PROJECT TITLE

PROPOSED BUILDING PLAN OF AFFORDABLE GROUP HOUSING COLONY FOR AN AREA MEASURING 12.8847 ACRES (LICENSE NO. 189 OF 2022 DATED 16/11/2022) IN SECTOR-5, SOHNA, DISTRICT GURUGRAM BEING DEVELOPED BY SRE INDIA AND DESI CONSTRUCTION PVT. LTD. IN COLLABORATION WITH DESI CONSTRUCTION PVT. LTD.

LC -4846

OWNERS' SIGNATURE

ARCHITECTS' SIGNATURE

Avanika Vashishth
CA/2018/91670

DRAWING TITLE

SITE PLAN WITH SEWERAGE LAYOUT

ARCHITECT	NORTH	
GANGA REALTY - DESIGN TEAM		
DATE	NOVEMBER, 2022	DWG. NO.
SCALE	1:1000	PL-101
DEALT	AN	
CHECKED	NKM	