


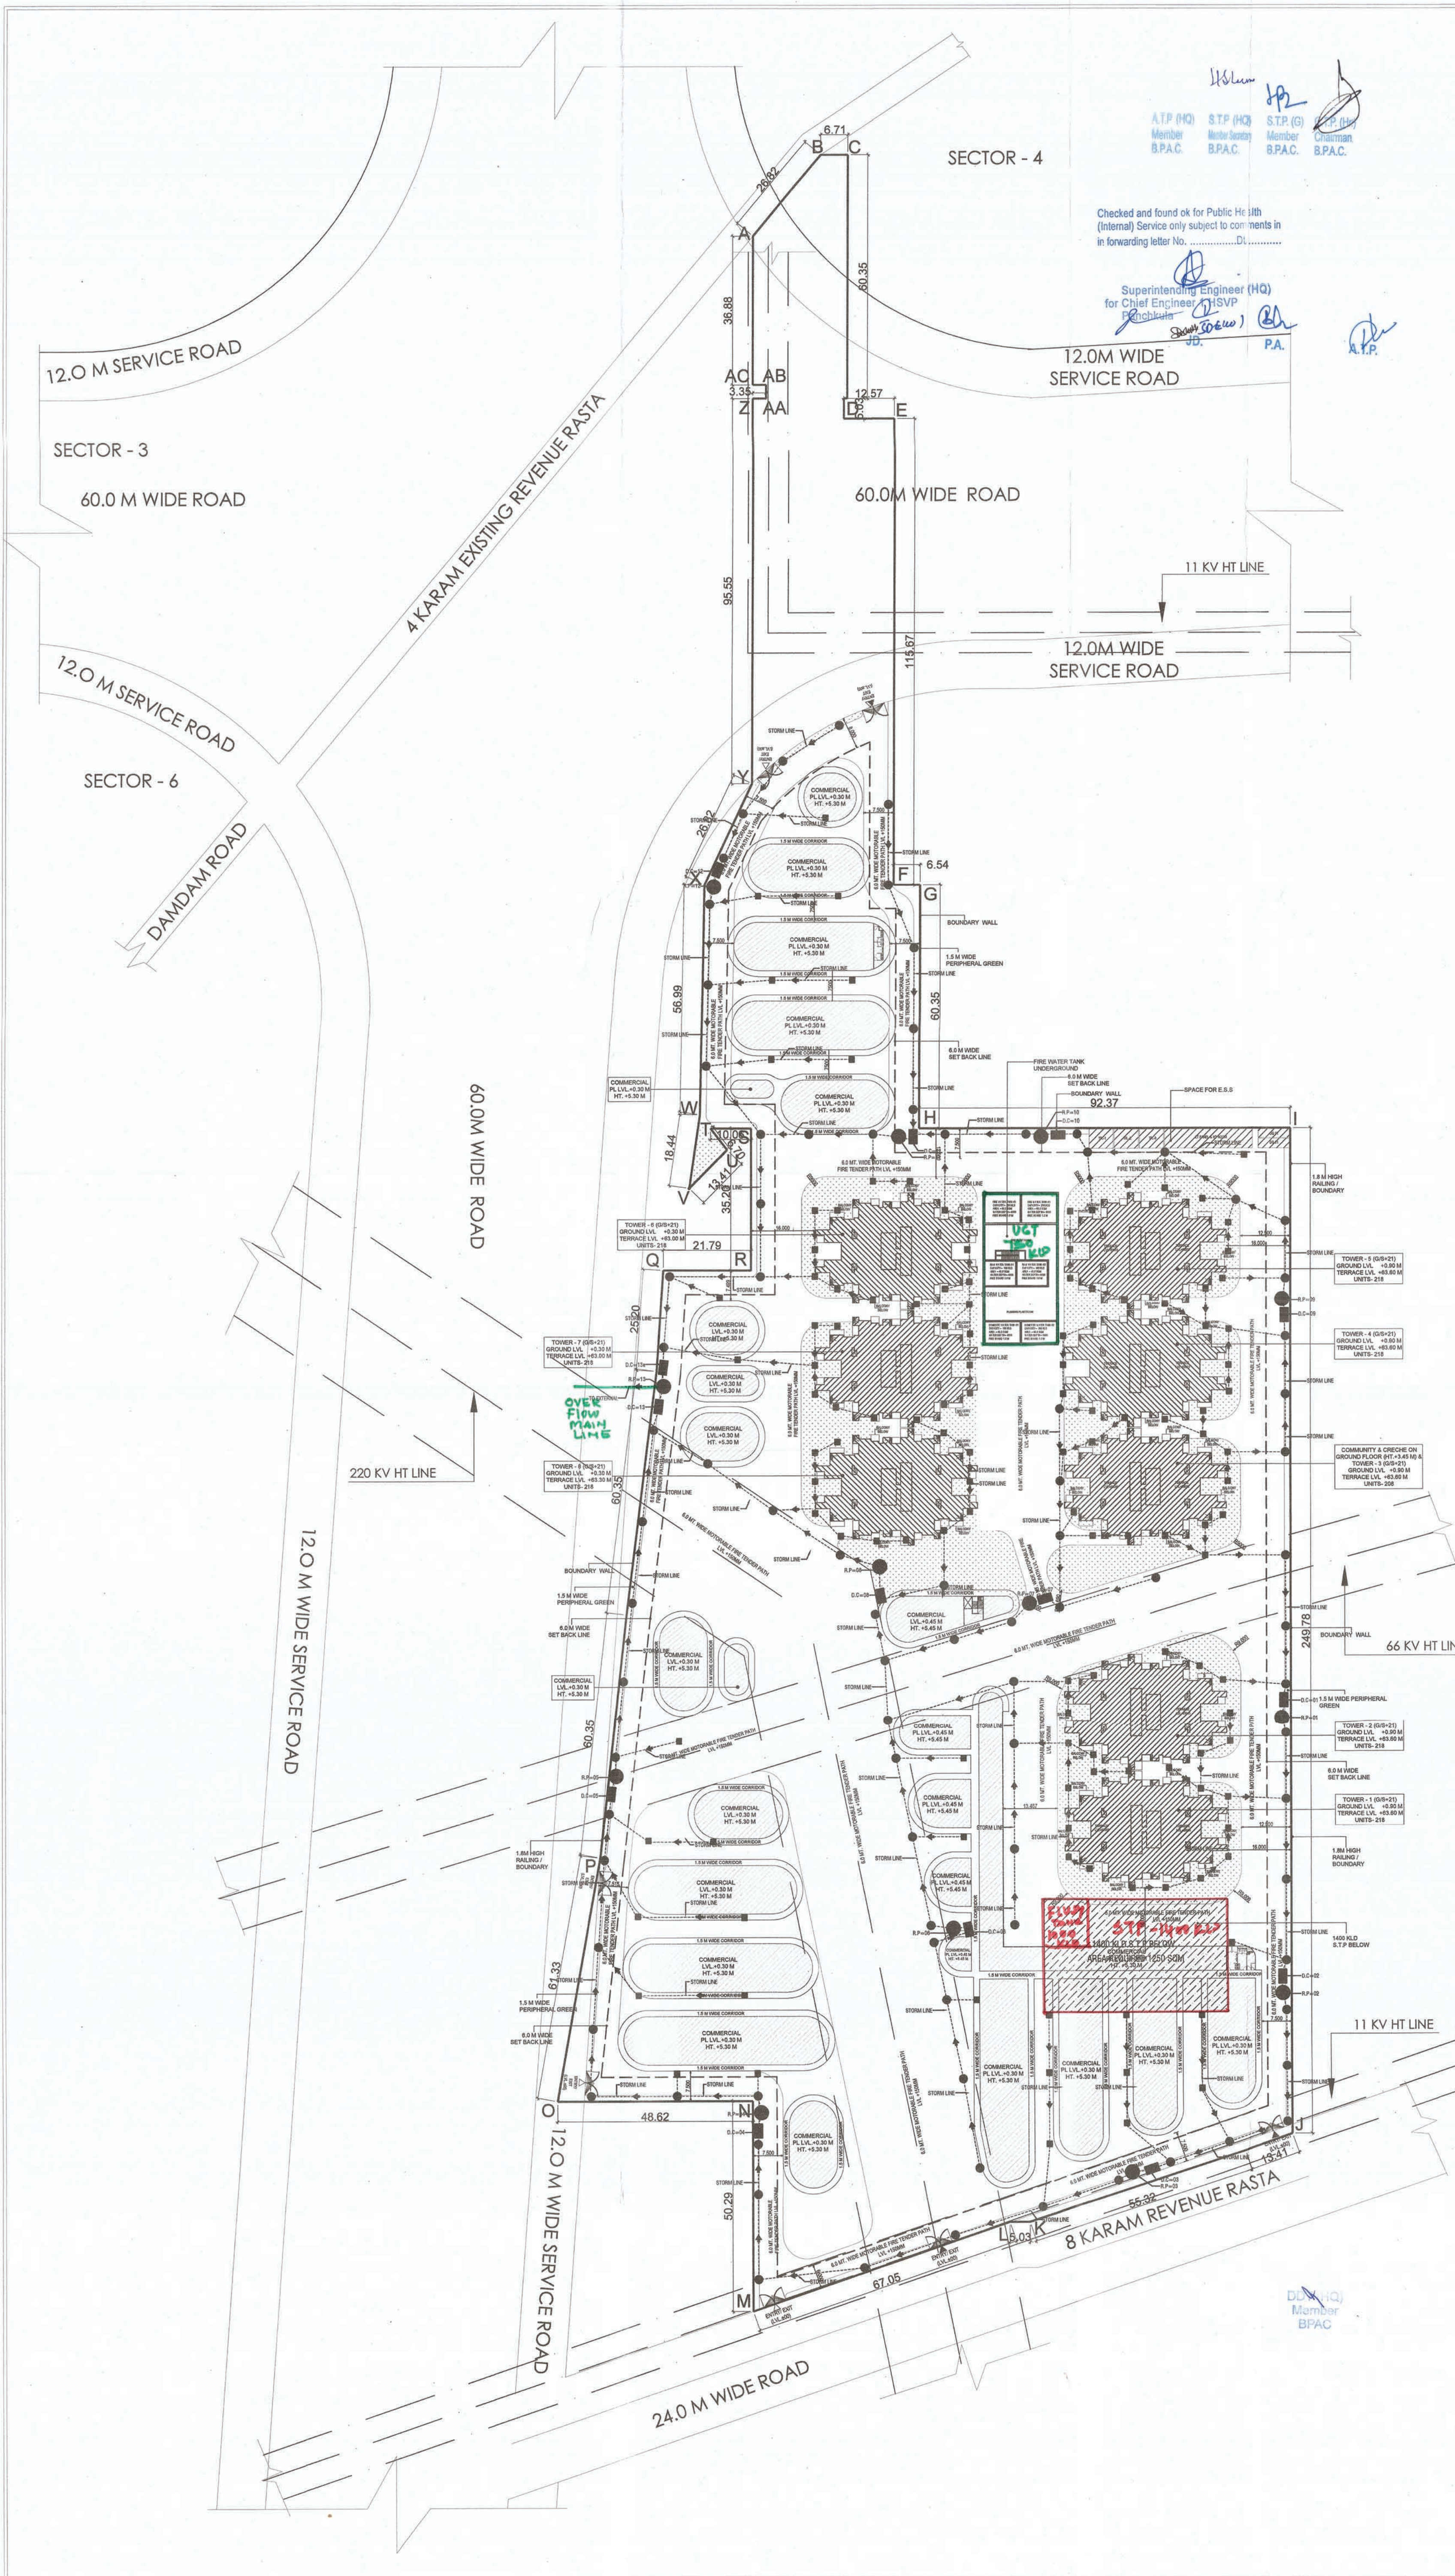

PLUMBING & FIRE SERVICES LEGEND:	
	SEWER MANHOLE WITH 5000 S.F.R.C. MANHOLE COVER.
	STORM WATER MANHOLE WITH 5000 S.F.R.C. PERFORATED MANHOLE COVER.
	CATCH BASIN (450 x 450) MM WITH PERFORATED MANHOLE COVER.
	CATCH BASIN (600 x 600) MM WITH PERFORATED MANHOLE COVER.
	STORM WATER MANHOLE (900 x 900) MM WITH PERFORATED MANHOLE COVER.
	SEWER MANHOLE (800 x 800) MM.
	SEWER MANHOLE (900 x 900) MM.
	GULLY TRAP (300 x 300) MM.
	EXTERNAL SW SEWER LINE (DIA AS / DESIGN CHART).
	EXTERNAL RCC STORM WATER LINE (DIA AS / DESIGN CHART).
	1500 DI MUNICIPAL WATER SUPPLY LINE.
	GI DOMESTIC WATER SUPPLY LINE.
	GI FLUSHING WATER SUPPLY LINE.
	HOPE GARDEN IRRIGATION WATER SUPPLY LINE.
	GARDEN HYDRANT WITH CHAMBER (300x300) MM.
	RECHARGE PIT, 3000 MM DIA.
	DESILTING CHAMBER (1000 x 2000)MM.
	4 WAY FIRE BRIGADE INLET CONNECTION FOR FIRE TANK PIPE DIA 1500.
	2 WAY FIRE BRIGADE WITHDRAWAL CONNECTION FROM FIRE TANK, PIPE DIA 1500.

PROJECT TITLE
PROPOSED BUILDING PLAN OF AFFORDABLE GROUP HOUSING COLONY FOR AN AREA MEASURING 12.8847 ACRES (LICENSE NO. 189 OF 2022 DATED 16/11/2022) IN SECTOR-5, SOHNA, DISTRICT GURUGRAM BEING DEVELOPED BY SRE INDIA AND DESI CONSTRUCTION PVT. LTD. IN COLLABORATION WITH DESI CONSTRUCTION PVT. LTD.
LC-4846

OWNERS' SIGNATURE
ARCHITECTS' SIGNATURE

Avanika Vashisth
CA/2018/91670

DRAWING TITLE	
SITE PLAN WITH STORM WATER LAYOUT	
ARCHITECT	NORTH
GANGA REALTY - DESIGN TEAM	
GANGA REALTY Vallu Tower, Golf Course Road Gurgaon, Haryana	
DATE	NOVEMBER, 2022
SCALE	1:1000
DEALT	AN
CHECKED	NKM
DWG. NO.	PL-102