


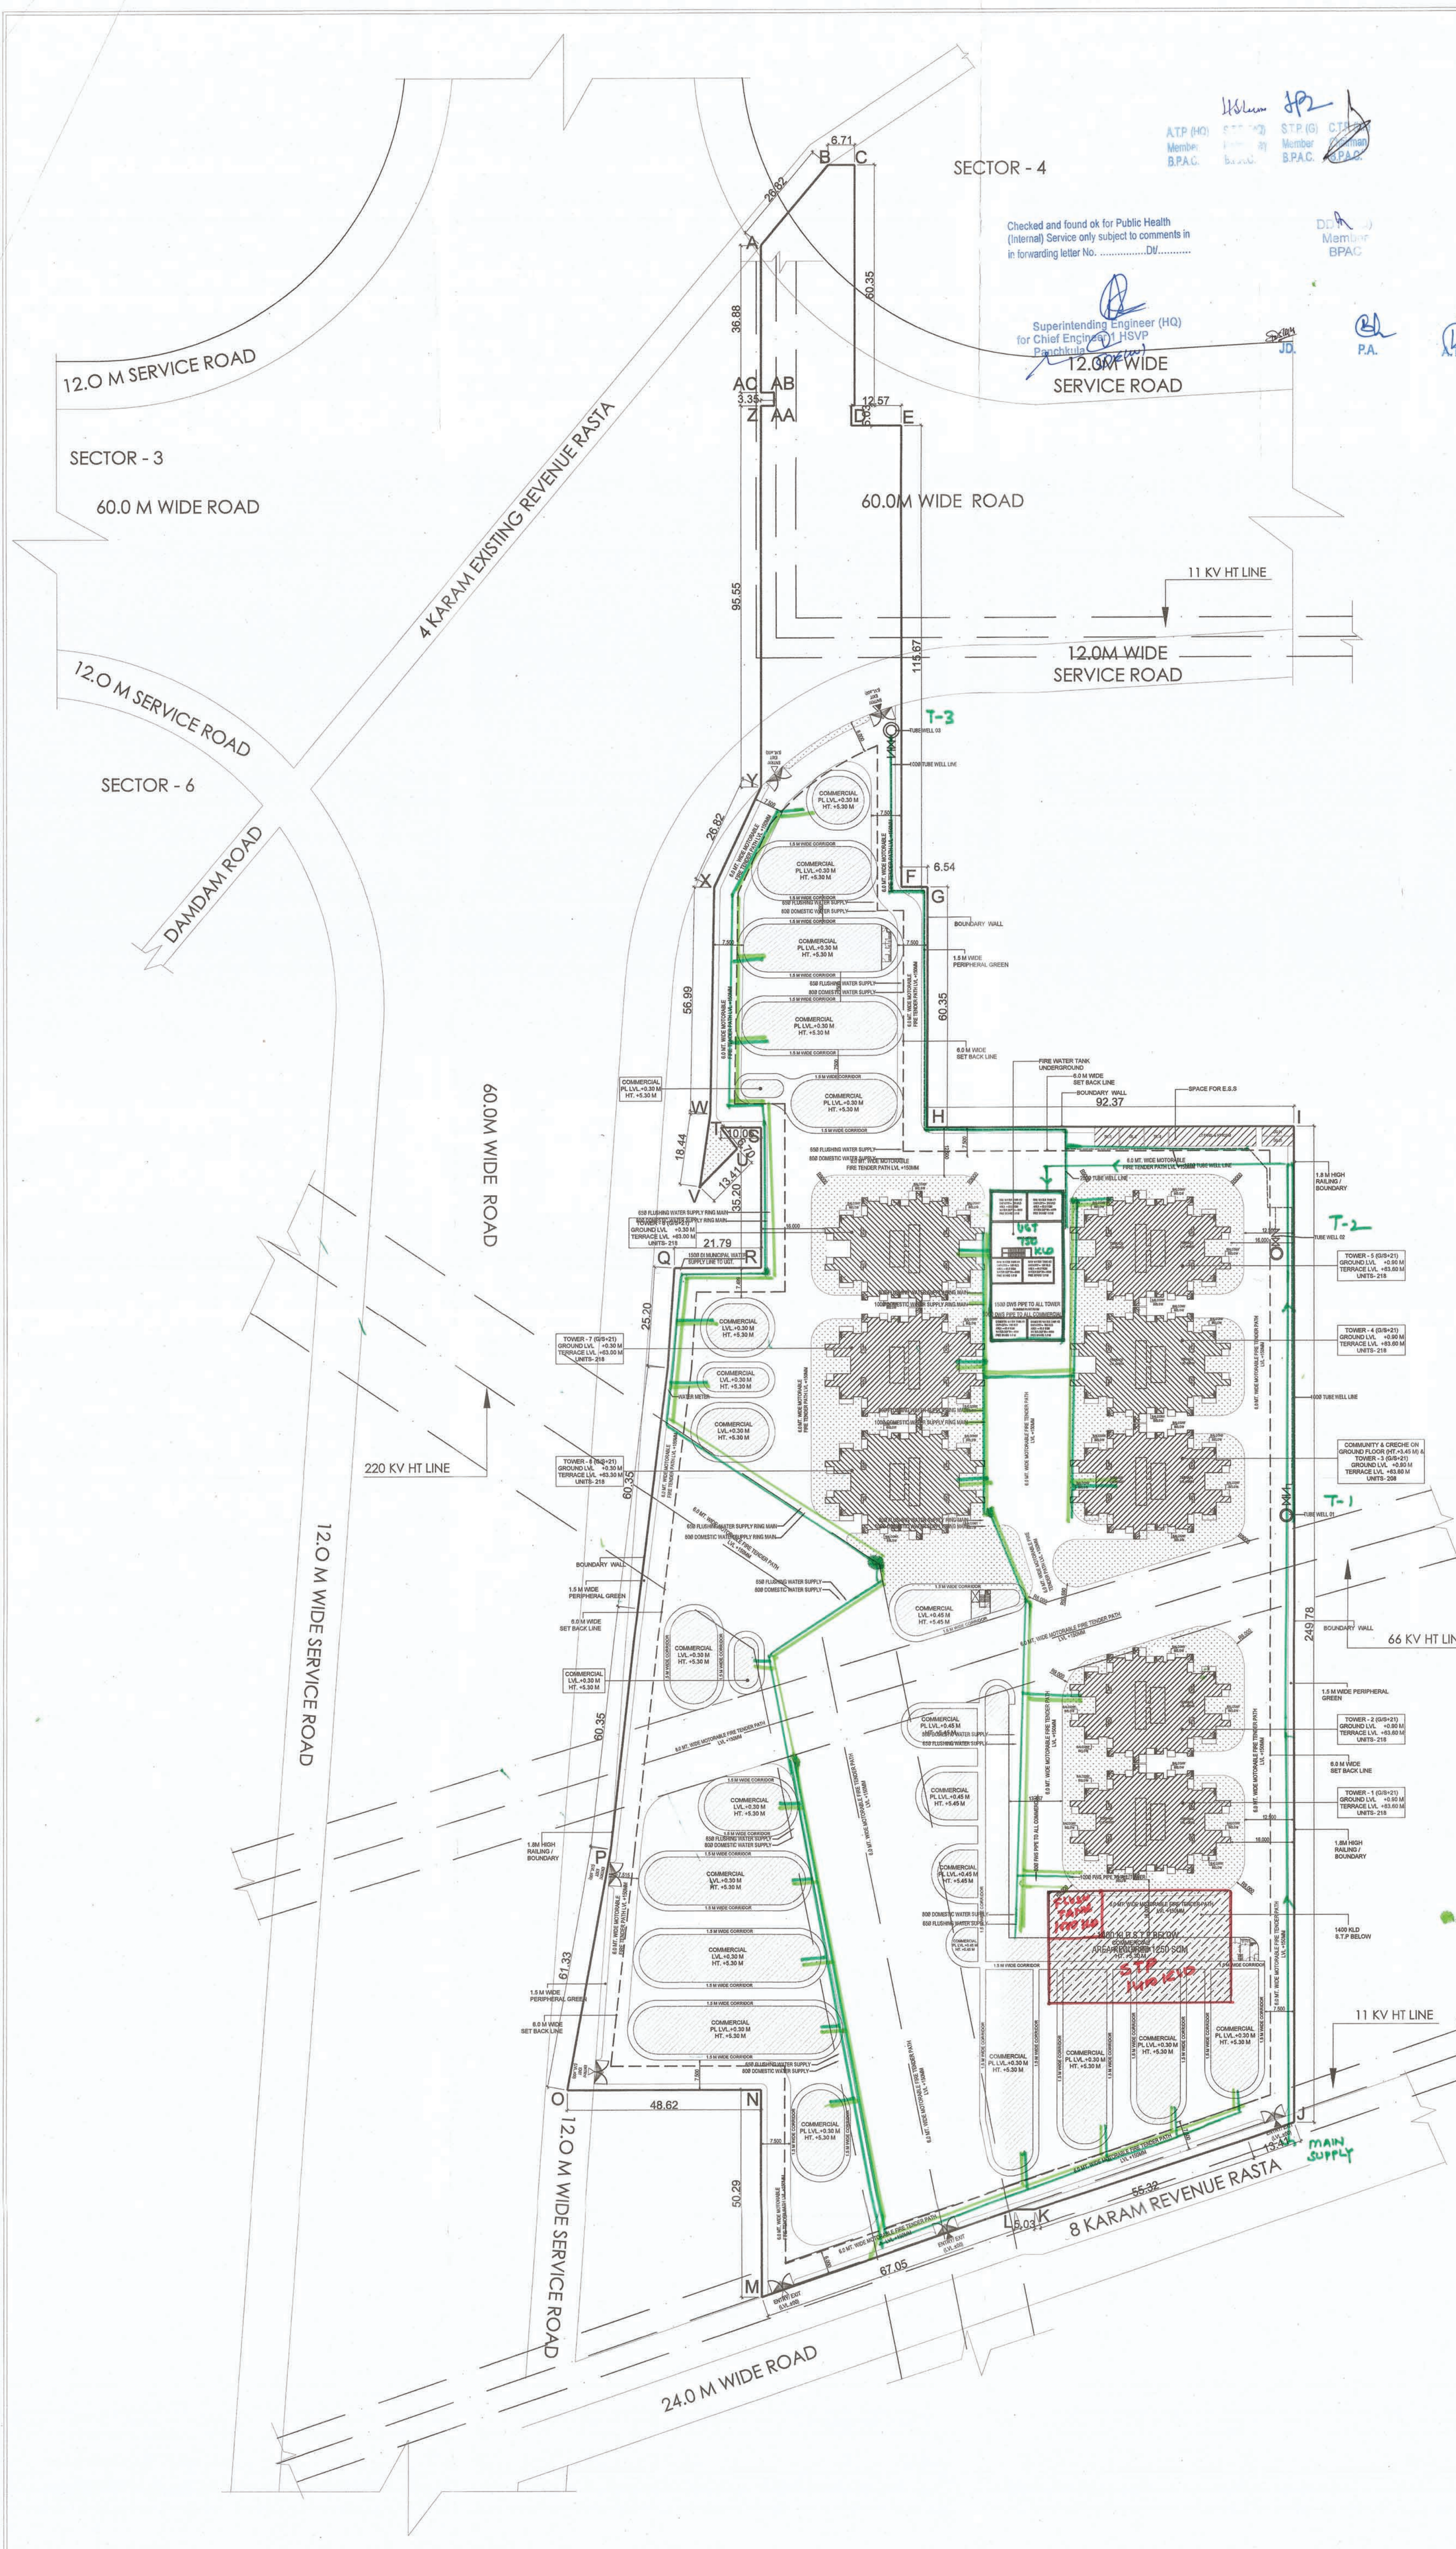

PLUMBING & FIRE SERVICES LEGEND:	
	SEWER MANHOLE WITH 500 S.F.R.C. MANHOLE COVER.
	STORM WATER MANHOLE WITH 500 S.F.R.C. PERFORATED MANHOLE COVER.
	CATCH BASIN (450 x 450) MM WITH PERFORATED MANHOLE COVER.
	CATCH BASIN (600 x 600) MM WITH PERFORATED MANHOLE COVER.
	STORM WATER MANHOLE (600 x 600) MM WITH PERFORATED MANHOLE COVER.
	SEWER MANHOLE (600 x 600) MM.
	SEWER MANHOLE (800 x 800) MM.
	GULLY TRAP (300 x 300) MM.
	EXTERNAL SW SEWER LINE (DIA AS / DESIGN CHART).
	EXTERNAL RCC STORM WATER LINE (DIA AS / DESIGN CHART).
	1500 DI MUNICIPAL WATER SUPPLY LINE.
	GI DOMESTIC WATER SUPPLY LINE.
	GI FLUSHING WATER SUPPLY LINE.
	HDPE GARDEN IRRIGATION WATER SUPPLY LINE.
	GARDEN HYDRANT WITH CHAMBER (300x300) MM.
	RECHARGE PIT, 3000 MM DIA.
	DESILTING CHAMBER (1000 x 2000)MM.
	4 WAY FIRE BRIGADE INLET CONNECTION FOR FIRE TANK PIPE DIA 1500.
	2 WAY FIRE BRIGADE WITHDRAWAL CONNECTION FROM FIRE TANK PIPE DIA 1500.

Checked and found ok for Public Health (Internal) Service only subject to comments in forwarding letter No.

Superintending Engineer (HQ) for Chief Engineer, H.S.V.P. Panchkula

Member BPAC

P.A.

PROJECT TITLE
PROPOSED BUILDING PLAN OF AFFORDABLE GROUP HOUSING COLONY FOR AN AREA MEASURING 12.8847 ACRES (LICENSE NO. 189 OF 2022 DATED 16/11/2022) IN SECTOR-5, SOHNA, DISTRICT GURUGRAM BEING DEVELOPED BY SRE INDIA AND DESI CONSTRUCTION PVT. LTD. IN COLLABORATION WITH DESI CONSTRUCTION PVT. LTD.
LC-4846

OWNERS' SIGNATURE

ARCHITECTS' SIGNATURE

Avanika Vaghishth
CA/2018/1670

DRAWING TITLE

SITE PLAN WITH
WATER SUPPLY LAYOUT

ARCHITECT		NORTH	
GANGA REALTY - DESIGN TEAM			
GANGA REALTY Vatika Tower, Golf Course Road Gurgaon, Haryana			
DATE	NOVEMBER, 2022	DWG. NO.	PL-103
SCALE	1:1000		
DEALT	AN		
CHECKED	NKM		