



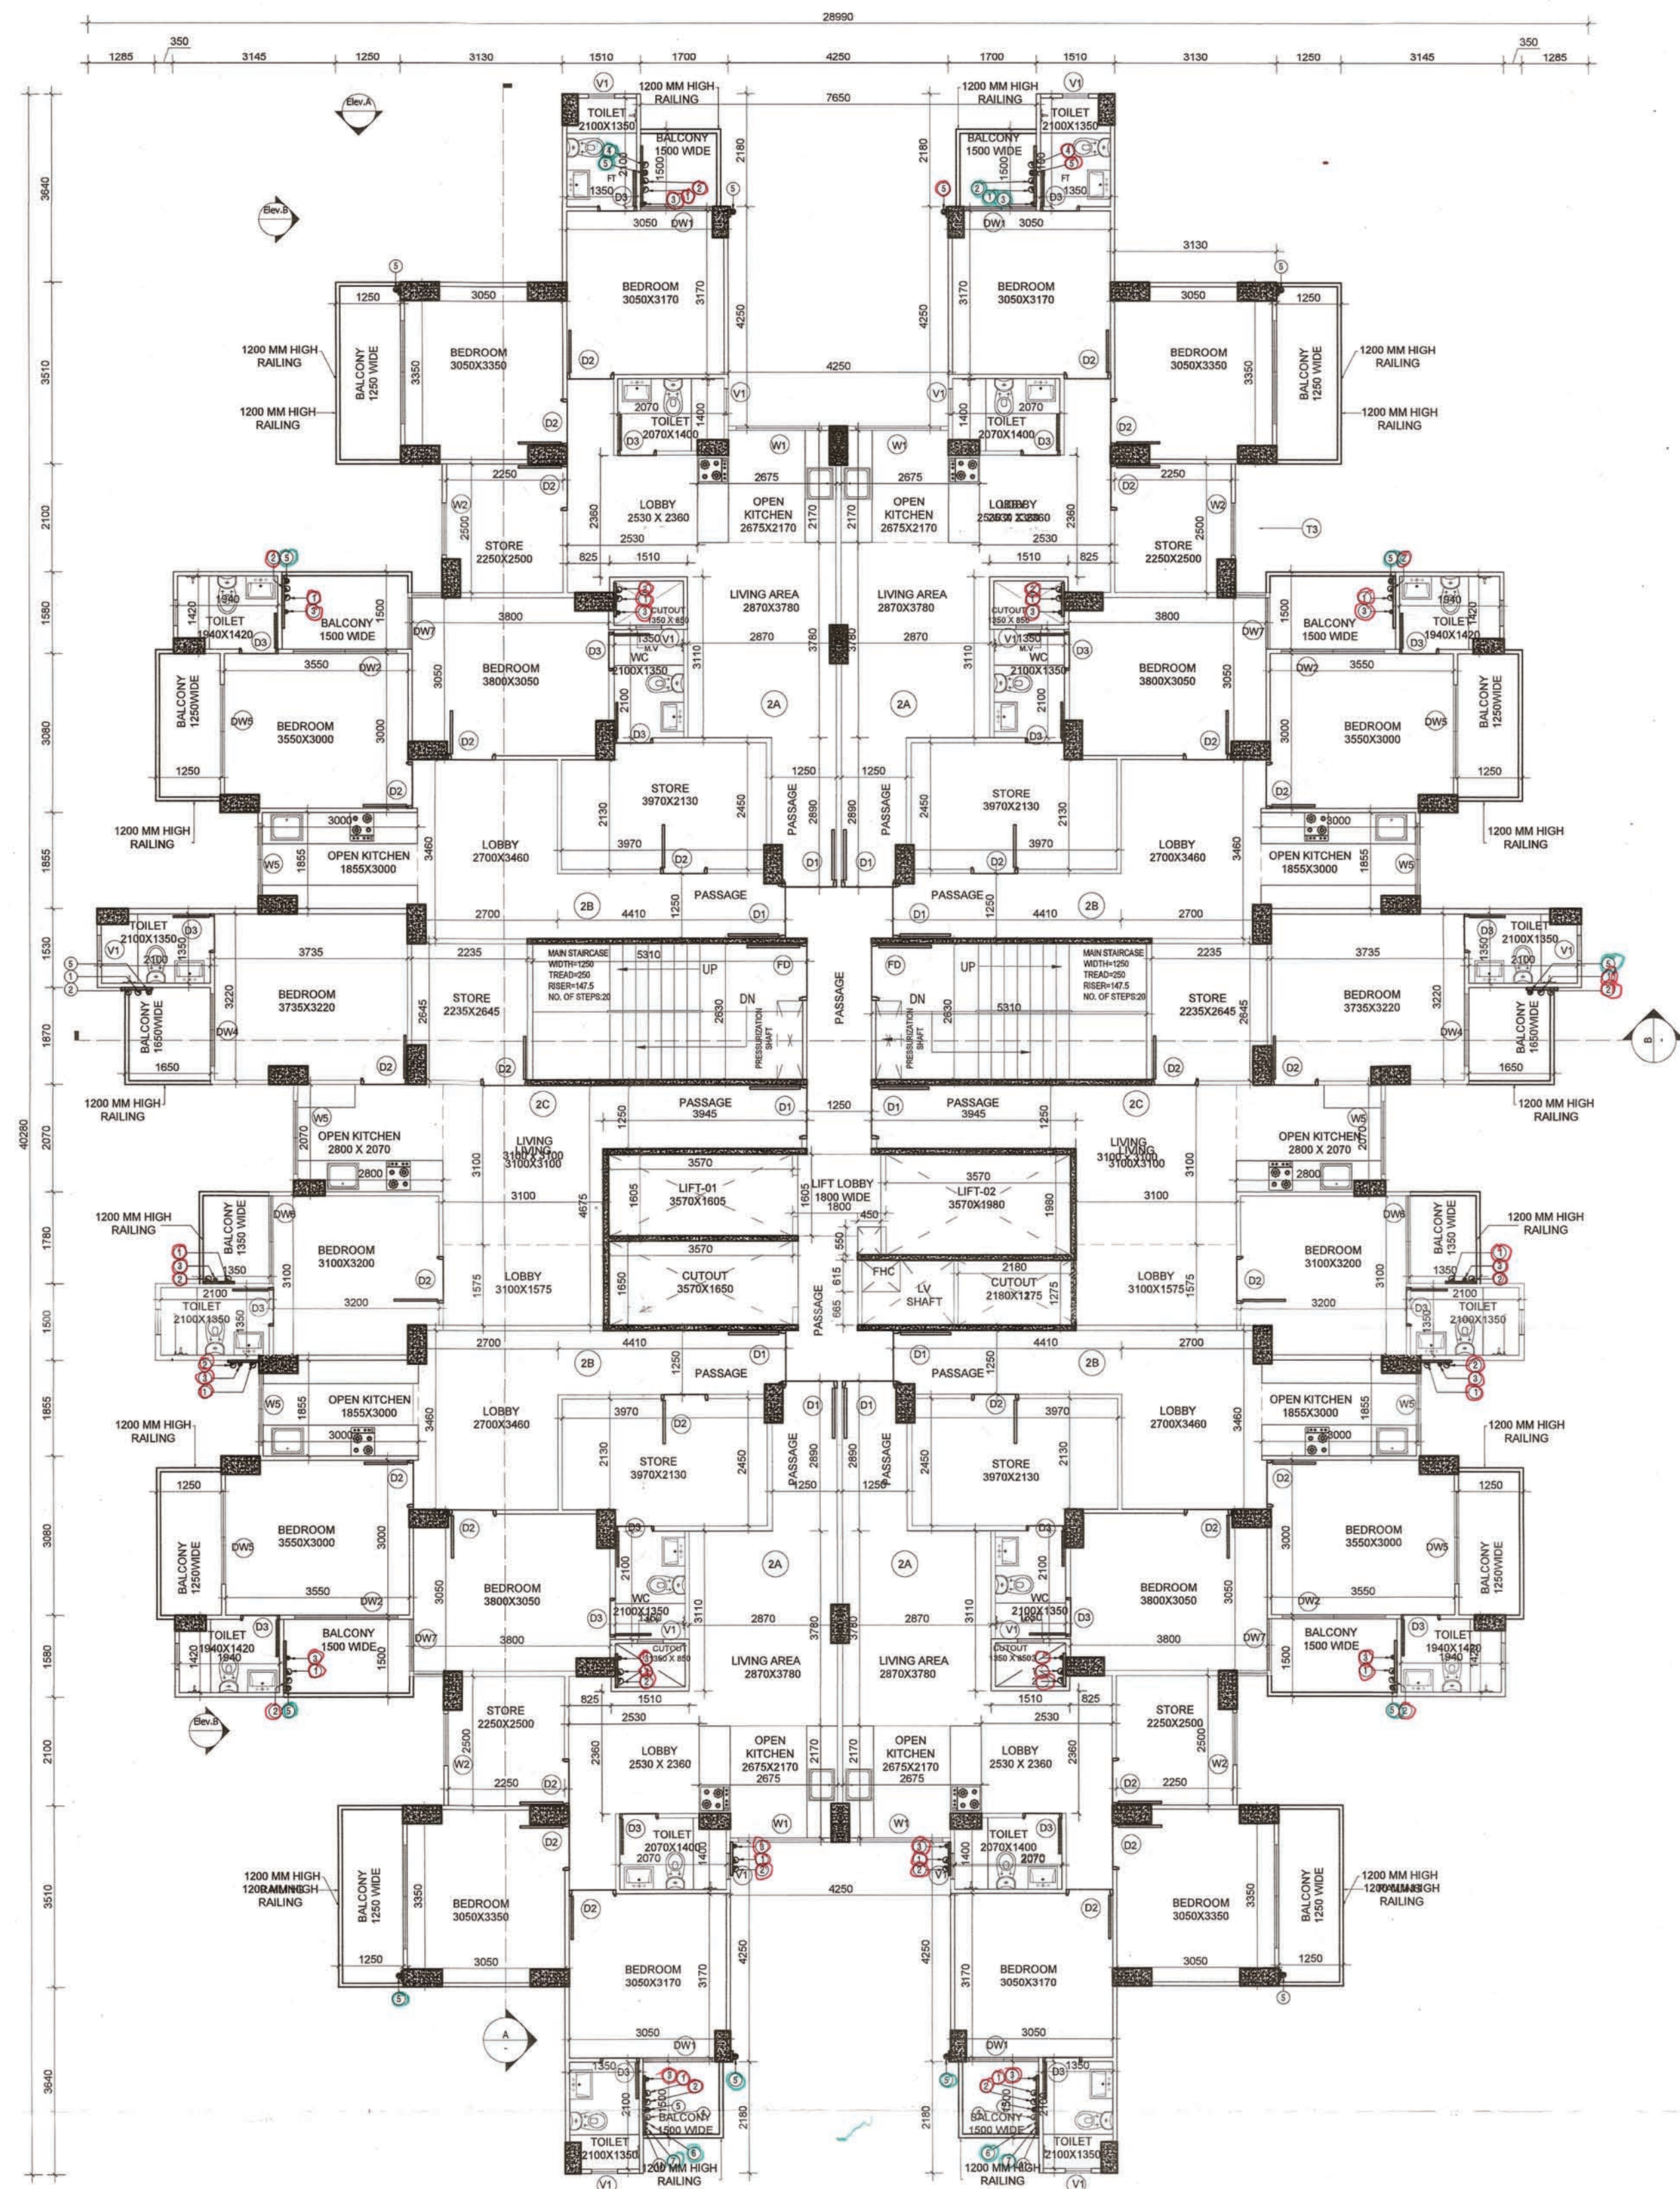

1 1ST-20TH FLOOR PLAN - TOWER 03

NAME	WIDTH (MM)	HEIGHT (MM)	NO.s	AREA (SQ. M)
1	3130	X	4	43.945
2	1510	X	4	43.186
3	1700	X	4	33.796
4	4250	X	2	6.120
5	15330	X	2	76.650
6	16660	X	2	36.652
7	21520	X	2	136.006
8	2180	X	4	13.778
9	1200	X	4	14.784
10	22450	X	1	41.645
11	28660	X	1	43.850
12	24320	X	1	45.478
13	21110	X	1	43.698
14	22052	X	1	50.279
15	22052	X	1	22.052
16	22460	X	1	41.663
17	2200	X	2	6.600
TO TAL				700.182

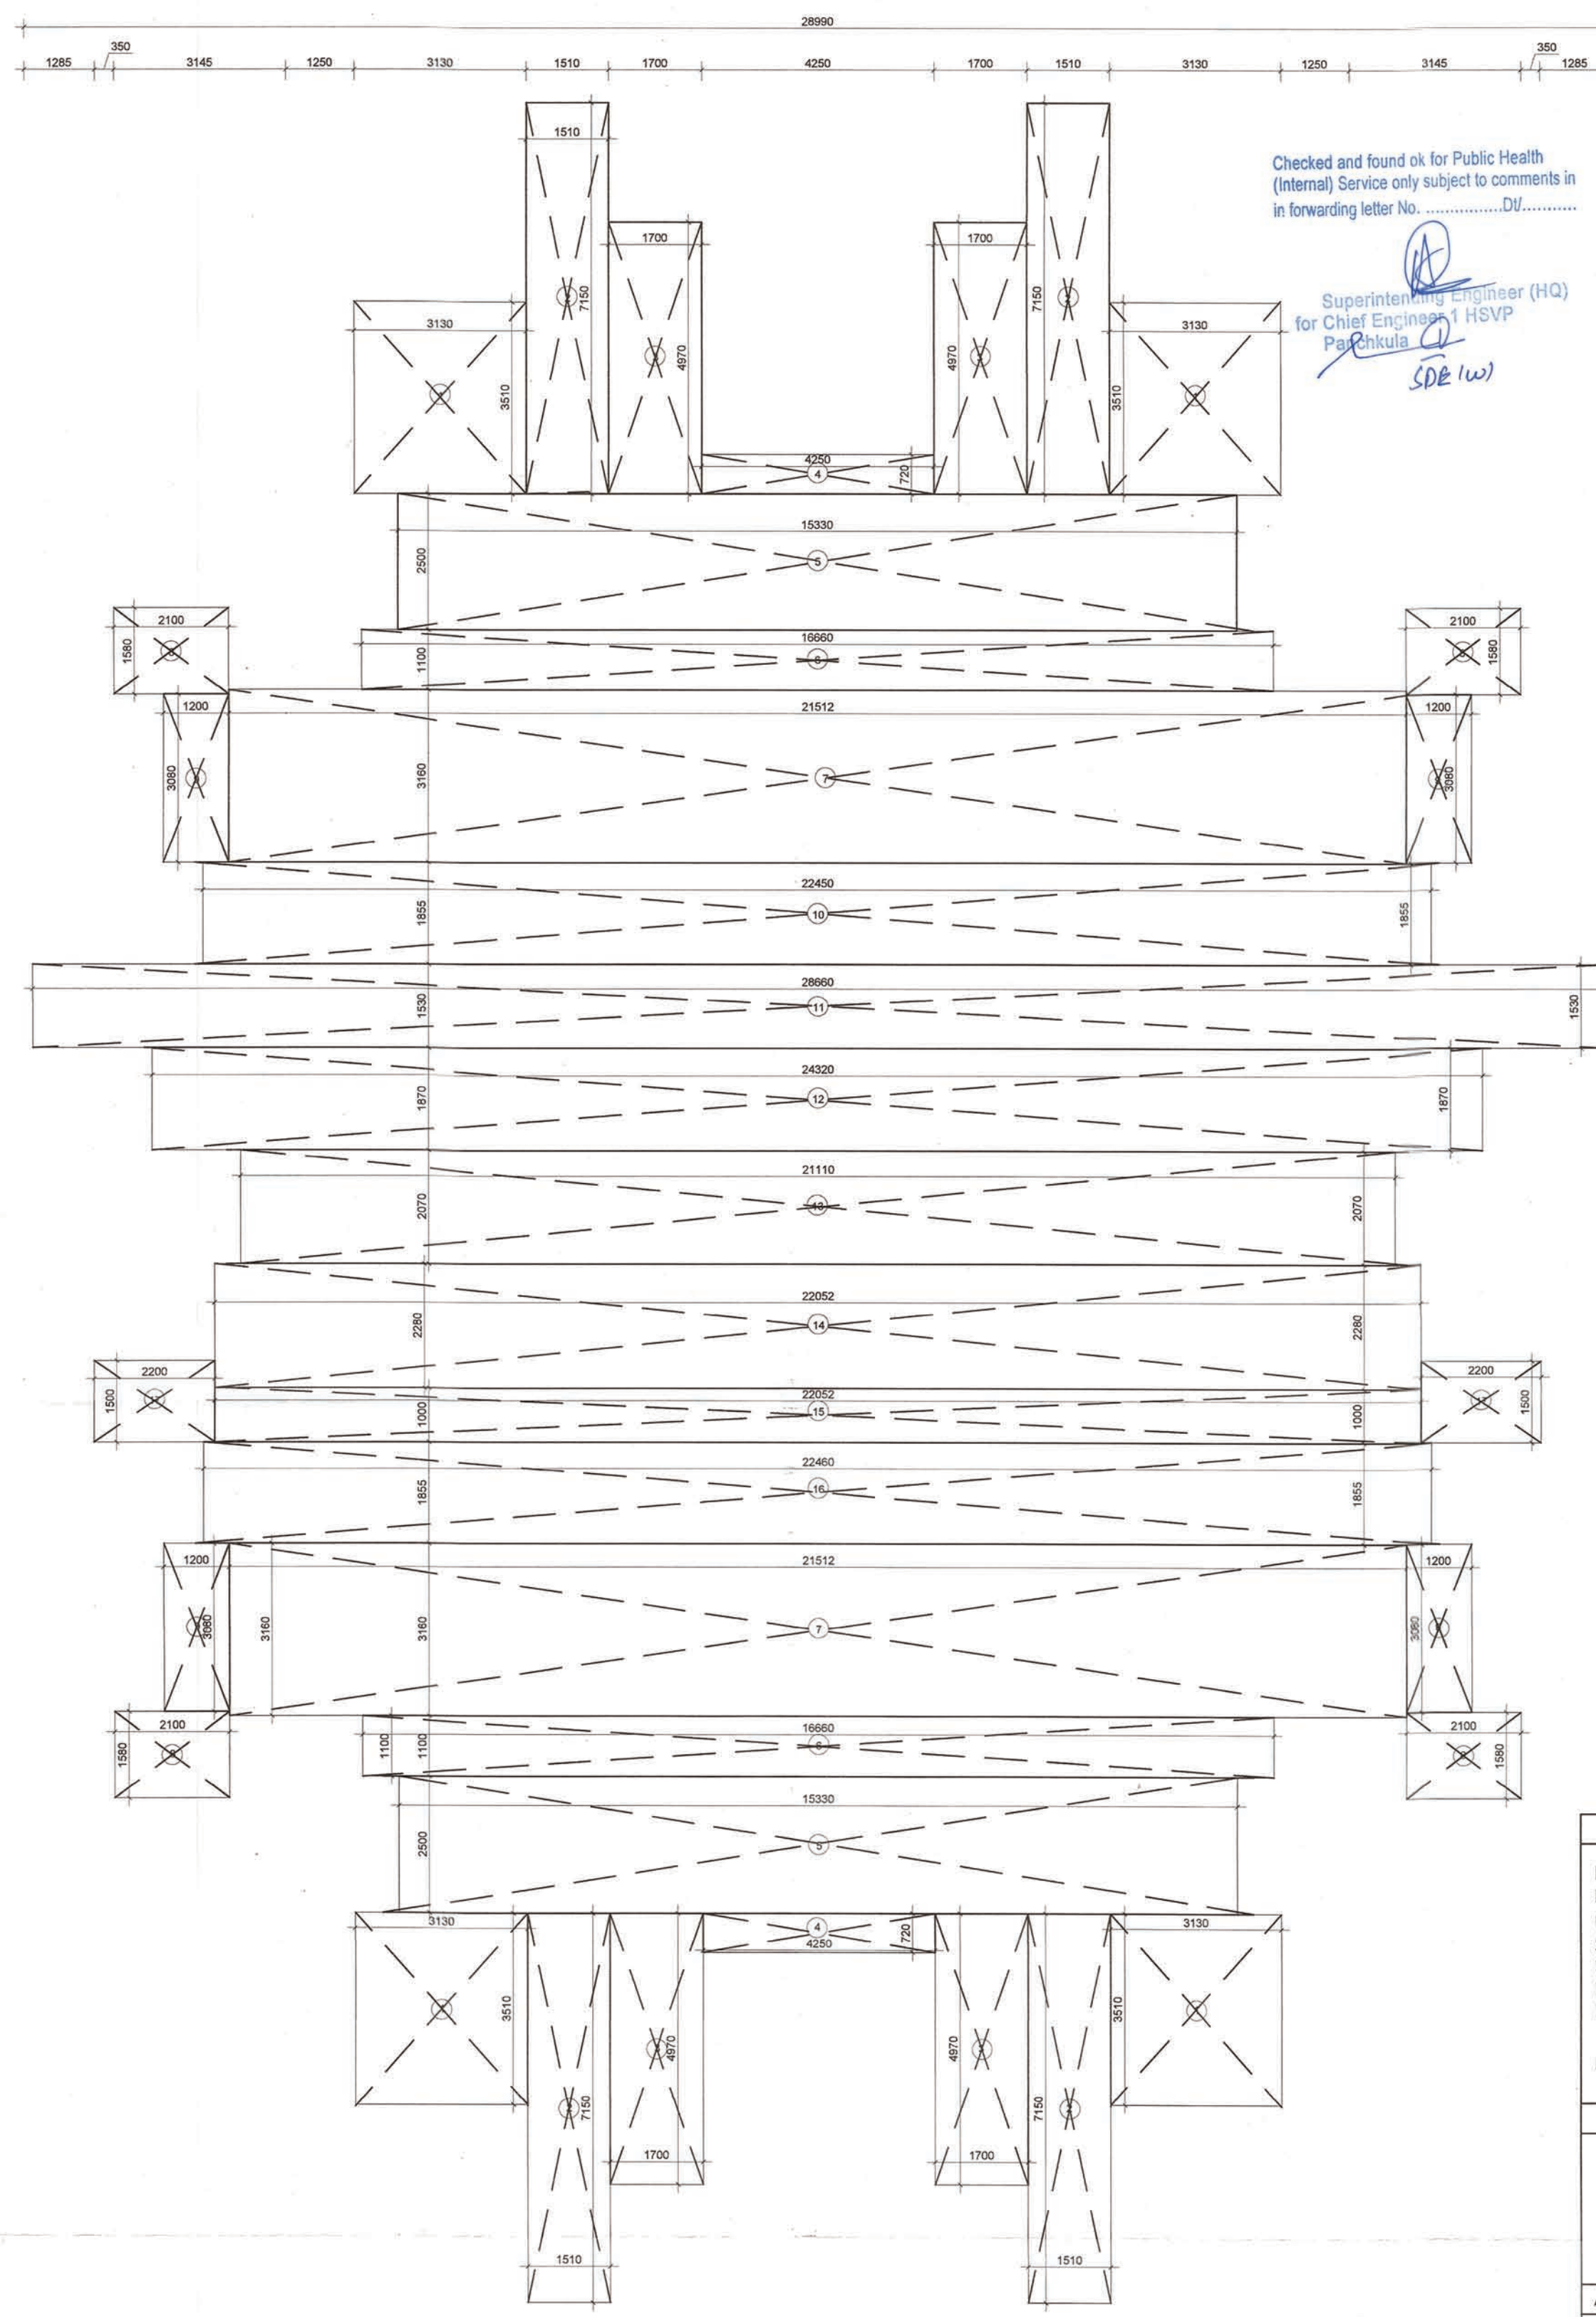

2 1ST-20TH FLOOR AREA DETAIL - TOWER 03

1	110 OD SWR PVC SOIL & VENT PIPE
2	110 OD SWR PVC WASTE & VENT PIPE
3	110 OD SWR PVC ANTI-SYPHONIC PIPE
4	500 CWS RISER TO O.H.T. FILLING TANK
5	500 FWS RISER TO O.H.T. FILLING TANK
6	DOMESTIC WATER SUPPLY DN. TAKE PIPE
7	FLUSHING WATER SUPPLY DN. TAKE PIPE
8	110 OD UPVC RAIN WATER PIPE (TERRACE)
9	110 OD UPVC RAIN WATER PIPE (BALCONY)

80/20	FIRE HOSE CABINET
9 L	WATER GAS PRESSURE TYPE FIRE EXTINGUISHER
4.5 kg	CO2 TYPE FIRE EXTINGUISHER
1	BUTTERFLY VALVE / SLUICE VALVE

EACH FIRE HOSE CABINET SHALL CONSIST OF:	
1 No.	- GUNMETAL SINGLE HEADED HYDRANT VALVE (63mm).
2 Nos.	- FIRE HOSES 63mm 15M LONG WITH ACCESSORIES.
1 No.	- SHORT BRANCH
1 No.	- FIRST AID HOSE REEL
2 Nos.	- FIRE EXTINGUISHERS
1 No.	- FIRE MAN'S AXE.

NOTE: D1 (1 HOUR FIRE RATED DOOR)

1	110 OD SWR PVC SOIL & VENT PIPE
2	110 OD SWR PVC WASTE & VENT PIPE
3	110 OD SWR PVC ANTI-SYPHONIC PIPE
4	500 CWS RISER TO O.H.T. FILLING TANK
5	500 FWS RISER TO O.H.T. FILLING TANK
6	DOMESTIC WATER SUPPLY DN. TAKE PIPE
7	FLUSHING WATER SUPPLY DN. TAKE PIPE
8	110 OD UPVC RAIN WATER PIPE (TERRACE)
9	110 OD UPVC RAIN WATER PIPE (BALCONY)

80/20	FIRE HOSE CABINET
9 L	WATER GAS PRESSURE TYPE FIRE EXTINGUISHER
4.5 kg	CO2 TYPE FIRE EXTINGUISHER
1	BUTTERFLY VALVE / SLUICE VALVE

EACH FIRE HOSE CABINET SHALL CONSIST OF:	
1 No.	- GUNMETAL SINGLE HEADED HYDRANT VALVE (63mm).
2 Nos.	- FIRE HOSES 63mm 15M LONG WITH ACCESSORIES.
1 No.	- SHORT BRANCH
1 No.	- FIRST AID HOSE REEL
2 Nos.	- FIRE EXTINGUISHERS
1 No.	- FIRE MAN'S AXE.

S. No.	TYPE	WIDTH (MM)	CILL (MM)	INTEL (MM)	HEIGHT (MM)
1	D1	1050	±0.0	+2300 (BOB)	2300
2	D2	900	±0.0	+2100	2100
3	D3	750	±0.0	+2100	2100
4	DW1	1350	±0.0	+2300 (BOB)	2300
5	DW2	2000	±0.0	+2300 (BOB)	2300
6	DW4	1400	±0.0	+2300 (BOB)	2300
7	DW5	1400	±0.0	+2300 (BOB)	2300
8	DW6	1700	±0.0	+2300 (BOB)	2300
9	DW7	1585	±0.0	+2300 (BOB)	2300
10	W1	1650	+1000	+2300 (BOB)	1300
11	W2	1000	+1000	+2300 (BOB)	1300
12	W3	900	+1000	+2300 (BOB)	1300
13	W4	1880	+1000	+2300 (BOB)	1300
14	W5	1400	+1000	+2300 (BOB)	1300
15	V1	500	+1350	+2100	750
16	V2	900	+1350	+2100	750
17	FD	1100	±0.0	+2300 (BOB)	2300

PROJECT TITLE

PROPOSED BUILDING PLANS OF AFFORDABLE GROUP HOUSING COLONY OVER AN AREA MEASURING 8.975 ACRES (LICENSE NO. 188 OF 2022 DATED 16.11.2022) IN SECTOR-5, SOHNA, DISTRICT GURUGRAM BEING DEVELOPED BY URBANEST BUILDCON LLP AND DESI CONSTRUCTION PVT.LTD. IN COLLABORATION WITH DESI CONSTRUCTION PVT.LTD.

LC-4845

OWNERS' SIGNATURE

ARCHITECTS' SIGNATURE

DRAWING TITLE

LAYOUT TOWER - 03

1ST -20TH FLOOR PLAN AND AREA DETAIL

ARCHITECT	NORTH	
GANGA REALTY - DESIGN TEAM		
GANGA REALTY Vastu Tower, Golf Course Road Gurgaon, Haryana		
DATE	DECEMBER, 2022	DWG. NO.
SCALE	1:100	S - 117
DEALT	AV	
CHECKED	NKM	