


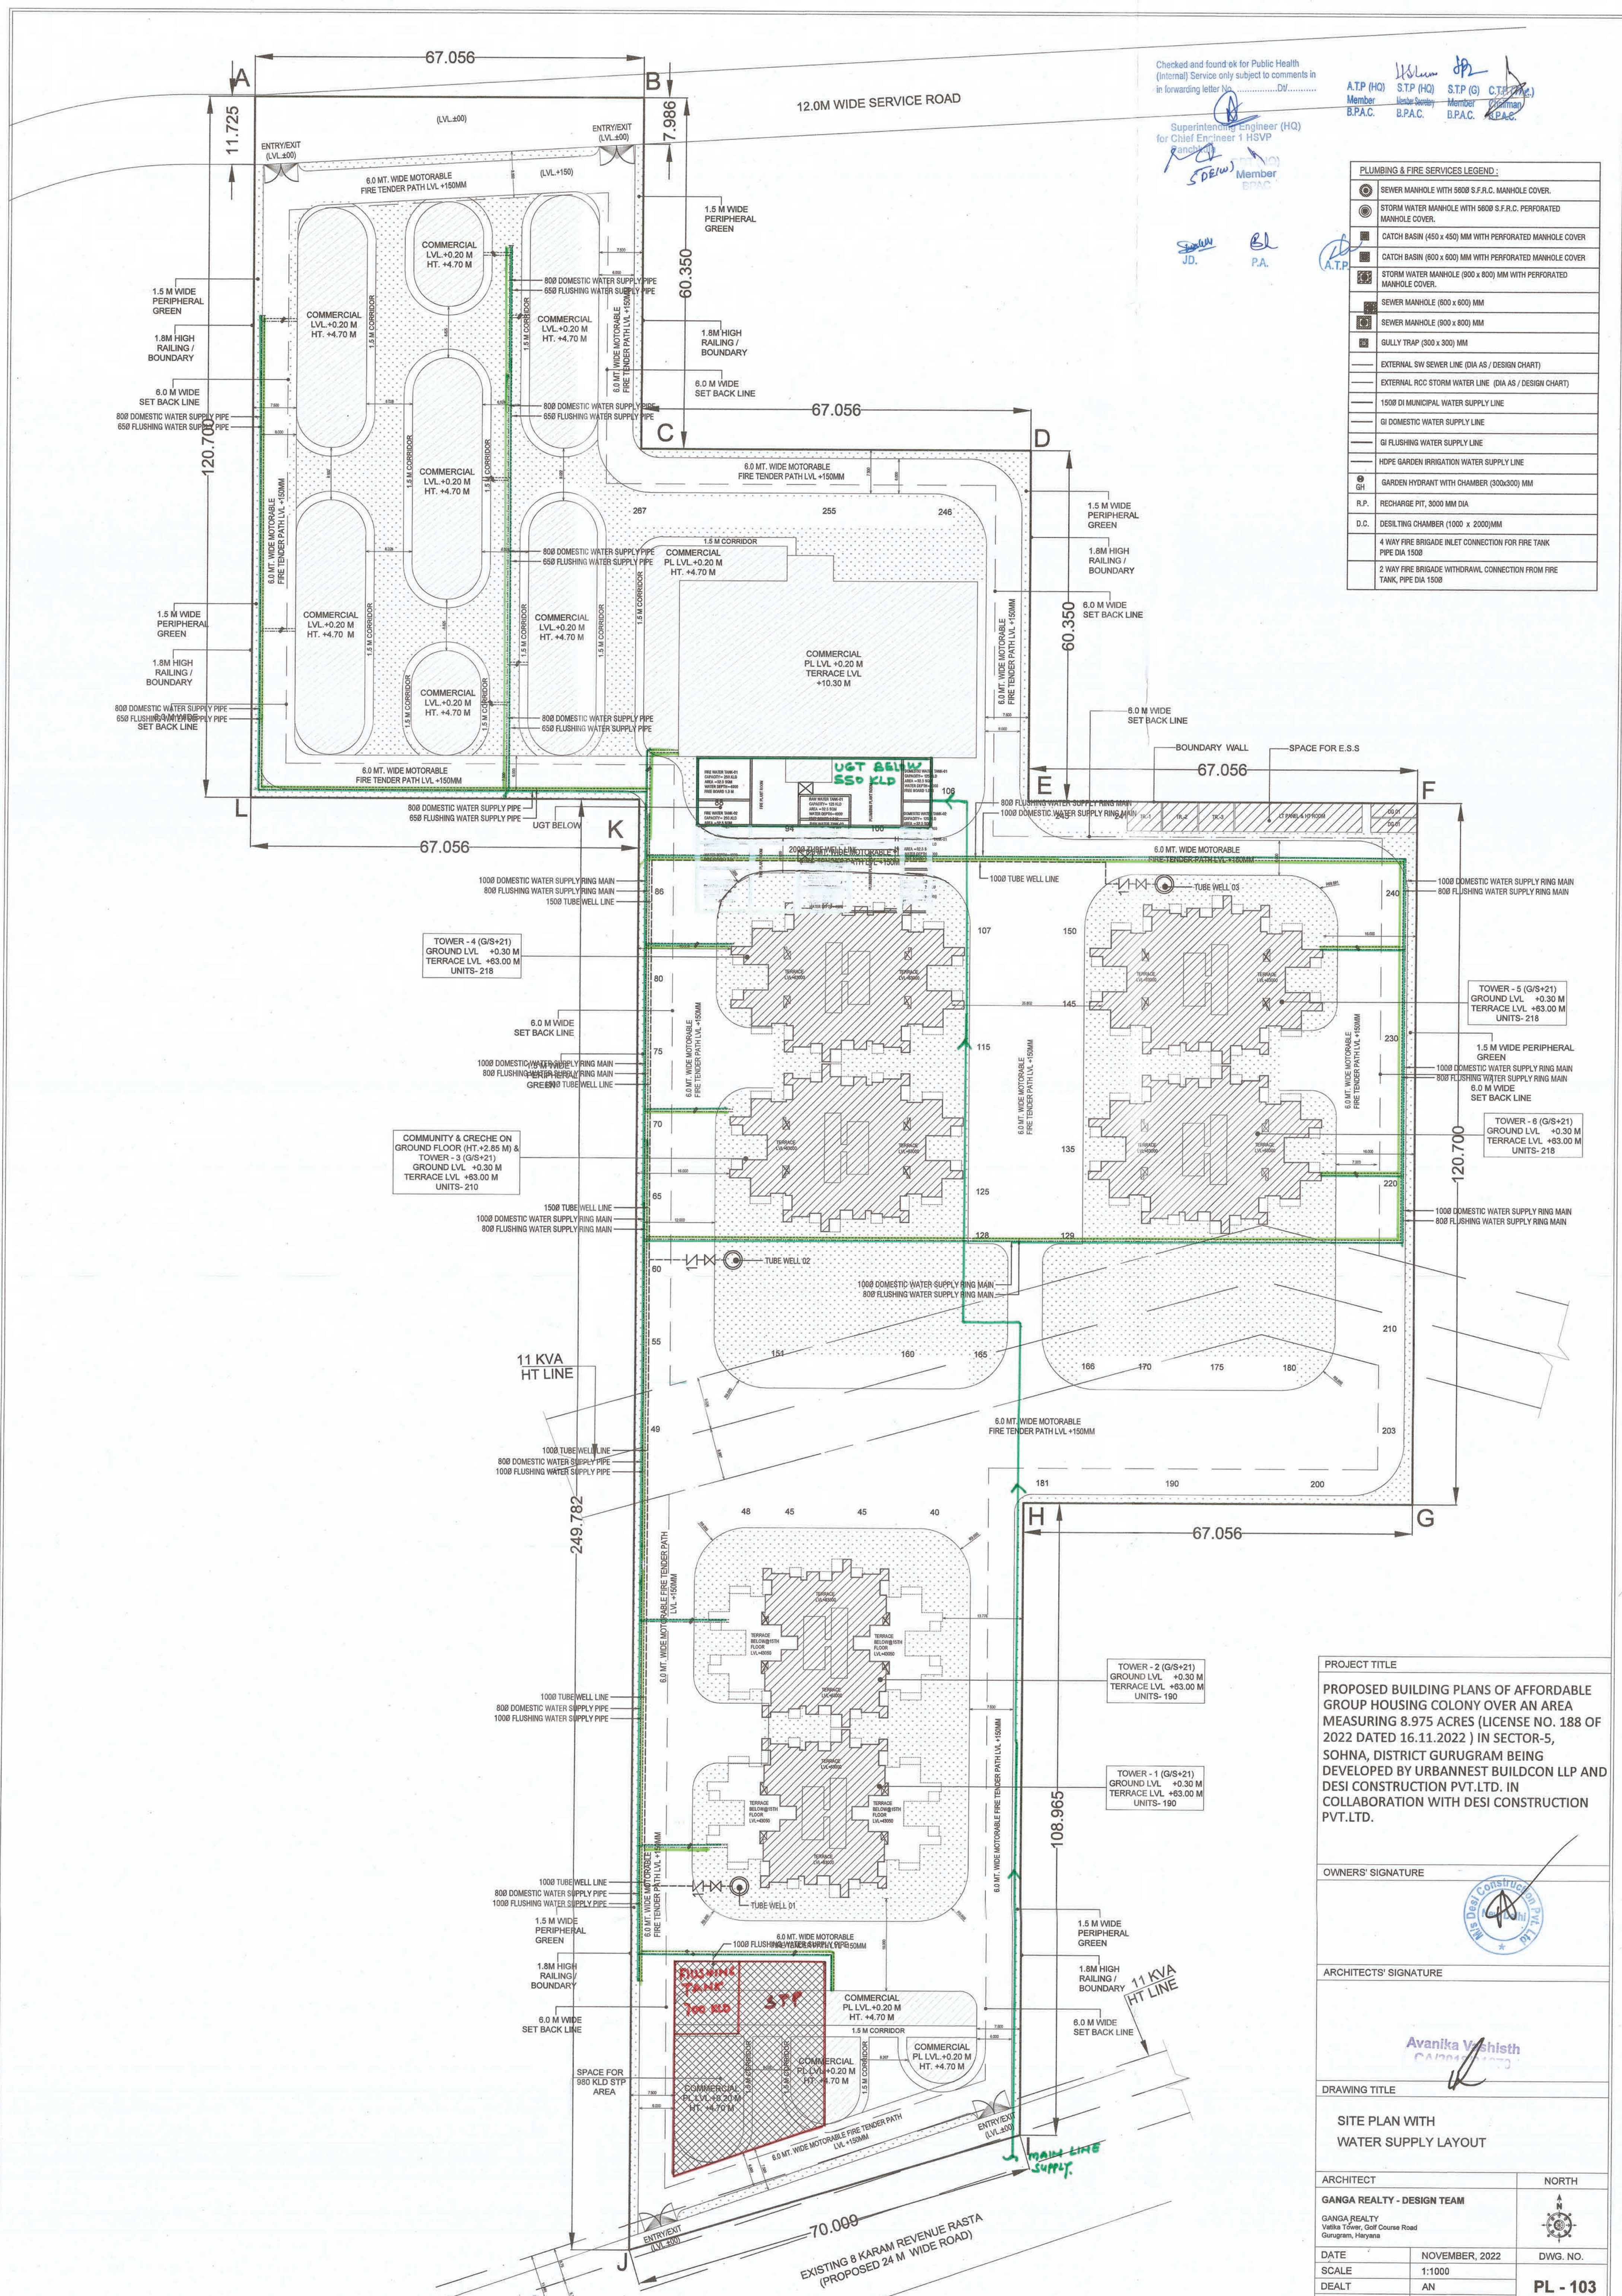

Checked and found ok for Public Health
(Internal Service only subject to comments in
in forwarding letter No.DV.....

Superintending Engineer (HQ)
for Chief Engineer 1 HSVP
Ranchi

Member
B.P.A.C.

Member
B.P.A.C.

Member
B.P.A.C.

Member
B.P.A.C.

PLUMBING & FIRE SERVICES LEGEND:	
	SEWER MANHOLE WITH 500 S.F.C. MANHOLE COVER.
	STORM WATER MANHOLE WITH 500 S.F.C. PERFORATED MANHOLE COVER.
	CATCH BASIN (450 x 450) MM WITH PERFORATED MANHOLE COVER.
	CATCH BASIN (600 x 600) MM WITH PERFORATED MANHOLE COVER.
	STORM WATER MANHOLE (900 x 900) MM WITH PERFORATED MANHOLE COVER.
	SEWER MANHOLE (600 x 600) MM.
	SEWER MANHOLE (900 x 900) MM.
	GULLY TRAP (300 x 300) MM.
	EXTERNAL SW SEWER LINE (DIA AS / DESIGN CHART).
	EXTERNAL RCC STORM WATER LINE (DIA AS / DESIGN CHART).
	1500 DI MUNICIPAL WATER SUPPLY LINE.
	GI DOMESTIC WATER SUPPLY LINE.
	GI FLUSHING WATER SUPPLY LINE.
	HDPE GARDEN IRRIGATION WATER SUPPLY LINE.
	GARDEN HYDRANT WITH CHAMBER (300x300) MM.
	RECHARGE PIT, 3000 MM DIA.
	DESILTING CHAMBER (1000 x 2000)MM.
	4 WAY FIRE BRIGADE INLET CONNECTION FOR FIRE TANK PIPE DIA 1500.
	2 WAY FIRE BRIGADE WITHDRAWAL CONNECTION FROM FIRE TANK, PIPE DIA 1500.

PROJECT TITLE	
PROPOSED BUILDING PLANS OF AFFORDABLE GROUP HOUSING COLONY OVER AN AREA MEASURING 8.975 ACRES (LICENSE NO. 188 OF 2022 DATED 16.11.2022) IN SECTOR-5, SOHNA, DISTRICT GURUGRAM BEING DEVELOPED BY URBANNEST BUILDCON LLP AND DESI CONSTRUCTION PVT.LTD. IN COLLABORATION WITH DESI CONSTRUCTION PVT.LTD.	
OWNERS' SIGNATURE	
ARCHITECTS' SIGNATURE	
DRAWING TITLE	
SITE PLAN WITH WATER SUPPLY LAYOUT	
ARCHITECT	NORTH
GANGA REALTY - DESIGN TEAM	
GANGA REALTY Vaikunth Tower, Golf Course Road Gurgaon, Haryana	
DATE	NOVEMBER, 2022
SCALE	1:1000
DEALT	AN
CHECKED	NKM
DWG. NO.	
PL - 103	