



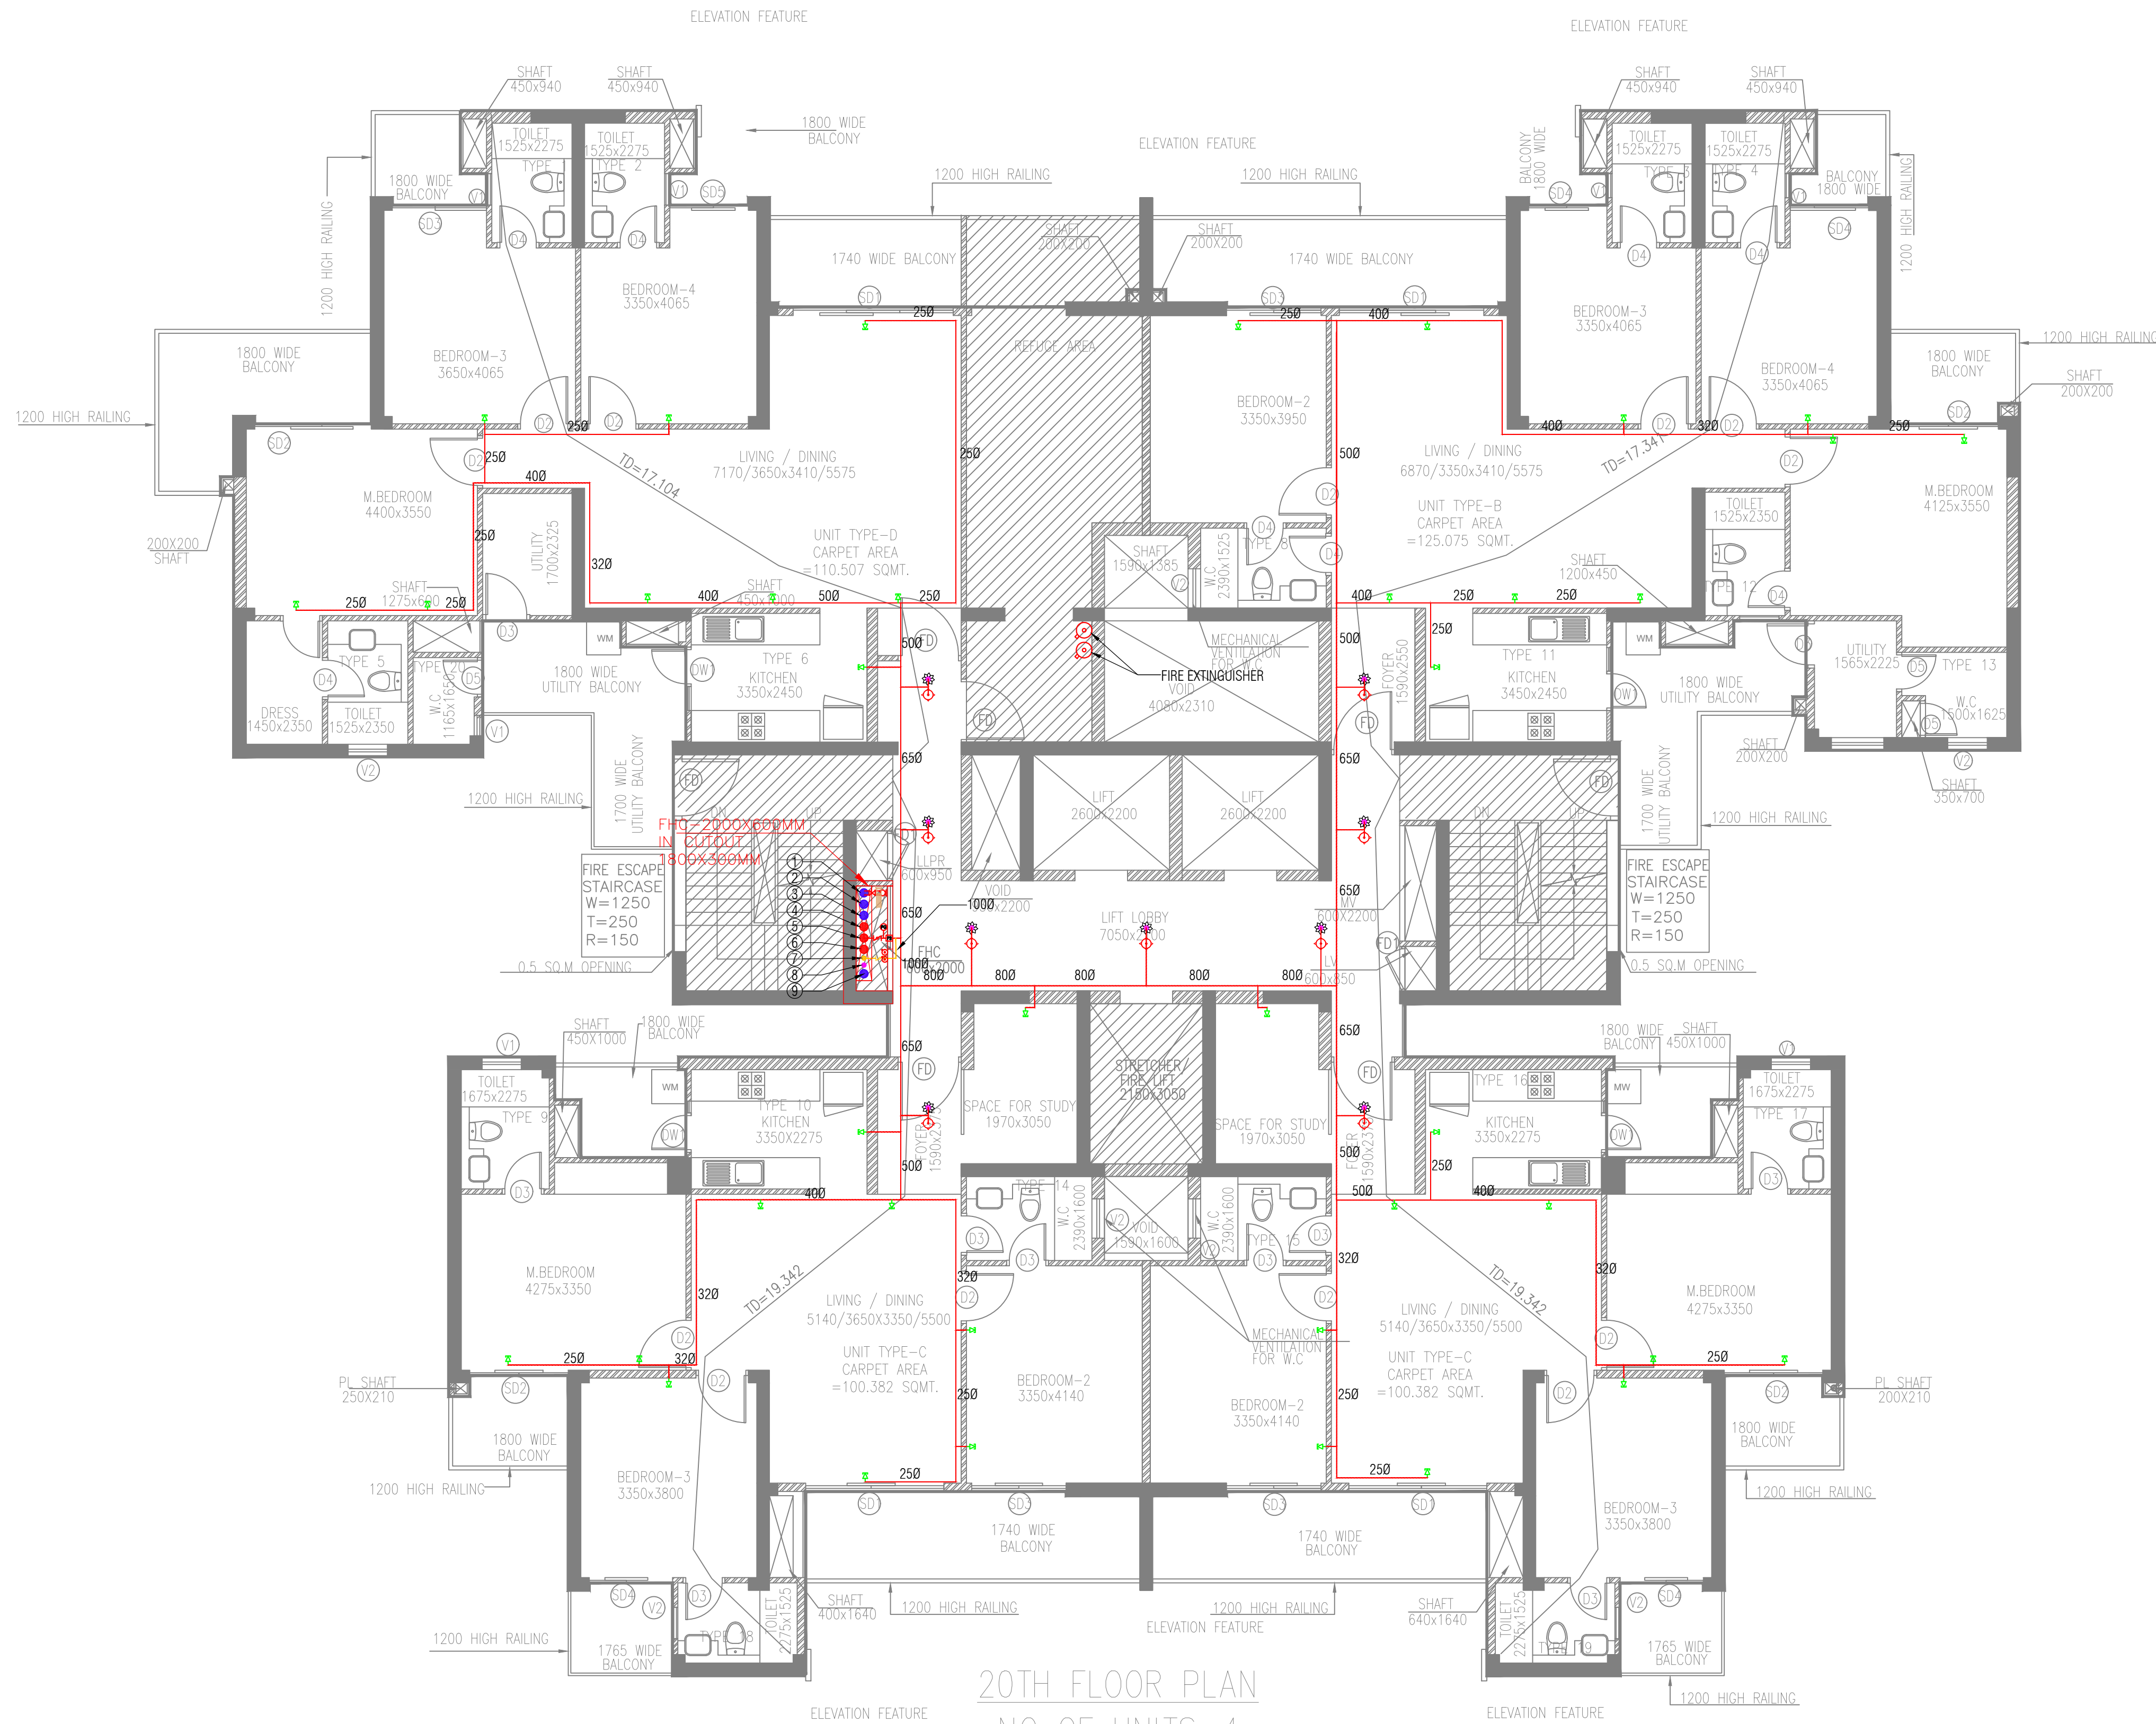

20TH FLOOR PLAN  
NO OF UNITS=4  
LVL+62000  
TOWER-1 & 2

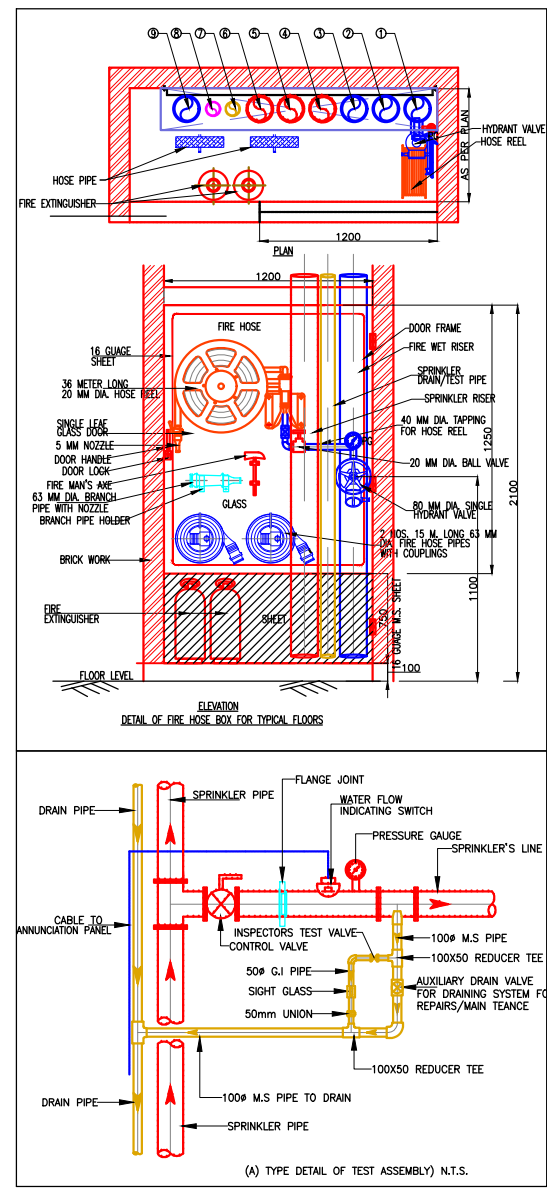

| LEGEND |        |                                                                            |
|--------|--------|----------------------------------------------------------------------------|
| Sl.No. | SYMBOL | DESCRIPTION                                                                |
| 1      |        | SPRINKLER (ABOVE FALSE CEILING)                                            |
| 2      |        | SPRINKLER (BELOW FALSE CEILING)                                            |
| 3      |        | EXTENDED SIDE WALL SPRINKLER                                               |
| 4      |        | SPRINKLER HEADER PIPE ABOVE GROUND PIPING                                  |
| 5      |        | BUTTERFLY VALVE                                                            |
| 6      |        | SPRINKLER DRAIN PIPE                                                       |
| 7      |        | FHC DRAIN PIPE                                                             |
| 8      |        | FLOW SWITCH                                                                |
| 9      |        | INTERNAL SINGLE HEADED HYDRANT & HOSE REEL ASSEMBLY                        |
| 10     |        | 2 X 2 NOS. OF 9 LITRES CAPACITY ROUND BOTTOM SAND BUCKETS ALONG WITH STAND |
| 11     |        | PRESSURE GAUGE                                                             |
| 12     |        | BUTTERFLY VALVE                                                            |
| 13     |        | NON RETURN VALVE                                                           |
| 14     |        | STRAINER VALVE                                                             |

| FIRE FIGHTING LEGEND:- |                                                    |
|------------------------|----------------------------------------------------|
| ①                      | 150Ø FIRE HYDRANT PIPE STILT TO 9TH FLOOR ZONE-1   |
| ②                      | 150Ø FIRE HYDRANT PIPE 10TH TO 20TH FLOOR ZONE-2   |
| ③                      | 150Ø FIRE HYDRANT PIPE 21TH TO 28TH FLOOR ZONE-3   |
| ④                      | 150Ø FIRE SPRINKLER PIPE STILT TO 9TH FLOOR ZONE-1 |
| ⑤                      | 150Ø FIRE SPRINKLER PIPE 10TH TO 20TH FLOOR ZONE-2 |
| ⑥                      | 150Ø FIRE SPRINKLER PIPE 21TH TO 28TH FLOOR ZONE-3 |
| ⑦                      | 100Ø SPRINKLER DRAIN PIPE                          |
| ⑧                      | 100Ø FHC DRAIN PIPE                                |
| ⑨                      | 150Ø HYDRANT PIPE FROM TERRACE TANK                |

|                                     |
|-------------------------------------|
| KITCHEN SPRINKLER TEMPERATURE IN 79 |
| NORMAL SPRINKLER TEMPERATURE IN 68  |

AMIT GUPTA  
Architect  
CA/2004/33147

DESIGN CENTRE CONSULTANTS  
ENGINEERS PVT. LTD.  
WARE: 10/10/2010/CONSULTANTS

- Note:-
- BUILDING HAS AUTOMATIC SPRINKLER SYSTEM WHEREVER REQUIRED BY NBC.
  - BUILDING WILL BE DESIGNED (STRUCTURES) AS PER RELEVANT IS CODES FOR EARTH QUAKE RESISTANCE.
  - 100% POWER BACKUP/ MECHANICAL VENTILATED SHAFTS.
  - SPRINKLER PIPE UP TO 50MMØ SHALL BE USED FOR cPVC PIPE.
  - SPRINKLER PIPE 65MMØ TO ABOVE SHALL BE USED FOR M.S C, CLASS PIPE.
  - THIS DRAWING IS MADE IN CONJUNCTION WITH RELEVANT ARCHITECTURAL. HUDA FIRE FIGHTING AND SUBMISSION DRAWINGS.

PROJECT:

PROPOSED BUILDING PLAN OF GROUP HOUSING COLONY (MIX LAND USE) UNDER TOD ZONE FOR(90% GH COMPONENT AND 10% COMMERCIAL COMPONENT) ON THE AREA MEASURING 15.99375 ACRES (LICENCE NO 213 OF 2022 DATED 27/12/22) IN REVENUE ESTATE OF VILLAGE CHAUMA, IN SECTOR 111 GURUGRAM HARYANA BEING DEVELOPED BY METRO EDUCATION AND WELFARE PVT. LTD

ARCHITECTS

ARCHITECT  
STUDIO SYMBIOSIS  
India | Germany | UK  
INDIA D-79, Sector 48, Delhi- NCR  
U.P. 201301, Noida  
TEL: +91 0120 4226979  
E-MAIL: info@studio-symbiosis.com  
www.studio-symbiosis.com

OWNER'S SEAL & SIGNATURE

ARCHITECT'S SEAL & SIGNATURE

SUBMISSION DRAWING:-

FIRE FIGHTING TOWER-1 & 2 (TYPE-A)

|                                                        |              |                  |
|--------------------------------------------------------|--------------|------------------|
| 27/01/2023                                             | Scale : 1:75 | REV NO. R1       |
| Drawing Title:-<br>FIRE FIGHTING LAYOUT FOR 20TH FLOOR |              |                  |
| Drawing No:-<br>M3M-111-245-T1&T2-FF-05                |              | SHEET SIZE<br>A1 |