


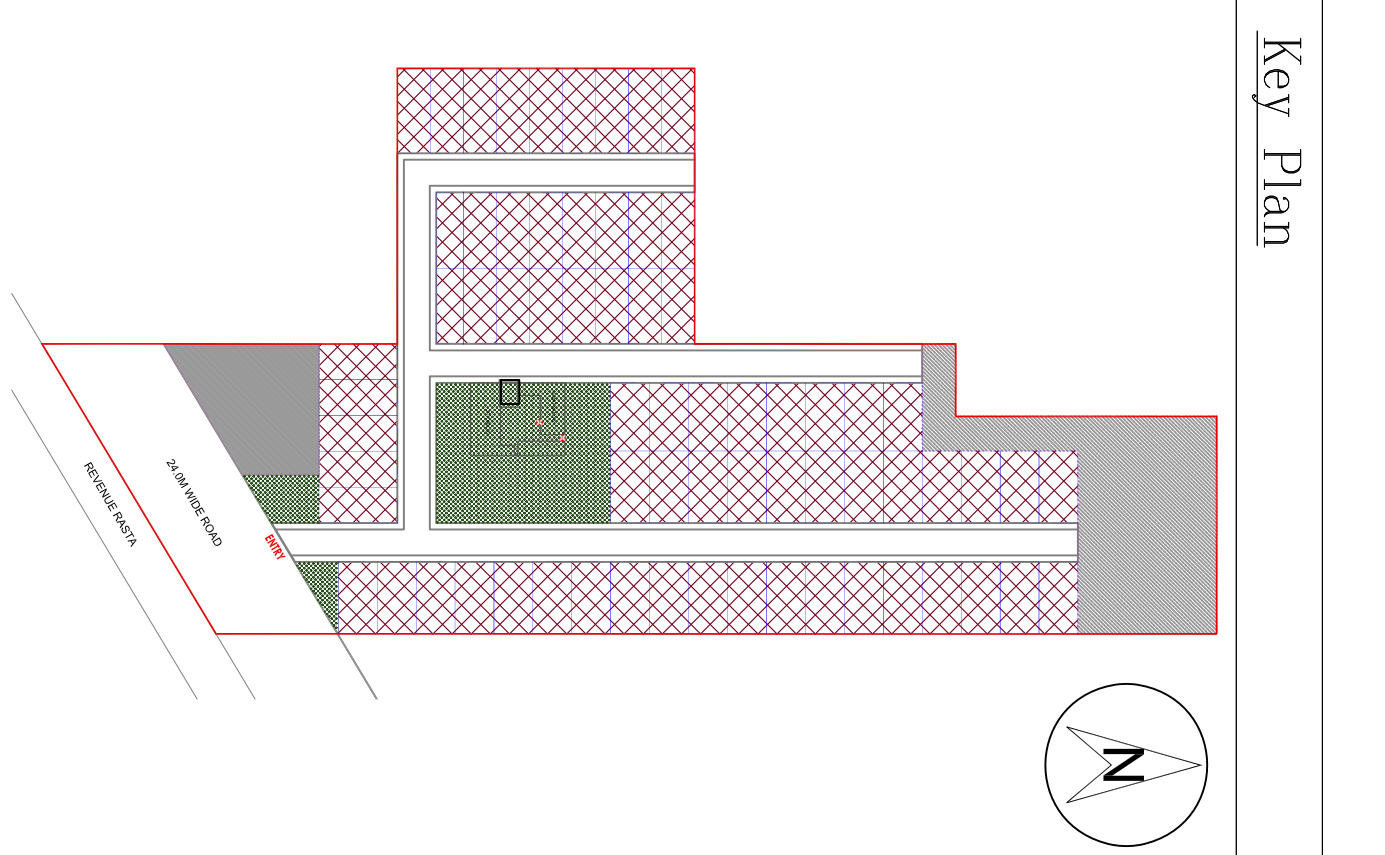

ARCHITECTS:
GRAN P. MATHER AND ASSOCIATES PVT. LTD.
C-35, East of Kailash, New Delhi-110065
T: +91 88699911 F: +91 88699112
P: +91 88699911 E: info@granmather.com W: www.granmather.com

ARCHITECT SIGNATURE: _____

CLIENT :
ALTON BUILDTECH INDIA PRIVATE LIMITED
PLOT NO 83, ADANI HOUSE, INDUSTRIAL
AREA, SECTOR 32, GURUGRAM, HARYANA, 122001
OWNER SIGNATURE: _____

JOB TITLE :
SUBMISSION DRAWING

PROJECT :
PROPOSAL FOR DEEN DAYAL JAN ANAS YOUNA OVER
AN AREA MEASURING 5.0 ACRES IN SECTOR-32 A,
GURUGRAM BEING DEVELOPED BY
MS ALTON BUILDTECH PVT. LTD.

DRAWING TITLE :
SITE PLAN
FLUSHING WATER SUPPLY LAYOUT
JOB NO. : _____ DRAWING NO. :
SCALE : 1:500 SB/PL/MP/02
DATE: 06-12-2022
DEALT : _____ CHECKED BY : _____
VARUN H.C. REVISION NO.
APPROVING AUTHORITY : _____
ARCHITECT'S SIGN CHIEF ARCHITECT

SCHEDULE OF PIPE FLUSHING WATER SUPPLY LINE				
S.NO.	SYMBOL	DIA 90 mm LENGTH(M)	DIA 75 mm LENGTH(M)	DIA 63 mm LENGTH(M)
01.	S1P TO F-1	16	-	-
02.	F-1 TO F-1A	38	-	-
03.	F-1A TO F-2	33	-	-
04.	F-2 TO F-3	-	112	-
05.	F-3 TO F-4	-	8	-
06.	F-4 TO F-5	-	112	-
07.	F-2 TO F-5	8	-	-
08.	F-5 TO F-6	36	-	-
09.	F-6 TO F-7	-	60	-
10.	F-7 TO F-8	-	8	-
11.	F-8 TO F-9	-	60	-
12.	F-6 TO F-9	8	-	-
13.	F-9 TO F-10	60	-	-
14.	F-10 TO F-11	-	65	-
15.	F-10 TO F-2	8	-	-
16.	F-1 TO F-13	-	116	-
17.	F-13 TO F-14	-	8	-
18.	F-14 TO F-15	-	149	-
19.	F-1A TO F-15	8	-	-
20.	F-15 TO F-16	-	-	16
	TOTAL	215	698	16
	SAV	215	700	20

NO.OF VALVES :- 650 = 1 NO. & SCOUR VALVE = 3 NOS.


NO.OF VALVES :- 750 = 6 NOS.

NO.OF VALVES :- 900 = 2 NOS. & AIR RELEASE VALVE = 1 NOS.

NO.OF GARDEN HYDRANTS :- 14 NOS.

LEGEND:-

SNO.	SYMBOL	DESCRIPTION
1.		FLUSHING / IRRIGATION WATER LINE
2.		GH
3.		ARV
4.		SCV
5.		VC
6.		200 MM OD DWC PE PIPE (IS-16098-2-SN8) HUME PIPE FOR ROAD CROSSING

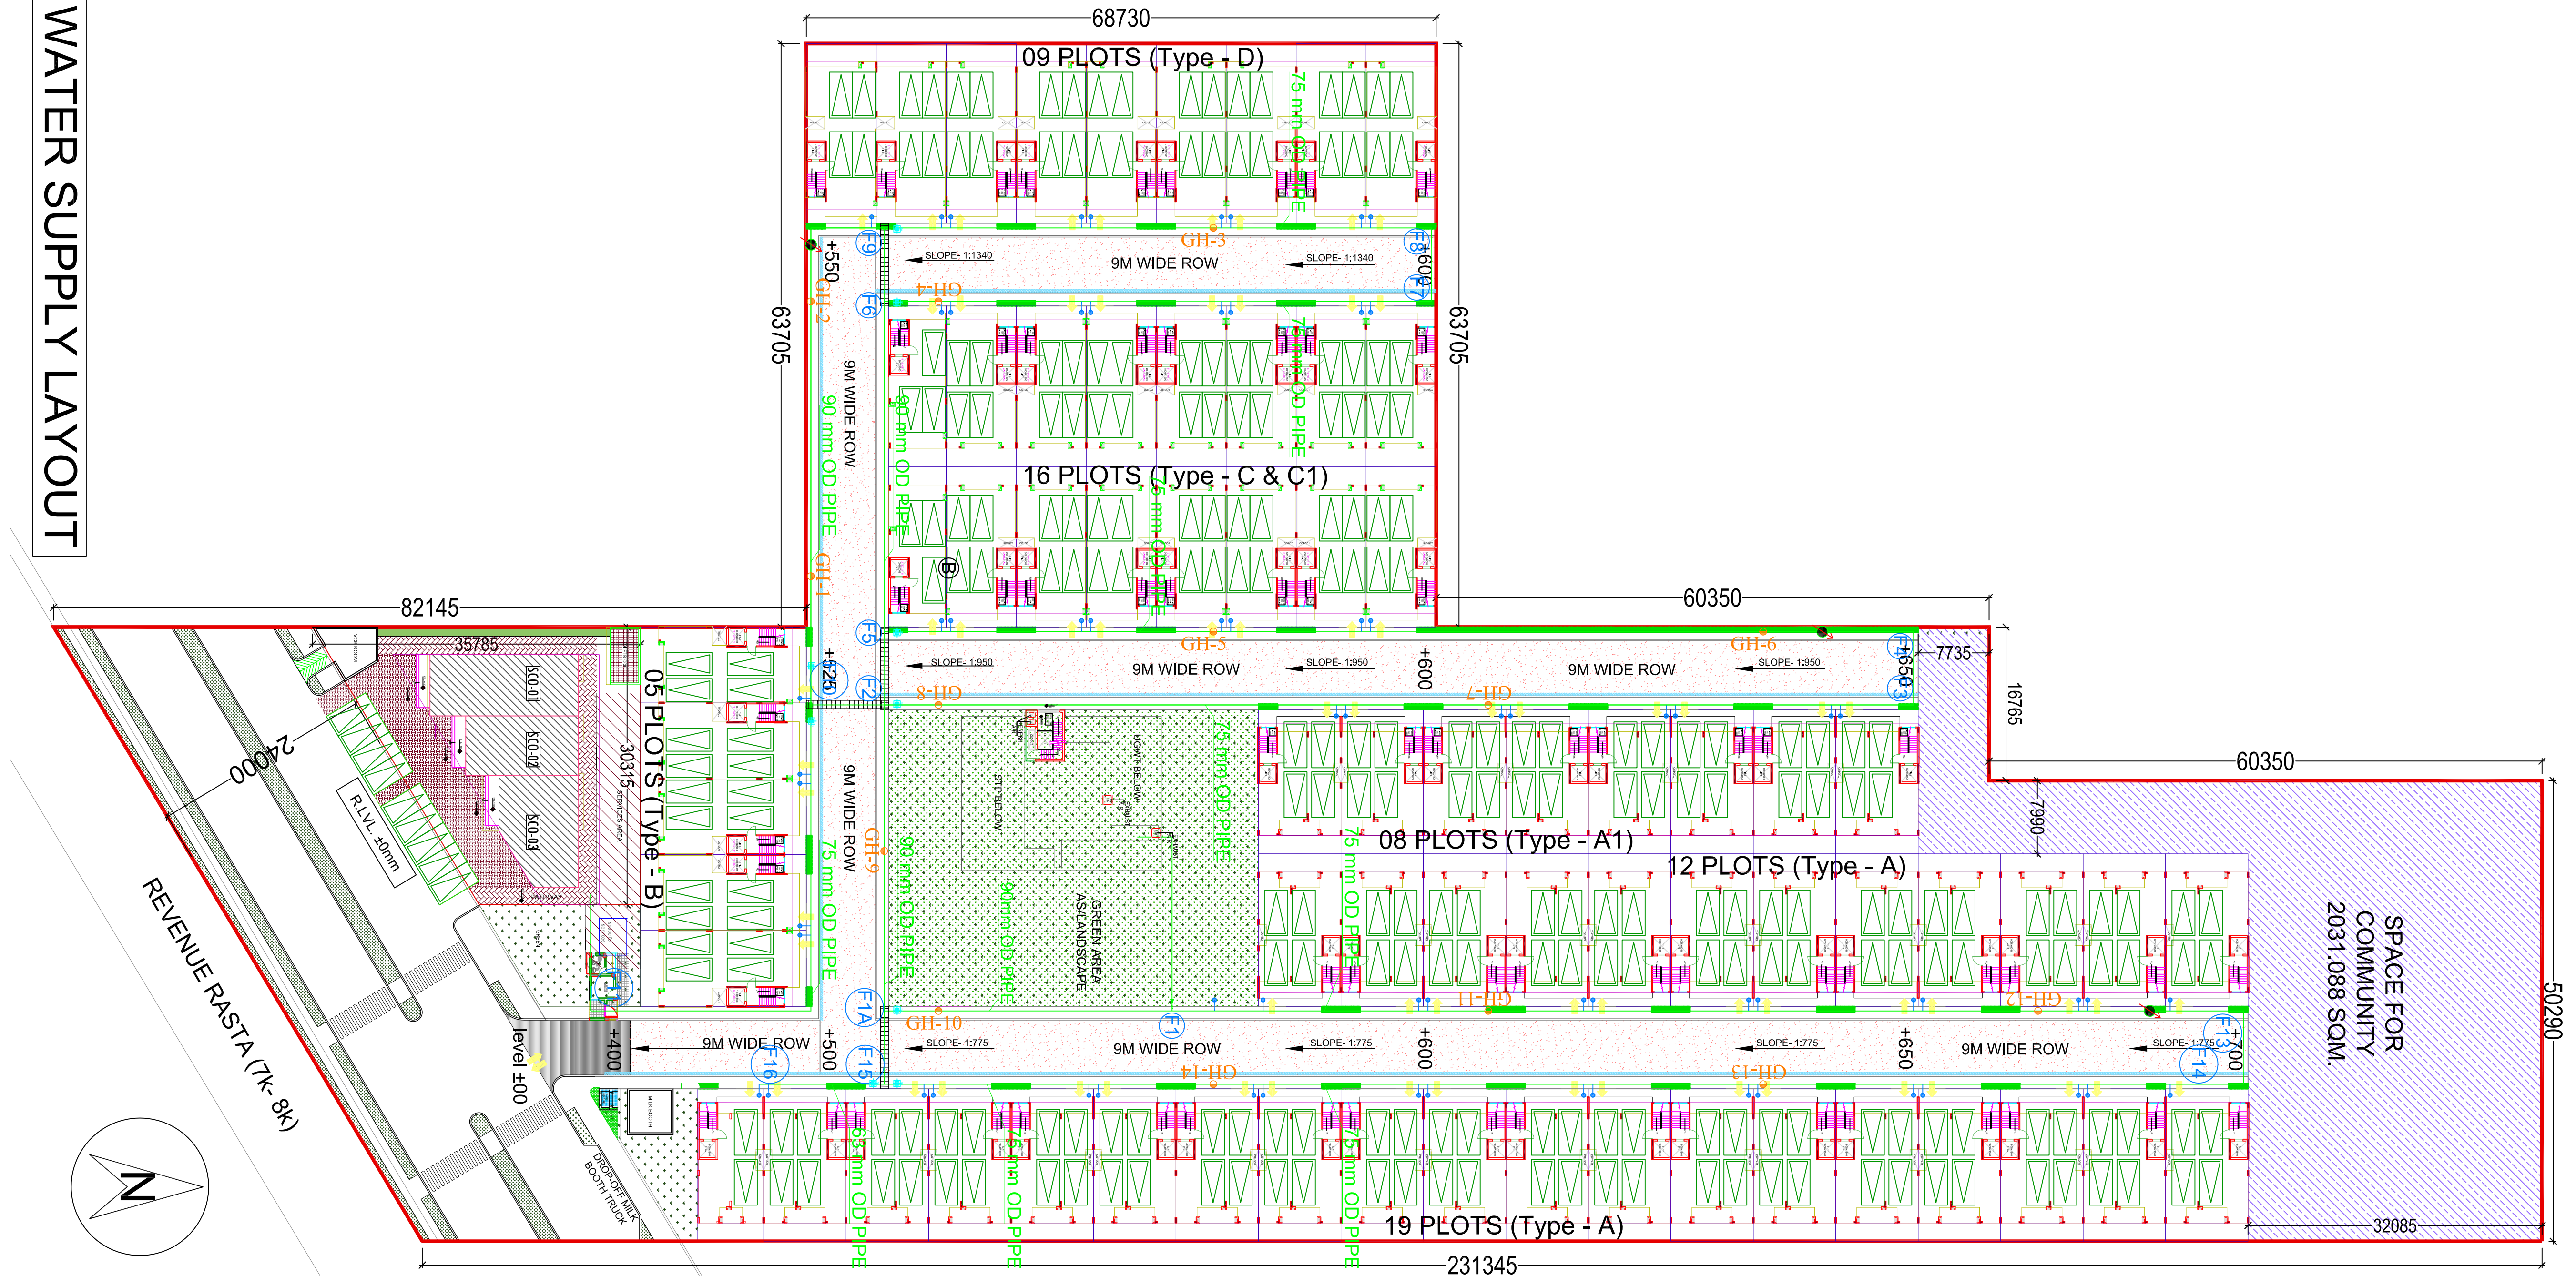

FLUSHING WATER SUPPLY LAYOUT