


SCHEDULE OF PIPE SEWER LINE					
DDJAY ADAMI (Gurgaon, Haryana, India)					
SR. MH No. (From)	MH (To)	2500 PIPE (Length mtr)	INTERMEDIATE MH (no.)	1500 PIPE (Length mtr)	NUMBER OF PLOTS Residential Commercial Community
1. MH-1	MH-2	55	3	87	17
2. MH-2	MH-4	44	1	0	0
3. MH-3	MH-4	106	6	84	16
4. MH-4	MH-6	42	2	36	5
5. MH-5	MH-6	32	1	21	2
6. MH-6	MH-8	26	0	30	4
7. MH-7	MH-8	116	6	133	25
8. MH-8	STP	--	1	0	0
TOTAL		421.0 MTR.	20 nos.	393.0 MTR.	69 nos.
STP OVER FLOW (1000) PIPE = 205.0 MTR.					
NO. OF SEWER MANHOLE = 28 NOS.					

COMMERCIAL / COMMUNITY = 250 mm OD SLOPE @ 1 : 300
PLOT - 0 - 50 = PIPE SIZE = 200 mm OD SLOPE @ 1 : 225
PLOT - 51 - ABOVE = PIPE SIZE = 250 mm OD SLOPE @ 1 : 300
(MATERIAL DMC PE PIPE (IS : 16098-2, SN4) (N VALUE = 0.009)


LEGEND:-

SNO.	SYMBOL	DESCRIPTION
1.	(A)	150mm OD SLOPE @ 1 : 200
2.	(B)	200 mm OD SLOPE @ 1 : 225
3.	(C)	250 mm OD SLOPE @ 1 : 300
4.	(D)	INSPECTION CHAMBER (600X600mm)
5.	---	SEWERAGE LINE
6.	(E)	SEWERAGE MANHOLE
7.	(F)	SEWERAGE MANHOLE

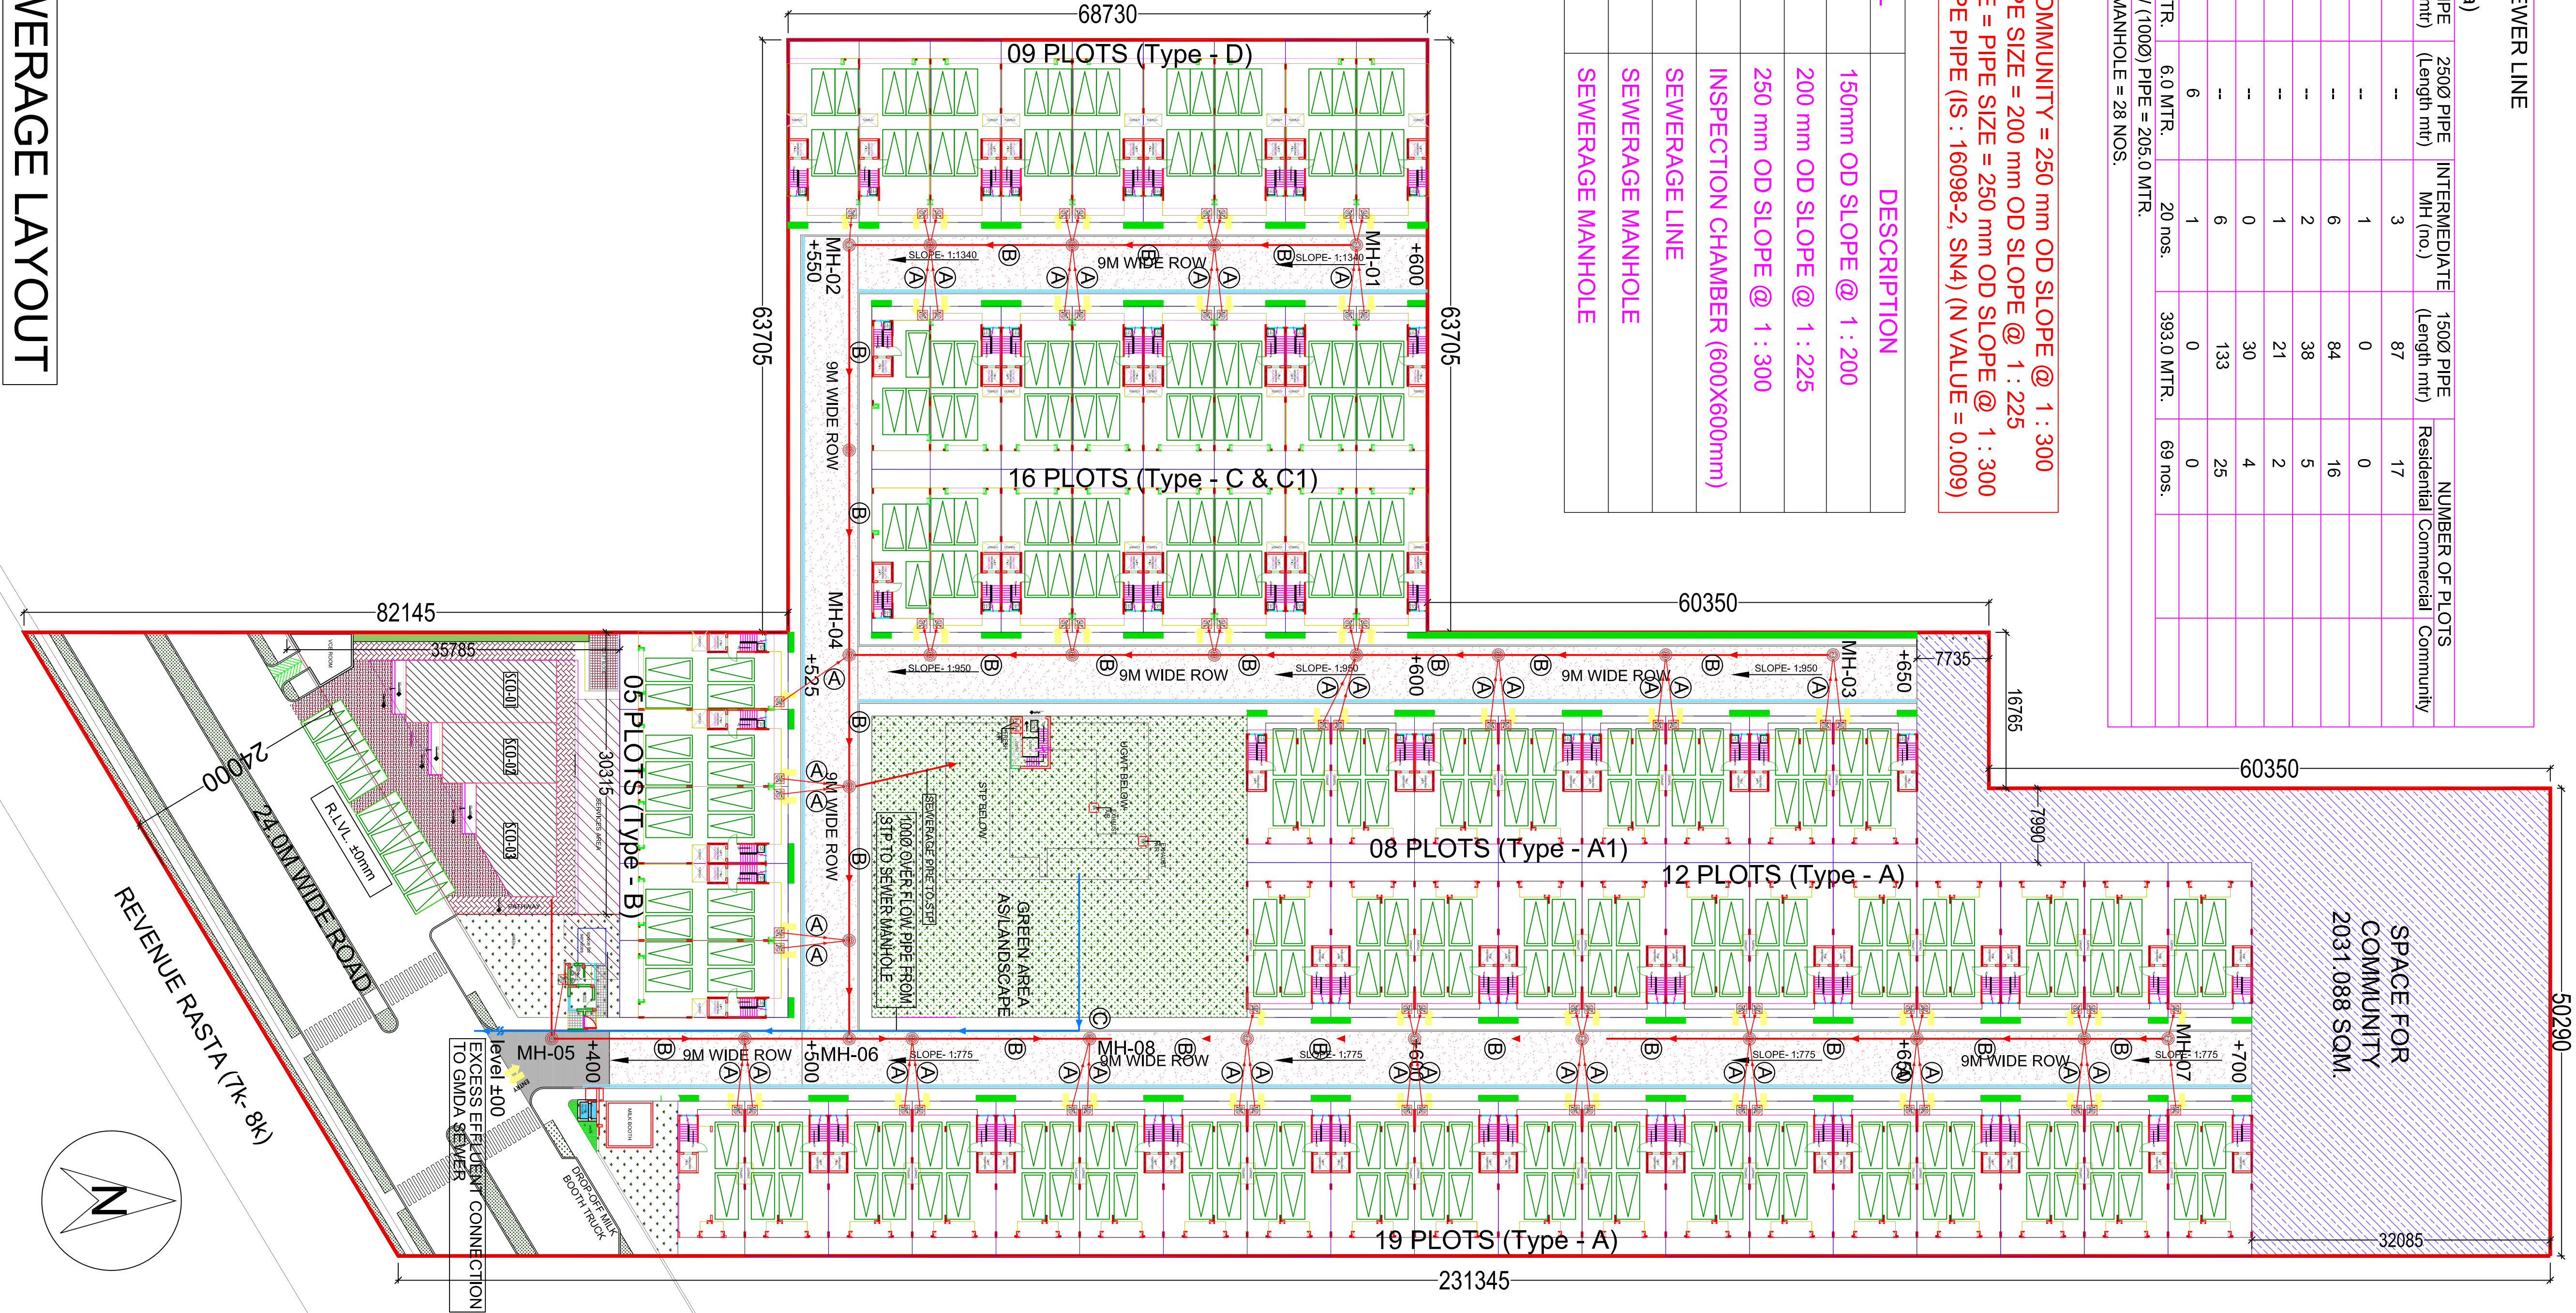

SEWERAGE LAYOUT

Key Plan

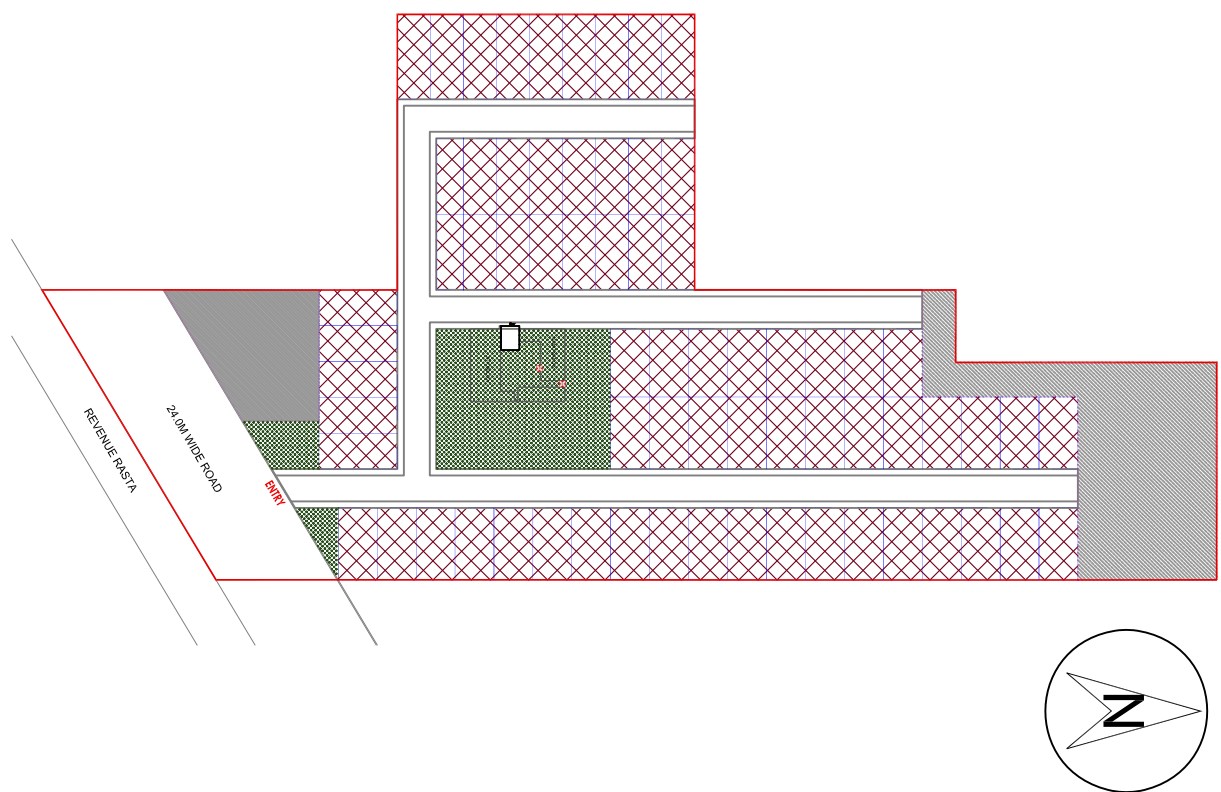

ARCHITECTS:

GRAN P. MATTHEW AND ASSOCIATES PVT. LTD.
ARCHITECTS T : 86595991 F : 86595912
PLANNERS E : info@gpmltd.com W : www.gpmltd.com

ARCHITECT SIGNATURE :

CLIENT :
ALTON BUILDTECH INDIA PRIVATE LIMITED
PLOT NO.83, ADANI HOUSE, INDUSTRIAL AREA, SECTOR 32, GURUGRAM, HARYANA, 122001
OWNER SIGNATURE :

JOB TITLE :
SUBMISSION DRAWING

PROJECT :

PROPOSAL FOR DEEN DAYAL JAIN AMAS YOUNG OVER AN AREA MEASURING 5.0 ACRES IN SECTOR-80 A, GURUGRAM BEING DEVELOPED BY MS ALTON BUILDTECH PVT. LTD.

DRAWING TITLE :

SITE PLAN
SEWERAGE LAYOUT

JOB NO. :
SCALE : 1:500
DRAWING NO. : SB/PL/MP/03
DATE : 06-12-2022
DEALT :
VARUN
CHECKED BY :
H.C.
REVISION NO.
APPROVING AUTHORITY :
ARCHITECT'S SIGN : CHIEF ARCHITECT