


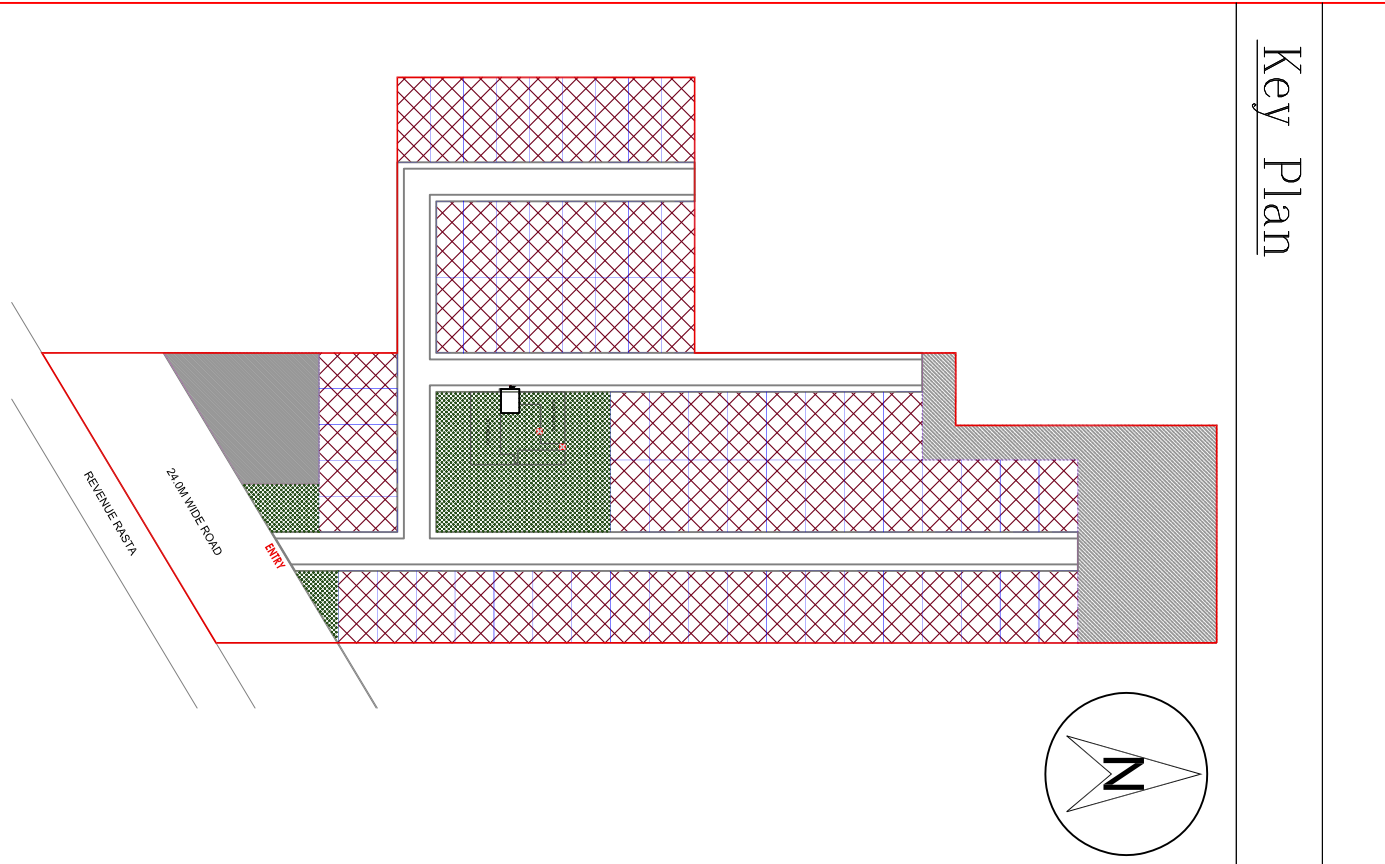

ARCHITECTS:
GRAN P. MATHER AND ASSOCIATES PVT. LTD.
ARCHITECTS T: +91 96999 11 46/999 11 47
PLANNERS E: info@granmather.com W: www.granmather.com

ARCHITECT SIGNATURE: _____

CLIENT:
ALTON BUILDTECH INDIA PRIVATE LIMITED
PLOT NO. 83, ADANI HOUSE, INDUSTRIAL
AREA, SECTOR 32, GURUGRAM, HARYANA, 122001

OWNER SIGNATURE: _____

JOB TITLE: _____

SUBMISSION DRAWING

PROJECT:
PROPOSAL FOR DEEN DAYAL JAIN AMAS YOUNG OVER
AN AREA MEASURING 5.0 ACRES IN SECTOR-39 A,
GURUGRAM BEING DEVELOPED BY
M/S ALTON BUILDTECH PVT. LTD.

DRAWING TITLE: _____

STORM WATER LAYOUT

JOB NO. _____ DRAWING NO. _____
SCALE: 1:1500 SB/PL/MP/04
DATE: 06-12-2022
DEALT: _____ CHECKED BY: _____
VARUN H.C. REVISION NO. _____
APPROVING AUTHORITY: _____
ARCHITECT'S SIGN CHIEF ARCHITECT

LEGEND:-

SNO.	SYMBOL	DESCRIPTION
1.	(A)	250mm DIA SLOPE @ 1 : 300
2.	(B)	400 mm DIA SLOPE @ 1 : 570
3.	(C)	450 mm DIA SLOPE @ 1 : 570
4.	■	CATCH BASIN (500X500mm)
5.	—	150Ø STORM WATER PIPE
6.	—	STORM WATER LINE
7.	⊕	STORM WATER MANHOLE
8.	⊕	STORM WATER MANHOLE
9.	—	300 mm WIDE SAUCER DRAIN
10.	⊕ RWH PIT	RAIN WATER HARVESTING PIT

SCHEDULE OF PIPE STORM WATER LINE

(Gurgaon, Haryana, India)

S/S (From)

MT (Length mtr)

INTERMEDIATE (Length mtr)

150Ø PIPE INTERMEDIATE (CS nos.)

Residential

Commercial

Community

Park

Roads

1- MH-1

MH-2

44

—

2

23

0

—

—

172

2- MH-2

MH-4

118

—

7

85

23

2182

—

1096

3- MH-4

MH-5

24

—

1

1

1

750

—

282

4- MH-5

MH-6

5

—

0

0

0

0

—

0

5- MH-6

MH-8

32

—

1

1

1

0

—

0

6- MH-8

MH-9

154

—

8

150

38

4646

—

1388

7- MH-9

RWH-2

—

22

0

1

1

0

—

265

8- MH-9

RWH-2

—

8

0

0

0

0

810

—

0

9- RWH-2

locally

—

8

0

0

0

0

810

—

0

TOTAL

442 MTR.

38 MTR.

11 NOS.

331 M.

89

0

0

0

—

3892 sqm.

NO. OF RWH PIT = 09 NOS.


TOTAL AREA = 9974 sqm.

810 sqm.

2031 sqm.

NO. OF STORM WATER MANHOLE = 31 NOS.

SUB TOTAL AREA = 41548 sqm.

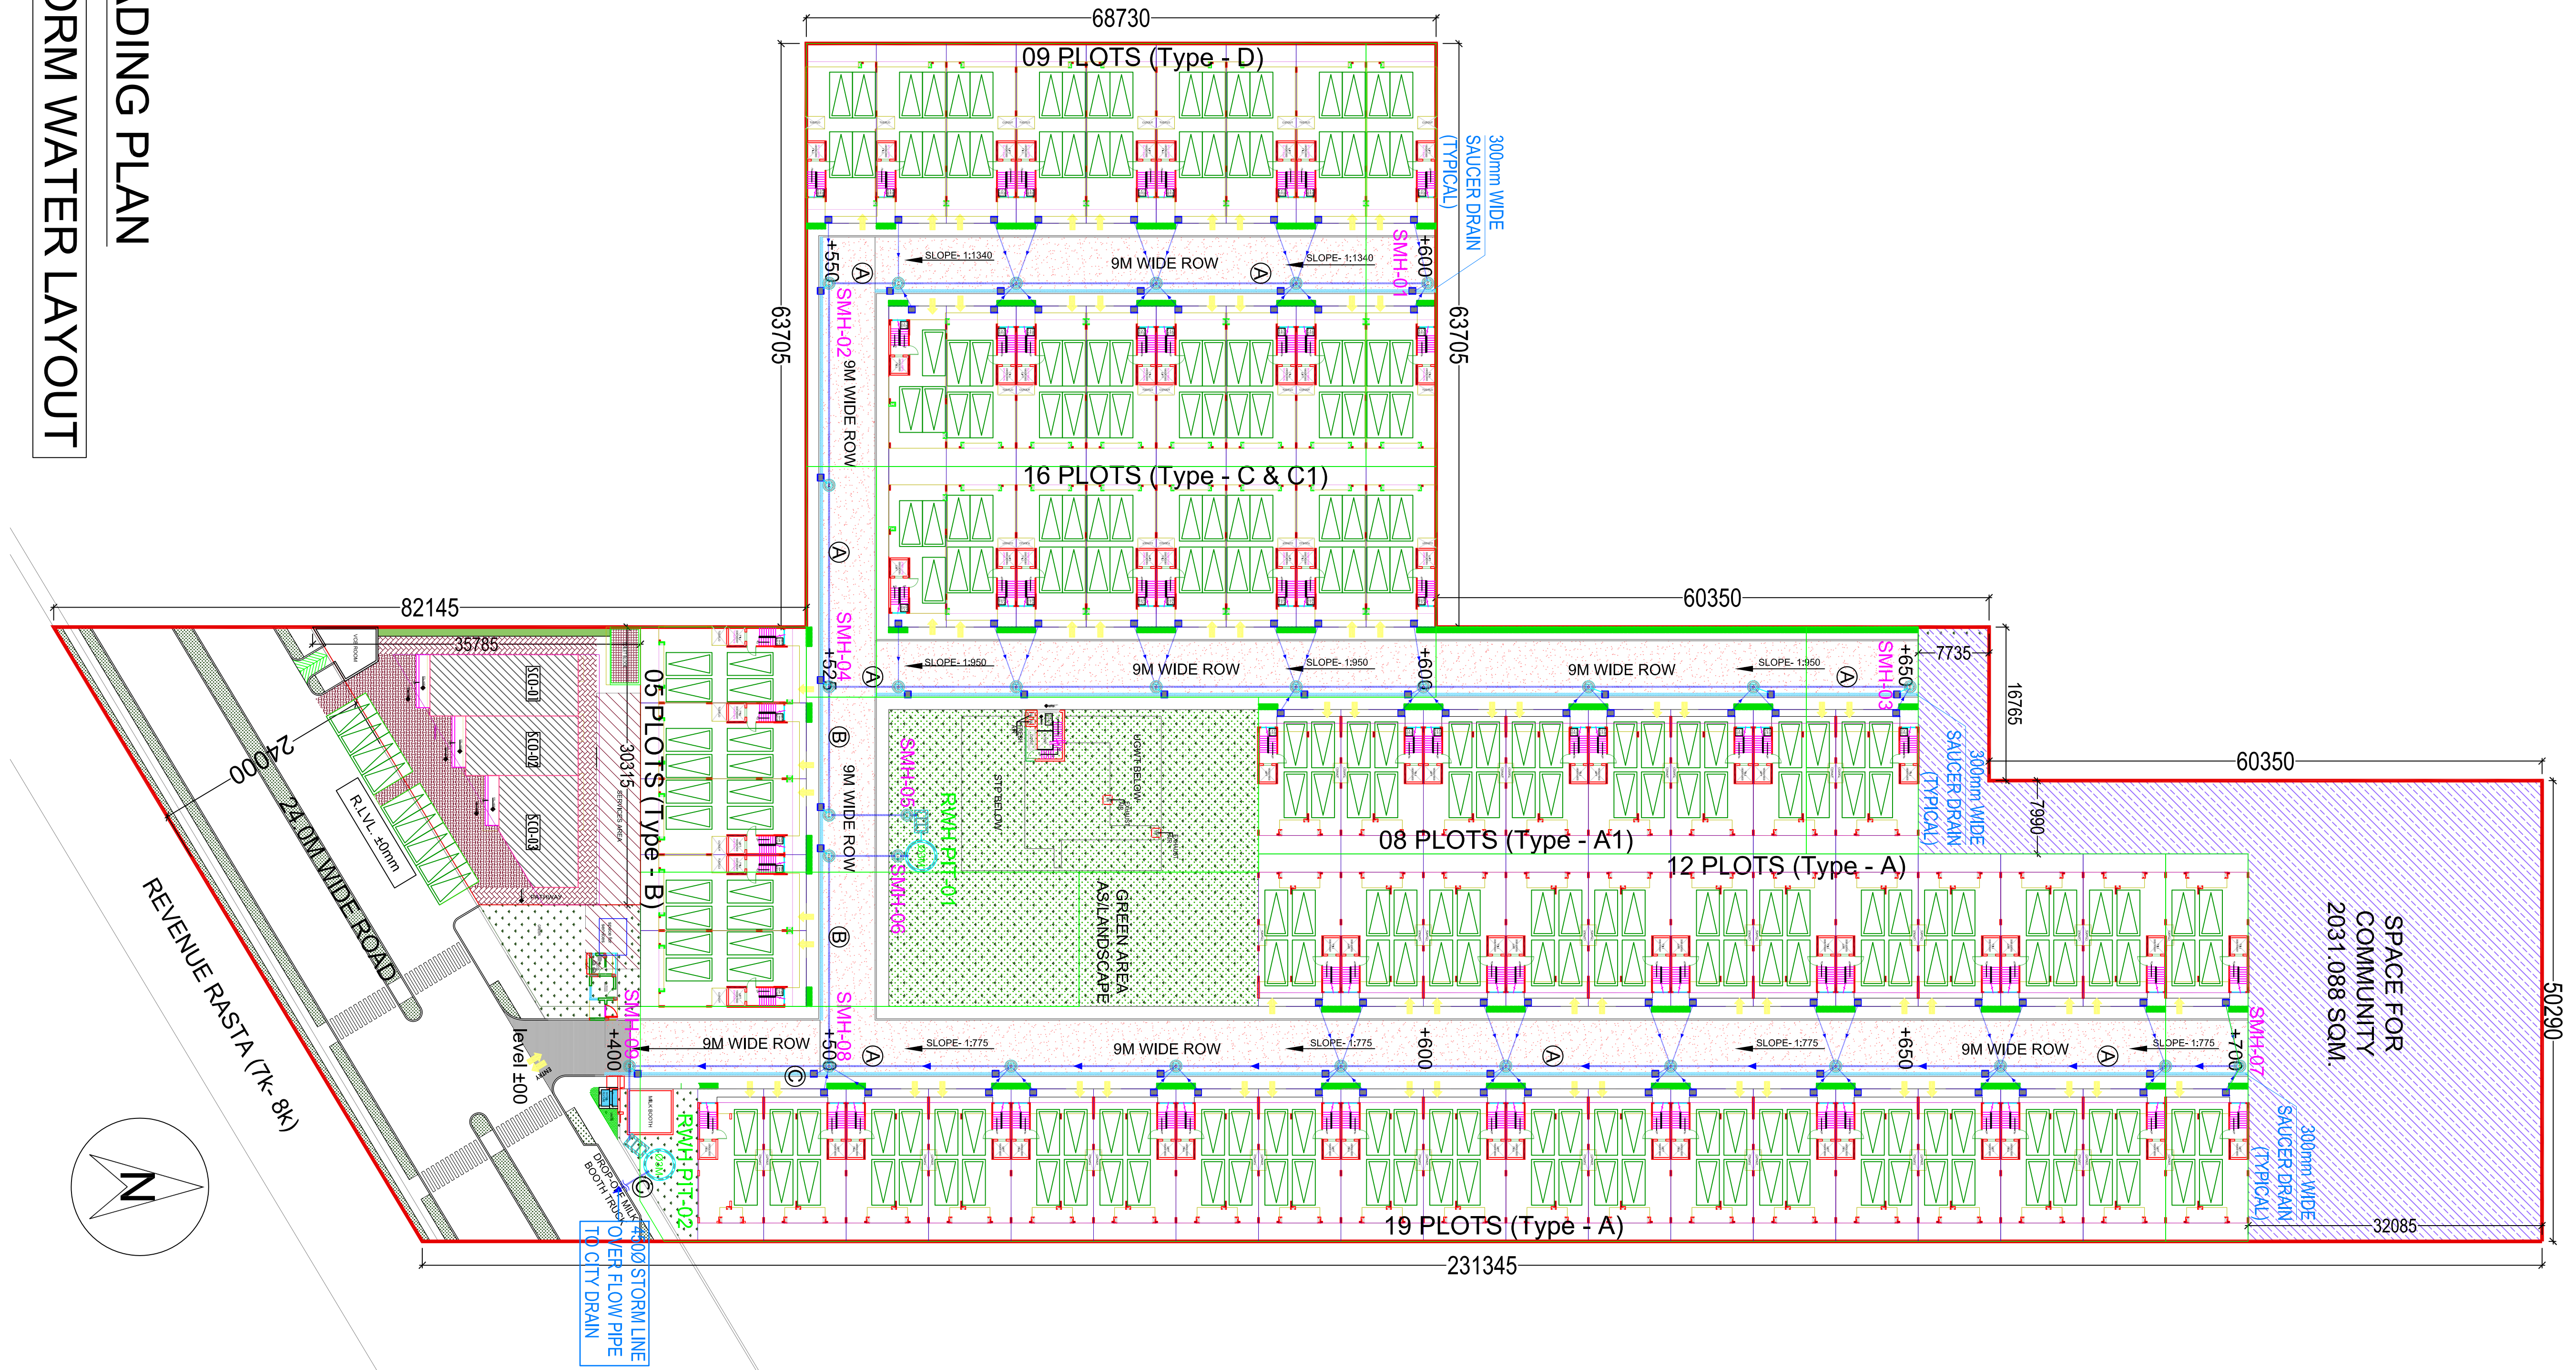

GRADING PLAN

STORM WATER LAYOUT