




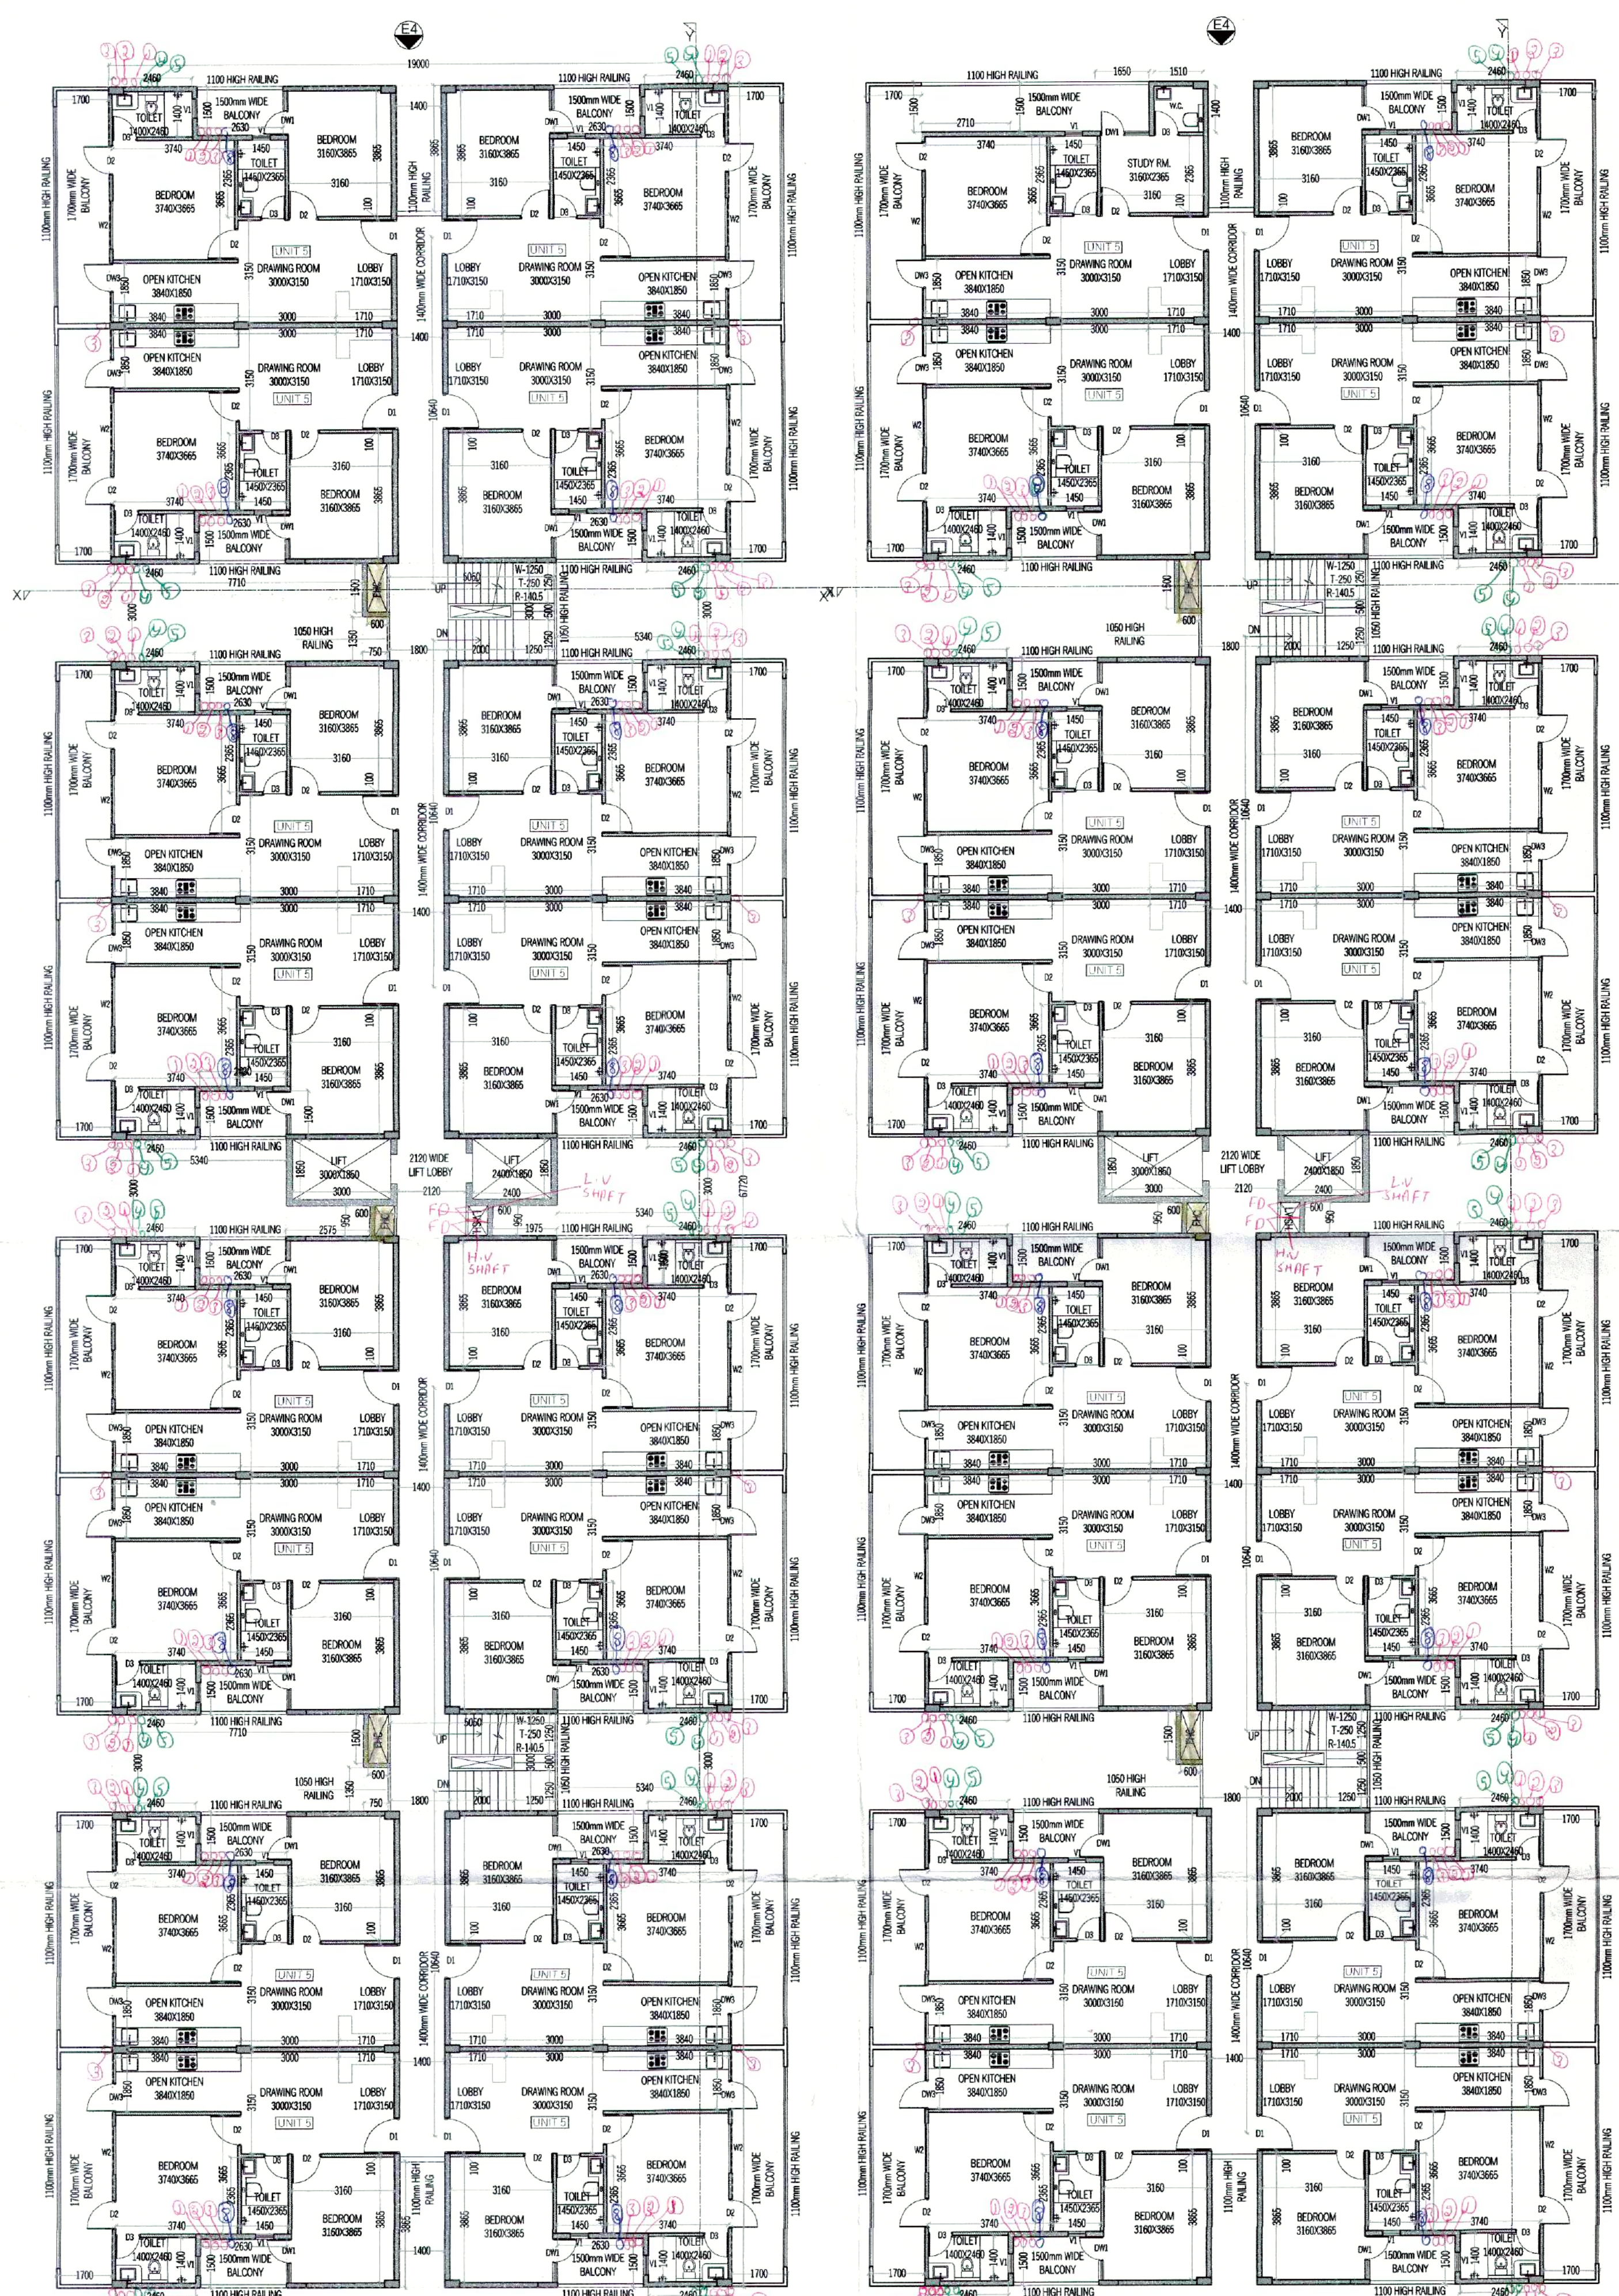


TYPICAL FLOOR PLAN (4TH TO 11TH)
(TOWER B)

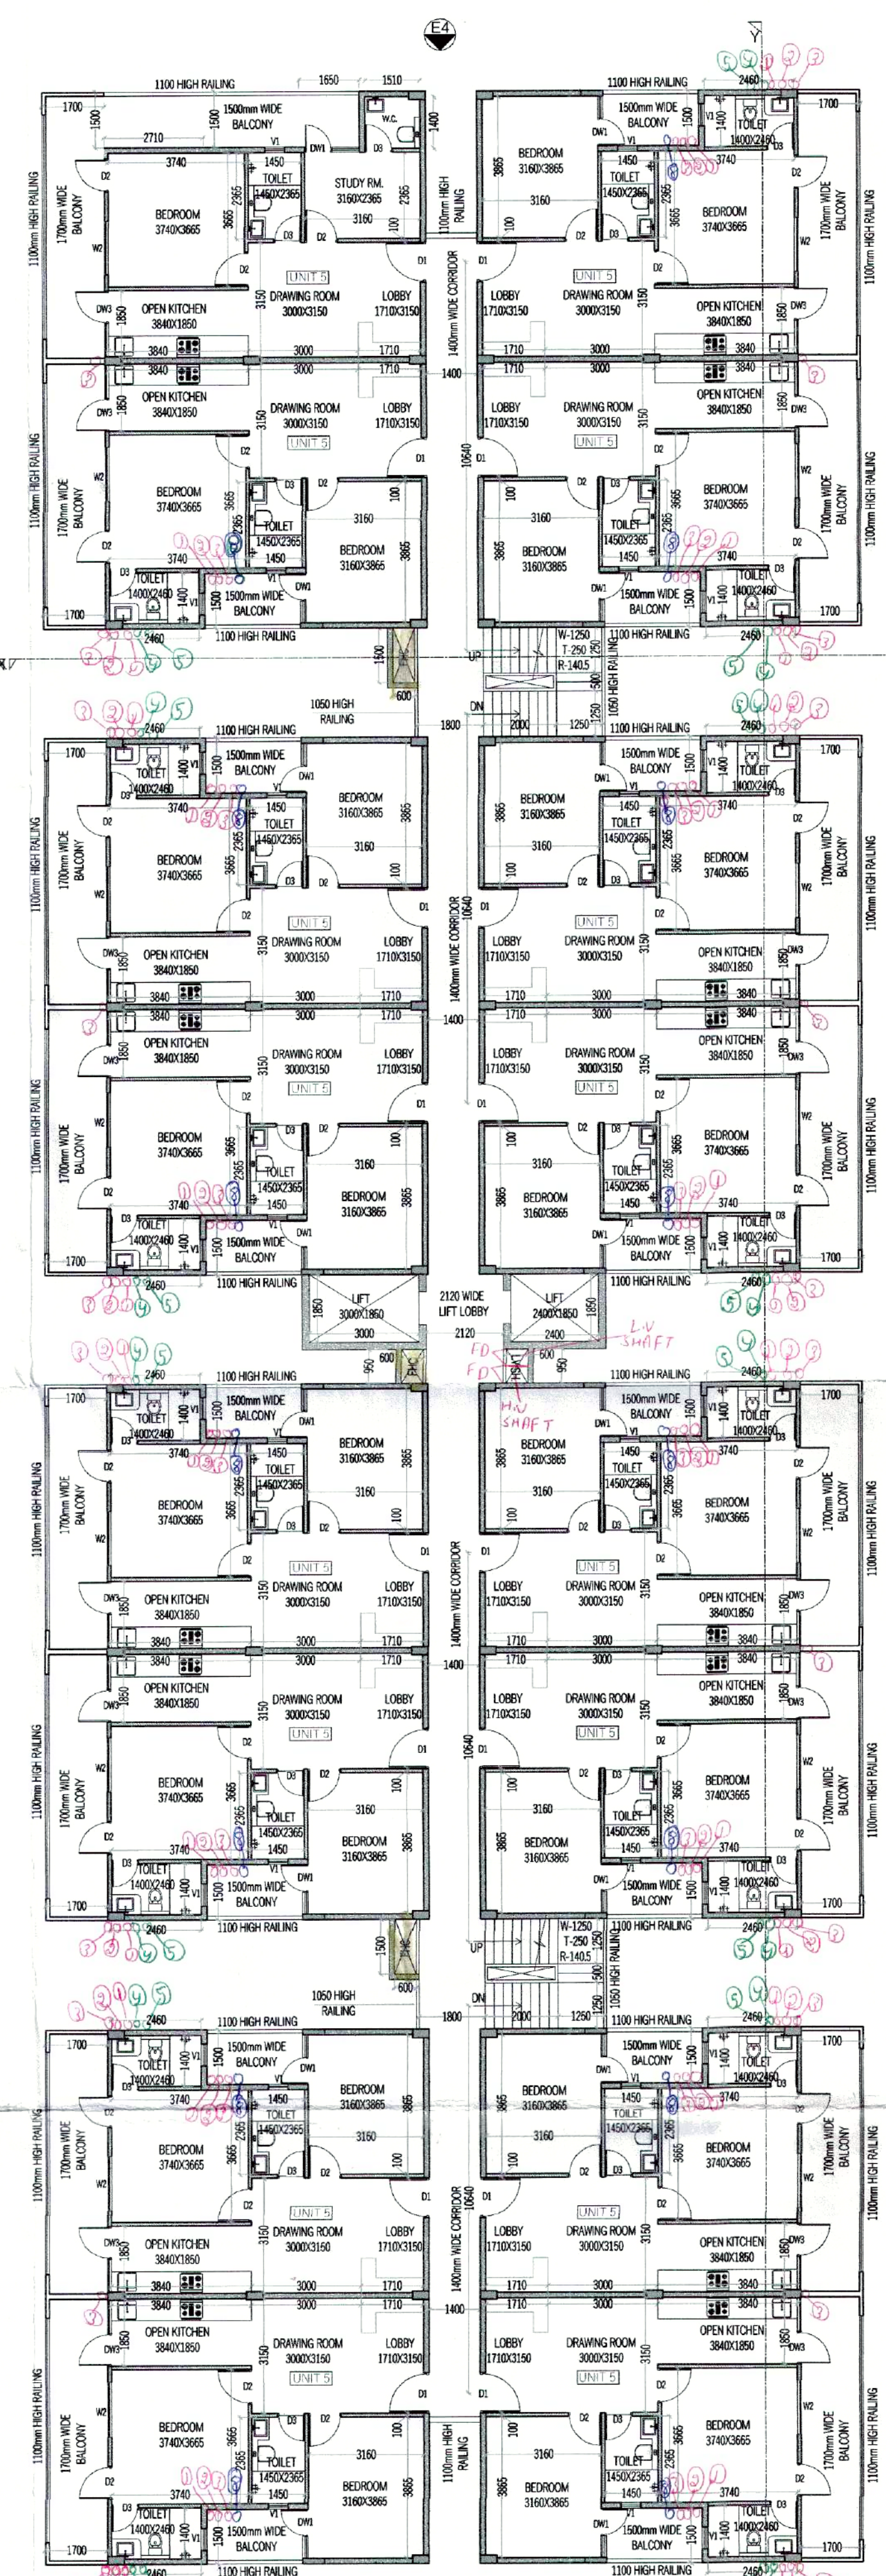

12TH TO 14TH FLOOR F.A.R.
(TOWER B)

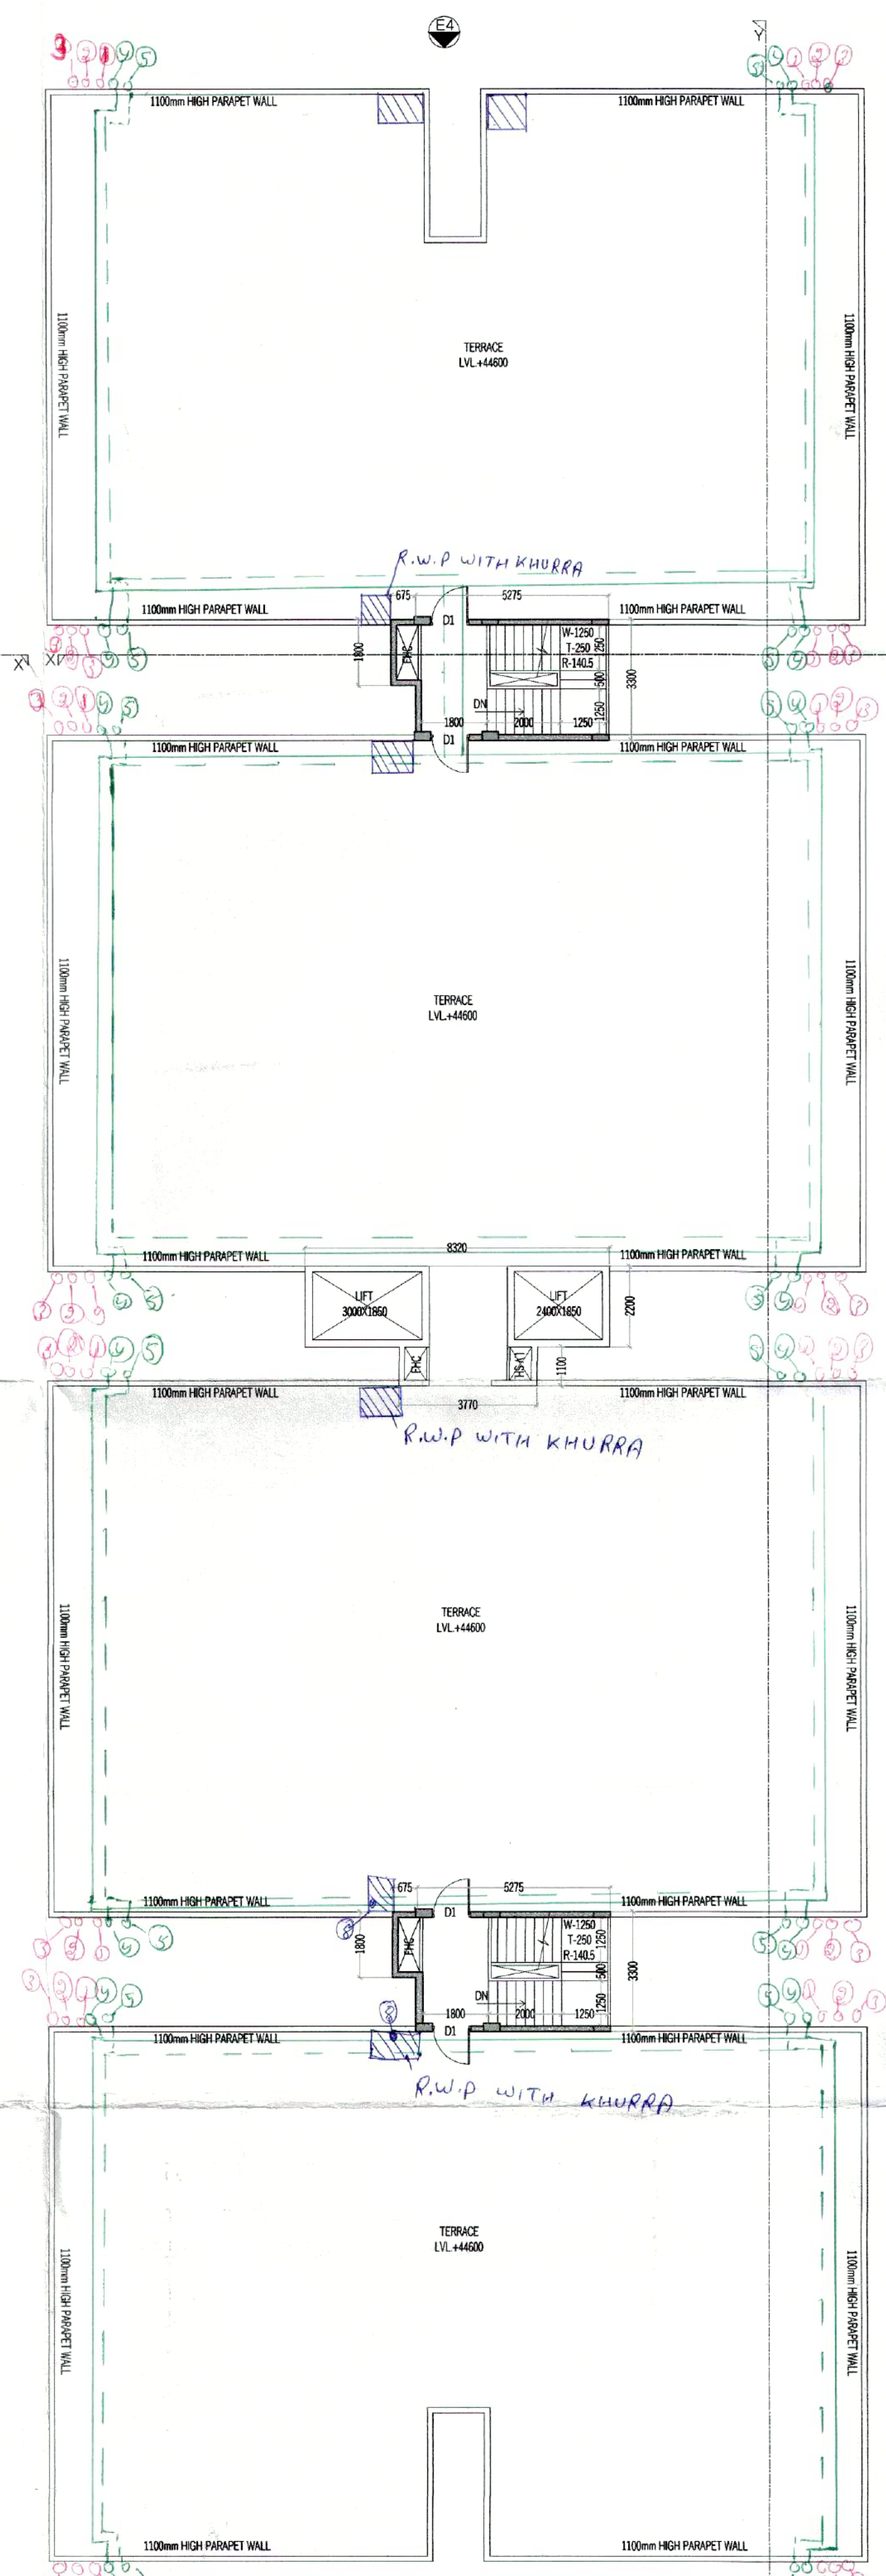

TERRACE FLOOR PLAN
(TOWER B)

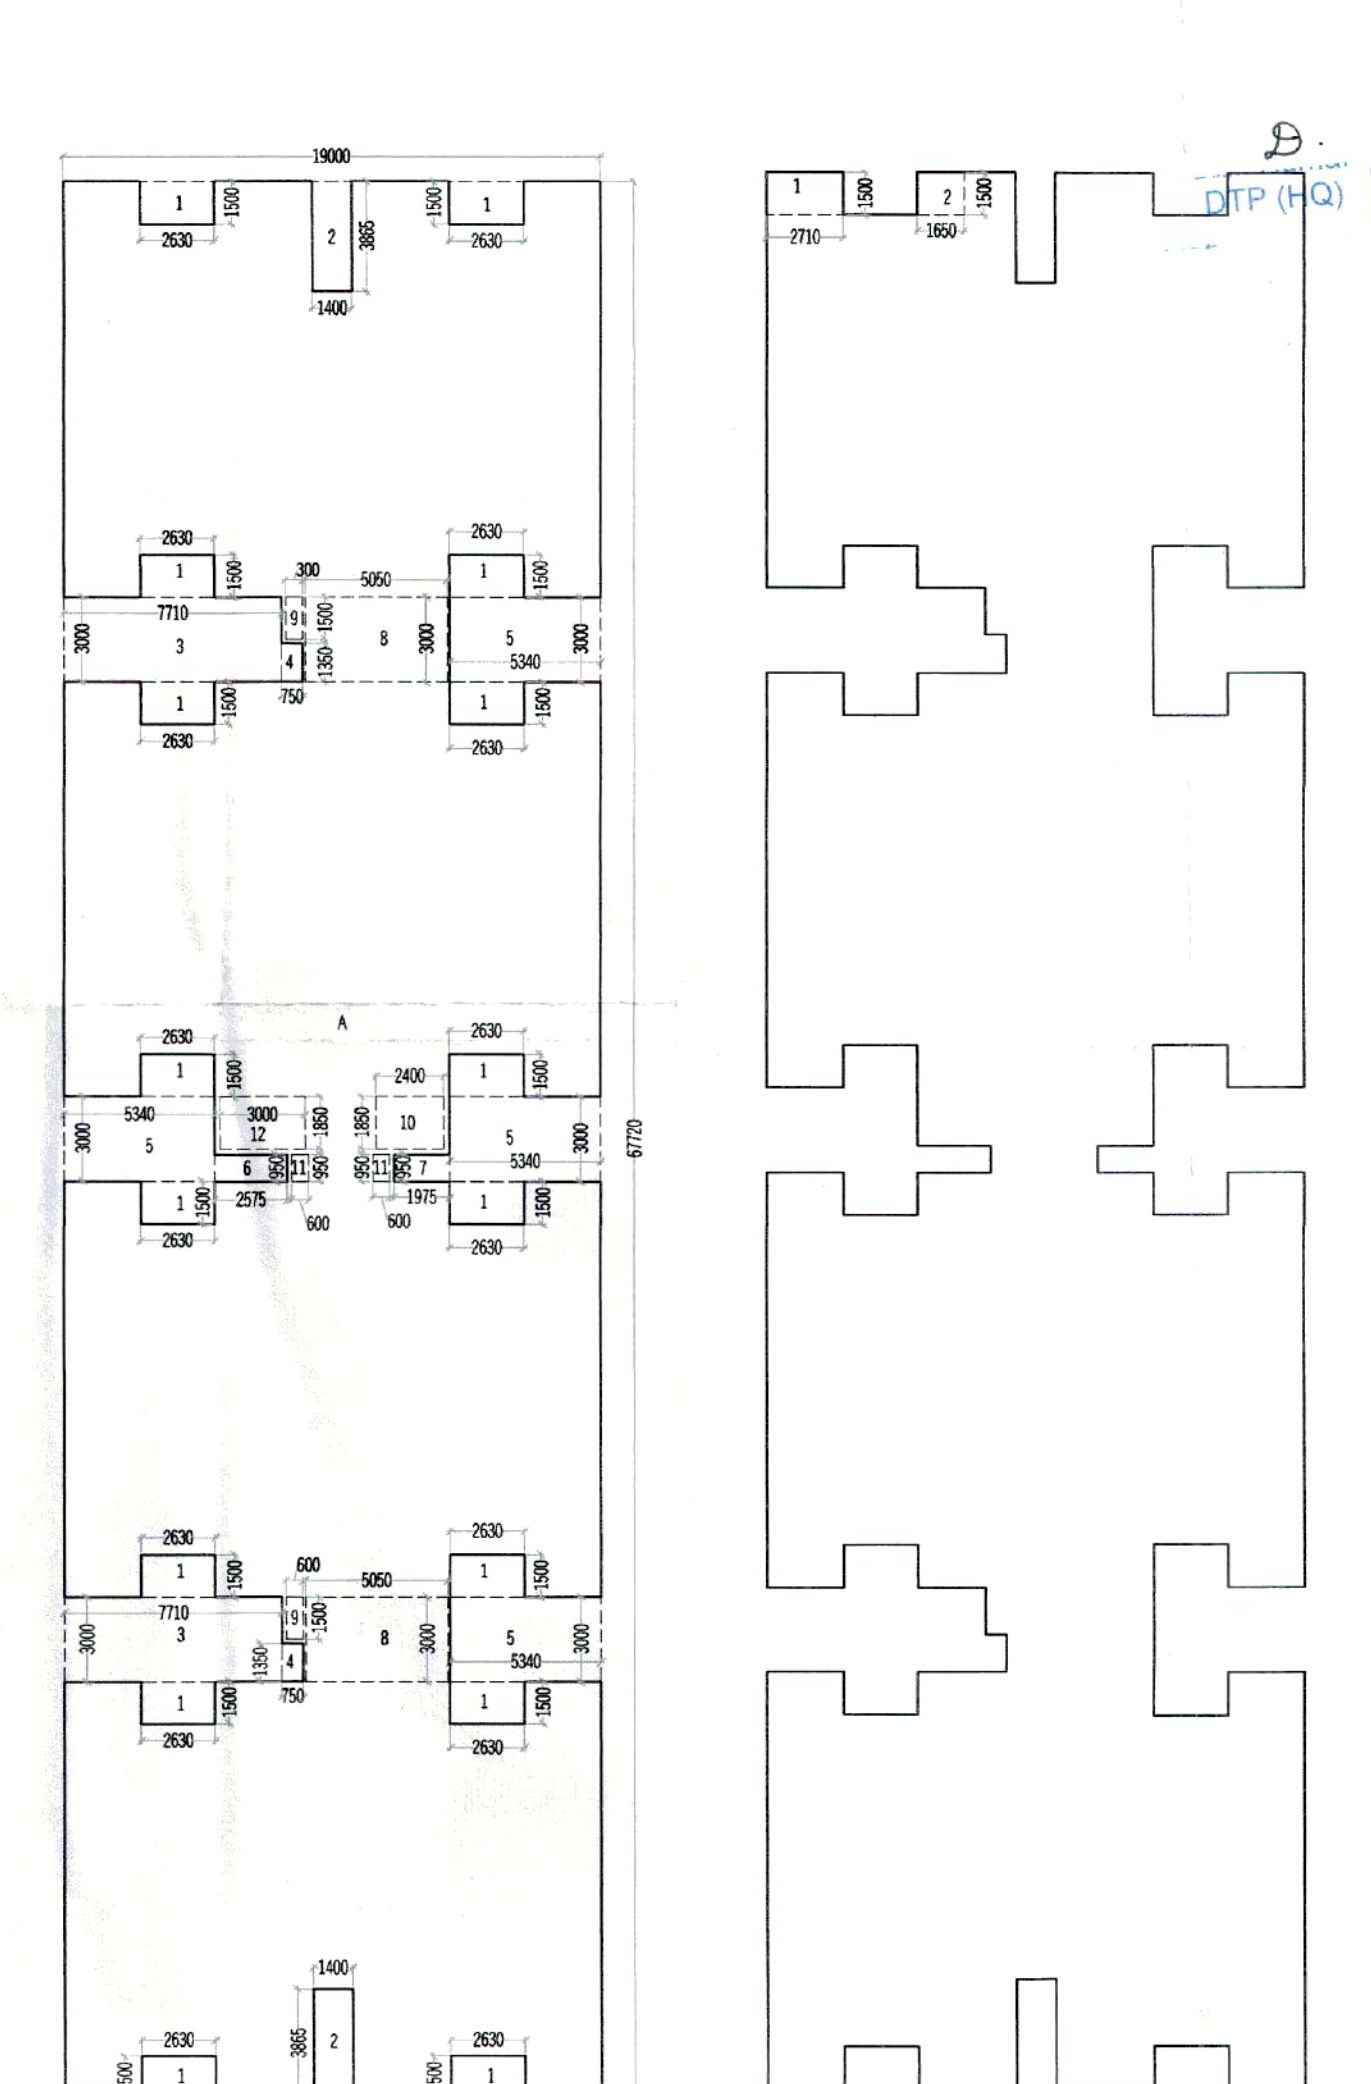

TYPICAL FLOOR AREA DIAGRAM
(4TH TO 11TH)
(TOWER B)


TYPICAL FLOOR F.A.R. (4TH TO 11TH)					
ADDITIONS					
S.N.O.	NO.	PREFIX	LENGTH	BREATH	AREA
A	1		19.000	67.720	1286.680
TOTAL ADDITION					1286.680
SUBTRACTIONS					
S.N.O.	NO.	PREFIX	LENGTH	BREATH	AREA
1	16	1	2.630	1.500	63.120
2	2	1	1.400	3.865	10.822
3	2	1	7.710	3.000	46.260
4	2	1	0.750	1.350	2.025
5	4	1	5.340	3.000	64.080
6	1	1	2.575	0.950	2.446
7	1	1	1.975	0.950	1.876
8	2	1	5.050	3.000	30.300
9	2	1	0.600	1.500	1.800
10	1	1	2.400	1.850	4.440
11	2	1	0.600	0.950	1.140
12	1	1	3.000	1.850	5.550
TOTAL SUBTRACTION					233.860
TOTAL TYP. 4TH TO 11TH FLOOR F.A.R.					1052.821

12TH TO 14TH FLOOR F.A.R.					
ADDITIONS					
S.N.O.	NO.	PREFIX	LENGTH	BREATH	AREA
TYPICAL FLOOR F.A.R.					1052.821
TOTAL ADDITION					1052.821
SUBTRACTIONS					
S.N.O.	NO.	PREFIX	LENGTH	BREATH	AREA
1	1	1	2.710	1.500	4.065
2	1	1	1.650	1.500	2.475
TOTAL SUBTRACTION					6.540
TOTAL 12TH TO 14TH FLOOR F.A.R.					1046.281

Checked and found ok for Public Health
(Internal) Service only subject to comments in
in forwarding letter No. DV.

Superintending Engineer (HQ)
for Chief Engineer
HSVP, Bhopal

Sd/-
Sd/-

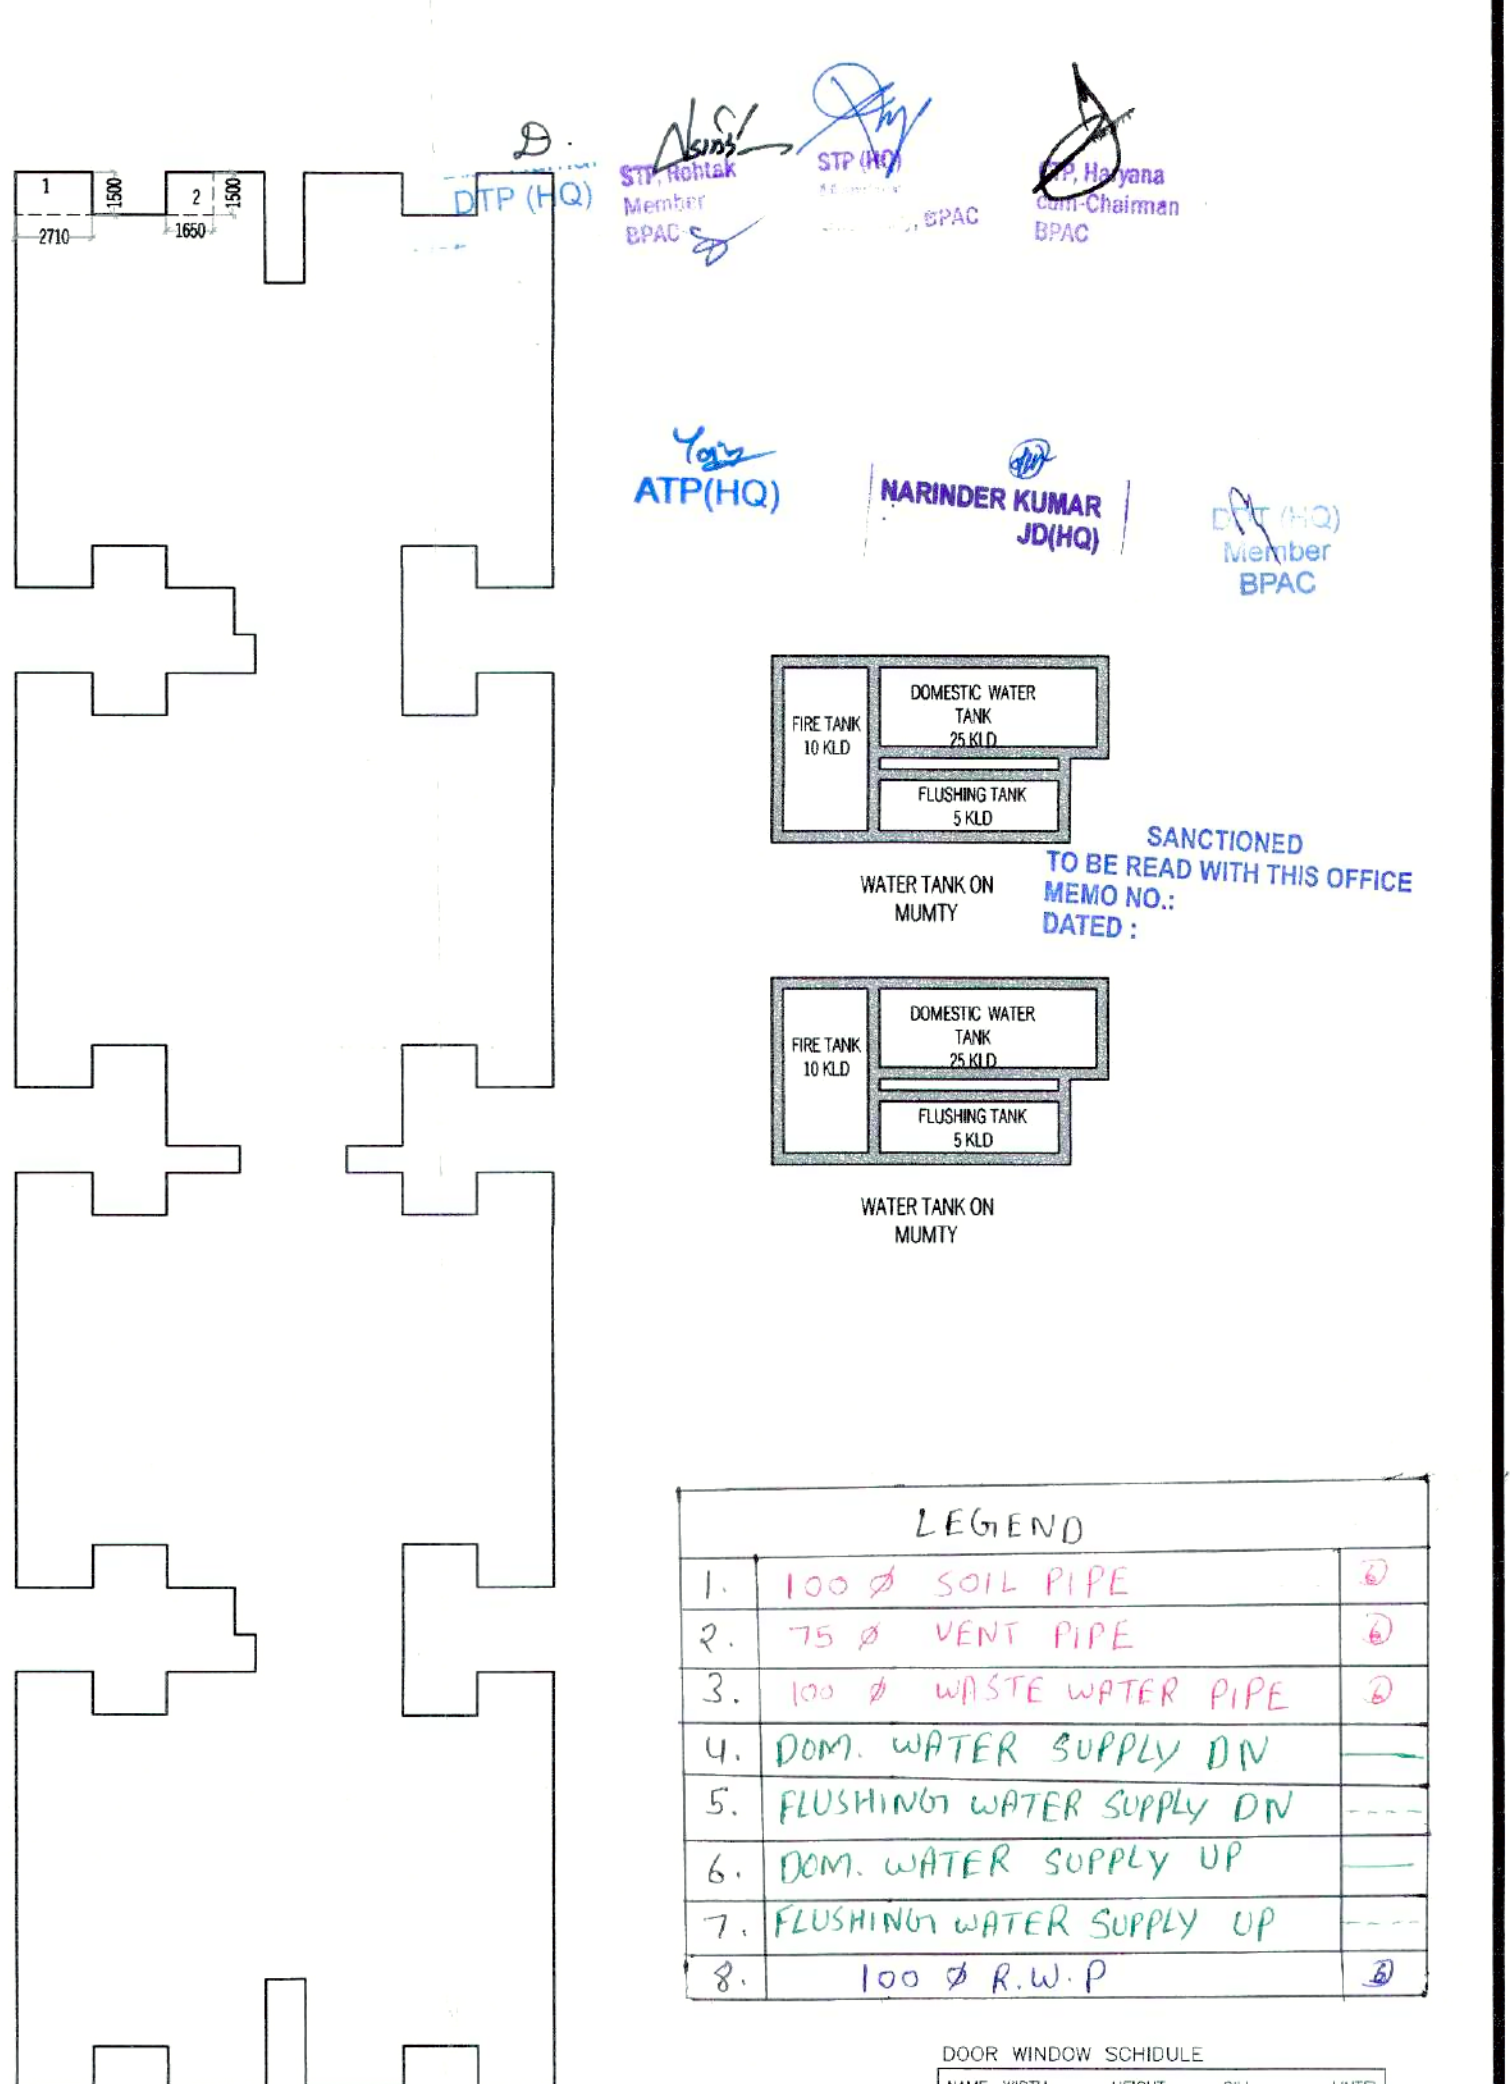

12TH TO 14TH FL.
AREA DIAGRAM
(TOWER B)

MUMTY / MACHINE ROOM
AREA DIAGRAM
(TOWER B)

MUMTY MACHINE ROOM AREA					
ADDITIONS					
S.N.O.	NO.	PREFIX	LENGTH	BREATH	AREA
A	2	1	5.275	3.300	34.815
B	2	1	0.675	1.800	2.430
C	1	1	8.320	2.200	18.304
D	1	1	3.770	1.100	4.147
TOTAL ADDITION					59.696
SUBTRACTIONS					
S.N.O.	NO.	PREFIX	LENGTH	BREATH	AREA
1	0	0	0.000	0.000	0.000
TOTAL SUBTRACTION					0.000
TOTAL MUMTY MACHINE ROOM AREA					59.696

STAIR CASE AREA (NON F.A.R.)					
ADDITIONS					
S.N.O.	NO.	PREFIX	LENGTH	BREATH	AREA
7	2	1	5.050	3.000	30.300
TOTAL ADDITION					30.300
SUBTRACTIONS					
S.N.O.	NO.	PREFIX	LENGTH	BREATH	AREA
1	0	0	0.000	0.000	0.000
TOTAL SUBTRACTION					0.000
TOTAL STAIR CASE AREA					30.300

LEGEND

1. 100 Ø SOIL PIPE
2. 75 Ø VENT PIPE
3. 100 Ø WASTE WATER PIPE
4. DOM. WATER SUPPLY DN
5. FLUSHING WATER SUPPLY DN
6. DOM. WATER SUPPLY UP
7. FLUSHING WATER SUPPLY UP
8. 100 Ø R.W.P

DOOR WINDOW SCHEDULE

NAME	WIDTH	HEIGHT	QTY	UNIT
DW1	1350	2450	900	2450
DW2	1220	2450	1050	2450
DW3	1600	2450	1050	2450
D1	1050	2150	---	2150
D2	915	2150	---	2150
D3	750	2150	---	2150
W1	1050	2450	900	2450
W1	1050	2450	900	2450
W2	1500	2450	900	2450
V	600	2450	1500	2450

- NOTES:-
1. ALL DIMENSIONS IN MM.
 2. ALL INTERNAL WALLS ARE 100MM BLOCK WORK AND EXTERNAL WALLS ARE 150MM THICK RCC WALL.
 3. LIFT SHALL BE WITH 100% POWER BACKUP.
 4. SCOOTER PARKING PROVIDED AT STILT (0.8X2.5)
 5. D1 ONE HOUR FIRE RATED DOOR

PROPOSED BUILDING PLAN FOR AFFORDABLE GROUP HOUSING COLONY FOR AN AREA MEASURING 4.175 ACRES (LICENSE NO. 16 DATED 01-02-2023) IN SECTOR-37, BHADURGARH, DISTT. JHAJAJAR BEING DEVELOPED BY H. L. RESIDENCY (PROPRIETORSHIP FIRM) THROUGH SMT. SHAILAJA W/O SH. RAKESH JOON.

ARCHITECT:-
VIKAS AHLAWAT ARCHITECTS
ARCHITECTURE, INTERIORS, PLANNING
Unit No. 303, Nriex Time Center, Suncity Sector-54, Golf Course Road Gurgaon
C-0124-4284295 M-09869158488 Mail - ar.vikas.a@rediffmail.com

OWNERS SIGNATURE:-
HL Residency
Auth. Smt.

ARCHITECT SIGNATURE:-
Ar. Vikas Ahlawat
CA/2013C-59

DRAWING TITLE:
TOWER B
FLOOR PLANS & AREA CALCULATION

DATE:- FEB. 2023
SCALE:- 1:100 (A1)

SHEET NO.
T-8-02