


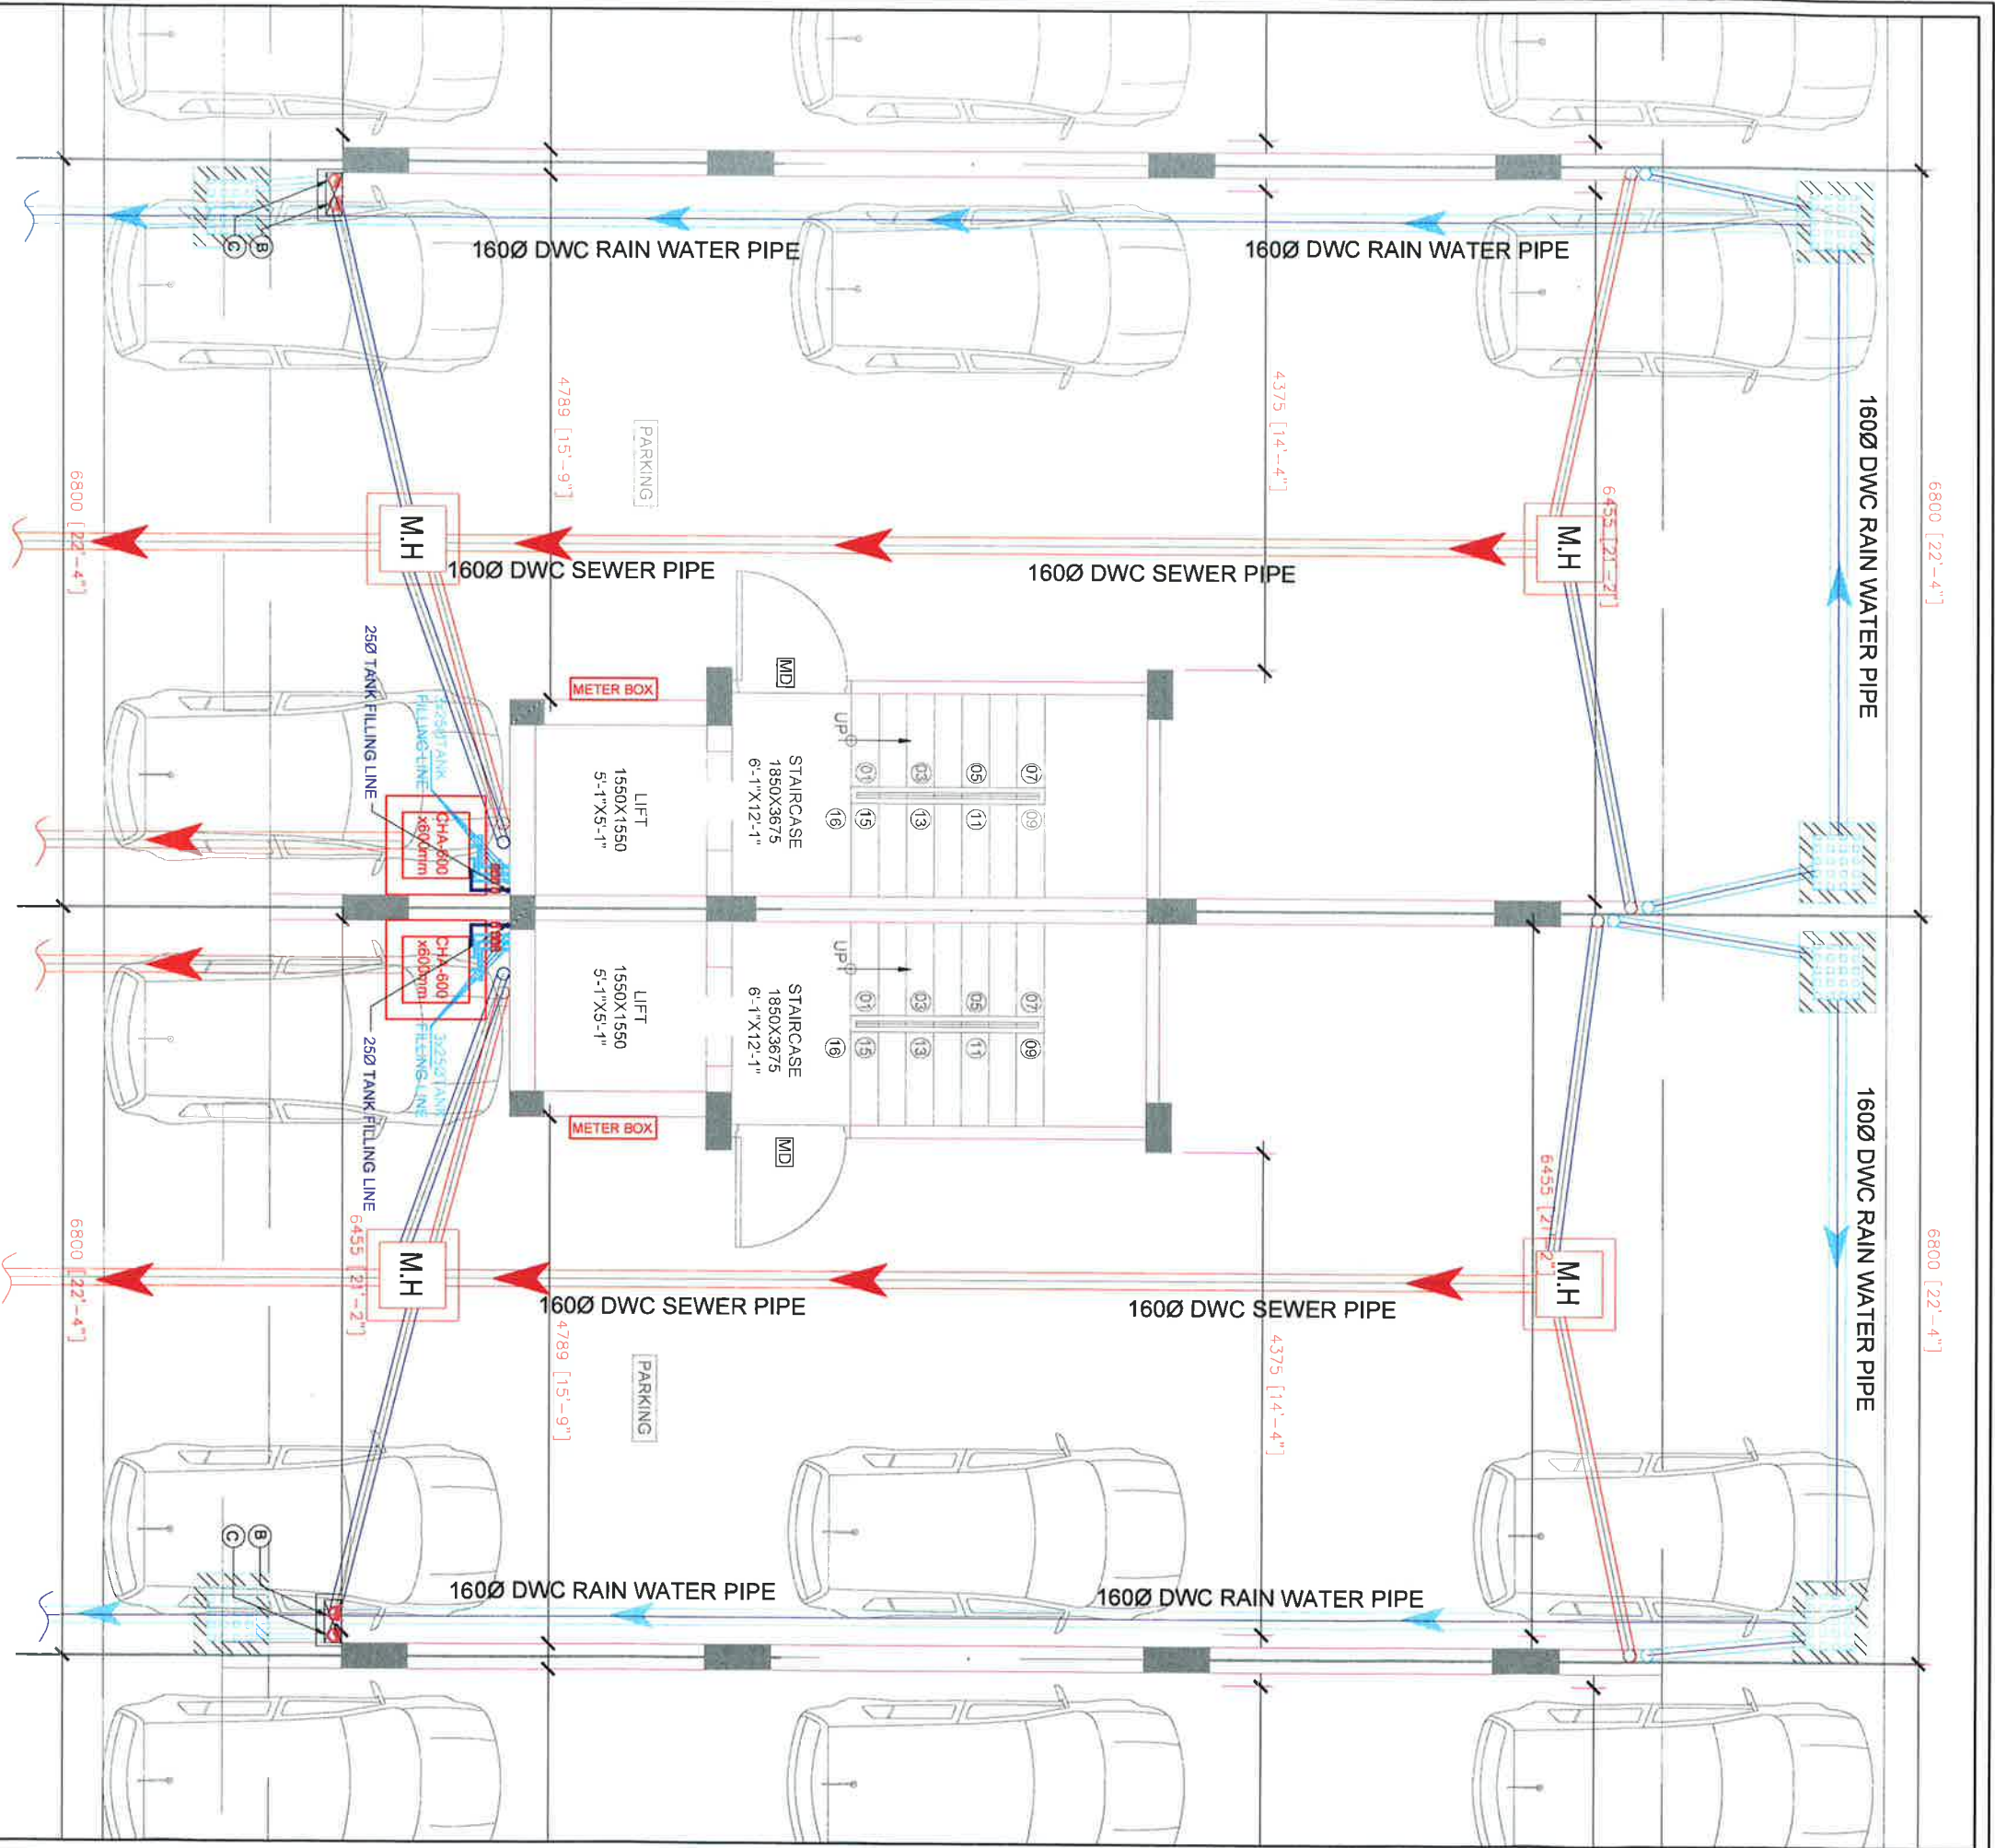

DESCRIPTION OF SYMBOLS USED

SNO.	DESCRIPTION	LEGEND
1.	MANHOLE-1 (600x600)	
2.	DRAIN 300x300	
3.	RAIN WATER COLLECTION CHAMBER (SIZE:450X300X600 DEEP AT START)	
4.	FLOOR TRAP	
5.	DRAIN POINT	
6.	BOTTLE TRAP	
7.	COLD WATER SUPPLY PIPE	
8.	HOT WATER SUPPLY PIPE	
9.	FLESHING WATER SUPPLY PIPE	
10.	SOIL AND VENT PIPE(1100)	
11.	WASTE AND VENT PIPE(1100)	
12.	RAIN WATER PIPE(1100)	
13.	COLD WATER SUPPLY TROOP FROM OVER HEAD WATER TANK	
14.	GROUND LEVEL, INVERT LEVEL AND CONNECTION LEVEL	
15.	DOWN COMER	
16.	KHURRA	

SNO.	DESCRIPTION	SIZE
1.	PIPE FROM WC/UT TO SHAFT (UPVC SOIL PIPE)	110 DIA
2.	PIPE FROM FT TO SHAFT (UPVC WASTE PIPE)	110 DIA
3.	PIPE FROM DP TO TT (UPVC WASTE PIPE)	90 DIA
4.	PIPE FROM BT TO DW/FT (UPVC SOIL & WASTE PIPE)	32 DIA

NOTE :-

- WC - WATER CLOSET
- FT - FLOOR TRAP
- DP - DRAIN POINT
- BT - BOTTLE TRAP



FOR JMK BUILDCON PRIVATE LIMITED

Authorised Signatory

NO	DATE	AS PER DRAWING
REV	DATE	DESCRIPTION

REVISIONS

PROJECT:-
GREENHIA FLOORS BY JMK BUILDCON
PVT. LTD., MET CITY, PLOT NO. 538-547,
POCKET-L, STREET NO.-14, SECTOR-8,
HARYANA-124515

CLIENT:-
JMK BUILDCON PVT LTD

TITLE:-
STILT FLOOR
DRAINAGE LAYOUT

SANITARY PLUMBING DRAWING

DATE	DEALT	CHECKED	APPROVED	STATUS
MAY 2023	P.K.	D.S. YADAV	D.S. YADAV	SUBMISSION DRAWING
DRAWING NO.:-	REVISION	SCALE	NO	N.T.S.
KES-845-0523-PS-01				


SERVICES CONSULTANTS:-

KRISHNA ENGINEERING SERVICES
BUILDING SERVICES AND ENGINEERING CONSULTANTS
B-10, SECTOR-10, GURGAON, HARYANA-122002, INDIA
PHONE # 011-2650 3018, FAX # 2650 3019
Website: www.kesengg.com, Email: kesengg@gmail.com



DREAM SPACE

ARCHITECTS AND INTERIOR DESIGNERS
C-226, SUSHANT SHOPPING ARCADE, SUSHANT LOK-1
GURGAON, HARYANA, MOB: 78985-38568
TEL: 0124-4078295, WEB: WWW.DS-DESIGN.IN

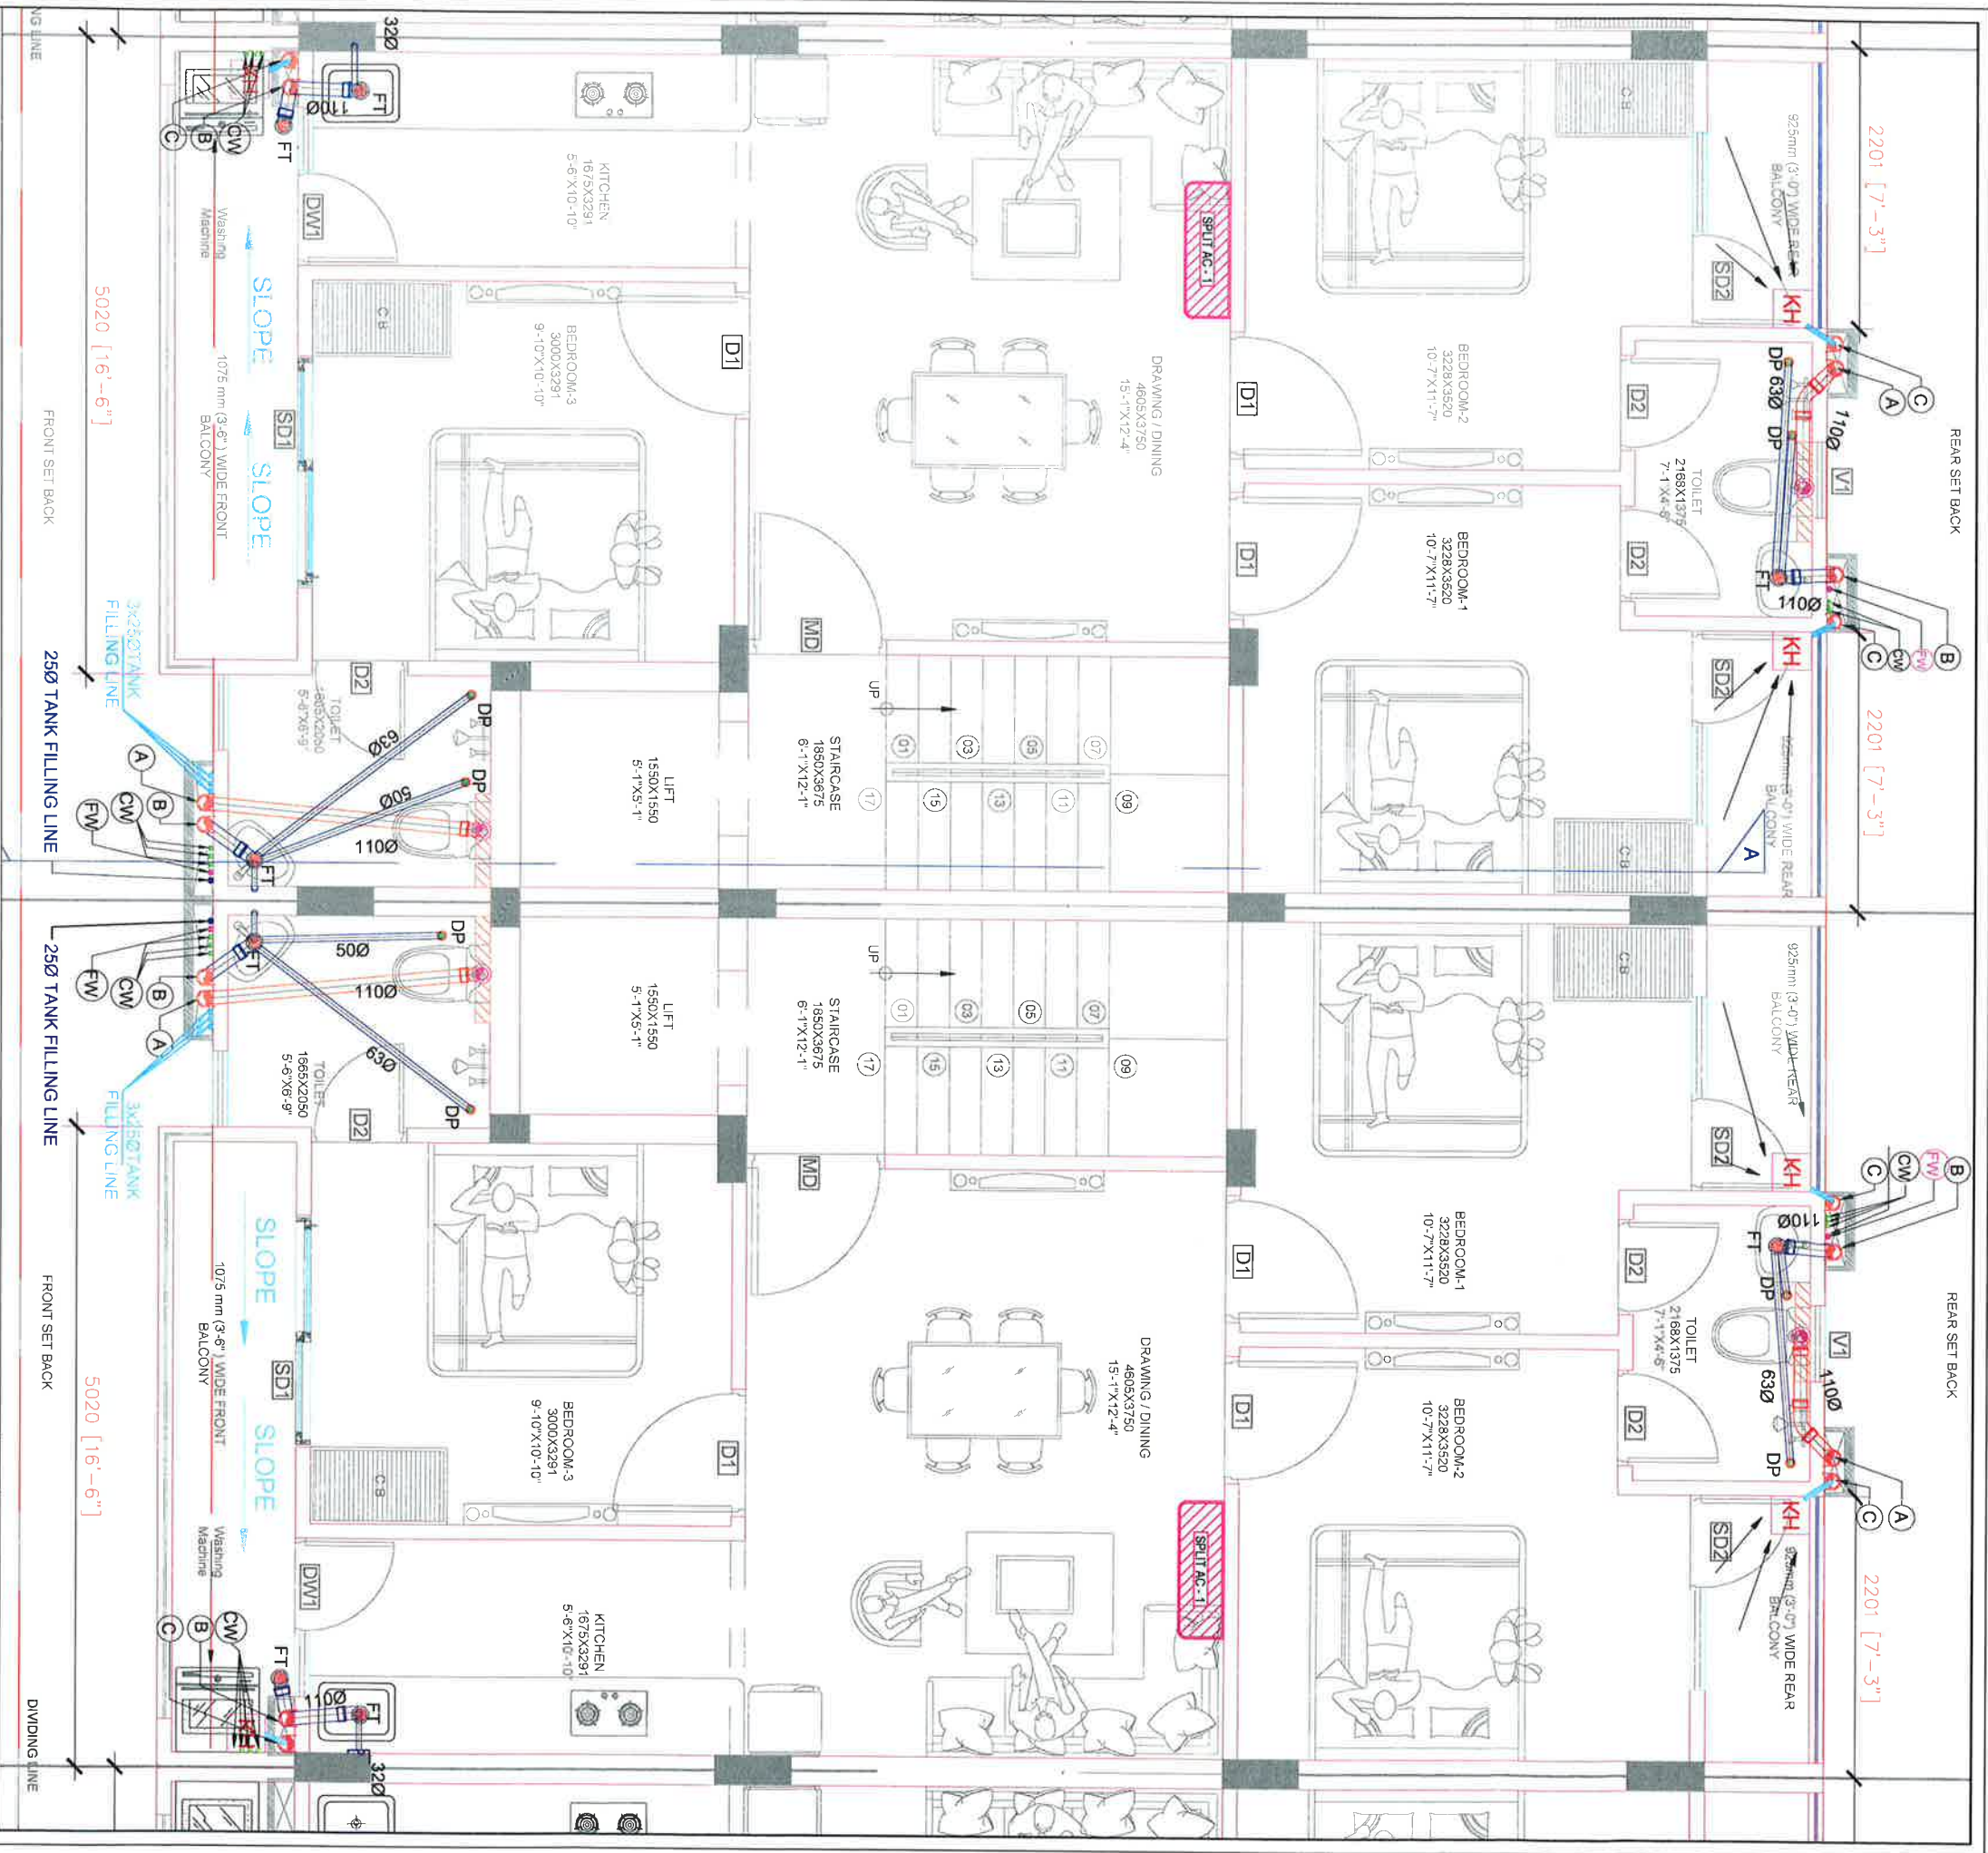

SNO.	DESCRIPTION	LEGEND
1.	MANHOLE-1 (600x600)	
2.	DRAIN 300x300	
3.	RAIN WATER COLLECTION CHAMBER (SIZE 450X300X600 DEEP AT STAKT)	
4.	FLOOR TRAP	
5.	DRAIN POINT	
6.	BOTTLE TRAP	
7.	COLD WATER SUPPLY PIPE	
8.	HOT WATER SUPPLY PIPE	
9.	FLESHING WATER SUPPLY PIPE	
10.	SOIL AND VENT PIPE(1100)	
11.	WASTE AND VENT PIPE(1100)	
12.	RAIN WATER PIPE(1100)	
13.	COLD WATER SUPPLY DROP FROM OVER HEAD WATER TANK	
14.	CONNECTION LEVEL	
15.	DOWN COMER	
16.	KHURRA	

S.NO.	DESCRIPTION	SIZE
1	PIPE FROM WC/UT TO SHAFT (UPVC SOIL PIPE)	110 DIA
2	PIPE FROM FT TO SHAFT (UPVC WASTE PIPE)	110 DIA
3	PIPE FROM DP TO FT (UPVC WASTE PIPE)	50 DIA
4	PIPE FROM BT TO DRAFT (UPVC SOIL & WASTE PIPE)	32 DIA

NOTE : -
WC - WATER CLOSET
FT - FLOOR TRAP
DP - DRAIN POINT
BT - BOTTLE TRAP

For JMK BUILDCON PRIVATE LIMITED
Authorised Signatory



NO

29-05-2023

AS PER DRAWING

REV

DATE

DESCRIPTION

REVISIONS

PROJECT-

GREHEA FLOORS BY JMK BUILDCON PVT. LTD., MET CITY PLOT NO. 538-547, POCKET-L, STREET NO.-14, SECTOR-8, HARYANA-124515

CLIENT-

JMK BUILDCON PVT LTD

TITLE-

TYPICAL FLOOR DRAINAGE LAYOUT

SANITARY PLUMBING D R A W I N G

DATE

DEALT

CHECKED

APPROVED

SUBMISSION

STATUS

MAY 2023

P K

D S YADAV

D S YADAV

REVISION

SCALE

DRAWING NO. -

KES-845-0523-PS-02

SERVICES CONSULTANTS-

KRISHNA ENGINEERING SERVICES

BUILDING SERVICES AND ENGINEERING CONSULTANTS

8, CLUB DRIVE ROAD, JAG ROAD, GHITORJI, NEHRULI

NEW DELHI - 110029 (INDIA)

PHONE # 011-2650 3016 FAX # 2650 3019

EMAIL # info@keshnaengg.com

ARCHITECTS-

DREAM SPACE


ARCHITECTS AND INTERIOR DESIGNERS

G 28, SUSHANT SHOPPING ARCADE, SUSHANT LOK 1

GURGAON, HARYANA INDIA. MOB: 78583-8659

TEL: 0124-4078265, WEB: WWW.DSD-DESIGN.IN



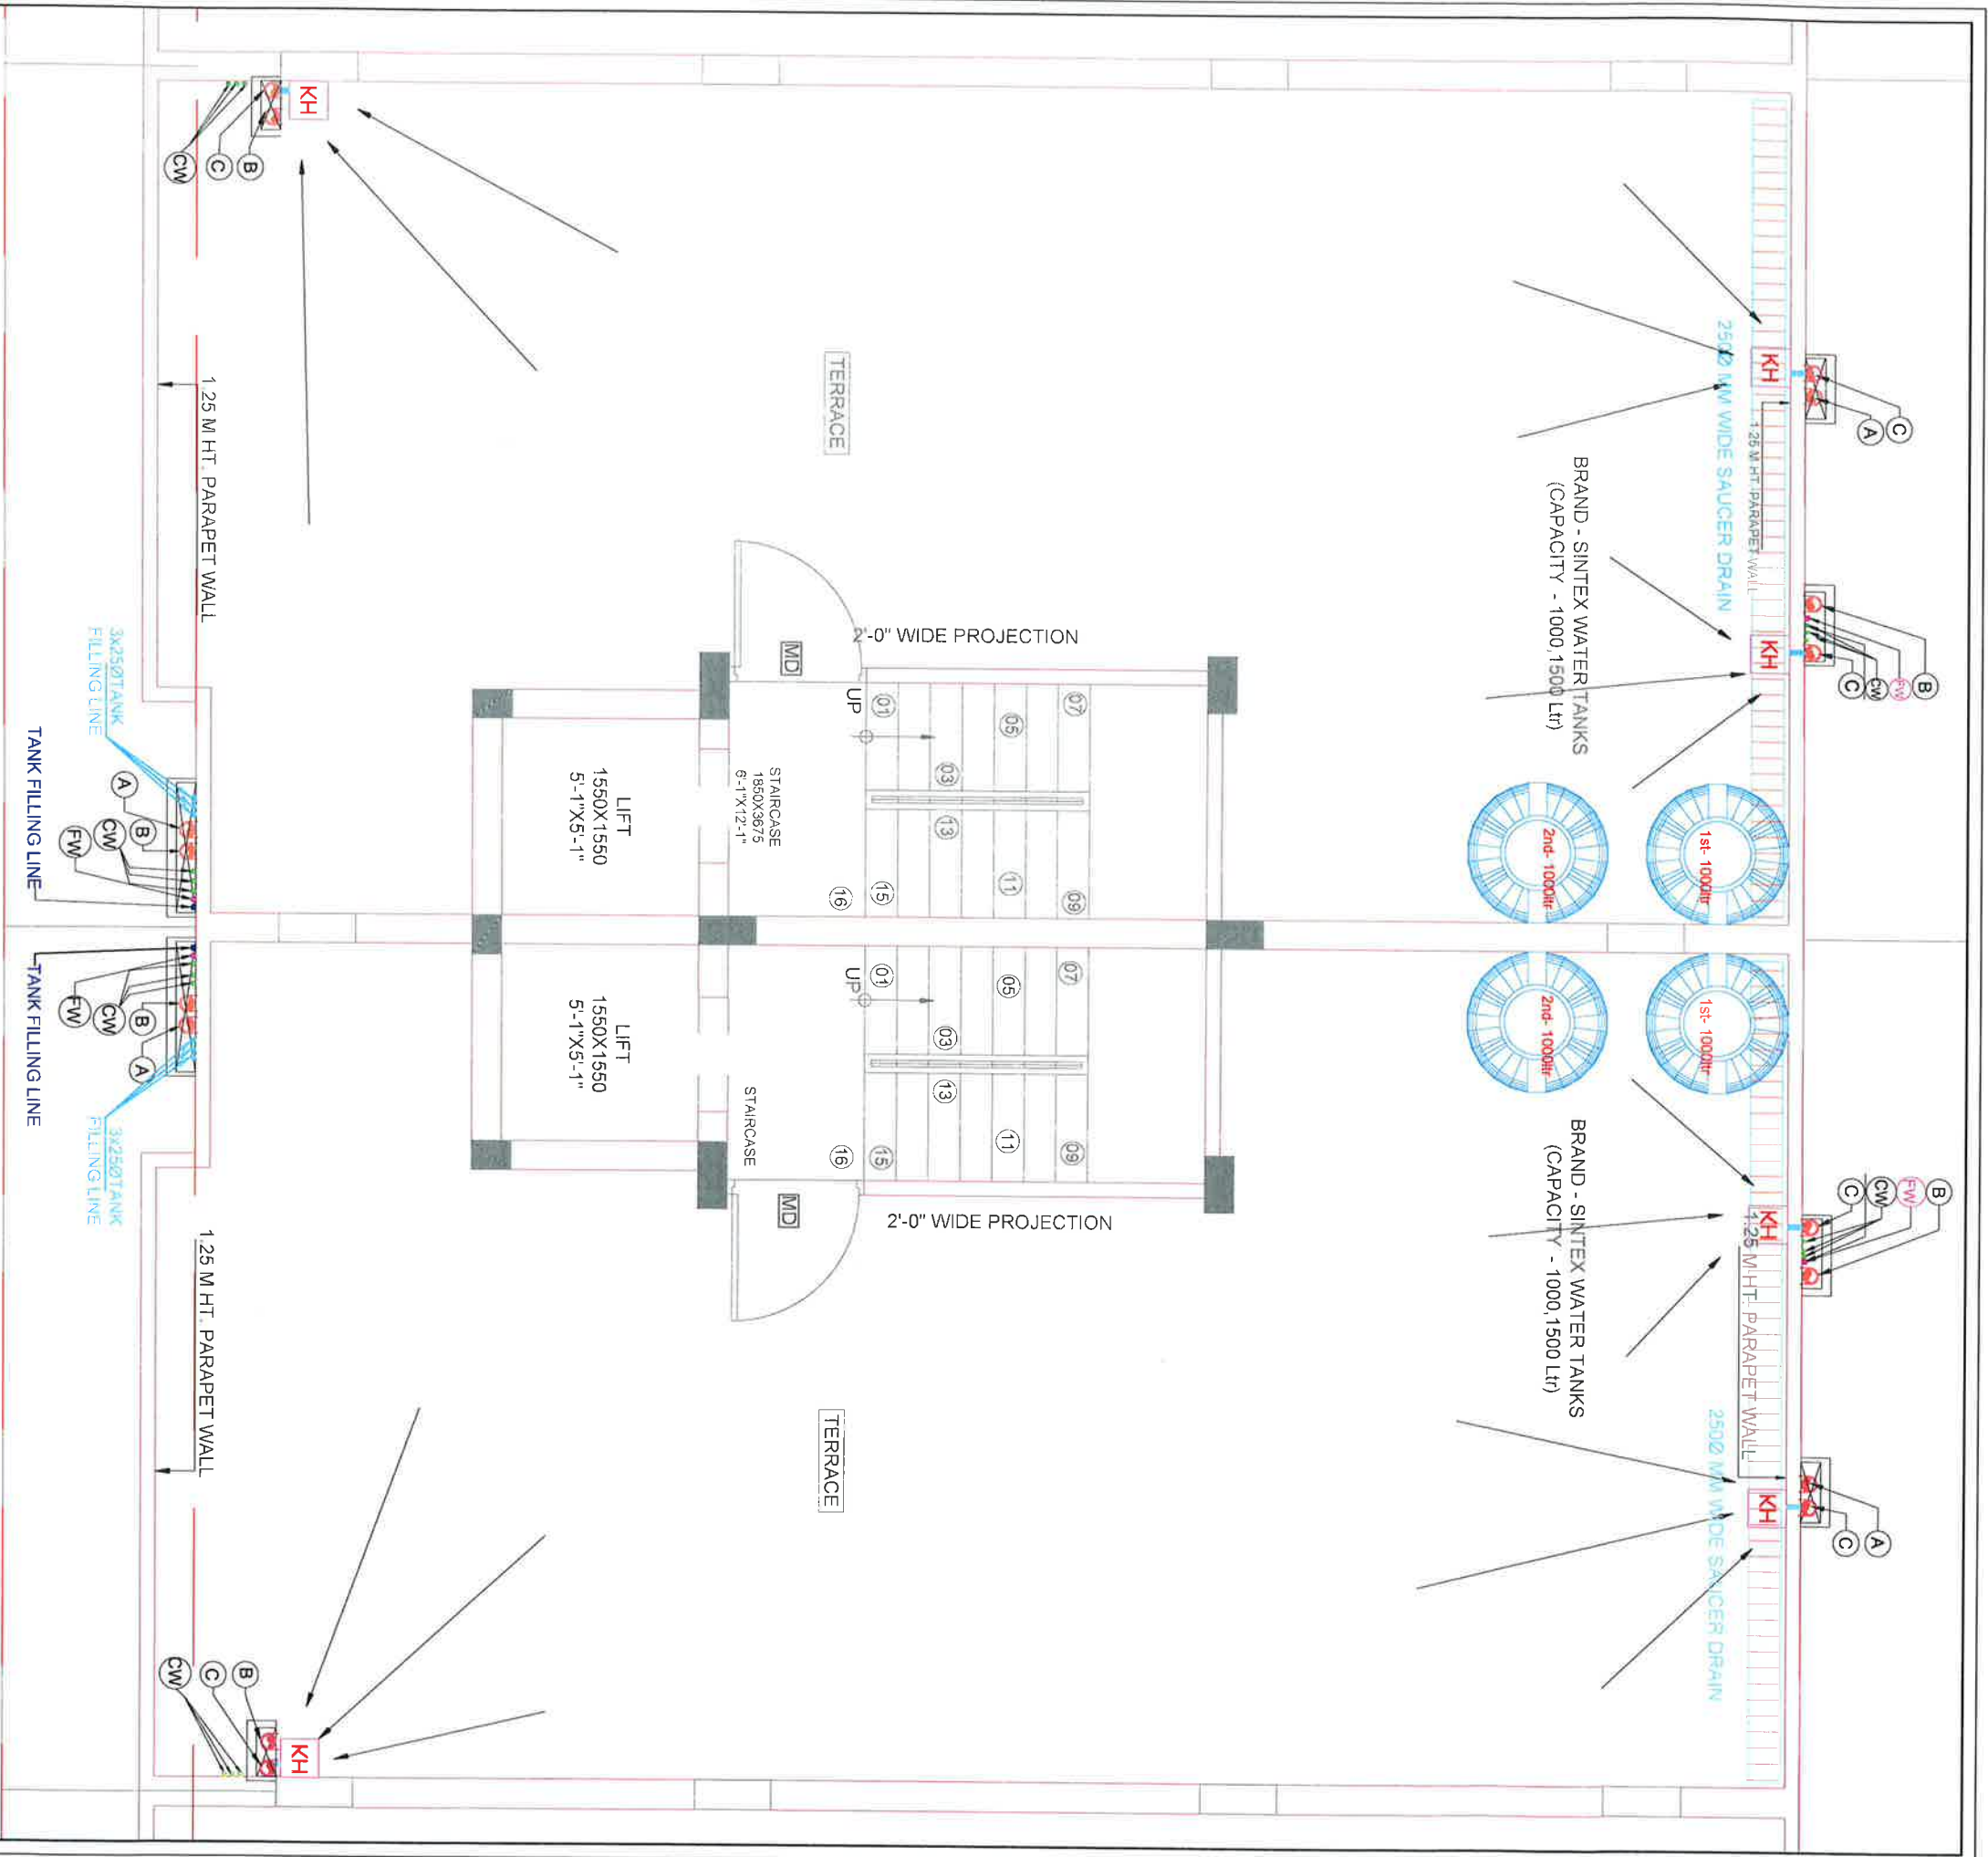

SNO.	DESCRIPTION	LEGEND
1.	MANHOLE-1 (600x600)	
2.	DRAIN 300X300	
3.	RAIN WATER COLLECTION CHAMBER (SIZE 450X300X900 DEEP AT STAKE)	
4.	FLOOR TRAP	
5.	DRAIN POINT	
6.	BOTTLE TRAP	
7.	COLD WATER SUPPLY PIPE	
8.	HOT WATER SUPPLY PIPE	
9.	FLESHING WATER SUPPLY PIPE	
10.	SOIL AND VENT PIPE (100)	
11.	WASTE AND VENT PIPE (100)	
12.	RAIN WATER PIPE (100)	
13.	COLD WATER SUPPLY DROP FROM OVER HEAD WATER TANK	
14.	GROUND LEVEL, INVERT LEVEL AND CONNECTION LEVEL.	
15.	DOWN COMER	
16.	KHURRA	

S.NO.	DESCRIPTION	SIZE
1.	PIPE FROM WC/UT TO SHAFT (UPVC SOIL PIPE)	110 DIA
2.	PIPE FROM FT TO SHAFT (UPVC WASTE PIPE)	110 DIA
3.	PIPE FROM DP TO FT (UPVC WASTE PIPE)	50 DIA
4.	PIPE FROM BT TO DRAFT (UPVC SOIL & WASTE PIPE)	72 DIA

NOTE : -
WC - WATER CLOSET
FT - FLOOR TRAP
DP - DRAIN POINT
BT - BOTTLE TRAP

For JMK BUILDCON PRIVATE LIMITED
Authorised Signatory



RO	29-05-2023	AS PER DRAWING
REV	DATE	DESCRIPTION
REVISIONS		
PROJECT - GREEHAA FLOORS BY JMK BUILDCON PVT. LTD., MET CITY, PLOT NO. 538-547, POCKET-L, STREET NO.-14, SECTOR-8, HARYANA-124515		
CLIENT - JMK BUILDCON PVT LTD		
TITLE - TERRACE FLOOR DRAINAGE LAYOUT		
DRAWING NO. - KES-845-0523-PS-04		
DATE	DEALT	CHECKED
MAY 2023	P. K.	D. S. YADAV
DRAWING NO. -	D. S. YADAV	D. S. YADAV
REVISION	STATUS	SCALE
RO	N.T.S.	N.T.S.
SERVICES CONSULTANTS - KRISHNA ENGINEERING SERVICES		
BUILDING SERVICES AND ENGINEERING CONSULTANTS		
8, CLUB DRIVE ROAD, MG ROAD, GHITOLI, MUMBAI		
NEW DELHI - 110035 (INDIA)		
PHONE : 8111-28503016, FAX : 28503019		
Website : www.krishnaengg.in, Email : info@krishnaengg.in		
ARCHITECTS - DREAM SPACE		
ARCHITECTS AND INTERIOR DESIGNERS		
C-726, SUSHANT SHOPPING ARCADE, SUSHANT LOK 1		
GURGAON, HARYANA, MOB : 8896-38589		
TEL : 0124-4019266, WEB : WWW.DS-DESIGN.IN		