


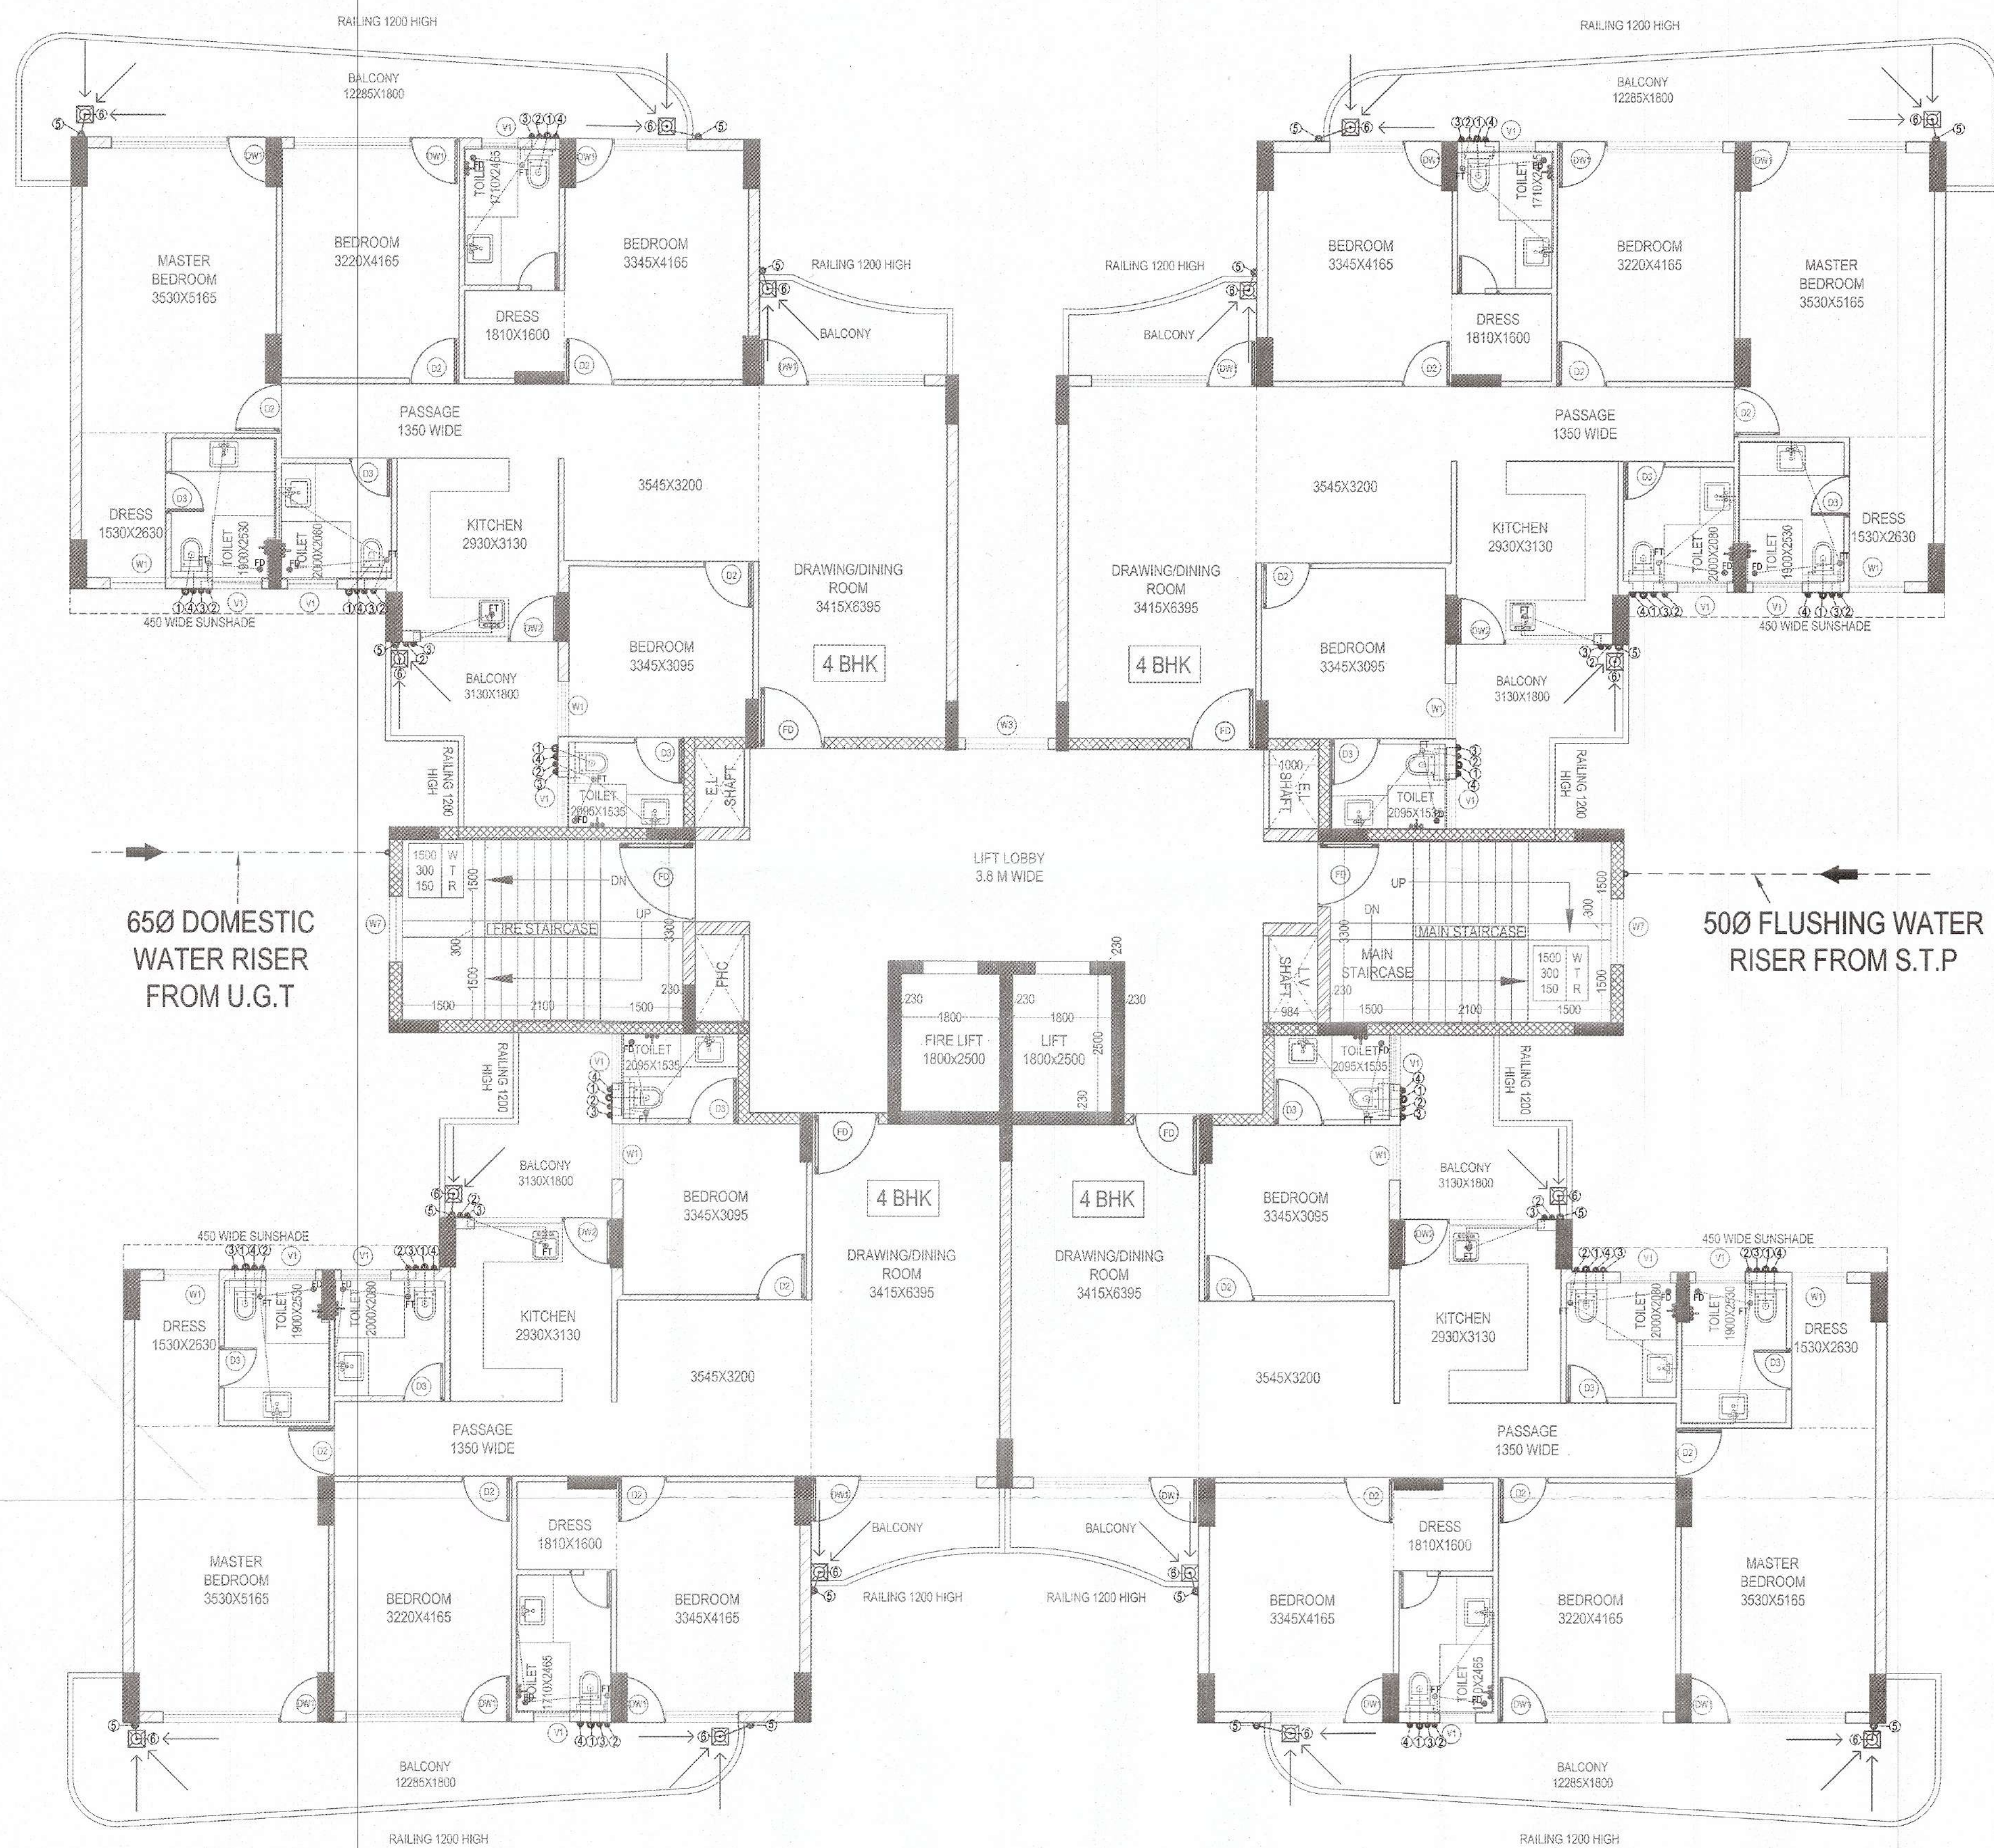

PLUMBING LEGEND:-

①	100 OD uPVC SOIL PIPE
②	100 OD uPVC WASTE PIPE
③	65Ø CPVC DWS DN TAKE PIPE
④	50Ø CPVC FWS DN TAKE PIPE
⑤	100 OD uPVC RAIN WATER
⑥	KHURRA 450x450mm
⑦	65Ø DWS RISER PIPE
⑧	50Ø FWS RISER PIPE
⑨	100Ø WASTE PIPE
⑩	100Ø SOIL PIPE
⑪	75 Ø RAIN WATER PIPE
⑫	FT FLOOR TRAP
⑬	FD FLOOR DRAIN
⑭	REG FLOOR CLEAN OUT
⑮	STP PORTANCE (PLUG)
⑯	Member B.P.A.C.
⑰	Member B.P.A.C.
⑱	Member B.P.A.C.
⑲	Member B.P.A.C.
⑳	Member B.P.A.C.
㉑	Member B.P.A.C.
㉒	Member B.P.A.C.
㉓	Member B.P.A.C.
㉔	Member B.P.A.C.
㉕	Member B.P.A.C.
㉖	Member B.P.A.C.
㉗	Member B.P.A.C.
㉘	Member B.P.A.C.
㉙	Member B.P.A.C.
㉚	Member B.P.A.C.
㉛	Member B.P.A.C.
㉜	Member B.P.A.C.
㉝	Member B.P.A.C.
㉞	Member B.P.A.C.
㉟	Member B.P.A.C.
㊱	Member B.P.A.C.
㊲	Member B.P.A.C.
㊳	Member B.P.A.C.
㊴	Member B.P.A.C.
㊵	Member B.P.A.C.
㊶	Member B.P.A.C.
㊷	Member B.P.A.C.
㊸	Member B.P.A.C.
㊹	Member B.P.A.C.
㊺	Member B.P.A.C.
㊻	Member B.P.A.C.
㊼	Member B.P.A.C.
㊽	Member B.P.A.C.
㊾	Member B.P.A.C.
㊿	Member B.P.A.C.

SANCTIONED
TO BE READ WITH THIS OFFICE
MEMO NO.:
DATED:

SP

PA

AP

Building plans have been checked and found in order
as per Public Health Services point of view.

EE(W/S)
GMDA

EE(Manager)
GMDA

EE(Super)
GMDA

EE(Nodal Officer)
Infra-II, GMDA

EE(Infra-II)
GMDA

PROJECT:

PROPOSED BUILDING PLAN OF
GROUP HOUSING COLONY
OVER AN AREA MEASURING
4.1875 ACRES UNDER TOD
POLICY (LICENCE NO 97 OF
2021 DATED 12.11.2021)
IN SECTOR 103, GURUGRAM,
DEVELOPED BY SUNITA KUMARI
W/o SH. ASHOK KUMAR &
OTHERS IN COLLABORATION
WITH M/s AVIANA GREEN
ESTATES PVT. LTD.

SHEET TITLE:

**TOWER - A
TYPICAL FLOOR PLAN
PLUMBING LAYOUT**

MEP CONSULTANT:
V.S. KUKREJA & ASSOCIATES PVT. LTD.
CONSULTING ENGINEERS
105-A GAUTAM NAGAR
NEW DELHI-110049 PH: 28521075/6
EMAIL: info@vskukreja.com

ARCHITECT:

ARCHITECTS AND CONSULTANTS

AE STUDIO

an architectural design studio

A-6, GREEN PARK EXT.,
NEW DELHI-110016 Ph: 011-47350366
E-Mail: info@ae-studio.in Web: www.ae-studio.in

DATE

18-11-2022

SCALE

1:100

NORTH

30

SHEET SIZE

A2

CLIENT SIGNATURE

ARCHITECT SIGNATURE

For AVIANA GREENESTATES PVT. LTD.

Director

Sandeep Tandon

Architect

CA/97121634