
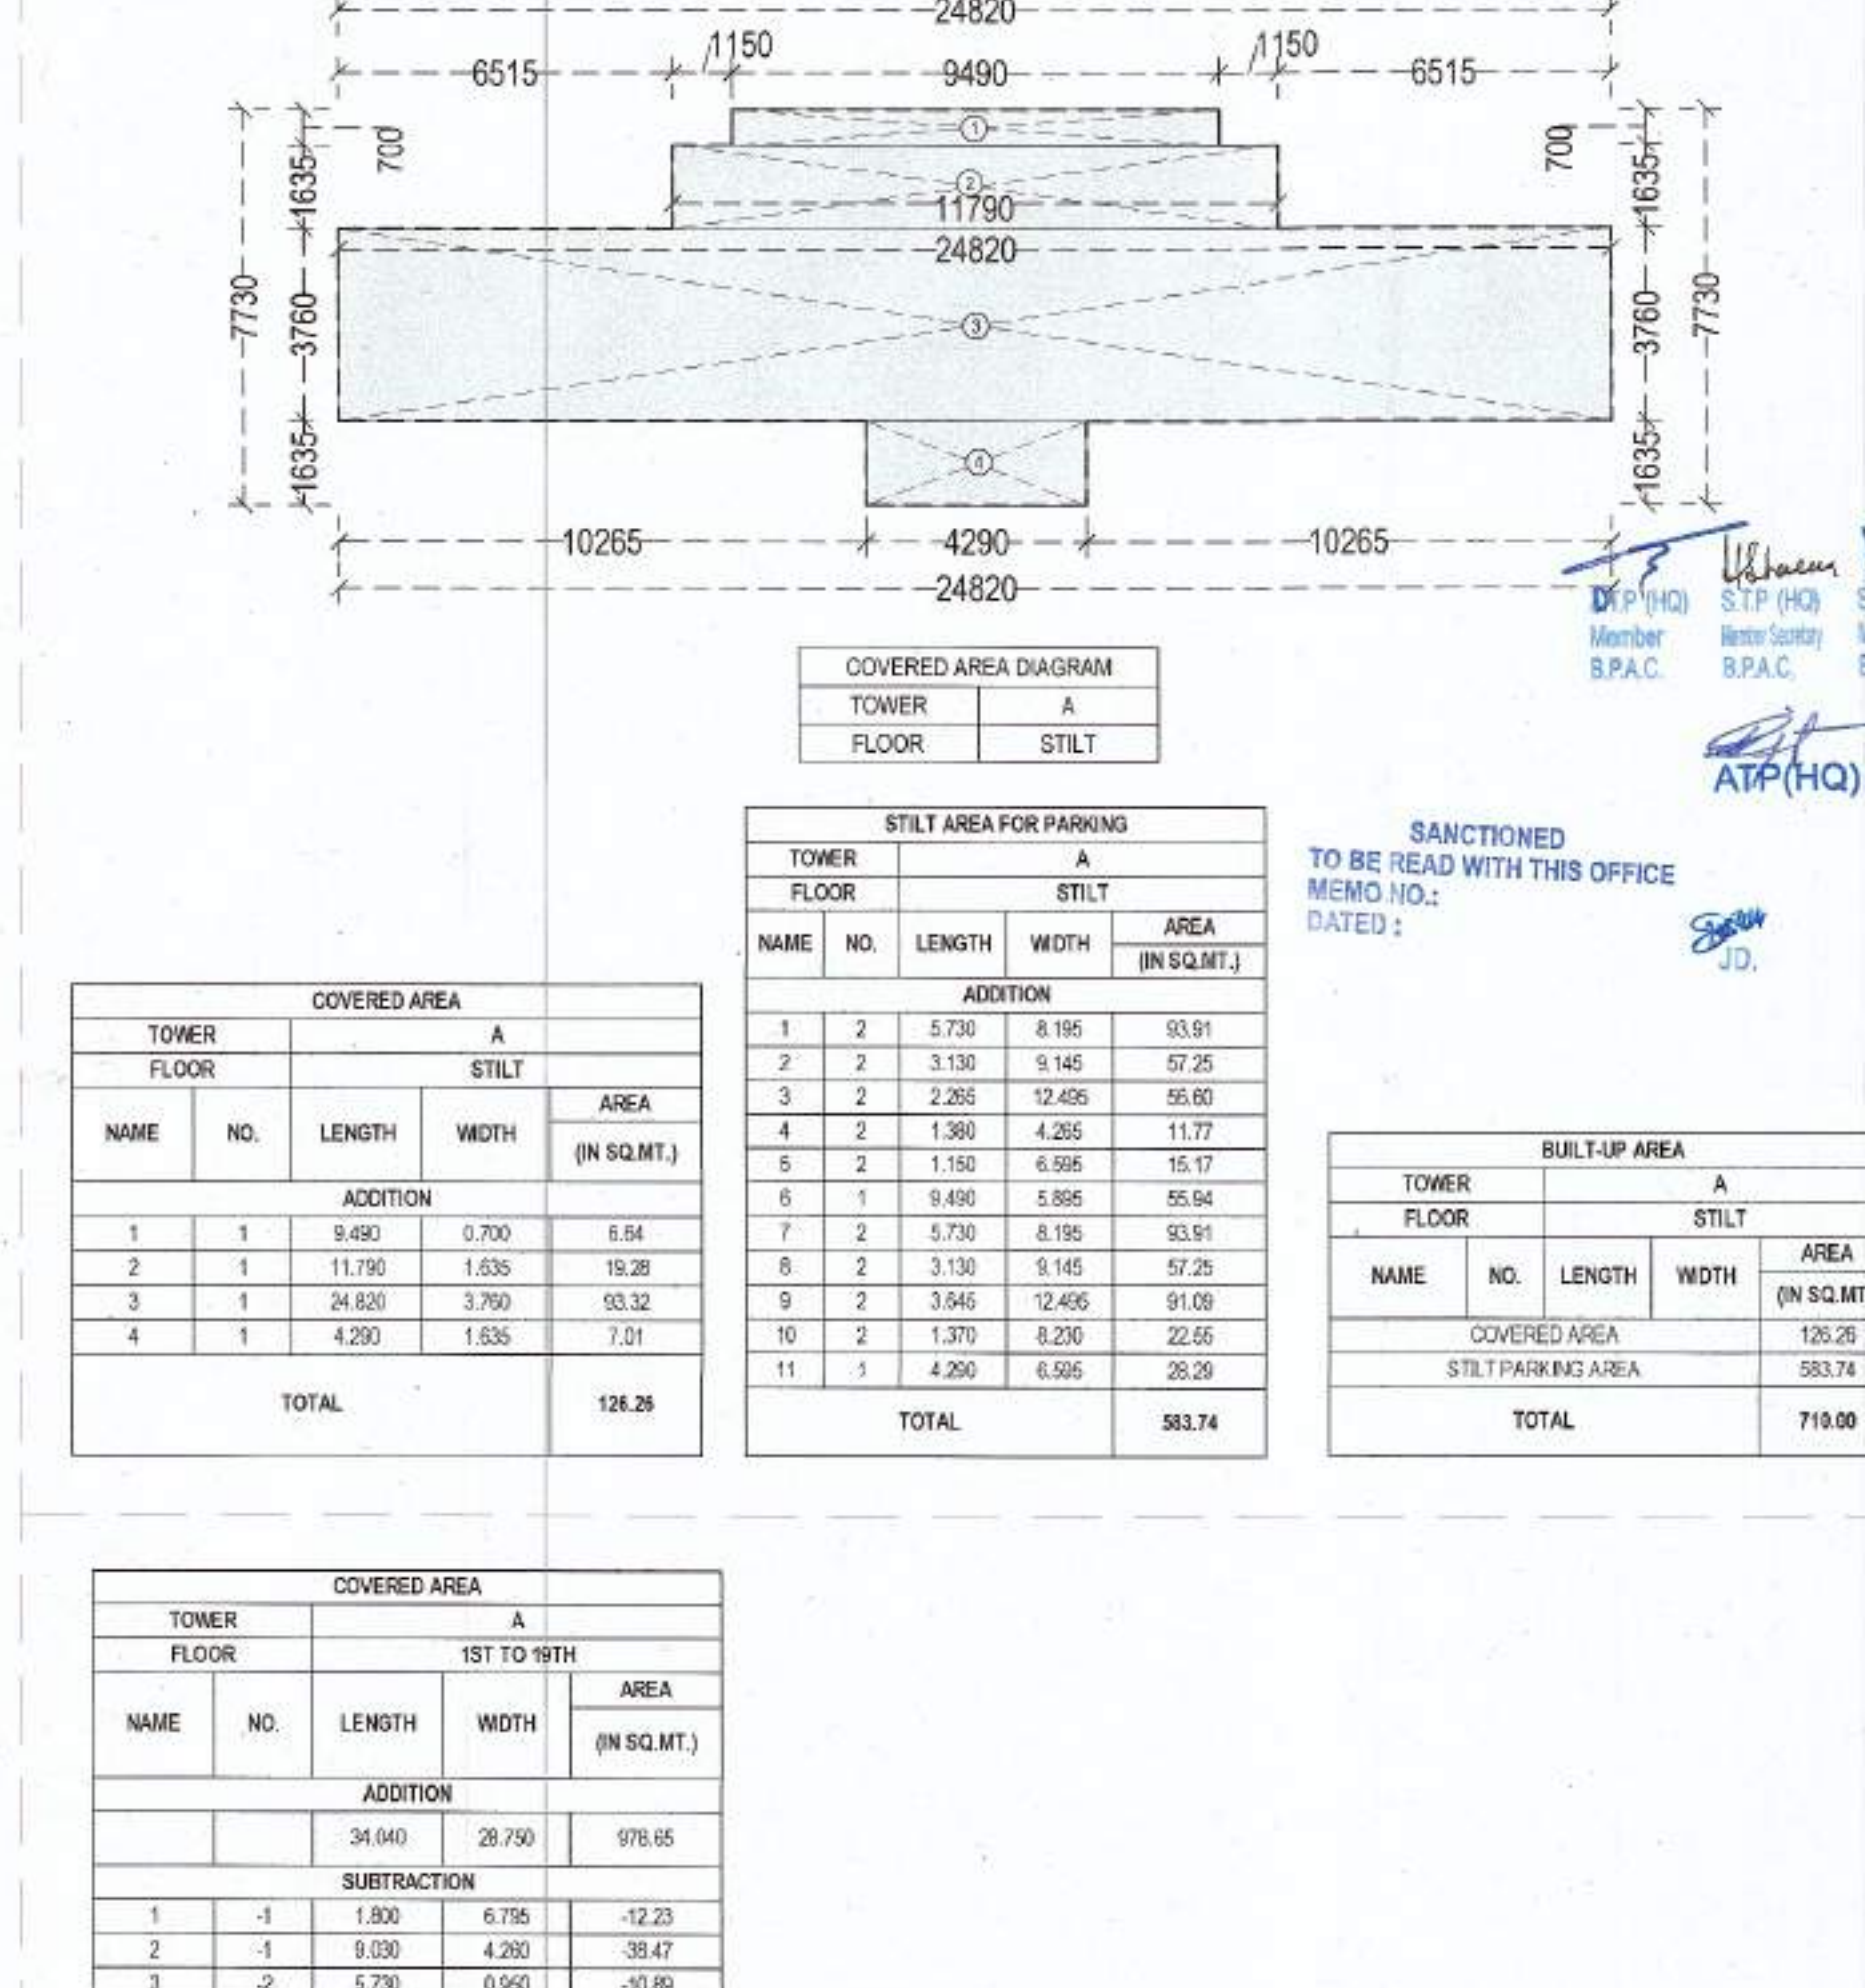
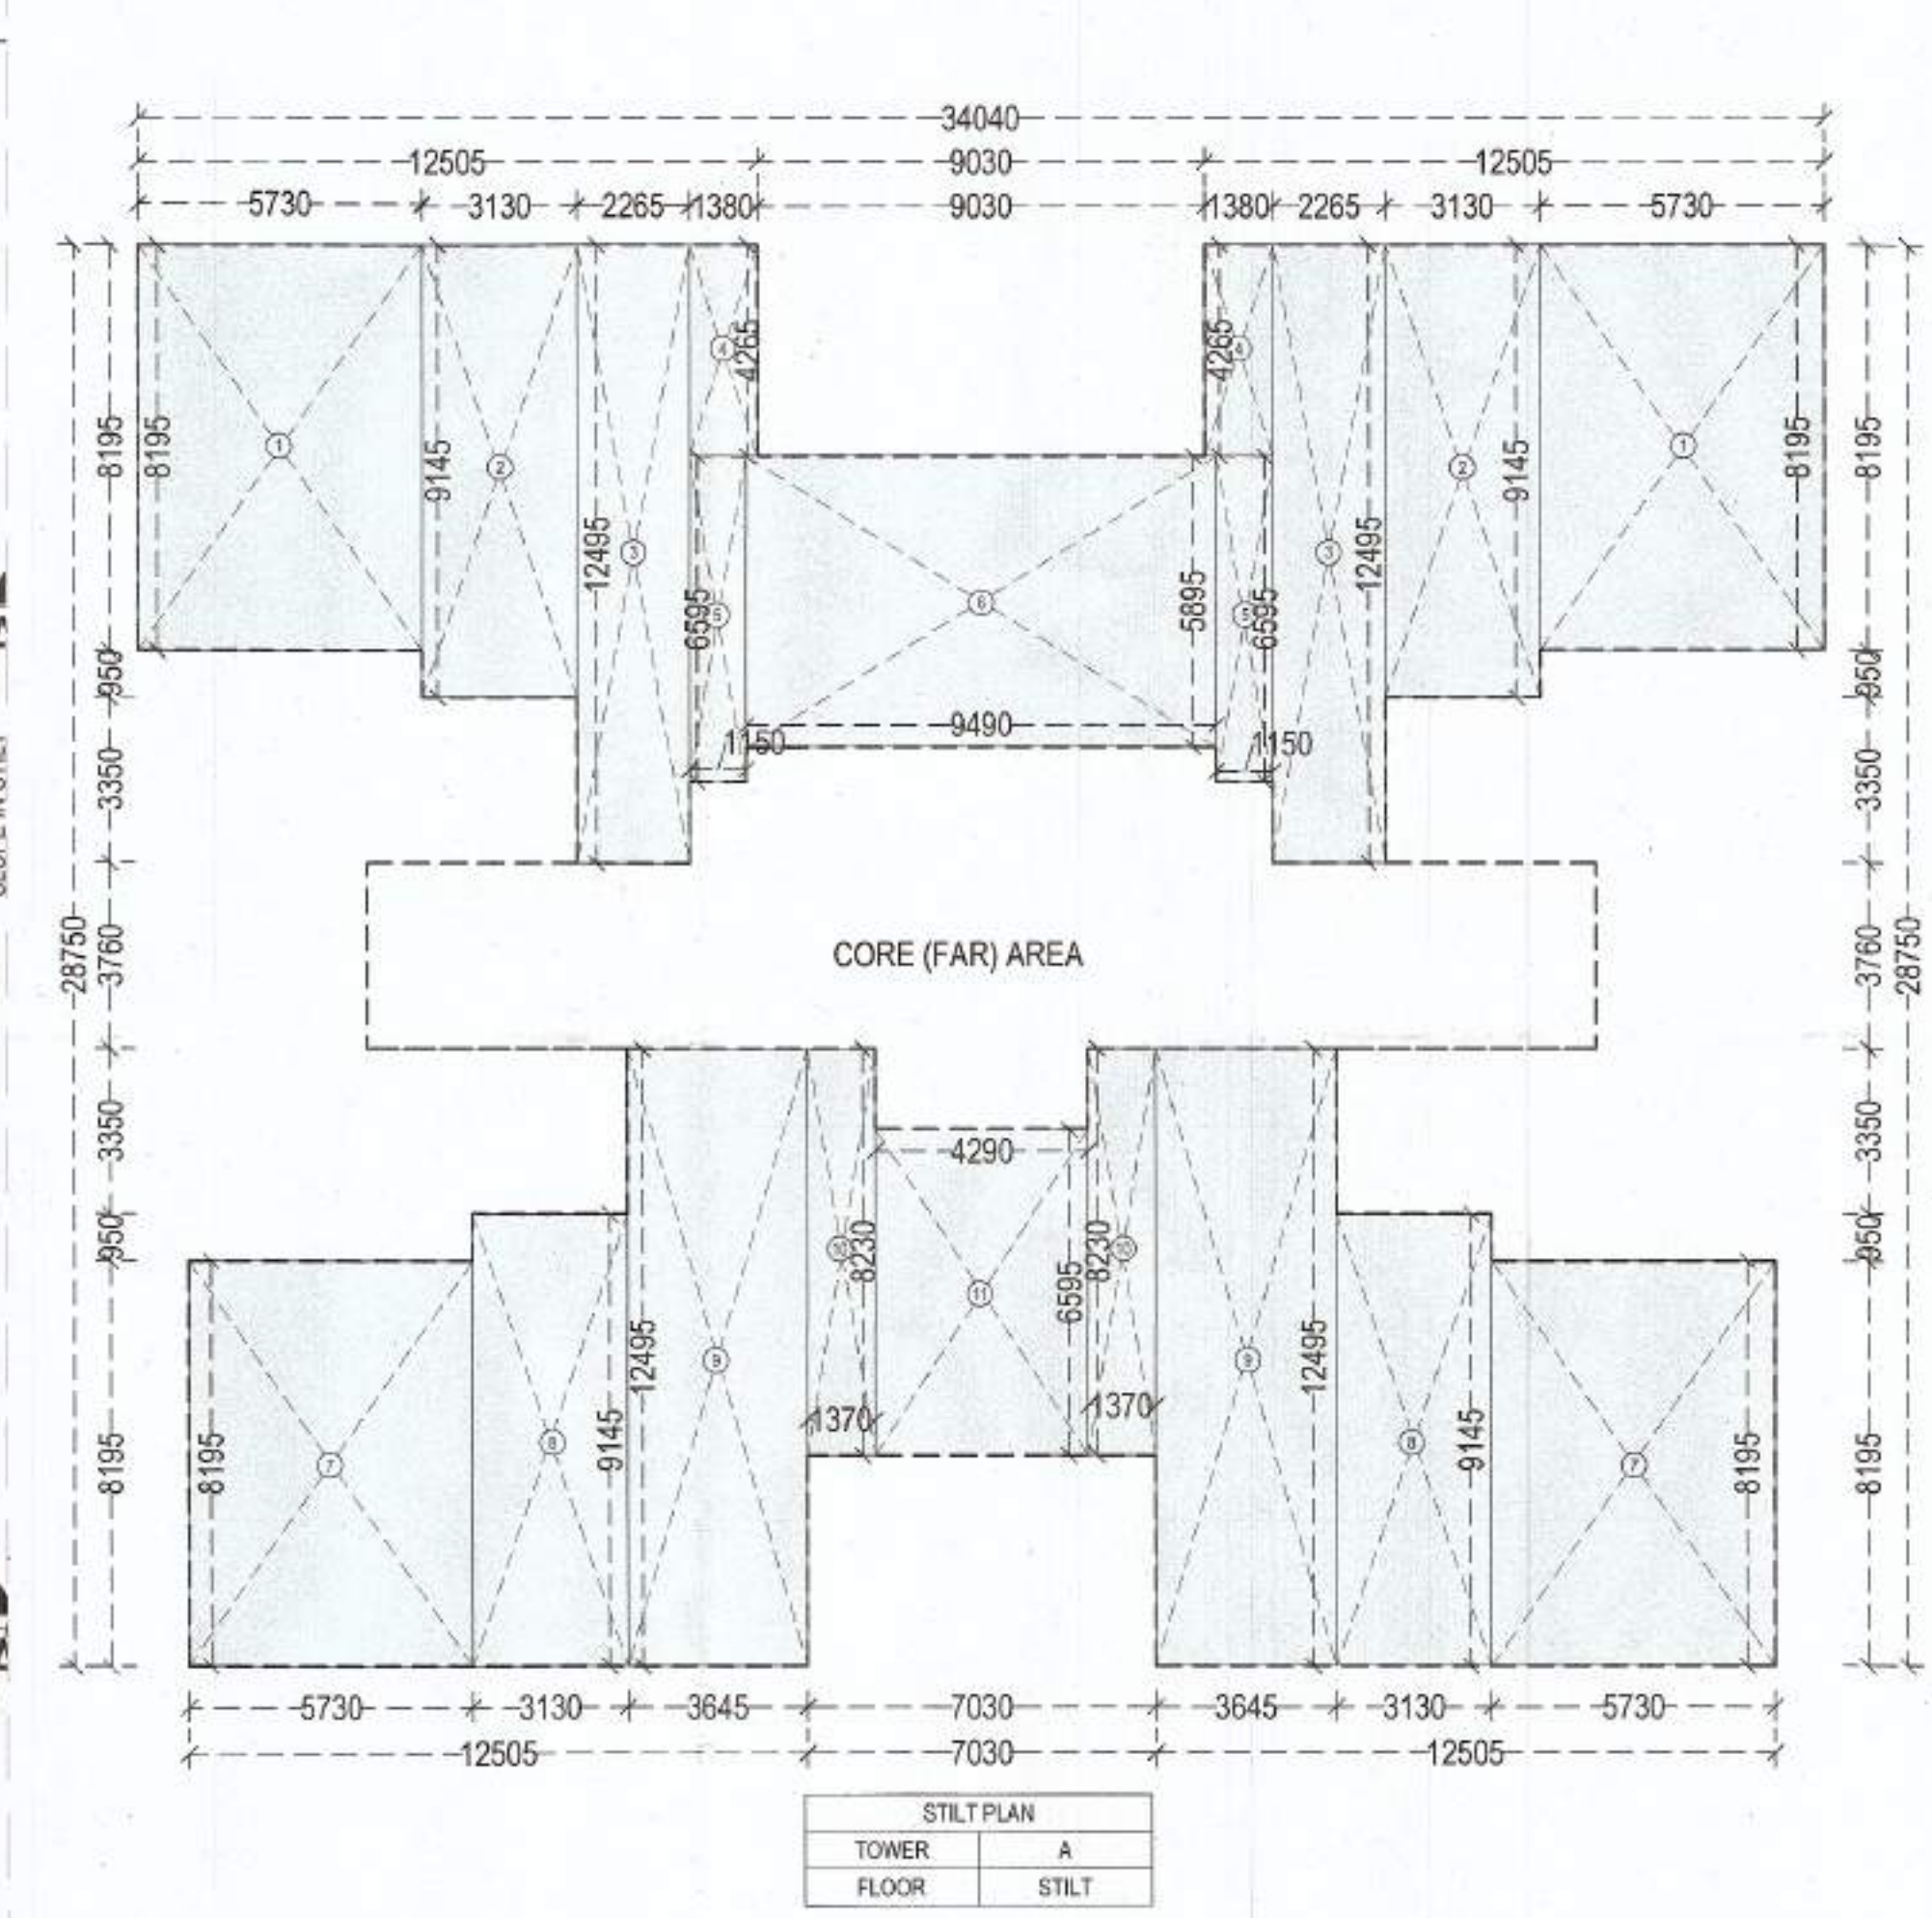




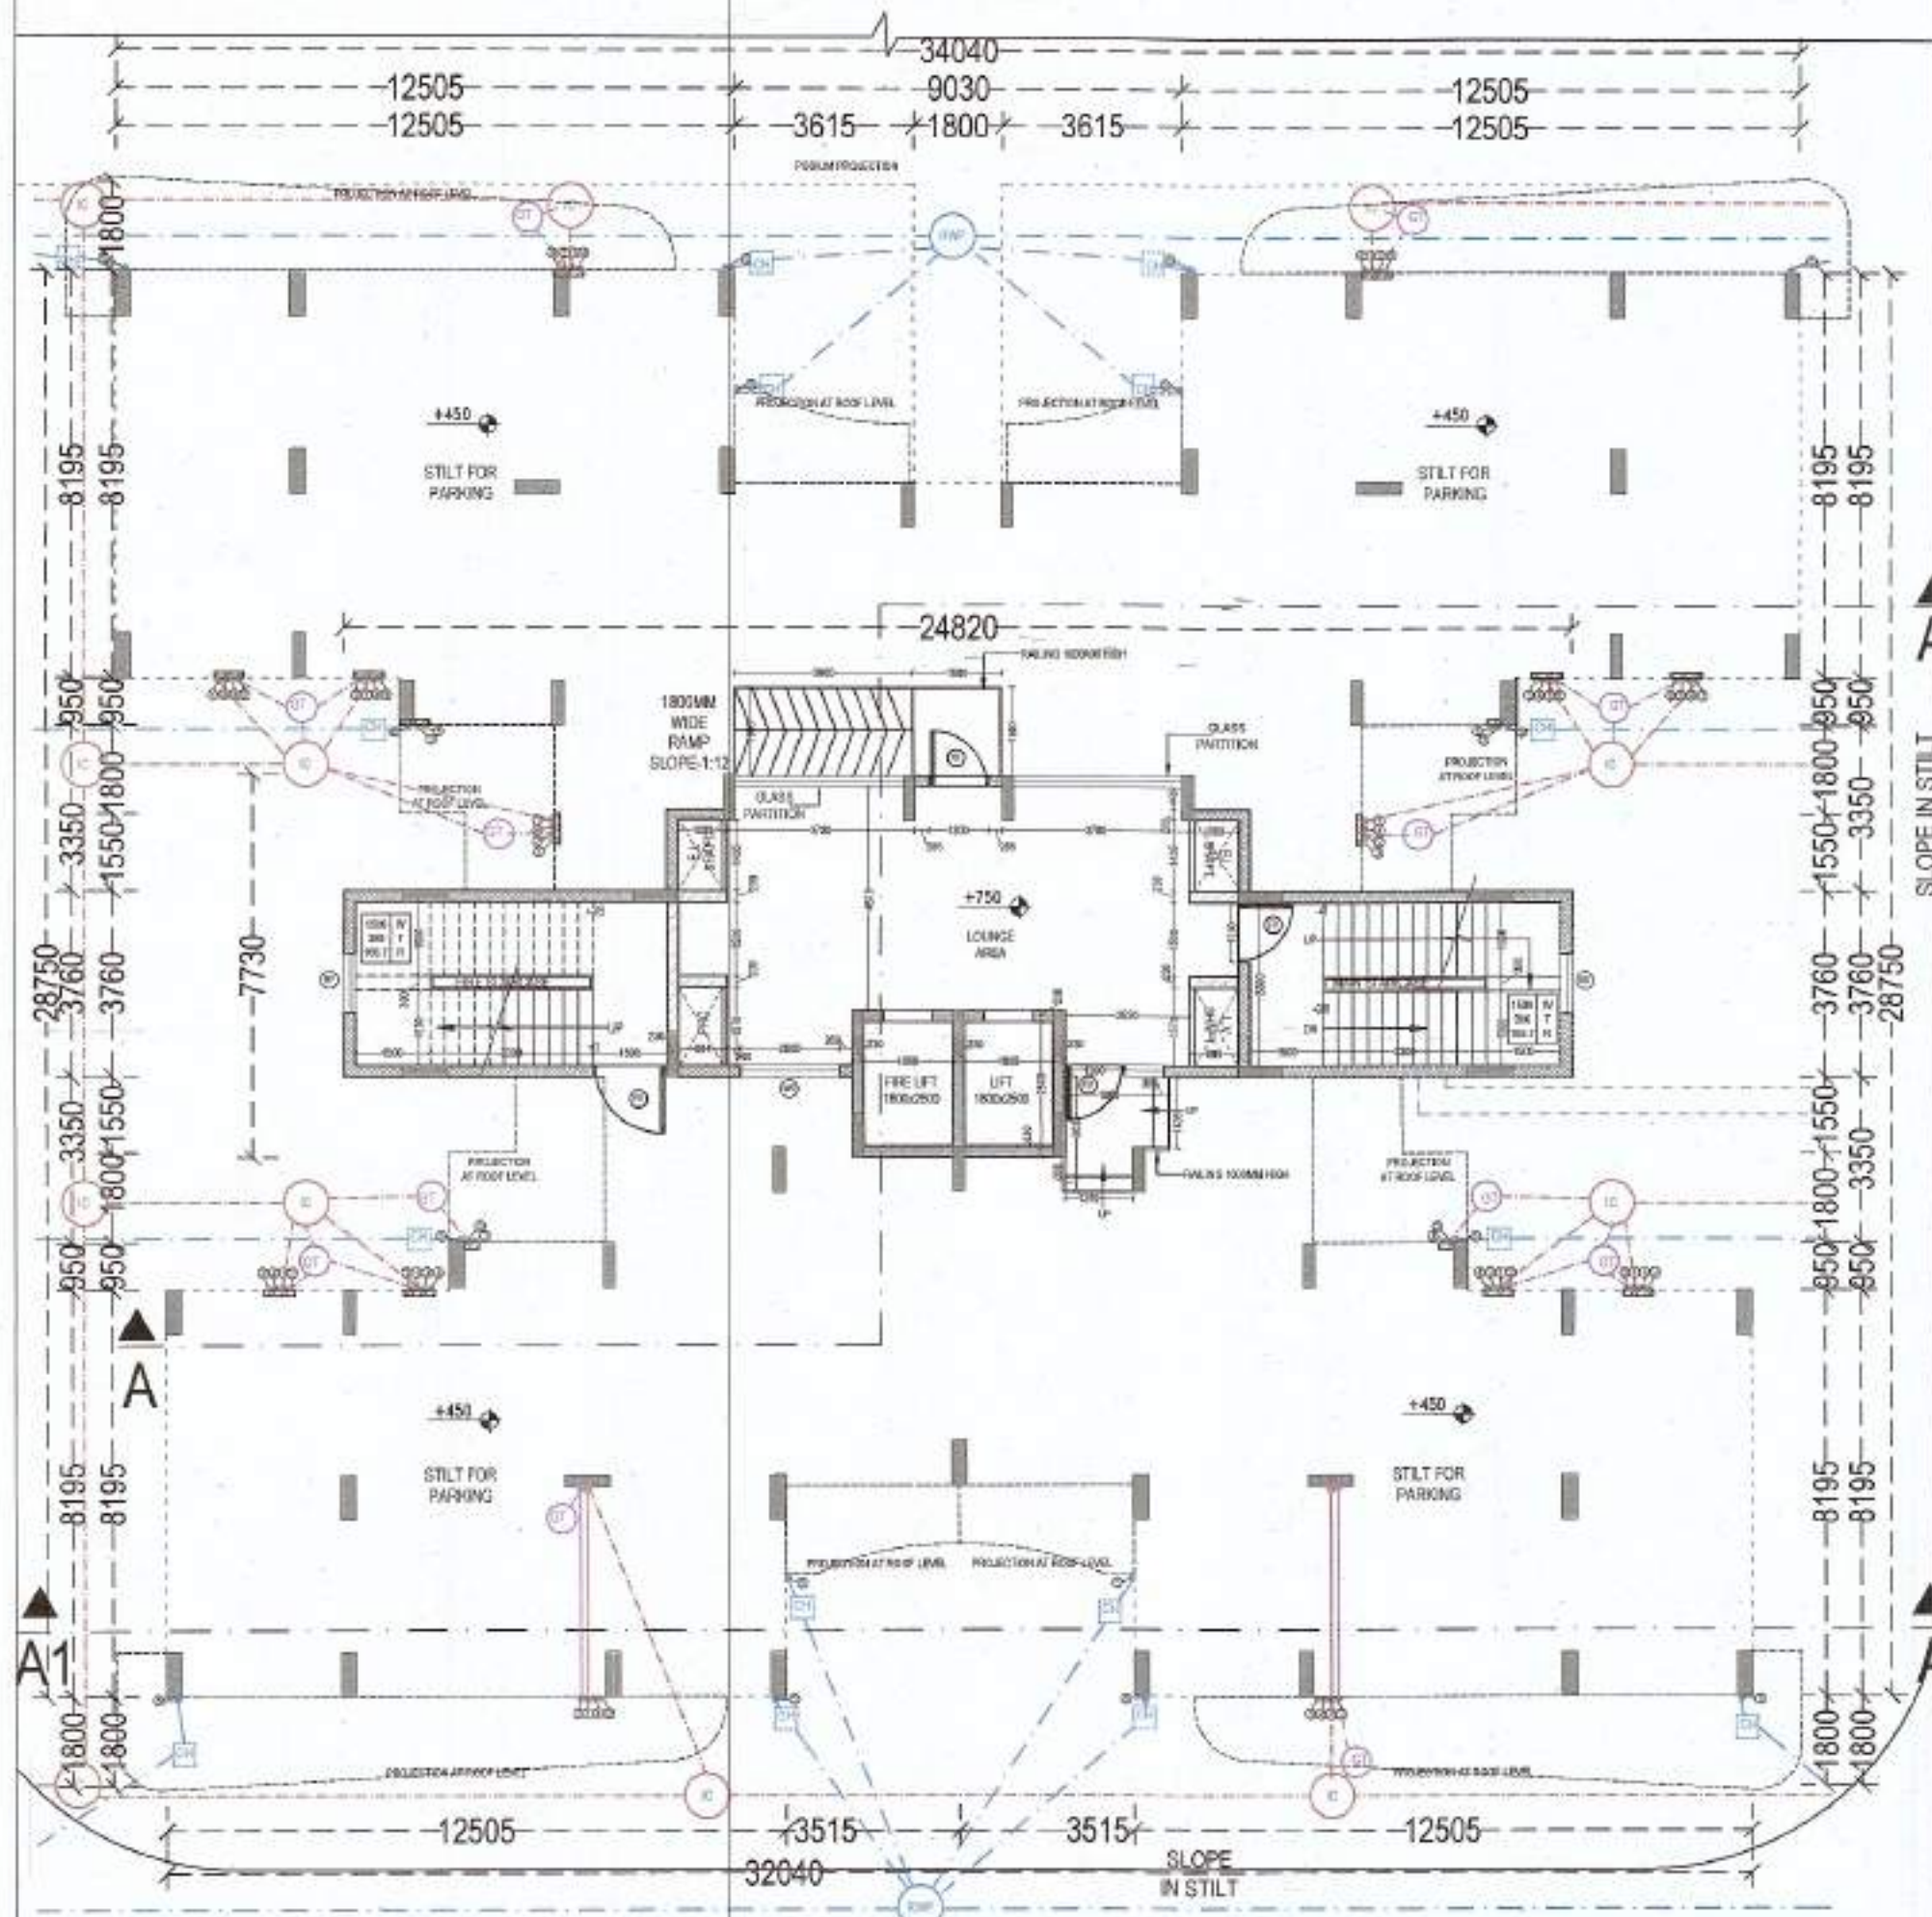


PLUMBING LEGEND

- 100 ØD uPVC SOIL PIPE
- 100 ØD uPVC WASTE PIPE
- 65Ø CPVC DWS DRAIN TAKE PIPE
- 50Ø CPVC FWS DRAIN TAKE PIPE
- 100 ØD uPVC RAIN WATER
- 65Ø DWS RISER PIPE
- 50Ø FWS RISER PIPE
- 100Ø WASTE PIPE
- 100Ø SOIL PIPE
- 75 Ø RAIN WATER PIPE
- FT FLOOR TRAP
- FD FLOOR DRAIN
- FC FLOOR CLEAN OUT
- FO FLOOR OUT PLUG
- FO OUT SIZE-150x150mm

JOINERY

SR. NO.	NAME	WIDTH	CLL	LINTEL
1	D1	1200	0	2500
2	D2	1050	0	2500
3	D3	750	0	2500
4	D4	500	0	2500
5	W1	3000	500	2500
6	W2	1000	600	2500
7	W3	1500	1050	2500
8	W4	1050	1050	2500
9	W5	2000	500	2500
10	W6	700	1050	2500
11	DW1	3000	0 & 900	2500
12	DW2	2500	0 & 1050	2500
13	DW3	2000	0 & 900	2500
14	DW4	1500	0 & 900	2500
15	DW5	1350	0 & 1050	2500
16	V1	500	1050	2500
17	V2	750	1050	2500
18	V3	1500	1050	2500

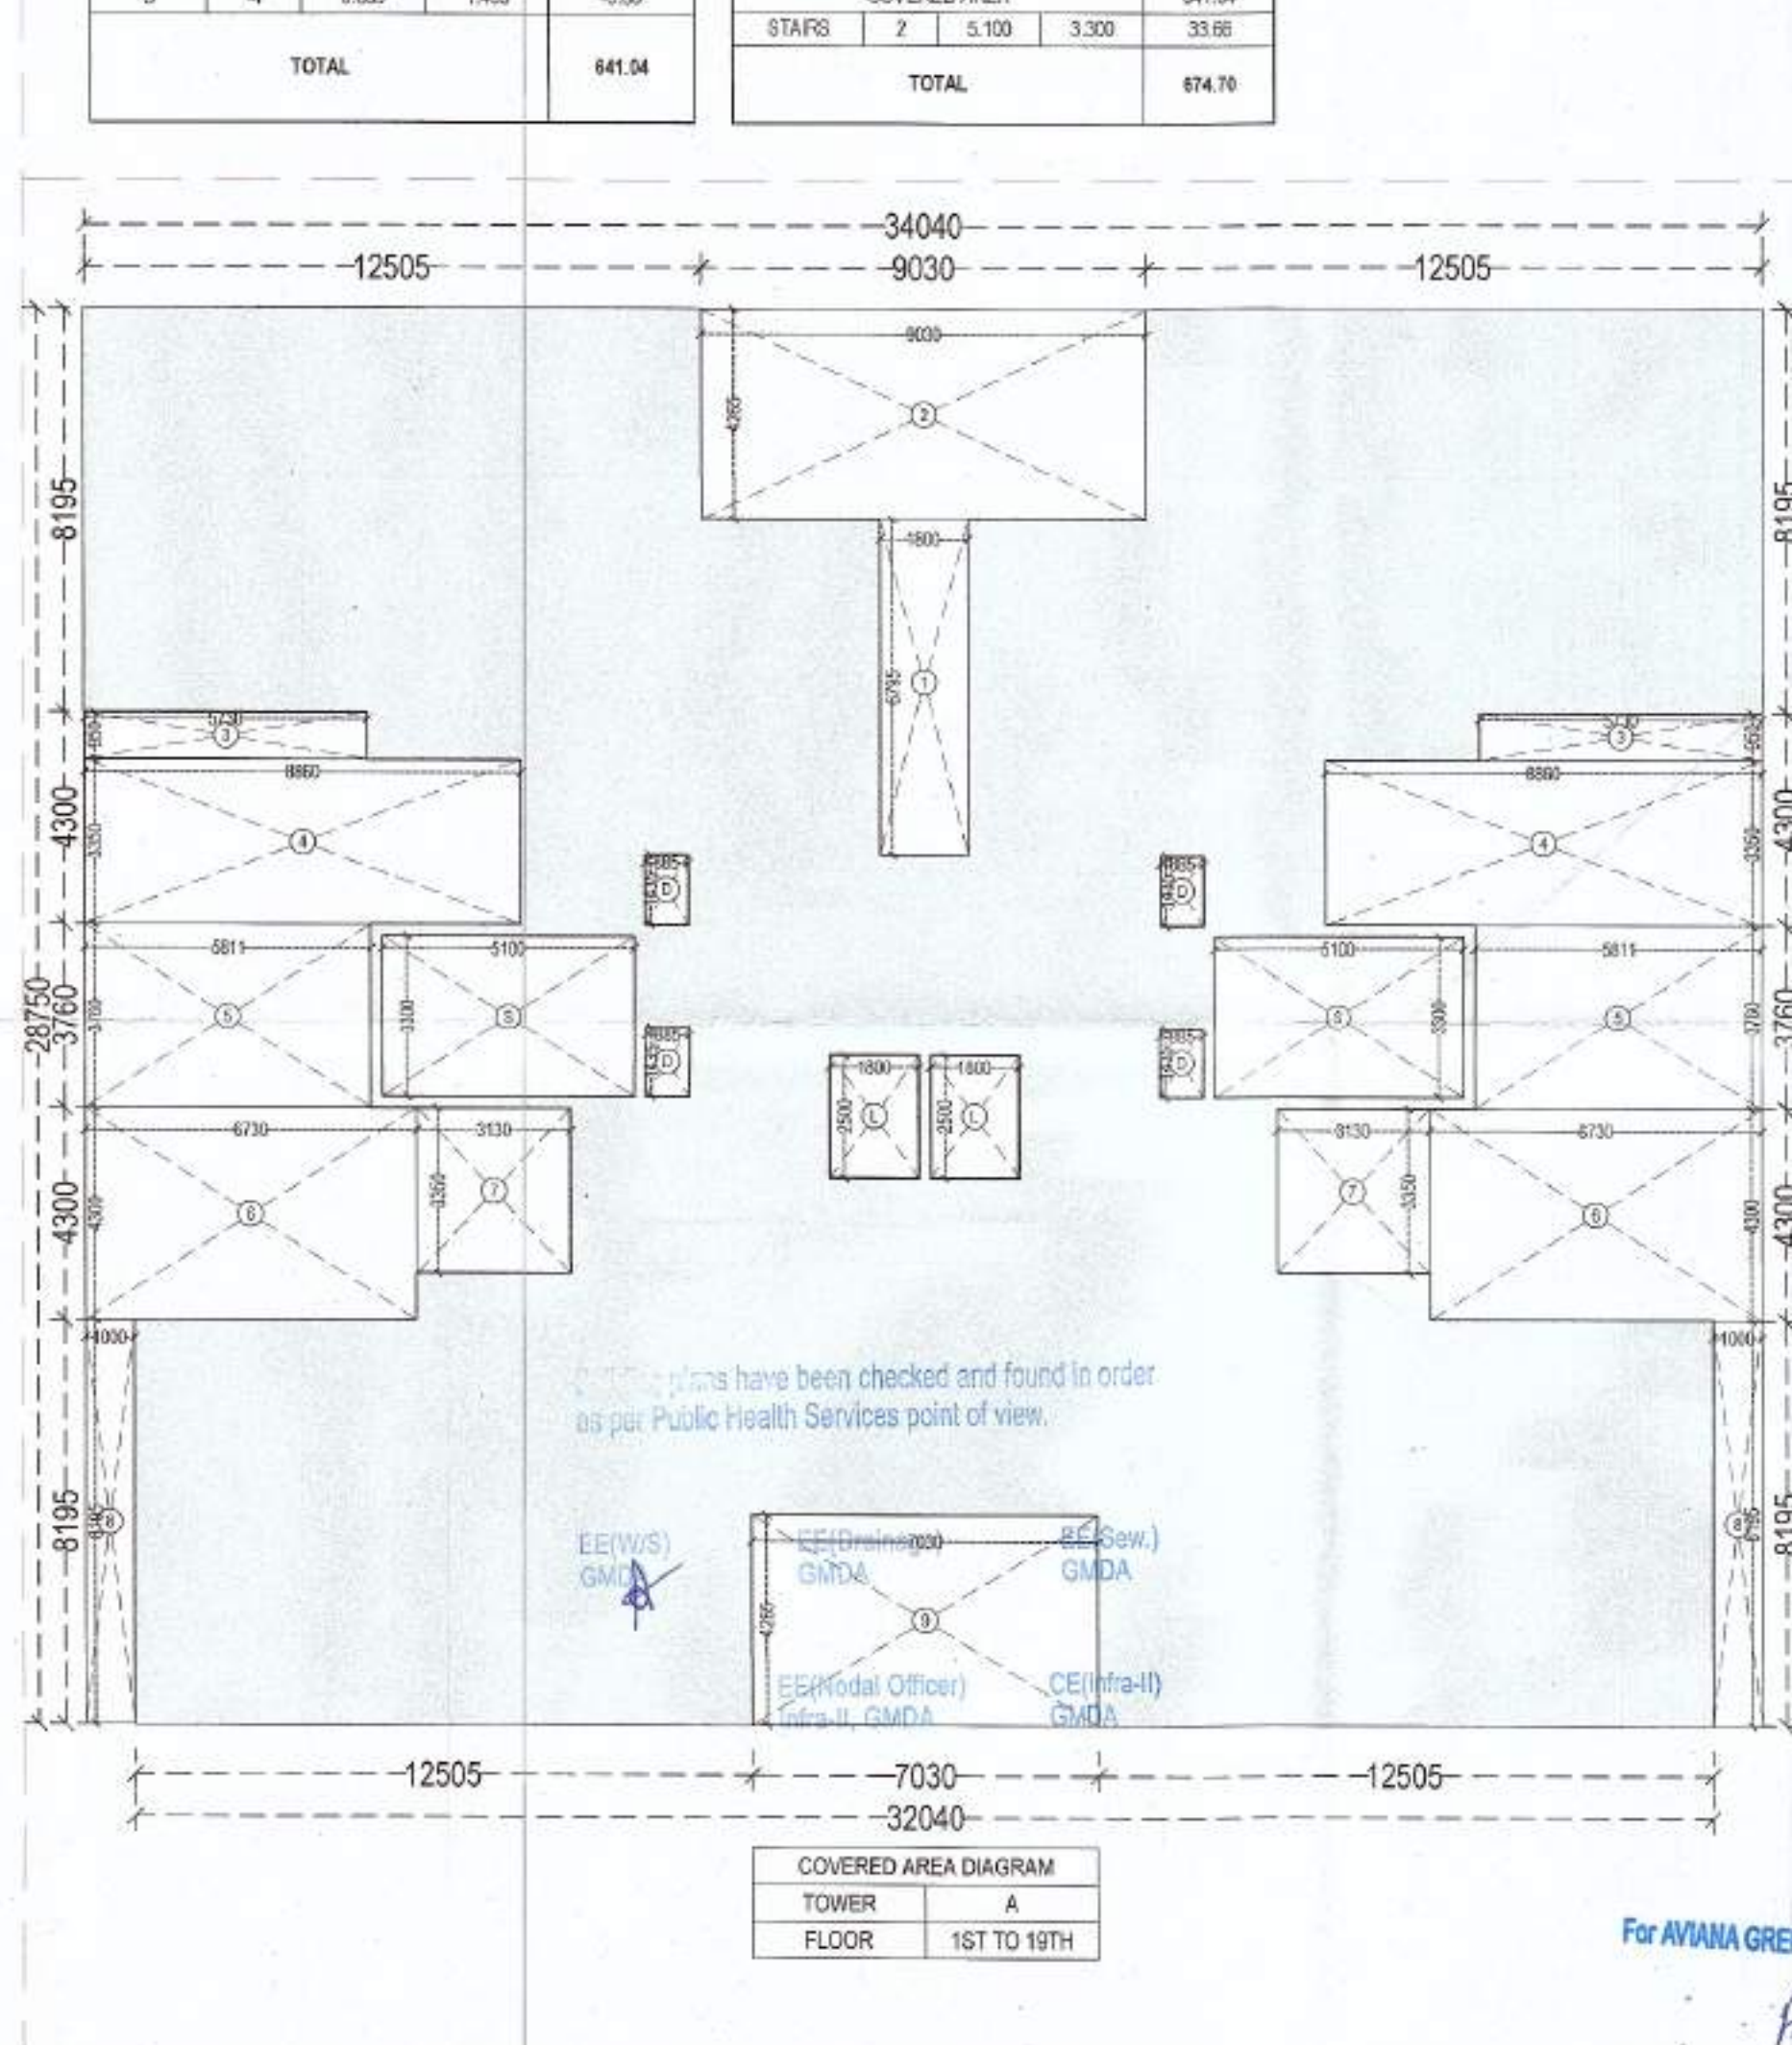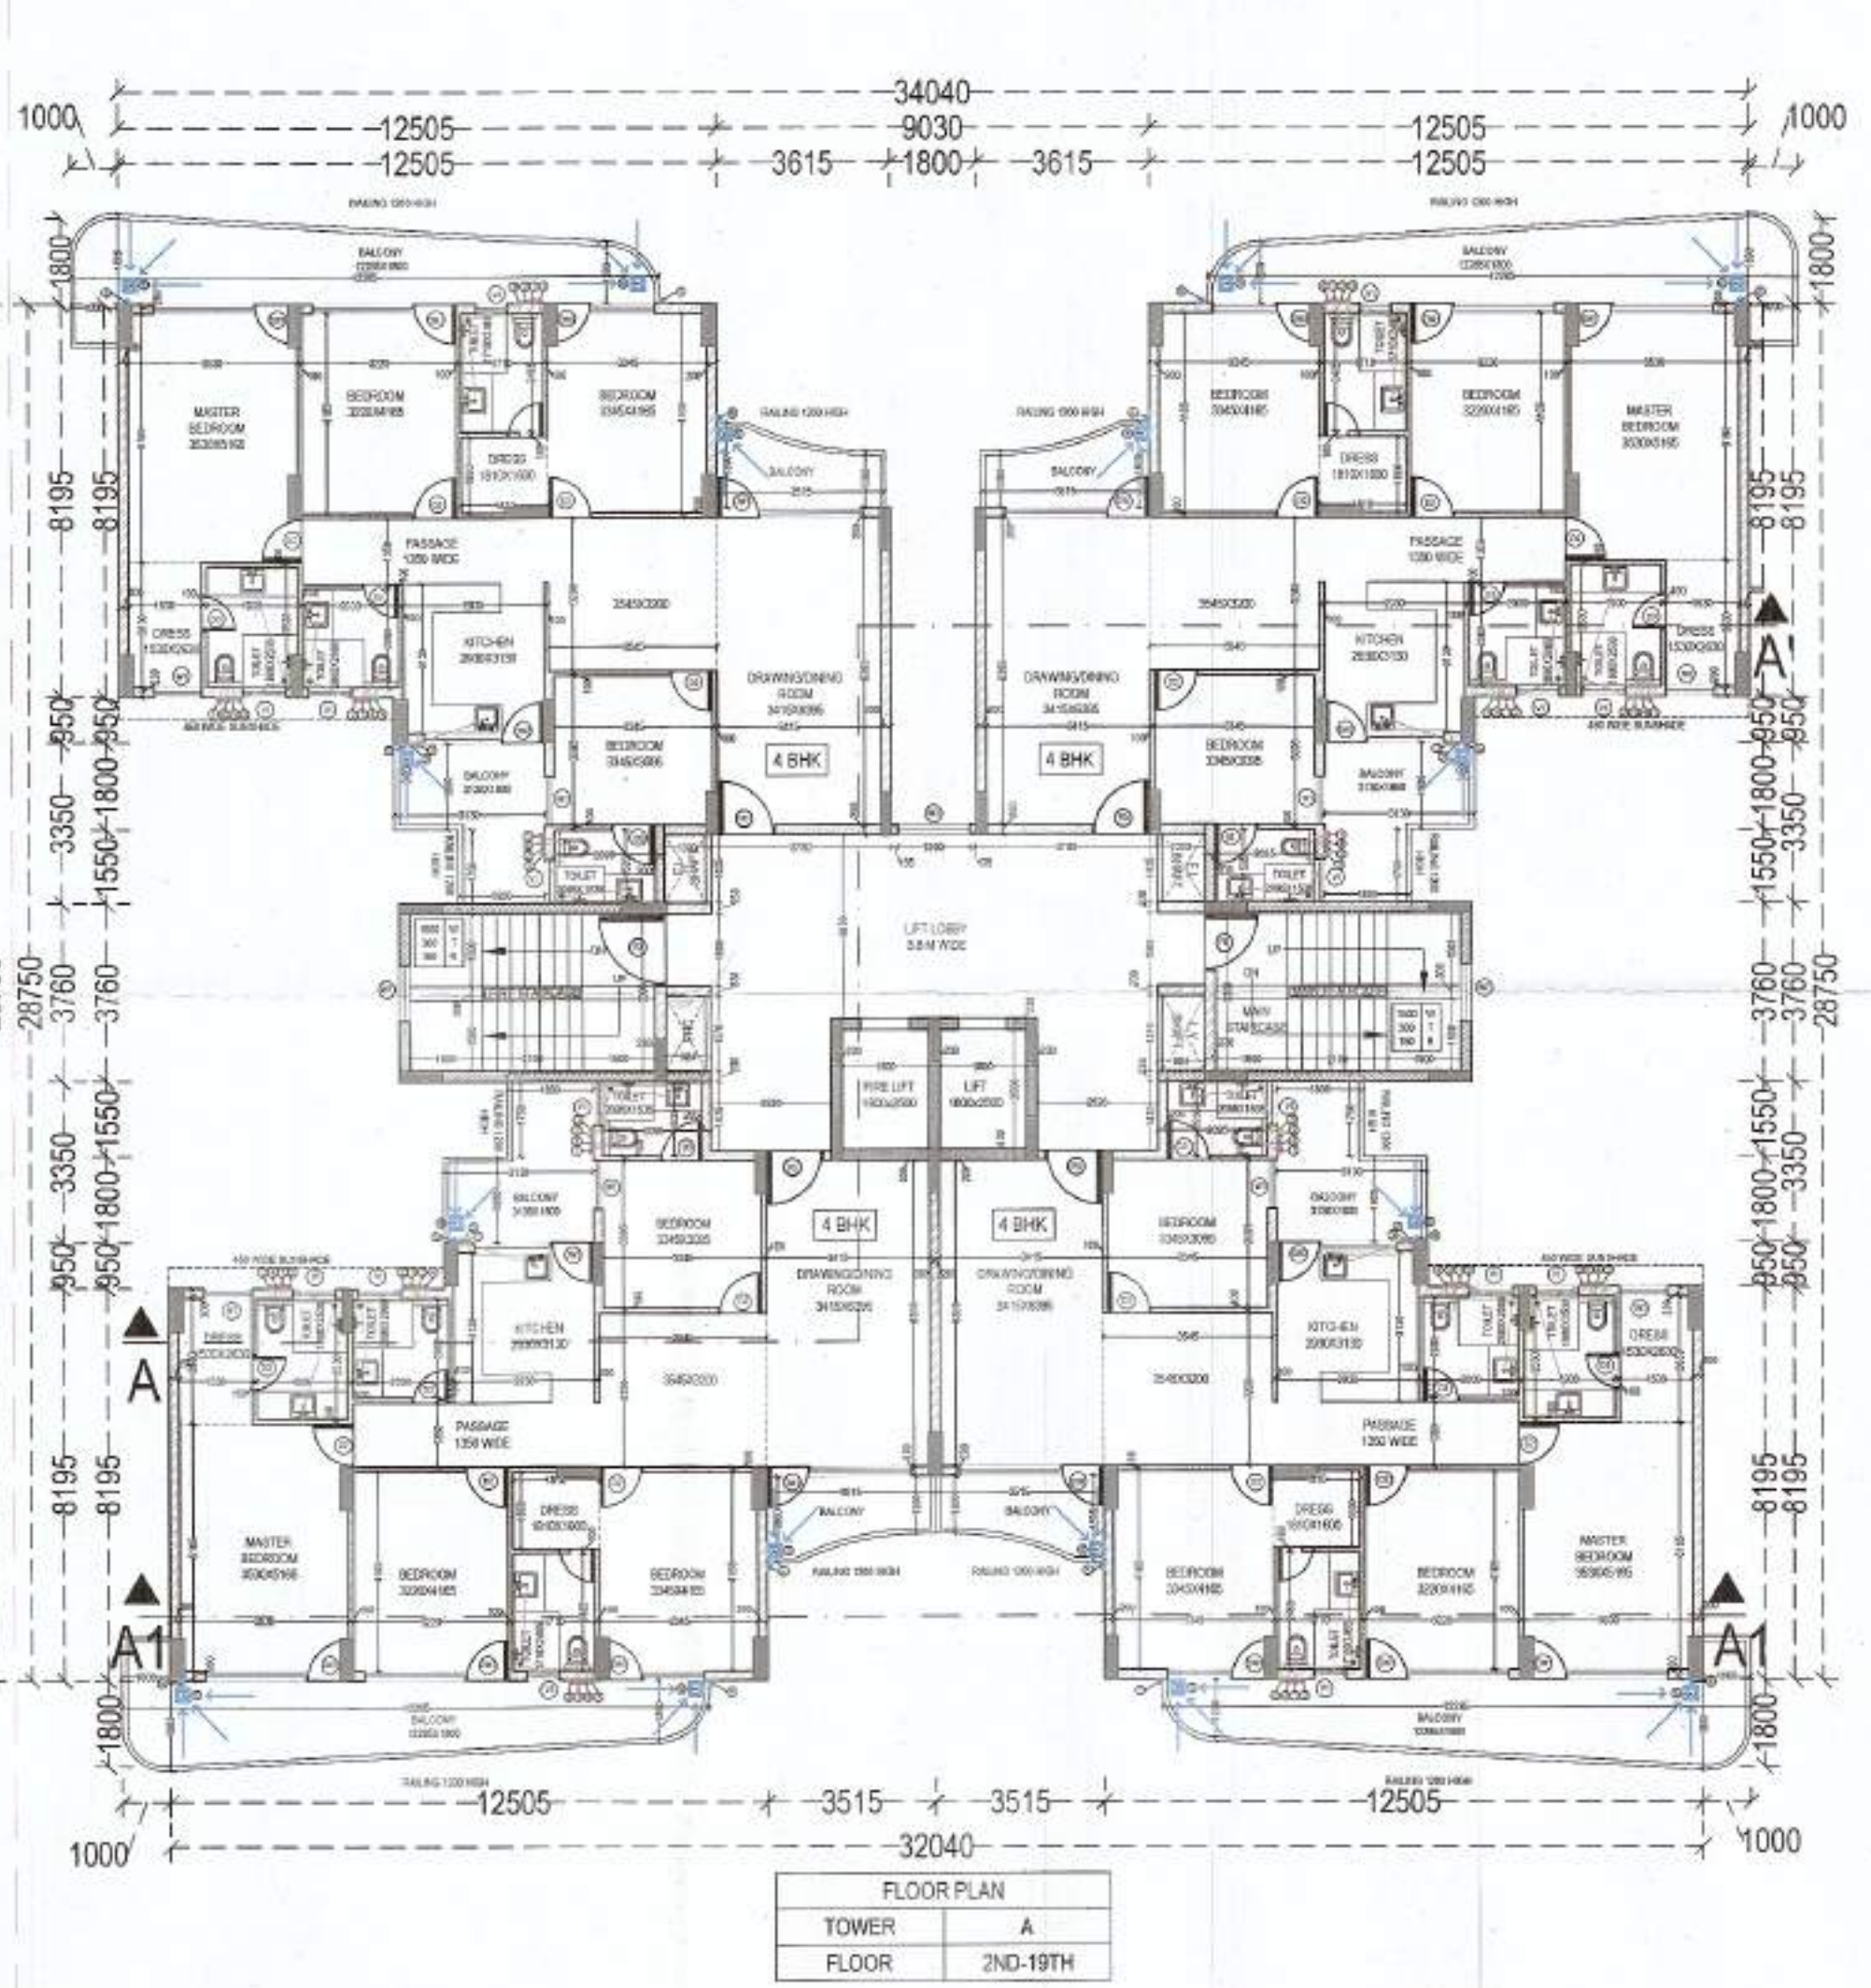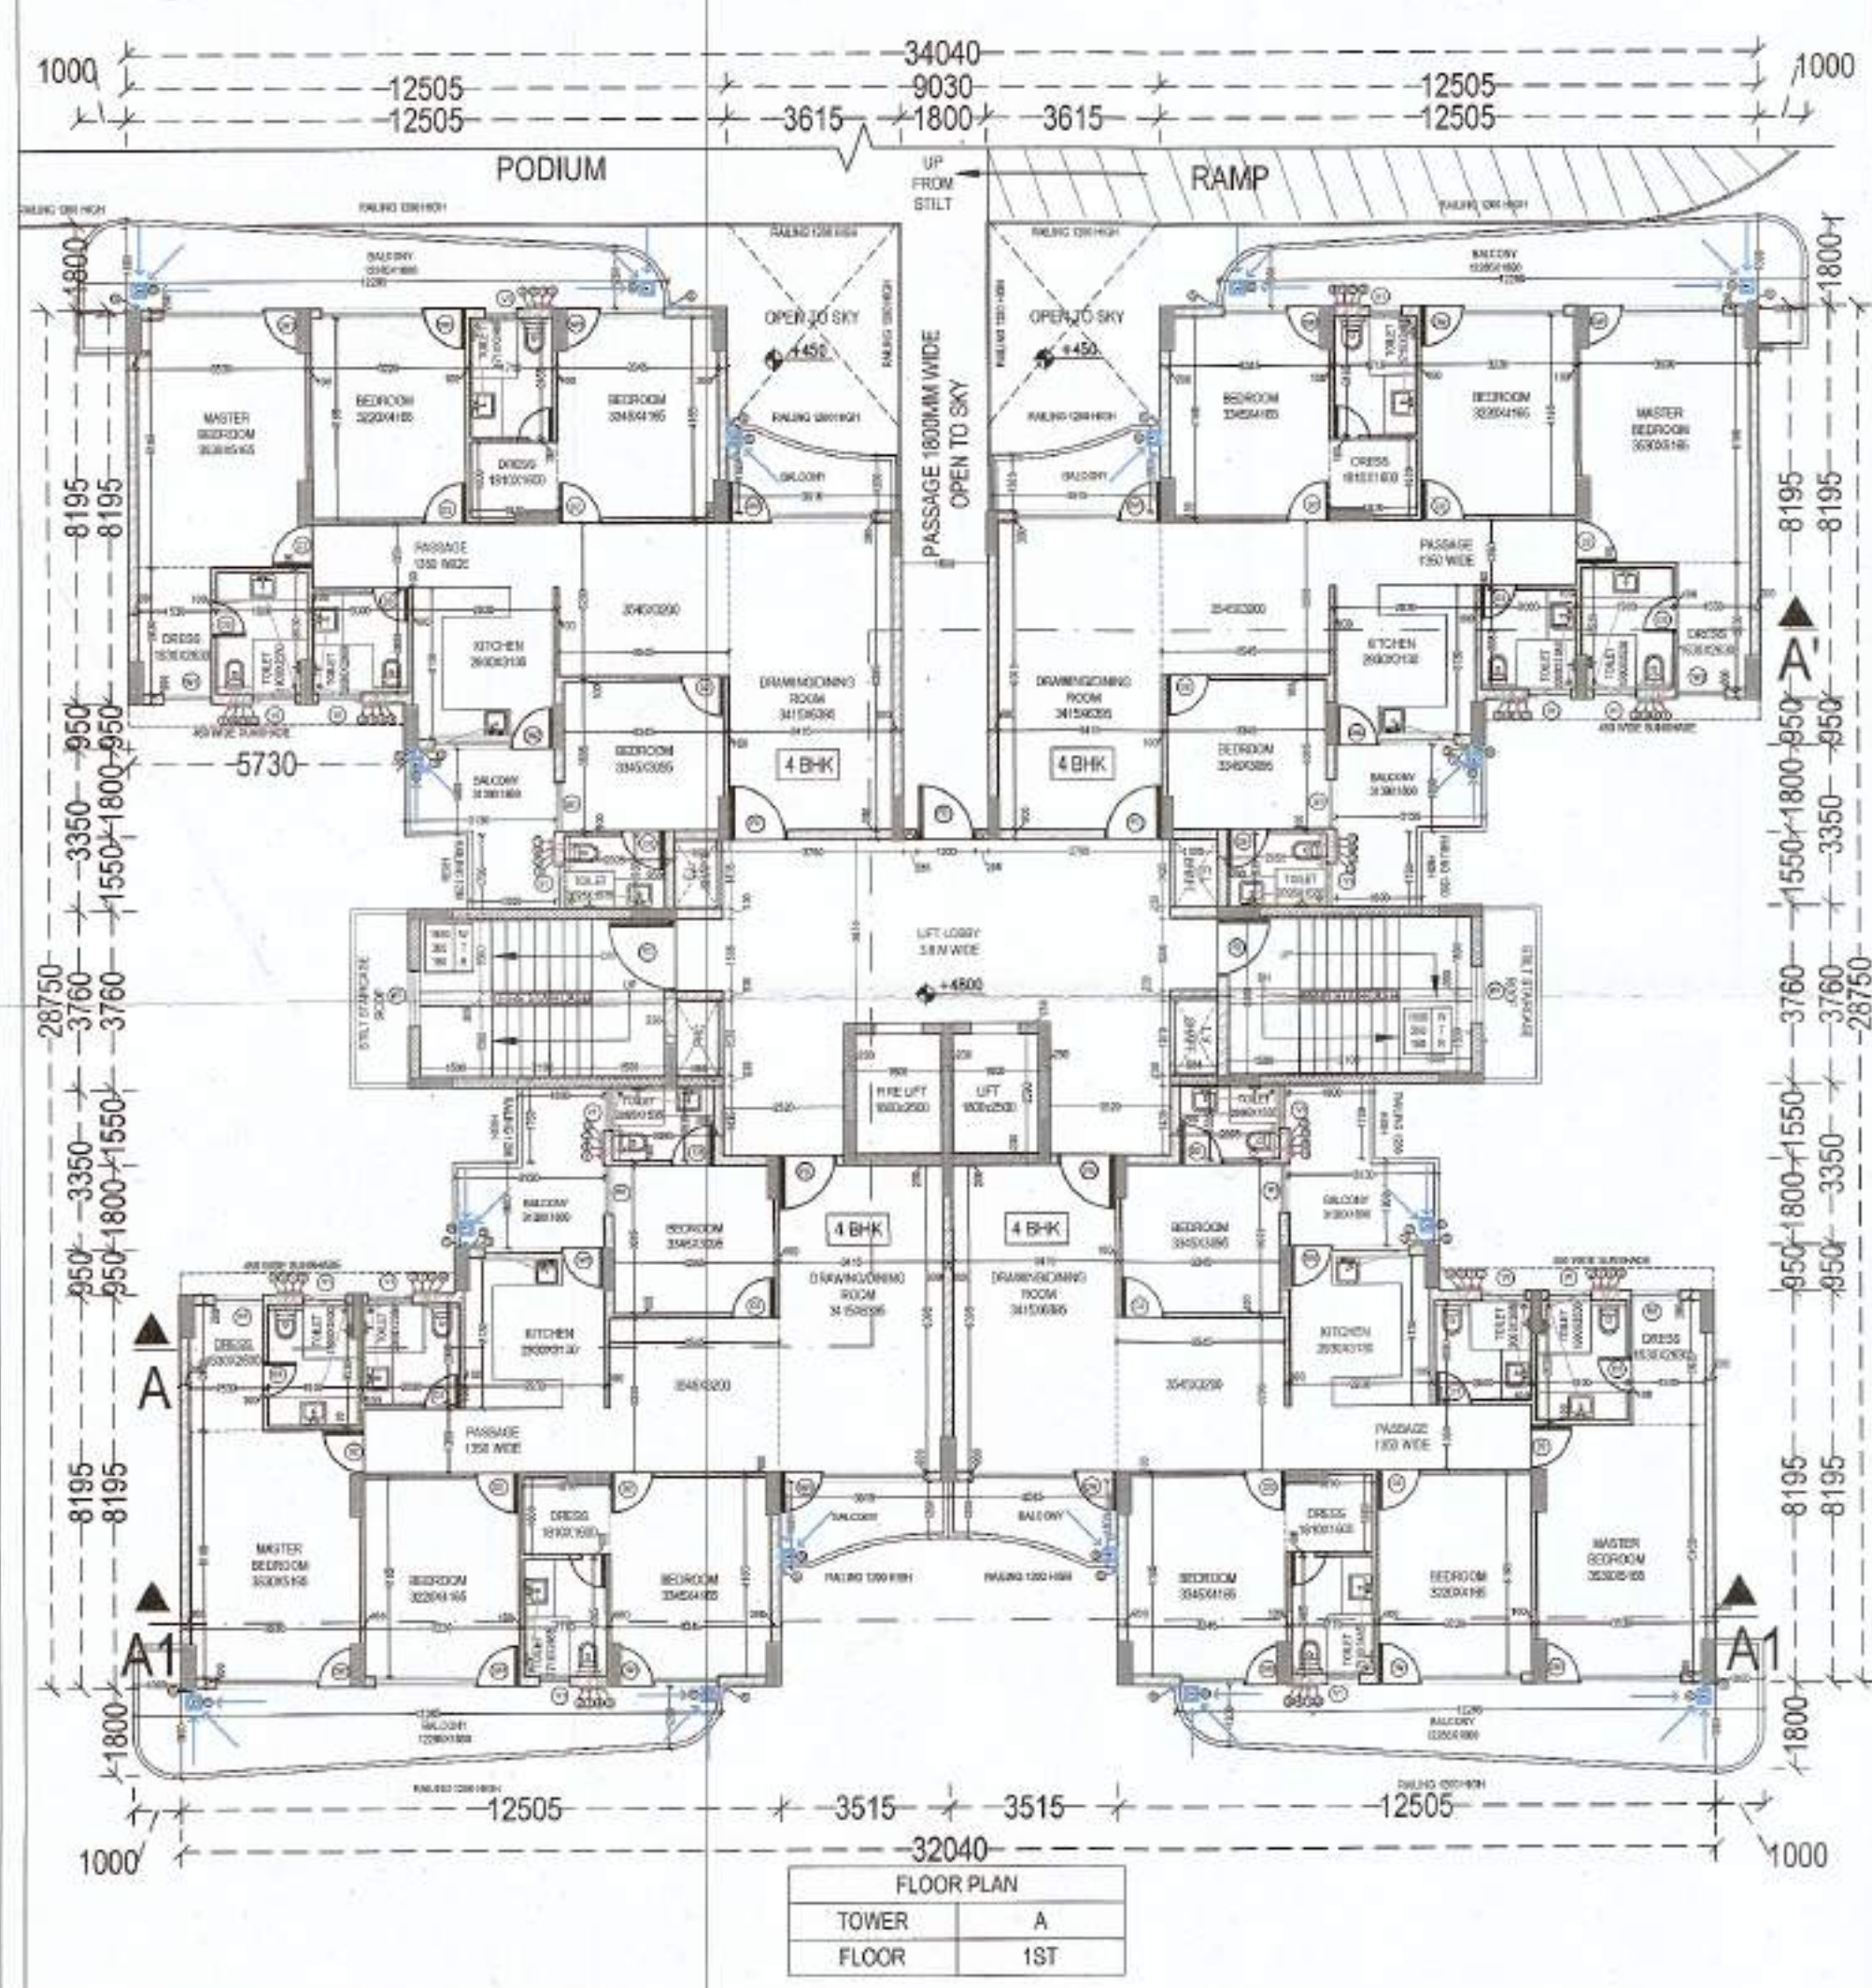

PROJECT:

PROPOSED BUILDING PLAN OF GROUP HOUSING COLONY OVER AN AREA MEASURING 4.1875 ACRES UNDER TOD POLICY (LICENCE NO 97 OF 2021 DATED 12.11.2021) IN SECTOR 103, GURUGRAM, DEVELOPED BY SUNITA KUMARI W/o SH. ASHOK KUMAR & OTHERS IN COLLABORATION WITH M/s AVIANA GREEN ESTATES PVT. LTD.

SHEET TITLE:

TOWER - A
STILT, 1ST - 19TH FLOOR
PLANS & AREA DIAGRAM

ARCHITECT:

AE STUDIO
Architects and Designers
A-1 GREEN PARK EXT., NEW DELHI-110016. Ph: 011 47353592
E-Mail: info@aeindia.com, Web: www.aeindia.in

DATE: SEPTEMBER 2022

SCALE: 1:100

NORTH: 07

SHEET SIZE: A0

CLIENT SIGNATURE:

ARCHITECT SIGNATURE:

For AVIANA GREENESTATES PVT. LTD.
Sandeep Tandon
Architect
CA/97/21/23