




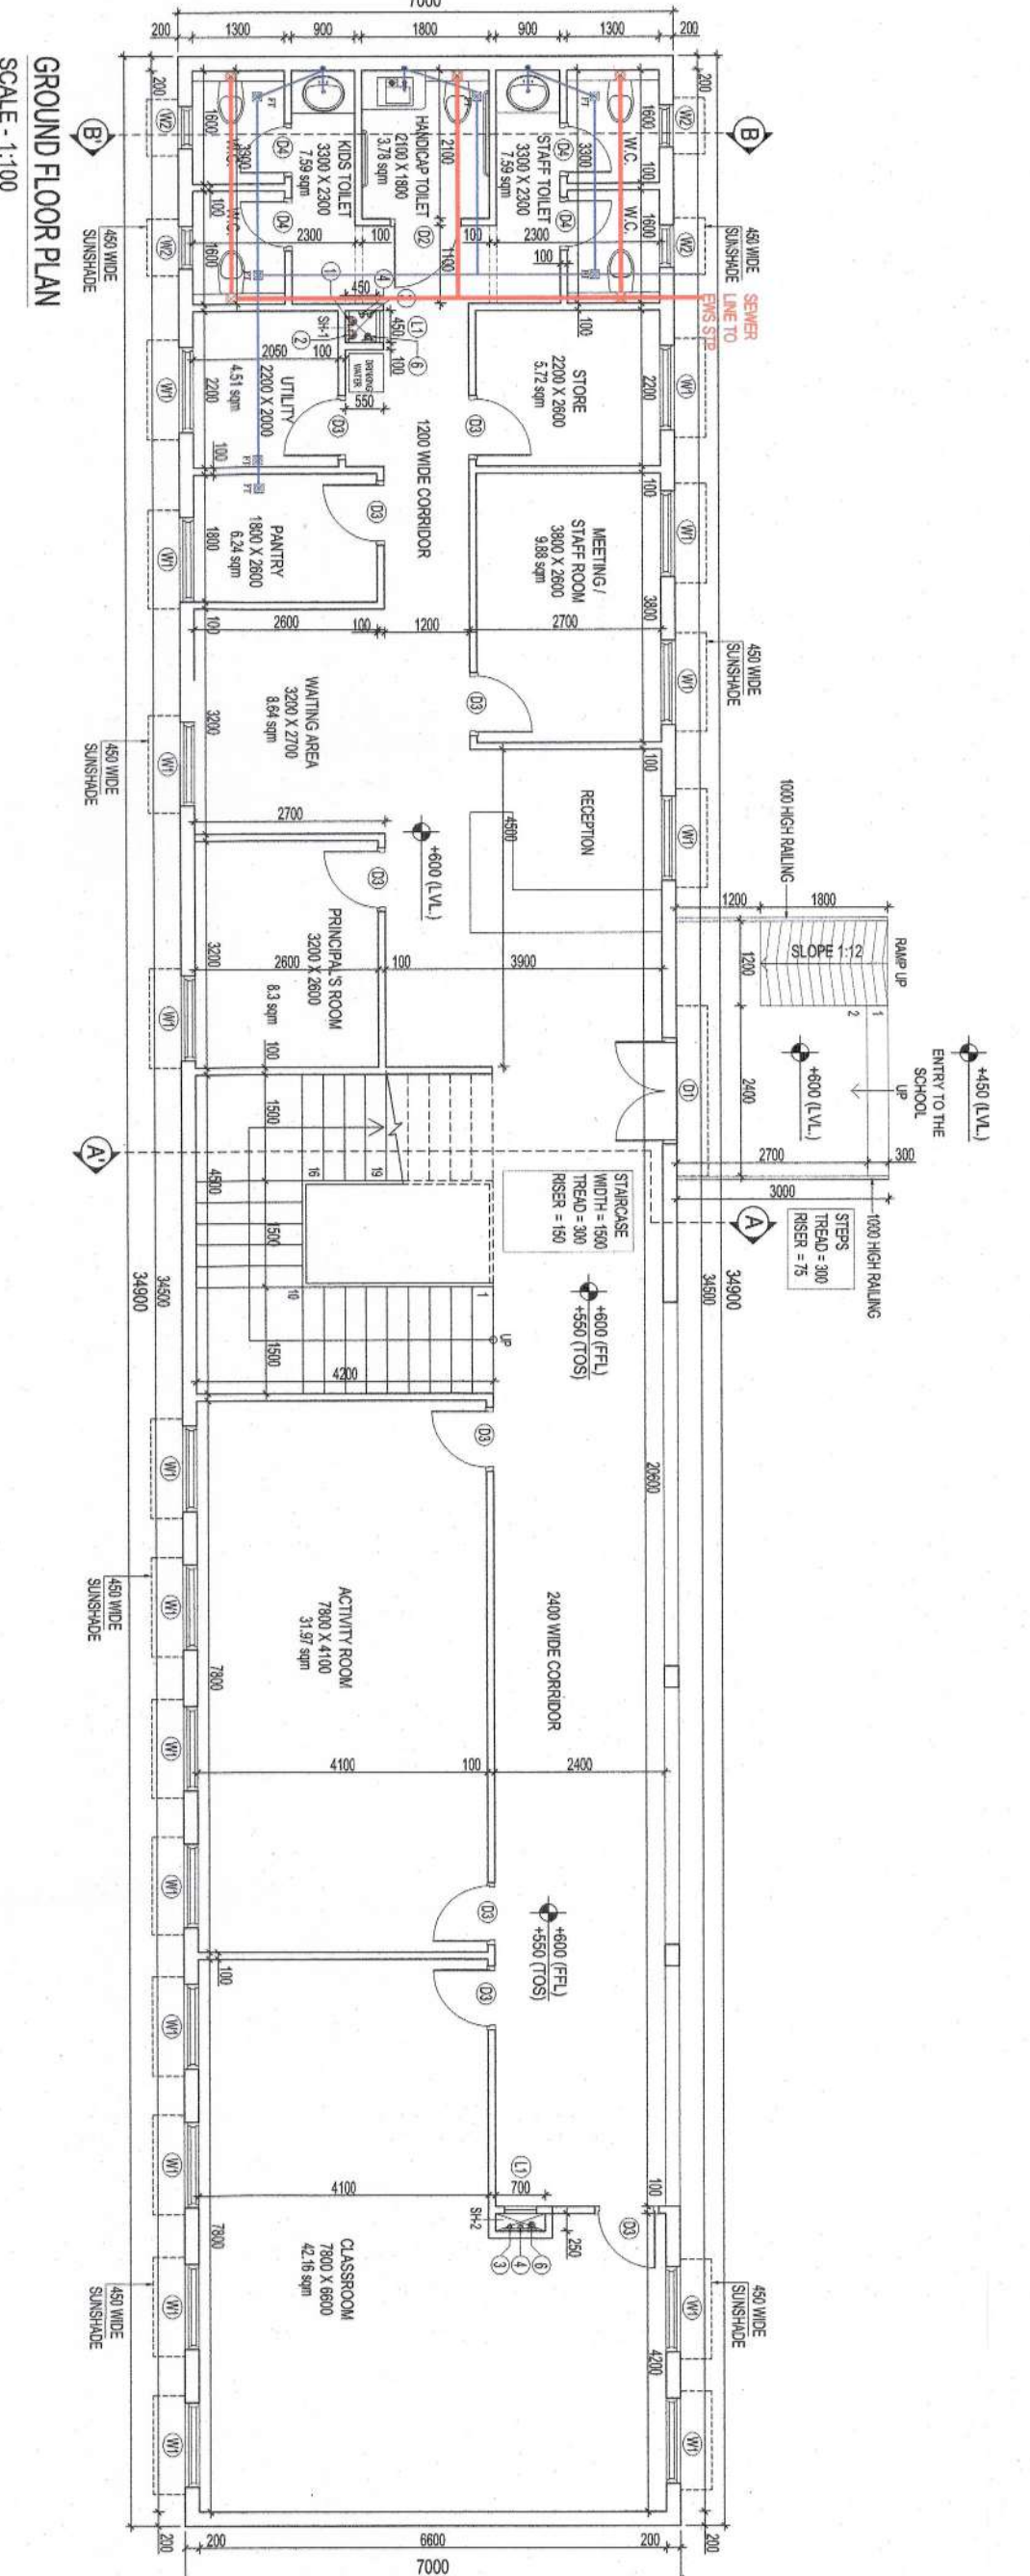

GROUND FLOOR PLAN
SCALE: 1:100

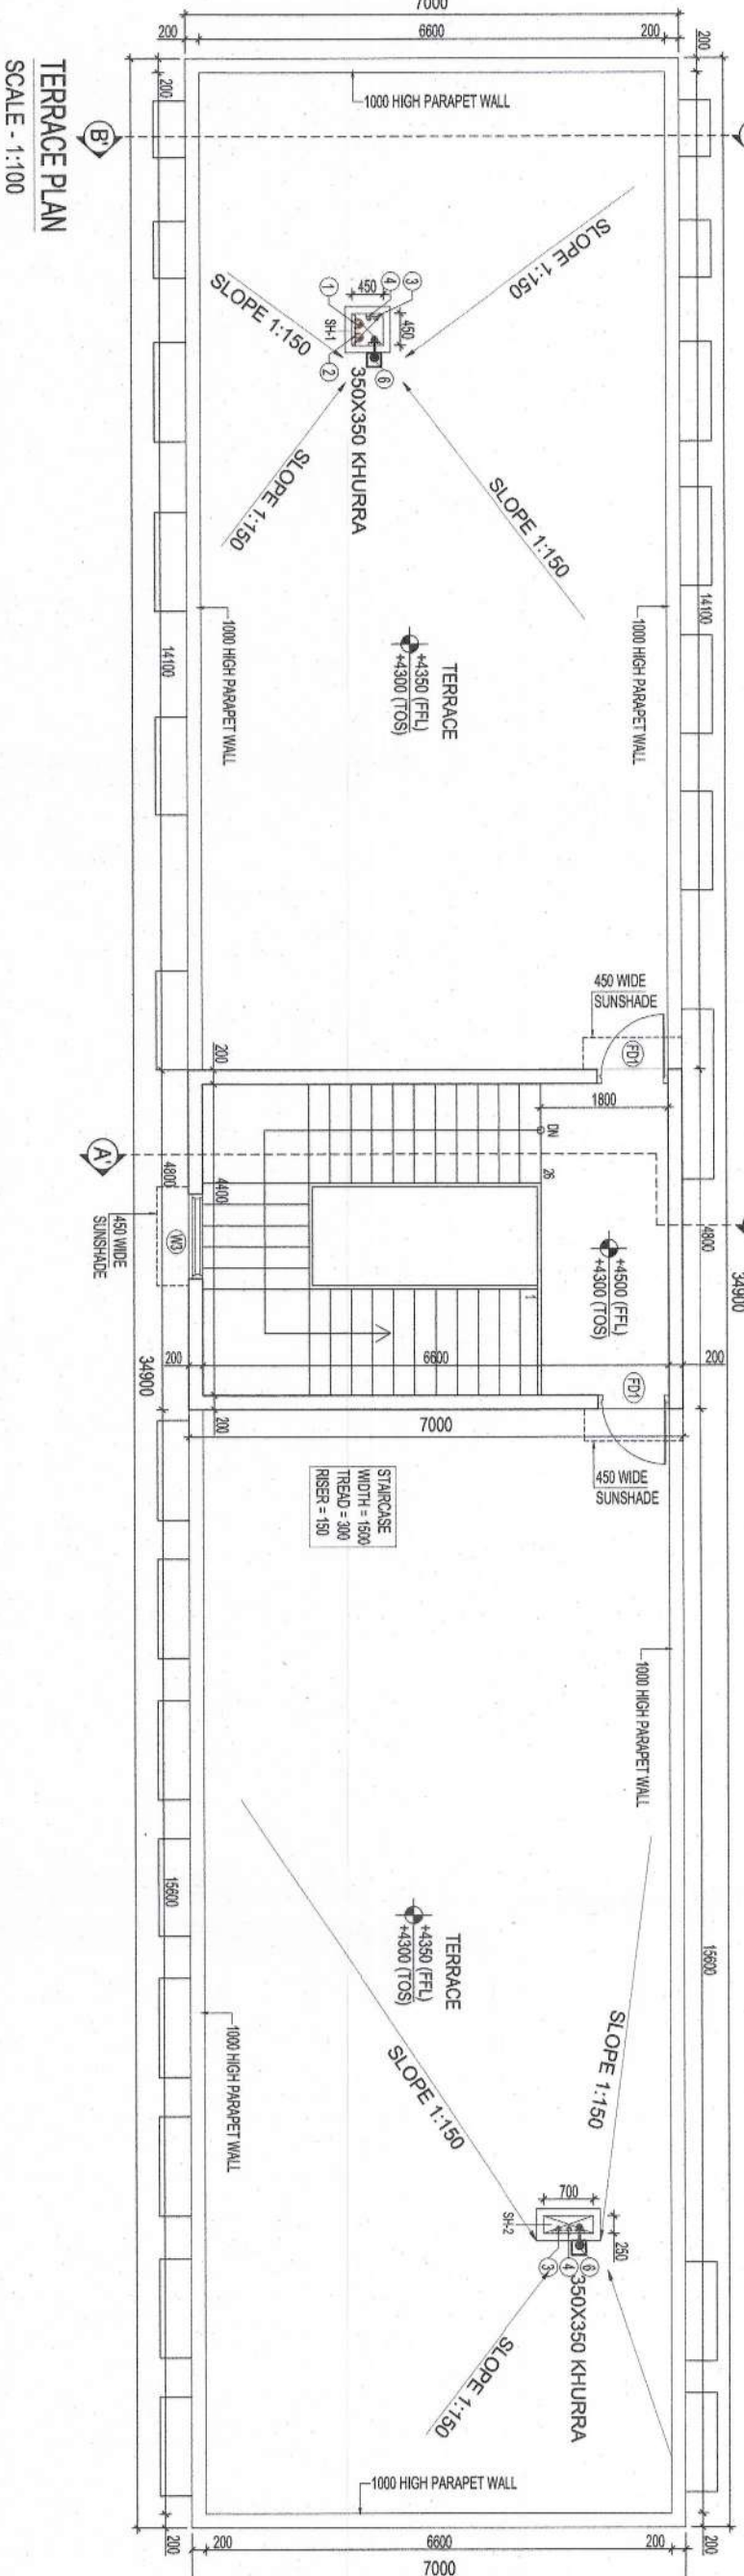

TERRACE PLAN
SCALE: 1:100

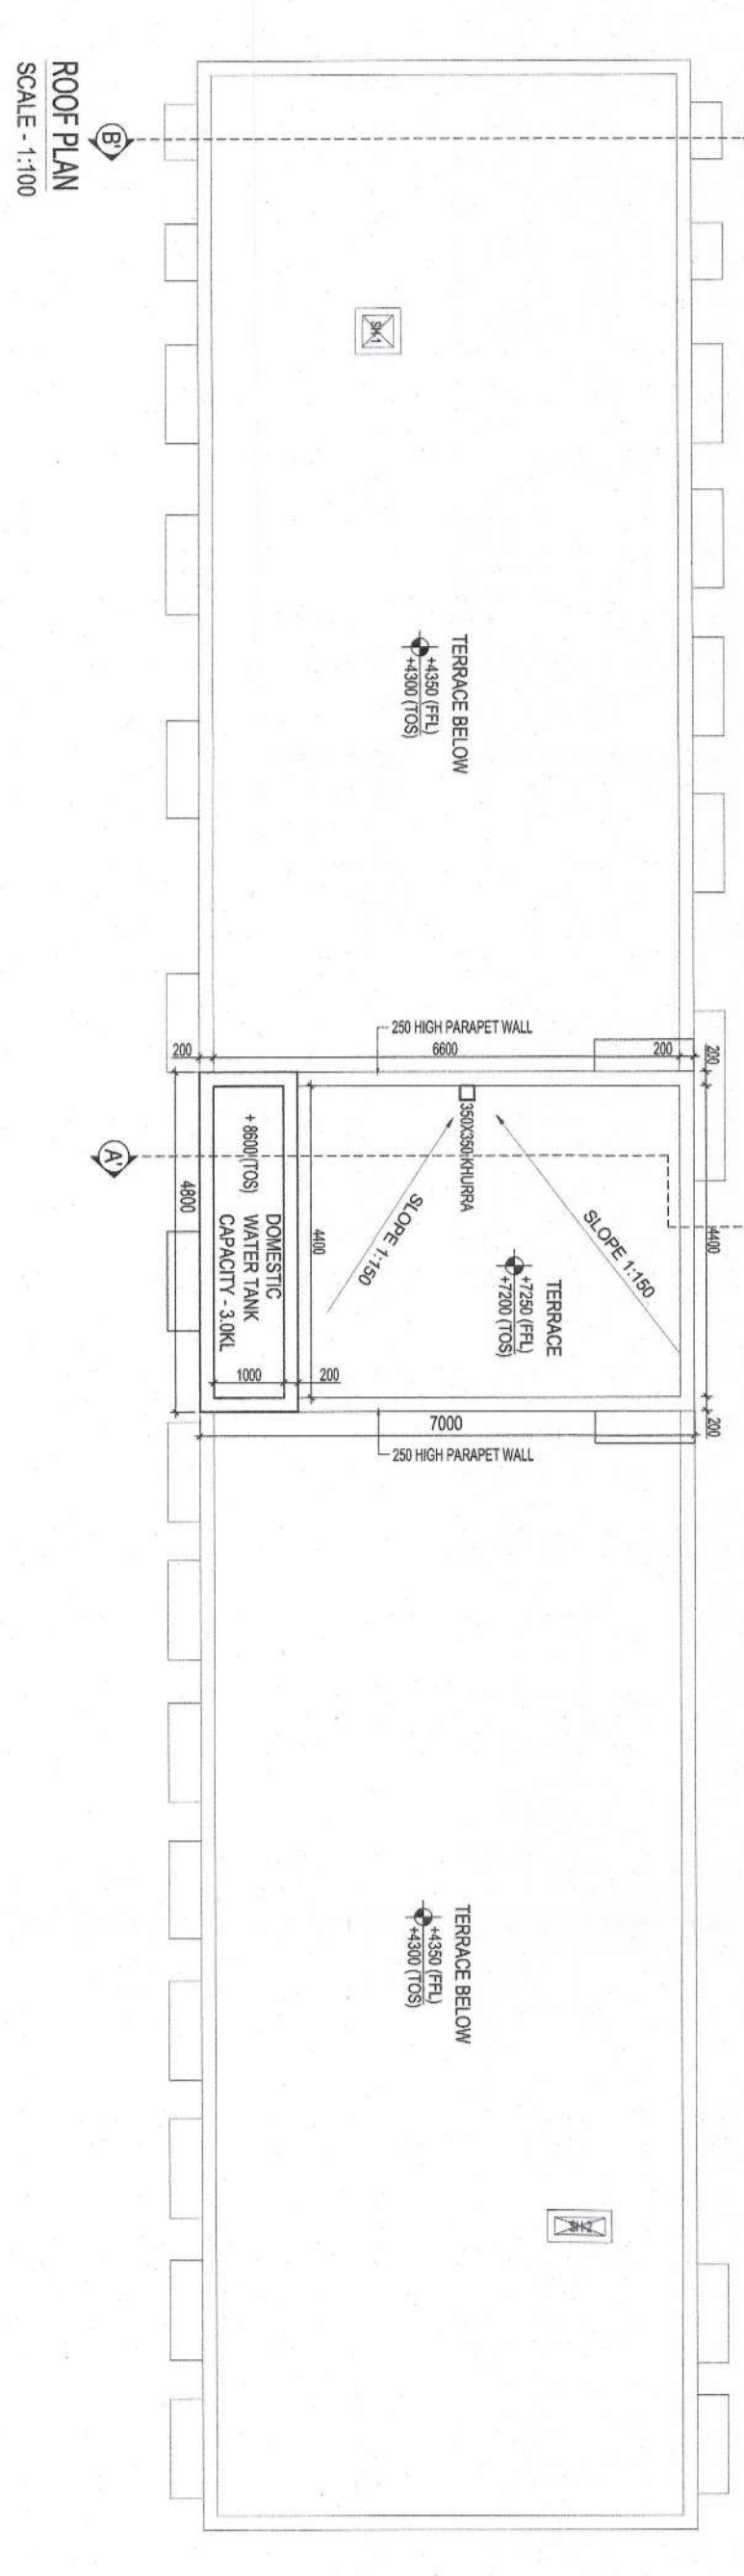

ROOF PLAN
SCALE: 1:100

PLUMBING LEGEND FOR VVS	
1	100% SINK, PIPES
2	100% SINK, PIPES
3	100% SINK, PIPES
100	100% SINK, PIPES


DOOR & WINDOW SCHEDULE			
S. NO.	TYPE	SIZE (mm)	QTY. U/L
1	D1	1000 X 2100	2100
2	D2	1000 X 2100	2100
3	D3	1000 X 2100	2100
100	D100	1000 X 2100	2100

SCHOOL (GROUND COVERAGE CALCULATION)			
LEGEND	LENGTH (m)	WIDTH (m)	AREA (sqm)
ADDITIONS			
A	34.900	7.000	244.300
TOTAL ADDITIONS			244.300
TOTAL AREA OF GROUND COVERAGE			244.300

GROUND FLOOR (F.A.R. CALCULATION)			
LEGEND	LENGTH (m)	WIDTH (m)	AREA (sqm)
ADDITIONS			
A	34.900	7.000	244.300
TOTAL ADDITIONS			244.300
TOTAL FAR AREA OF GROUND FLOOR			244.300


BUILT UP AREA OF MUNITY			
LEGEND	LENGTH (m)	WIDTH (m)	AREA (sqm)
ADDITIONS			
B	3.700	7.000	25.900
TOTAL ADDITIONS			25.900
TOTAL BUILT UP AREA OF MUNITY			25.900

SCHOOL BUILDING (BUILT UP CALCULATION)			
LEVEL	AREA (sqm)	NO. OF LEVEL	TOTAL
GROUND FLOOR	244.300	1	244.300
BUILT UP AREA OF MUNITY	25.900	1	25.900
TOTAL BUILT UP AREA OF SCHOOL BUILDING			270.200

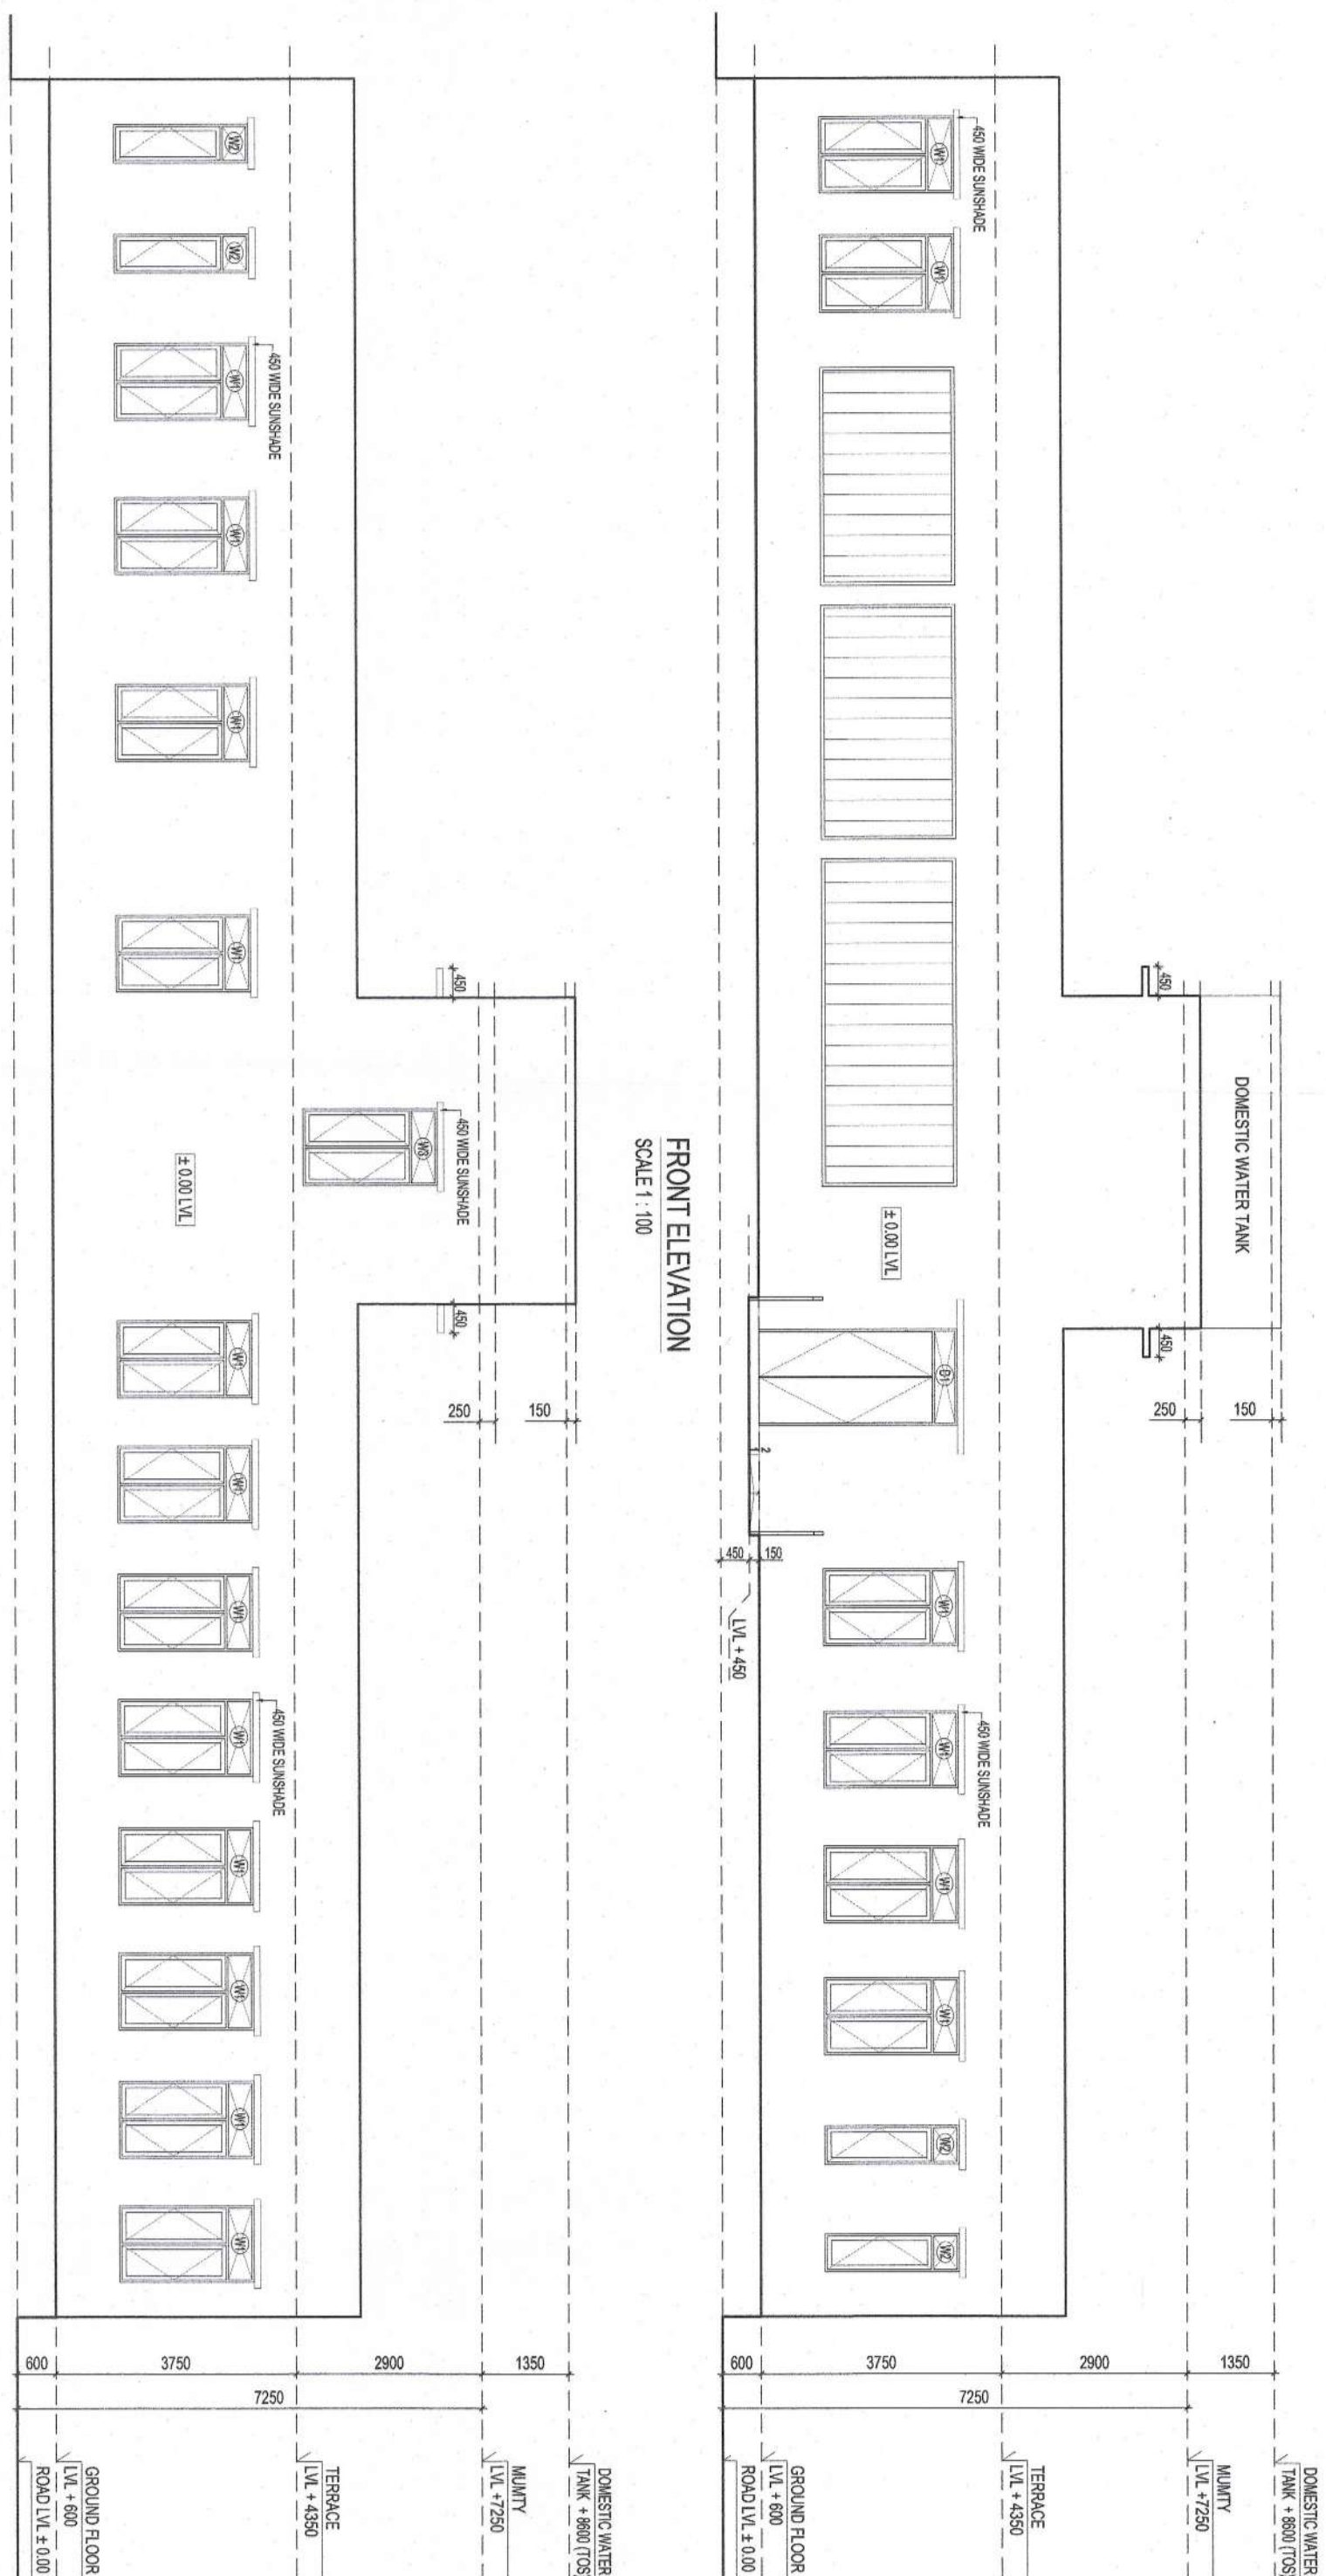


FRONT ELEVATION
SCALE: 1:100

REAR ELEVATION
SCALE: 1:100

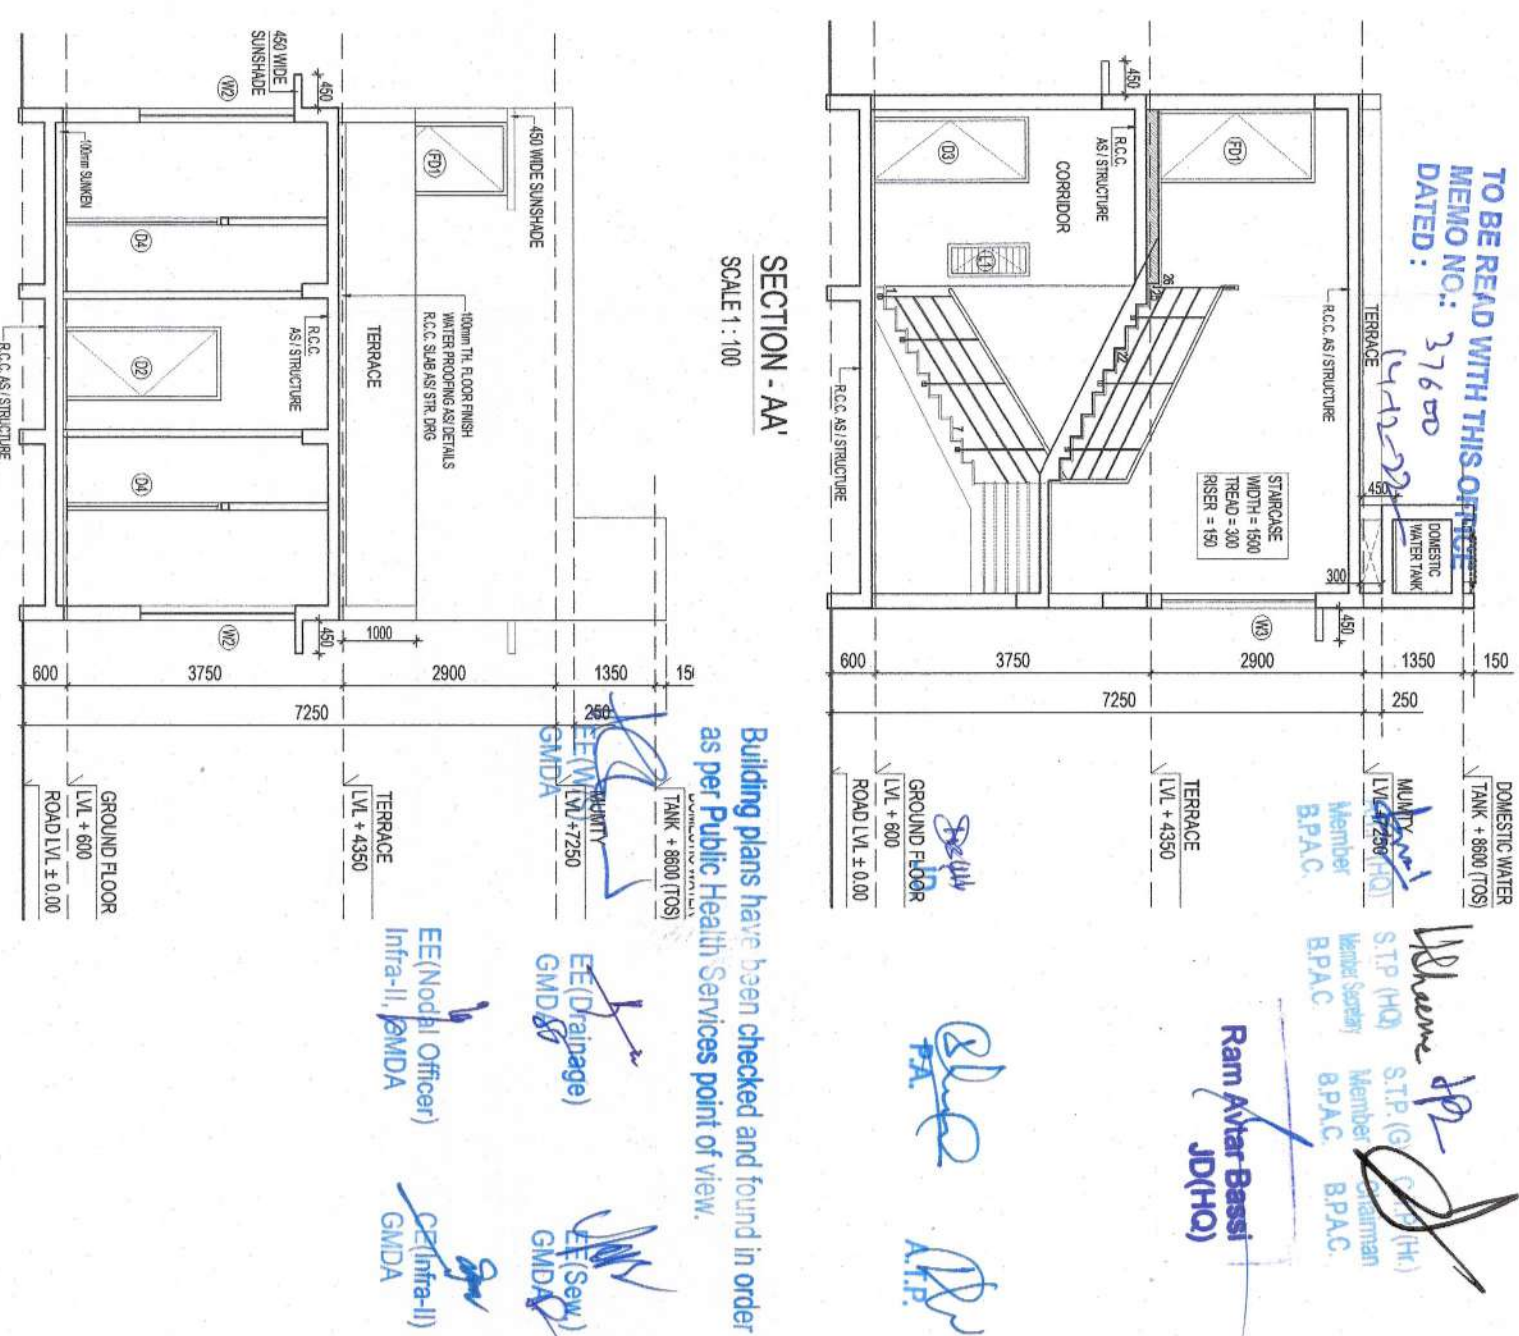

SECTION - A-A
SCALE: 1:100

SECTION - B-B
SCALE: 1:100

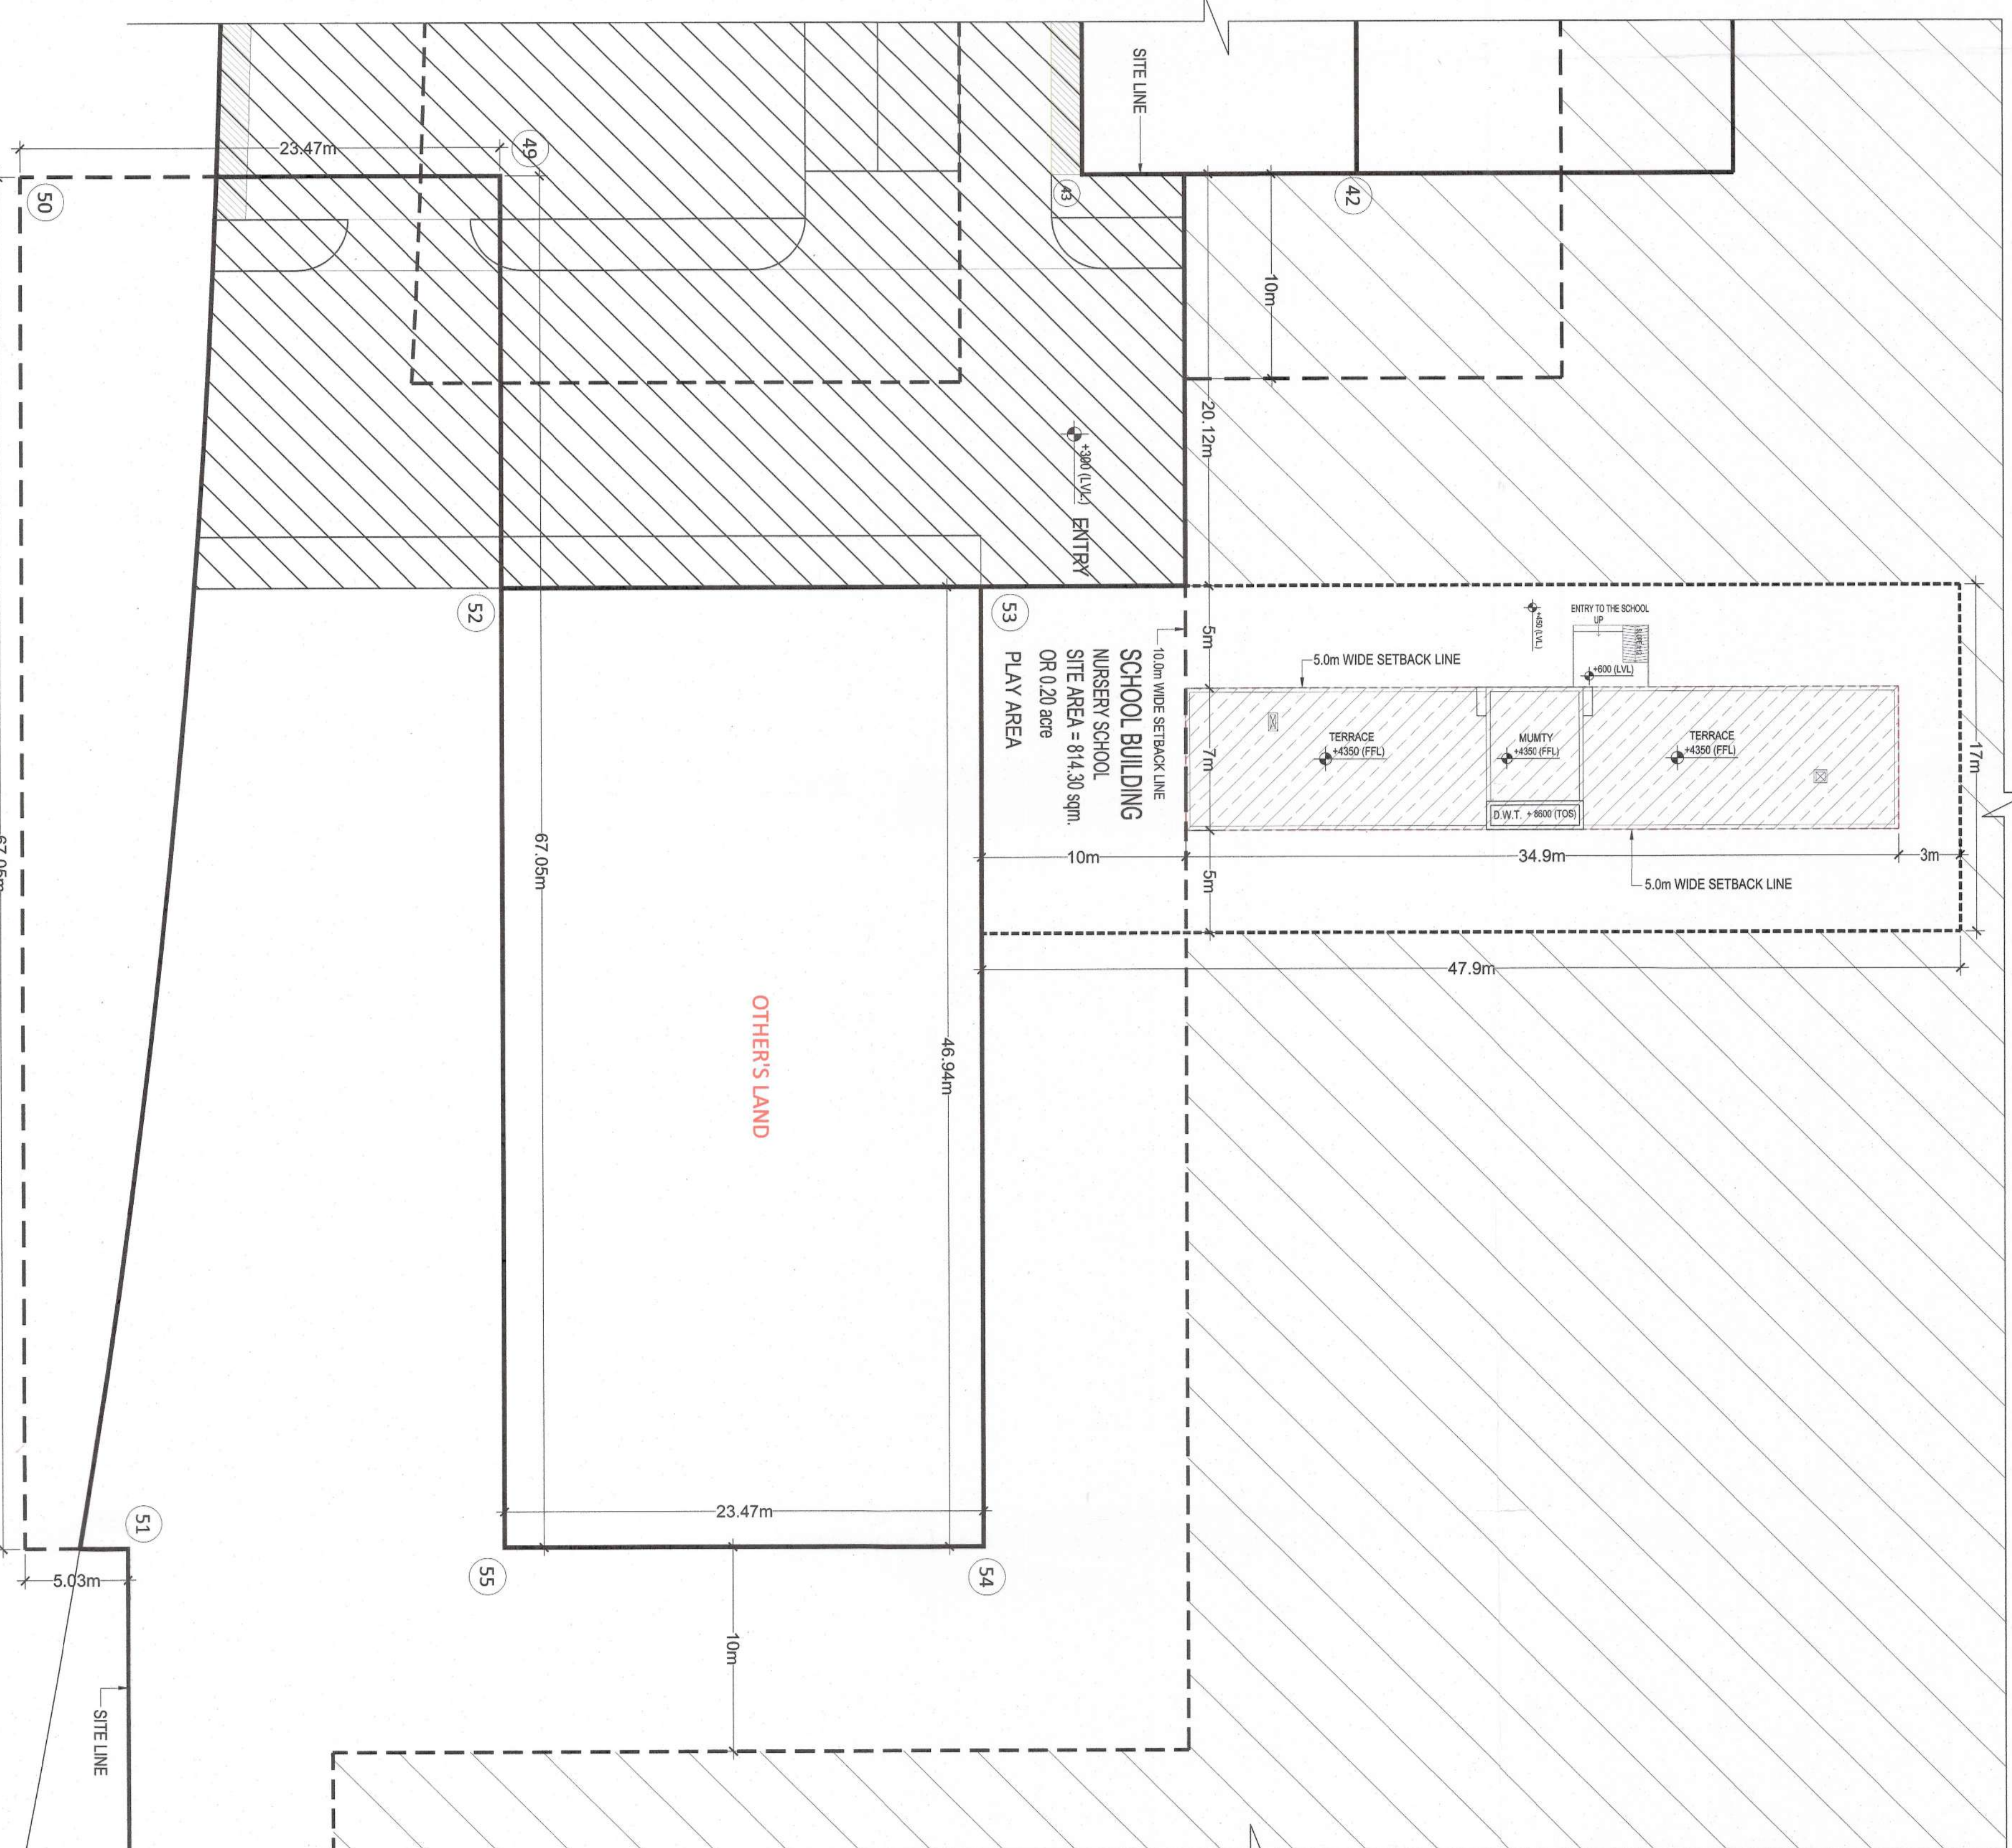

KEY PLAN
SCALE: 1:200

AUTHORITY STAMP:

KEY PLAN:

PROJECT ARCHITECT:

PROJECT ARCHITECT:

STRUCTURE:

MEP CONSULTANTS:

PROJECT TITLE:

ARCHITECT'S SIGNATURE / STAMP:

OWNER SIGNATURE / STAMP:

DRAWING TITLE:

SCALE:

DATE:

DRAWING NO.:

DATE:

DRAWING NO.: