


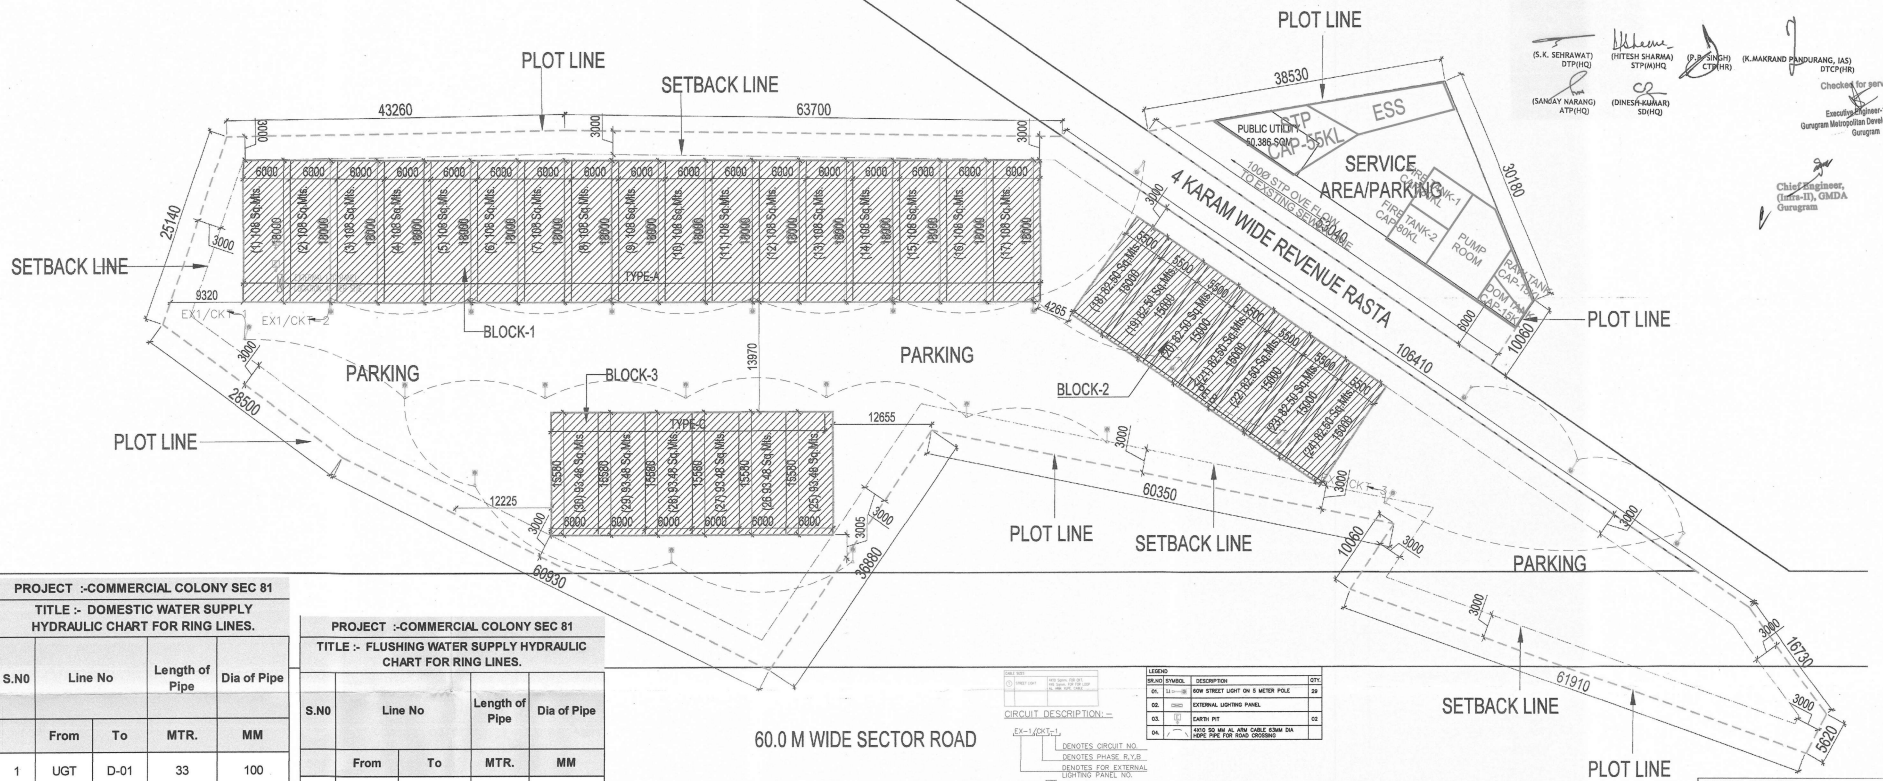

(S.K. SEHRAWAT) DTP(HQ)
 (RITESH SHARMA) STP(HQ)
 (P.B. SINGH) CTP(HQ)
 (K. MAHARAJ PANDURANG, IAS) DTP(HQ)
 (SANGSI NARANG) ATP(HQ)
 (DINESH KUMAR) SH(HQ)
 Chief Engineer,
 (Civil-10), CMDA
 Gurgaon

Checked for service estimate
 Executing Engineer-1 (EEC)
 Gurgaon Metropolitan Development Authority
 Gurgaon

PRINCIPAL ARCHITECT:

DESIGN FORUM INTERNATIONAL

K-47, KALASH COLONY, NEW DELHI-110048
 PHONE NO: 011-46556600

OWNER'S SIGNATURE **ARCHITECT'S SIGNATURE**

CLIENT:
 M/S ACTION CONSTRUCTWELL PVT. LTD.

PROJECT:
 UTILIZATION PLAN OF COMMERCIAL COLONY
 M/S ACTION CONSTRUCTWELL PVT.
 LTD. ON VILLAGE NAHARPUR KASAN, SEC- 81,
 TEHSIL GURGAON, DIST. - GURGAON.
 RECT. NO. 2 KILA NO. 21/2 (1-9), 22(0-18)
 RECT. NO. 3 KILA NO. 1/2/2(2-10), 2(5-9),
 8/3(1-5), 9/1(3-8), 12/1/2(1-17) TOTAL 16
 KANAL 16 MARLA OR 2.1 ACRES.

DRAWING TITLE:
 LAYOUT PLAN
ELECTRICAL LAYOUT

SCALE: 1:300

DATE: