


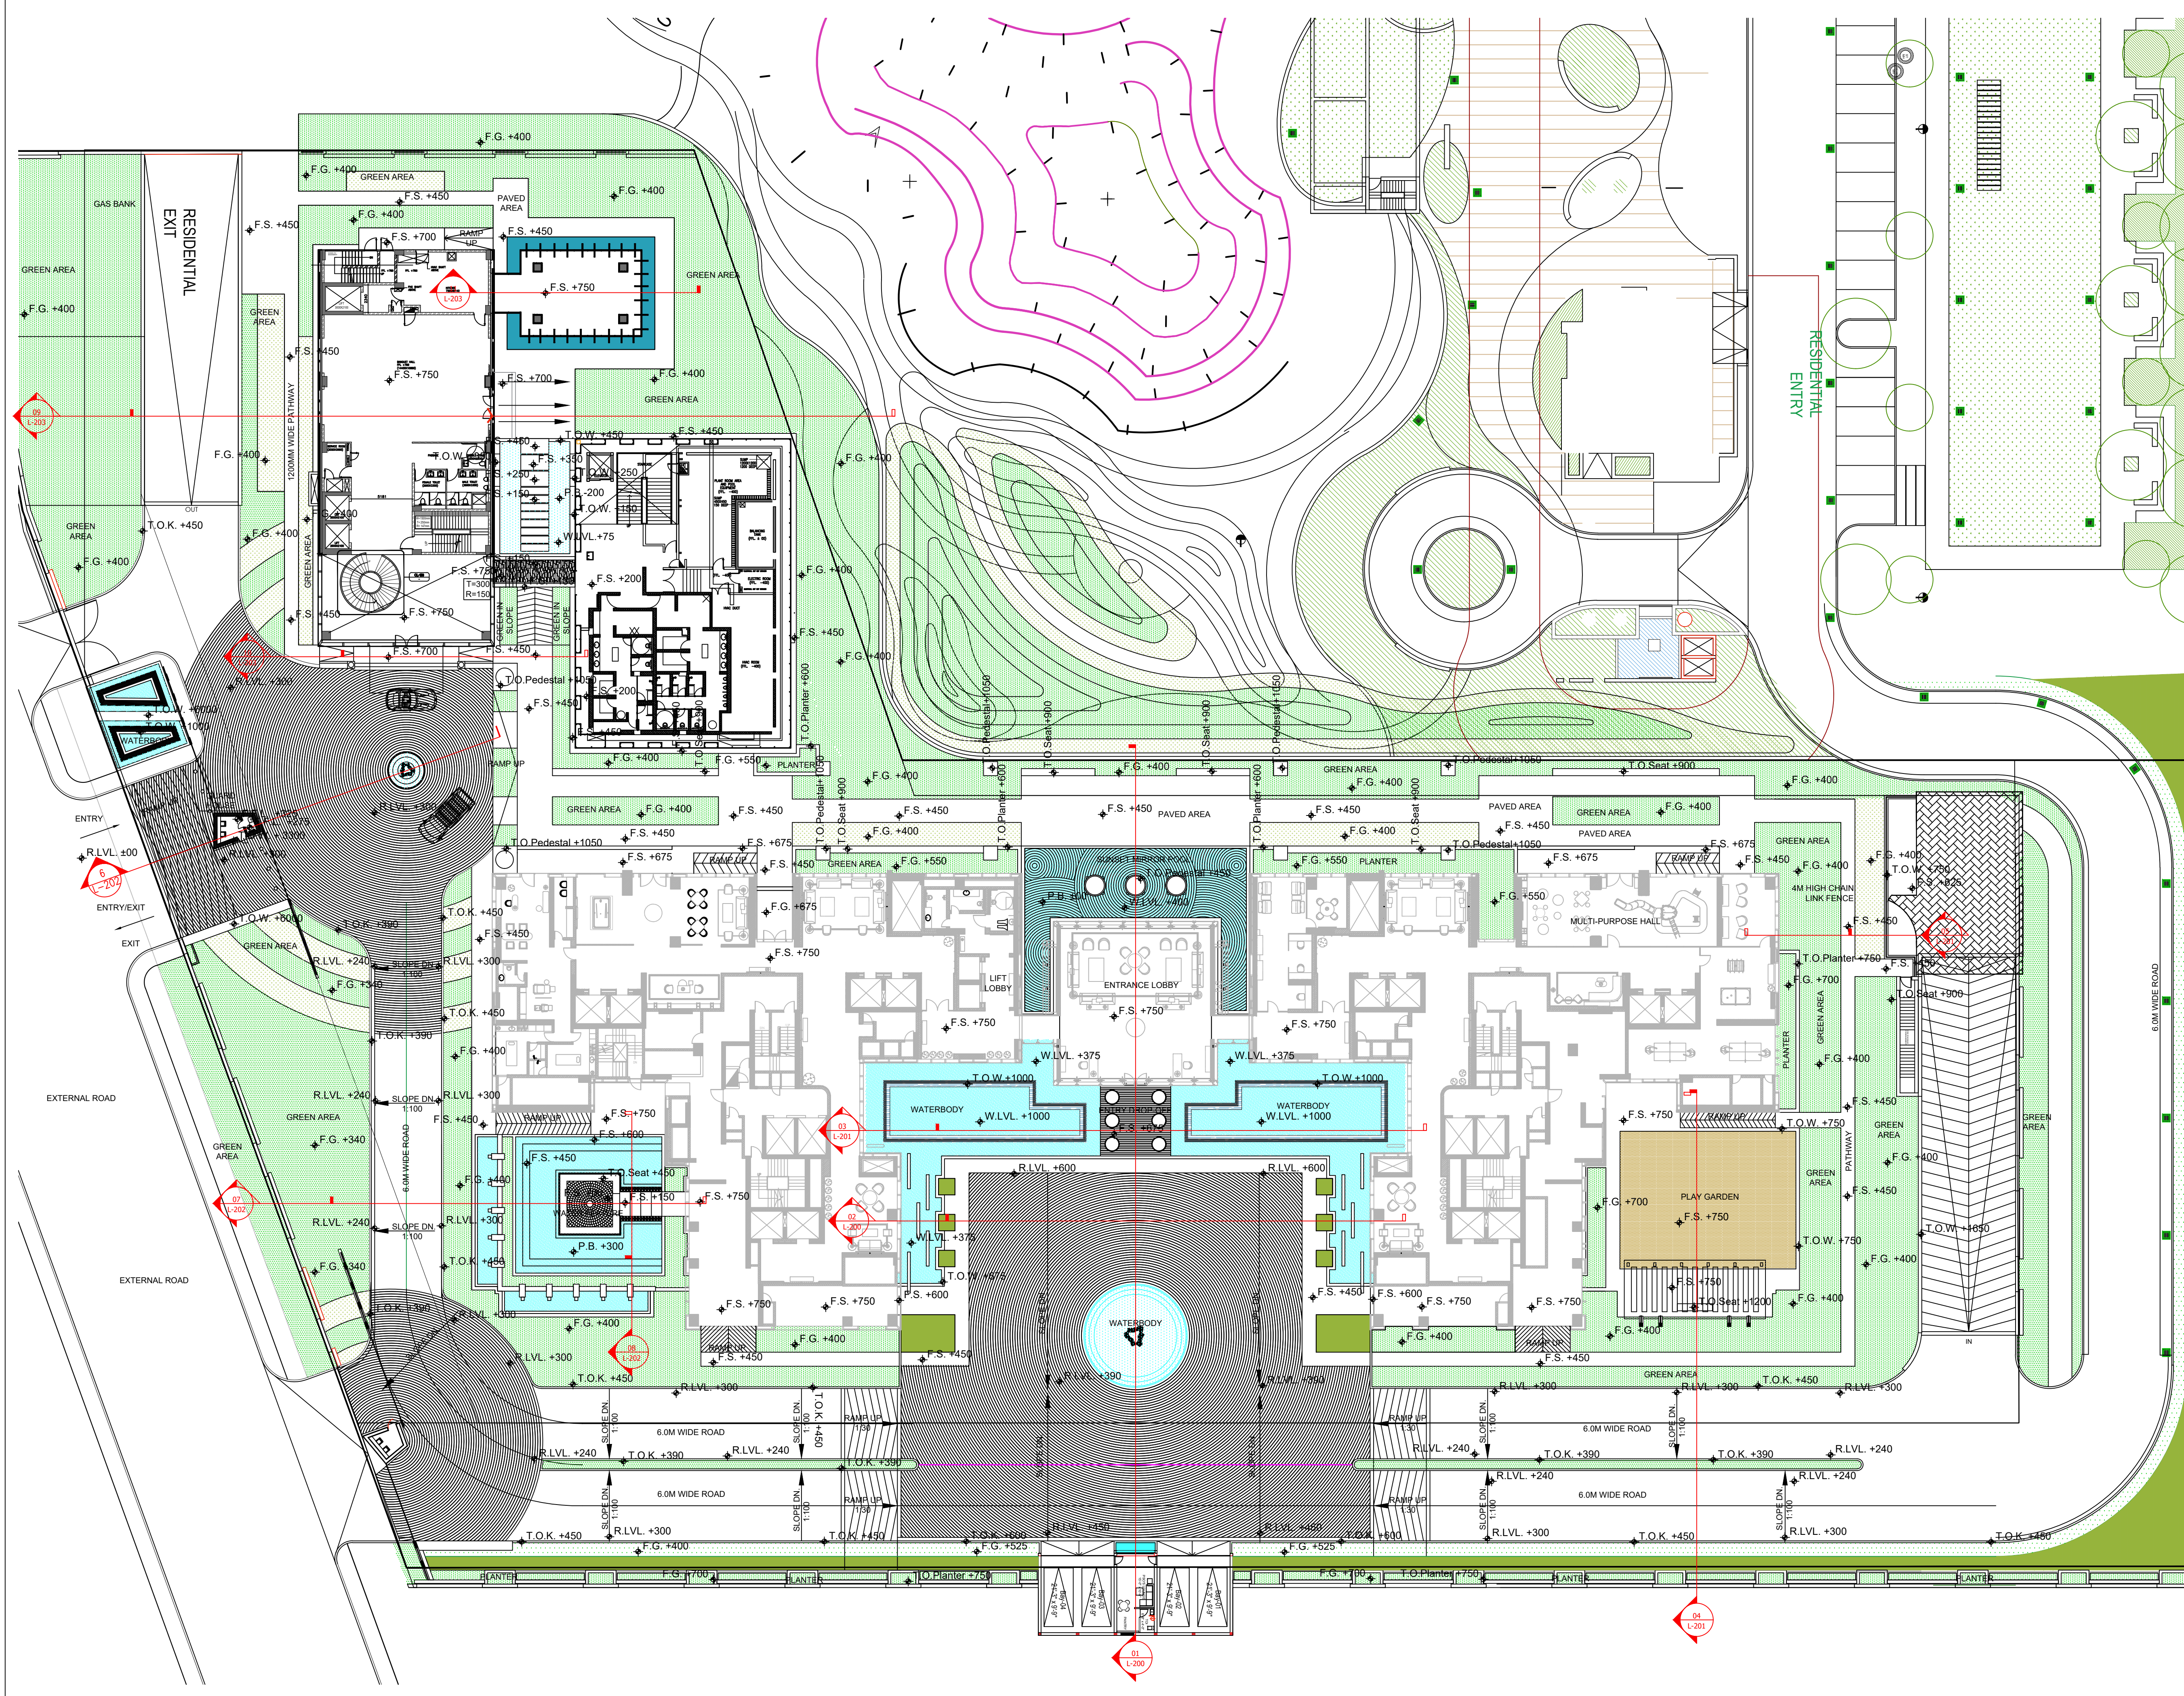

GENERAL NOTES

- All the Dimensions are in MILLIMETERS unless otherwise mentioned.
- All the Levels are in METERS unless otherwise mentioned.
- Do not scale the Drawings.
- This Drawing has to be read in conjunction with relevant Architectural, Structural & MEP Drawings. In case of any discrepancies, bring it to the notice of Engineer and same to be resolved prior to execution of work.
- Dimensions and levels as shown on these drawings relate to finished face/surface unless otherwise specified.
- For finishes, refer to schedule of material finishes.

KEY PLAN :

LEGEND:-

T.O.W. - TOP OF WALL
T.O.S. - TOP OF SLAB
T.O.K. - TOP OF KERB STONE
F.S.C.L. - FINISH SCREED LEVEL
T.O.Portal - TOP OF PORTAL
F.S. - FINISHED SURFACE LEVEL
F.G. - FINISHED GRADE FOR PLANTING SOIL
W.L.VL. - WATER LEVEL
P.B. - POOL BOTTOM
T.O.Plantier - TOP OF PLANTIER
R.L.VL. - ROAD LEVEL

ARCHITECT
morphogenesis
N 85B, Panchsheel park,
New Delhi 110017, India
TEL: +91 11 41828070 FAX: 91 11 26490351
E Mail: studio@morphogenesis.org

CONSULTING STRUCTURAL ENGINEER
MEHRO Consultants
Structural Engineering Division
A-1/36, SAFDARJUNG ENCLAVE,
NEW DELHI- 110 029
Ph.: +91-11- 26194486 / 26172156
Telefax.: +91-11- 46023053

CONSULTING PHE
MKG Engineering Services Pvt Ltd
1st Floor, A-8 Paryavaran Complex,
IGNOU Road
New Delhi - 110030
Ph.: +91-11- 29532720 / 29532257

CONSULTING MVAC
Dewpoint Services Consultants LLP
TA_8&10, 3rd Floor, Crown Plaza,
Sector-15A Faridabad
Haryana

CONSULTING ELECTRICAL
Ampower Consultancy Services
B-222 Second Floor,
Naraina Industrial Area Phase- 1,Near
Bikanerwala
New Delhi -110028
Ph.: +91-11-41414735 / 45054718

LANDSCAPE DESIGN ARCHITECT
Scape Design Associates Ltd
10-18 Vestry Street,
London N1 7RE
Ph.: 020 7729 7989

LANDSCAPE EXECUTIVE ARCHITECT
ORACLES
G-88, KALKAJI, NEW DELHI-110019
+91-11-26481630
Mail@Oracleslandscape.in

PROJECT
TT GURGAON

REV.	DATE	DESCRIPTION	REV. BY
R5	24-01-23	UPDATED ENTRANCE LOBBY	SATYA
R4	21-01-23	REVISED PLAN	SATYA
R3	10-03-21	REVISED CLUB AREA	MUMTAZ
R2	11-12-20	REVISED CLUB WATERBODY	MUMTAZ
R1	03-09-19	REVISED CONCEPT	MUMTAZ
R0	14-04-19	ISSUED DD PACKAGE	MUMTAZ

ISSUE STATUS:-

DRAWING NAME		
GRADING PLAN		
DRAWING NO.	REVISION	NORTH
OR-TTG-L-H-GL-100	R5	
Issued By	Drawn by	Chkd by
Scale : 1:250	MUMTAZ	S.M.
Date : 11-12-2020		