



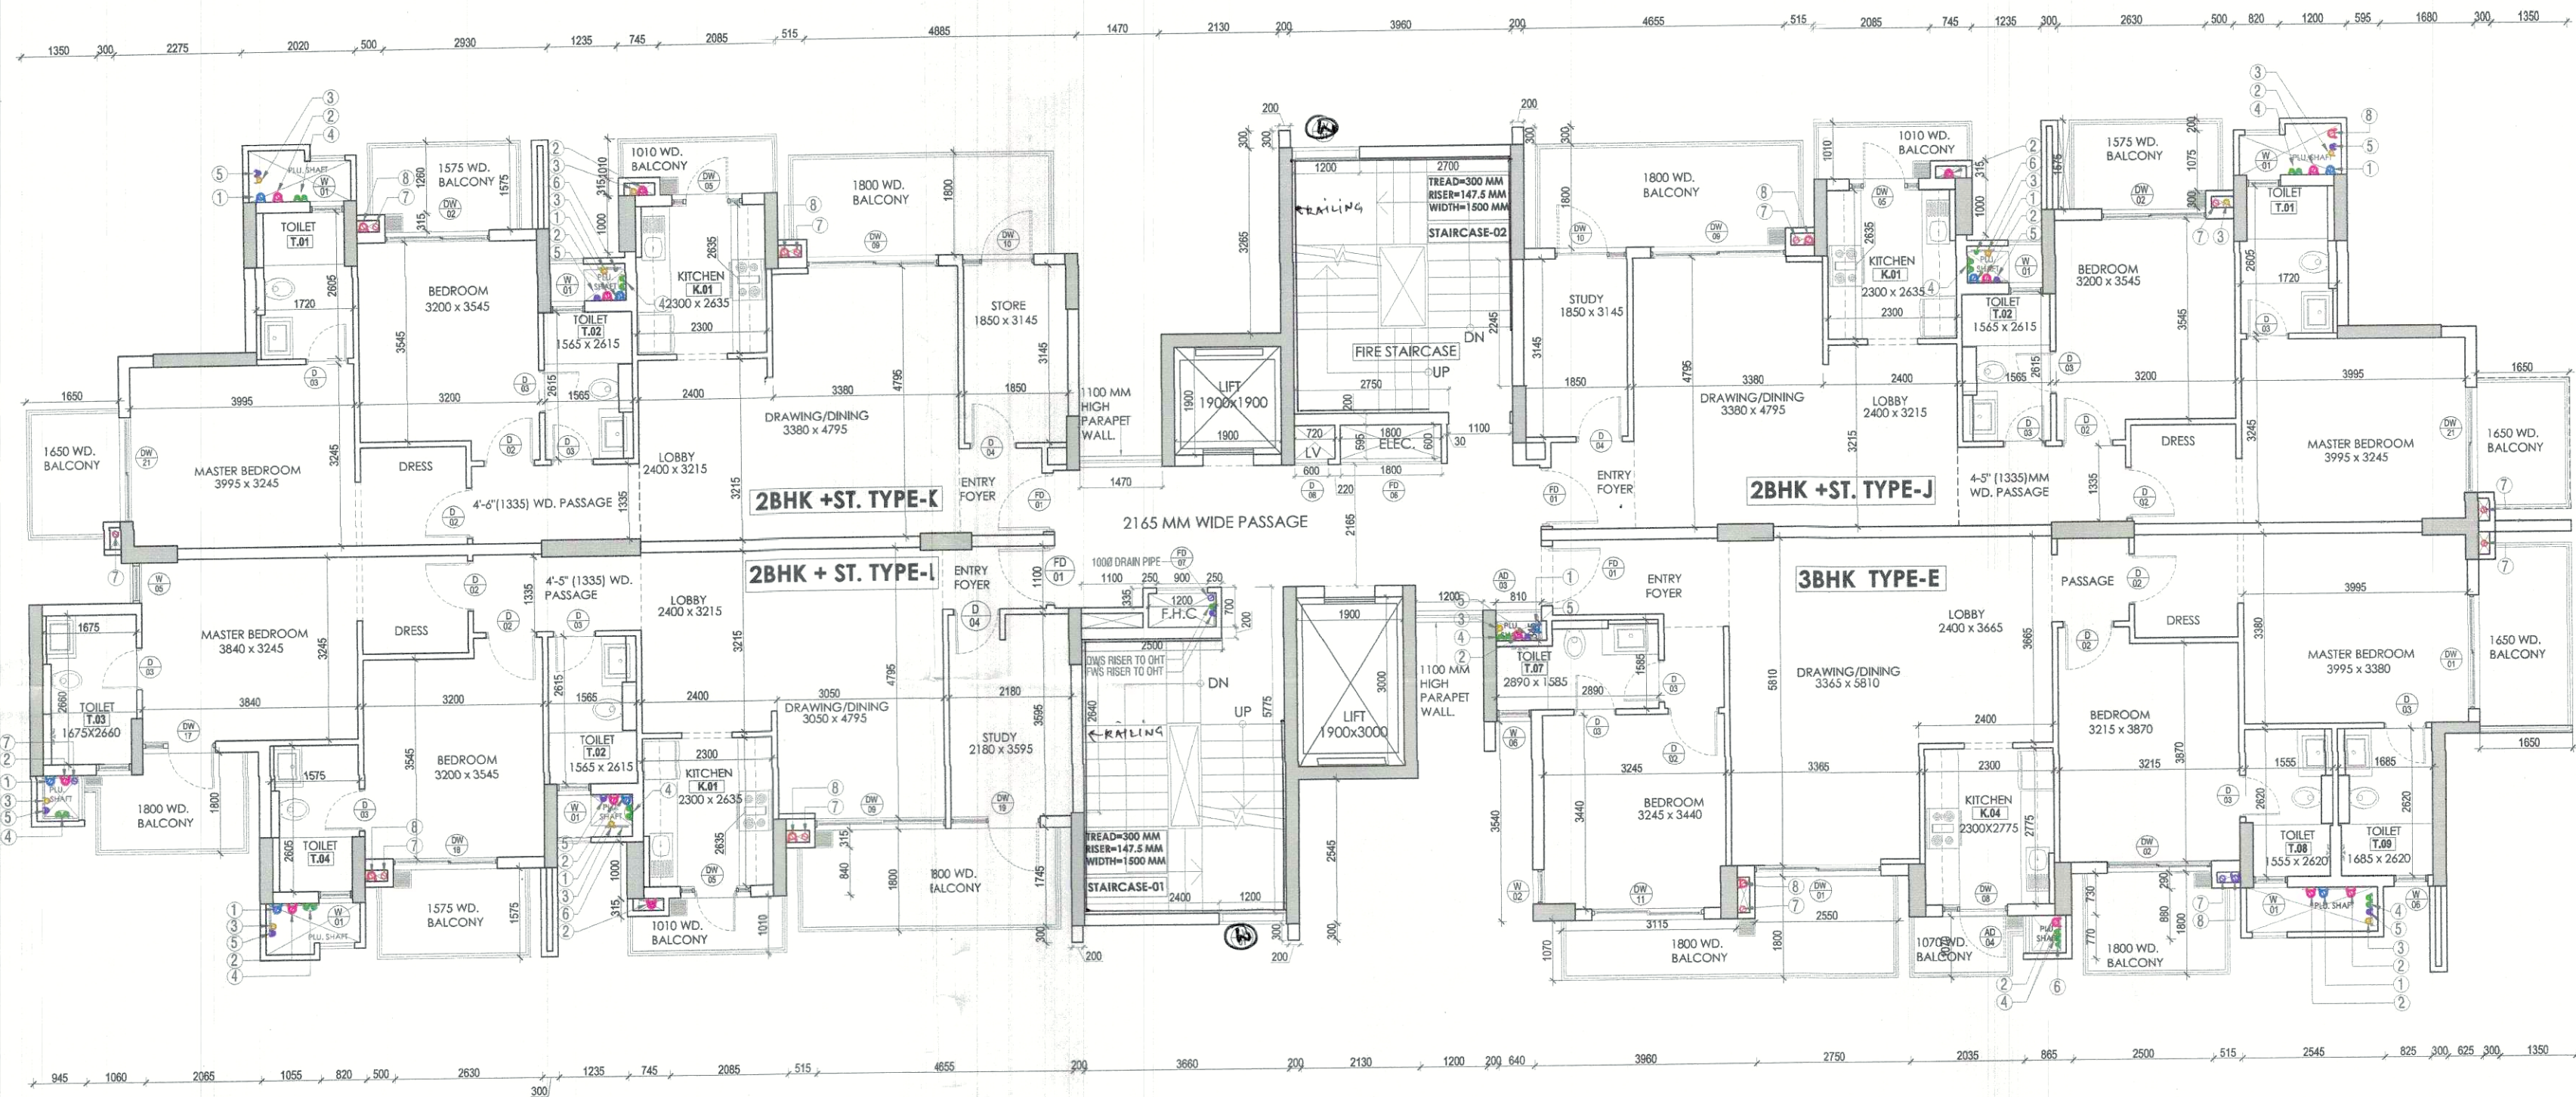

TOWER - 05

TYPICAL(1ST-7TH) FLOOR PLAN

TOILET DETAIL (C/P/100)

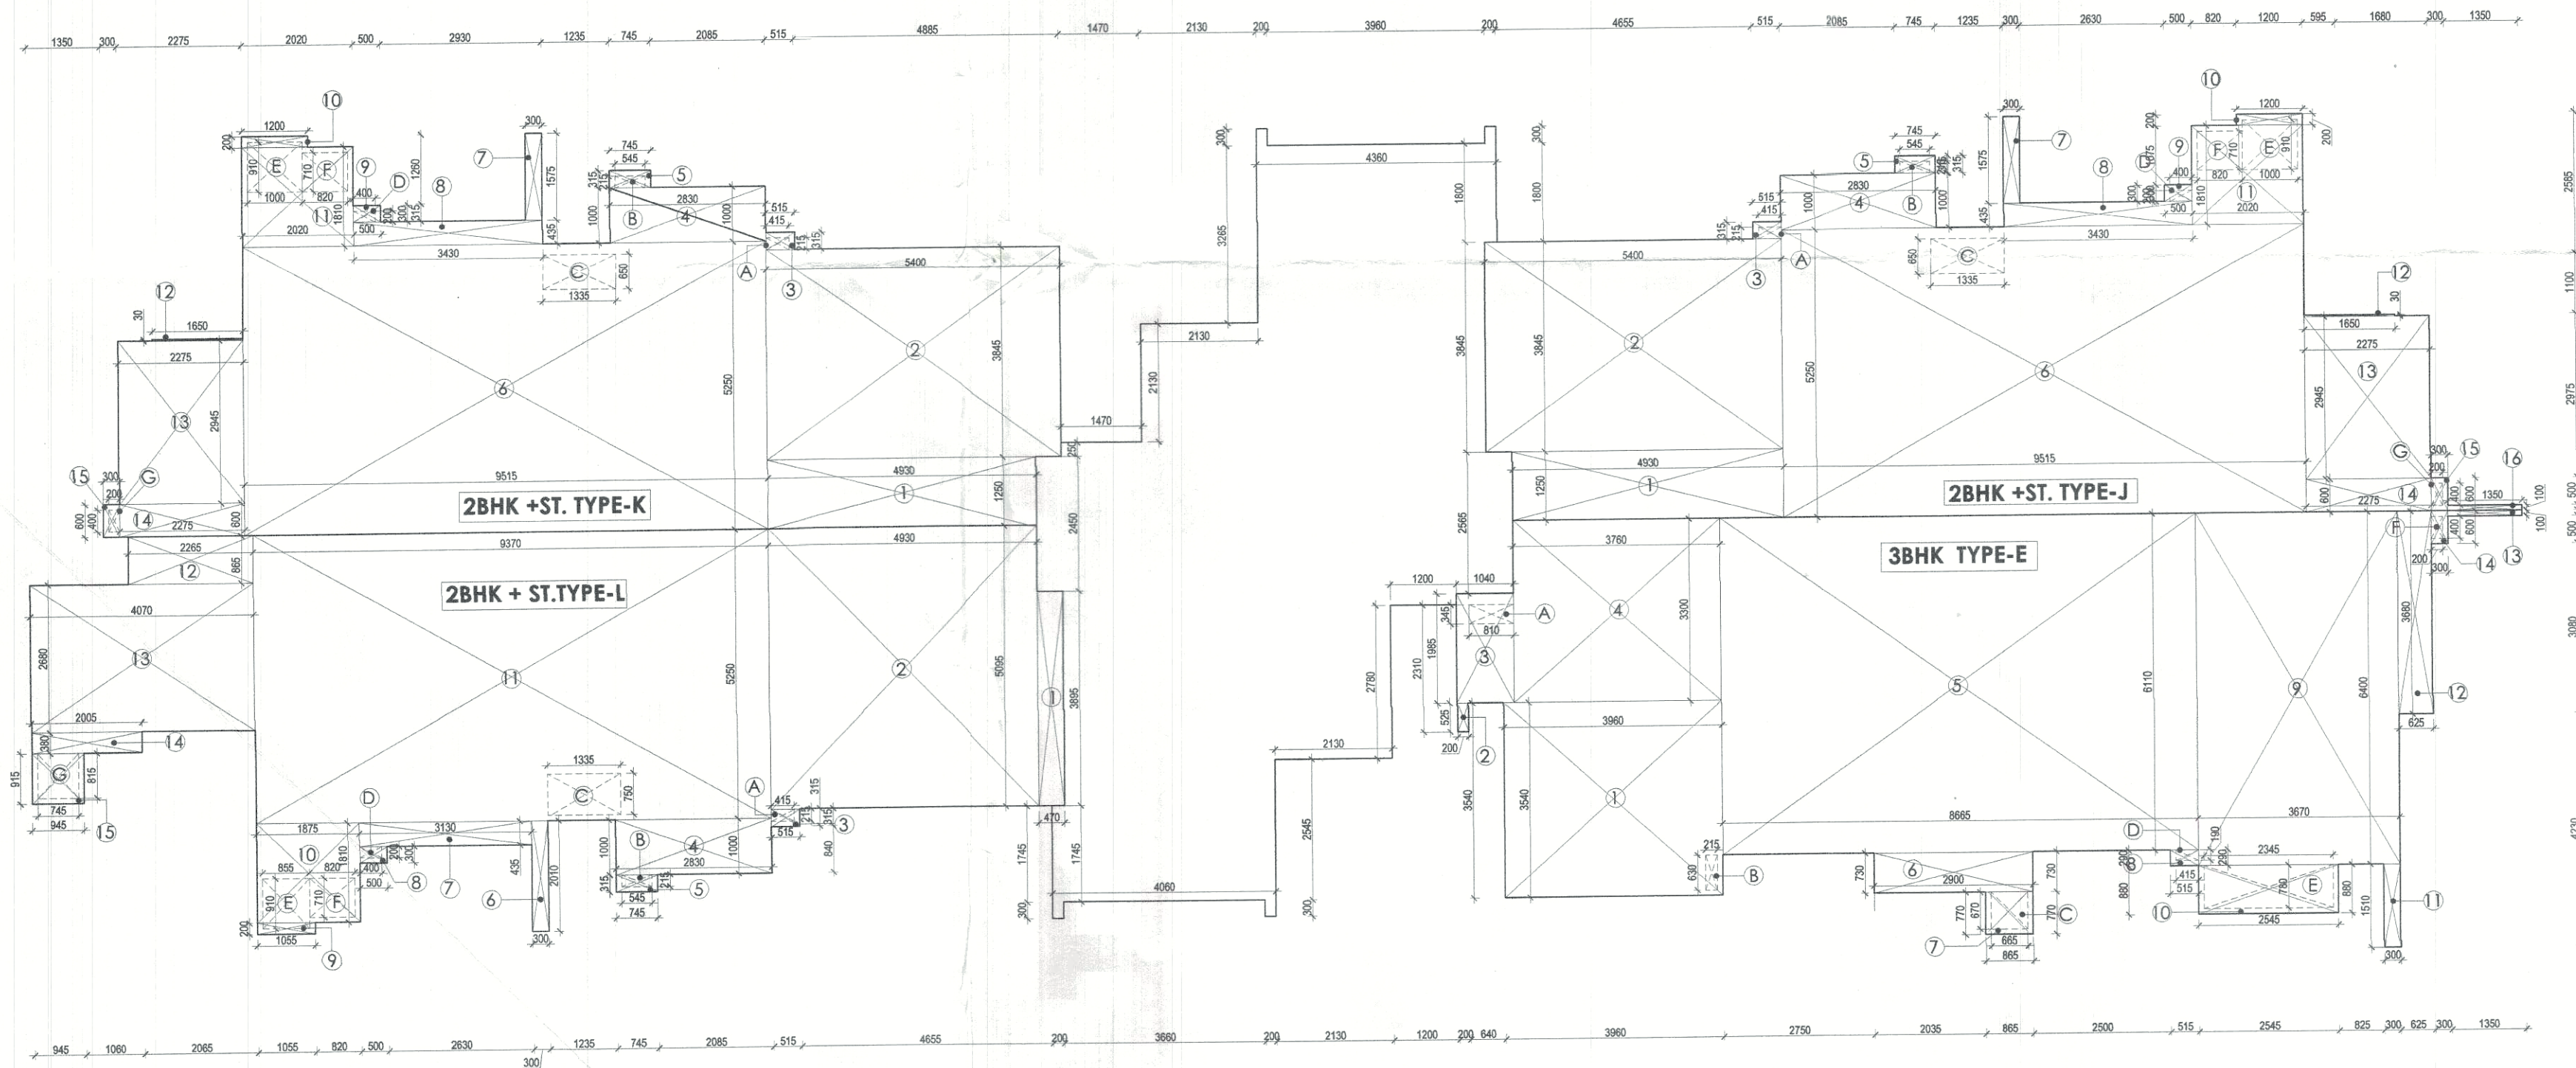

TOWER - 05

TYPICAL (1ST -7TH)FLOOR UNIT AREA CALCULATION PLAN

TOILET/KITCHEN SCHEDULE

TOILET & KITCHEN DETAILS FOR TYPICAL FLOOR				
S.NO.	TYPE	LENGTH	WIDTH	NUMBER
1	T01	1.720	2.605	02
2	T02	1.565	2.605	03
3	T03	1.675	2.660	01
4	T04	1.575	2.605	01
5	T07	2.890	1.585	01
6	T08	1.555	2.620	01
7	T09	1.885	2.620	01
9	K01	2.300	2.635	03
10	K04	2.300	2.775	01

PLUMBING LEGEND

- 1000 SOIL PIPE (SP)
- 1000 WASTE PIPE (WP)
- 750 VENT PIPE (VP)
- DWS DN. TAKE
- FWS DN. TAKE
- HWS DN. TAKE
- 1000 RWP/BALCONY DRAIN
- 1500 RWP
- FWS = FLUSHING WATER SUPPLY
- DWS = DOMESTIC WATER SUPPLY

FAR STATEMENT - TYPICAL FLOOR

TYPICAL FLOOR				
S. NO.	TYPE	NOS	FAR AREA	TOTAL FAR AREA
AREAS				
1	2 bhk+St. Type J	1	92.265000	92.265000
2	2 bhk+St. Type K	1	91.585000	91.585000
3	2 bhk+St. Type L	1	96.324000	96.324000
4	3 bhk Type E	1	110.910000	110.910000
5	Core	1	32.817850	32.817850
TOTAL F.A.R. AREA OF TYPICAL FLOOR			423.904 or 423.9 SQ. M	

CORE CALCULATION				
COVERED AREA				
S. NO.	Length	Breadth	Number	AREA SQ. M
1	0.200	0.300	4	0.240000
2	0.400	1.745	1	0.698000
3	0.470	2.450	1	1.151500
4	3.830	6.595	1	25.298850
5	2.130	2.780	1	5.921400
6	3.330	3.015	1	10.039950
7	1.040	2.565	1	2.667600
8	0.570	0.250	1	0.142500
9	2.130	2.130	1	4.536900
10	4.130	3.595	1	14.847350
11	4.360	1.800	1	7.848000
TOTAL				79.738750
F.A.R.= Covered Area				
79.738750				
DEDUCTION				
A	3.600	4.875	1	17.550000
B	1.100	0.265	1	0.291500
C	1.200	0.600	1	0.720000
D	1.900	3.000	1	5.700000
E	1.900	1.900	1	3.610000
F	0.720	0.595	1	0.428400
G	1.800	0.595	1	1.071000
H	4.500	3.900	1	17.550000
TOTAL				46.9209
F.A.R.= Covered Area - Deduction				
32.81785				

TYPICAL FLOOR CORE AREA CALCULATION PLAN

FAR AREA STATEMENT

2BHK + STUDY (TYPE K)				
COVERED AREA				
S. NO.	Length	Breadth	Number	AREA SQ. M
1	4.930	1.250	1	6.162500
2	5.400	3.845	1	20.763000
3	0.515	0.315	1	0.162225
4	2.830	1.000	1	2.830000
5	0.745	0.315	1	0.234675
6	9.515	5.250	1	49.953750
7	0.300	1.575	1	0.472500
8	3.430	0.435	1	1.492050
9	0.500	0.300	1	0.150000
10	1.200	0.200	1	0.240000
11	2.020	1.810	1	3.656200
12	1.650	0.030	1	0.049500
13	2.275	2.945	1	6.699875
14	2.275	0.600	1	1.365000
15	0.300	0.600	1	0.180000
TOTAL				94.411275
DEDUCTION				
A	0.415	0.215	1	0.089225
B	0.545	0.215	1	0.117175
C	1.335	0.650	1	0.867750
D	0.400	0.200	1	0.080000
E	1.000	0.910	1	0.910000
F	0.820	0.710	1	0.582200
G	0.200	0.400	1	0.080000
TOTAL				2.726350
F.A.R.= Covered Area - Deduction				
91.585000				


2BHK + STUDY (TYPE J)				
COVERED AREA				
S. NO.	Length	Breadth	Number	AREA SQ. M
1	4.930	1.250	1	6.162500
2	5.400	3.845	1	20.763000
3	0.515	0.315	1	0.162225
4	2.830	1.000	1	2.830000
5	0.745	0.315	1	0.234675
6	9.515	5.250	1	49.953750
7	0.300	1.575	1	0.472500
8	3.430	0.435	1	1.492050
9	0.500	0.300	1	0.150000
10	1.200	0.200	1	0.240000
11	2.020	1.810	1	3.656200
12	1.650	0.030	1	0.049500
13	2.275	2.945	1	6.699875
14	2.275	0.600	1	1.365000
15	0.300	0.600	1	0.180000
16	1.350	0.100	1	0.135000
TOTAL				94.991775
DEDUCTION				
A	0.415	0.215	1	0.089225
B	0.545	0.215	1	0.117175
C	1.335	0.650	1	0.867750
D	0.400	0.200	1	0.080000
E	1.000	0.910	1	0.910000
F	0.820	0.710	1	0.582200
G	0.200	0.400	1	0.080000
TOTAL				2.726350
F.A.R.= Covered Area - Deduction				
92.265000				

2BHK + STUDY (TYPE L)				
COVERED AREA				
S. NO.	Length	Breadth	Number	AREA SQ. M
1	4.930	3.895	1	1.830650
2	4.930	5.095	1	25.118350
3	0.515	0.315	1	0.162225
4	2.830	1.000	1	2.830000
5	0.745	0.315	1	0.234675
6	0.300	2.010	1	0.603000
7	3.130	0.435	1	1.361550
8	0.500	0.300	1	0.150000
9	1.055	0.200	1	0.211000
10	1.875	1.810	1	3.393750
11	9.370	5.250	1	49.192500
12	2.265	0.865	1	1.959225
13	4.070	2.680	1	10.907600
14	2.005	0.380	1	0.761900
15	0.945	0.915	1	0.864675
TOTAL				99.581100
DEDUCTION				
A	0.415	0.215	1	0.089225
B	0.545	0.215	1	0.117175
C	1.335	0.750	1	1.001250
D	0.400	0.200	1	0.080000
E	0.855	0.910	1	0.778050
F	0.820	0.710	1	0.582200
G	0.745	0.815	1	0.607175
TOTAL				3.255075
F.A.R.= Covered Area - Deduction				
96.324000				

3BHK TYPE - E				
COVERED AREA				
S. NO.	Length	Breadth	Number	AREA SQ. M
1	3.960	3.540	1	14.018400
2	0.200	0.525	1	0.105000
3	1.040	1.985	1	2.064400
4	3.760	3.300	1	12.408000
5	3.645	6.110	1	22.283150
6	2.900	0.730	1	2.117000
7	0.865	0.770	1	0.666050
8	0.515	0.290	1	0.149350
9	3.670	6.400	1	23.48800
10	2.545	0.880	1	2.239600
11	0.300	1.510	1	0.453000
12	0.625	3.680	1	2.300000
13	1.350	0.100	1	0.135000
14	0.300	0.600	1	0.180000
TOTAL				113.26695
DEDUCTION				
A	0.810	0.345	1	0.278550
B	0.215	0.630	1	0.135450
C	0.665	0.670	1	0.445450
D	0.415	0.190	1	0.078850
E	2.345	0.780	1	1.829100
F	0.200	0.400	1	0.080000
TOTAL				2.815940
F.A.R.= Covered Area - Deduction				
110.91				

TOWER-05

DOOR/DOOR-WINDOW SCHEDULE				
S.NO.	TYPE	WIDTH	HEIGHT	DESCRIPTION
1	D01	1050	2250	FLUSH DOOR
2	D02	800	2250	FLUSH DOOR
3	D03	750	2250	FLUSH DOOR
4	D04	825	2250	FLUSH DOOR
5	D05	800	2250	FLUSH DOOR
6	D06	1200	2250	FLUSH DOOR
7	D07	1000	2400	FLUSH DOOR
8	D08	800	2400	FLUSH DOOR
9	F001	1100	2100	FIRE DOOR
10	F002	1800	2400	FIRE DOOR
11	F003	1200	1200	FIRE DOOR
12	F004	750	1200	FIRE DOOR
13	D001	2250	2400	DOOR CUM WINDOW
14	D002	1450	2400	DOOR CUM WINDOW
15	D003	2500	2400	DOOR CUM WINDOW
16	D005	1650	2400	DOOR CUM WINDOW
17	D006	2000	2400	DOOR CUM WINDOW
18	D007	1300	2400	DOOR CUM WINDOW
19	D008	1500	2400	DOOR CUM WINDOW
20	D010	3500	2400	DOOR CUM WINDOW
21	D011	1800	2400	DOOR CUM WINDOW
22	D012	4750	2400	DOOR CUM WINDOW
23	D013	3300	2400	DOOR CUM WINDOW
24	D014	2800	2400	DOOR CUM WINDOW
25	D016	4650	2400	DOOR CUM WINDOW
26	D017	1300	2400	DOOR CUM WINDOW
27	D018	1850	2400	DOOR CUM WINDOW
28	D019	1600	2400	DOOR CUM WINDOW
29	D020	6000	2400	DOOR CUM WINDOW
30	W01	800	1500	AL GLAZED WINDOW
31	W02	800	1500	AL GLAZED WINDOW
32	W03	450	1500	AL GLAZED WINDOW
33	W04	500	1500	AL GLAZED WINDOW
34	W05	750	1500	AL GLAZED WINDOW
35	W06	800	1500	AL GLAZED WINDOW
36	W07	1000	1500	AL GLAZED WINDOW
37	W08	1500	2400	AL GLAZED WINDOW
38	W09	1200	2400	AL GLAZED WINDOW
39	W10	1470	2400	AL GLAZED WINDOW
40	W11	800	1800	AL GLAZED WINDOW
41	W12	800	1900	AL GLAZED WINDOW

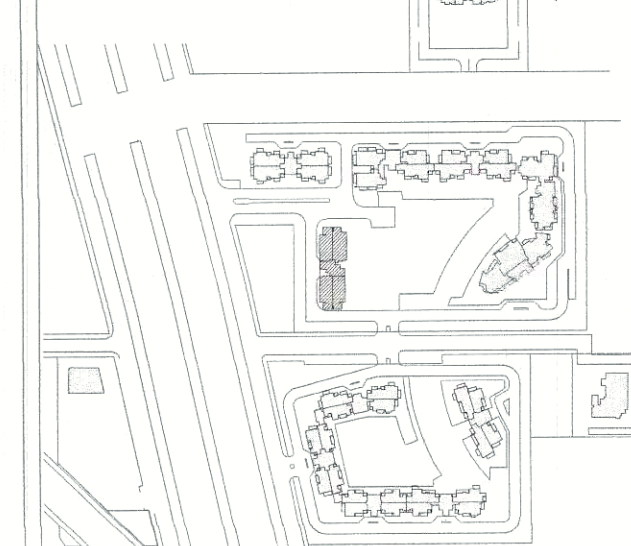

KEY PLAN
SCALE: 1:500

ELECTRICAL & PLUMBING CONSULTANTS:
AECOM
A-197, Sector-63
Noida 201301
Uttar Pradesh, India
T: +91 120 4049000
F: +91 120 4049001
www.aecom.com