
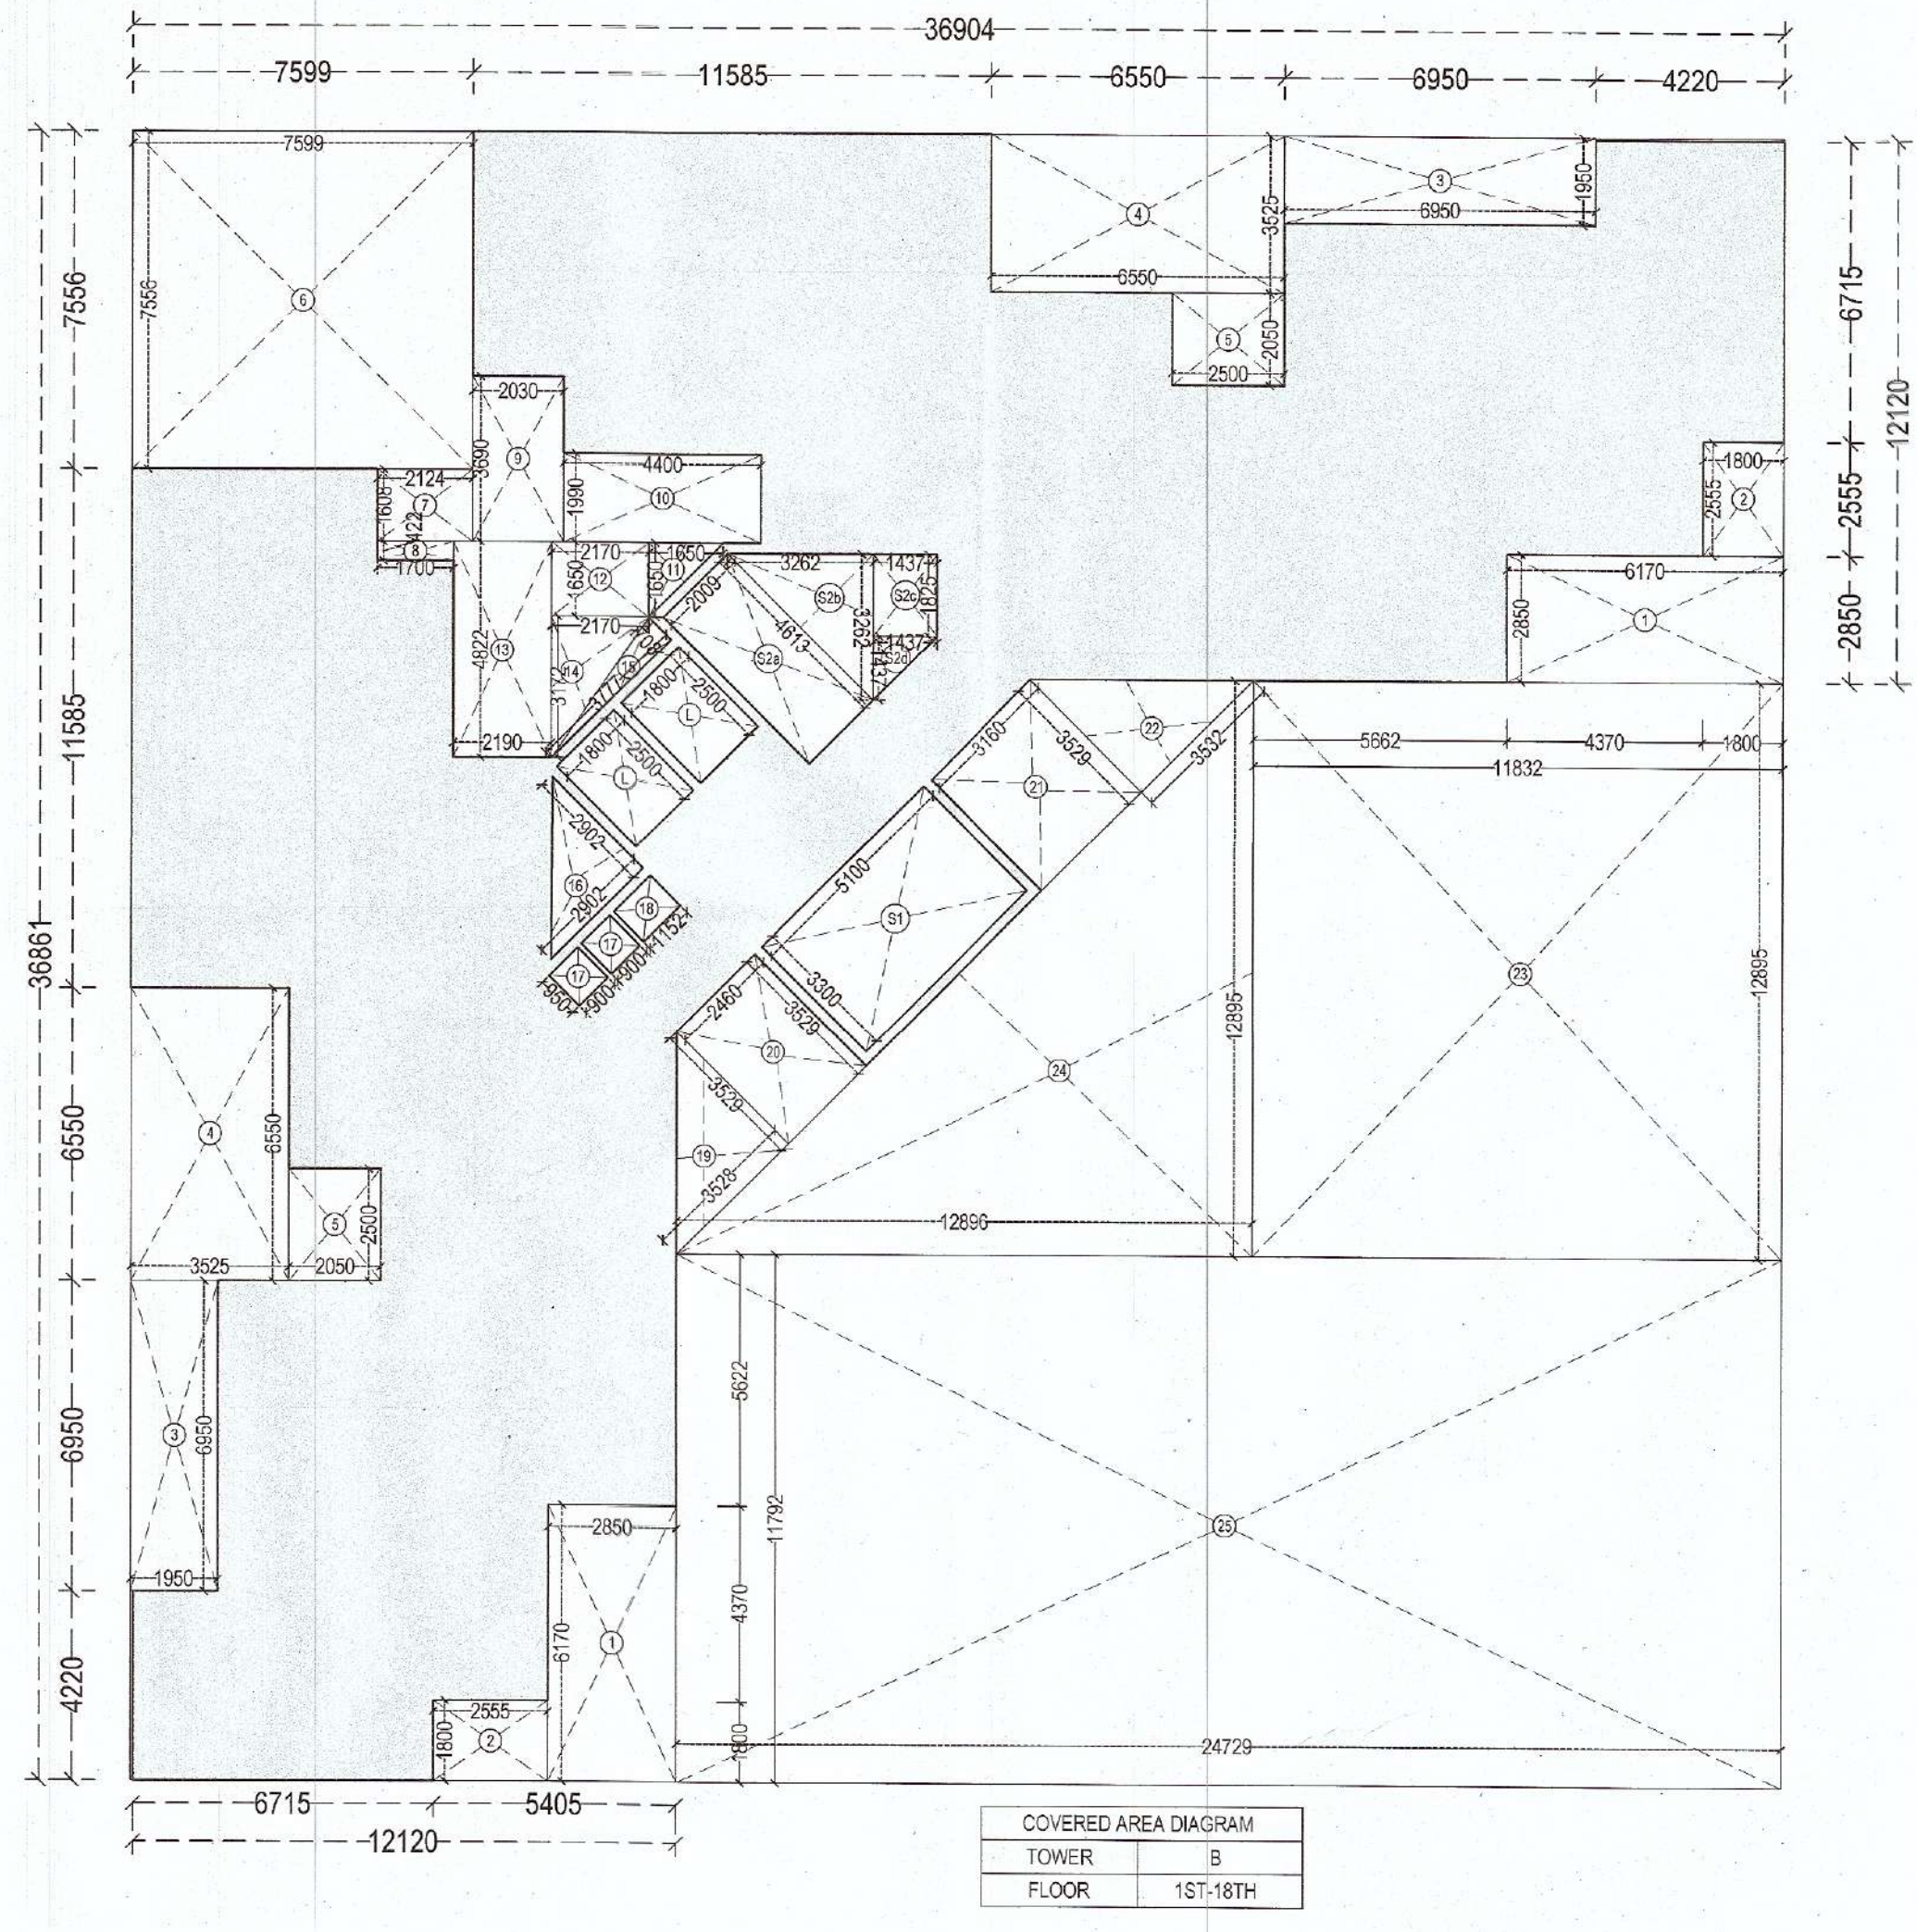
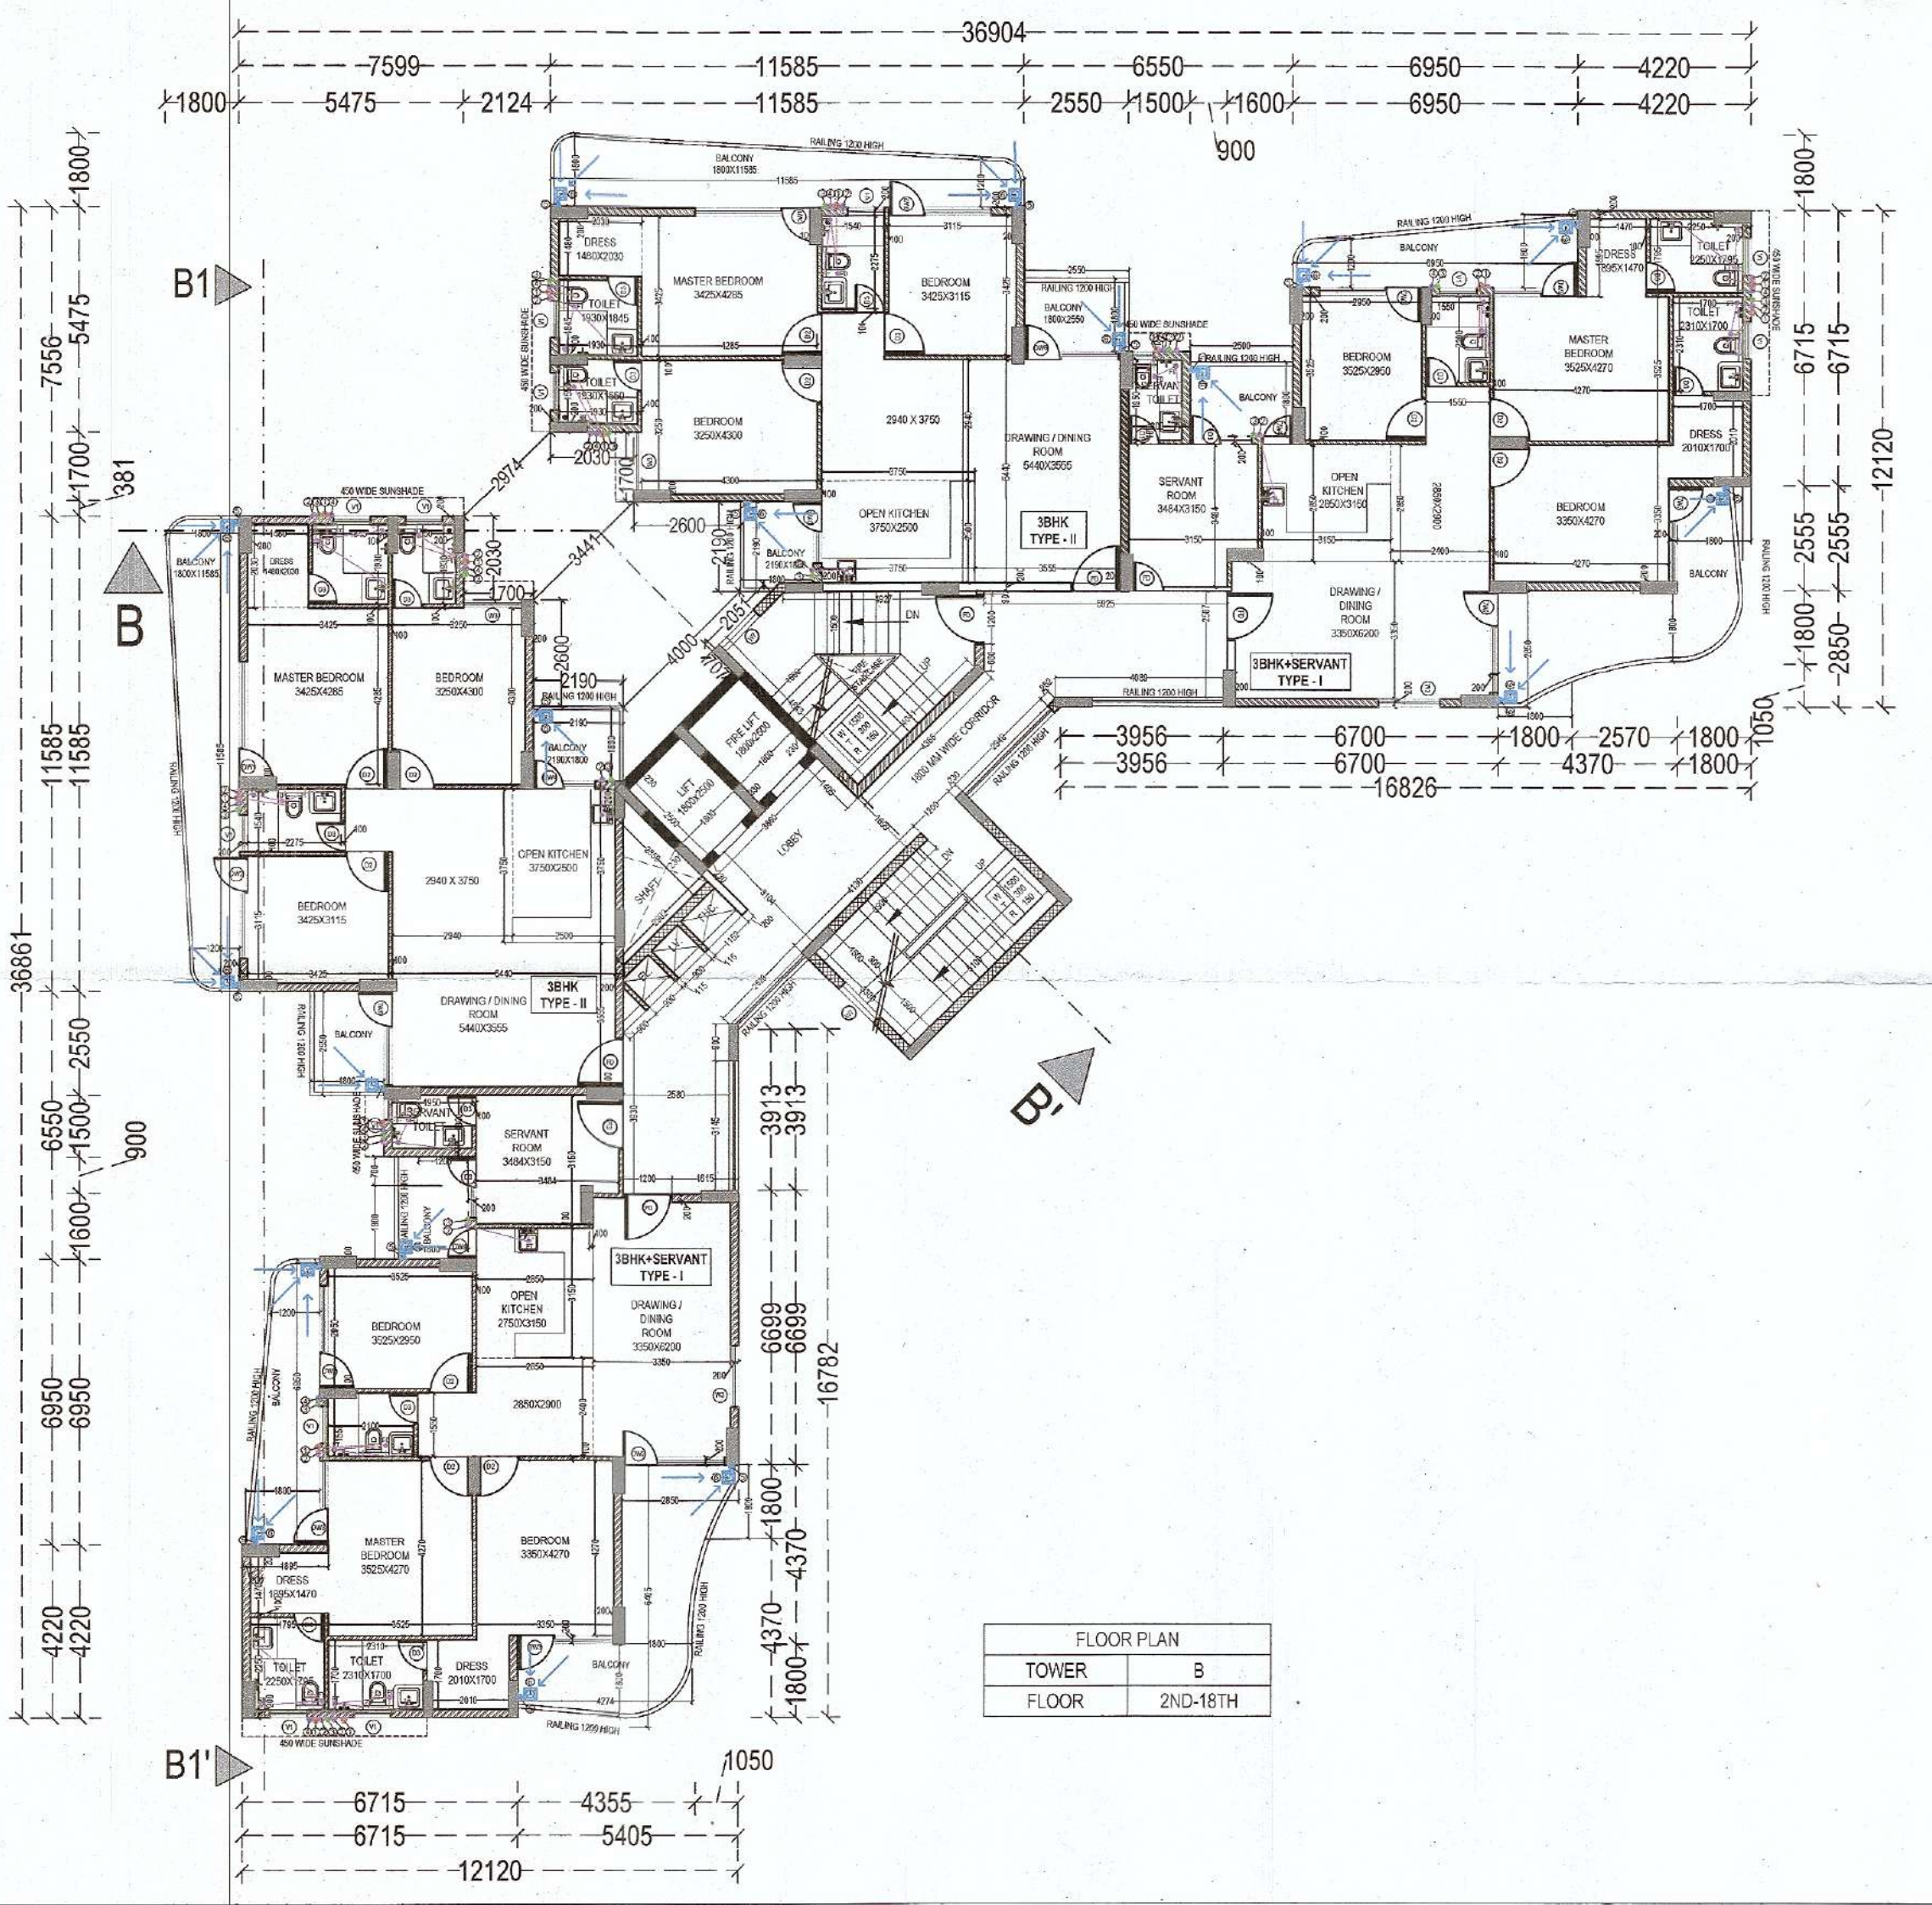


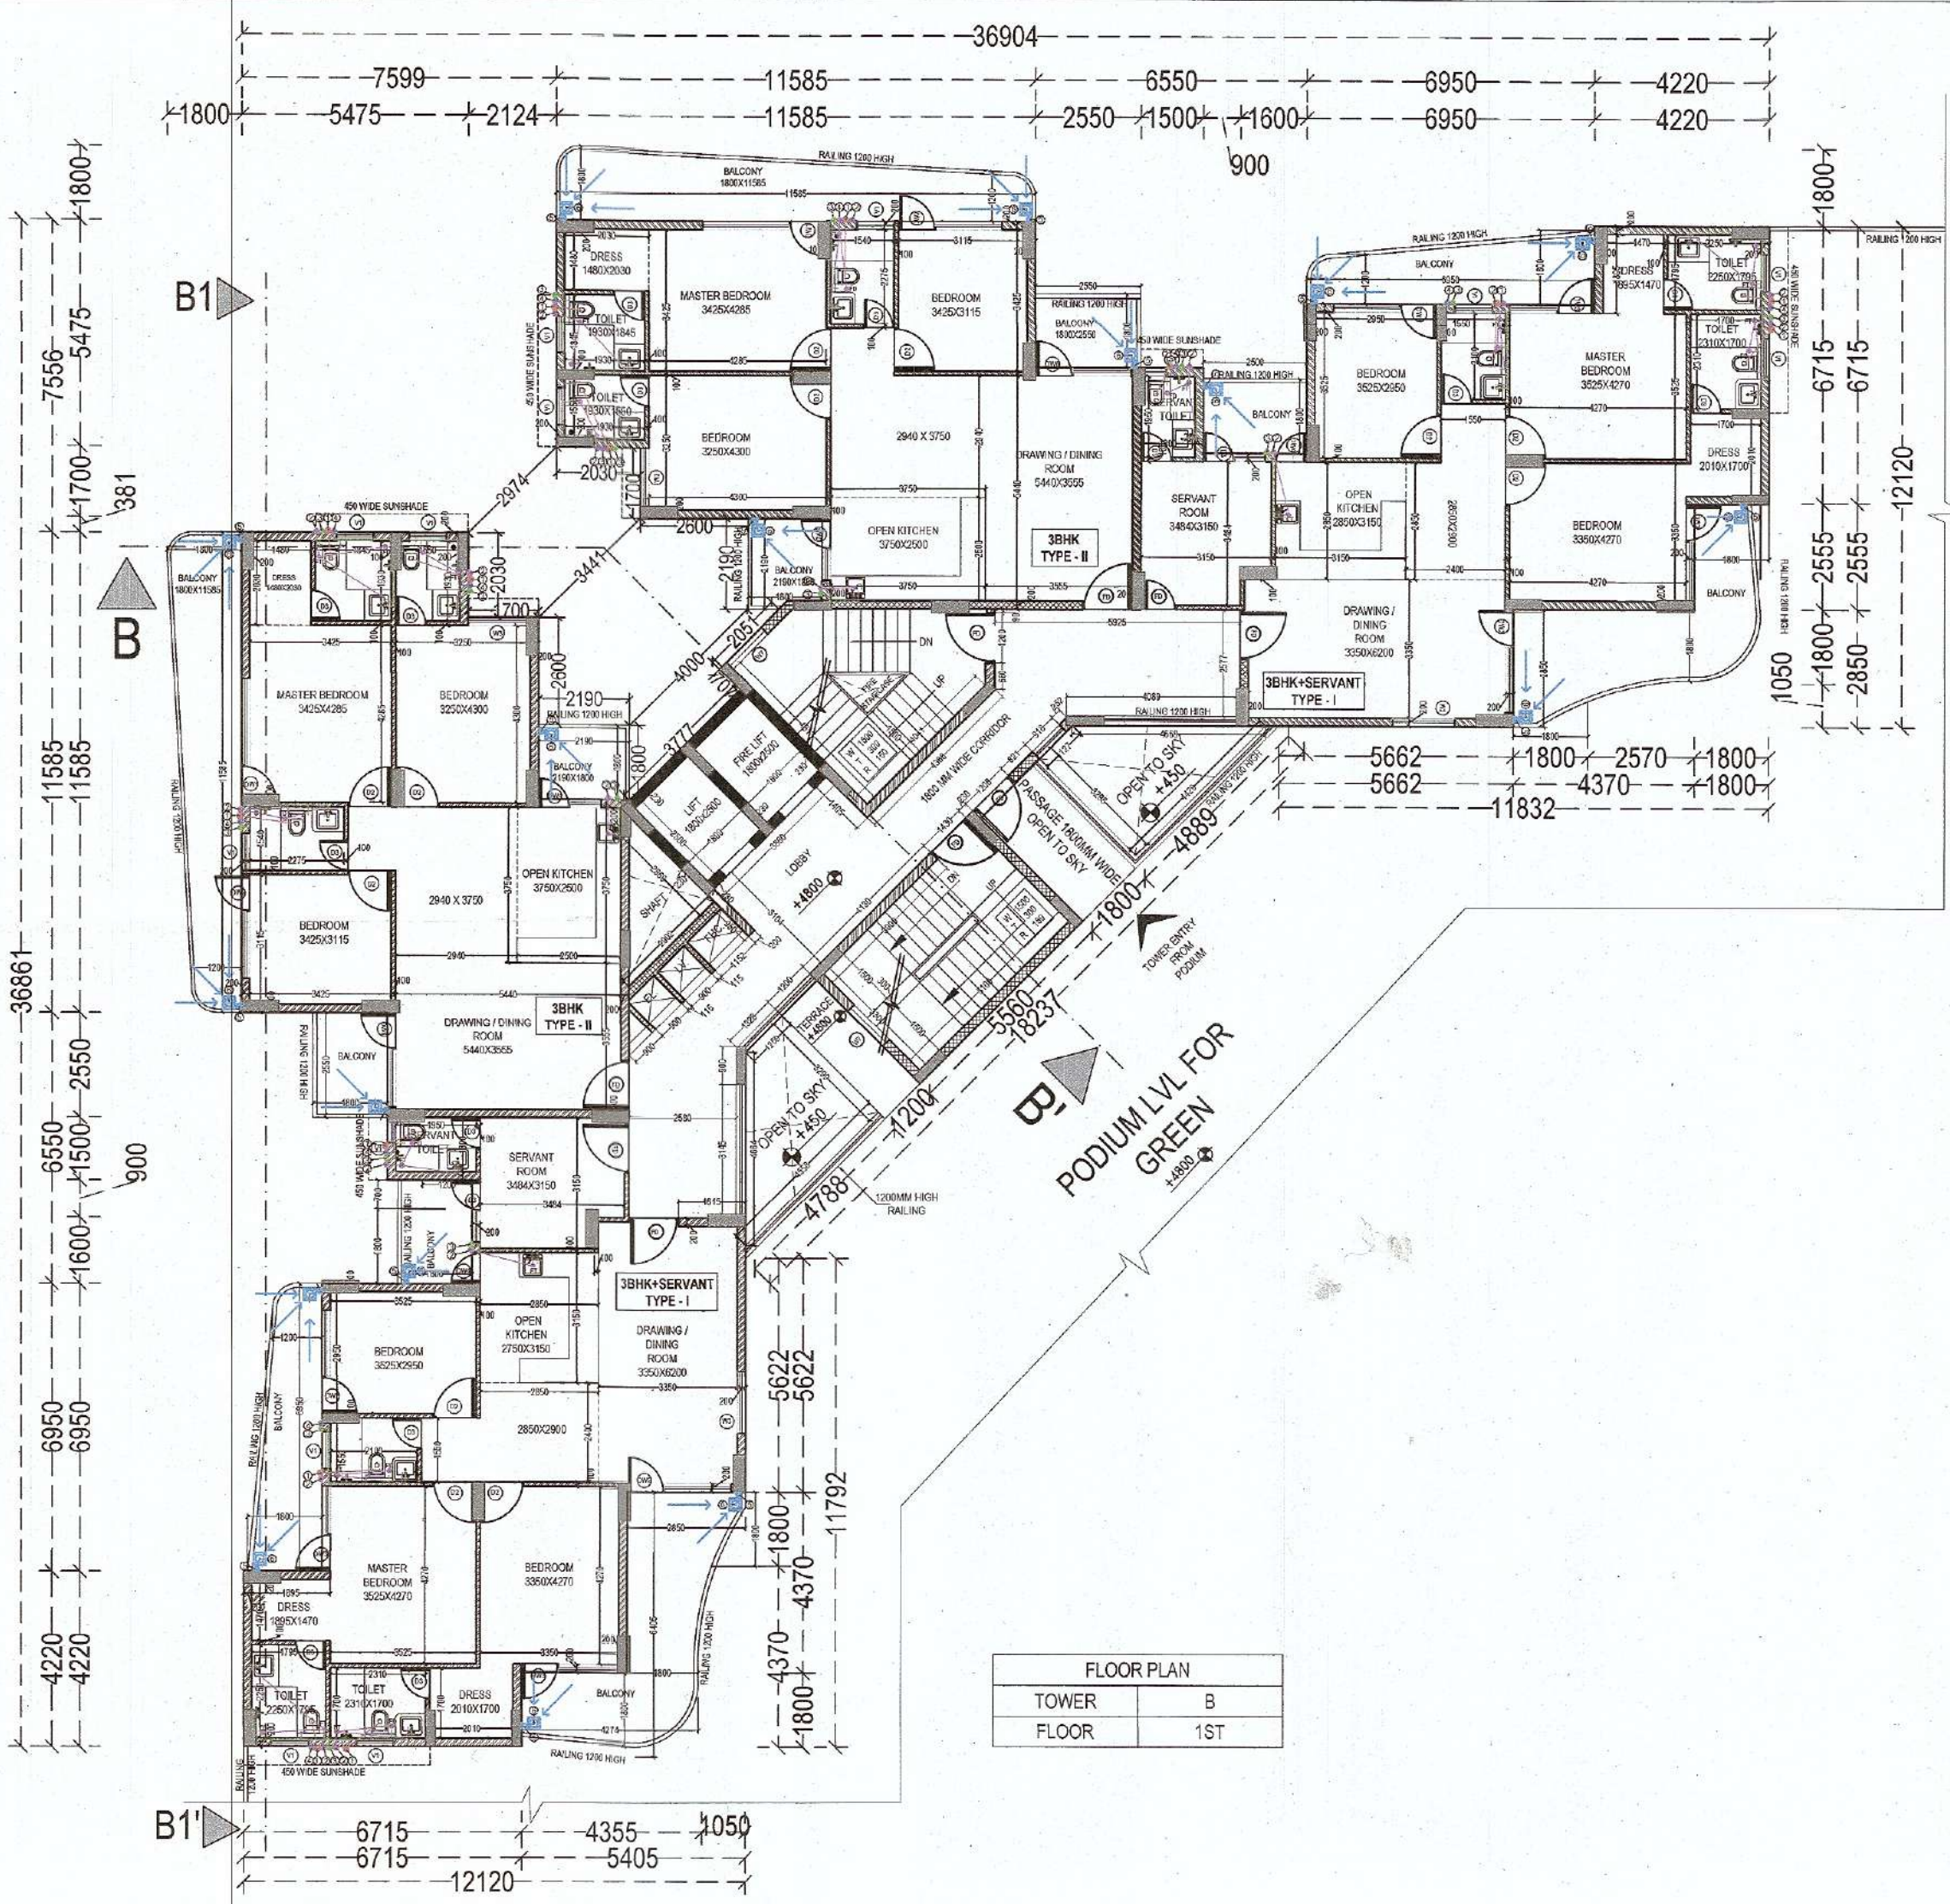

COVERED AREA				
TOWER B				
FLOOR 1ST TO 18TH				
NAME	NO.	LENGTH	WIDTH	AREA (IN SQ. MT.)
ADDITION				
SUBTRACTION				
1	-2	6.170	2.950	-35.166
2	-2	2.555	1.900	-8.158
3	-2	6.950	1.950	-27.105
4	-2	6.550	3.525	-46.178
5	-2	2.500	2.350	-10.250
6	-1	7.509	7.556	-57.418
7	-1	2.124	1.908	-3.415
8	-1	1.700	0.422	-0.717
9	-1	2.030	3.390	-7.491
10	-1	4.400	1.990	-8.756
11	-0.5	1.650	1.650	-1.361
12	-1	2.170	1.650	-3.581
13	-1	2.190	4.822	-10.360
14	-0.5	2.170	3.172	-3.442
15	-0.5	0.708	3.777	-1.337
16	-0.5	2.502	2.902	-4.211
17	-2	0.900	0.950	-1.710
18	-1	1.152	0.950	-1.094
19	-0.5	3.528	3.529	-6.225
20	-1	2.460	3.529	-8.881
21	-1	3.190	3.529	-11.152
22	-0.5	3.532	3.529	-6.232
23	-1	11.832	12.895	-152.574
24	-0.5	12.895	12.895	-83.147
25	-1	24.729	11.792	-291.024
S1	-1	5.100	3.300	-16.830
S2a	-1	2.009	4.813	-9.769
S2b	-0.5	3.262	3.262	-5.301
S2c	-1	1.437	1.825	-2.623
S2d	-0.5	1.437	1.437	-1.032
L	-2	1.800	2.500	-9.000
TOTAL				523.637

BUILT-UP AREA				
TOWER		B		
FLOOR		1ST TO 18TH		
NAME	NO.	LENGTH	WIDTH	AREA (N SQ.MT.)
STAIR	COVERED AREA			
	1	5.100	3.300	523.64
	1	2.009	4.813	16.83
	1			9.27
	1	1.437	1.825	2.62
	0.5	1.437	1.437	1.03
TOTAL				548.07

Building plans have been checked and found in order as per Public Health Services point of view.

EE(W/S) GMDA
EE(Drainage) GMDA
EE(Sew.) GMDA
EE(Nodal Officer) Infra-II, GMDA
CE(Infra-II) GMDA

- PLUMBING LEGEND:-**
- 100 OD UPVC SOIL PIPE
 - 100 OD UPVC WASTE PIPE
 - 65 CPVC DWS DN.TAKE PIPE
 - 50 CPVC FWS DN.TAKE PIPE
 - 100 OD UPVC RAIN WATER
 - KHURRA 450x450mm
 - 65 DWS RISER PIPE
 - 50 FWS RISER PIPE
 - 100 WASTE PIPE
 - 100 SOIL PIPE
 - 75 RAIN WATER PIPE
 - FT FLOOR TRAP
 - FD FLOOR DRAIN
 - FCD FLOOR CLEAN OUT
 - COF CLEAN OUT PLUG
 - CUTOUT SIZE-150x150mm

Sanctioned to be read with this office
MEMO NO.:
DATED:

ATP(HQ)
NARINDER KUMAR JDMH

SR. NO.	NAME	WIDTH	CLL	LINTEL
1	D1	1200	0	2500
2	D2	1050	0	2500
3	D3	750	0	2500
4	D4	900	0	2500
5	FCD	1500	0	2500
6	W1	3000	600	2500
7	W2	1000	600	2500
8	W3	1500	1050	2500
9	W4	1050	1050	2500
10	W5	2000	600	2500
11	W6	700	1050	2500
12	W7	1200	3100	4300
13	DW1	3000	0 & 800	2500
14	DW2	2500	0 & 1050	2500
15	DW3	2000	0 & 800	2500
16	DW4	1900	0 & 800	2500
17	DW5	1350	0 & 1050	2500
18	DW6	2300	0 & 800	2500
19	DW7	1950	0 & 1050	2500
20	V1	500	1050	2500
21	V2	750	1050	2500
22	V3	1500	1050	2500

PROJECT:

PROPOSED BUILDING PLAN OF GROUP HOUSING COLONY OVER AN AREA MEASURING 4.1875 ACRES UNDER TOD POLICY (LICENCE NO 97 OF 2021 DATED 12.11.2021) IN SECTOR 103, GURUGRAM. DEVELOPED BY SUNITA KUMARI W/o SHASHOK KUMAR & OTHERS IN COLLABORATION WITH M/s AVIANA GREEN ESTATES PVT. LTD.

SHEET TITLE:

TOWER - B
1ST - 18TH
FLOOR PLANS & AREA
DIAGRAM

ARCHITECT:
ARCHITECTS AND CONSULTANTS
AE STUDIO
an architectural design studio

A-6, GREEN PARK EXT., NEW DELHI 110019. Ph: 011 42760380 E-Mail: info@aeindia.in, Web: www.aeindia.in

DATE: SEPTEMBER 2022

SCALE: 1:100

NORTH

SHEET SIZE: 11 A0

CLIENT SIGNATURE: For AVIANA GREENESTATES PVT. LTD. Director

ARCHITECT SIGNATURE: Sanjeev Randon Architect CA/97/21634